


File: H:\DRAWINGS\RHINEBECK (V)\22-2496 WTP\RHINEBECK_WTP P&ID.DWG Saved: 2/27/2024 3:12:20 PM Plotted: 10/2/2024 10:21:16 AM User: Iria Broiles LastSavedBy: brogrye

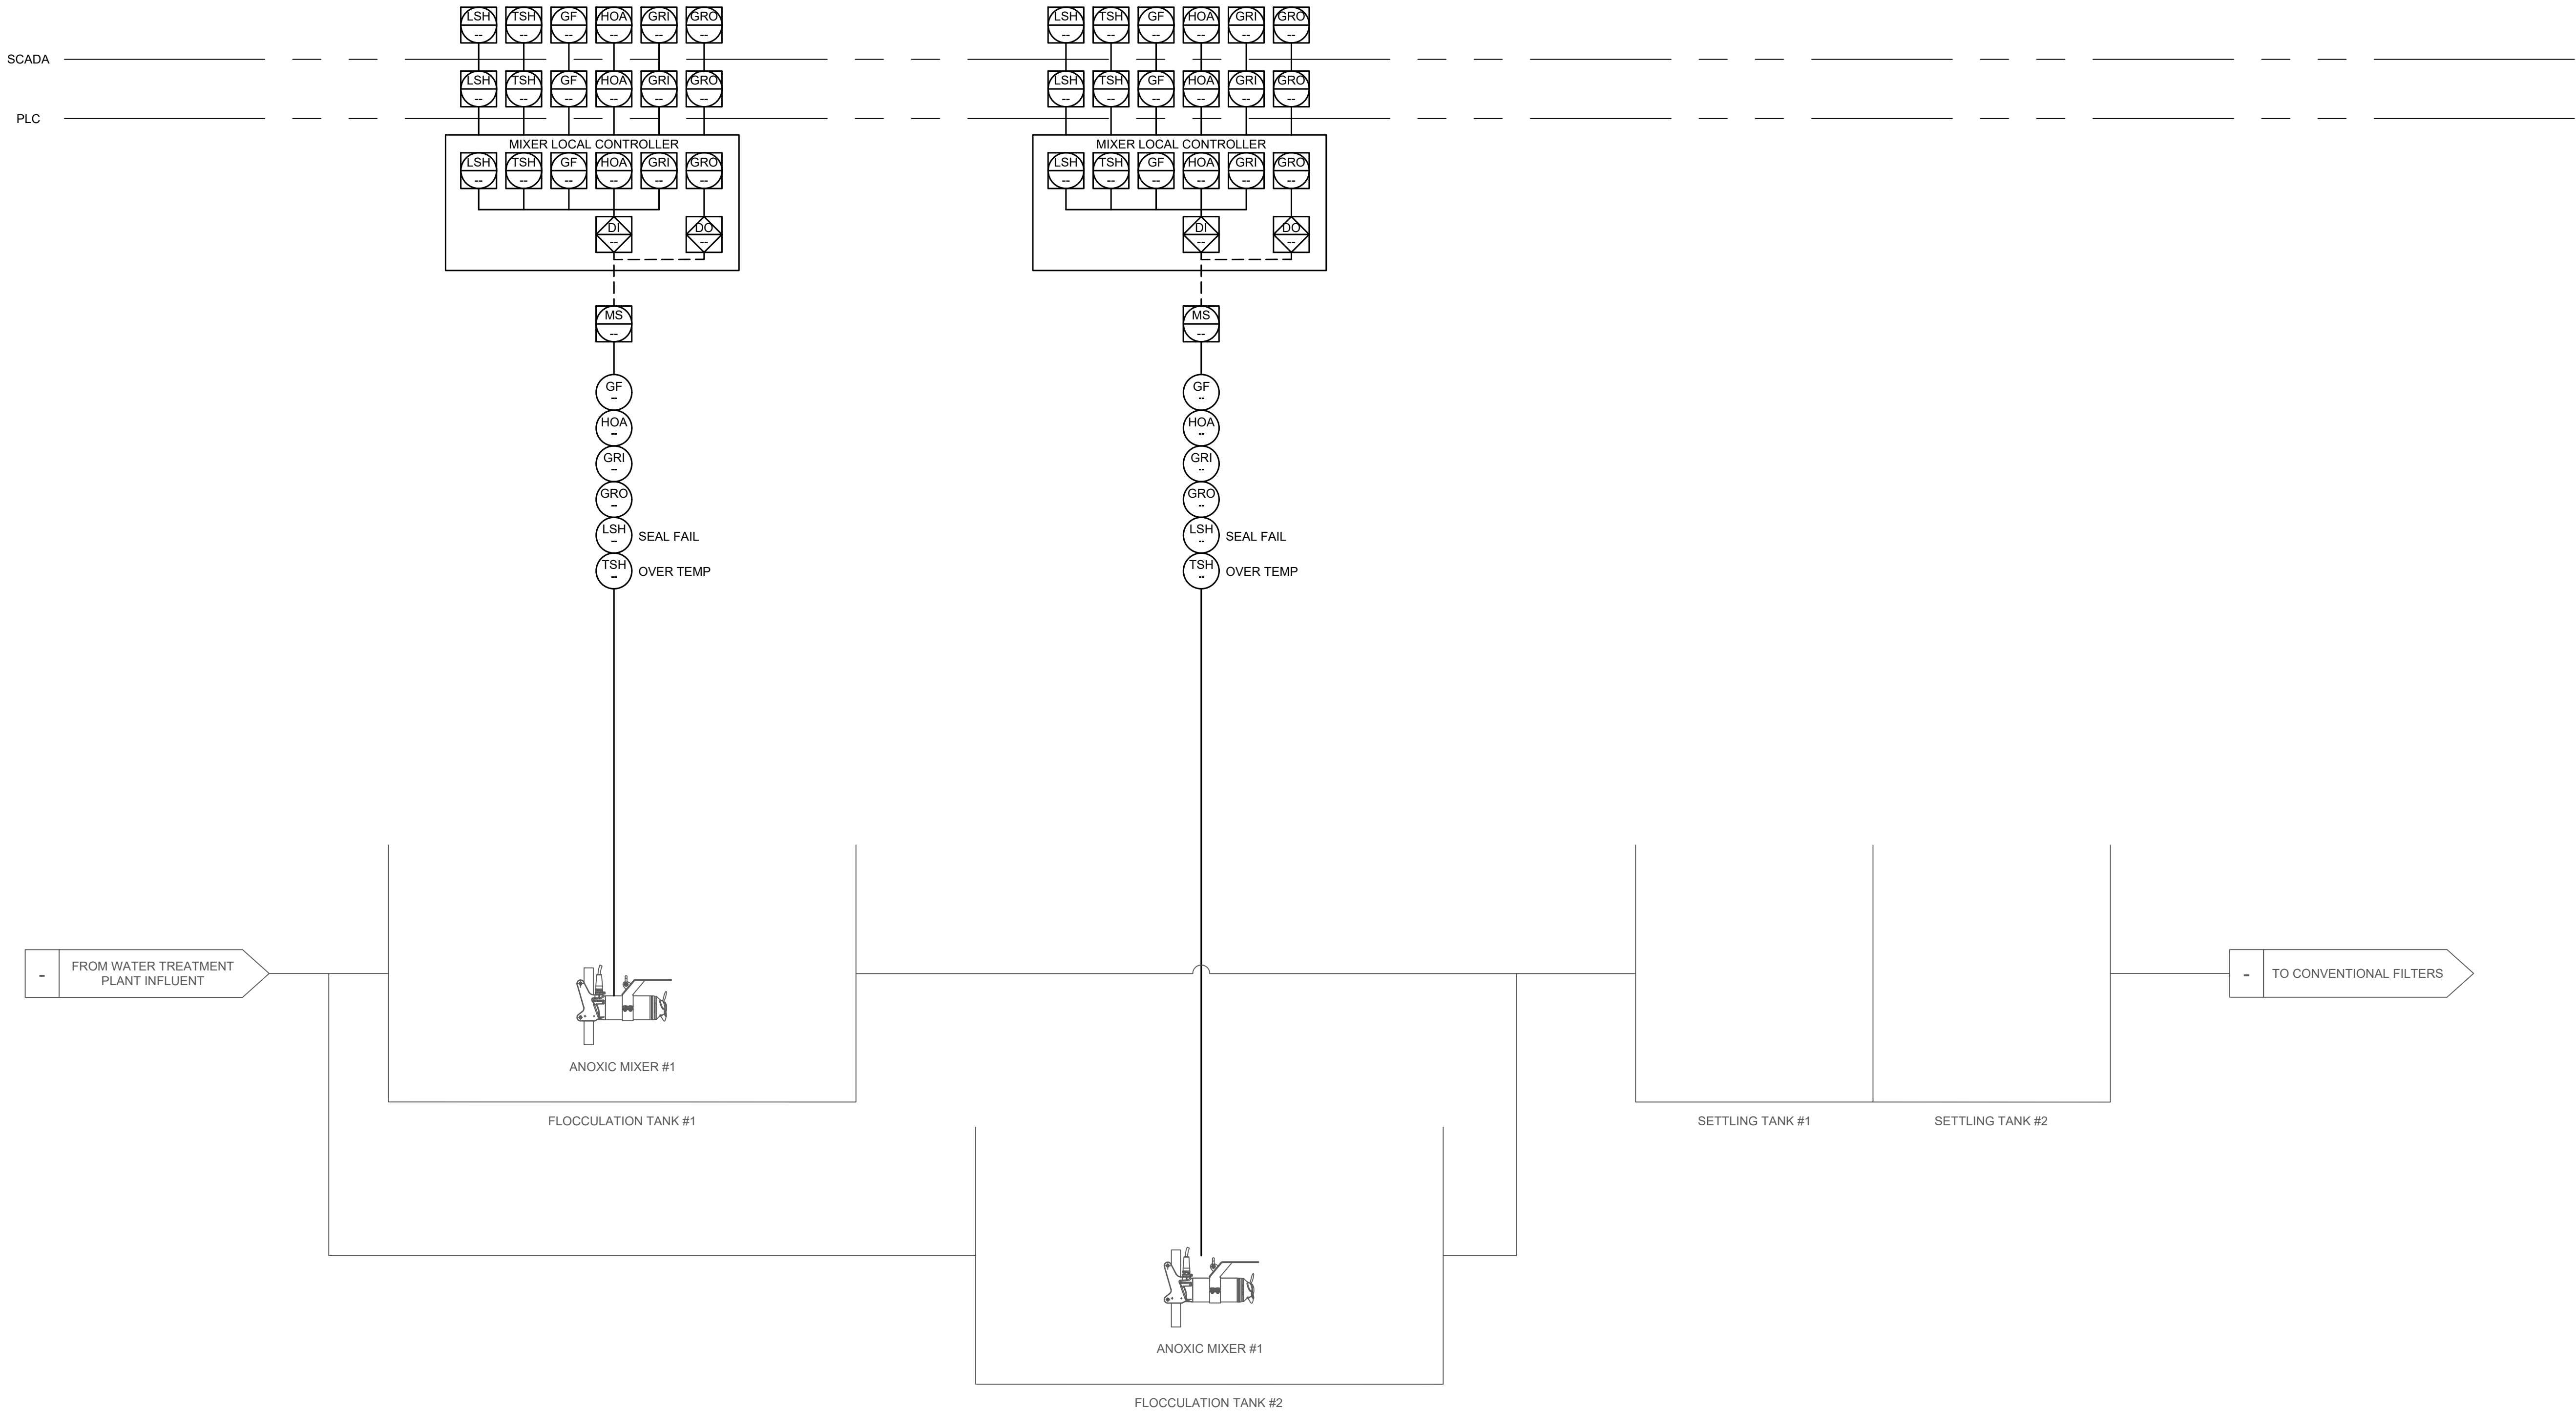


SHEET:

I-004

FLOCCULATION &
SETTLING TANKS
INSTRUMENTATION

RHINEBECK WTP
PLANT IMPROVEMENTS
VILLAGE OF RHINEBECK
DUTCHESS COUNTY, NEW YORK

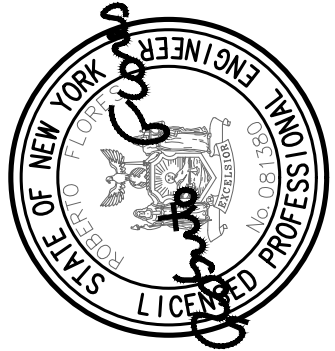

**DELAWARE
ENGINEERING, D.P.C.**
CIVIL AND ENVIRONMENTAL ENGINEERING
28 MADISON AVENUE EXTENSION, ALBANY, NY 12203 - 518.452.1290
55 SOUTH MAIN ST. ONEONTA, NY 13820 - 607.432.8073
31 NORTH MAIN STREET, LIBERTY, NY 12754 - 845.747.9862
110 WEST MARKET STREET, ALBANY, NY 12202 - 518.452.1290
16 EAST MARKET STREET, RED HOOK, NY 12571 - 518.452.1290
548 BROADWAY, MONTICELLO, NY 12001 - 845.791.7777

REVISIONS

NO.	DATE	DESCRIPTION

DATE: 2/27/2024
DRAWN BY: EMB
SCALE: NTS
REVIEWED BY: RF
PROJECT NO.: ----
FILE:

WARNING - IT IS A VIOLATION OF NEW YORK EDUCATION LAW SECTION 7209.2, FOR ANY PERSON, UNLESS HE IS ACTING UNDER THE DIRECTION OF A LICENSED PROFESSIONAL ENGINEER OR LAND SURVEYOR, TO ALTER THIS DOCUMENT IN ANY WAY. IF ALTERED THE ALTERING PERSON SHALL COMPLY WITH THE REQUIREMENTS OF NEW YORK EDUCATION LAW SECTION 7209.2.