



File: H:\DRAWINGS\RHINEBECK (V)\22-2496 WTP\RHINEBECK_WTP P&ID.DWG Saved: 2/27/2024 3:12:20 PM Plotted: 10/2/2024 10:21:18 AM User: Irf Brodie LastSavedBy: brodyie

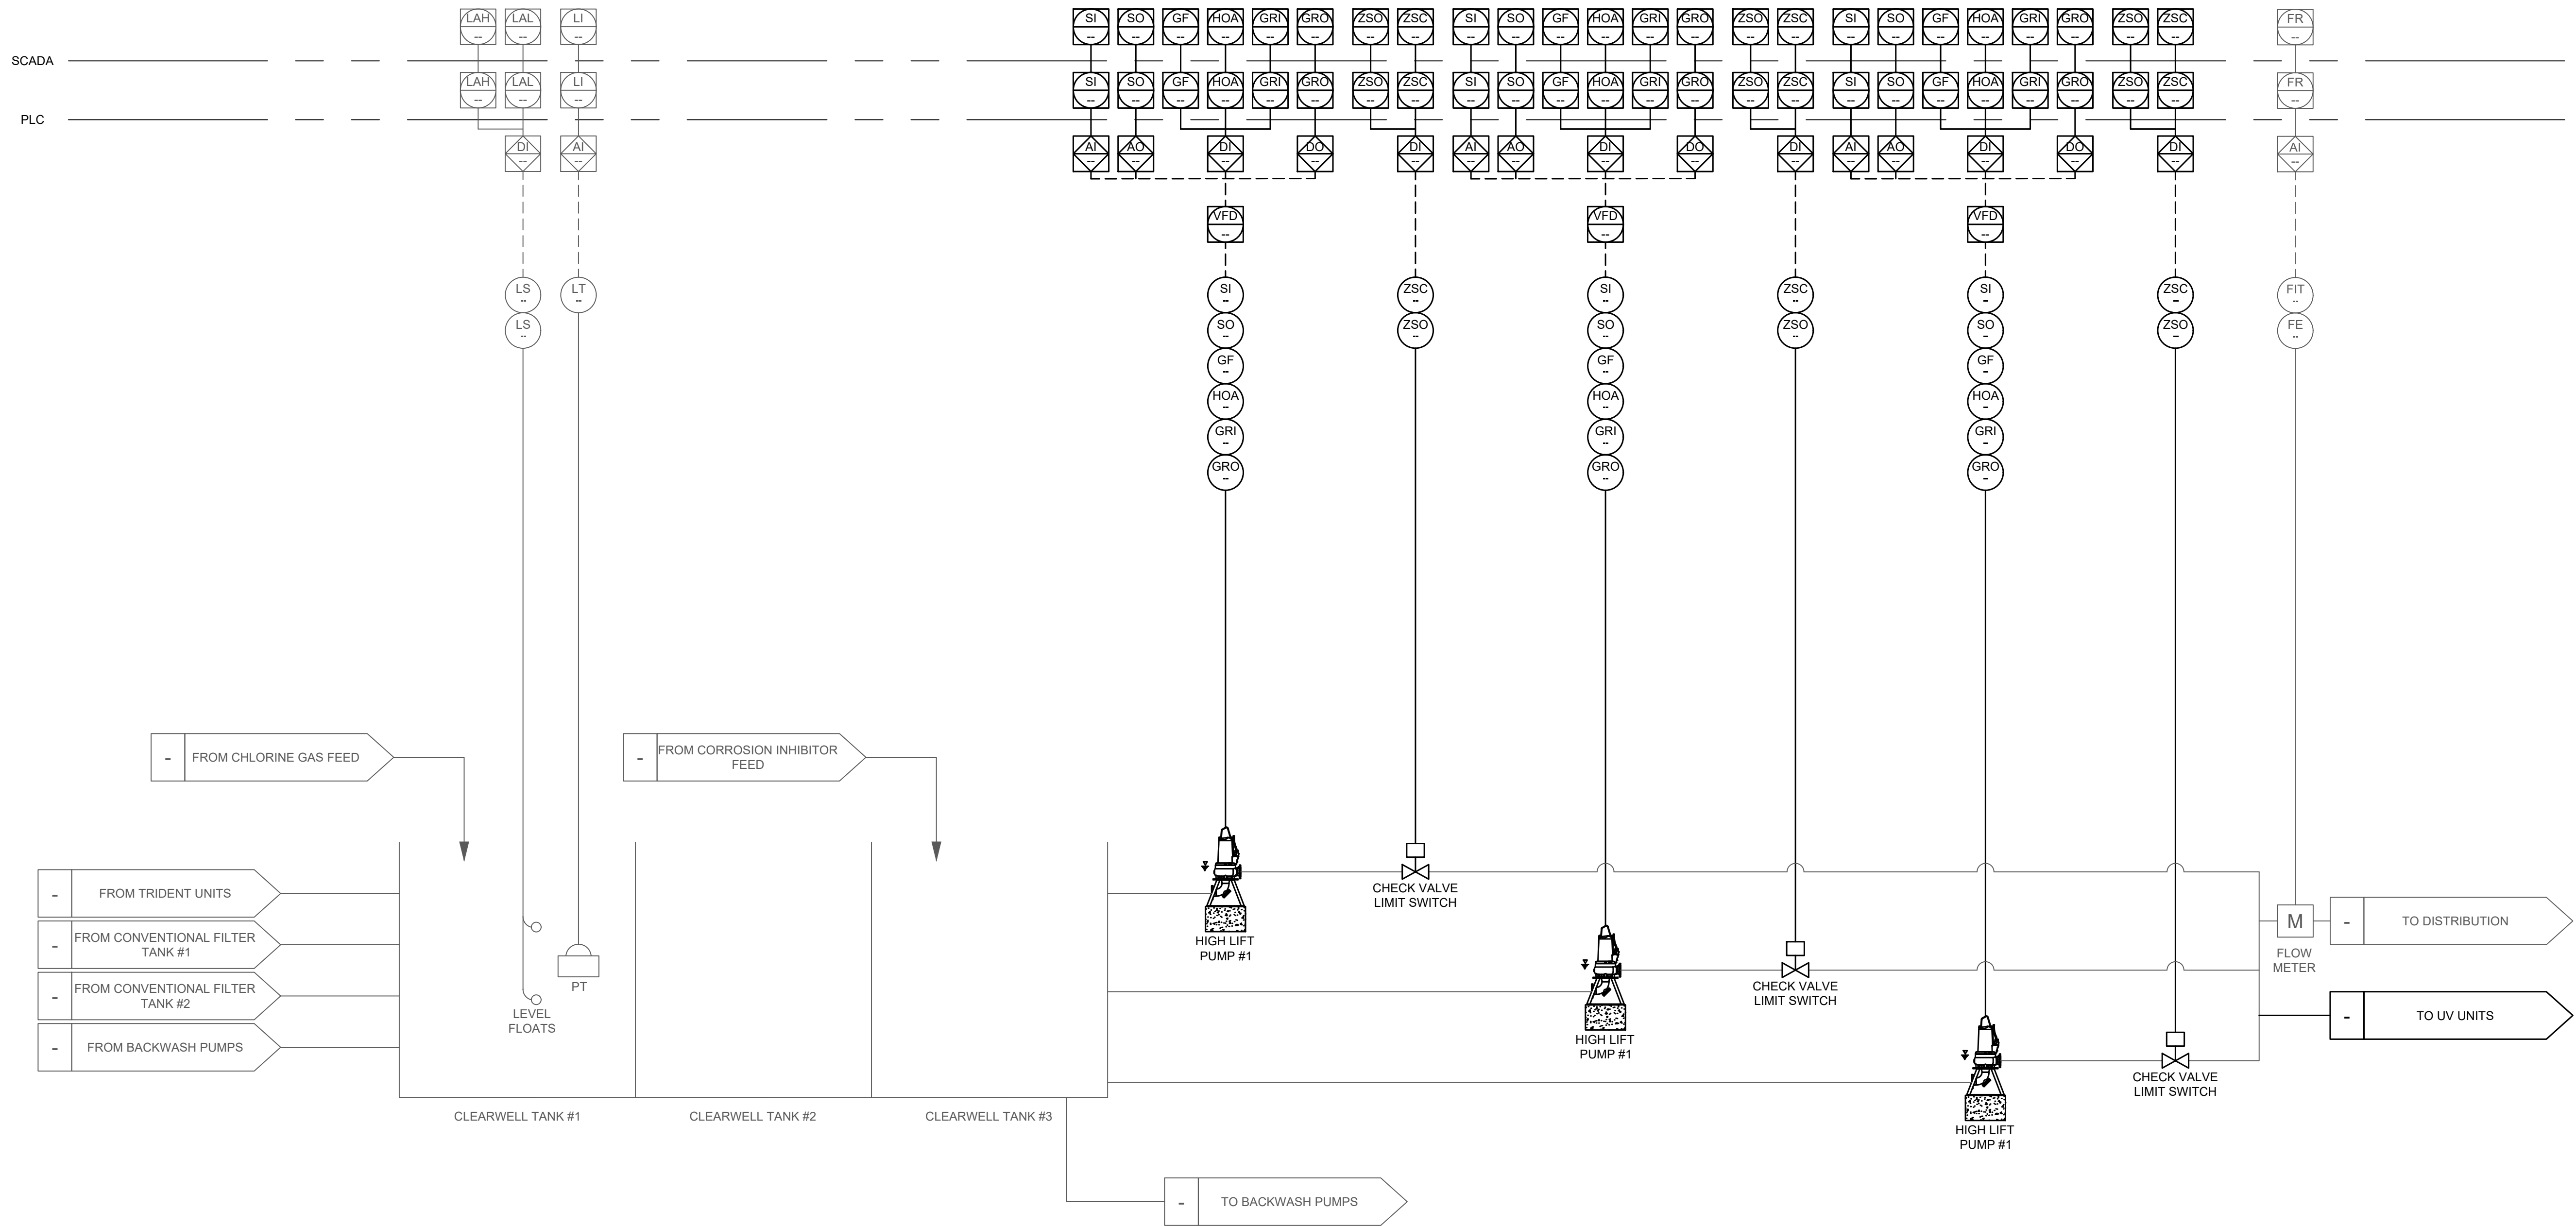

WARNING - IT IS A VIOLATION OF NEW YORK EDUCATION LAW SECTION 7209.2, FOR ANY PERSON, UNLESS HE IS ACTING UNDER THE DIRECTION OF A LICENSED PROFESSIONAL ENGINEER OR LAND SURVEYOR, TO ALTER THIS DOCUMENT IN ANY WAY. IF ALTERED THE ALTERING PERSON SHALL COMPLY WITH THE REQUIREMENTS OF NEW YORK EDUCATION LAW SECTION 7209.2.

DATE: 2/27/2024
DRAWN BY: EMB
SCALE: NTS
REVIEWED BY: RF
PROJECT NO.: ----
FILE:

DELAWARE ENGINEERING, D.P.C.
CIVIL AND ENVIRONMENTAL ENGINEERING
28 MADISON AVENUE EXTENSION, ALBANY, NY 12203 - 518.452.1290
55 SOUTH MAIN ST. ONEONTA, NY 13820 - 607.432.8073
31 NORTH MAIN STREET, LIBERTY, NY 12544 - 845.747.9862
100 WEST MARKET STREET, ALBANY, NY 12202 - 518.452.1290
16 EAST MARKET STREET, RED HOOK, NY 12571 - 518.452.1290
548 BROADWAY, MONTICELLO, NY 12001 - 845.791.7777

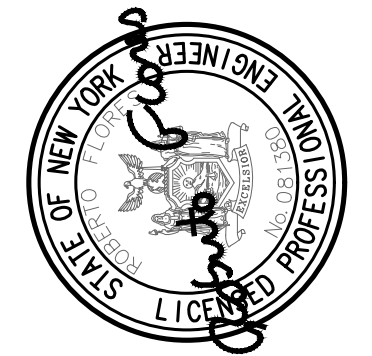

REVISIONS		DESCRIPTION
NO.	DATE	

RHINEBECK WTP
PLANT IMPROVEMENTS
VILLAGE OF RHINEBECK
DUTCHESS COUNTY, NEW YORK

CLEARWELL TANKS &
HIGH LIFT PUMPS
INSTRUMENTATION

SHEET:
I-006