


File: H:\DRAWINGS\RHINEBECK\0\22-2496 WTP\RHINEBECK_WTP_P&ID.DWG Saved: 2/27/2024 3:12:20 PM Plotted: 10/2/2024 10:21:26 AM User: Ihs Brodas LutzSawady Brophy

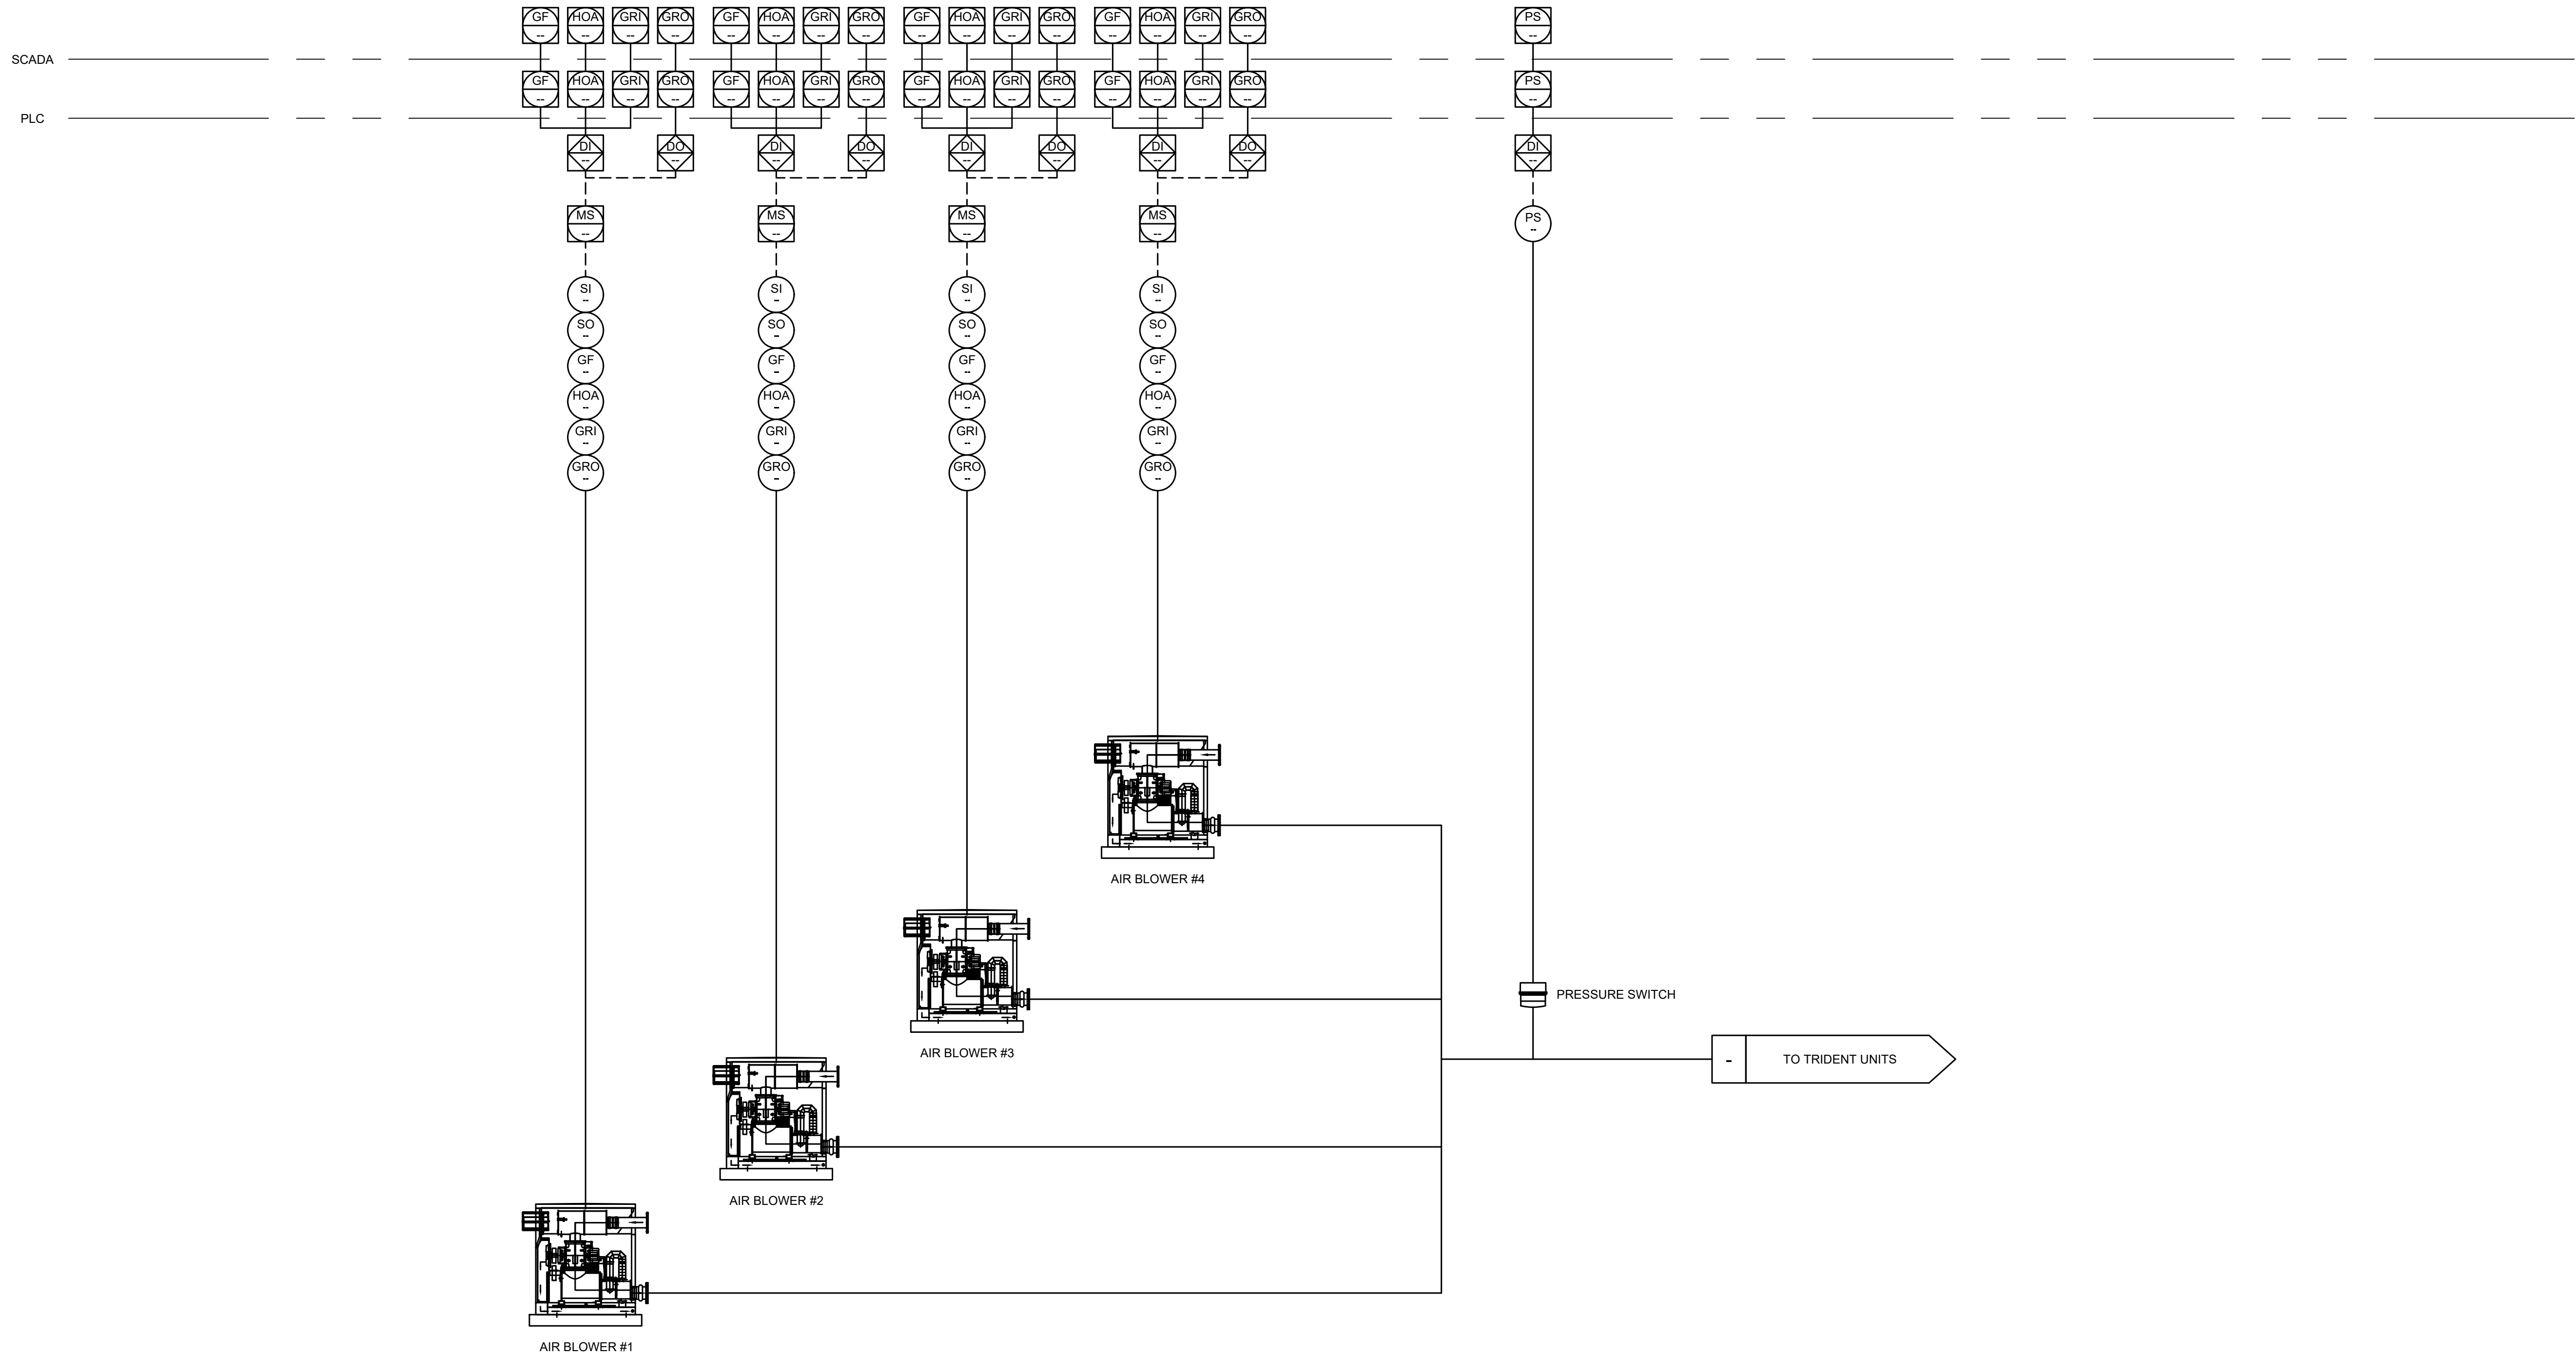

WARNING - IT IS A VIOLATION OF NEW YORK EDUCATION LAW SECTION 7209.2, FOR ANY PERSON, UNLESS HE IS ACTING UNDER THE DIRECTION OF A LICENSED PROFESSIONAL ENGINEER OR LAND SURVEYOR, TO ALTER THIS DOCUMENT IN ANY WAY. IF ALTERED THE ALTERING PERSON SHALL COMPLY WITH THE REQUIREMENTS OF NEW YORK EDUCATION LAW, SECTION 7209.2.


SHEET:

I-011

BLOWER
INSTRUMENTATION

RHINEBECK WTP
PLANT IMPROVEMENTS
VILLAGE OF RHINEBECK
DUTCHESS COUNTY, NEW YORK

REVISIONS	
NO.	DESCRIPTION

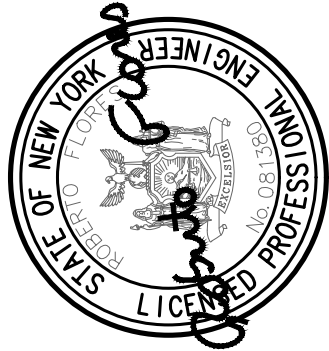

**DELAWARE
ENGINEERING, D.P.C.**
CIVIL AND ENVIRONMENTAL ENGINEERING
28 MADISON AVENUE EXTENSION, ALBANY, NY 12203 - 518.452.1290
55 SOUTH MAIN ST. ONEONTA, NY 13820 - 607.432.8073
311 NORTH MAIN STREET, LIBERTY, NY 12544 - 518.747.9862
110 WEST MARKET STREET, ALBANY, NY 12202 - 518.452.1290
16 EAST MARKET ST., RED HOOK, NY 12571 - 518.452.1290
548 BROADWAY, MONTICELLO, NY 12521 - 845.791.7777

DATE: 2/27/2024
DRAWN BY: EMB
SCALE: NTS
REVIEWED BY: RF
PROJECT NO.: ----
FILE: