


File: H:\DRAWINGS\RHINEBECK (V)\22-2496 WTP\RHINEBECK_WTP P&ID.DWG Saved: 2/27/2024 3:12:20 PM Plotted: 10/2/2024 10:21:27 AM User: Ihs Brodas LutzSawdy, Brophy

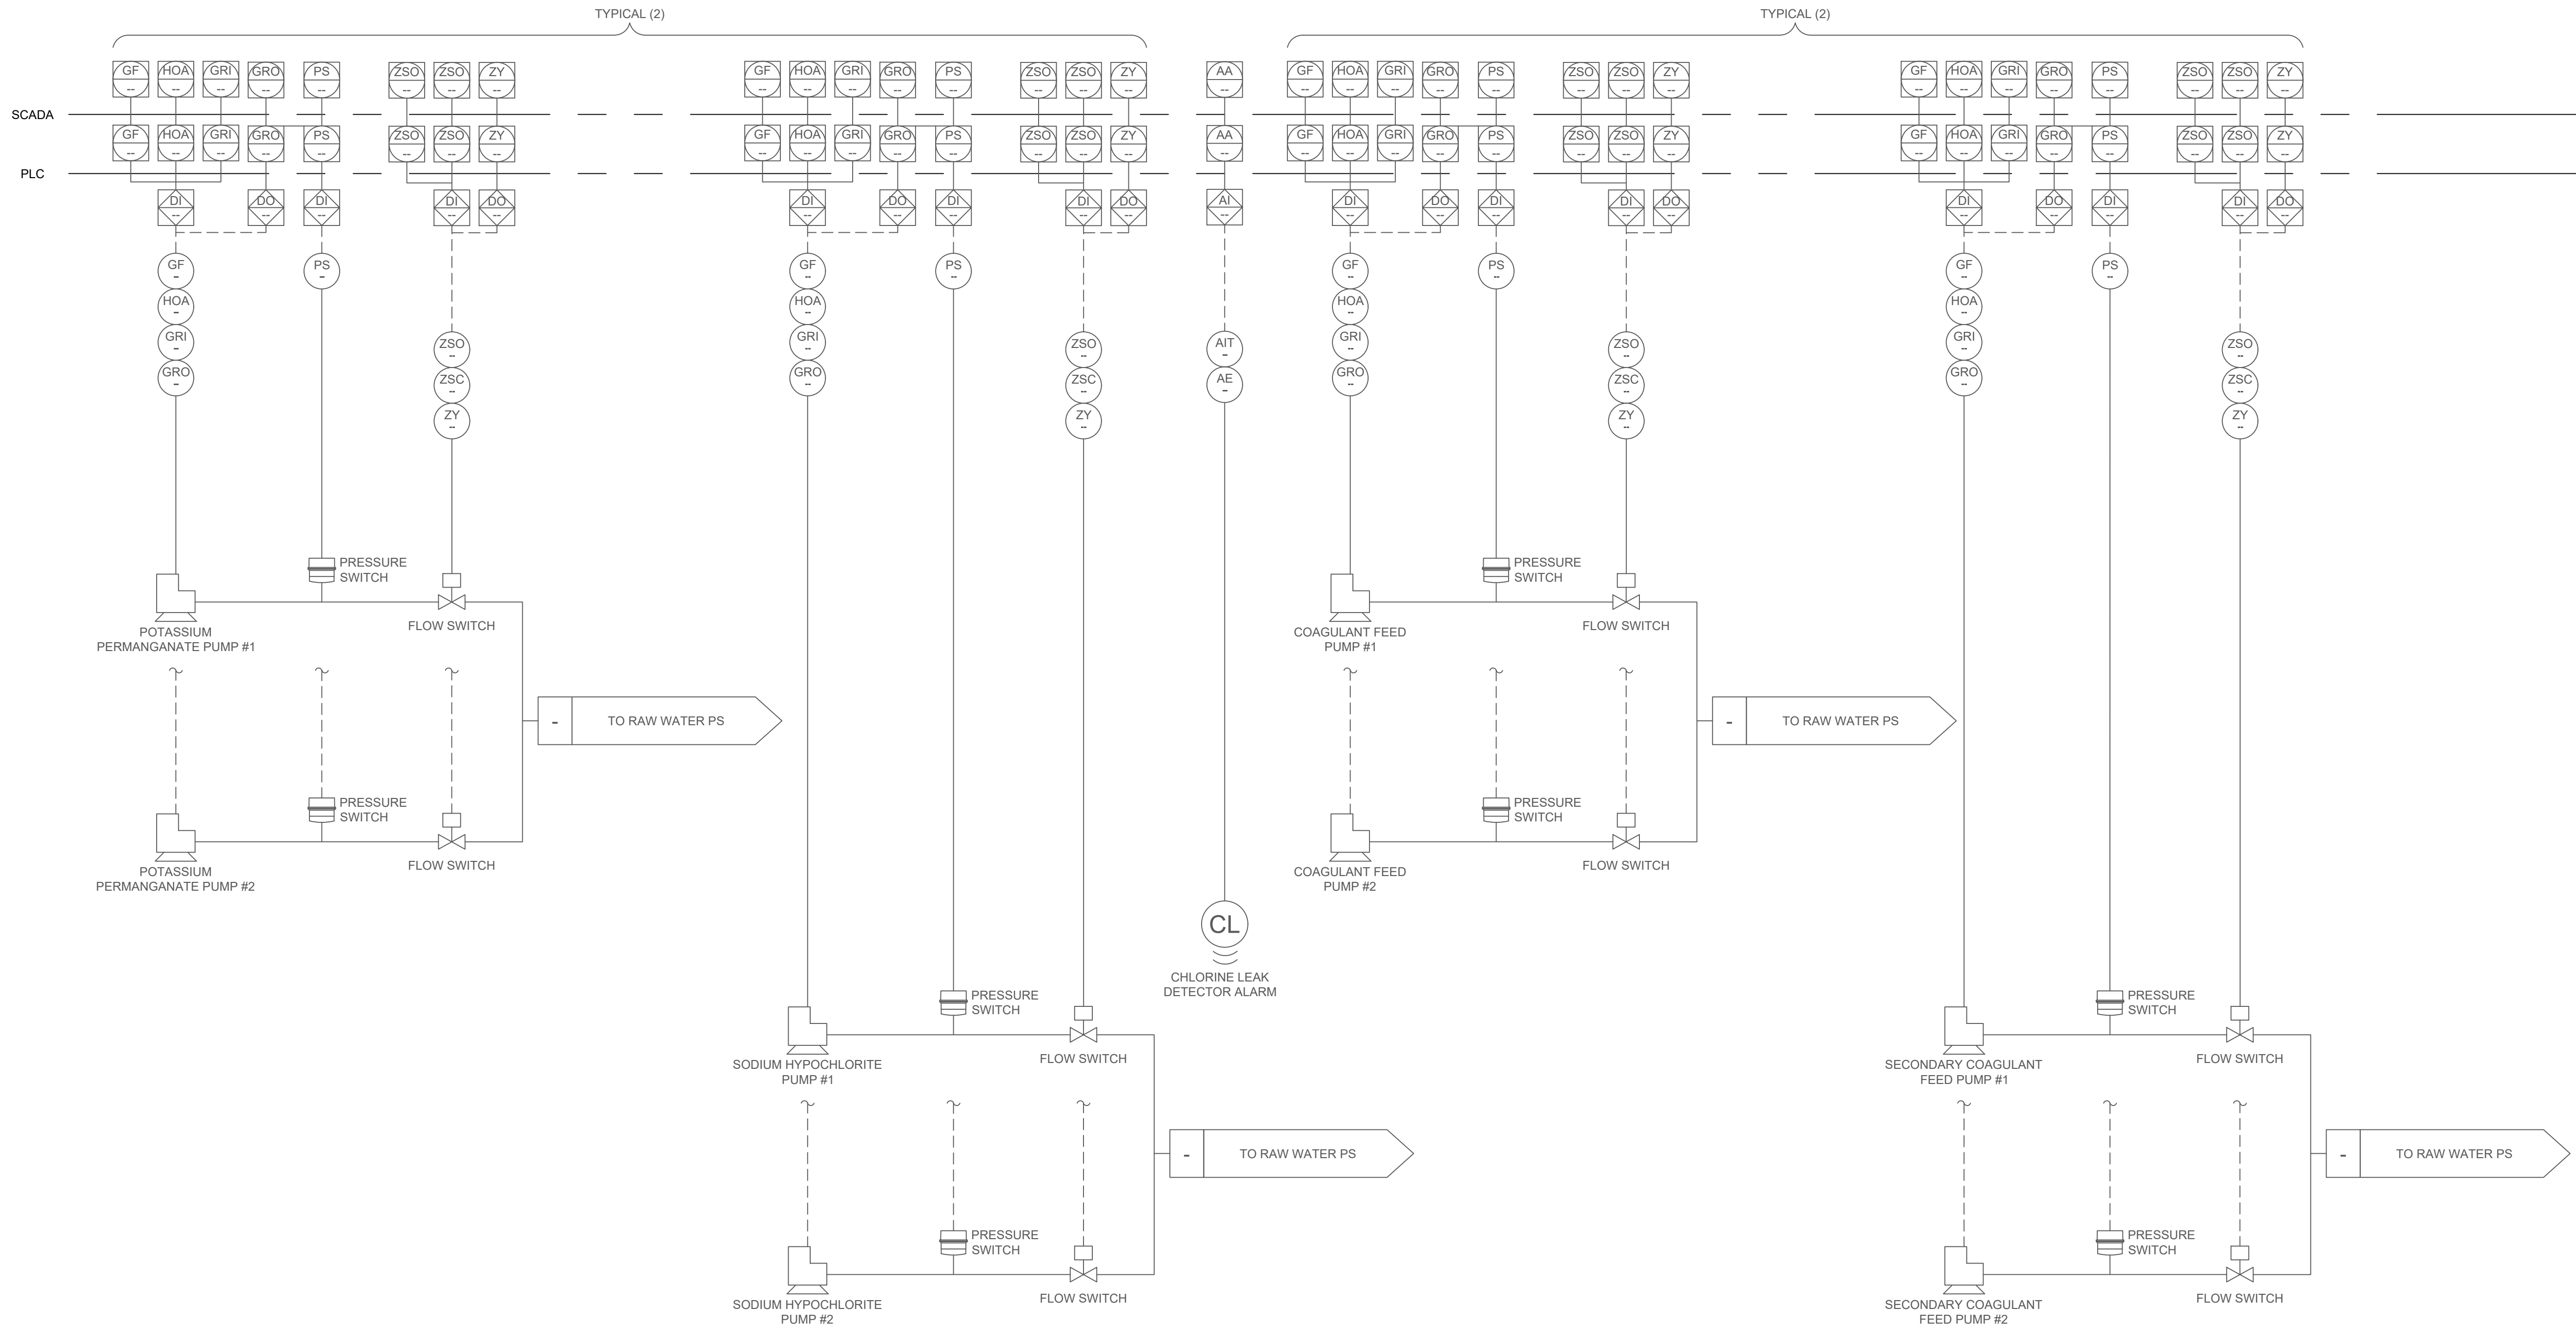

REVISIONS	
NO.	DESCRIPTION

RHINEBECK WTP
PLANT IMPROVEMENTS
VILLAGE OF RHINEBECK
DUTCHESS COUNTY, NEW YORK

CHEMICAL FEED
INSTRUMENTATION

SHEET:
I-012

DATE:	2/27/2024
DRAWN BY:	EMB
SCALE:	NTS
REVIEWED BY:	RF
PROJECT NO.:	----
FILE:	----

DELAWARE ENGINEERING, D.P.C.
CIVIL AND ENVIRONMENTAL ENGINEERING
28 MADISON AVENUE EXTENSION, ALBANY, NY 12203 - 518.452.1290
55 SOUTH MAIN ST., ONEONTA, NY 13820 - 607.432.8073
311 NORTH MAIN STREET, LIBERTY, NY 12544 - 518.474.9862
16 EAST MARKET ST., RED HOOK, NY 12571 - 518.482.1290
548 BROADWAY, MONTICELLO, NY 12701 - 845.791.7777

