

EDGEMONT SCHOOL DISTRICT

GREENVILLE ELEMENTARY SCHOOL

HVAC UPGRADES AND CAFETERIA RENOVATION


100 GLENDALE ROAD, SCARSDALE, NY 10583

SED PROJECT NUMBERS:

GREENVILLE ELEMENTARY

66-04-06-03-0-008-021

GREENVILLE ELEMENTARY SCHOOL
100 GLENDALE ROAD, SCARSDALE, NY 10583

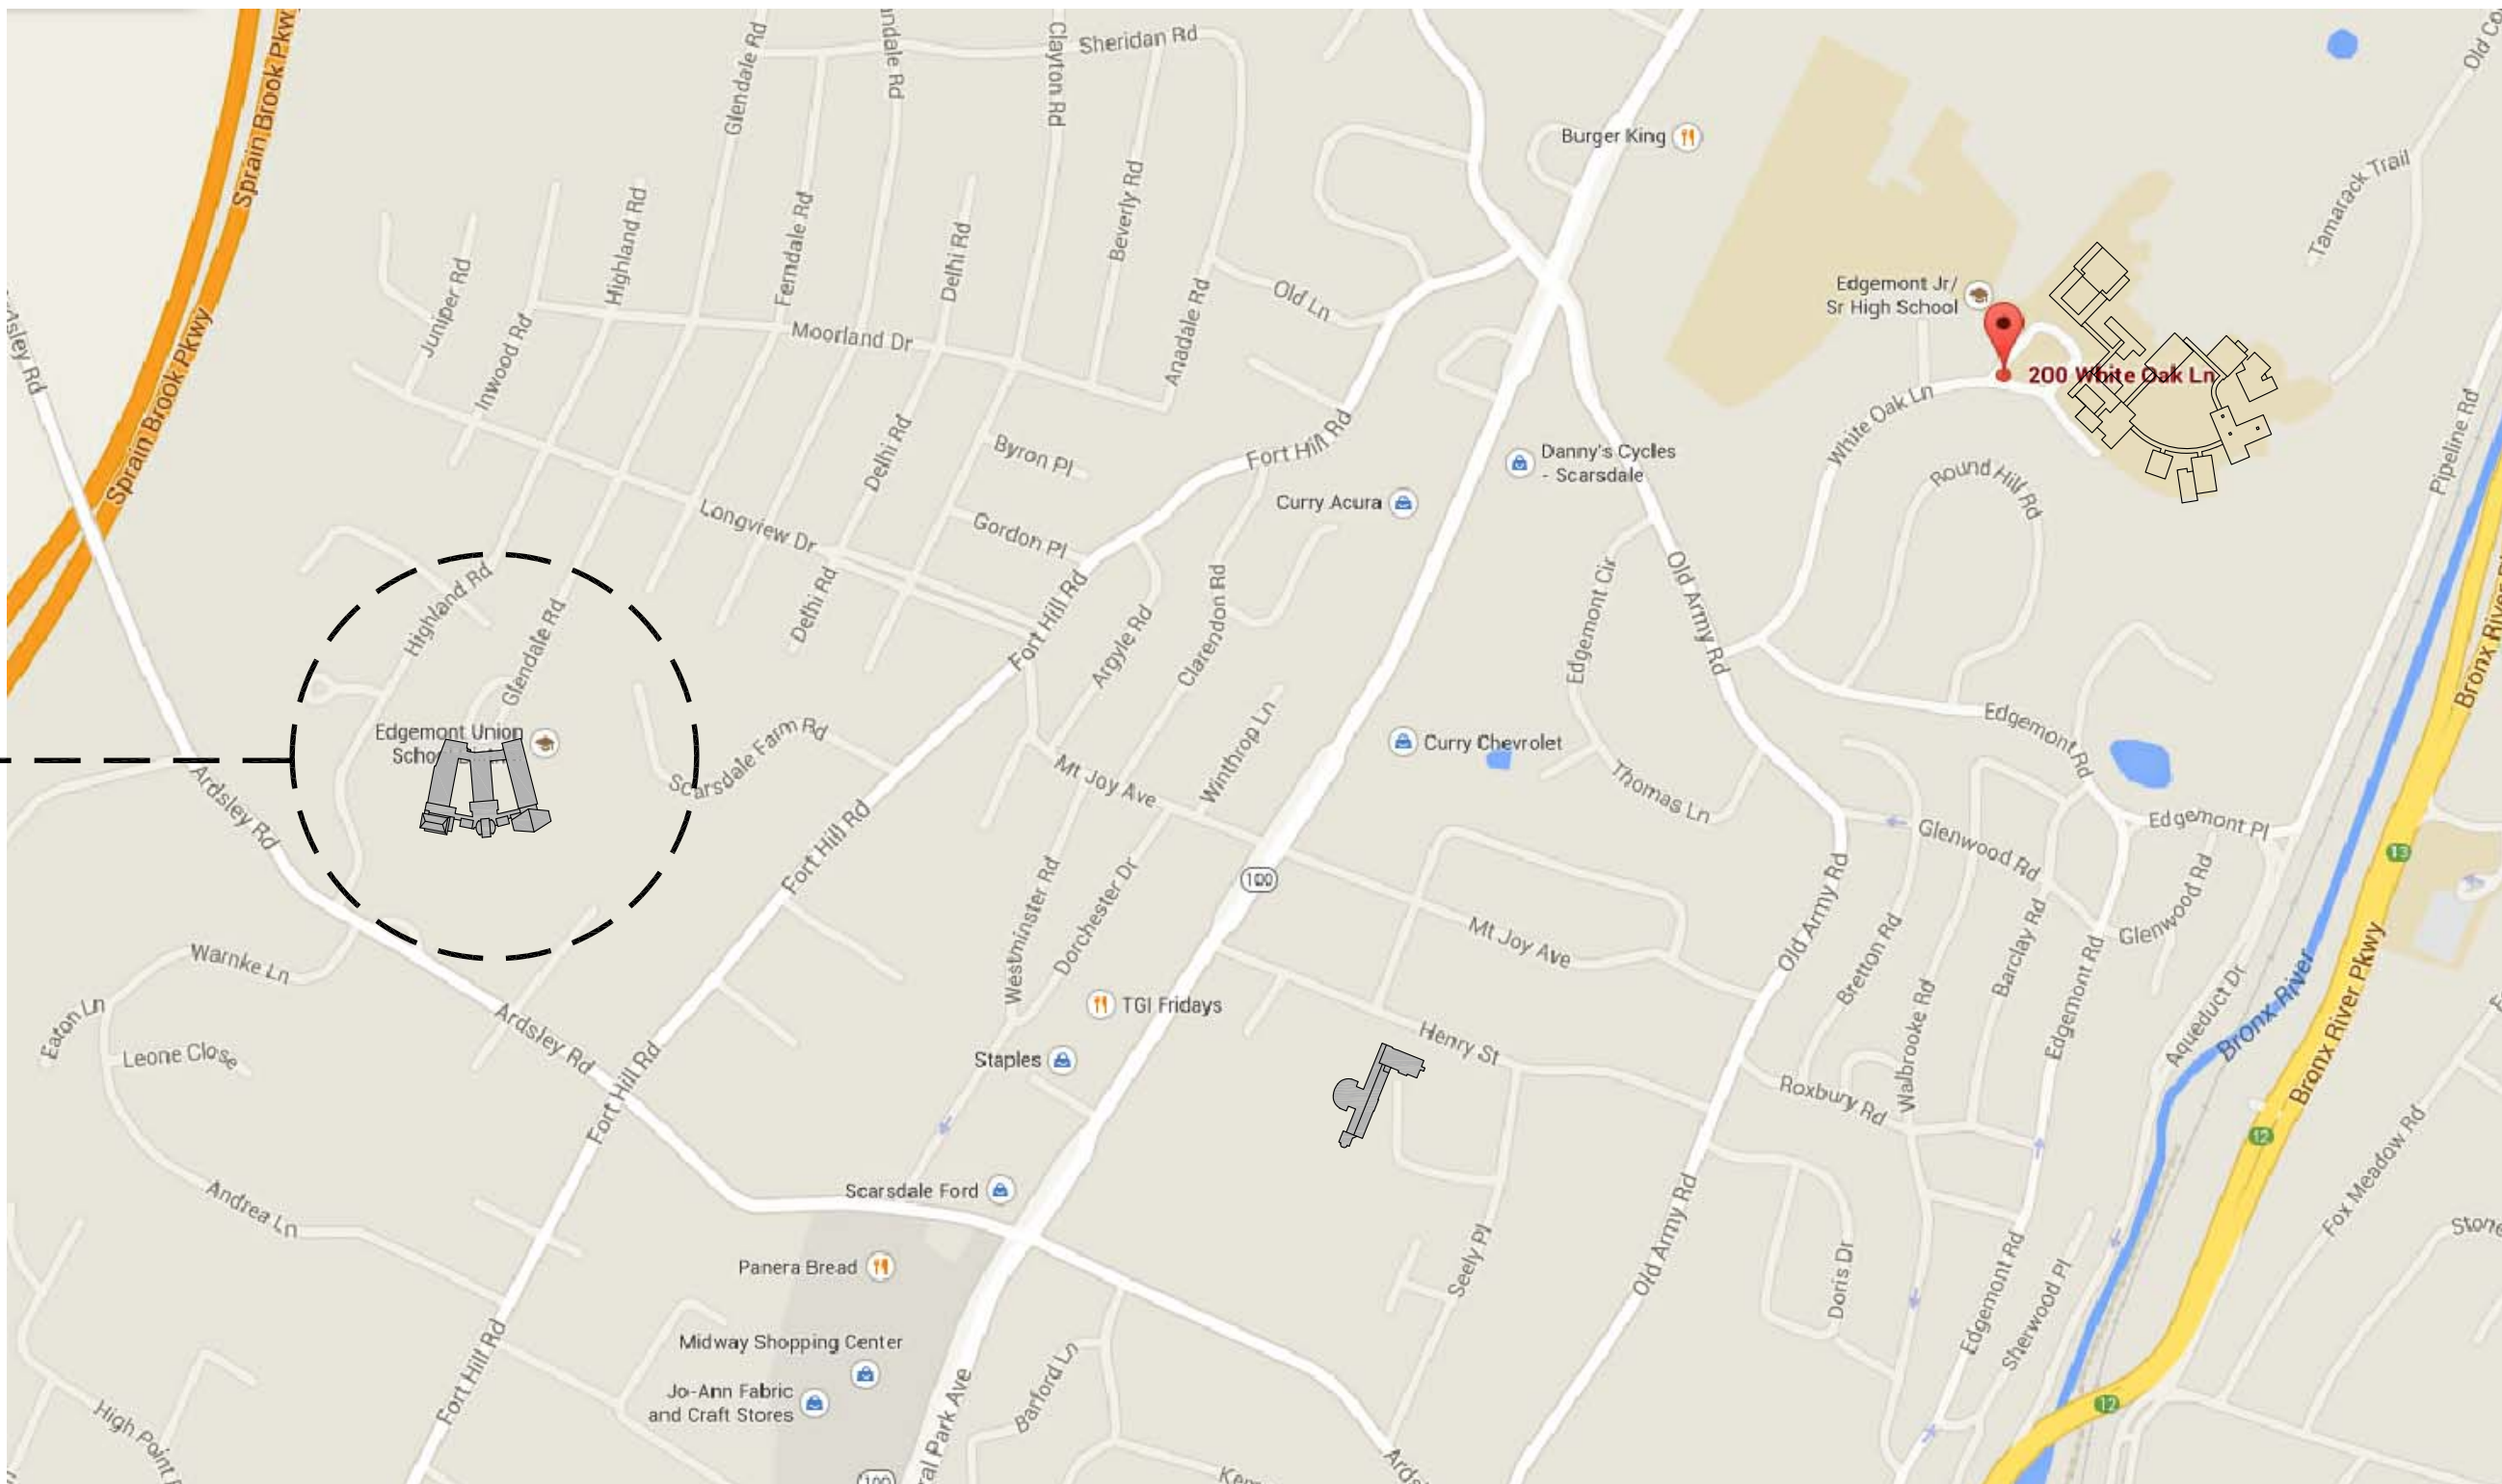

FULLER
D'ANGELO
P.C.

ARCHITECTS
PLANNERS

45 KNOLLWOOD ROAD ELMSFORD NEW YORK 10523
TEL 914.592.4444 FAX 914.592.1717
WWW.FULLERDANGELO.COM

Copyright 2025 All Rights Reserved by FULLER & D'ANGELO P.C.

ENVIRONMENTAL :

EISENBACH&RUHNKE ENGINEERING, P.C.

291 GENESEE STREET
UTICA, NY 13501
TEL: (315) 735-1916
FAX: (315) 735-6365
www.erengpc.com

MECHANICAL, PLUMBING AND ELECTRICAL :

LANDMARK FACILITIES GROUP, INC.

252 EAST AVENUE
NORWALK, CT 06855
TEL: (203) 866-4626
FAX: (203) 866-8019
EMAIL: info@lfginc.com

FOOD SERVICE :

RAYMOND/ RAYMOND ASSOCIATES

44 St. JOHN STREET
GOSHEN, NEW YORK 10924
TEL: (845) 360 5112
RRAdesigns.com

LICENSE EXP. DATE: 02-28-2027

01-31-2024	BID
05-10-2022	SED ADDENDUM
01-10-2022	SED SUBMISSION
DATE	ISSUED TO
SHEET SIZE 30"x42"	DRAWING NO. T-1
SCALE AS NOTED	FILE NO. 24529.01
DRAWN BY F & D	

[illegible]

CLASSROOM		CLASSROOM	
100		100	
	ROOM NAME & NUMBER		REMOVE EXISTING CONSTRUCTION
	DOOR NUMBER		EXISTING CONSTRUCTION
	ELEVATION KEY		NEW WALL CONSTRUCTION
	INTERIOR WALL INDICATIONS		COLUMN GRID LINES
	WINDOW TYPE		EXISTING COLUMN DESIGNATION
	REMOVAL/WORKSCOPE NOTE		BUILDING/WALL SECTION/DETAIL
	REVISION MARK		REFERENCE POINT
	DETAIL NO.		HIDDEN LINE BELOW
	DETAIL KEY		HIDDEN LINE ABOVE OR BEYOND
	WALL TYPE		CENTERLINE OR N.I.C. LINE
	EXTERIOR ELEVATION KEY		EXISTING DOOR INDICATES DOOR NUMBER (SEE DOOR SCHEDULE)
	FLUSH THRESHOLD		NEW DOOR INDICATES DOOR NUMBER (SEE DOOR SCHEDULE)
	5'-0" ø HANDICAPPED TURNING RADIUS		

	CONCRETE		PARTICLE BOARD
	CONCRETE MASONRY UNITS		PLYWOOD
	BRICK		ACOUSTICAL TILE
	STONE		CONTINUOUS WOOD FRAMING THROUGH MEMBER
	METALS		WOOD FRAMING THROUGH INTERRUPTED MEMBER
	COMPACTED GRAVEL		FINISHED WOOD
	EARTH/UNDISTURBED SOIL		BATT INSULATION
	DRAINAGE BOARD		RIGID INSULATION

[illegible]

★ T1	TITLE SHEET
★ G1	LOCATION MAP, ABBREVIATIONS, MATERIALS, GRAPHIC LEGEND, GENERAL NOTES, PROJECT CONTACTS & LIST OF DRAWINGS.
★ GVES CC-1	CODE COMPLIANCE SHEET
<u>ABATEMENT- CONTRACT #1</u>	
HM-100	HAZARDOUS MATERIALS REMOVAL PLAN
<u>ARCHITECTURAL- CONTRACT #1</u>	
A10	RAMP ELEVATIONS, RAMP SECTIONS AND DETAILS
A100	OVERALL BASEMENT PLAN
A101	OVERALL FIRST FLOOR PLAN
A102	OVERALL ROOF PLAN
A150	PARTIAL BASEMENT PLAN
A151	PARTIAL FIRST FLOOR REMOVAL PLAN
A151	PARTIAL FIRST FLOOR PLAN, INTERIOR ELEVATIONS & NOTES
A152	PARTIAL ROOF PLAN
AR200	PARTIAL FIRST FLOOR REMOVAL REFLECTED CEILING PLAN
A200	PARTIAL FIRST FLOOR REFLECTED CEILING PLAN
A425	WALL SECTIONS
A426	WALL SECTIONS
A427	PARTIAL BUILDING SECTIONS
A500	PARTITION TYPES & MISCELLANEOUS DETAILS
A501	CEILING DETAILS
A625	ROOF DETAILS
A626	ROOF DETAILS
A627	ROOF DETAILS
A650	MISCELLANEOUS DETAILS
A700	DOOR SCHEDULE, TYPES & DETAILS
A800	FINISH PLANS, FINISH SCHEDULE LEGEND, SCHEDULE & DETAILS
A900	SIGNAGE PLANS, SIGN TYPE & DETAILS
<u>STRUCTURE- CONTRACT #1</u>	
GVES S-1	PARTIAL FIRST FLOOR FRAMING PLAN
GVES S-2	PARTIAL ROOF FRAMING PLAN
<u>FOOD SERVICES- CONTRACT #1</u>	
GVES FS101	FOOD SERVICE EQUIPMENT PLAN, SCHEDULE & NOTES
GVES FS102	FOOD SERVICE TYPICAL TRADE RESPONSIBILITY NOTES
<u>PLUMBING- CONTRACT #2</u>	
P001	PLUMBING SYMBOLS, ABBREVIATIONS, SCHEDULES AND DETAILS
P100	BASEMENT PLUMBING PLAN
P101	FIRST FLOOR PLUMBING PLAN
<u>MECHANICAL- CONTRACT #3</u>	
M001	MECHANICAL NOTES AND LEGEND
M0100	BASEMENT AND FIRST FLOOR MECHANICAL DEMO PLANS
M100	BASEMENT MECHANICAL PLAN
M101	FIRST FLOOR MECHANICAL RCP
M102	ROOF MECHANICAL PLAN
M200	MECHANICAL DETAILS
M300	MECHANICAL SCHEDULES
<u>ELECTRICAL- CONTRACT #4</u>	
E001	ELECTRICAL LEGEND, NOTES, ABBREVIATIONS, KEY PLAN & DRAWING SCHEDULES
E100	BASEMENT ELECTRICAL PLAN
E101	FIRST FLOOR ELECTRICAL PLAN
E102	ROOF ELECTRICAL PLAN
E103	FIRST FLOOR ELECTRICAL LIGHTING PLAN
E200	ELECTRICAL ONE LINE DIAGRAM
E300	ELECTRICAL SCHEDULES, LOAD SUMMARY, AND WIRING DIAGRAMS
FA100	FIRE ALARM LEGEND, NOTES, PART RISER, SEQUENCE OF OPERATIONS AND PLAN

48 KNOLLWOOD ROAD ELMFORD NEW YORK 10853
TEL 914.892.4444 FAX 914.892.1717
WWW.FULLERANGELO.COM

FULLER
D'ANGELO
P.C.

ARCHITECTS
PLANNERS

LICENSE EXP. DATE: 02-28-2027

S.E.D. CONTROL NUMBER:
GREENVILLE ELEMENTARY SCHOOL
66-04-06-03-0-008-021

LE
NT SCHOOL DISTRICT
LE ELEMENTARY SCHOOL
IA RENOVATION



LE
MATIONS, LEGENDS, GENERAL NOTES,
L REMOVAL NOTES & LIST OF
GS

ED G-1	DR AT G-1
01-31-2025	BID
01-10-2022	SED SUBMISSION
DATE	ISSUED TO
SHEET SIZE 30"x42"	DRAWING NO.
SCALE AS NOTED	G-1
DRAWN BY F & D	FILE NO. 24529.01


CONTRACT DRAWINGS

*	COMMON DRAWINGS TO ALL CONTRACTORS
----------	---

  PLOT DATE: January 22, 2025 - 7:44am

* KEY			
	YEAR OF CONSTRUCTION	CONSTRUCTION CLASSIFICATION	BUILDING AREA S.F.
	ORIGINAL CONSTRUCTION -- 1949	TYPE 2	11,460
	ADDITION -- 1960	TYPE 2	26,540
	ADDITION -- 1969	TYPE 2	10,300
	ADDITION -- 2000	TYPE 2	24,090

* INFORMATION BASED ON DRAWINGS PROVIDED BY
EDGEMONT UNION FREE SCHOOL DISTRICT.
S.E.D. PROJECT NUMBER 64-04-06-03-0-008-007
DATED 12/18/2000
















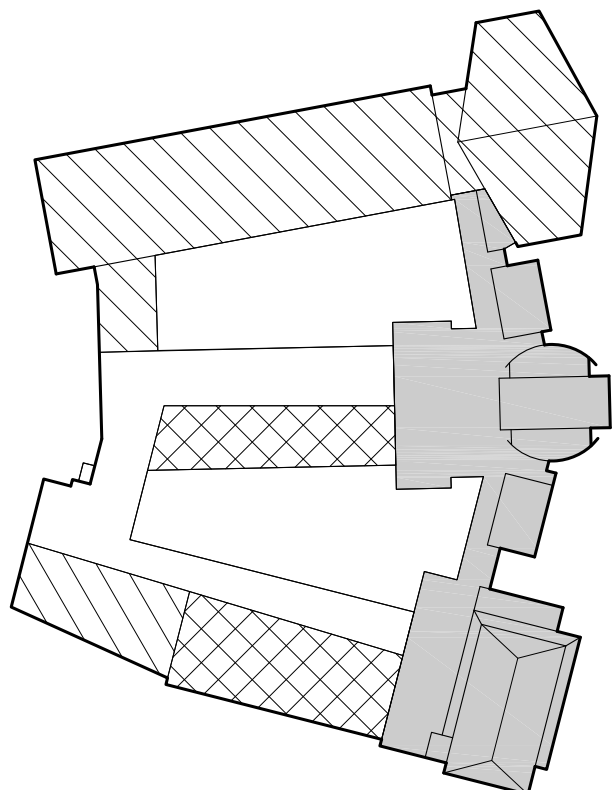


KEY PLAN
SCALE N.T.S.

CODE INFORMATION FOR PROPOSED WORK

- APPLICABLE CODE STANDARDS
1998 MANUAL OF PLANNING STANDARDS FOR SCHOOLS
2020 BUILDING CODE OF NEW YORK STATE (IBC 2018 WITH AMENDMENTS)
ICC A117.1 2009 ACCESSIBLE AND USABLE BUILDINGS AND FACILITIES
2020 ENERGY CONSERVATION CODE OF NEW YORK STATE (ECC 2018 WITH AMENDMENTS)
2020 FIRE CODE OF NEW YORK STATE (IFC 2018 WITH AMENDMENTS)
2020 MECHANICAL CODE OF NEW YORK STATE (IMC 2018 WITH AMENDMENTS)
2020 PLUMBING CODE OF NEW YORK STATE (IPC 2018 WITH AMENDMENTS)
2020 INTERNATIONAL EXISTING BUILDING CODE OF NEW YORK STATE (IEBC 2018 WITH AMENDMENTS)
2017 NATIONAL ELECTRICAL CODE (NFPA 70 WITHOUT AMENDMENTS)
- ALTERATION -- LEVEL 2 (603)
- USE GROUP CLASSIFICATION (302)
NO CHANGE TO EXISTING OCCUPANCY OR USE GROUP.
- NUMBER OF STORIES (504.4)
1 STORY
- OCCUPANCY LOAD (1004.5)
ASSEMBLY
UNCONCENTRATED (TABLE & CHAIRS) 15 s.f. (GROSS)/OCCUPANT
- EGRESS WIDTH PER OCCUPANT SERVED (1005)
STAIRS 0.37/PERSON (NON-SPRINKLERED)
OTHER EGRESS COMPONENTS 0.2*/PERSON (NON-SPRINKLERED)
- INTERIOR WALL & CEILING FINISH REQUIREMENTS (TABLE 803.1.3)
GROUP "E" AND "A2" (NON-SPRINKLERED)
VERTICAL EXITS AND EXIT PASSAGE
EXIT ACCESS CORRIDORS & OTHER EXIT WAYS
ROOMS AND ENCLOSED SPACES
A
B
C
- CORRIDORS (1020)
MINIMUM WIDTH: 8'-0" MIN. (NYSIBC)
MAIN 8'-0" MIN. (NYS SED)
SECONDARY 6'-0" MIN. (NYS SED)
FIRE RESISTANCE RATING (NON-SPRINKLERED) 1 HR.
- LINE OF TRAVEL (NYS ED-S107-h)
GROUND FLOOR 150' MAX.
OTHER THAN GROUND FLOOR 120' MAX.
- COMMON PATH OF EGRESS TRAVEL (TABLE 1006.2.1)
(NON-SPRINKLERED) 75' MAX.
30' MAX. (FIXED SEATING)
- DEAD END (NYS ED)
UNLIMITED WHEN LENGTH IS LESS THAN 1½ x WIDTH OF CORRIDOR
- FIRE PROTECTION SYSTEM (901)
A. NOTIFICATION/ALARMS YES
B. DETECTION YES
- PORTABLE FIRE EXTINGUISHERS (NYS FC-906)
C. MAXIMUM DISTANCE OF TRAVEL TO EXTINGUISHER 75'
D. MINIMUM EXTINGUISHER RATING 2-A
E. MAXIMUM FLOOR AREA FOR EXTINGUISHER 11,250 s.f.

                CODE REFERENCE PLAN LEGEND

	ROOM NAME AND NUMBER
	AREA IN SQ. FT.
	ROOM OCCUPANCY LOAD
	OCCUPANCY LOAD FACTOR
	ACTUAL EGRESS OCCUPANCY OF DOOR OR STAIR
	MAXIMUM ALLOWABLE EGRESS OCCUPANCY OF DOOR OR STAIR
	DIRECTION OF TRAVEL WITH ACCUMULATED OCCUPANCY LOAD
	ACCESSIBLE AREA OR EXIT
	1 HR. FIRE RATED WALL (TIGHT TO DECK ABOVE)
	2 HR. FIRE RATED WALL (TIGHT TO DECK ABOVE)
	SMOKE TIGHT WALL (TIGHT TO DECK ABOVE)
	EXISTING 1 HR. OCCUPANCY SEPARATION FIRE RATED PARTITION
	LINE OF FIRE SEPARATION DISTANCE FROM EACH BUILDING ON SAME PROPERTY
	MAXIMUM TRAVEL DISTANCE TO A COMMON PATH OF TRAVEL (FROM MOST REMOTE POINT)
	MAXIMUM TRAVEL DISTANCE TO AN EXIT (FROM MOST REMOTE POINT)
	AREA OF REFUGE
	RESCUE WINDOW
	FIRE EXTINGUISHER
	FIRE SEPARATION DISTANCE
	PANIC HARDWARE
	DRINKING FOUNTAIN
	EXIT

DOOR EXIT WIDTH (NON-SPRINKLERED) (1005)

32" DOOR WIDTH = 29.62" ACTUAL DOOR EXIT WIDTH @ .20"/P = 148 PERSONS
36" DOOR WIDTH = 33.62" ACTUAL DOOR EXIT WIDTH @ .20"/P = 168 PERSONS
48" DOOR WIDTH = 45.62" ACTUAL DOOR EXIT WIDTH @ .20"/P = 228 PERSONS

AT DOORS WITH CENTER MULLION:
(2)32" DOOR WIDTH = 58.5" ACTUAL DOOR EXIT WIDTH @ .20"/P = 292 PERSONS
(2)36" DOOR WIDTH = 66.5" ACTUAL DOOR EXIT WIDTH @ .20"/P = 332 PERSONS

DOOR HARDWARE NOTES


- ALL RATED DOORS SHALL HAVE POSITIVE LATCHING LOCKSETS / LATCHSETS AND CLOSERS.
- ALL DOORS LEADING TO HAZARDOUS SPACE SHALL HAVE TACTILE WARNING. HAZARDOUS AREAS INCLUDE STORAGE, PREP. ROOM, MECHANICAL ROOM, JANITOR.
- ALL DOORS EXISTING (50) OR MORE PERSONS SHALL HAVE PANIC EXIT DEVICES.
- ALL DOORS FRONTING CORRIDORS SHALL HAVE POSITIVE LATCHING LOCKSETS OR LATCHSETS.
- DOOR HARDWARE ACCESSIBLE TO PERSONS WITH DISABILITIES SHALL BE PROVIDED TO COMPLY WITH UNIFORM FEDERAL ACCESSIBILITY STANDARDS.
- BOILER ROOM SHALL HAVE A 90 MINUTE DOOR, FRAME AND HARDWARE.
- THE CONTRACTOR SHALL INSURE THAT ITEMS 1 THROUGH 7 ARE IMPLEMENTED.
- ALL HAZARDOUS AREA DOORS SHALL HAVE CLOSERS.

KEYED NOTES - GREENVILLE

1 TOTAL OCCUPANT LOAD OF EXISTING CAFETERIA 159
TOTAL OCCUPANT LOAD OF RENOVATED CAFETERIA 161
OCCUPANT LOAD OF RENOVATED CAFETERIA WILL BE LIMITED TO 159

2 AREA OF PANTRY NOT INCLUDED IN FLOOR AREA OF CAFETERIA.

* INFORMATION BASED ON DRAWINGS PROVIDED BY
EDGEMONT UNION FREE SCHOOL DISTRICT.
S.E.D. PROJECT NUMBER 64-04-06-03-0-008-007
DATED 12/18/2000

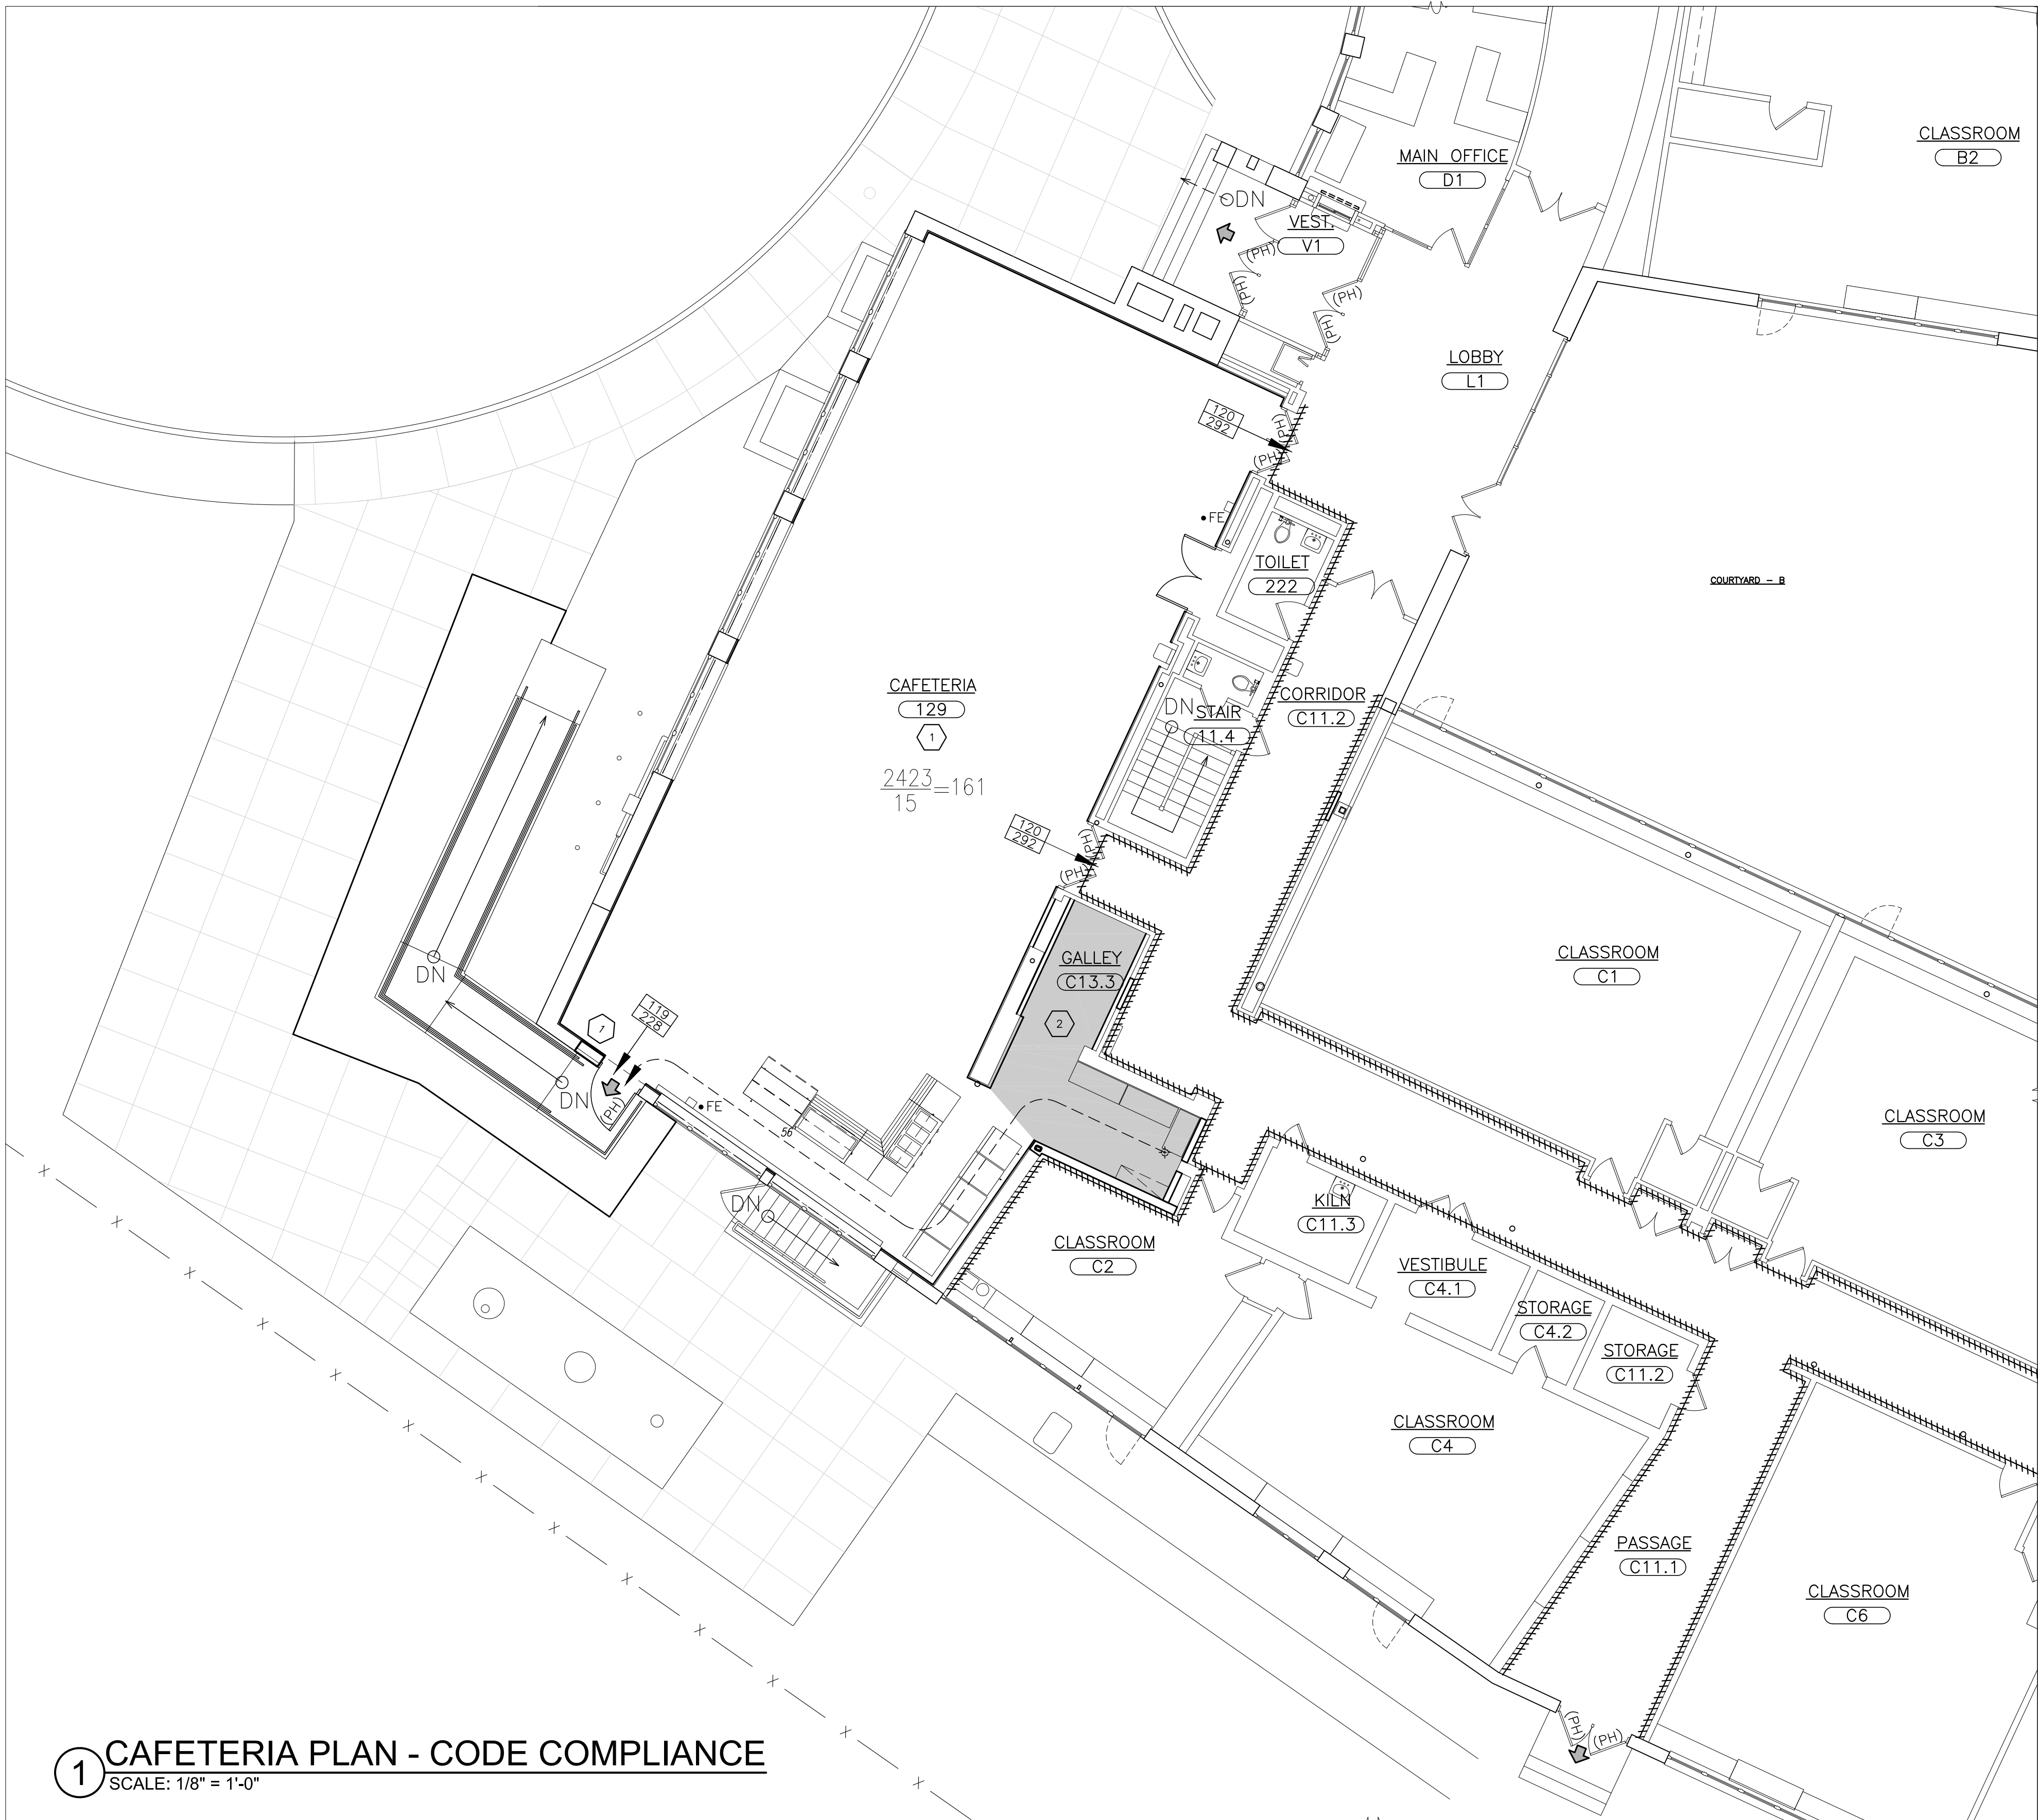

1 CAFETERIA PLAN - CODE COMPLIANCE
SCALE: 1/8" = 1'-0"

AS PER USA CONGRESS ARCHITECTURAL WORKS COPYRIGHT PROTECTION ACT OF 1990 ALL IDEAS AND DESIGNS INCLUDING DERIVATIVES THEREOF, ALL DRAWINGS AND SPECIFICATIONS CONSTITUTE THE ORIGINAL COPYRIGHT WORK BY FULLER AND DANIELO, P.C. (F&D). THE DRAWINGS AND SPECIFICATIONS AS INSTRUMENTS OF SERVICE BY F&D ARE CREATED BY F&D FOR THIS PROJECT ONLY AND REMAIN THE PRODUCT AND PROPERTY OF F&D. ANY REPRODUCTION WITHOUT THE PRIOR CONSENT OF F&D IS PROHIBITED.

48 KNOXWOOD ROAD ELLENHURST NEW YORK 11533
TEL 914.889.4444 FAX 914.889.1919
Copyright 2025 All Rights Reserved by FULLER & DANIELO, P.C.

FULLER
DANIELO
P.C.
ARCHITECTS
PLANNERS

LICENSE EXP. DATE: 02-28-2027

S.E.D. CONTROL NUMBER:
GREENVILLE ELEMENTARY SCHOOL
66-04-06-03-0-008-021

PROJECT TITLE
EDGEMONT SCHOOL DISTRICT
GREENVILLE ELEMENTARY SCHOOL
CAFETERIA RENOVATION

DRAWING TITLE
CODE COMPLIANCE SHEET

01-31-2025 BID
01-10-2022 SED SUBMISSION
DATE ISSUED TO

SHEET SIZE 30"x42"
SCALE AS NOTED
DRAWN BY F & D

DRAWING NO.
CC-1

FILE NO.
24529.01

KEY PLAN:


- S

ABATE ASBESTOS SINK MASTIC
- C


OPEN CHASE AND ABATE PIPE INSULATION (10 LF ASSUMED)
- #

LINEAR FEET OF PIPE INSULATION
- ###

SQUARE FEET OF DUCT INSULATION

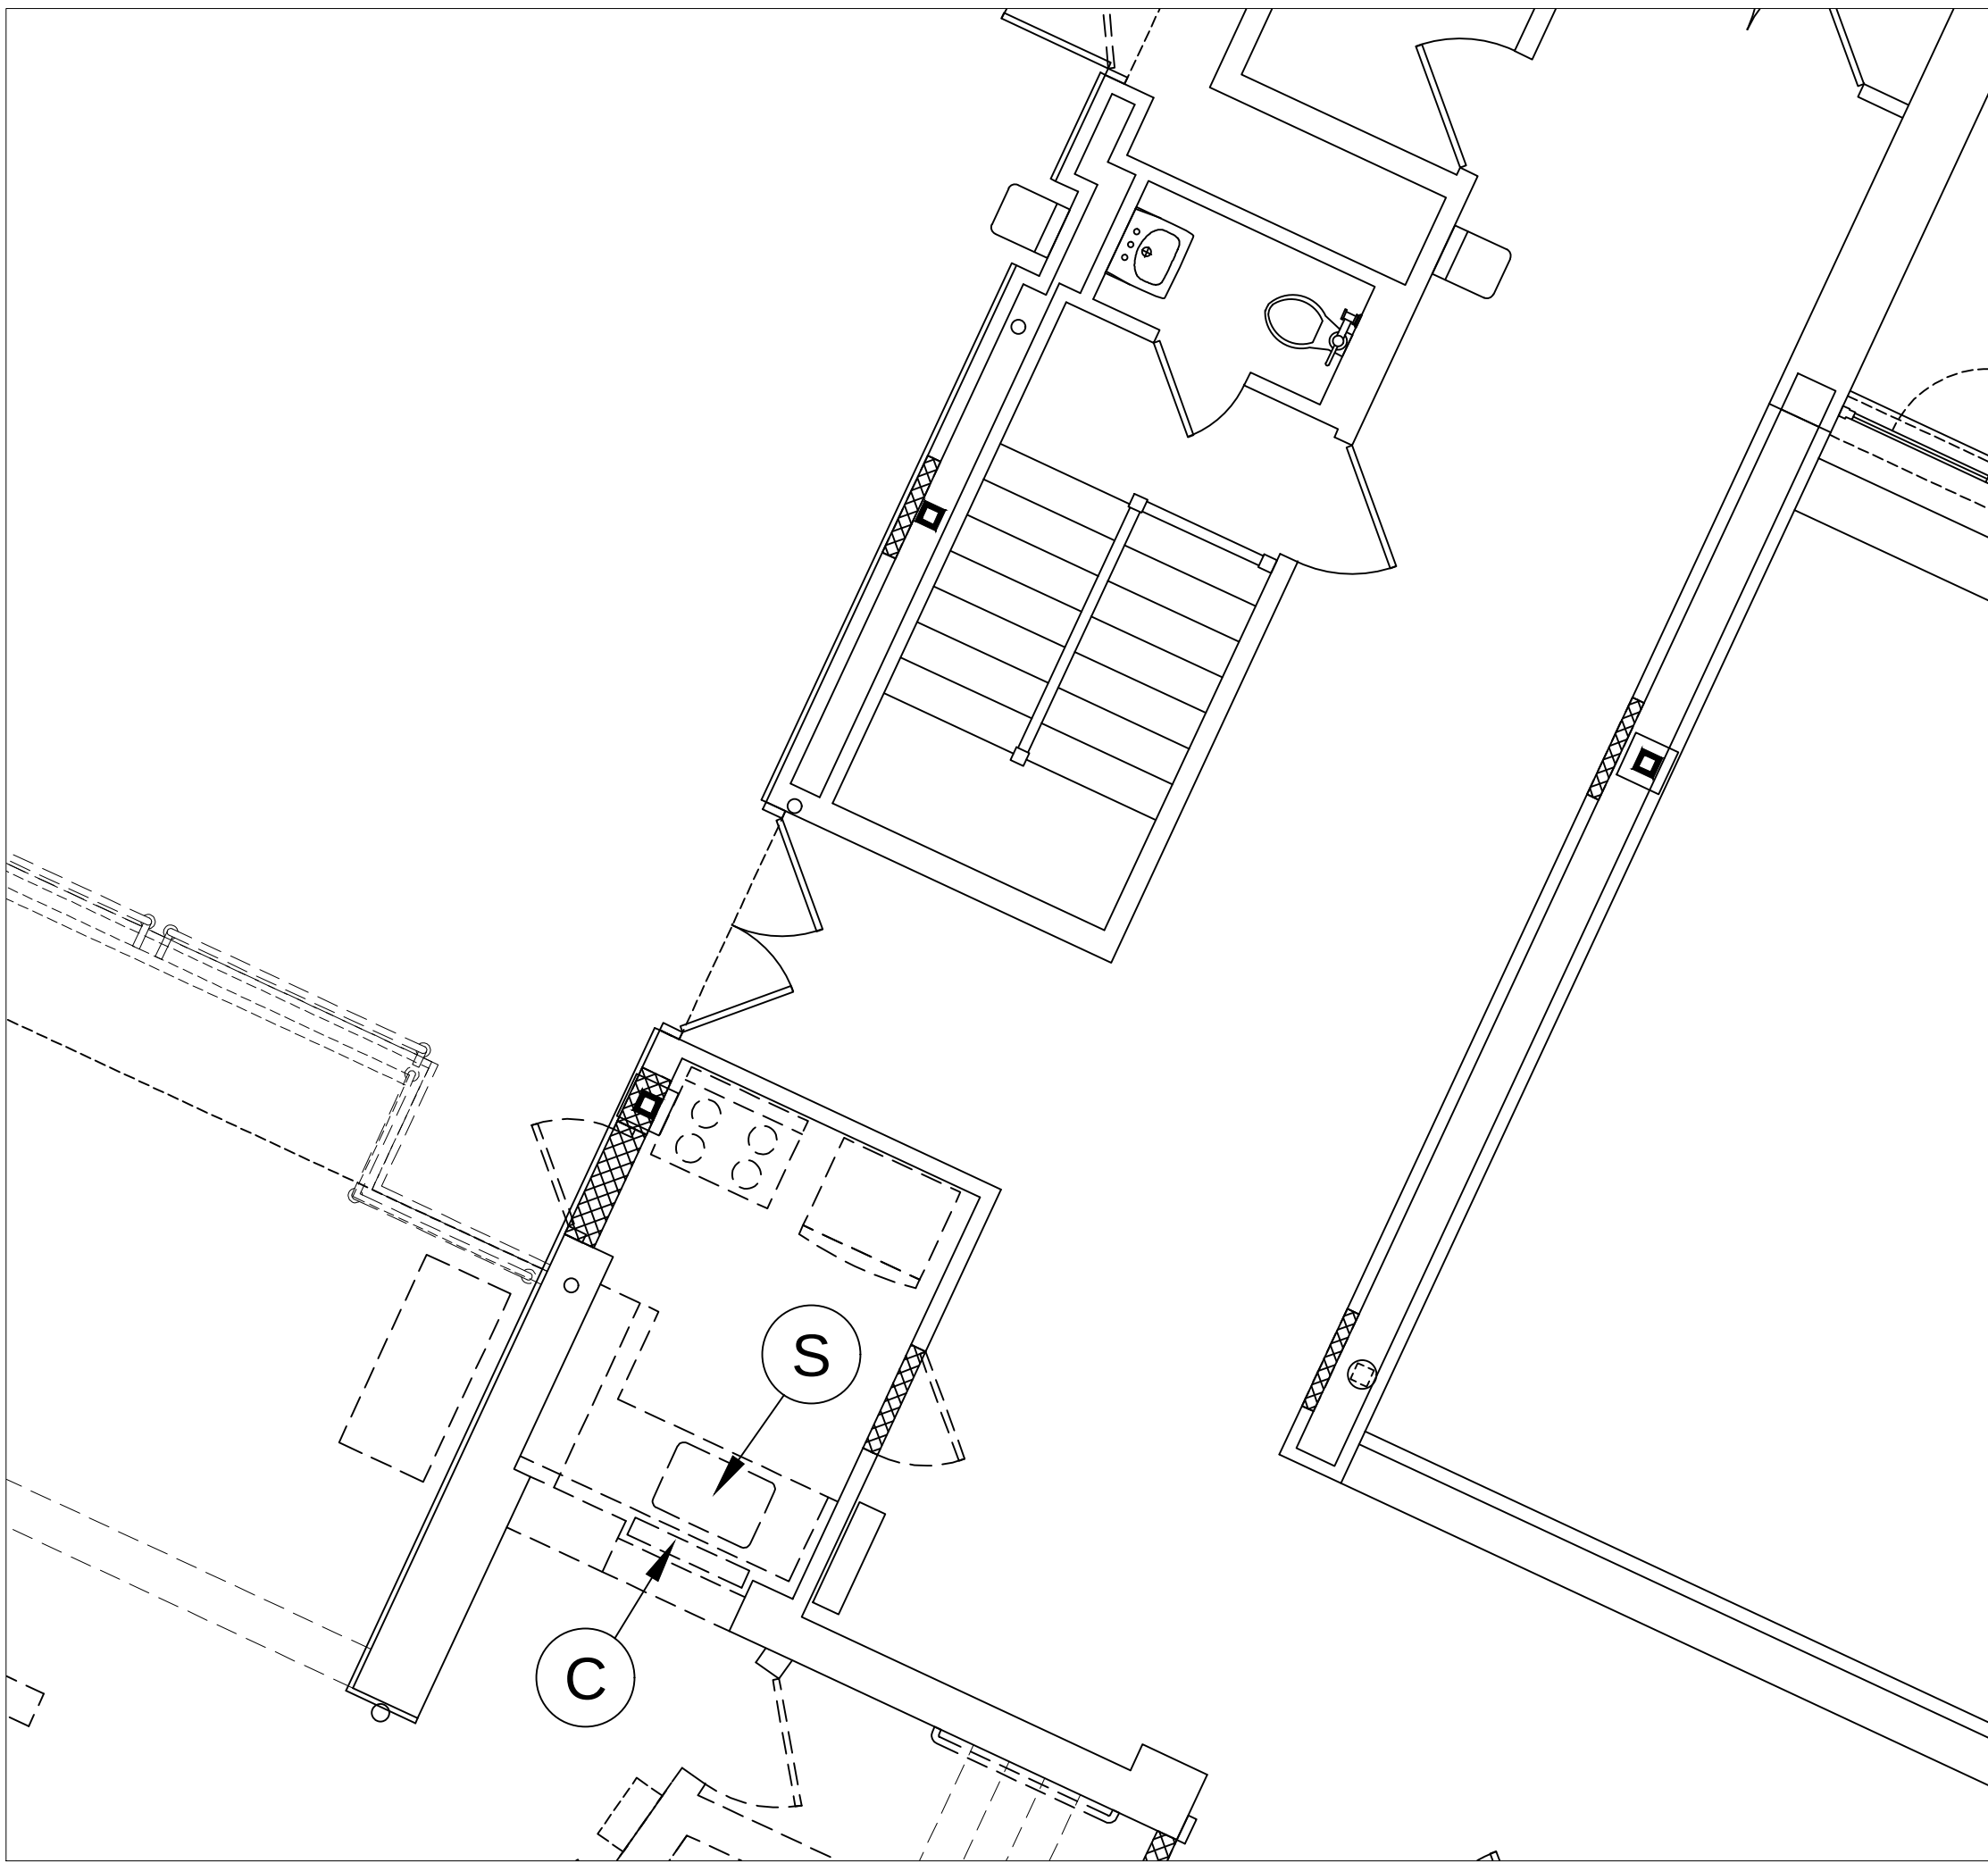

1 ABATEMENT PLAN - 1ST FLOOR WEST
SCALE:1/4" = 1' 0"

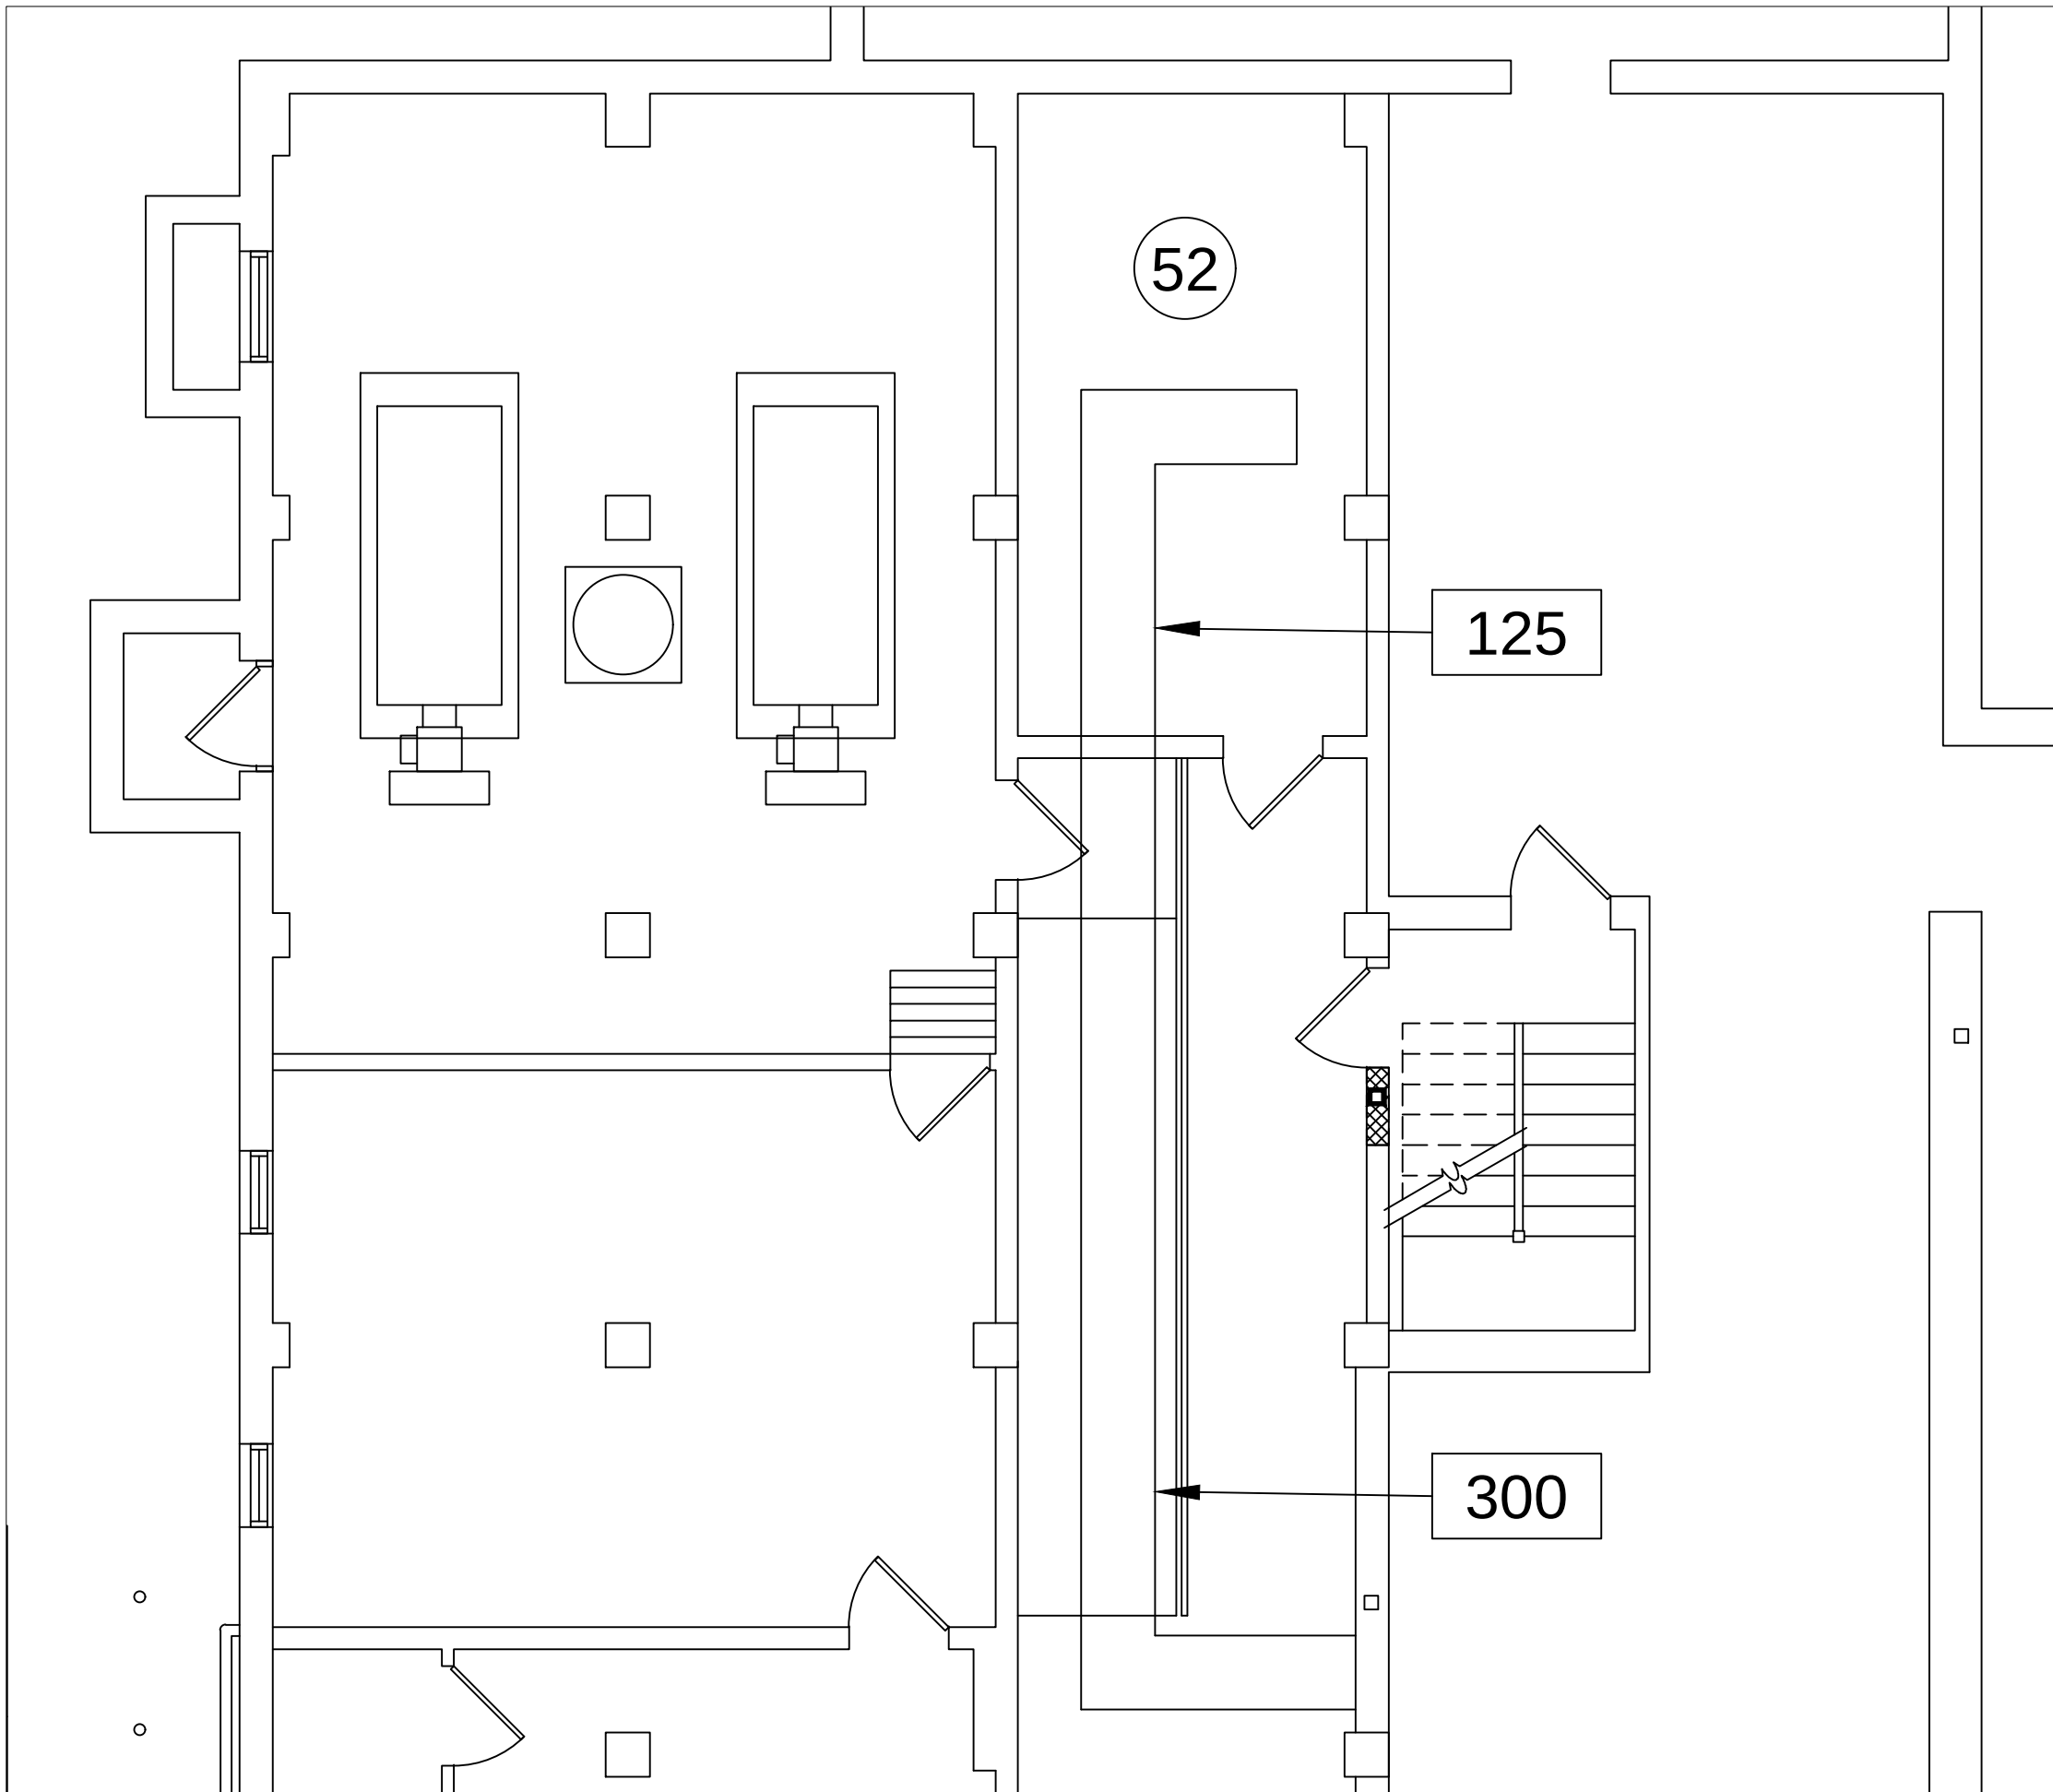

2 ABATEMENT PLAN - BASEMENT
SCALE:3/16" = 1' 0"

HAZARDOUS MATERIALS ABATEMENT - GENERAL NOTES:

- THE FIGURES SHOWN ON THE DRAWINGS ARE INCLUDED HEREIN FOR INFORMATIONAL PURPOSES ONLY AND DO NOT ABSOLVE THE CONTRACTOR FROM THEIR RESPONSIBILITY TO VERIFY ALL MEASUREMENTS PRIOR TO BIDDING. THE ENGINEER DOES NOT STATE THAT THESE MEASUREMENTS ARE COMPLETELY ACCURATE, BUT ARE BASED UPON AVAILABLE DATA.
- ALL WORK SHALL BE PERFORMED IN ACCORDANCE WITH THE PLANS AND THE SPECIFICATIONS; 12 NYCRR PART 56 (INDUSTRIAL CODE RULE 56), ANY APPROVED SITE SPECIFIC AND APPLICABLE VARIANCE; 40 CFR 763 SUBPART E (A.H.E.R.A.); 40 CFR 61 SUBPART M (N.E.S.H.A.P); 29 CFR 1926.1101; AND NY STATE EDUCATION DEPARTMENT (S.E.D.) 8-NYCRR PART 155.5 AND APPLICABLE, FEDERAL, STATE AND LOCALS CODES, REGULATIONS AND LAWS.
- THE CONTRACTOR SHALL PROPOSE TO THE ENGINEER THE METHODS USED FOR ABATEMENT, TRANSPORT, AND DISPOSAL OF ALL HAZARDOUS MATERIALS.
- ALL EMERGENCY EXITS MUST BE MAINTAINED. ALL FIRE SAFETY SYSTEMS (SPRINKLERS, SENSORS, EMERGENCY LIGHTS, AND ALARMS) MUST BE MAINTAINED IN AN OPERATING CONDITION.
- NON-FRIABLE ASBESTOS CONTAINING MATERIALS (E.G. CAULKING AND GLAZING) MAY BE TRANSPORTED FROM THE SITE AND DISPOSED OF AS CONSTRUCTION AND DEMOLITION DEBRIS IN ACCORDANCE WITH 6 NYCRR PART 360 AND 364.
- ALL NON-FRIABLE ASBESTOS CONTAINING MATERIALS REMOVED FROM THE SITE AS CONSTRUCTION AND DEMOLITION DEBRIS WASTE MUST NOT BE PROCESSED AT A C&D WASTE CONSOLIDATION FACILITY WHERE THE ACM WILL BE GRINDED OR PROCESSED BY A MEANS THAT MAY MAKE THE ACM FRIABLE REGULATED ASBESTOS CONTAINING MATERIAL (RACM). ANY ACM MADE FRIABLE BY THE CONTRACTOR SHALL BE MANAGED AND DISPOSED OF AS RACM.
- FRIABLE ASBESTOS CONTAINING MATERIALS MUST BE HANDLED, TRANSPORTED AND DISPOSED OF AS REGULATED ASBESTOS CONTAINING MATERIALS (RACM). ALL RACM MUST BE MANIFESTED FROM THE SITE USING A REGULATED WASTE MANIFEST (RWM). COPIES OF MANIFEST MUST BE PROVIDED TO OWNERS REPRESENTATIVE AT THE TIME WASTE IS REMOVED FROM SITE. MANIFEST MUST CLEARLY IDENTIFY TYPES OF WASTE AND QUANTITY OF WASTE (I.E. NUMBER OF BAGS, DRUMS) AND WHAT WASTE IS CONTAINED IN THEM.
- ALL LIQUID WASTE MUST BE CONTAINERIZED IN APPROPRIATE CONTAINERS APPROVED BY THE U.S. DEPARTMENT OF TRANSPORTATION (DOT) FOR LIQUID WASTE.
- ALL WASTE MUST BE REMOVED FROM SITE WITHIN 10 DAYS OF JOB COMPLETION. ALL WASTE MANIFESTS SHALL BE SIGNED BY DISPOSAL FACILITY AND RETURNED TO OWNER WITHIN 30 DAYS. DISPOSAL FACILITY SHALL BE THE SAME AS LISTED ON NOTIFICATIONS. ANY DEVIATIONS FROM NOTIFICATION SHALL REQUIRE APPROVAL. WASTE CANNOT BE REMOVED FROM SITE AND MIXED OR TRANSFERRED INTO OTHER WASTE CONTAINERS UNLESS COMPLETED AT A PERMITTED WASTE TRANSFER STATION.
- CONTRACTOR SHALL PREPARE AND SUBMIT A WORK PLAN SHOWING WORK AREA CONTAINMENT LOCATIONS, EMERGENCY EXITS, DECONTAMINATION AND WASTE OUT LOCATIONS, ROUTE FROM WORK AREA TO WASTE CONTAINER, AND WASTE CONTAINER LOCATIONS. (NOTE: SMALL SCALE 8.5"X 11" PLANS CAN BE REQUESTED FROM ENGINEER FOR CONTRACTORS DEVELOPMENT OF THESE PLANS).
- THE OWNER, ENGINEER AND ABATEMENT CONTRACTOR WILL AGREE ON THE LOCATION OF THE PERSONAL AND WASTE DECONTAMINATION ENCLOSURE SYSTEMS, AND WASTE CONTAINER STORAGE AREA.
- ASBESTOS CAULK ABATEMENT PROJECTS MUST BE NOTIFIED TO NYSDEL IN THE QUANTITY OF SQUARE FEET OR LINEAR FEET AND THE TOTAL NUMBER OF WINDOWS AND DOOR OPENINGS SHALL BE PROVIDED.
- THE ENGINEER THAT SIGNED THIS DOCUMENT CERTIFIES THAT TO THE BEST OF HIS KNOWLEDGE, INFORMATION, AND BELIEF THE PLANS AND SPECIFICATIONS ARE IN ACCORDANCE WITH THE APPLICABLE REQUIREMENTS OF THE NEW YORK STATE UNIFORM FIRE PREVENTION
- THE ENGINEER, JACK EISENBACH IS ACCREDITED BY THE ENVIRONMENTAL PROTECTION AGENCY UNDER THE AHERA REGULATION FOR ASBESTOS PROJECT DESIGNER (ASBESTOS HANDLING CERTIFICATE NUMBER AH 88-07060).


ASBESTOS CONTAINING SINK MASTIC

- THIS WORK CONSISTS OF THE REMOVAL AND DISPOSAL OF WATERPROOFING MASTIC APPLIED TO THE UNDERSIDE OF THE SINK FIXTURE.
- REFER TO THE KEY PLAN FOR EXACT LOCATION FOR THIS WORK.
- THE ABATEMENT CONTRACTOR SHALL WRAP AND DISPOSE OF THE FIXTURE AND DIOSPOSE OF AS ASBESTOS CONTAMINATED.
- THE ABATEMENT CONTRACTOR SHALL COORDINATE THE DISCONNECT WITH THE PLUMBING CONTRACTOR.
- ALL WORK SHALL BE PERFORMED INSIDE A NEGATIVE PRESSURE TENT ENCLOSURE.
- THE WORK AREA SHALL BE CLEARED BY PCM AIR SAMPLING.

ASBESTOS CONTAINING PIPE AND FITTING INSULATION IN CHASE WALLS

- THIS WORK CONSISTS OF THE REMOVAL AND DISPOSAL OF ASBESTOS CONTAINING PIPE INSULATION AND FITTINGS INSIDE A WALL CHASE.
- THE WORK INCLUDES THE ABATEMENT OF A MINIMUM OF 10 LINEAR FEET OF PIPE INSULATION AND FITTINGS.
- PIPING IN THE CHASE WAS NOT ACCESSIBLE AT THE TIME OF THE INSPECTION AND SHALL BE ASSUMED POSITIVE.
- WORK SHALL BE PERFORMED INSIDE A NEGATIVE PRESSURE TENT ENCLOSURE WITH GLOVEBAG ABATEMENT.
- THE AREA SHALL BE CLEARED BY PCM AIR SAMPLING.

KEY PLAN:

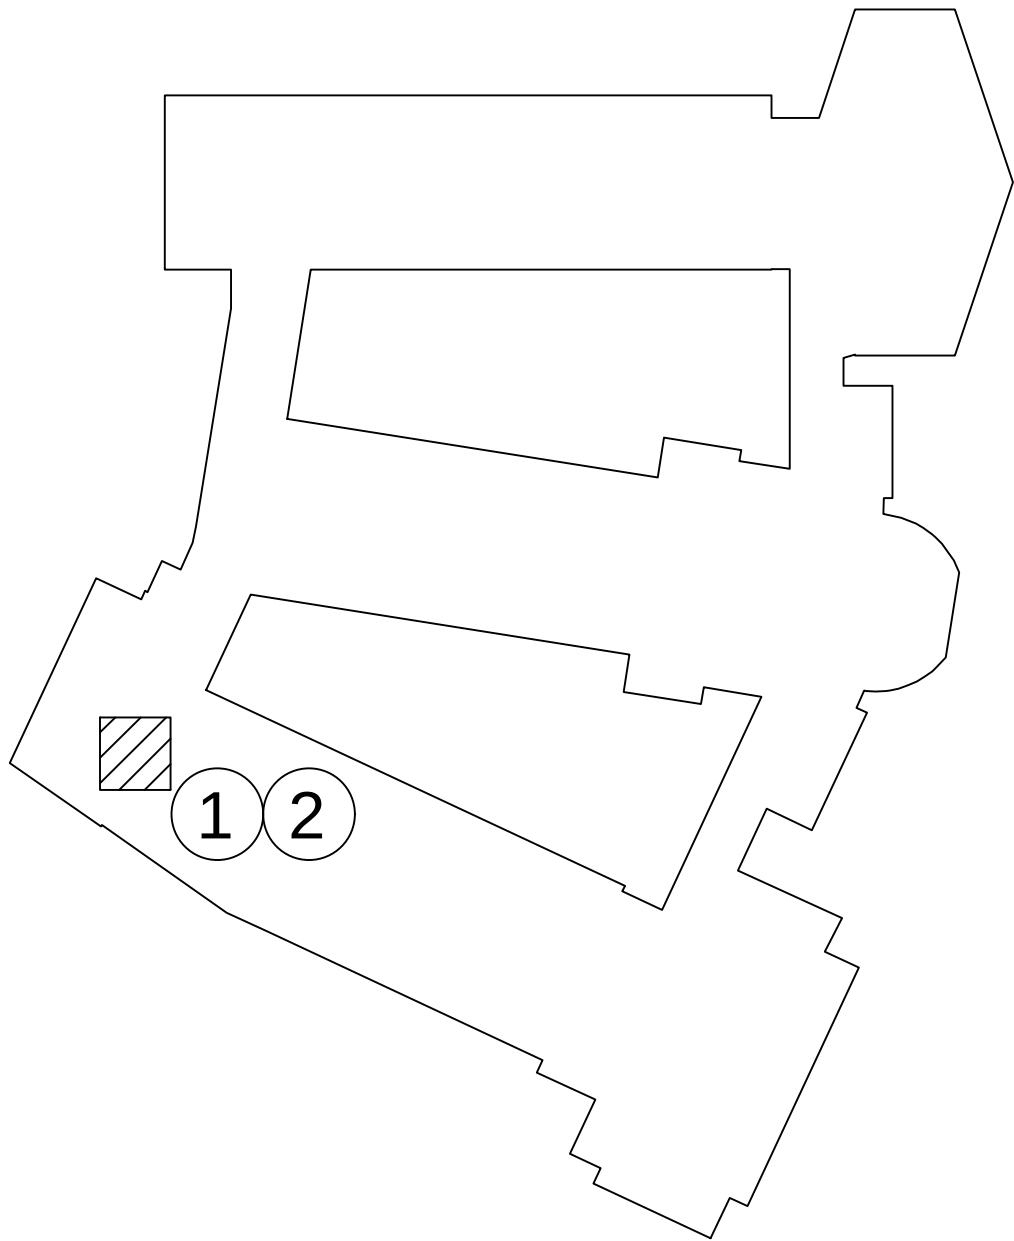

AS PER USA CONGRESS ARCHITECTURAL WORKS COPYRIGHT PROTECTION ACT OF 1990 ALL IDEAS AND DESIGNS INCLUDING DERIVATIVES THEREOF, ALL DRAWINGS AND SPECIFICATIONS CONSTITUTE THE ORIGINAL COPYRIGHT WORK BY FULLER AND D'ANGELO, P.C. (F&D). THE DRAWINGS AND SPECIFICATIONS AS INSTRUMENTS OF SERVICE BY F&D ARE CREATED BY F&D FOR THIS PROJECT ONLY AND REMAIN THE PRODUCT AND PROPERTY OF F&D. ANY REPRODUCTION WITHOUT THE PRIOR CONSENT OF F&D IS PROHIBITED.













438 KNOXWOOD ROAD
TEL: 914.898.4444
FAX: 914.898.1717
E-MAIL: info@fuller-dangelo.com
Copyright 2007 All Rights Reserved by FULLER & D'ANGELO P.C.

FULLER
& D'ANGELO
P.C.
ARCHITECTS
PLANNERS



S.E.D. CONTROL NUMBER:
GREENVILLE ELEMENTARY SCHOOL
66-04-06-03-0-008-021

PROJECT TITLE: EDGEMONT SCHOOL DISTRICT GREENVILLE ELEMENTARY SCHOOL CAPITOL RENOVATION	DRAWING TITLE: HAZARDOUS MATERIALS REMOVAL PLAN
11-31-2025	B I D
DATE	ISSUED TO
SHEET SIZE: 30"x42"	DRAWING NO. HM100
SCALE: AS NOTED	DRAWN BY: E & R
	FILE NO. 24529.01

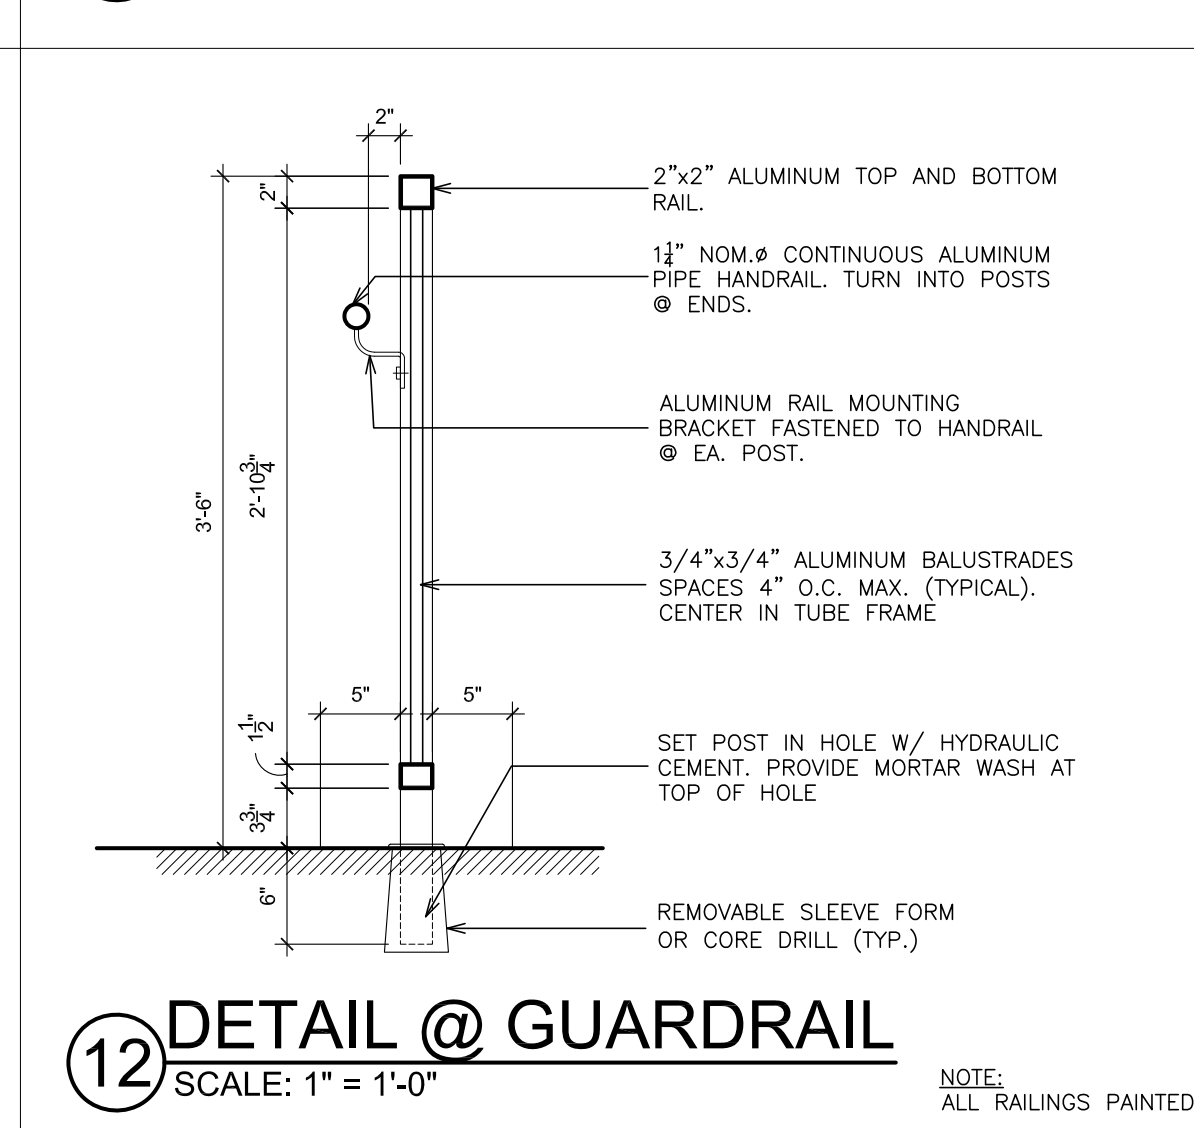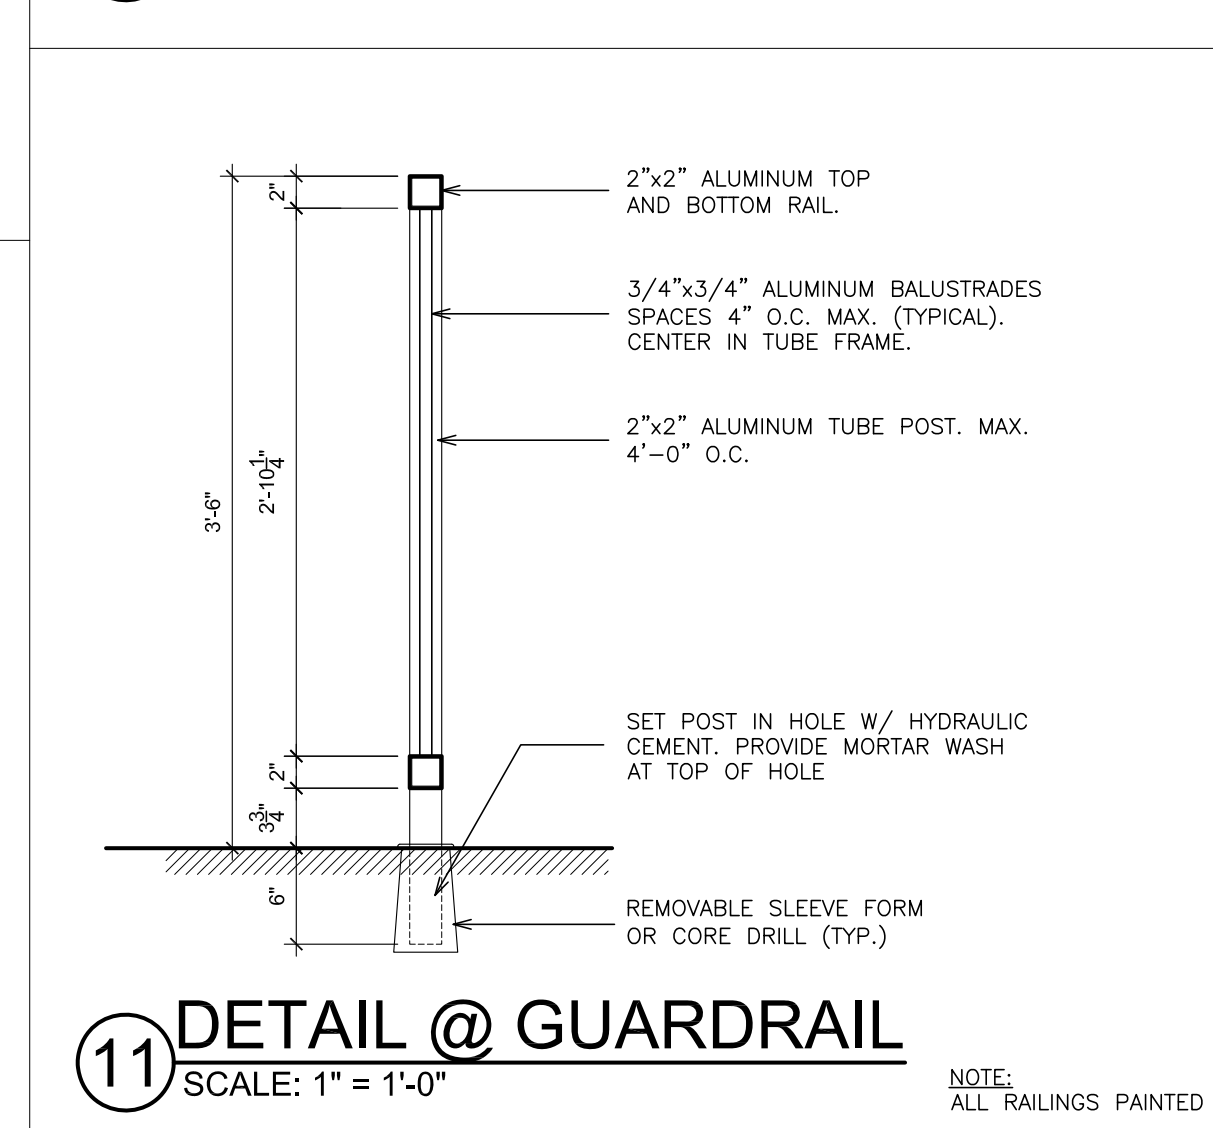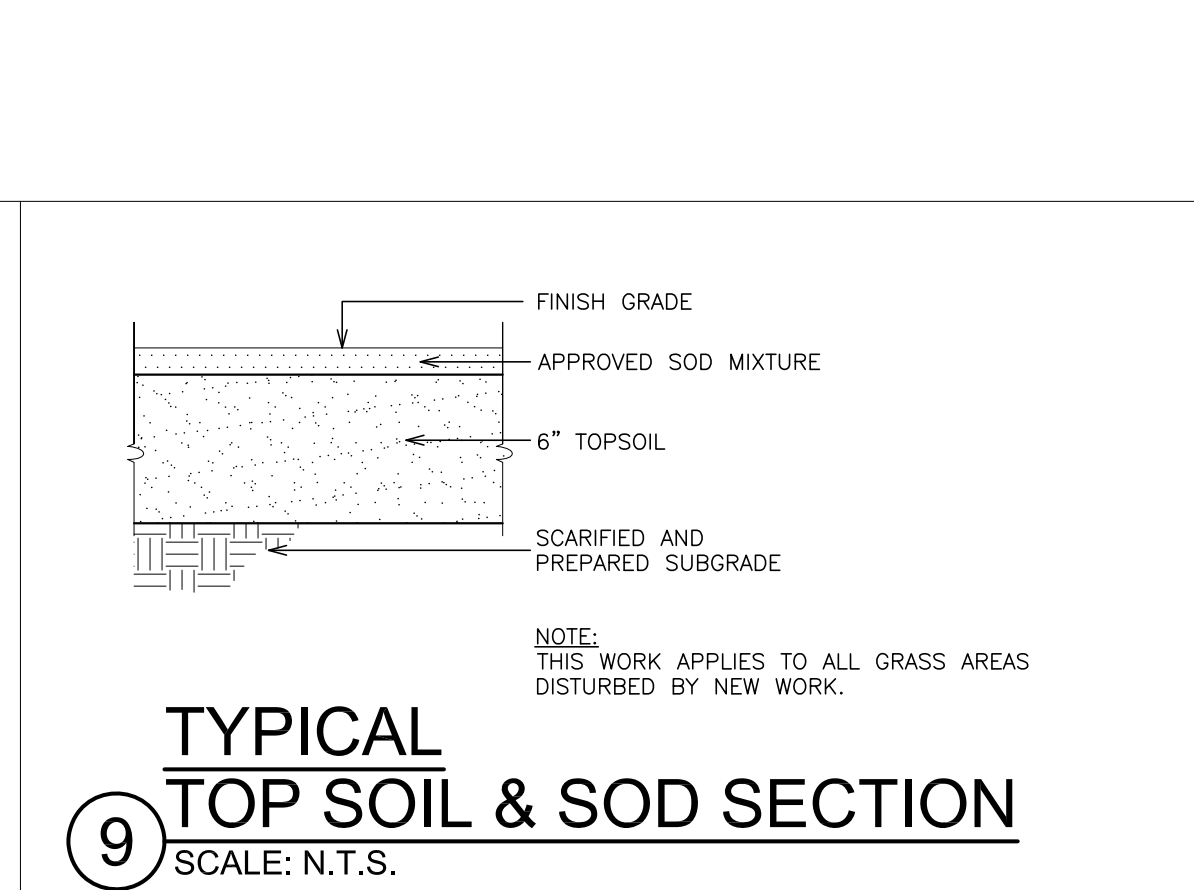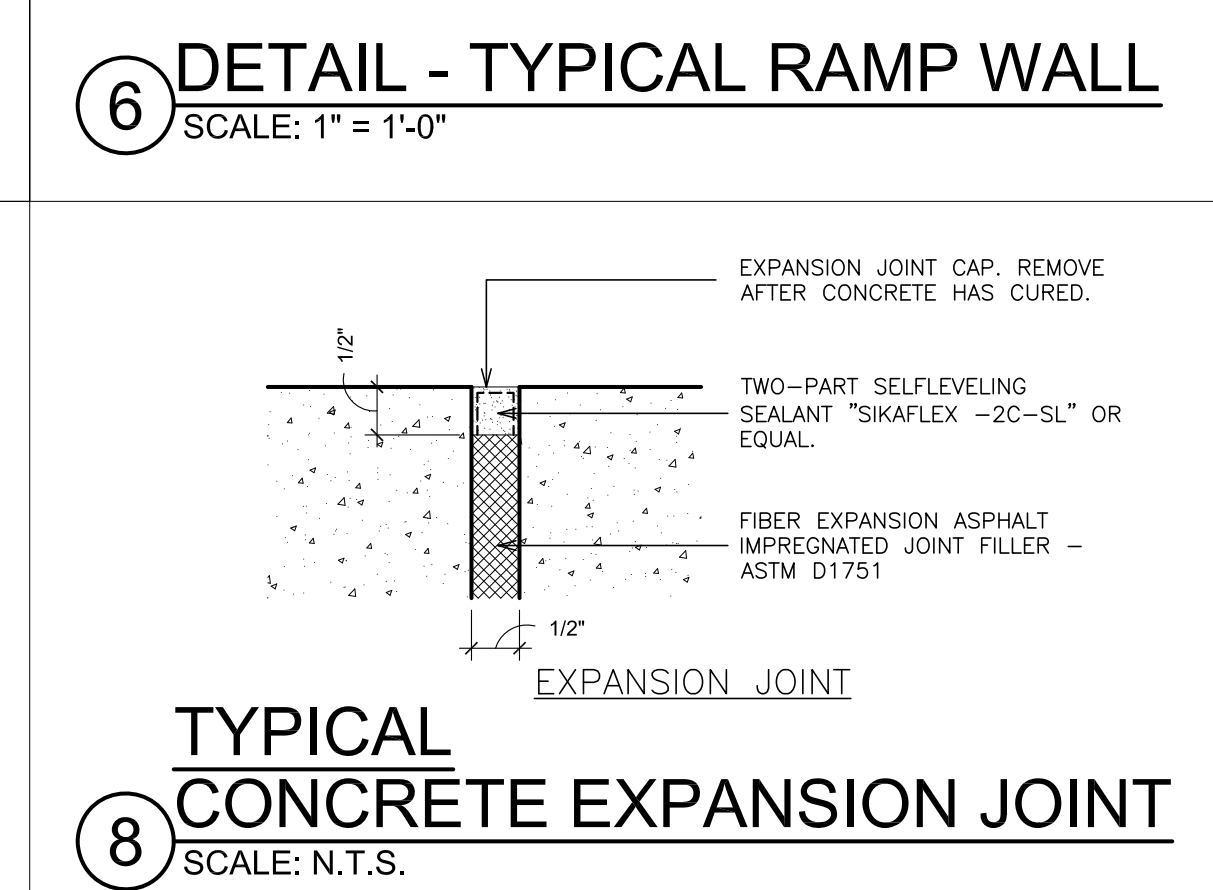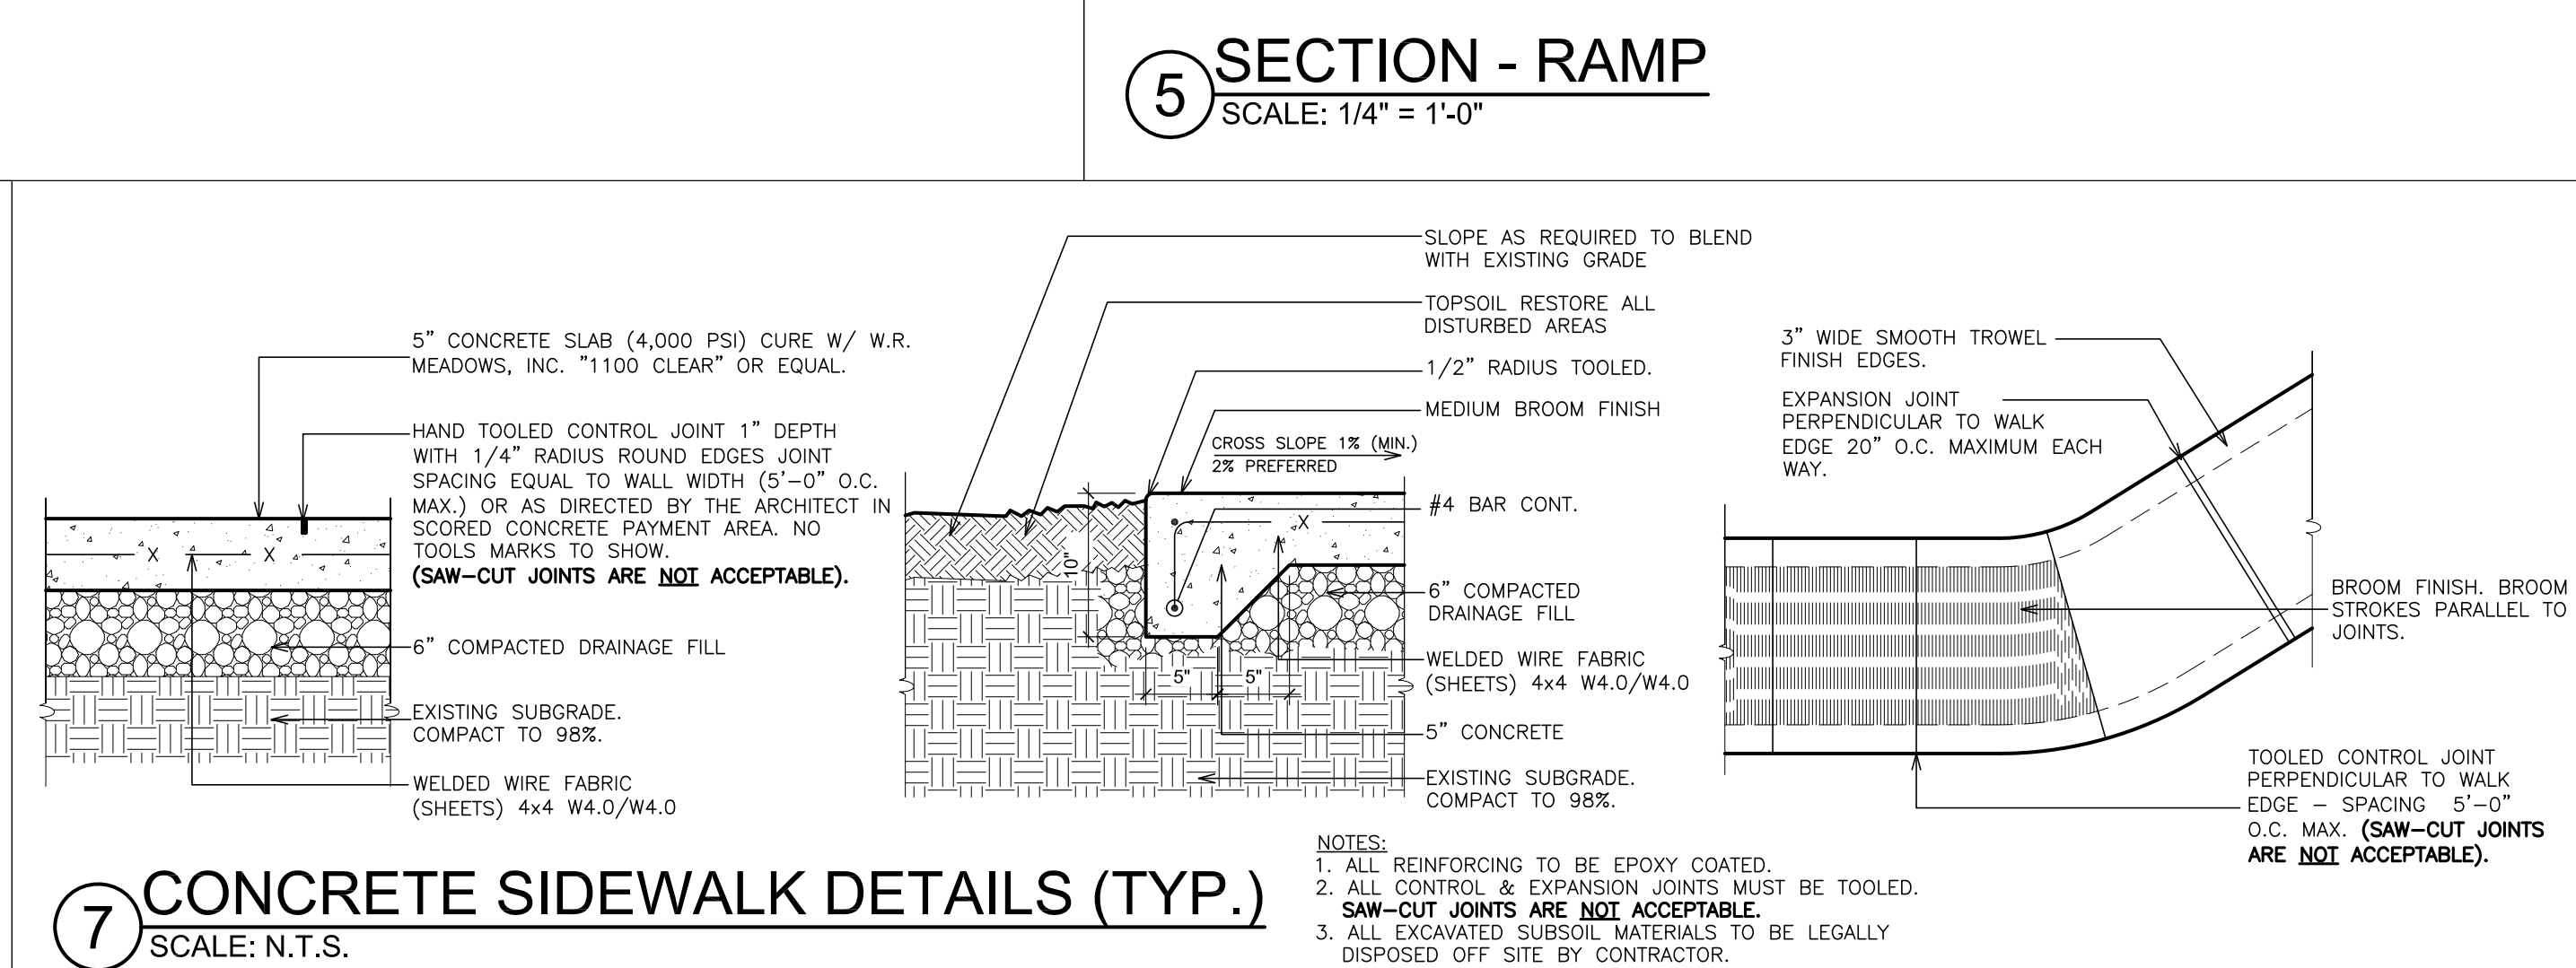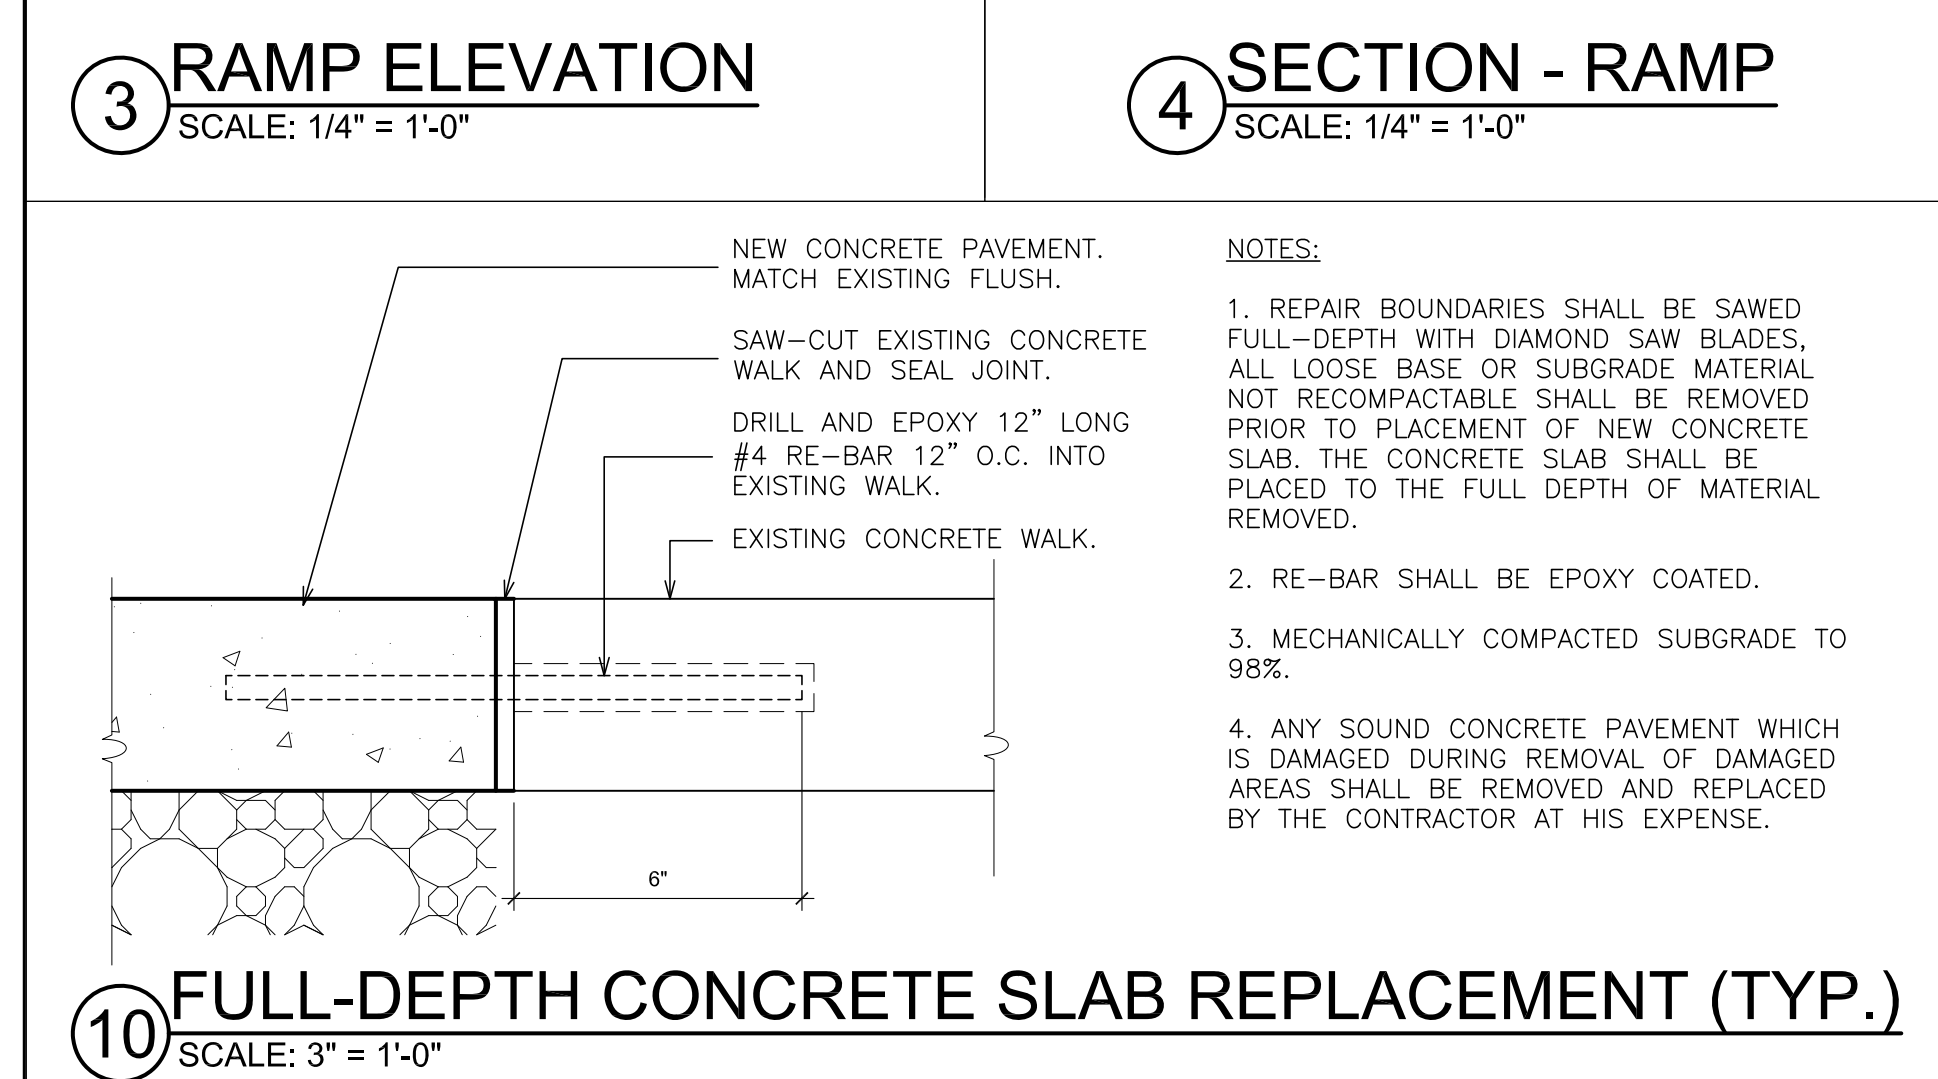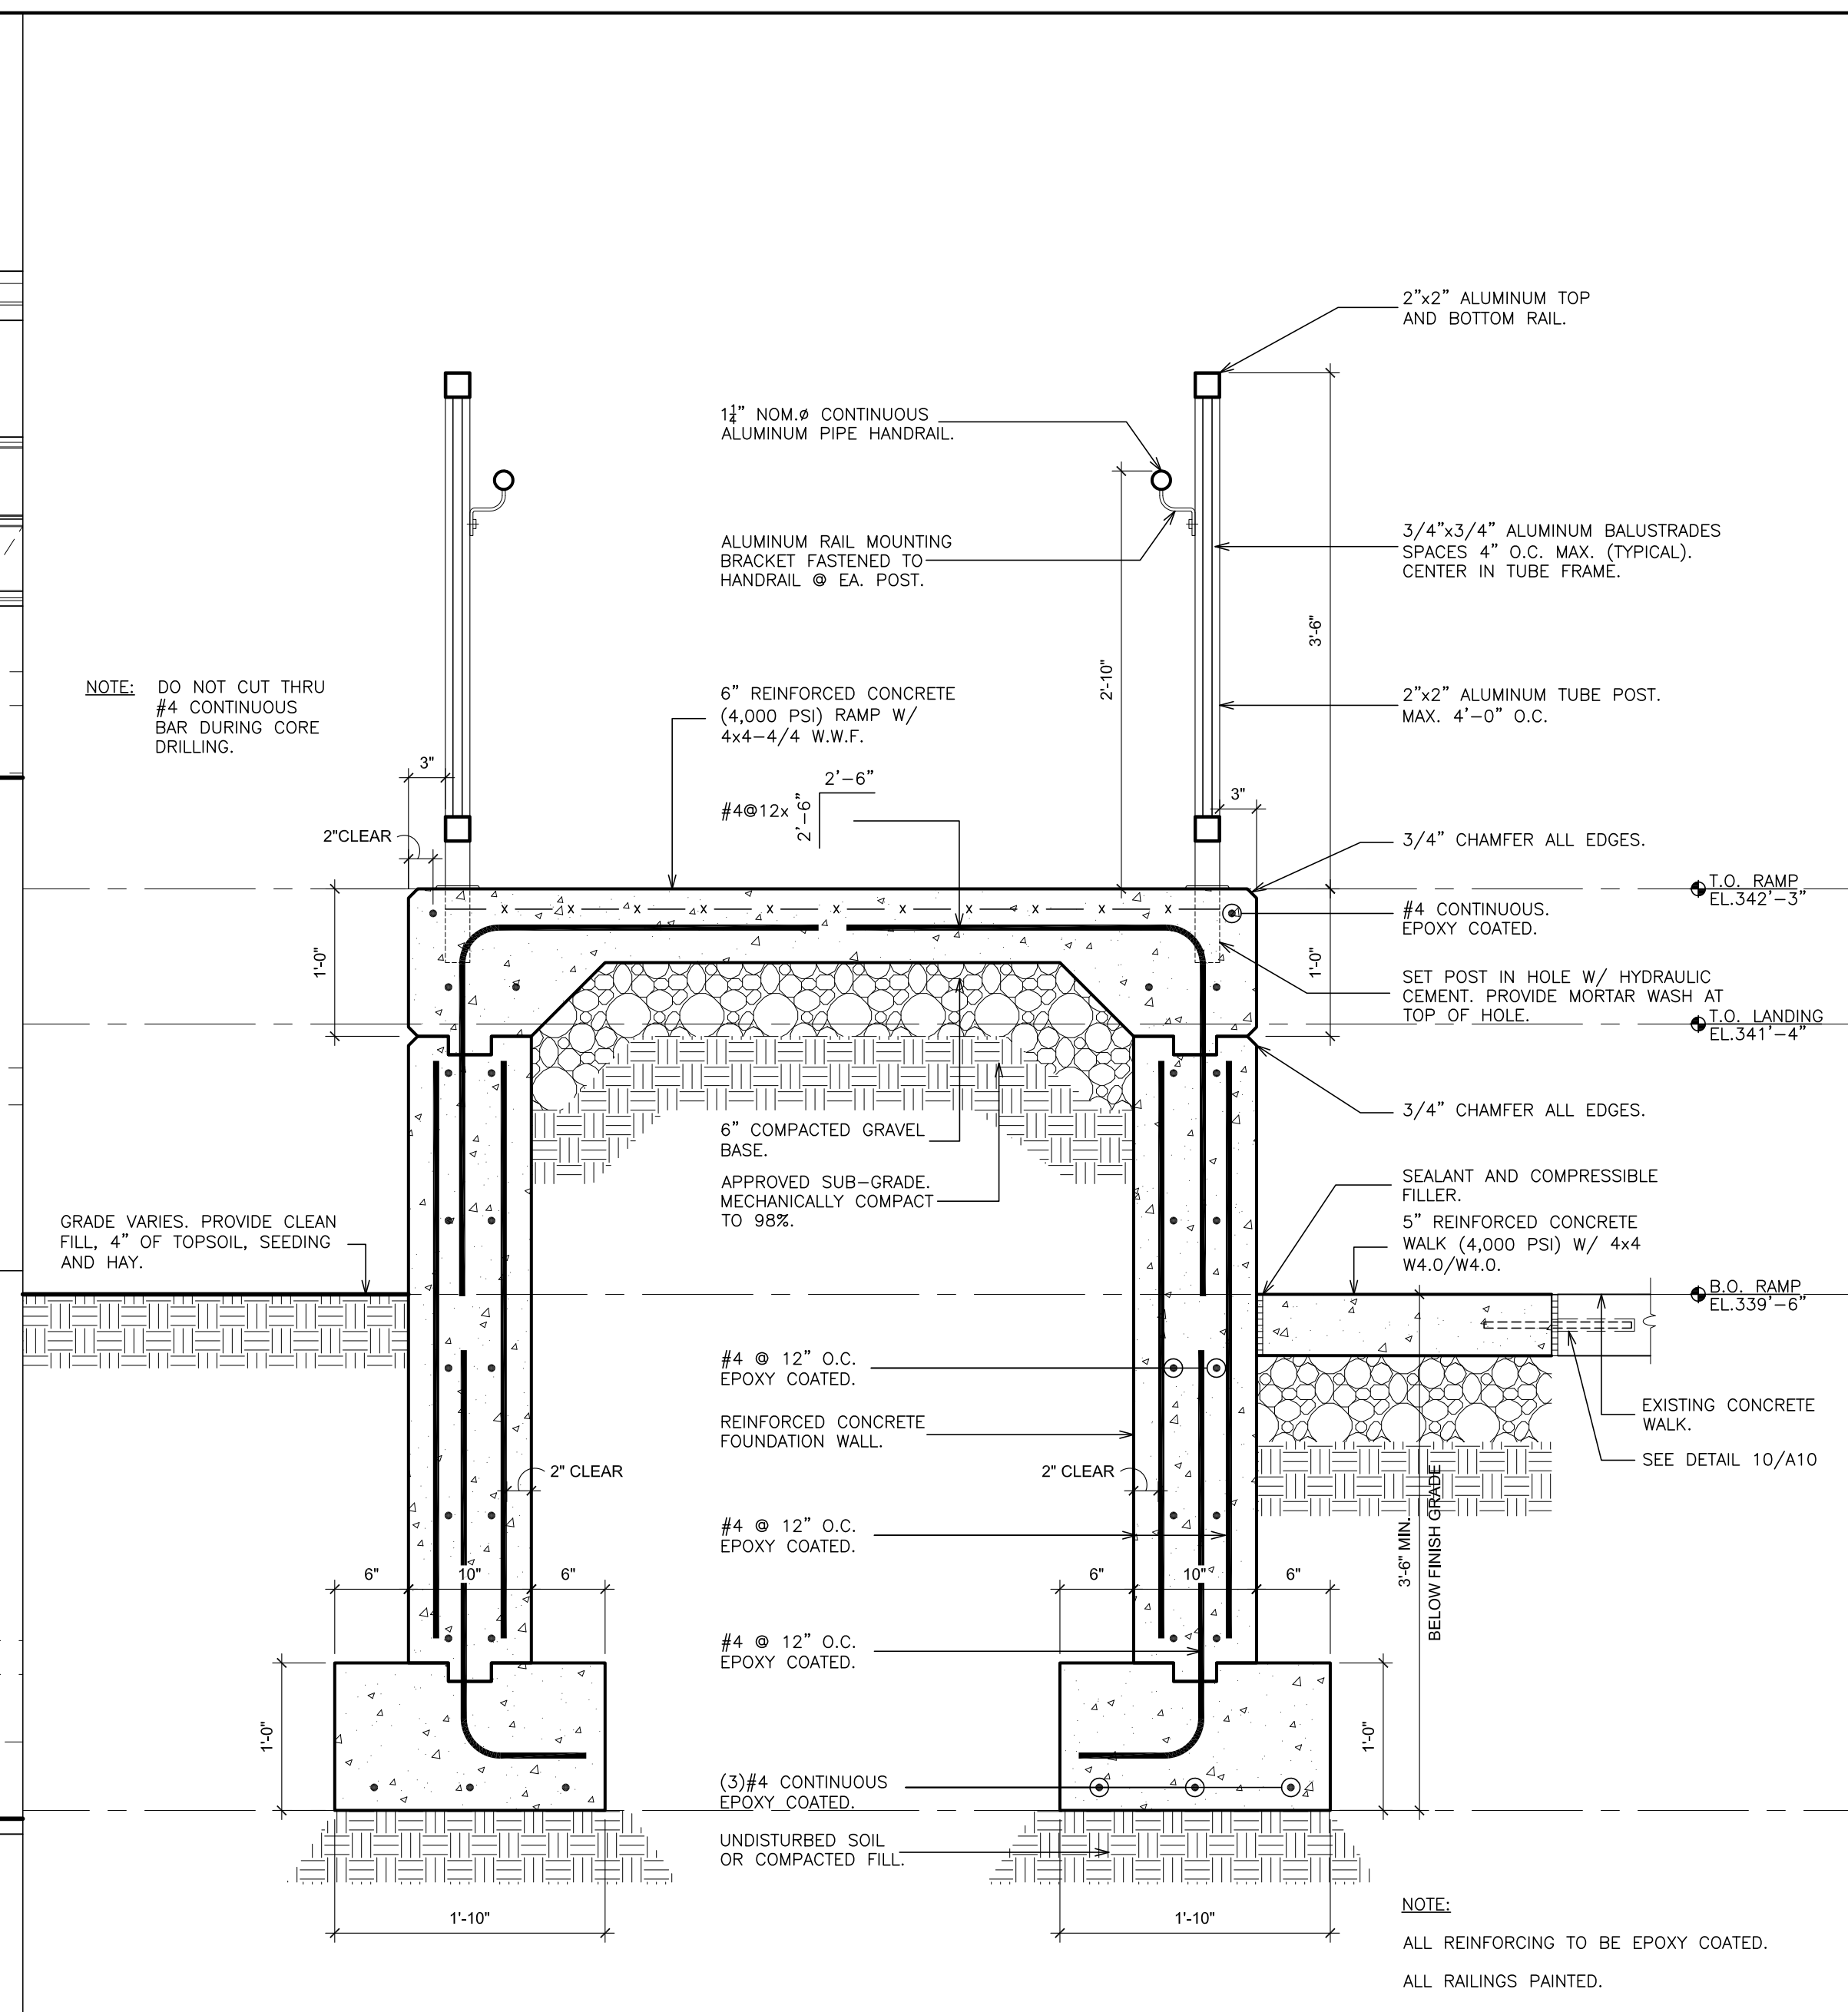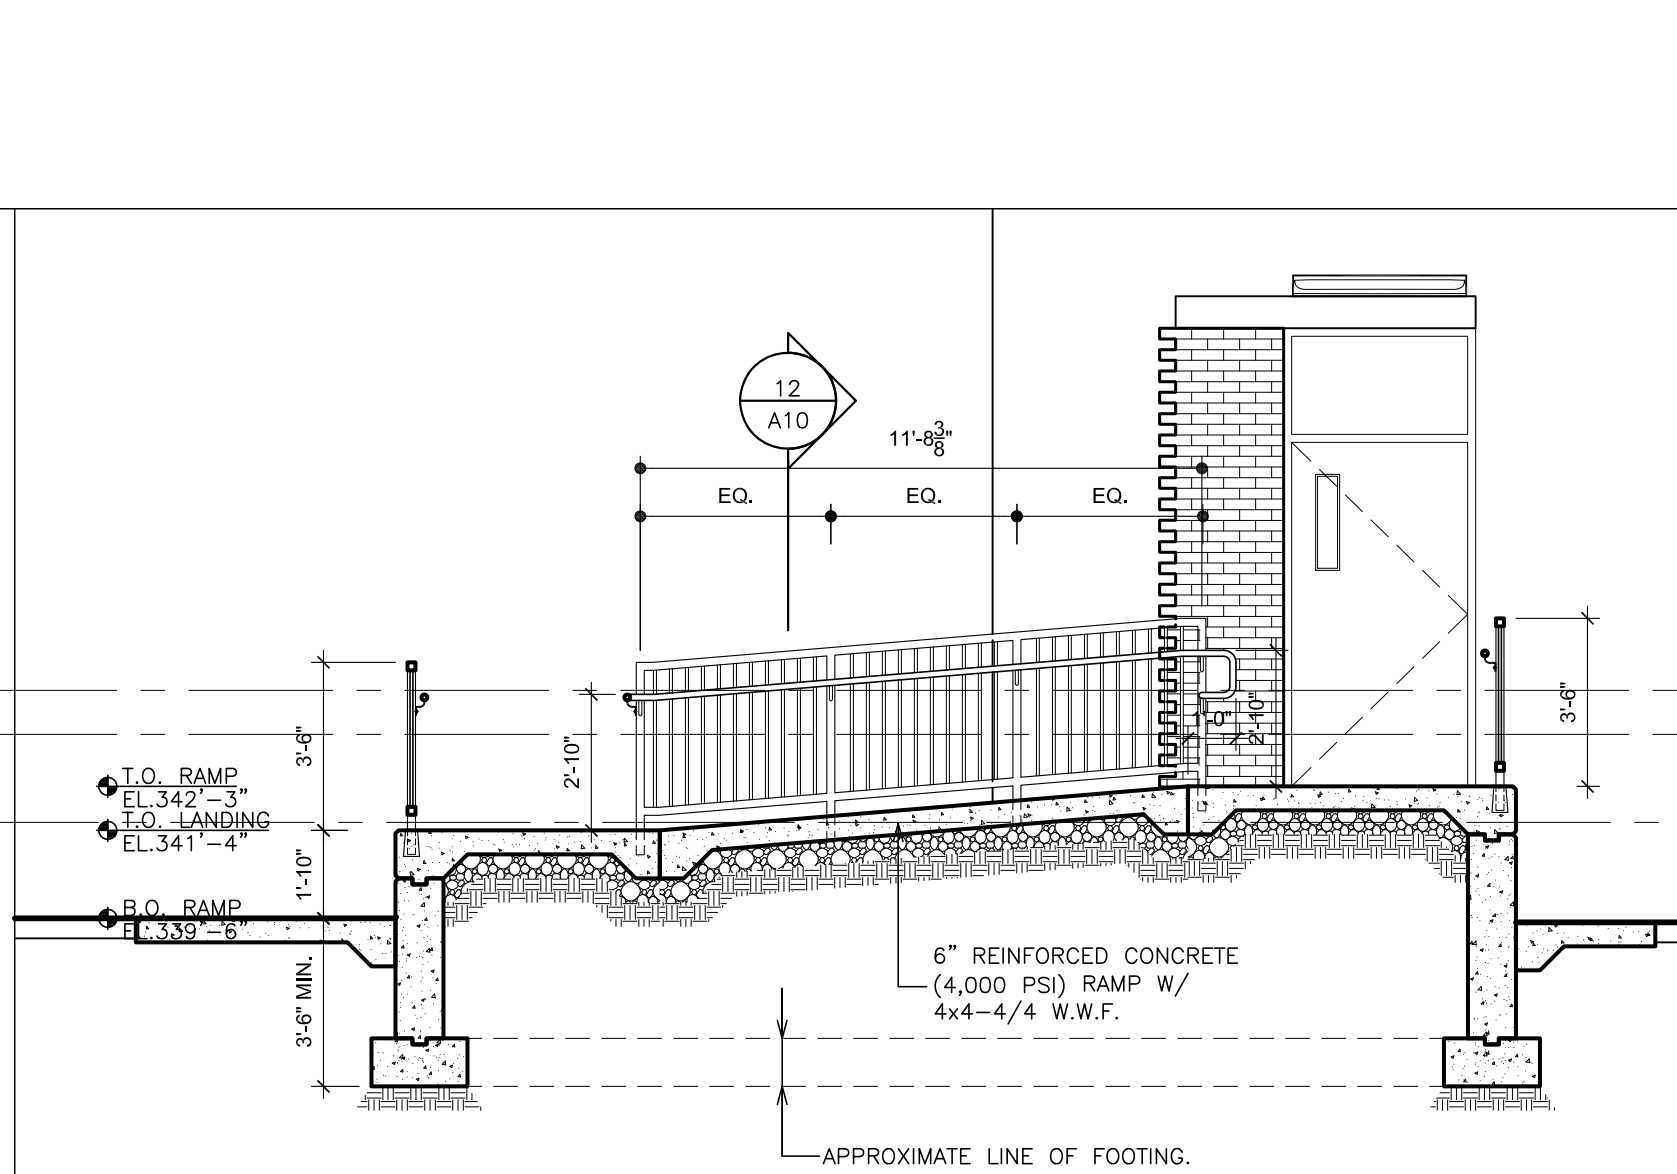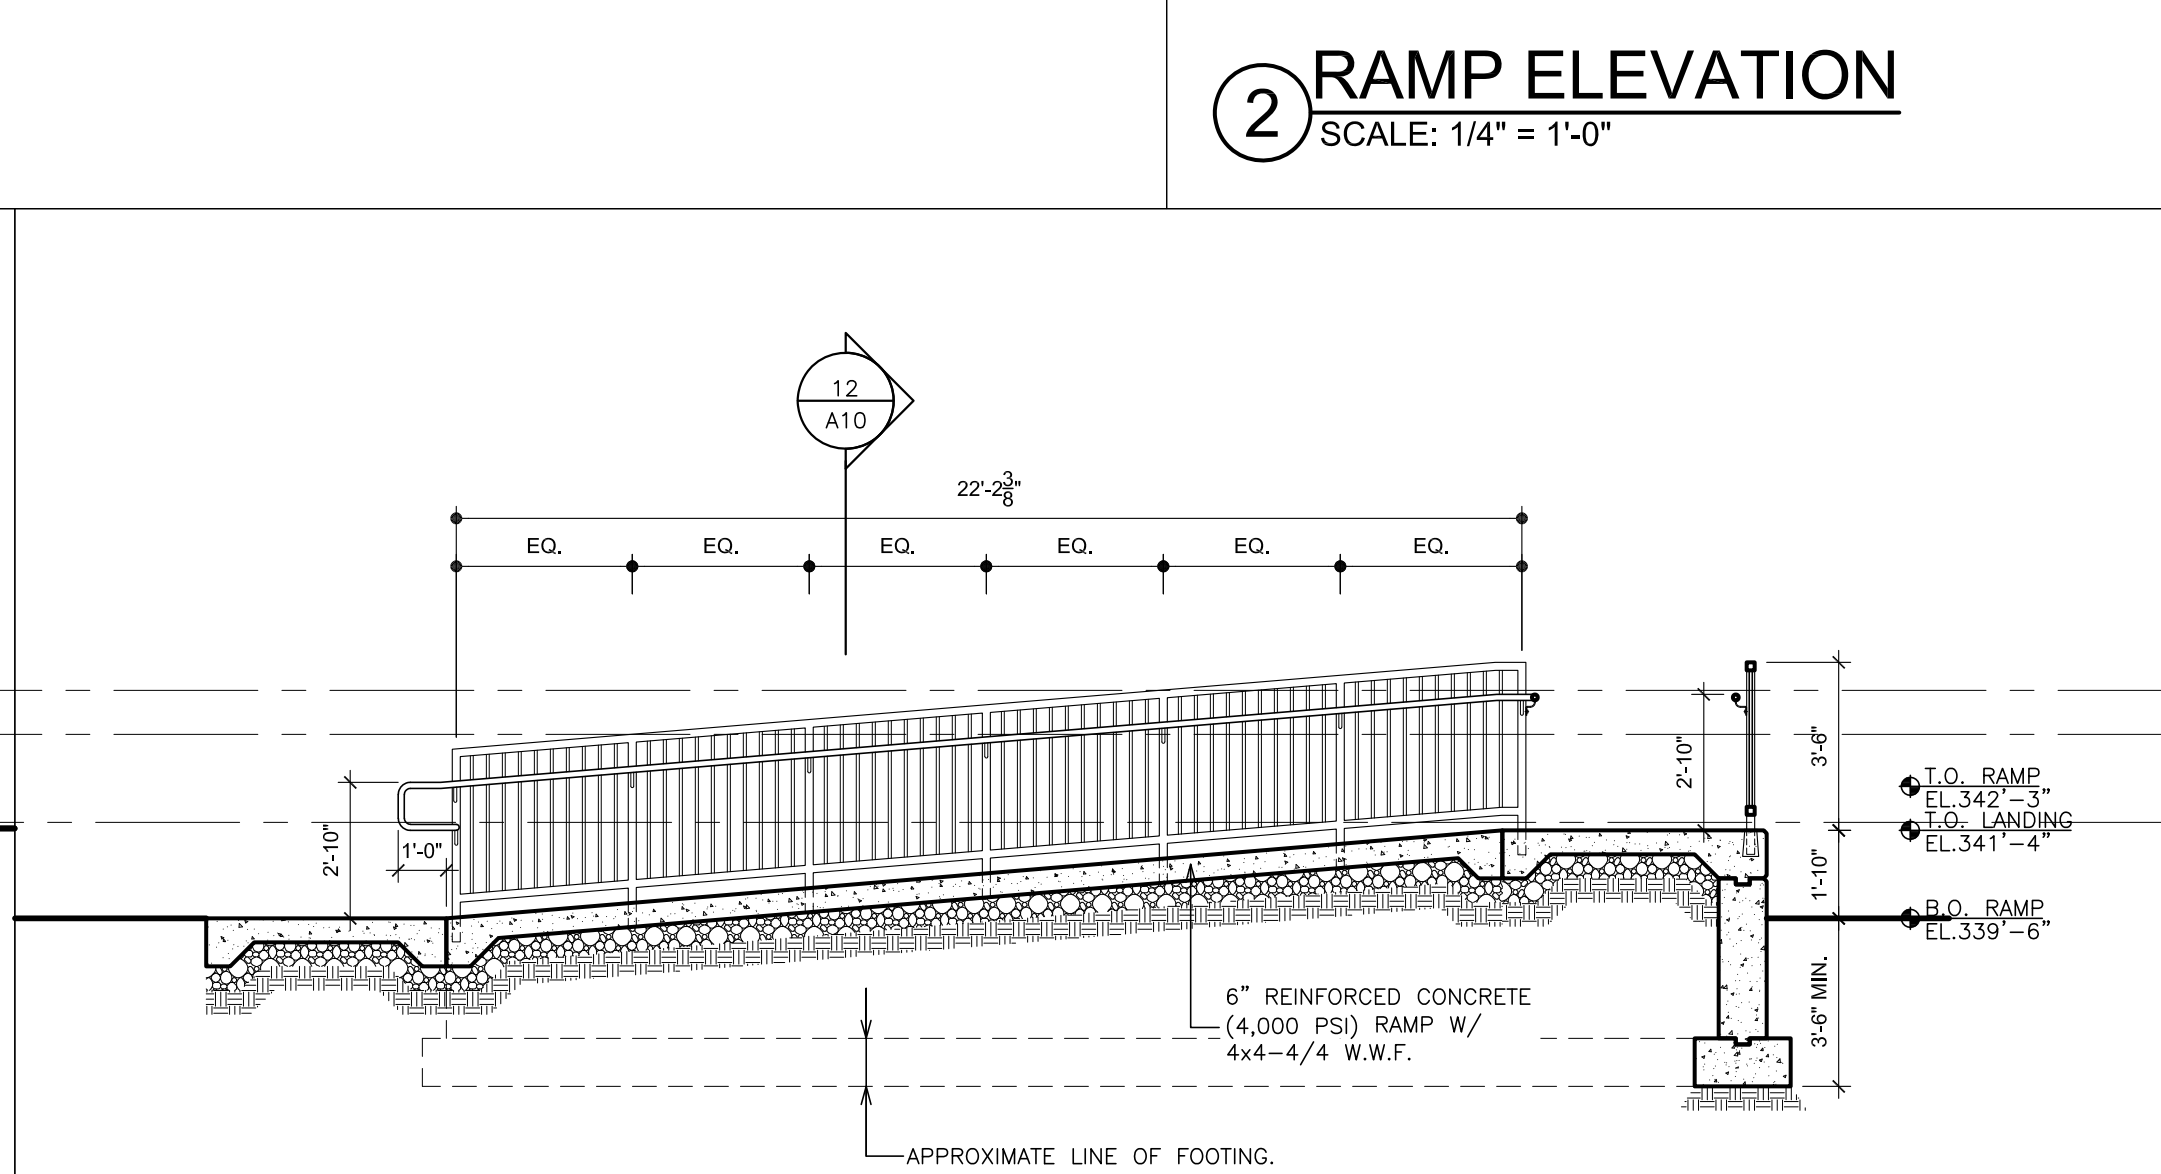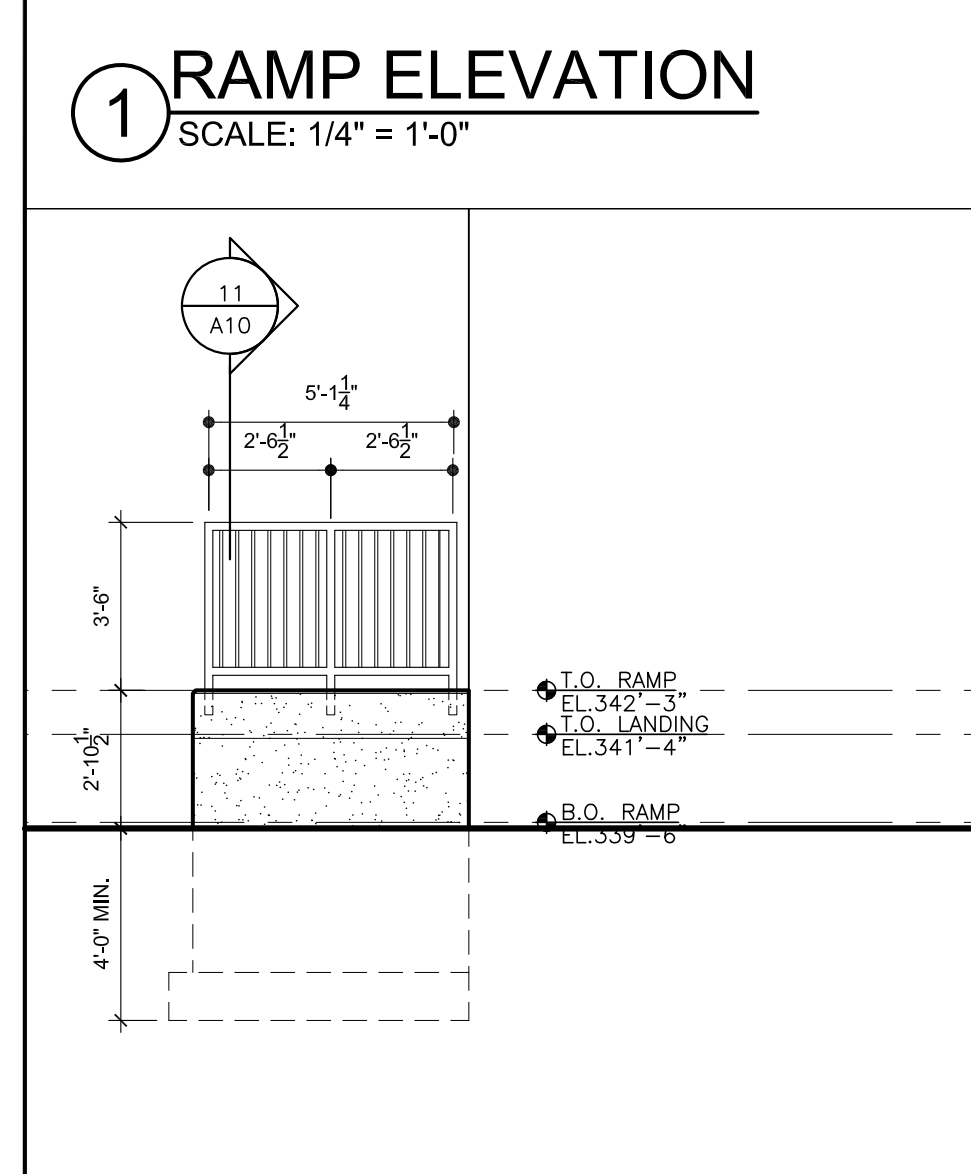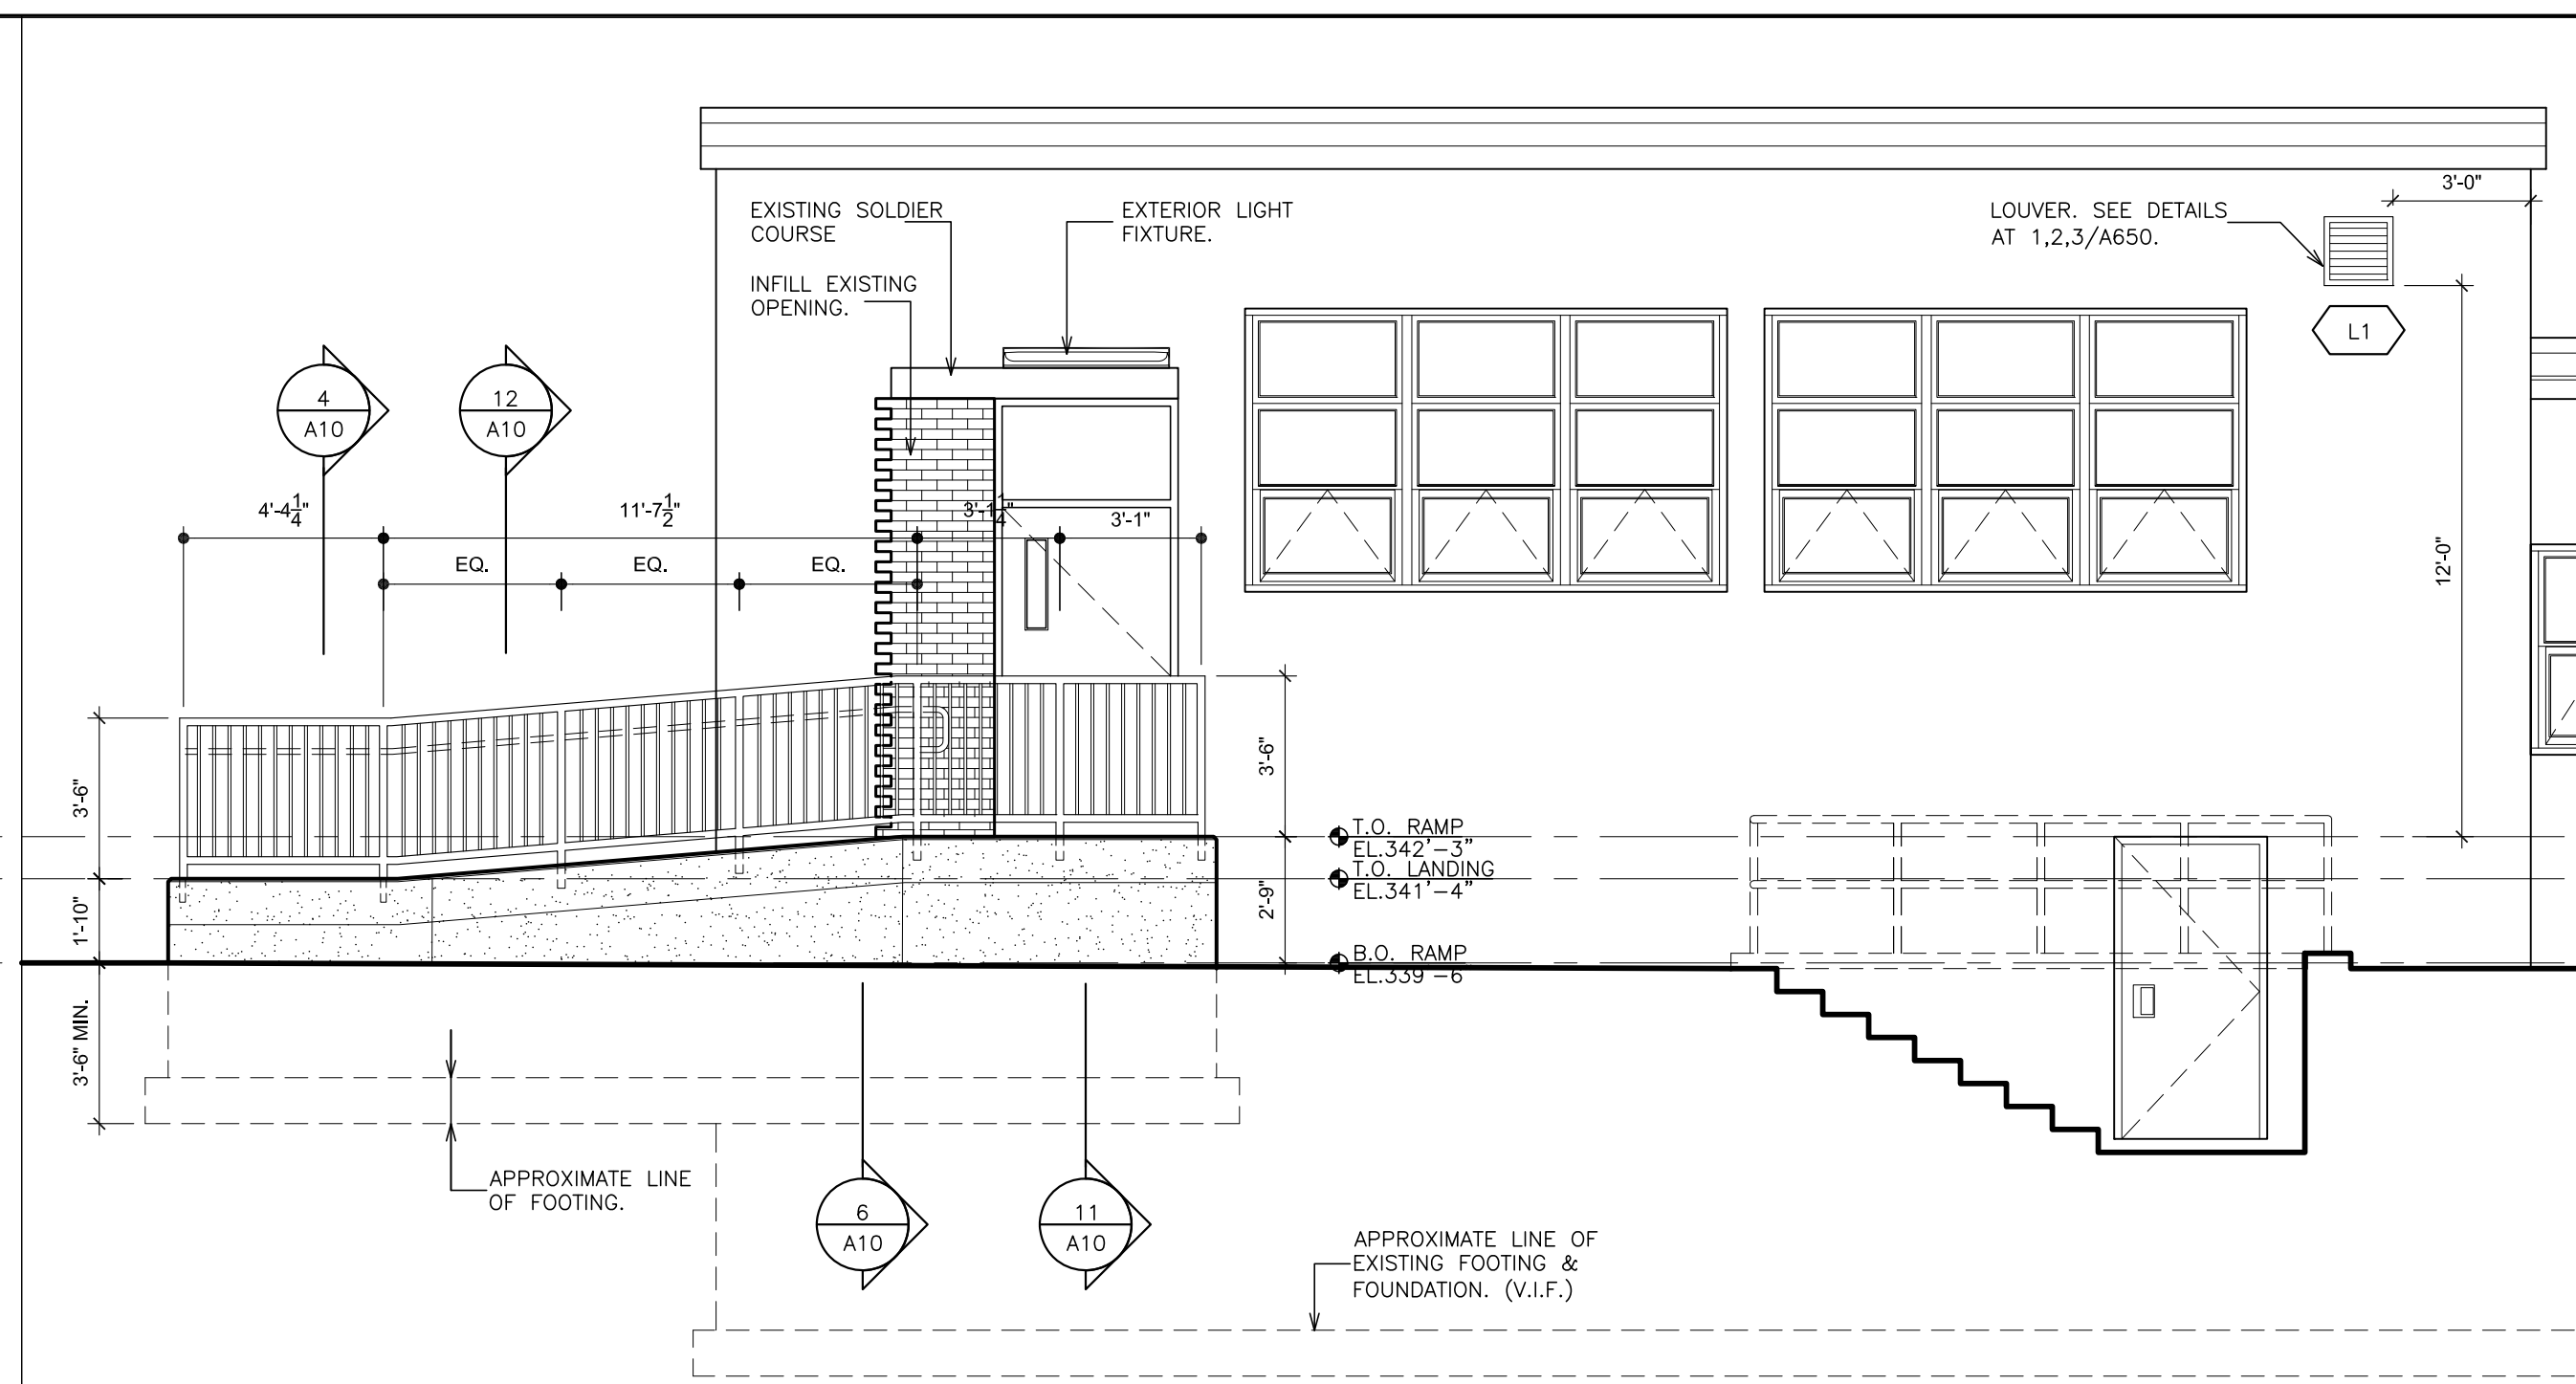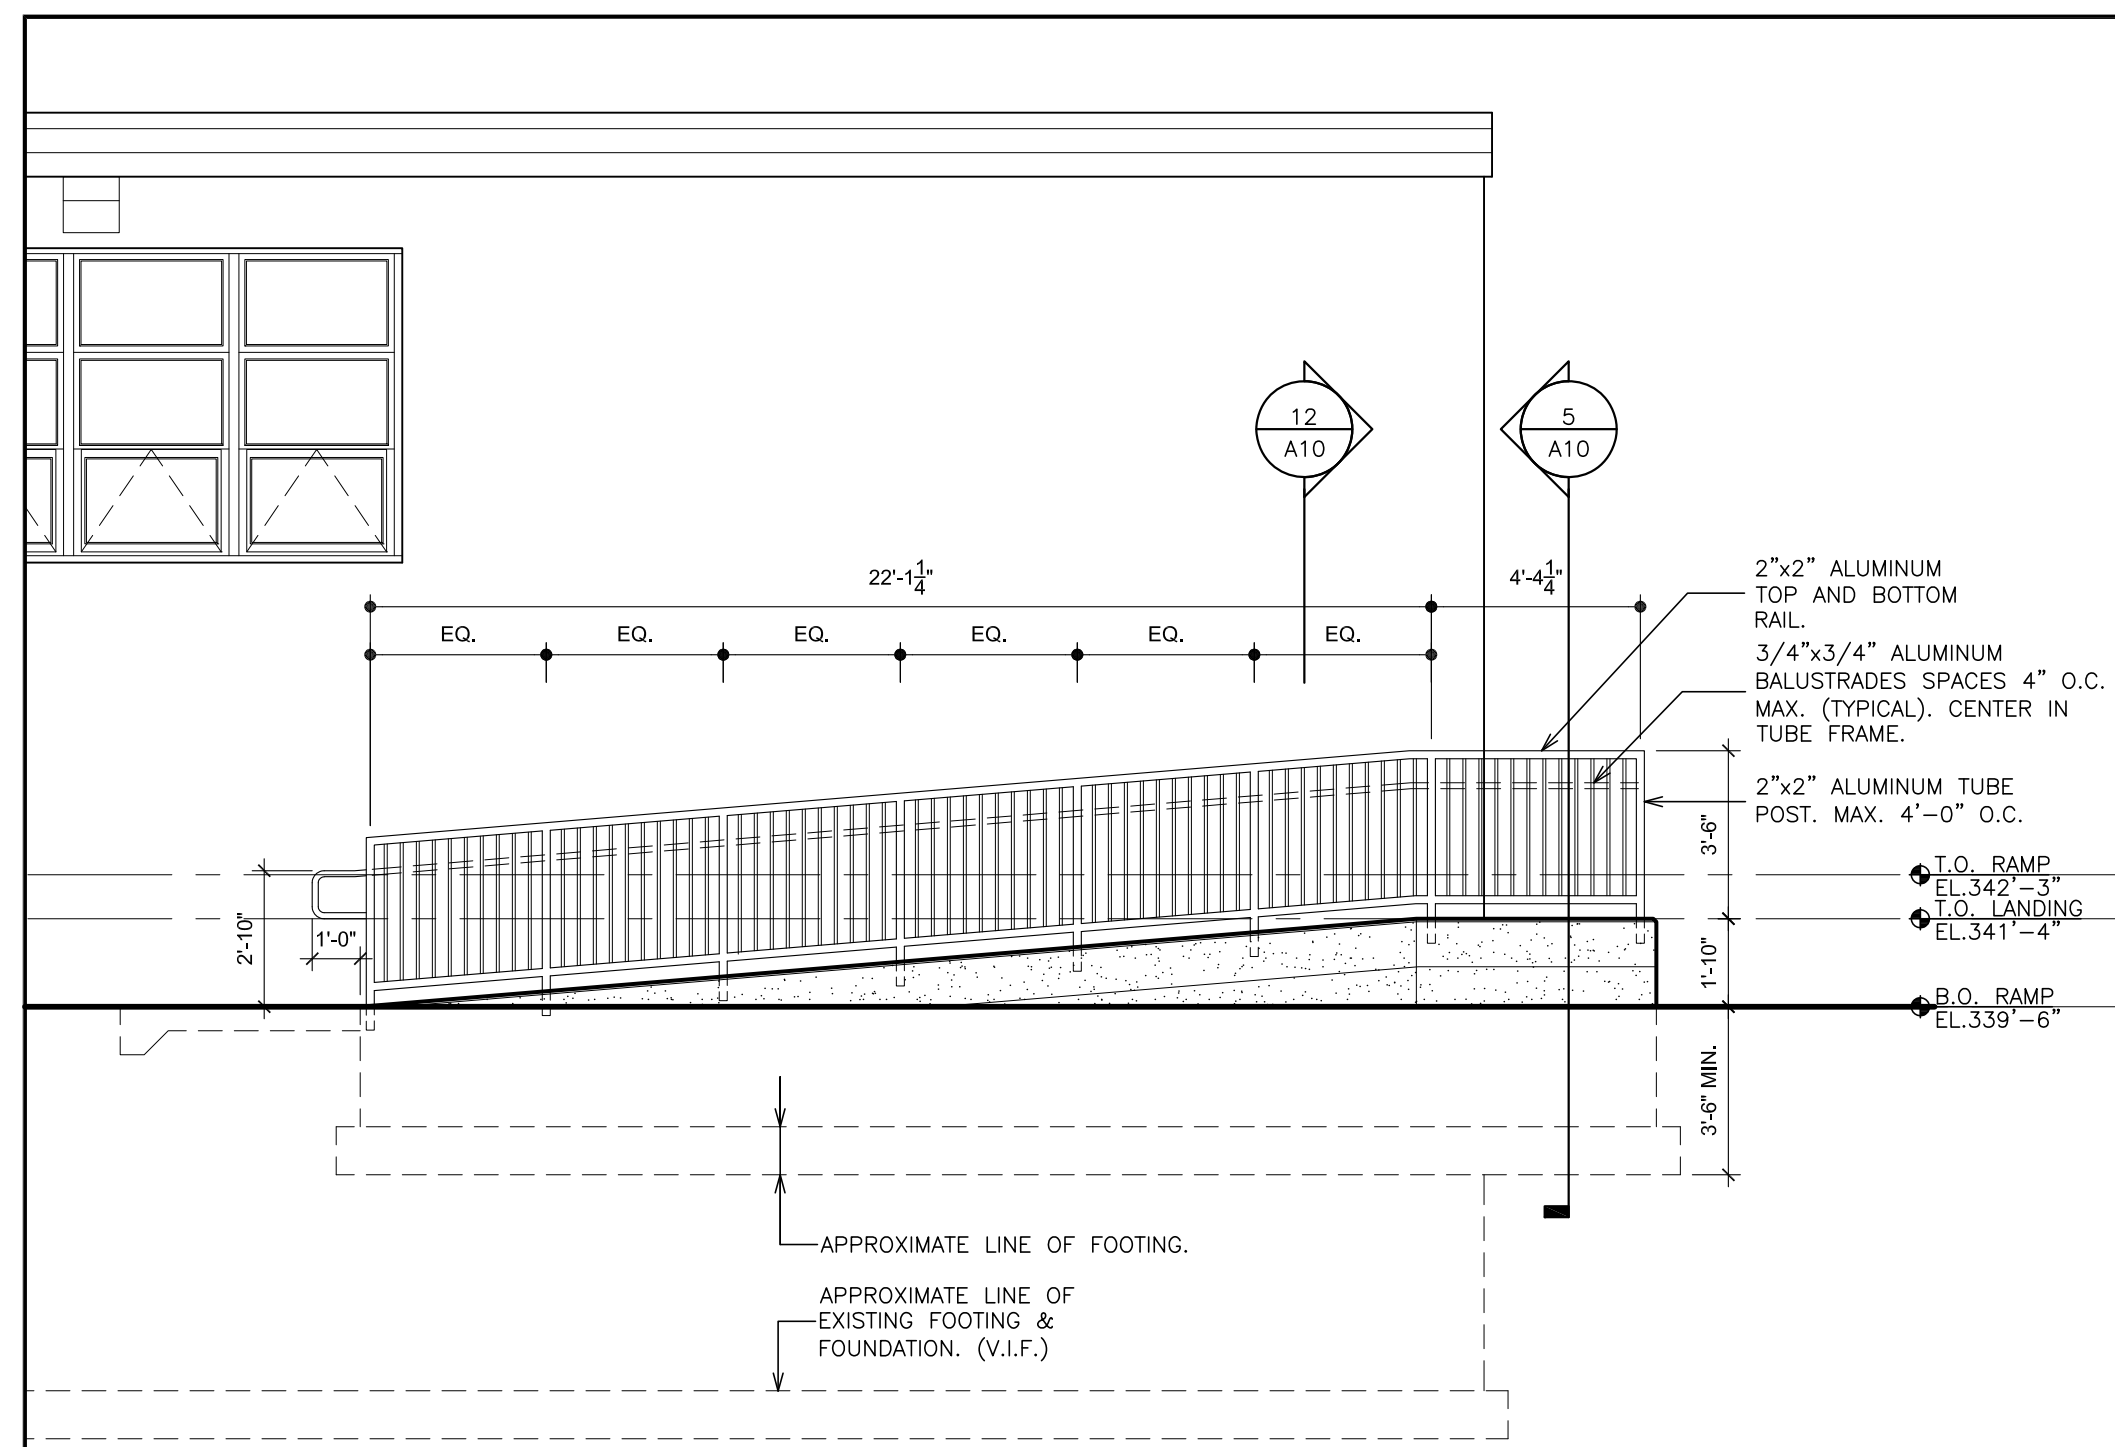

AS PER U.S. CONGRESS ARCHITECTURAL WORKS COPYRIGHT PROTECTION ACT OF 1990 ALL IDEAS AND DESIGNS INCLUDING DERIVATIVES THEREOF, ALL DRAWINGS AND SPECIFICATIONS CONSTITUTE THE ORIGINAL COPYRIGHT WORK BY FULLER AND D'ANGELO, P.C. (F&D). THE DRAWINGS AND SPECIFICATIONS AS INSTRUMENTS OF SERVICE BY F&D ARE CREATED BY F&D FOR THIS PROJECT ONLY AND REMAIN THE PRODUCT AND PROPERTY OF F&D. ANY REPRODUCTION WITHOUT THE PRIOR CONSENT OF F&D IS PROHIBITED.

448 KNOLLWOOD ROAD ELMSFORD NEW YORK 10823
TEL 914.895.4644 FAX 914.892.1717
WWW.FULLERDANIELLO.COM
Copyright 2005, All Rights Reserved by FULLER & DANIELLO P.C.

FULLER
D'ANGELO
P.C.
ARCHITECTS
PLANNERS

LICENSE EXP. DATE: 02-28-2027


S.E.D. CONTROL NUMBER:
GREENVILLE ELEMENTARY SCHOOL
66-04-06-03-0-008-021

PROJECT TITLE	EDGEMONT SCHOOL DISTRICT GREENVILLE ELEMENTARY SCHOOL CAFETERIA RENOVATION
DRAWING TITLE	TRAMP ELEVATION, SECTION AND DETAIL


01-31-2025	BID
01-10-2022	SED SUBMISSION
DATE	ISSUED TO

SHEET SIZE 30"x42"	DRAWING NO. A10
-----------------------	--------------------

SCALE AS NOTED	A10
DRAWN BY	FILE NO.

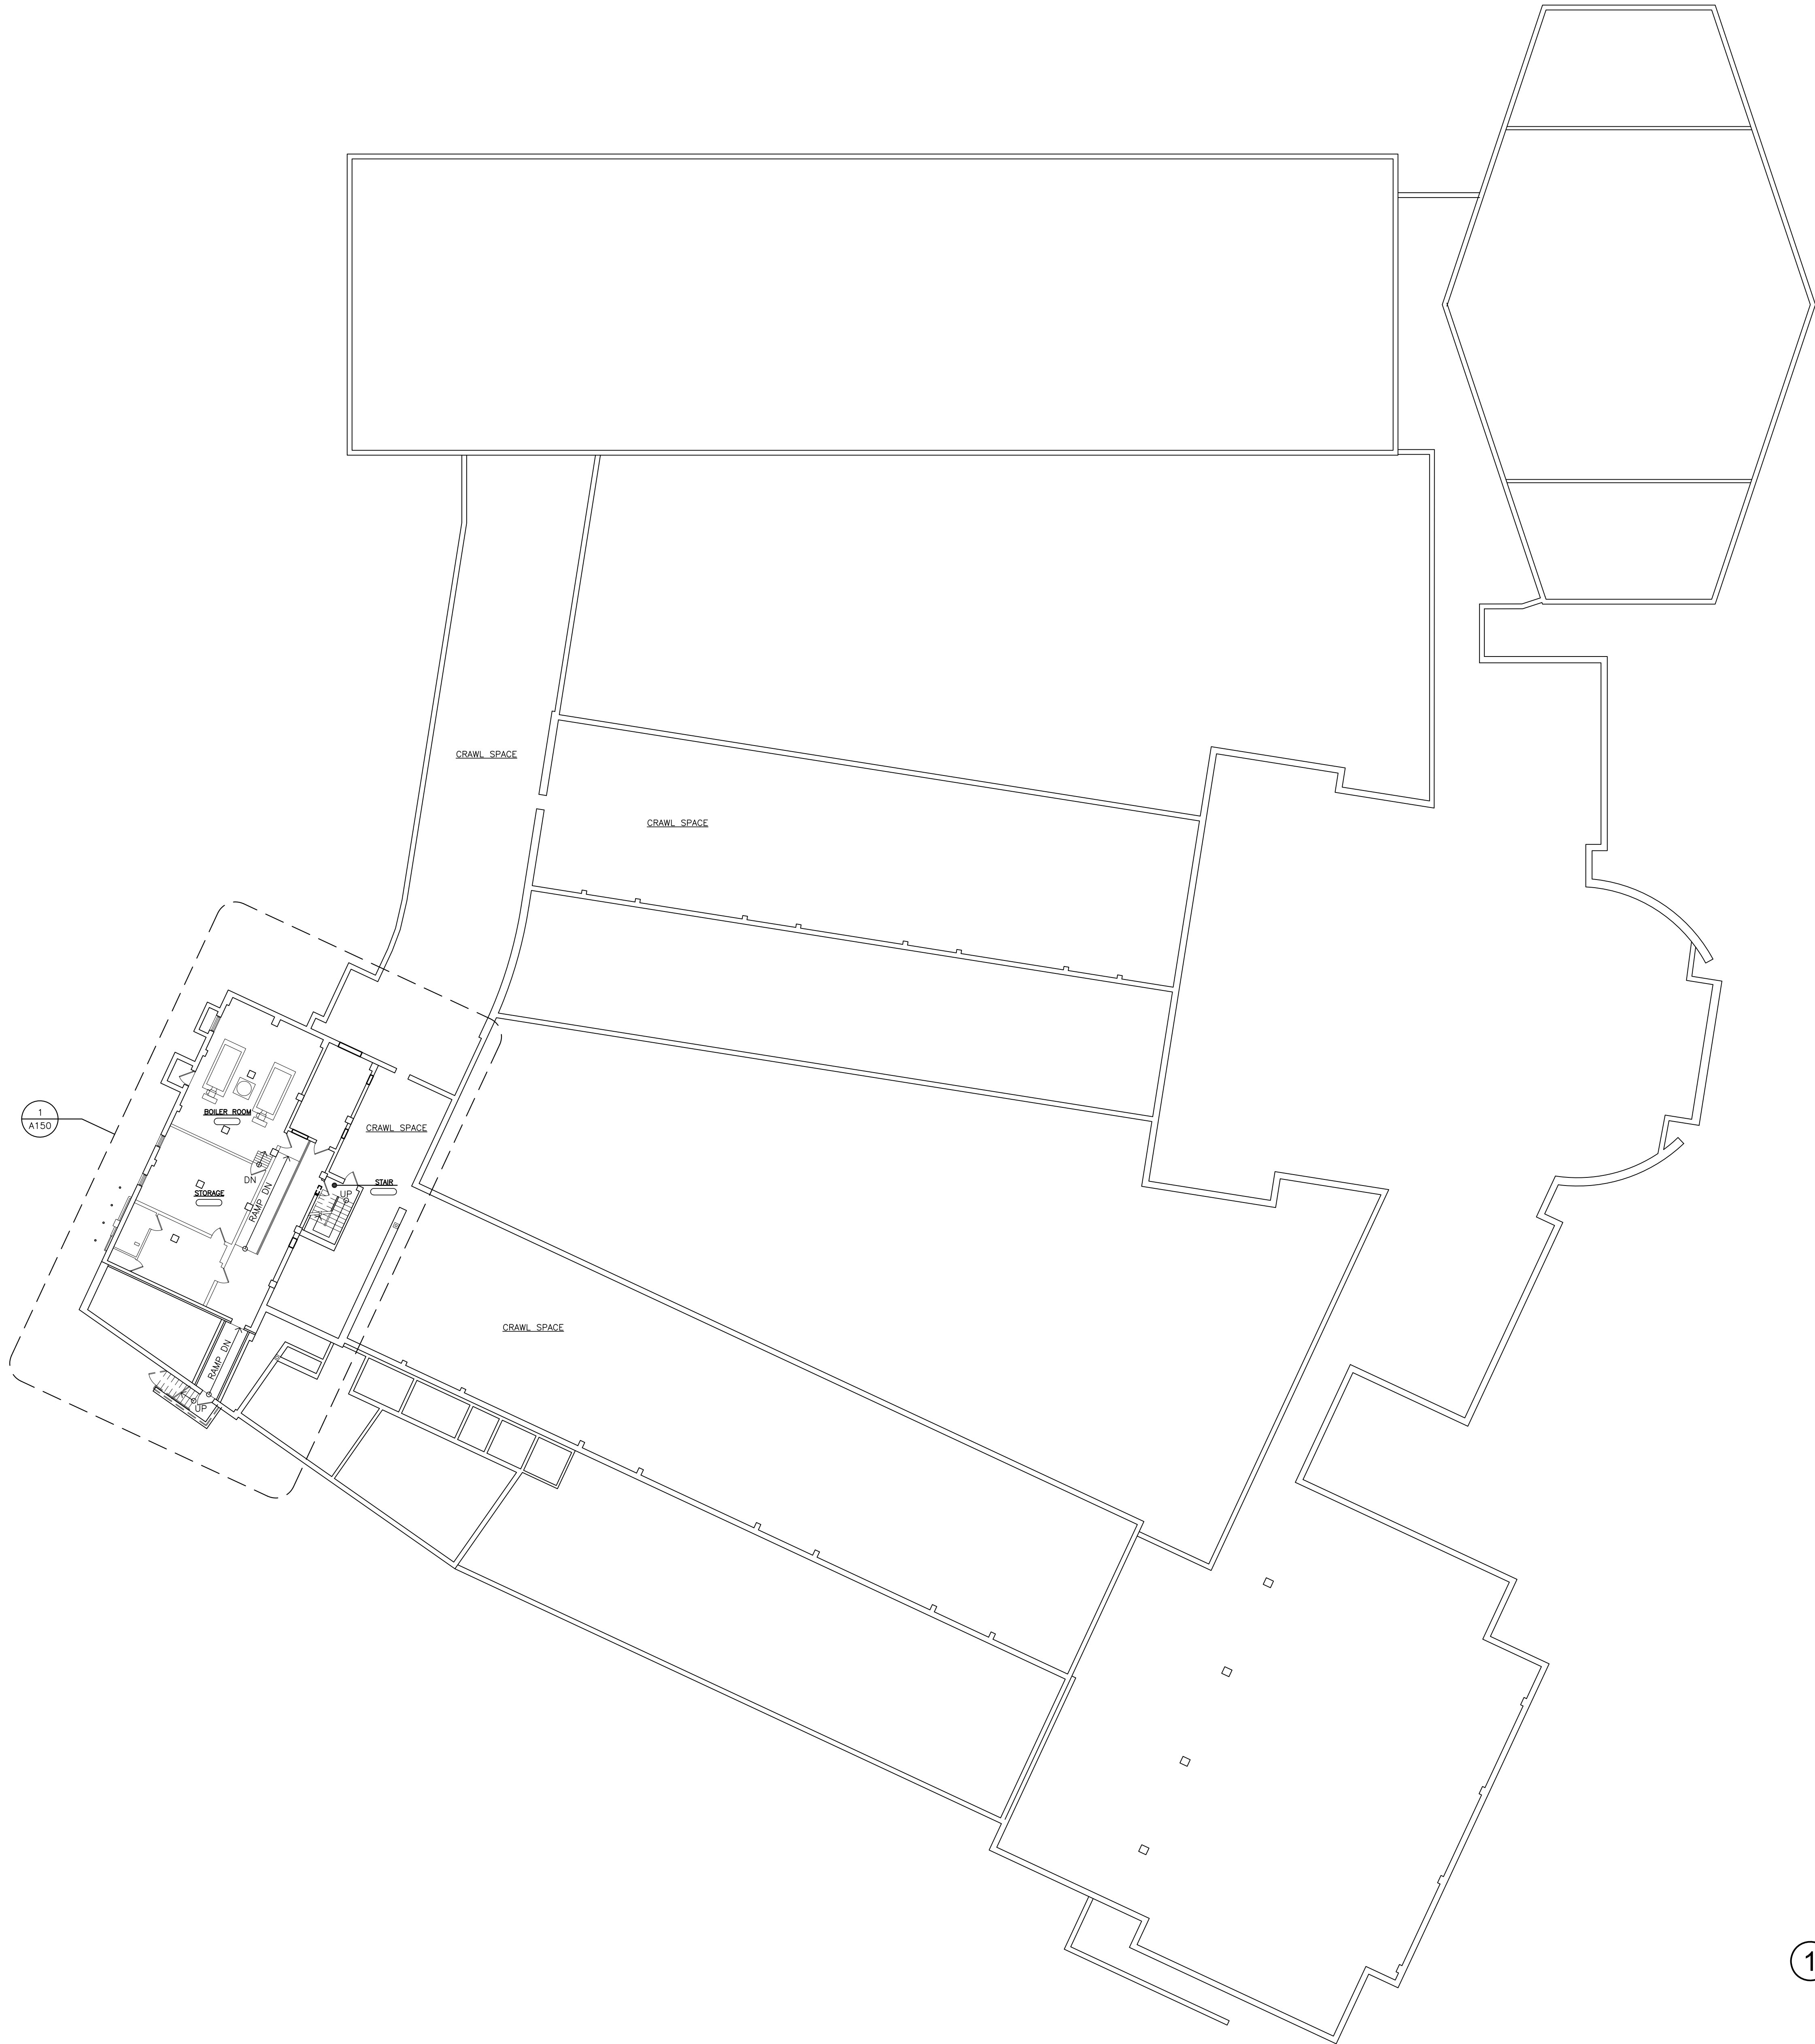

 1 OVERALL BASEMENT PLAN
SCALE: 1/16" = 1'-0"



PLOT DATE: January 22, 2025 — 7:19am

FILE: I:\24529.01 Greenville Cafeteria Renovation\DRAWINGS\CURRENT\1-F&D\A100 150.dwg

PROJECT TITLE
EDGEMONT SCHOOL DISTRICT
GREENVILLE ELEMENTARY SCHOOL
CAFETERIA RENOVATION

DRAWING TITLE
OVERALL BASEMENT PLAN

01-31-2025
01-19-2022
DATE

SHEET SIZE
30"x42"

SCALE
AS NOTED

DRAWN BY
F & D

BID
SED SUBMISSION
ISSUED TO

DRAWING NO.

A100

FILE NO.
24529.01

LICENSE EXP. DATE: 02-28-2027

S.E.D. CONTROL NUMBER:
GREENVILLE ELEMENTARY SCHOOL
66-04-06-03-0-008-021

**FULLER
D'ANGELO
P.C.**

**ARCHITECTS
PLANNERS**

428 KILLWOOD ROAD ELLENFIELD NEW YORK 10883
TEL 914.888.4444 FAX 914.888.1917
WWW.FULLERDANGELO.COM
Copyright 2022 All Rights Reserved by FULLER & D'ANGELO P.C.

AS PER USA CONGRESS ARCHITECTURAL WORKS COPYRIGHT
PROTECTION ACT OF 1990 ALL IDEAS AND DESIGNS INCLUDING
DERIVATIVES THEREOF, ALL DRAWINGS AND SPECIFICATIONS
CONSTITUTE THE ORIGINAL COPYRIGHT WORK BY FULLER AND
D'ANGELO, P.C. (F&D). THE DRAWINGS AND SPECIFICATIONS AS
INSTRUMENTS OF SERVICE BY F&D ARE CREATED BY F&D FOR
THIS PROJECT ONLY AND REMAIN THE PROPERTY AND PROPERTY
OF F&D. ANY REPRODUCTION WITHOUT THE PRIOR CONSENT OF
F&D IS PROHIBITED.



48 KNOLLWOOD ROAD ELMSFORD NEW YORK 10523
TEL 914.892.4444 FAX 914.892.1717
WWW.FULLERANGELO.COM
Copyright 2015 All Rights Reserved by FULLER & FANGELO P.C.


FULLER
D'ANGELO
P.C.

ARCHITECTS
PLANNERS

S.E.D. CONTROL NUMBER:
GREENVILLE ELEMENTARY SCHOOL
66-04-06-03-0-008-021

PROJECT TITLE EDGEMONT SCHOOL DISTRICT GREENVILLE ELEMENTARY SCHOOL CAFETERIA RENOVATION	DRAWING TITLE OVERALL FIRST FLOOR PLAN
---	---

FILE: I:\24529.01 Greenville Cafeteria Renovation\DRAWINGS\CURRENT\1-F&D\A101 151 AR151.dwg

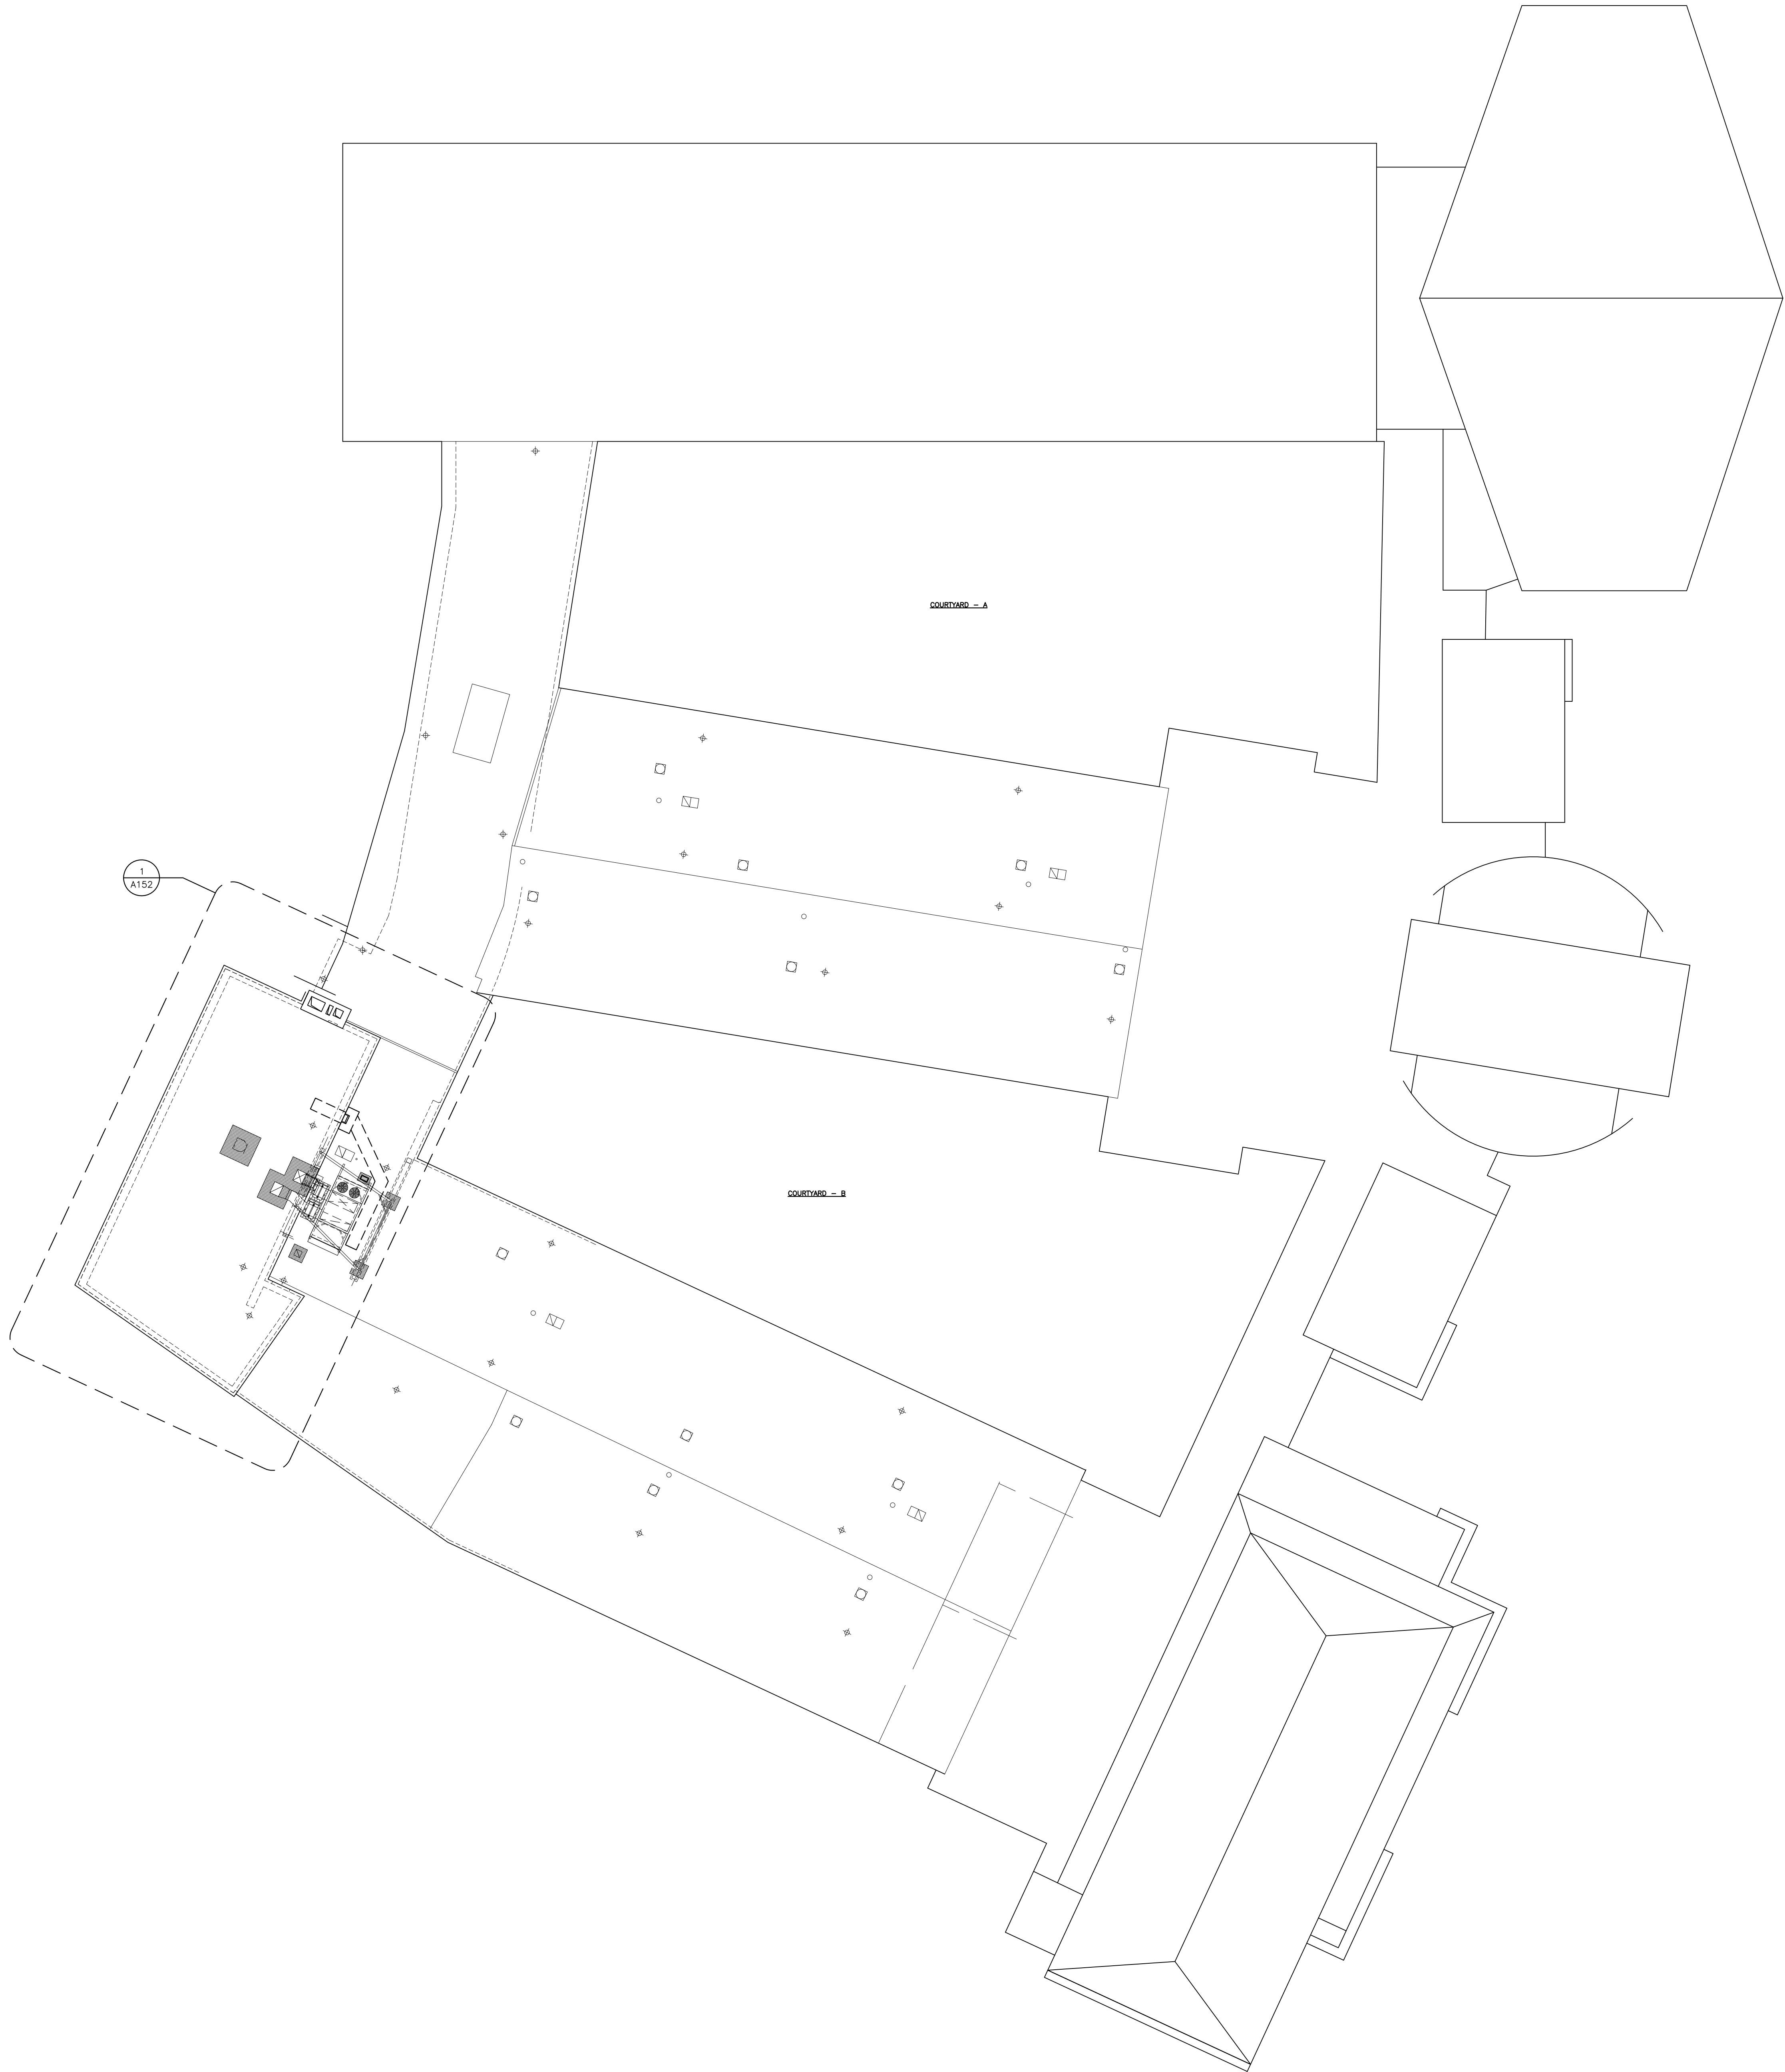

1 OVERALL ROOF PLAN
SCALE: 1/16" = 1'-0"



PROJECT TITLE
EDGEWORTH SCHOOL DISTRICT
GREENVILLE ELEMENTARY SCHOOL
CAFETERIA RENOVATION

DRAWING TITLE
OVERALL ROOF PLAN

SHEET SIZE
30"x42"

SCALE
AS NOTED

DRAWN BY
F & D

DATE
01-19-2022

SED SUBMISSION
ISSUED TO

DRAWING NO.
A102

FILE NO.
24529.01

S.E.D. CONTROL NUMBER:
GREENVILLE ELEMENTARY SCHOOL
66-04-06-03-0-008-021


LICENSE EXP. DATE: 02-28-2027

FULLER
DIANGELO
P.C.


ARCHITECTS
PLANNERS

428 KILLWOOD ROAD ELLENBORO NEW YORK 10823
TEL 914.898.4444 FAX 914.898.1917
Copyright 2022 All Rights Reserved By FULLER & DIANGELO P.C.

AS PER USA CONGRESS ARCHITECTURAL WORKS COPYRIGHT
PROTECTION ACT OF 1990 ALL IDEAS AND DESIGNS INCLUDING
DERIVATIVES THEREOF, ALL DRAWINGS AND SPECIFICATIONS
CONSTITUTE THE ORIGINAL COPYRIGHT WORK BY FULLER AND
DIANGELO, P.C. (F&D). THE DRAWINGS AND SPECIFICATIONS AS
INSTRUMENTS OF SERVICE BY F&D ARE CREATED BY F&D FOR
THIS PROJECT ONLY AND REMAIN THE PROPERTY AND PROPERTY
OF F&D. ANY REPRODUCTION WITHOUT THE PRIOR CONSENT OF
F&D IS PROHIBITED.

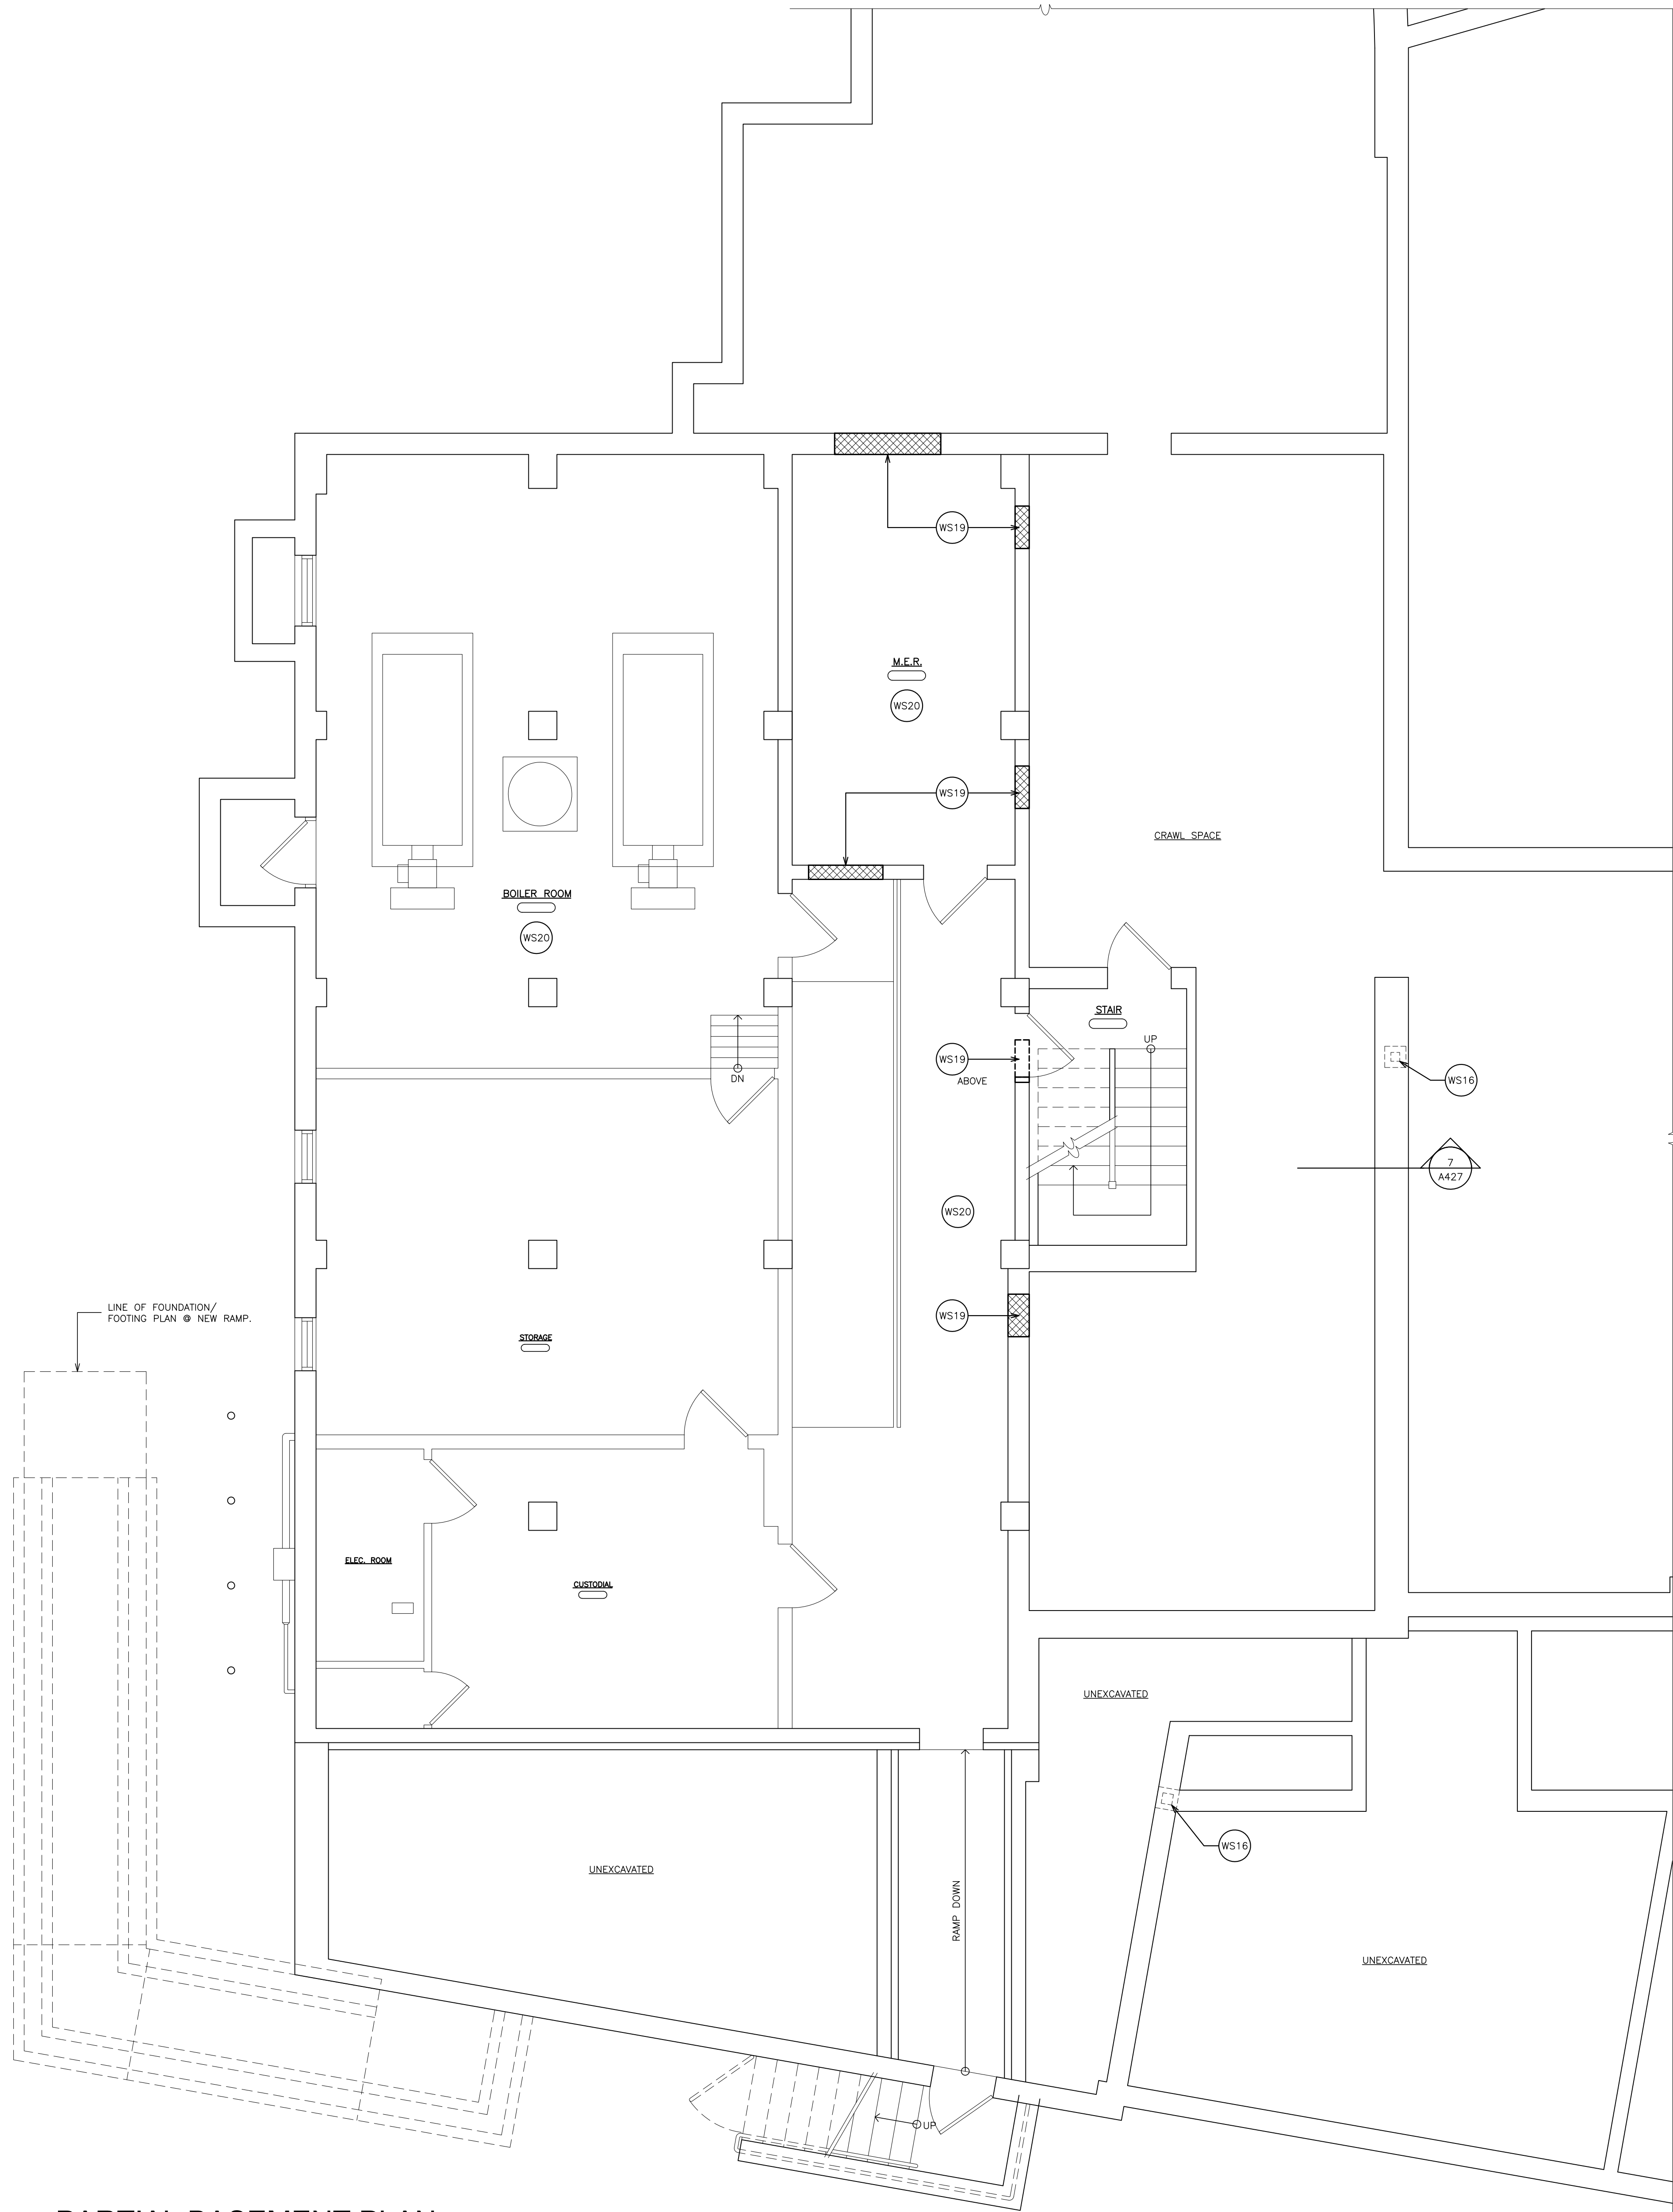

 1 PARTIAL BASEMENT PLAN
SCALE: 1/4" = 1'-0"



WORKSCOPE NOTES:

- WS1 INFILL OPENING WITH SALVAGED GLAZED BLOCK FROM REMOVALS. TOOTH INTO ADJACENT WALLS. MATCH EXISTING BOND PATTERN AND GROUT.
- WS2 EXISTING GAS SERVICE. PROVIDE PROTECTION AND ACCESS DURING CONSTRUCTION OPERATIONS.
- WS3 REFER TO FOOD SERVICE DRAWINGS FOR EQUIPMENT IN THIS AREA.
- WS4 PREP AND PAINT EXISTING DOOR AND FRAME.
- WS5 REFER TO DRAWING A900 FOR SIGNAGE INFORMATION.
- WS6 NEW STEEL COLUMN FOR ROOF DUNNAGE. SEE DRAWINGS S2 FOR ADDITIONAL INFORMATION.
- WS7 PROVIDE A MINIMUM OF 2" OF SELF-LEVELING UNDERLAYMENT OVER ENTIRE FLOOR SLAB EXPOSED BY THE REMOVAL OF THE PLATFORM.
- WS8 RESTORE ALL DISTURBED GRASS AREA. SEE DETAIL 9/A10.
- WS9 PROVIDE NEW BRICK & BLOCK TOOTHED INTO EXISTING BRICK TO MATCH EXISTING COLOR, TEXTURE & PATTERN. PROVIDE S.S. BRICK & BLOCK TIES, DAMPROOFING & RIGID INSULATION. EXISTING STEEL LINTEL TO REMAIN (SCRAPE, WIRE BRUSH PRIME & PAINT).
- WS10 CONSTRUCT NEW PARTITION TO MATCH EXISTING. REINFORCE WITH BLOCKING TO ANCHOR NEW HANDRAIL EXTENSION.
- WS11 CONCRETE SLAB PATCHING BY M/E/P. COORDINATE FINISH WORK.
- WS12 PATCH FLOOR OPENING IN CONCRETE FLOOR SLAB AFTER MECHANICAL CONTRACTOR REMOVES AIR GRILLE AND BLANKS OFF THE DUCK OPENING. SEE DETAIL 9/A500.
- WS13 REMOVE AND REMOUNT EXISTING F.E. TO BE FLUSH WITH NEW WALL FINISH.
- WS14 NEW 1 1/2" NOM.# CONTINUOUS ALUMINUM HANDRAILS EACH SIDE OF WALL.
- WS15 WELD NEW HANDRAILS (DOUBLE HEIGHT) TO EXISTING. EXTEND BEYOND NEW TREAD DISTANCE EQUAL TO TREAD WIDTH.
- WS16 NEW STEEL COLUMN ABOVE. SEE DRAWING S1 FOR ADDITIONAL INFORMATION.
- WS17 PROVIDE LOUVER. SEE DETAIL 3/A650.
- WS18 FILL IN FLOOR WITH METAL DECKING AND CONCRETE. SEE SIMILAR DETAIL 9/A500. PATCH AND PAINT WALLS TO MATCH EXISTING.
- WS19 INFILL OPENING RESULTING FROM DUCT REMOVALS WITH CONCRETE BLOCK TO MATCH WIDTH OF EXISTING. COORDINATE WITH MECHANICAL CONTRACTOR.
- WS20 REFER TO ABATEMENT DOCUMENTS FOR ADDITIONAL INFORMATION.

AS PER USA CONGRESS ARCHITECTURAL WORKS COPYRIGHT PROTECTION ACT OF 1990 ALL IDEAS AND DESIGNS INCLUDING DERIVATIVES THEREOF, ALL DRAWINGS AND SPECIFICATIONS CONSTITUTE THE ORIGINAL COPYRIGHT WORK BY FULLER AND DANKELO, P.C. (F&D). THE DRAWINGS AND SPECIFICATIONS AS INSTRUMENTS OF SERVICE BY F&D ARE CREATED BY F&D FOR THIS PROJECT ONLY AND REMAIN THE PRODUCT AND PROPERTY OF F&D. ANY REPRODUCTION WITHOUT THE PRIOR CONSENT OF F&D IS PROHIBITED.

48 KILLWOOD ROAD ELLENHURST NEW YORK 11533
TEL 914.888.4444 FAX 914.888.1717
Copyright 2022 All Rights Reserved by FULLER & DANKELO, P.C.

FULLER
DANKELO
P.C.
ARCHITECTS
PLANNERS


LICENSE EXP. DATE: 02-28-2027

S.E.D. CONTROL NUMBER:
GREENVILLE ELEMENTARY SCHOOL
66-04-06-03-0-008-021


PROJECT TITLE
EDGEMONT SCHOOL DISTRICT
GREENVILLE ELEMENTARY SCHOOL
CAFETERIA RENOVATION

DRAWING TITLE
PARTIAL BASEMENT PLAN

01-31-2025	BID
01-19-2022	SED SUBMISSION
DATE	ISSUED TO
SHEET SIZE 30"x42"	DRAWING NO. A150
SCALE AS NOTED	FILE NO. 24529.01
DRAWN BY F & D	

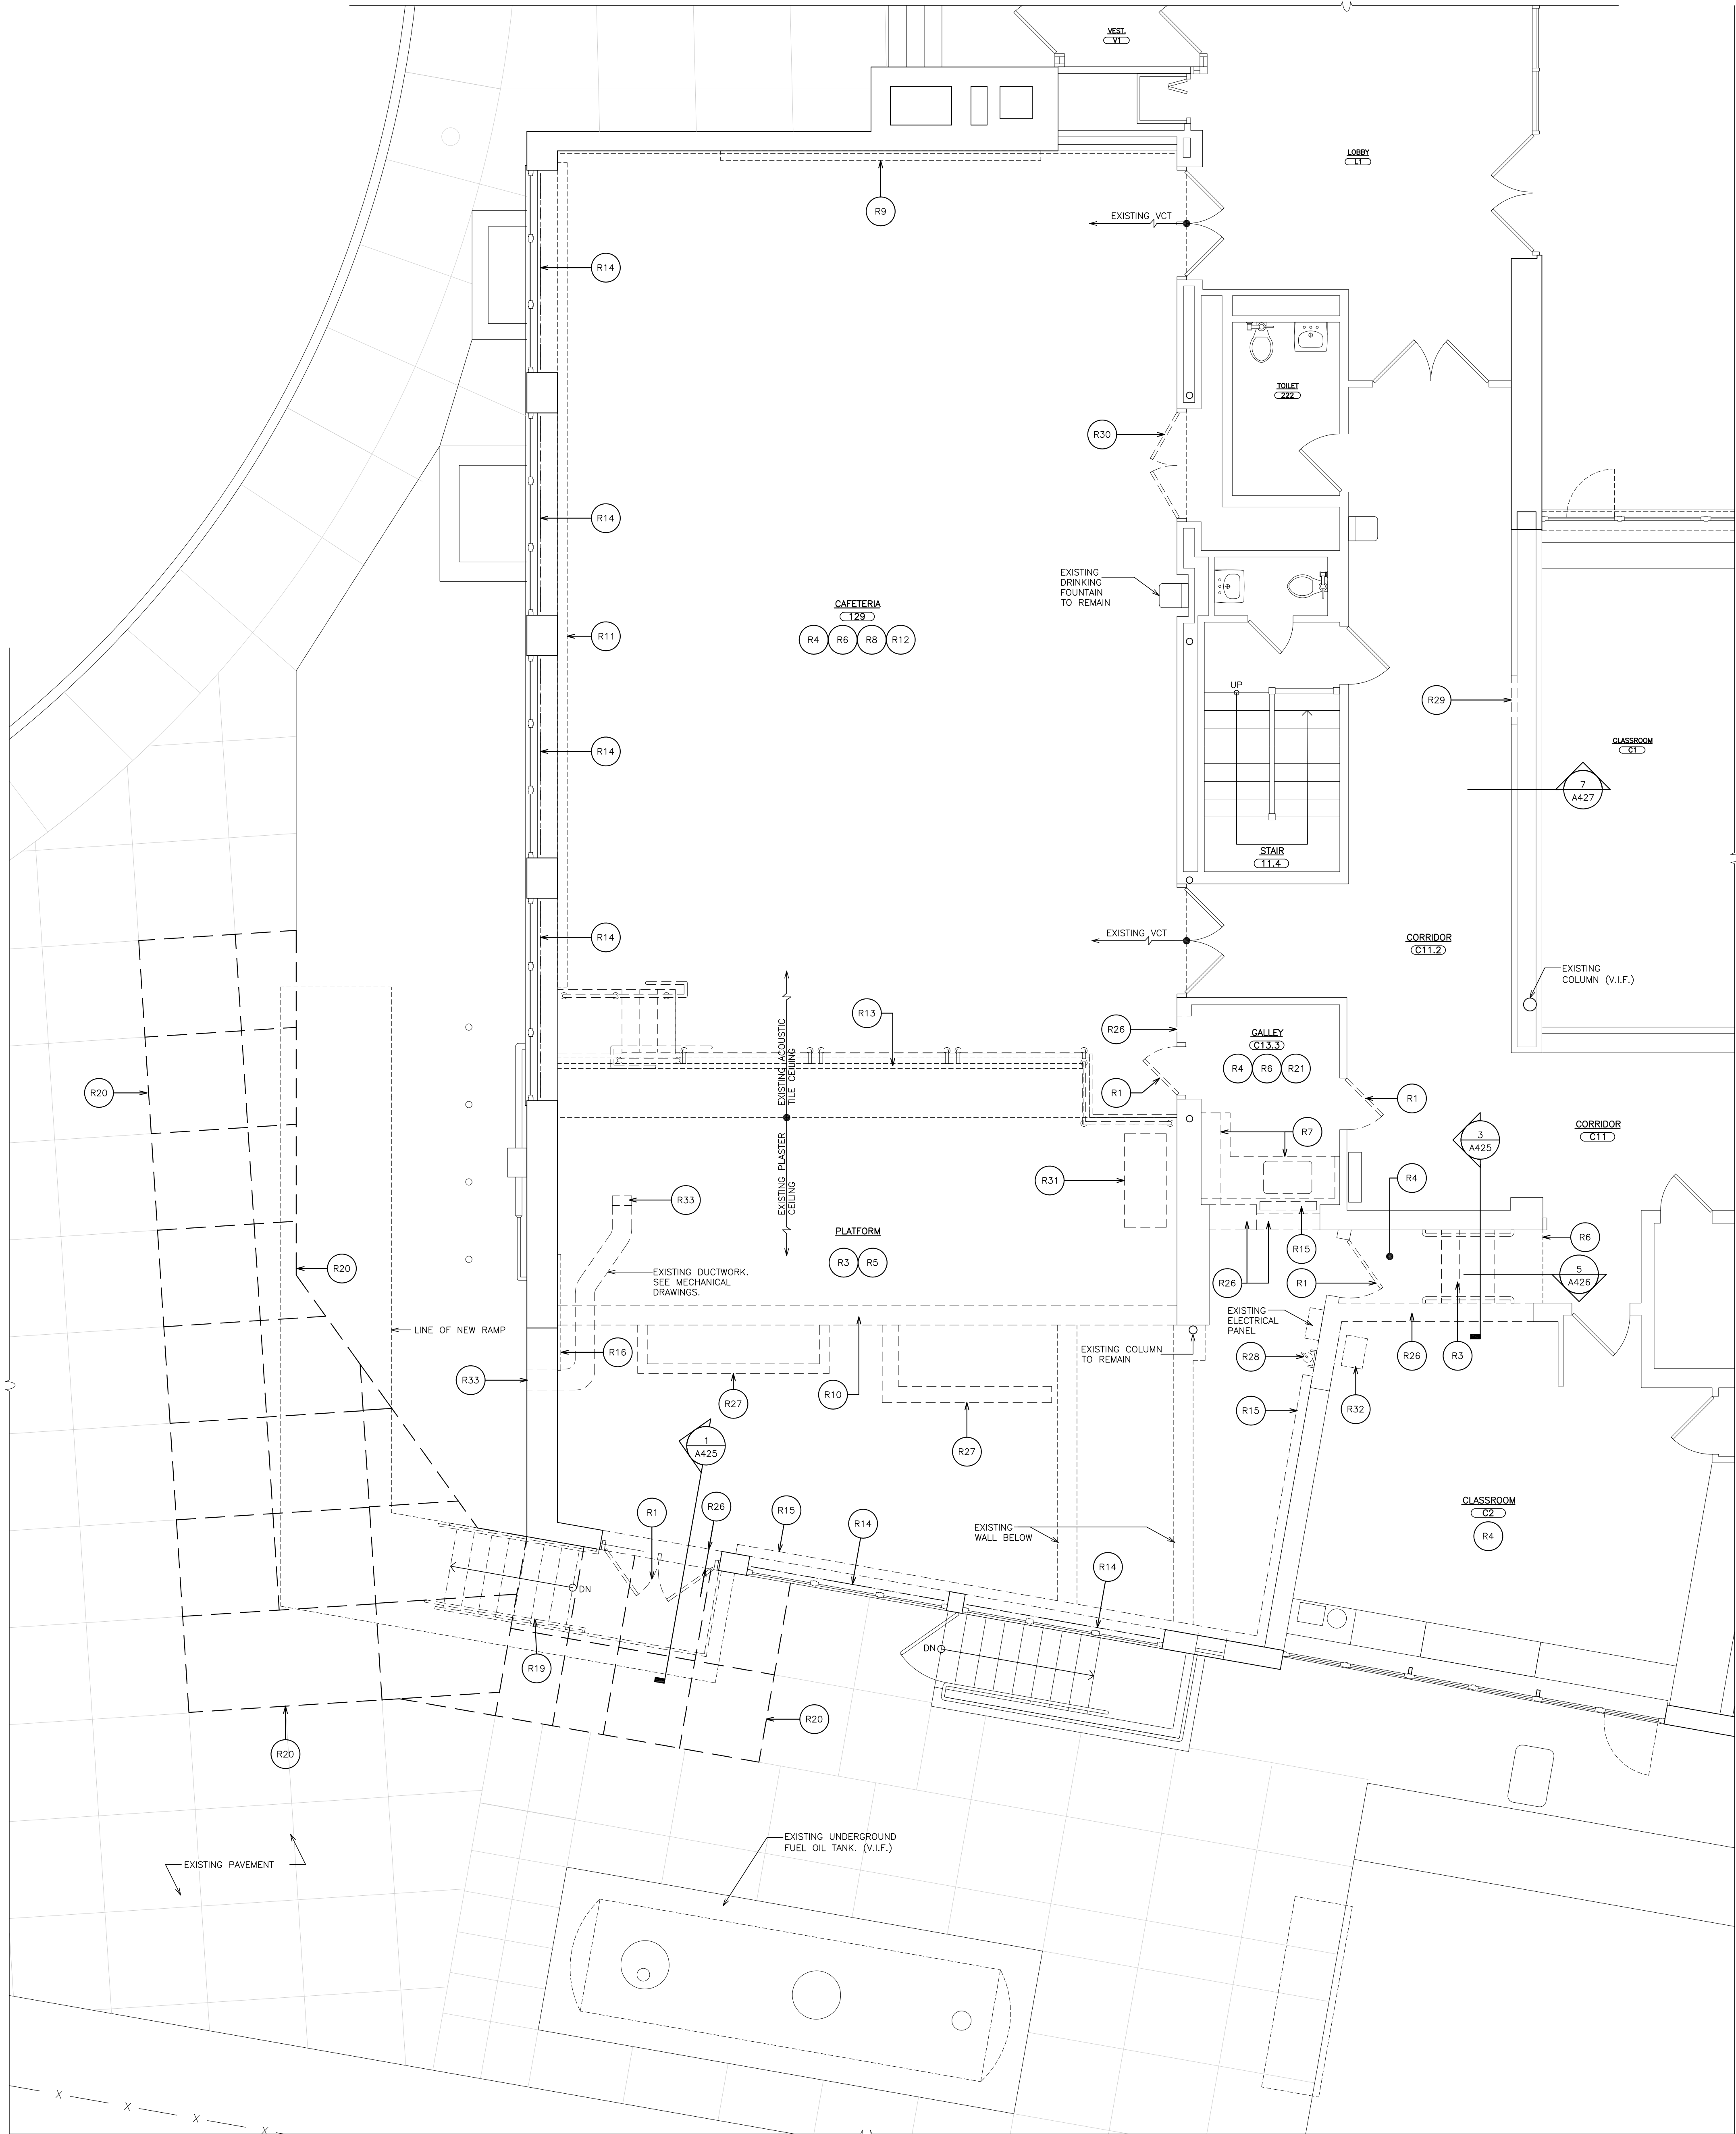

 1 PARTIAL FIRST FLOOR REMOVAL PLAN
SCALE: 1/4" = 1'-0"



- REMOVAL NOTES:**
- (R1) REMOVE EXISTING DOORS, METAL FRAMES, TRANSOMS, HARDWARE, SADDLES, SIDE-LITES AND ALL RELATED ITEMS. PATCH ALL DISTURBED SURFACES TO MATCH EXISTING ADJACENT SURFACES.
 - (R2) REMOVE EXISTING SUSPENDED CEILING ASSEMBLY (2x4 OR 2x2), SUSPENSION SYSTEM, PANELS, WALL ANGLES, SEISMIC TIES AND ALL RELATED ITEMS. COORDINATE WORK WITH E-CONTRACTOR. PATCH ALL DISTURBED SURFACES TO MATCH EXISTING ADJACENT SURFACES.
 - (R3) REMOVE EXISTING WOOD FRAMED PLATFORM, RAILING AND STAIR IN IT'S ENTIRETY AND RELATED ITEMS. PATCH ALL DISTURBED SURFACES TO MATCH EXISTING ADJACENT SURFACES.
 - (R4) REMOVE EXISTING SUSPENDED CEILING ASSEMBLY, SUSPENSION SYSTEM, PANELS, WALL ANGLES, SEISMIC TIES AND ALL RELATED ITEMS. COORDINATE WORK WITH E-CONTRACTOR. PATCH ALL DISTURBED SURFACES TO MATCH EXISTING ADJACENT SURFACES.
 - (R5) REMOVE EXISTING PLASTER CEILING ASSEMBLY INCLUDING HANGERS, BLACK IRON, PANELS AND ASSOCIATED ITEMS. COORDINATE WORK WITH E-CONTRACTOR. PATCH ALL DISTURBED SURFACES TO MATCH EXISTING ADJACENT SURFACES.
 - (R6) REMOVE EXISTING VCT FLOOR TILE, (MULTIPLE LAYER MAY EXIST) WALL BASE, TRANSITION STRIPS, MASTIC AND SUBSTRATE DOWN TO EXISTING SLAB. MECHANICALLY PROFILE 100% OF EXISTING SUB-FLOOR FOR NEW FLOOR FINISHES.
 - (R7) REMOVE EXISTING CASEWORK, BRACKETS, BASE, FLOOR TRACKS AND ALL RELATED ITEMS. PATCH ALL DISTURBED SURFACES TO MATCH EXISTING ADJACENT SURFACES. COORDINATE WORK WITH PLUMBING AND ELECTRICAL CONTRACTORS.
 - (R8) REMOVE EXISTING WALL MOUNTED ACOUSTIC PANELS AND FRAME AND ALL RELATED ITEMS. PATCH ALL DISTURBED SURFACES TO MATCH EXISTING ADJACENT SURFACES.
 - (R9) REMOVE EXISTING WALL MURAL AND ALL RELATED ITEMS. PATCH ALL DISTURBED SURFACES TO MATCH EXISTING ADJACENT SURFACES. REINSTALL MURAL OVER NEW WALL FURRING.
 - (R10) REMOVE EXISTING FOUNDATION WALL DOWN TO A MINIMUM OF 6" BELOW THE CAFETERIA FINISHED FLOOR. PATCH WITH CONCRETE.
 - (R11) REMOVE EXISTING WALL PADDING AND ALL RELATED ITEMS. PATCH ALL DISTURBED SURFACES TO MATCH EXISTING ADJACENT SURFACES.
 - (R12) REMOVE EXISTING WALL MOUNTED PADDING SUPPORT TRACK AND ALL RELATED ITEMS. PATCH ALL DISTURBED SURFACES TO MATCH EXISTING ADJACENT SURFACES.
 - (R13) REMOVE EXISTING MASONRY KNEE WALL AT EDGE OF EXISTING PLATFORM. COORDINATE WITH ELECTRICAL CONTRACTOR. PATCH DISTURBED SURFACES TO MATCH EXISTING ADJACENT SURFACES. GRIND DOWN ANY HIGH SPOTS UNDER EXISTING WALL. FLASH PATCH SMOOTH TO ADJACENT SURFACES.
 - (R14) REMOVE AND RE-INSTALL EXISTING WINDOW SHADES. SAFELY STORE AND REMOUNT.
 - (R15) MECHANICAL CONTRACTOR TO REMOVE EXISTING FIN-TUBE. COORDINATE WORK.
 - (R16) REMOVE MARKER BOARD AND RELATED ITEMS. TURN OVER TO OWNER.
 - (R17) REMOVE EXISTING CEILING & EXISTING PLASTER CEILING ASSEMBLY INCLUDING HANGERS, BLACK IRON, PANELS AND ASSOCIATED ITEMS.
 - (R18) REMOVAL OF EXISTING LIGHT FIXTURE BY ELECTRICAL CONTRACTOR.
 - (R19) REMOVE EXISTING METAL STAIR STRUCTURE AND RELATED ITEMS. PATCH DISTURBED SURFACES TO MATCH EXISTING ADJACENT SURFACES.
 - (R20) SAW-CUT ALONG EXISTING SCORED JOINTS AND REMOVE PORTION OF EXISTING CONCRETE WALK, BASE & SUB-BASE TO INSTALL NEW RAMP.
 - (R21) SALVAGE EXISTING REMOVED GLAZED BLOCK FOR RE-USE.
 - (R22) REMOVAL OF EXISTING CEILING MOUNTED DEVICES. BY ELECTRICAL CONTRACTOR
 - (R23) REMOVAL OF EXISTING AIR GRILLES BY MECHANICAL CONTRACTOR.
 - (R24) APPROXIMATE LOCATION OF CEILING REMOVALS IN ORDER TO ACCESS AREA TO INSTALL NEW STEEL COLUMN.
 - (R25) REMOVE EXISTING SOFFIT.
 - (R26) SAW-CUT AND REMOVE PORTION OF WALL DOWN TO SLAB LEVEL. FOR INSTALLATION ON NEW WORK. PATCH DISTURBED SURFACES TO MATCH EXISTING ADJACENT SURFACES.
 - (R27) REMOVE EXISTING CONCRETE AREAWAY AND FOUNDATION. REMOVE ABANDONED DRAIN AND PIPING OUT OF NEW WORK AREA. CAP PIPING.
 - (R28) REMOVE FIRE EXTINGUISHER AND BRACKET AND TURN OVER TO OWNER.
 - (R29) REMOVE AND SALVAGE EXISTING GLAZED BLOCK TO INSTALL COLUMN. REINSTALL TO MATCH EXISTING.
 - (R30) REMOVE EXISTING DOOR AND HARDWARE.
 - (R31) EXISTING FOOD SERVICE EQUIPMENT. TURN OVER TO OWNER.
 - (R32) OWNER TO REMOVE EXISTING CHARGER STATION.
 - (R33) PATCH FLOOR/ WALL OPENING TO MATCH EXISTING DUE TO DUCT REMOVAL. COORDINATE WITH MECHANICAL CONTRACTOR.
- COORDINATE ALL REMOVALS WITH ASBESTOS AND LEAD ABATEMENT DRAWINGS AND SPECIFICATIONS.

AS PER USA CONGRESS ARCHITECTURAL WORKS COPYRIGHT PROTECTION ACT OF 1990 ALL IDEAS AND DESIGNS INCLUDING DERIVATIVES THEREOF, ALL DRAWINGS AND SPECIFICATIONS CONSTITUTE THE ORIGINAL COPYRIGHT WORK BY FULLER AND DANIELO, P.C. (F&D). THE DRAWINGS AND SPECIFICATIONS AS INSTRUMENTS OF SERVICE BY F&D ARE CREATED BY F&D FOR THIS PROJECT ONLY AND REMAIN THE PRODUCT AND PROPERTY OF F&D. ANY REPRODUCTION WITHOUT THE PRIOR CONSENT OF F&D IS PROHIBITED.

48 KNOXWOOD ROAD ELLENHURST NEW YORK 10883
TEL 914.888-4444 FAX 914.888-1917
Copyright 2022 All Rights Reserved by FULLER & DANIELO, P.C.

**FULLER
DANIELO
P.C.**
**ARCHITECTS
PLANNERS**

LICENSE EXP. DATE: 02-28-2027

S.E.D. CONTROL NUMBER:
GREENVILLE ELEMENTARY SCHOOL
66-04-06-03-0-008-021

PROJECT TITLE
EDGEMONT SCHOOL DISTRICT
GREENVILLE ELEMENTARY SCHOOL
CAFETERIA RENOVATION

DRAWING TITLE
PARTIAL FIRST FLOOR REMOVAL PLAN

01-31-2025	BID
01-19-2022	SED SUBMISSION
DATE	ISSUED TO

SHEET SIZE
30"x42"

SCALE
AS NOTED

DRAWN BY
F & D

DRAWING NO.
AR151

FILE NO.
24529.01





AWN BY EAD	FILE NO. 24520.01
---------------	----------------------

PLOT DATE: January 22, 2025 -- 7:20am

FILE: I:\24529.01 Greenville Cafeteria Renovation\DRAWINGS\CURRENT\1-F&D\A102 152.dwg

 1 PARTIAL ROOF PLAN
SCALE: 1/4" = 1'-0"

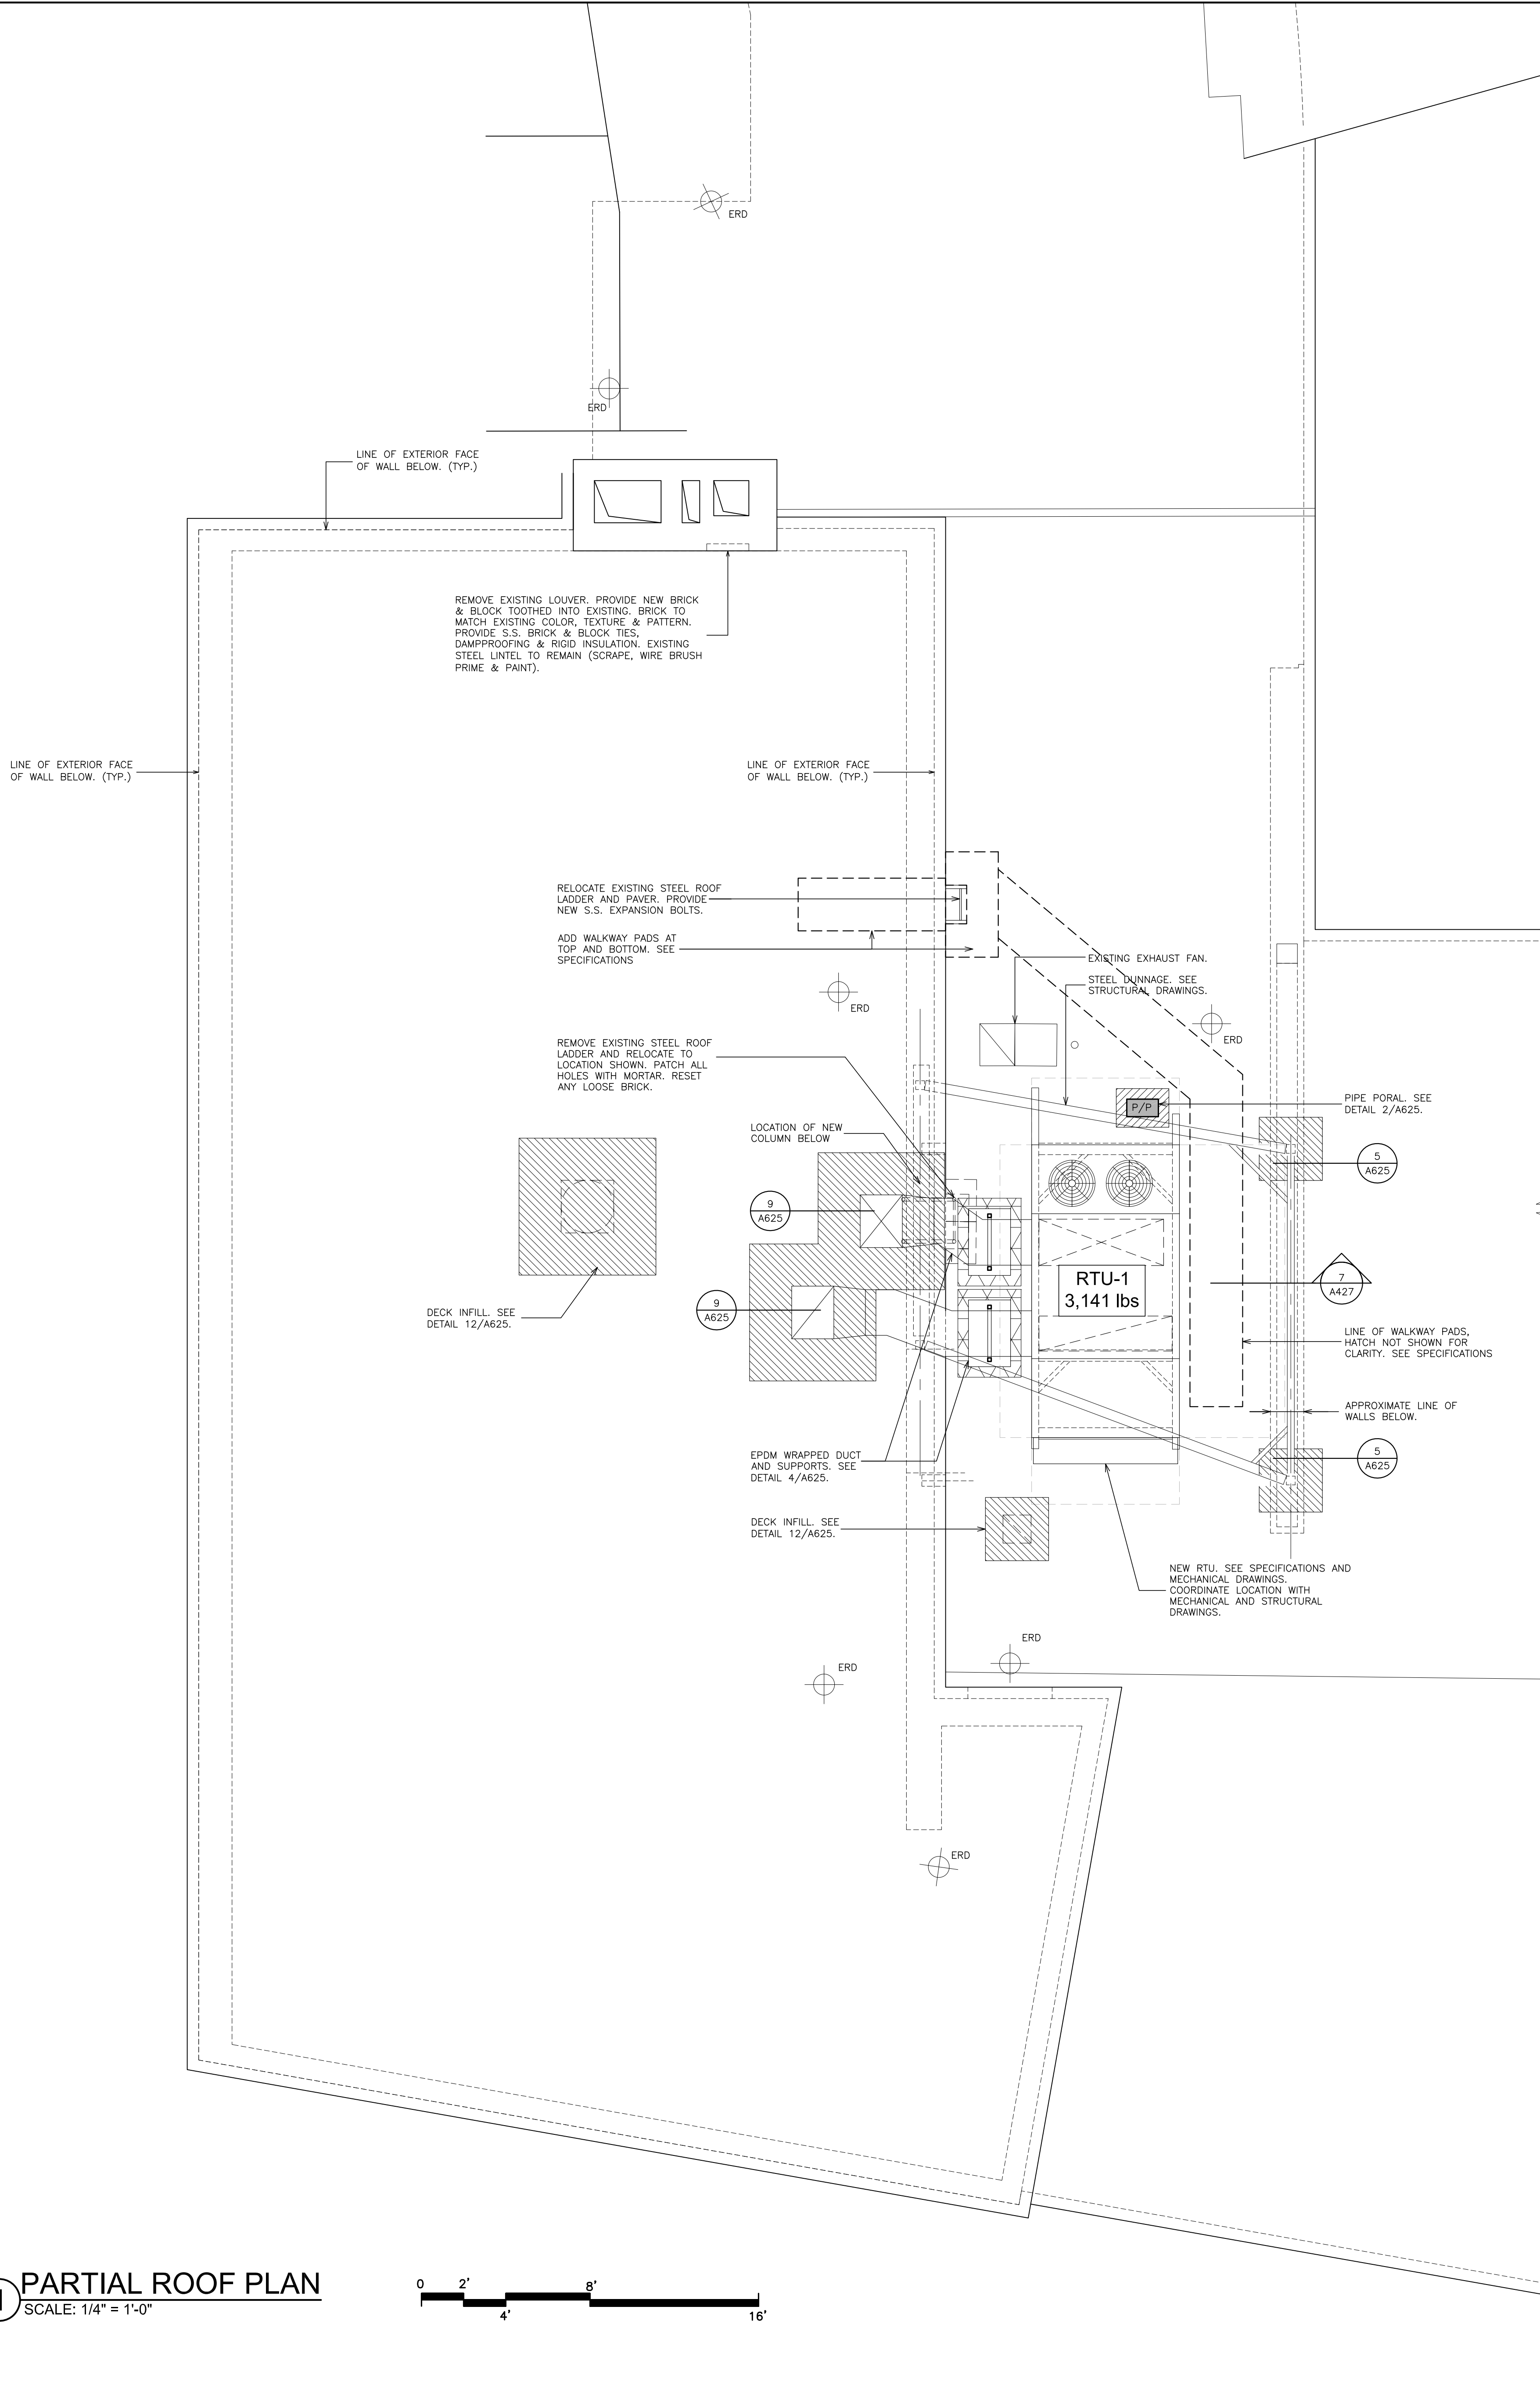


- NOTES:
1. CONTRACTOR TO COORDINATE PLATFORM DIMENSIONS WITH RTU & ERU MANUFACTURER'S CUTS.
 2. DUNNAGE STEEL TO BE GALVANIZED.
 3. SUBMIT SHOP DRAWINGS WITH FIELD MEASURED DIMENSIONS.
 4. SECURE EQUIPMENT TO DUNNAGE WITH MECHANICAL FASTENERS.
 5. PROVIDE NEOPRENE PADS UNDER EQUIPMENT TO REDUCE VIBRATION.
 6. COORDINATE FINAL LOCATION OF CU UNIT & DUNNAGE WITH EXISTING STRUCTURE, EXISTING ROOF DRAINS AND EXISTING ROOF EQUIPMENT.
 7. ALL EXPOSED FASTENERS TO BE PRIMED AND PAINTED.
 8. EXISTING ROOFING & INSULATION TO REMAIN EXCEPT WHERE SHOWN TO BE REMOVED & REPLACED TO INSTALL NEW EQUIPMENT OR TO INFILL WHERE EXISTING EQUIPMENT IS BEING REMOVED. EXISTING EPDM ROOFS ARE UNDER WARRANTY PERFORM ALL WORK IN ACCORDANCE WITH EXISTING MEMBRANE MANUFACTURE'S REQUIREMENTS TO MAINTAIN THE EXISTING WARRANTY INTACT.
 9. CONTRACTOR TO PROTECT EXISTING ROOF(S) DURING CONSTRUCTION. CONTRACTOR TO PROVIDE 1" RIDGE INSULATION AND 1/2" EXTERIOR PLYWOOD, WEIGH DOWN W/ SAND BAGS. ROOF PROTECTION AT ALL WORK AREAS. CONTRACTOR TO LIMIT ROOF TRAFFIC ON EXISTING ROOFS.
 10. CONTRACTOR TO MAINTAIN WATER TIGHTNESS OF BUILDING AT ALL TIMES.
 11. ALL CONNECTION TO BE FILLET WELDS TO BE MINIMUM 1/4" CONTINUOUS. UNLESS NOTED OTHER WISE.

ROOF LEGEND

	PIPE PORTAL. SEE DETAIL 2/A625.
	NEW ROOFING, INSULATION & INFILL. REFER TO DETAIL 1/A625
	ADD NEW WALKWAY PADS. PROVIDE 20 L.F. OF WALKWAY PADS TO BE LOCATED IN FIELD
	EXISTING ROOF DRAIN

- ROOF NOTES:**
1. DIMENSIONS AND CONDITIONS ON THE ROOF PLAN AND DETAILS ARE APPROXIMATE AND MUST BE CONFIRMED BY THE CONTRACTOR.
 2. COVER & PROTECT ALL DRAIN OPENINGS AT THE BEGINNING OF EACH WORK DAY. REMOVE THE COVERS AT THE END OF EACH DAY AND BEFORE PRECIPITATION OCCURS.
 3. INSTALL NEW WALKWAY PADS WHERE SHOWN ON THE ROOF PLAN.
 4. PATCH AND/OR REPLACE EXISTING ROOFING AFFECTED BY NEW NEW WORK. WORK SHALL BE COMPATIBLE WITH EXISTING ROOFING SYSTEM AND PERFORMED BY INSTALLERS ACCEPTABLE TO THE ROOFING MANUFACTURE, SO AS NOT TO VOID ANY EXISTING ROOFING WARRANTIES. REFER TO GENERAL REMOVAL NOTES ON DWG G-1 FOR ADDITIONAL INFORMATION.
 5. PROVIDE CRICKET (1/7" SLOPE) TO DIVERT WATER AWAY FROM CURBS TYPICAL AT ALL NEW SKYLIGHTS AND ROOF MOUNTED EQUIPMENT.
 6. REFER TO M/E/P FOR COORDINATION AND ADDITIONAL INFORMATION.
 7. PROVIDE 20 L.F. OF WALKWAY PADS. LOCATION TO BE DETERMINED IN FIELD.

- ROOF PROTECTION NOTES:**
- 1 PROTECTION SHALL EXTEND A MINIMUM OF 10 FEET IN ALL DIRECTIONS AROUND THE WORK AREA INCLUDING MATERIAL TRANSPORTATION ROUTE(S). PROTECTION SHALL CONSIST OF A POLYETHYLENE TARP (6 MIL.), COVERED WITH A LAYER OF 1/2 INCH THICK EXTRUDED POLYSTYRENE INSULATION (STYROFOAM), AND 1/2 INCH PLYWOOD OR PARTIAL BOARD.
 - a. SECURE THE PLYWOOD OR OSB BOARDS TO PERIMETER PLANKING, WEIGHTED WITH BAGS OF GRAVEL (DOUBLE BAGGED TO PREVENT SPILLAGE) AS NEEDED TO PREVENT BLOW OFF AND/OR DISPLACEMENT.
 - b. COVER JOINTS BETWEEN ADJOINING BOARDS WITH A PEEL AND STICK TYPE MEMBRANE (WR GRACE ICE AND WATER SHIELD OR EQUAL) TO SECURE THE BOARDS AND KEEP THE JOINTS FLUSH. REPLACE DAMAGED SECTIONS OF PROTECTION AND MAINTAIN THE ROOF PROTECTION SYSTEM IN PLACE UNTIL ALL ROOF TOP WORK, BY ALL TRADES, IS COMPLETE.
 - c. REMOVE THE PROTECTION SYSTEM WHEN ROOF TOP WORK IS COMPLETE AND THERE WILL BE NO MORE CONSTRUCTION TRAFFIC. THEN CAREFULLY POWER WASH AND INSPECT THE ROOF MEMBRANE/COATING. REPAIR ANY MINOR DEFECTS; REPLACE PORTIONS OF THE ROOFING SYSTEM WHERE LEAKAGE HAS OCCURRED DESPITE THE PROTECTION AND ROOF INSULATION IS WET, AND RECOAT THE EFFECTED AREA.
 - d.

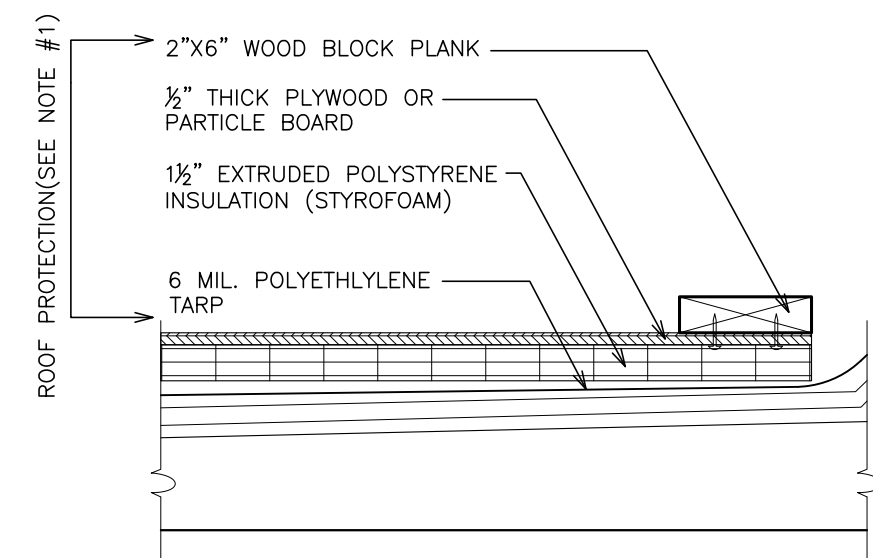

2 DETAIL - ROOF PROTECTION
SCALE: 1 1/2" = 1'-0"

AS PER USA CONGRESS ARCHITECTURAL WORKS COPYRIGHT PROTECTION ACT OF 1990 ALL IDEAS AND DESIGNS INCLUDING DERIVATIVES THEREOF, ALL DRAWINGS AND SPECIFICATIONS CONSTITUTE THE ORIGINAL COPYRIGHT WORK BY FULLER AND DANIELO, P.C. (F&D). THE DRAWINGS AND SPECIFICATIONS AS INSTRUMENTS OF SERVICE BY F&D ARE CREATED BY F&D FOR THIS PROJECT ONLY AND REMAIN THE PRODUCT AND PROPERTY OF F&D. ANY REPRODUCTION WITHOUT THE PRIOR CONSENT OF F&D IS PROHIBITED.

48 KILLWOOD ROAD ELLENHURST NEW YORK 11533
TEL 914.889.4444 FAX 914.889.1717
Copyright 2025 All Rights Reserved by FULLER & DANIELO, P.C.

FULLER
DANIELO
P.C.
ARCHITECTS
PLANNERS

LICENSE EXP. DATE: 02-28-2027

S.E.D. CONTROL NUMBER:
GREENVILLE ELEMENTARY SCHOOL
66-04-06-03-0-008-021

PROJECT TITLE
EDGEHART SCHOOL DISTRICT
GREENVILLE ELEMENTARY SCHOOL
CAFETERIA RENOVATION


DRAWING TITLE
PARTIAL ROOF PLAN

01-31-2025	BID
01-19-2022	SED SUBMISSION
DATE	ISSUED TO
SHEET SIZE 30"x42"	DRAWING NO.
SCALE AS NOTED	A152
DRAWN BY F & D	FILE NO. 24529.01

PLOT DATE: January 22, 2025 -- 7:22am

FILE: I:\24529.01 Greenville Cafeteria Renovation\DRAWINGS\CURRENT\1-F&D\A200 AR200.dwg

 1 PARTIAL FIRST FLOOR REMOVAL REFLECTED CEILING PLAN
SCALE: 1/4" = 1'-0"



LUNCH
(129)
CH=13'-5/8"±
R2 R18
R22 R23

PLATFORM
(133)
CH=10'-11 1/2"±
R17 R18 R22

MAIN OFFICE
(10)

VEST.
(11)

LOBBY
(11)
CH=9'-0"±

TOILET
(222)

STAIR
(11.4)

CORRIDOR
(11.2)
CH=8'-5 1/2"±

KITCHEN
WALKER
(133)
CH=8'-5"±
R2 R18 R22

CLASSROOM
(12)
CH=12'-1"±

REMOVAL NOTES:

- R1 REMOVE EXISTING DOORS, METAL FRAMES, TRANSOMS, HARDWARE, SADDLES, SIDE-LITES AND ALL RELATED ITEMS. PATCH ALL DISTURBED SURFACES TO MATCH EXISTING ADJACENT SURFACES.
- R2 REMOVE EXISTING SUSPENDED CEILING ASSEMBLY (2x4 OR 2x2), SUSPENSION SYSTEM, PANELS, WALL ANGLES, SEISMIC TIES AND ALL RELATED ITEMS. COORDINATE WORK WITH E-CONTRACTOR. PATCH ALL DISTURBED SURFACES TO MATCH EXISTING ADJACENT SURFACES.
- R3 REMOVE EXISTING WOOD FRAMED PLATFORM, RAILING AND STAIR IN IT'S ENTIRETY AND RELATED ITEMS. PATCH ALL DISTURBED SURFACES TO MATCH EXISTING ADJACENT SURFACES.
- R4 REMOVE EXISTING SUSPENDED CEILING ASSEMBLY, SUSPENSION SYSTEM, PANELS, WALL ANGLES, SEISMIC TIES AND ALL RELATED ITEMS. COORDINATE WORK WITH E-CONTRACTOR. PATCH ALL DISTURBED SURFACES TO MATCH EXISTING ADJACENT SURFACES.
- R5 REMOVE EXISTING PLASTER CEILING ASSEMBLY INCLUDING HANGERS, BLACK IRON, PANELS AND ASSOCIATED ITEMS. COORDINATE WORK WITH E-CONTRACTOR. PATCH ALL DISTURBED SURFACES TO MATCH EXISTING ADJACENT SURFACES.
- R6 REMOVE EXISTING VCT FLOOR TILE, (MULTIPLE LAYER MAY EXIST) WALL BASE, TRANSITION STRIPS, MASTIC AND SUBSTRATE DOWN TO EXISTING SLAB. MECHANICALLY PROFILE 100% OF EXISTING SUB-FLOOR FOR NEW FLOOR FINISHES.
- R7 REMOVE EXISTING CASEWORK, BRACKETS, BASE, FLOOR TRACKS AND ALL RELATED ITEMS. PATCH ALL DISTURBED SURFACES TO MATCH EXISTING ADJACENT SURFACES. COORDINATE WORK WITH PLUMBING AND ELECTRICAL CONTRACTORS.
- R8 REMOVE EXISTING WALL MOUNTED ACOUSTIC PANELS AND FRAME AND ALL RELATED ITEMS. PATCH ALL DISTURBED SURFACES TO MATCH EXISTING ADJACENT SURFACES.
- R9 REMOVE EXISTING WALL MURAL AND ALL RELATED ITEMS. PATCH ALL DISTURBED SURFACES TO MATCH EXISTING ADJACENT SURFACES. REINSTALL MURAL OVER NEW WALL FURRING.
- R10 REMOVE EXISTING FOUNDATION WALL DOWN TO A MINIMUM OF 6" BELOW THE CAFETERIA FINISHED FLOOR. PATCH WITH CONCRETE.
- R11 REMOVE EXISTING WALL PADDING AND ALL RELATED ITEMS. PATCH ALL DISTURBED SURFACES TO MATCH EXISTING ADJACENT SURFACES.
- R12 REMOVE EXISTING WALL MOUNTED PADDING SUPPORT TRACK AND ALL RELATED ITEMS. PATCH ALL DISTURBED SURFACES TO MATCH EXISTING ADJACENT SURFACES.
- R13 REMOVE EXISTING MASONRY KNEE WALL AT EDGE OF EXISTING PLATFORM. COORDINATE WITH ELECTRICAL CONTRACTOR. PATCH DISTURBED SURFACES TO MATCH EXISTING ADJACENT SURFACES. GRIND DOWN ANY HIGH SPOTS UNDER EXISTING WALL. FLASH PATCH SMOOTH TO ADJACENT SURFACES.
- R14 REMOVE AND RE-INSTALL EXISTING WINDOW SHADES. SAFELY STORE AND REMOUNT.
- R15 MECHANICAL CONTRACTOR TO REMOVE EXISTING FIN-TUBE. COORDINATE WORK.
- R16 REMOVE MARKER BOARD AND RELATED ITEMS. TURN OVER TO OWNER.
- R17 REMOVE EXISTING CEILING & EXISTING PLASTER CEILING ASSEMBLY INCLUDING HANGERS, BLACK IRON, PANELS AND ASSOCIATED ITEMS.
- R18 REMOVAL OF EXISTING LIGHT FIXTURE BY ELECTRICAL CONTRACTOR.
- R19 REMOVE EXISTING METAL STAIR STRUCTURE AND RELATED ITEMS. PATCH DISTURBED SURFACES TO MATCH EXISTING ADJACENT SURFACES.
- R20 SAW-CUT ALONG EXISTING SCORED JOINTS AND REMOVE PORTION OF EXISTING CONCRETE WALK, BASE & SUB-BASE TO INSTALL NEW RAMP.
- R21 SALVAGE EXISTING REMOVED GLAZED BLOCK FOR RE-USE.
- R22 REMOVAL OF EXISTING CEILING MOUNTED DEVICES. BY ELECTRICAL CONTRACTOR
- R23 REMOVAL OF EXISTING AIR GRILLES BY MECHANICAL CONTRACTOR.
- R24 APPROXIMATE LOCATION OF CEILING REMOVALS IN ORDER TO ACCESS AREA TO INSTALL NEW STEEL COLUMN.
- R25 REMOVE EXISTING SOFFIT.
- R26 SAW-CUT AND REMOVE PORTION OF WALL DOWN TO SLAB LEVEL. FOR INSTALLATION ON NEW WORK. PATCH DISTURBED SURFACES TO MATCH EXISTING ADJACENT SURFACES.
- R27 REMOVE EXISTING CONCRETE AREAWAY AND FOUNDATION. REMOVE ABANDONED DRAIN AND PIPING OUT OF NEW WORK AREA. CAP PIPING.
- R28 REMOVE FIRE EXTINGUISHER AND BRACKET AND TURN OVER TO OWNER.
- R29 REMOVE AND SALVAGE EXISTING GLAZED BLOCK TO INSTALL COLUMN. REINSTALL TO MATCH EXISTING.
- R30 REMOVE EXISTING DOOR AND HARDWARE.
- R31 EXISTING FOOD SERVICE EQUIPMENT. TURN OVER TO OWNER.
- R32 OWNER TO REMOVE EXISTING CHARGER STATION.
- R33 PATCH FLOOR/ WALL OPENING TO MATCH EXISTING DUE TO DUCT REMOVAL. COORDINATE WITH MECHANICAL CONTRACTOR.

COORDINATE ALL REMOVALS WITH ASBESTOS AND LEAD ABATEMENT DRAWINGS AND SPECIFICATIONS.

AS PER USA CONGRESS ARCHITECTURAL WORKS COPYRIGHT PROTECTION ACT OF 1990 ALL IDEAS AND DESIGNS INCLUDING DERIVATIVES THEREOF, ALL DRAWINGS AND SPECIFICATIONS CONSTITUTE THE ORIGINAL COPYRIGHT WORK BY FULLER AND DANKELO, P.C. (F&D). THE DRAWINGS AND SPECIFICATIONS AS INSTRUMENTS OF SERVICE BY F&D ARE CREATED BY F&D FOR THIS PROJECT ONLY AND REMAIN THE PRODUCT AND PROPERTY OF F&D. ANY REPRODUCTION WITHOUT THE PRIOR CONSENT OF F&D IS PROHIBITED.

48 KENNESAW ROAD KENNESAW, ALABAMA 36144
TEL 914.888.4444 FAX 914.888.1919
Copyright 2025 All Rights Reserved By FULLER & DANKELO, P.C.

FULLER
DANKELO
P.C.
ARCHITECTS
PLANNERS

LICENSE EXP. DATE: 02-28-2027

S.E.D. CONTROL NUMBER:
GREENVILLE ELEMENTARY SCHOOL
66-04-06-03-0-008-021

PROJECT TITLE
EDGEWORTH SCHOOL DISTRICT
GREENVILLE ELEMENTARY SCHOOL
CAFETERIA RENOVATION

DRAWING TITLE
PARTIAL FIRST FLOOR REMOVAL REFLECTED
CEILING PLAN

01-31-2025 BID
01-10-2022 SED SUBMISSION
DATE ISSUED TO

SHEET SIZE
30"x42"

SCALE
AS NOTED

DRAWN BY
F & D

FILE NO.
24529.01

DRAWING NO.
AR200



FILE: I:\24529.01 Greenville Cafeteria Renovation\DRAWINGS\CURRENT\1-F&D\A200 AR200.dwg


DRAWN BY F & D	FILE NO. 24529.01
-------------------	----------------------

PLOT DATE: January 22, 2025 - 7:24am

FILE: I:\24529.01 Greenville Cafeteria Renovation\DRAWINGS\CURRENT\1-F&D\A425 426 427.dwg


1 REMOVAL WALL SECTION

SCALE: 1" = 1'-0"

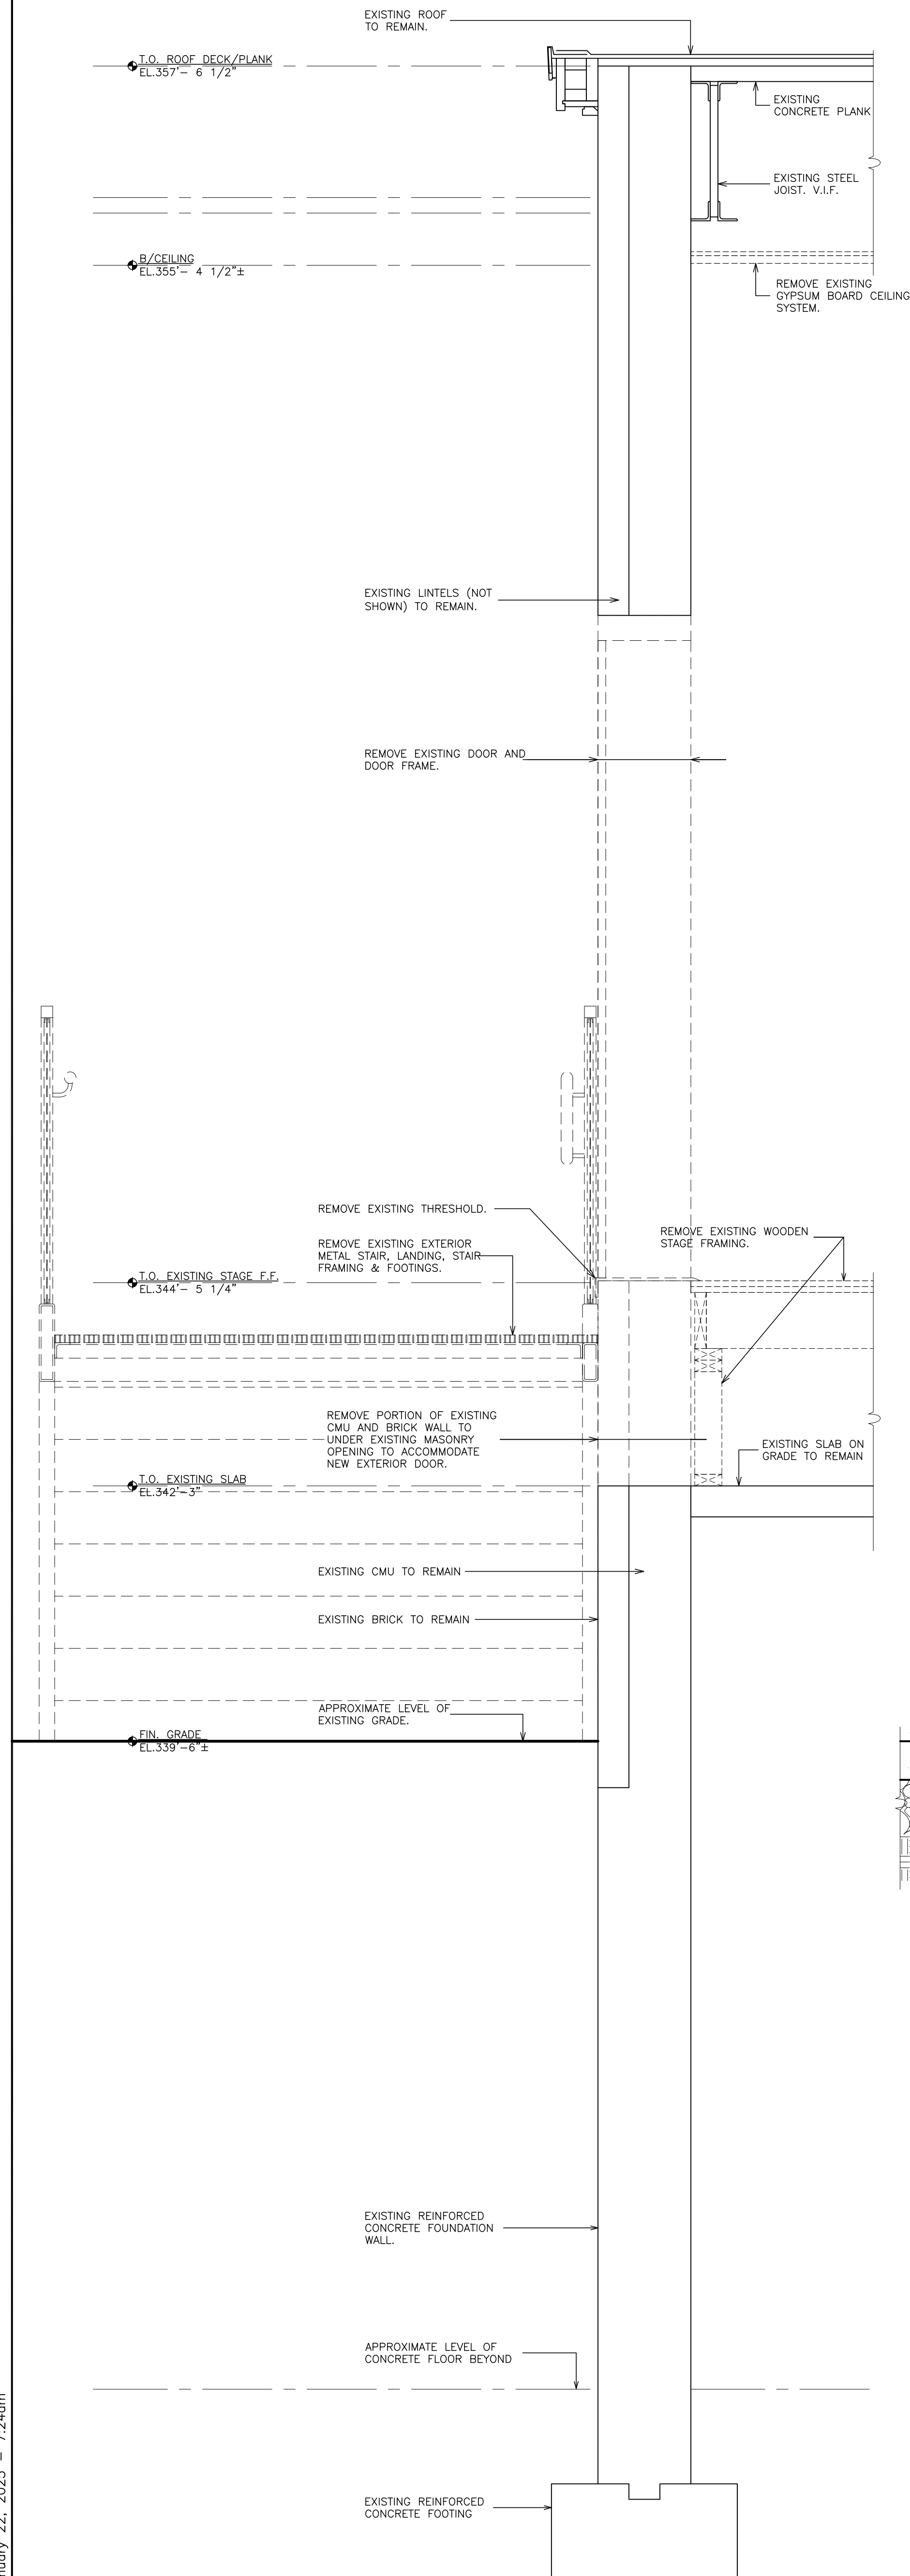


2 WALL SECTION

SCALE: 1" = 1'-0"

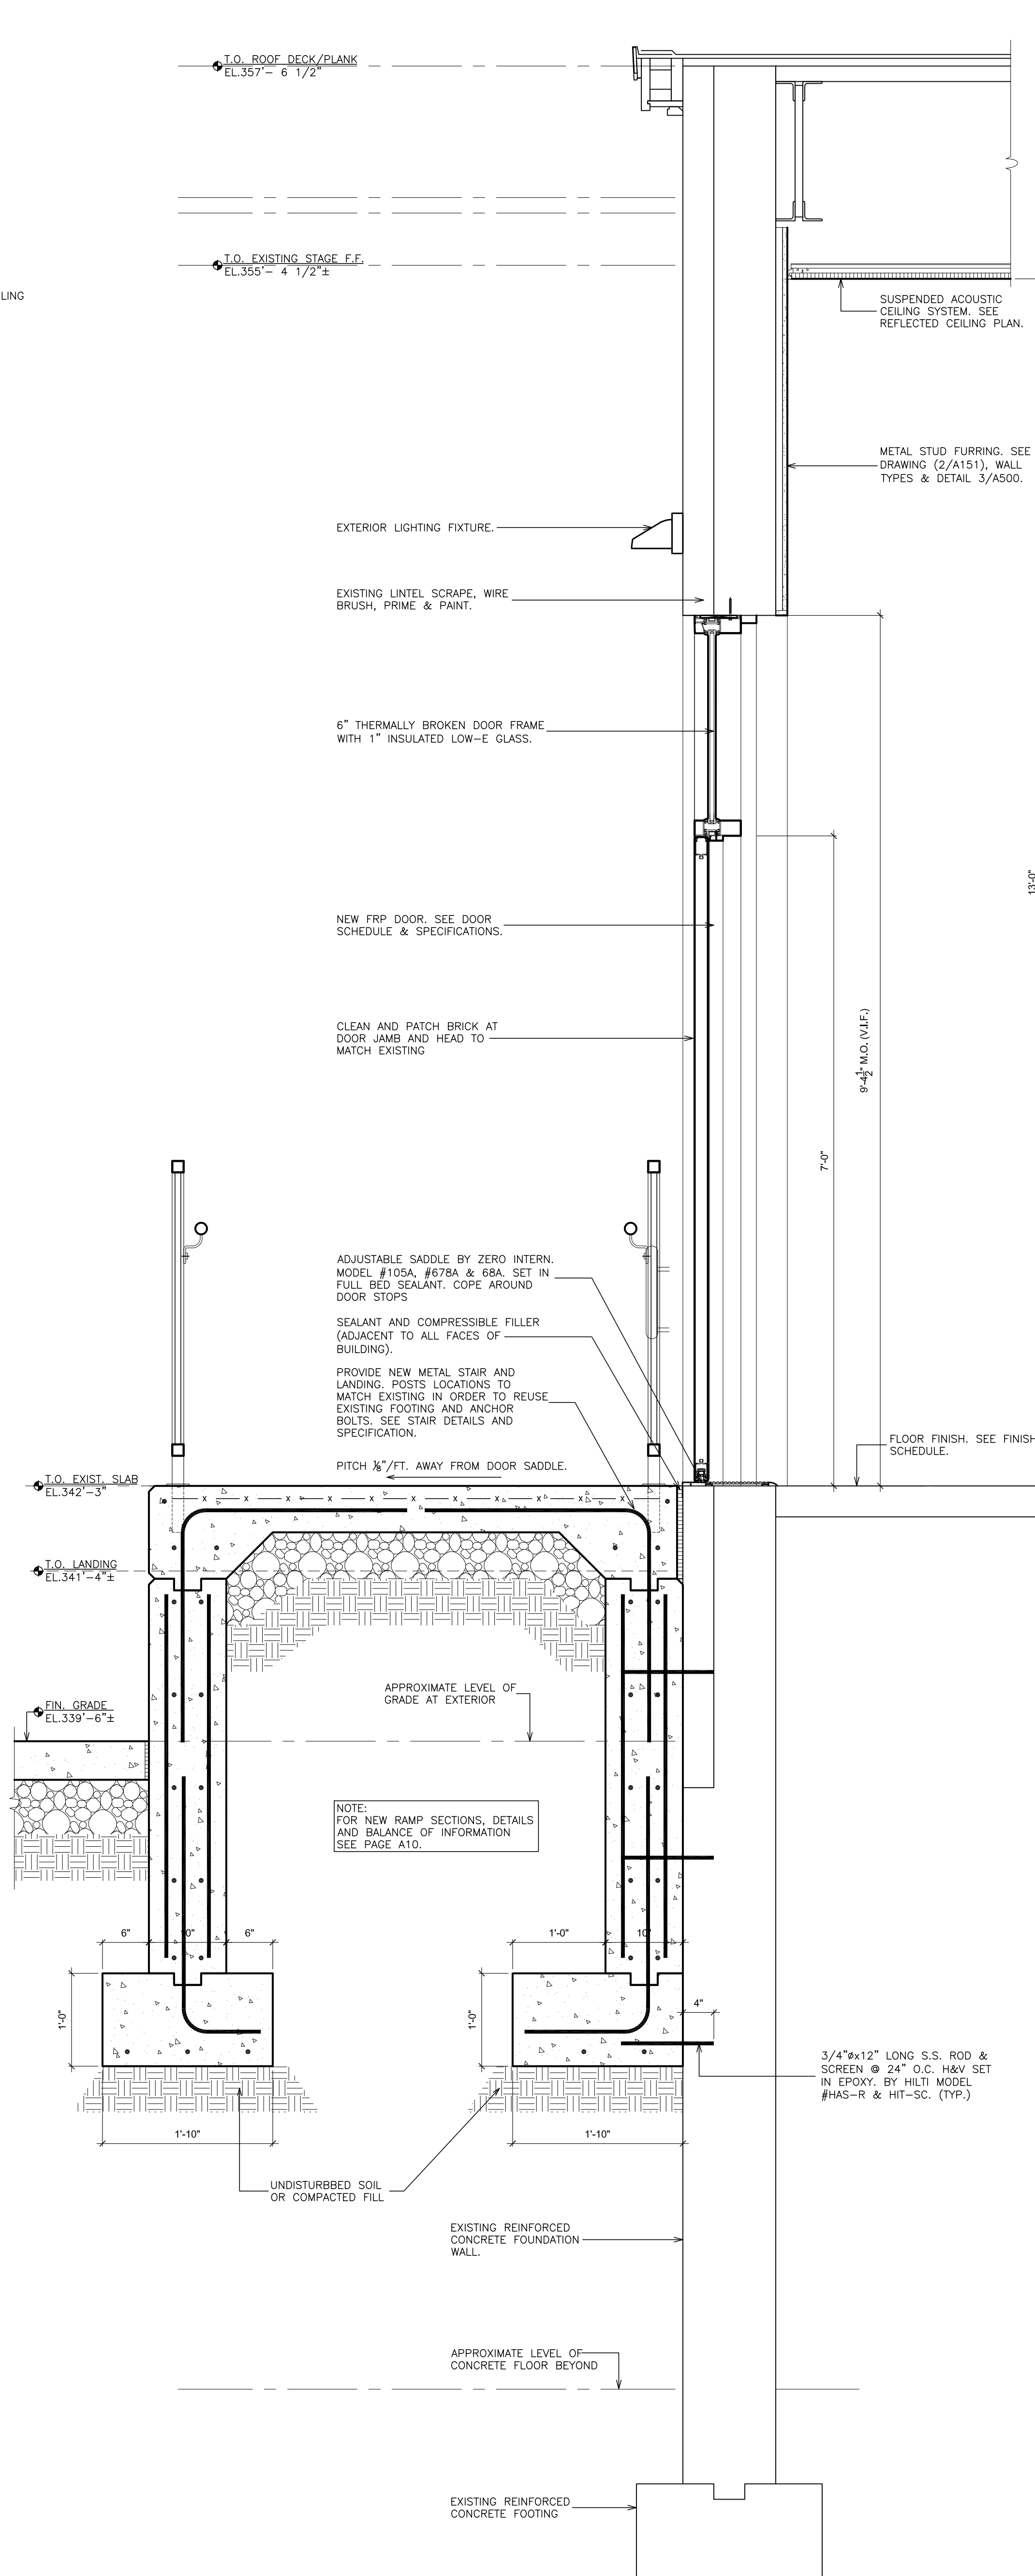


3 REMOVAL WALL SECTION

SCALE: 1" = 1'-0"

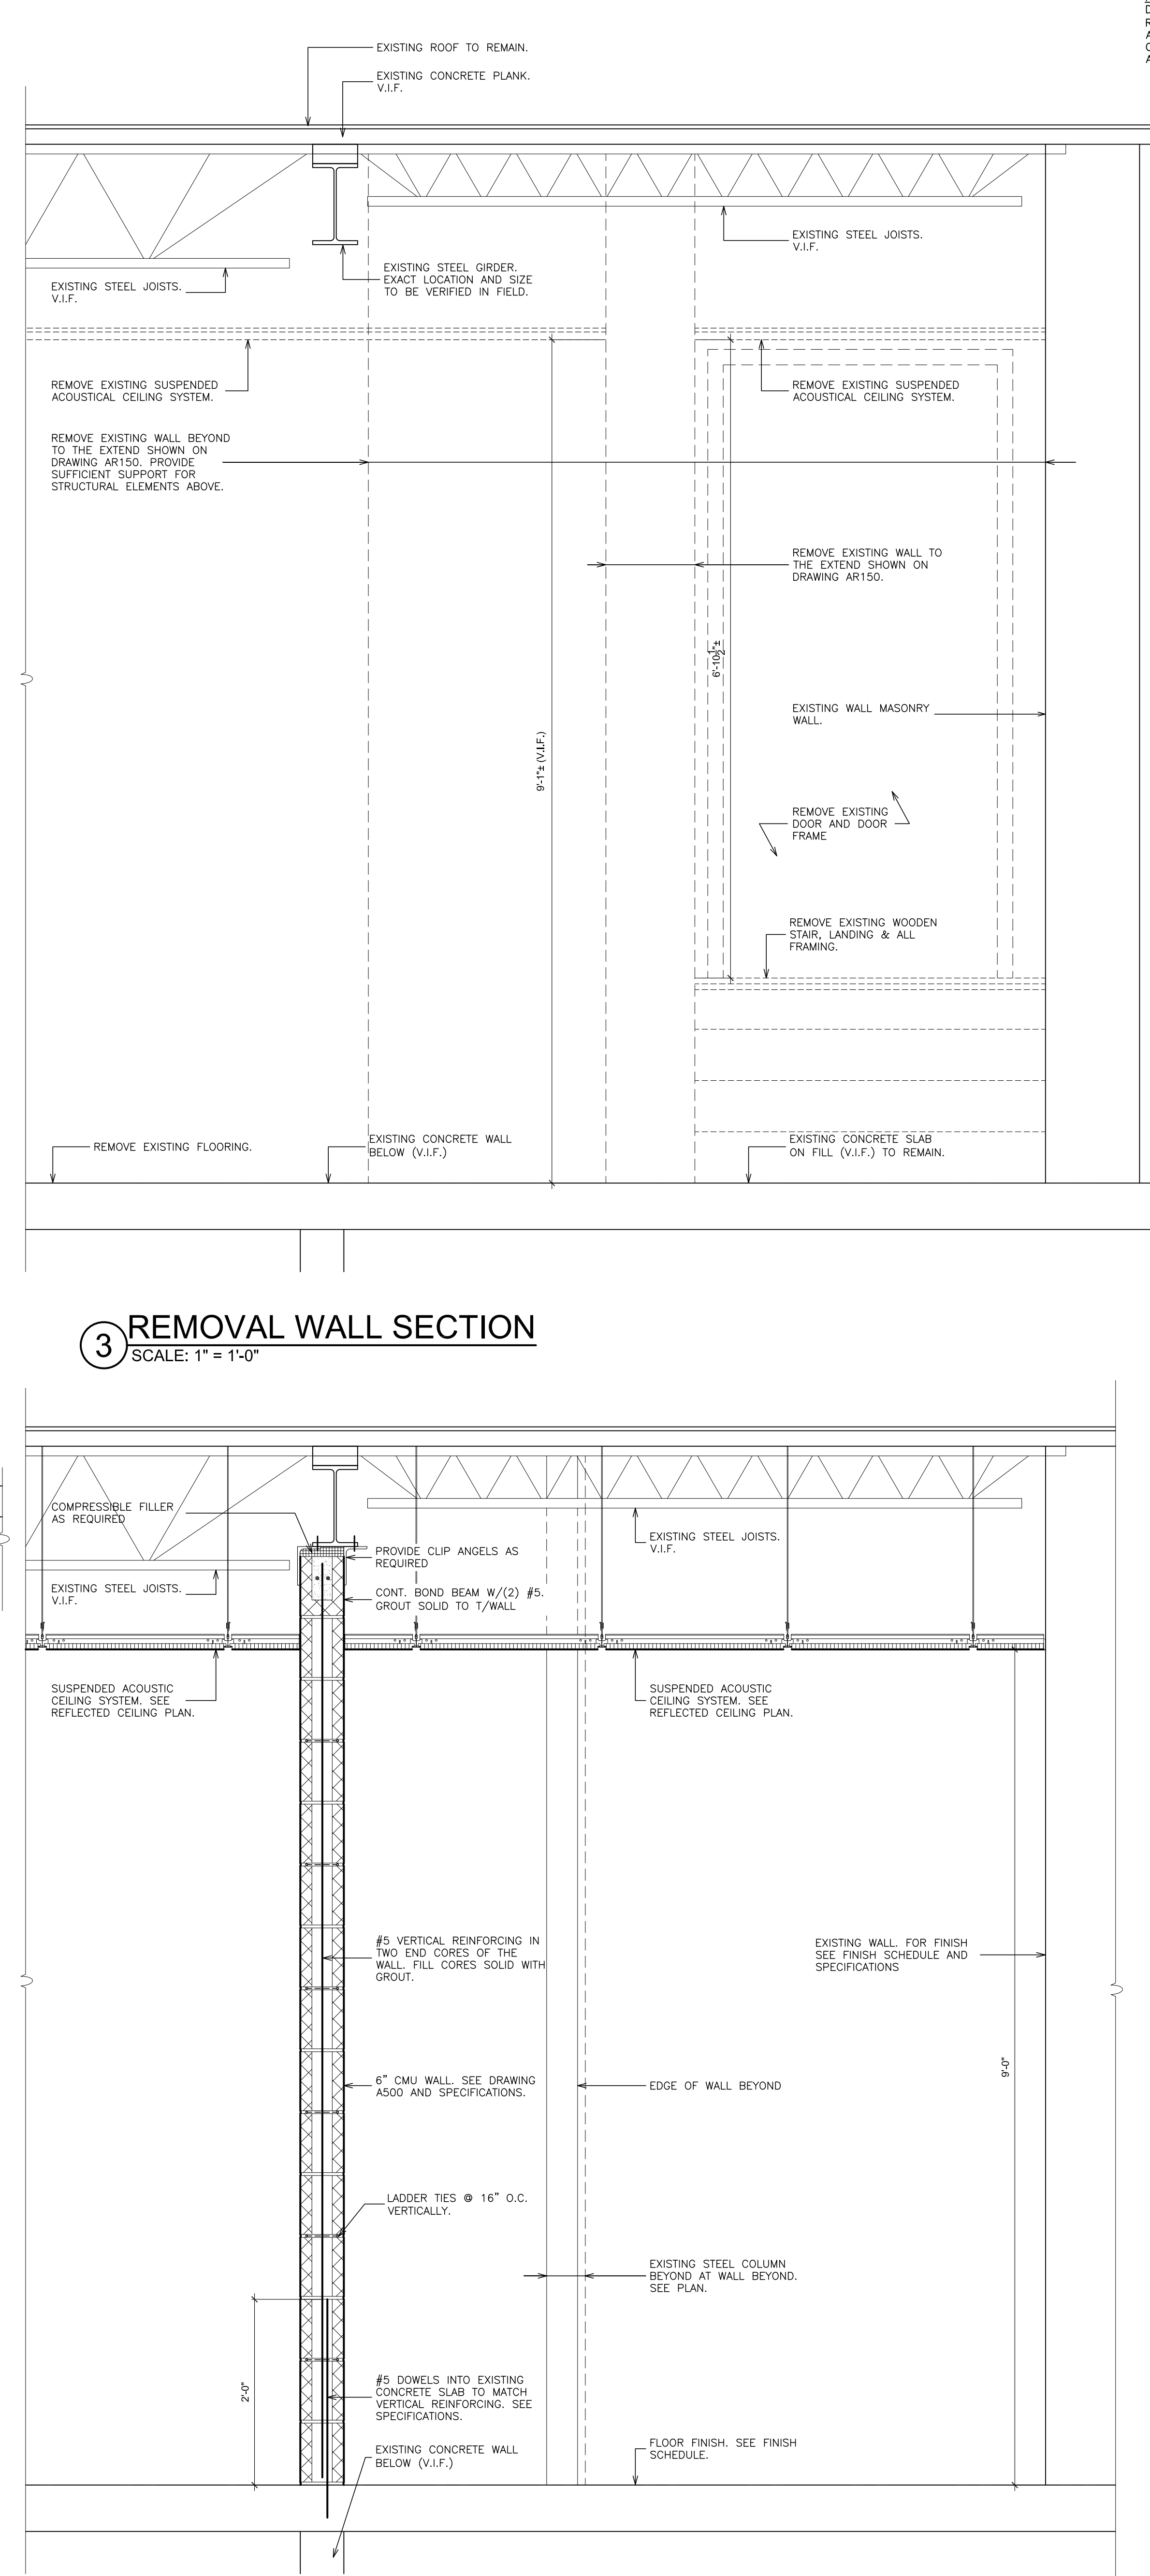

KEY PLAN

N.T.S.

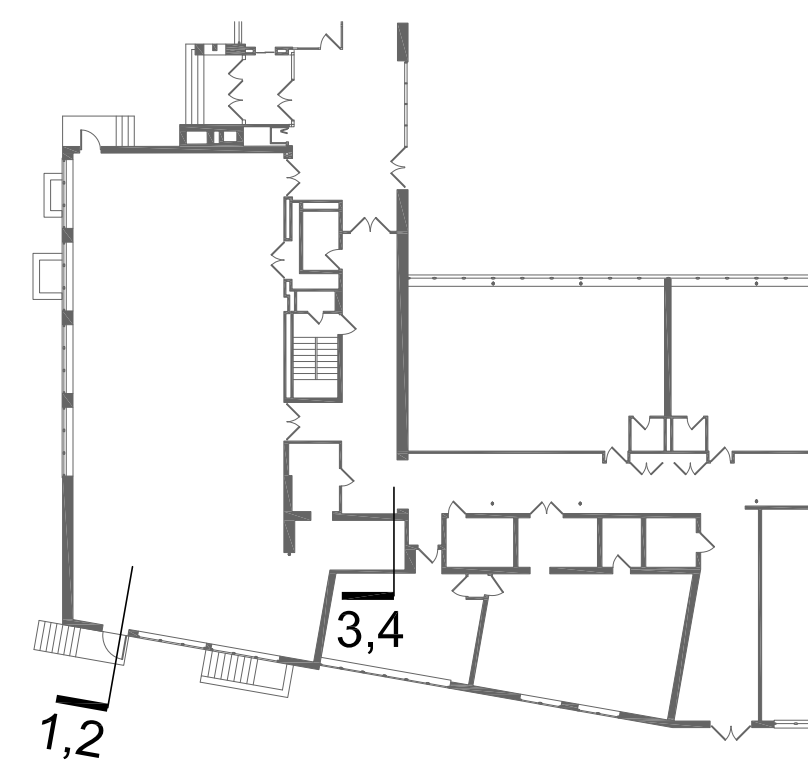

NOTE: EXISTING CONDITIONS OF CONSTRUCTION SHOWN ON THIS DRAWINGS ARE BASED ON DRAWINGS PROVIDED BY OWNER TO F&D FOR REFERENCE ONLY (NOT AS-BUILT DRAWINGS). ALL EXISTING CONDITIONS AND DIMENSIONS ARE TO BE FIELD VERIFIED. ANY VARIATIONS FROM CONDITIONS AS SHOWN ON THIS DRAWINGS SHALL BE BROUGHT TO THE ATTENTION OF THE ARCHITECT.

AS PER USA CONGRESS ARCHITECTURAL WORKS COPYRIGHT PROTECTION ACT OF 1990 ALL IDEAS AND DESIGNS INCLUDING DERIVATIVES THEREOF, ALL DRAWINGS AND SPECIFICATIONS CONSTITUTE THE ORIGINAL COPYRIGHT WORK BY FULLER AND DANKELO, P.C. (F&D). THE DRAWINGS AND SPECIFICATIONS AS INSTRUMENTS OF SERVICE BY F&D ARE CREATED BY F&D FOR THIS PROJECT ONLY AND REMAIN THE PRODUCT AND PROPERTY OF F&D. ANY REPRODUCTION WITHOUT THE PRIOR CONSENT OF F&D IS PROHIBITED.

48 ENCLWOOD ROAD ELLENHURST NEW YORK 11533
TEL 914.898.4444 FAX 914.898.1917
Copyright 2025 All Rights Reserved by FULLER & DANKELO, P.C.

FULLER
DANKELO
P.C.
ARCHITECTS
PLANNERS

LICENSE EXP. DATE: 02-28-2027

S.E.D. CONTROL NUMBER:
GREENVILLE ELEMENTARY SCHOOL
66-04-06-03-0-008-021

PROJECT TITLE
GREENMONT SCHOOL DISTRICT
GREENVILLE ELEMENTARY SCHOOL
CAFETERIA RENOVATION

DRAWING TITLE
WALL SECTIONS

01-31-2025	BID
01-19-2022	SED SUBMISSION
DATE	ISSUED TO
SHEET SIZE 30"x42"	DRAWING NO.
SCALE AS NOTED	A425
DRAWN BY F & D	FILE NO. 24529.01

AS PER USA CONGRESS ARCHITECTURAL WORKS COPYRIGHT PROTECTION ACT OF 1990 ALL IDEAS AND SPECIFICATIONS DERIVATIVES THEREOF, ALL DRAWINGS AND SPECIFICATIONS CONSTITUTE THE ORIGINAL COPYRIGHT WORK BY FULLER AND D'ANGELO, P.C. (F&D). THE DRAWINGS AND SPECIFICATIONS AS INSTRUMENTS OF SERVICE BY F&D ARE CREATED BY F&D FOR THIS PROJECT ONLY AND REMAIN THE PRODUCT AND PROPERTY OF F&D. ANY REPRODUCTION WITHOUT THE PRIOR CONSENT OF F&D IS PROHIBITED.

45 KNOLLWOOD ROAD ELMSFORD NEW YORK 10523
TEL 914.592.4444 FAX 914.592.1717
WWW.FULLERDANDELO.COM

FULLER
D'ANGELO
P.C.

ARCHITECTS
PLANNERS

LICENSE EXP. DATE: 02-28-2027

S.E.D. CONTROL NUMBER:
GREENVILLE ELEMENTARY SCHOOL
66-04-06-03-0-008-021

PROJECT TITLE
EDGEMONT SCHOOL DISTRICT
GREENVILLE ELEMENTARY SCHOOL
CAFETERIA RENOVATION

DRAWING TITLE
WALL SECTIONS



01-31-2025	BID
01-10-2022	SED SUBMISSION
DATE	ISSUED TO


SHEET SIZE 20" x 40"	DRAWING NO.
-------------------------	-------------

SCALE
AS NOTED

A426


FILE NO.
24529.01

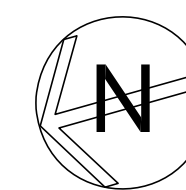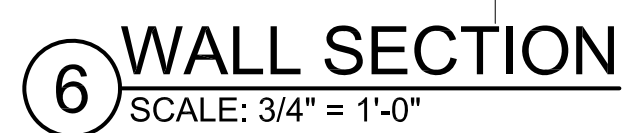

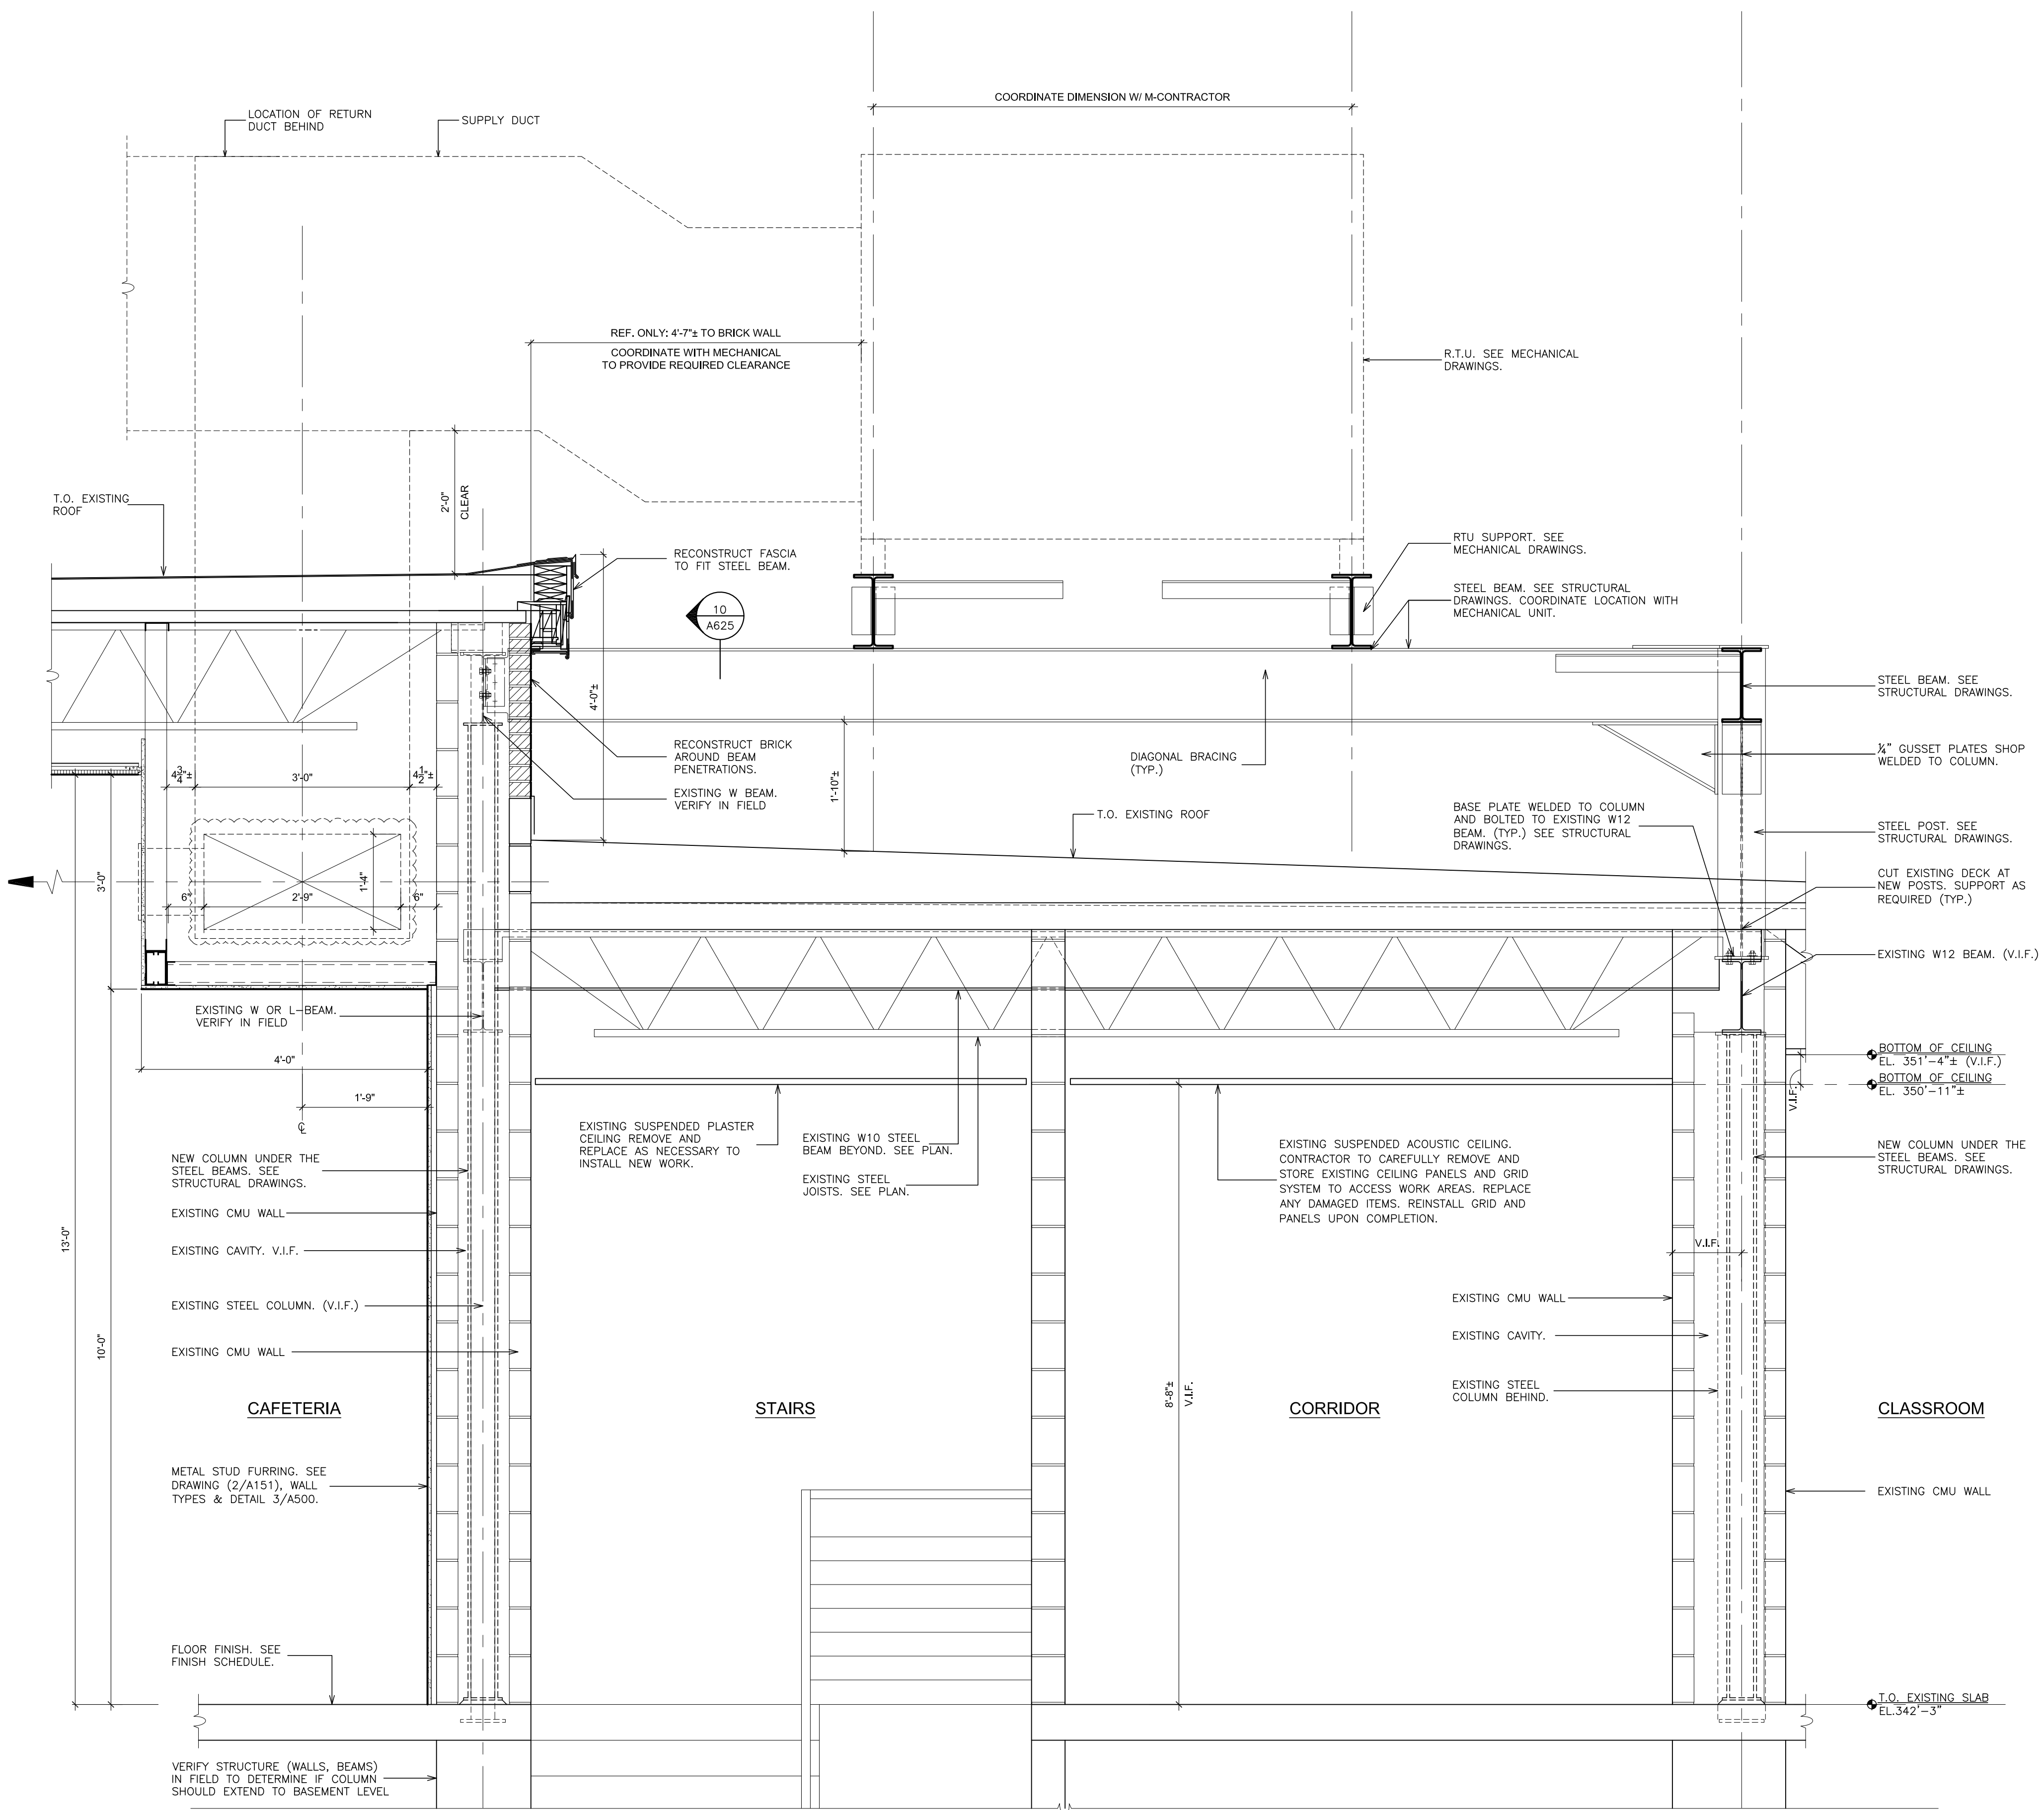

7 PARTIAL BUILDING SECTION
SCALE: 3/4" = 1'-0"

- NOTES:
- NEW HSS 6X6X $\frac{5}{8}$ STEEL DUNNAGE POST ON TOP OF EXISTING COLUMN.
 - EXISTING ROUND STEEL COLUMN BELOW. BELOW EXISTING WF BEAM.
 - VERIFY FIELD CONDITIONS PRIOR FABRICATION AND INSTALLATION.
 - PROVIDE MOMENT CONNECTION TO NEW BEAMS

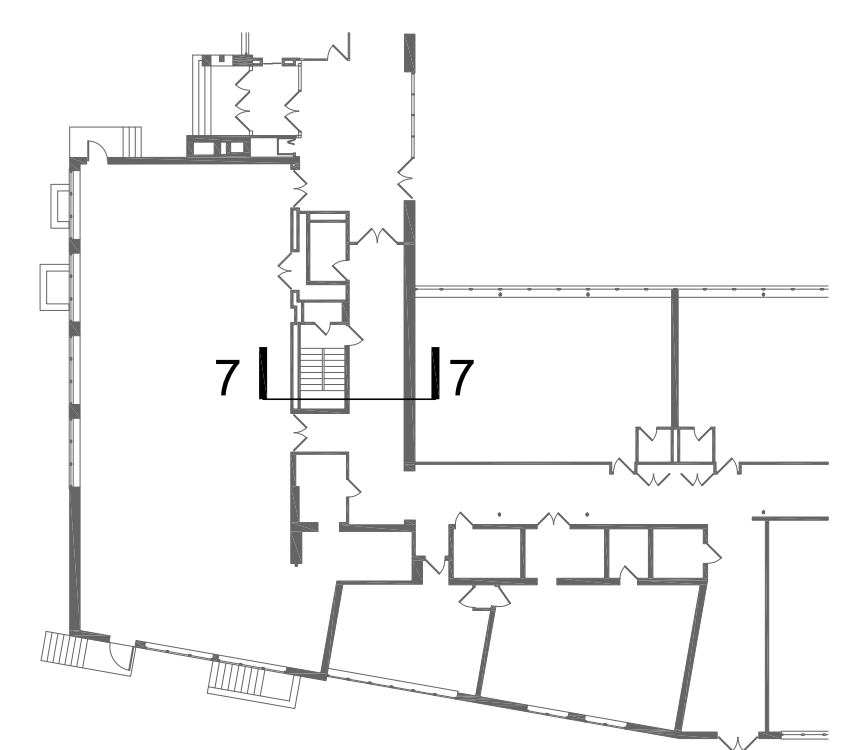

KEY PLAN
N.T.S.

NOTE: EXISTING CONDITIONS OF CONSTRUCTION SHOWN ON THIS DRAWING ARE BASED ON DRAWINGS PROVIDED BY OWNER TO F&D FOR REFERENCE ONLY (NOT AS-BUILT DRAWINGS). ALL EXISTING CONDITIONS AND DIMENSIONS ARE TO BE FIELD VERIFIED. ANY VARIATIONS FROM CONDITIONS AS SHOWN ON THIS DRAWING SHALL BE BROUGHT TO THE ATTENTION OF THE ARCHITECT.

AS PER USA CONGRESS ARCHITECTURAL WORKS COPYRIGHT PROTECTION ACT OF 1990 ALL IDEAS AND DESIGNS INCLUDING DERIVATIVES THEREOF, ALL DRAWINGS AND SPECIFICATIONS CONSTITUTE THE ORIGINAL COPYRIGHT WORK BY FULLER AND DANKELO, P.C. (F&D). THE DRAWINGS AND SPECIFICATIONS AS INSTRUMENTS OF SERVICE BY F&D ARE CREATED BY F&D FOR THIS PROJECT ONLY AND REMAIN THE PROPERTY OF F&D. ANY REPRODUCTION WITHOUT THE PRIOR CONSENT OF F&D IS PROHIBITED.

48 KNOXWOOD ROAD ELLENFIELD NEW YORK 10833
TEL 914.898.4444 FAX 914.898.1717
Copyright 2022 All Rights Reserved By FULLER & DANKELO, P.C.

**FULLER
DANKELO
P.C.**
**ARCHITECTS
PLANNERS**
















LICENSE EXP. DATE: 02-28-2027

S.E.D. CONTROL NUMBER:
GREENVILLE ELEMENTARY SCHOOL
66-04-06-03-0-008-021

PROJECT TITLE
EDGEWORTH SCHOOL DISTRICT
GREENVILLE ELEMENTARY SCHOOL
CAFETERIA RENOVATION

DRAWING TITLE
PARTIAL BUILDING SECTIONS

01-31-2025	BID
01-10-2022	SED SUBMISSION
DATE	ISSUED TO
SHEET SIZE 30"x42"	DRAWING NO.
SCALE AS NOTED	A427
DRAWN BY F & D	FILE NO. 24529.01

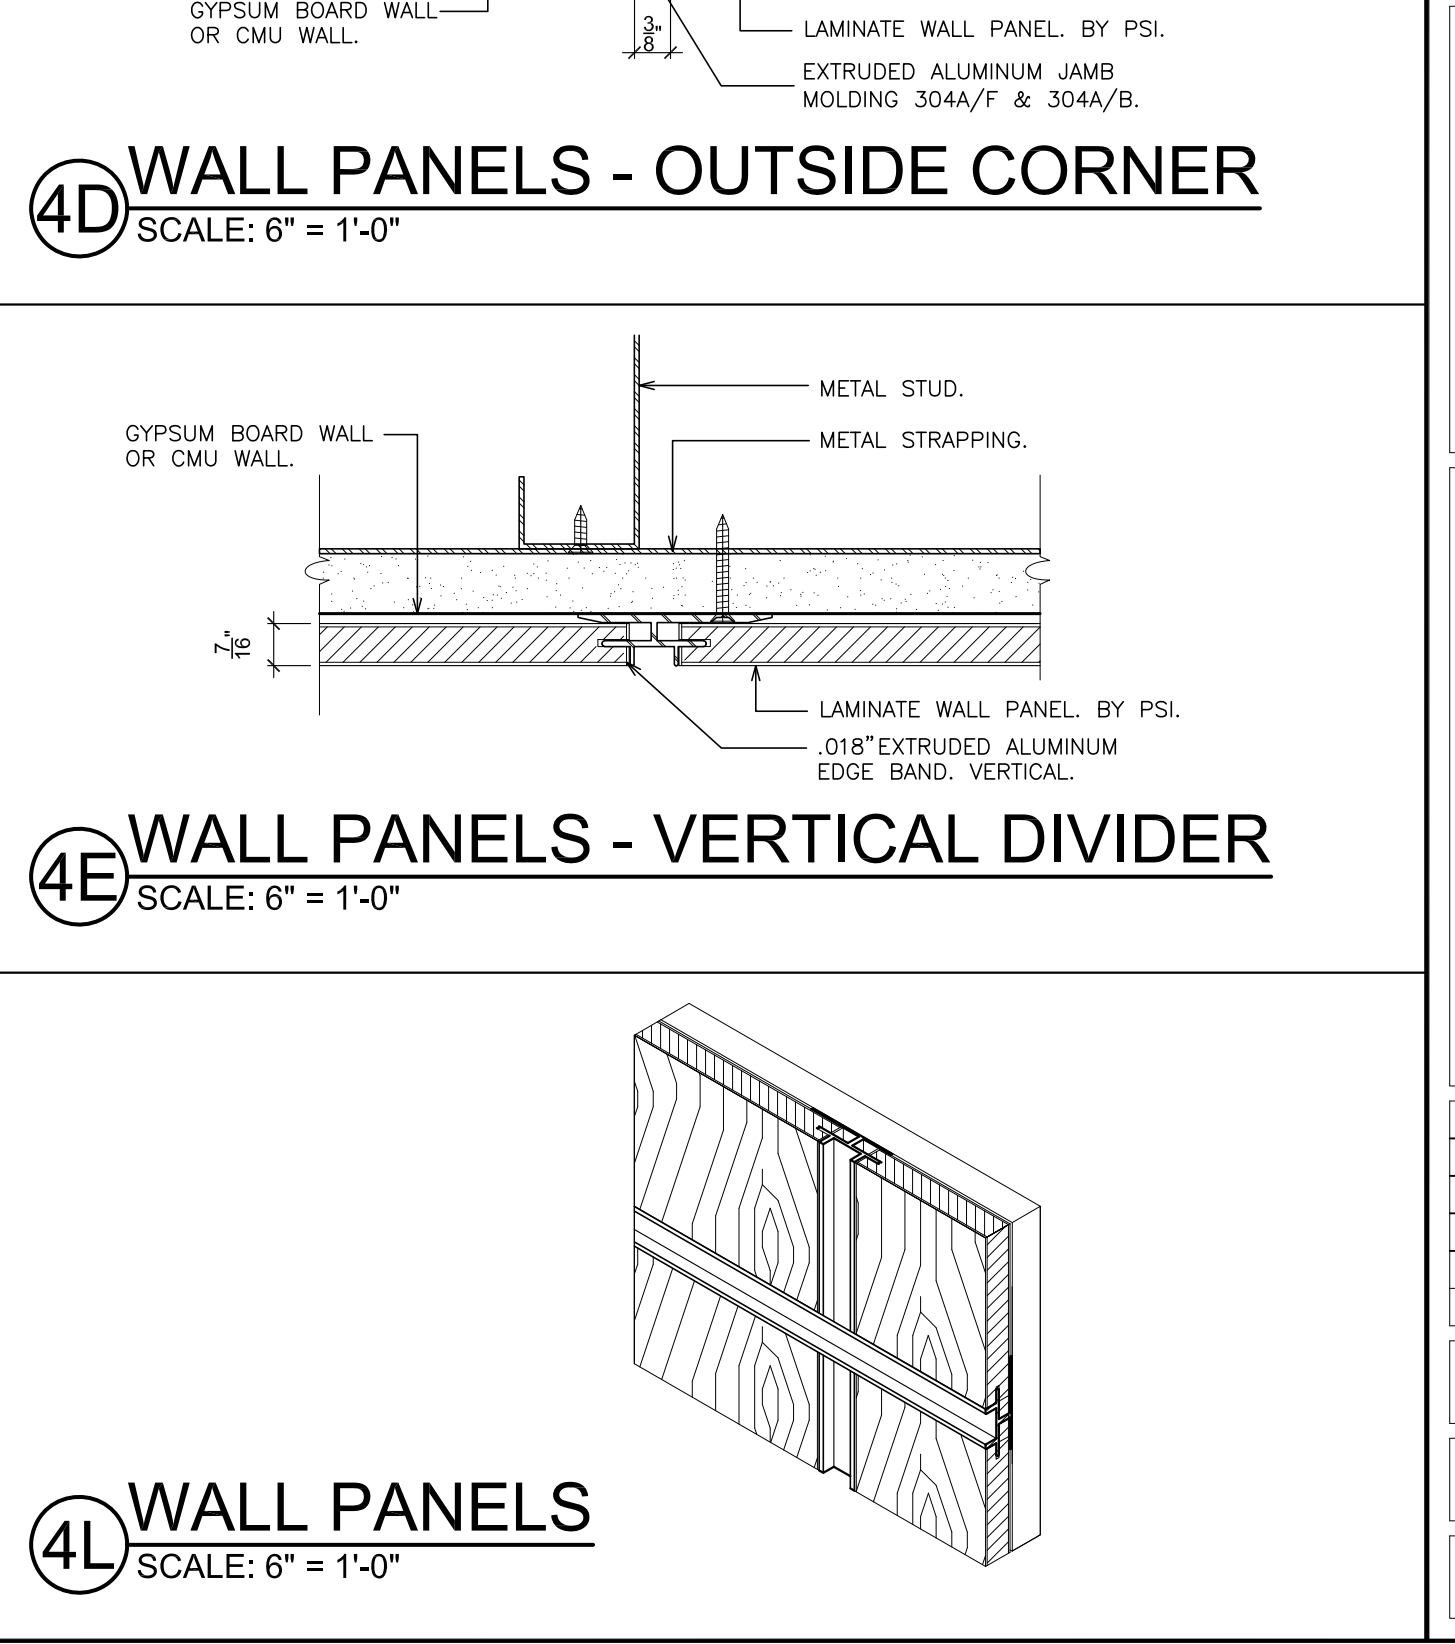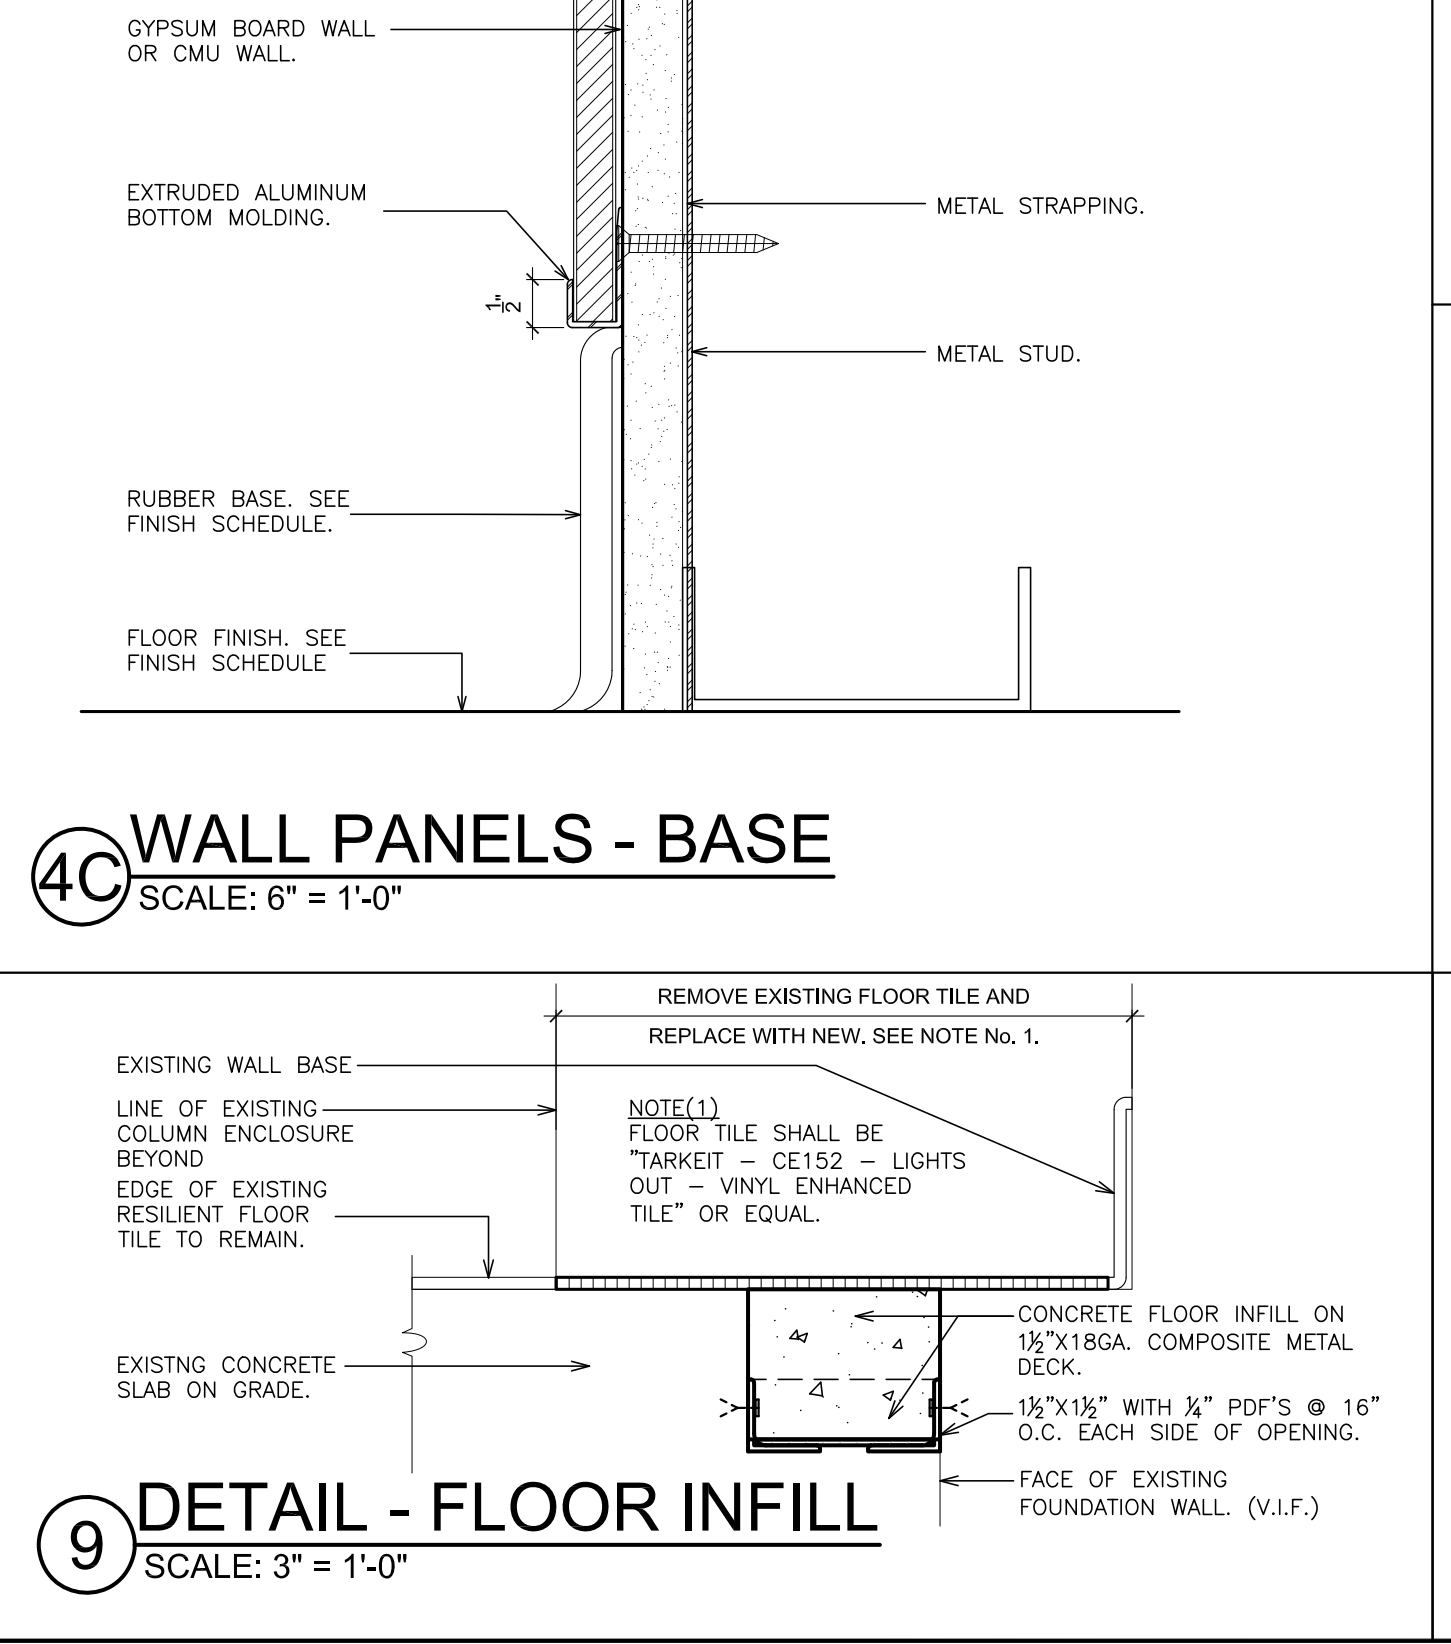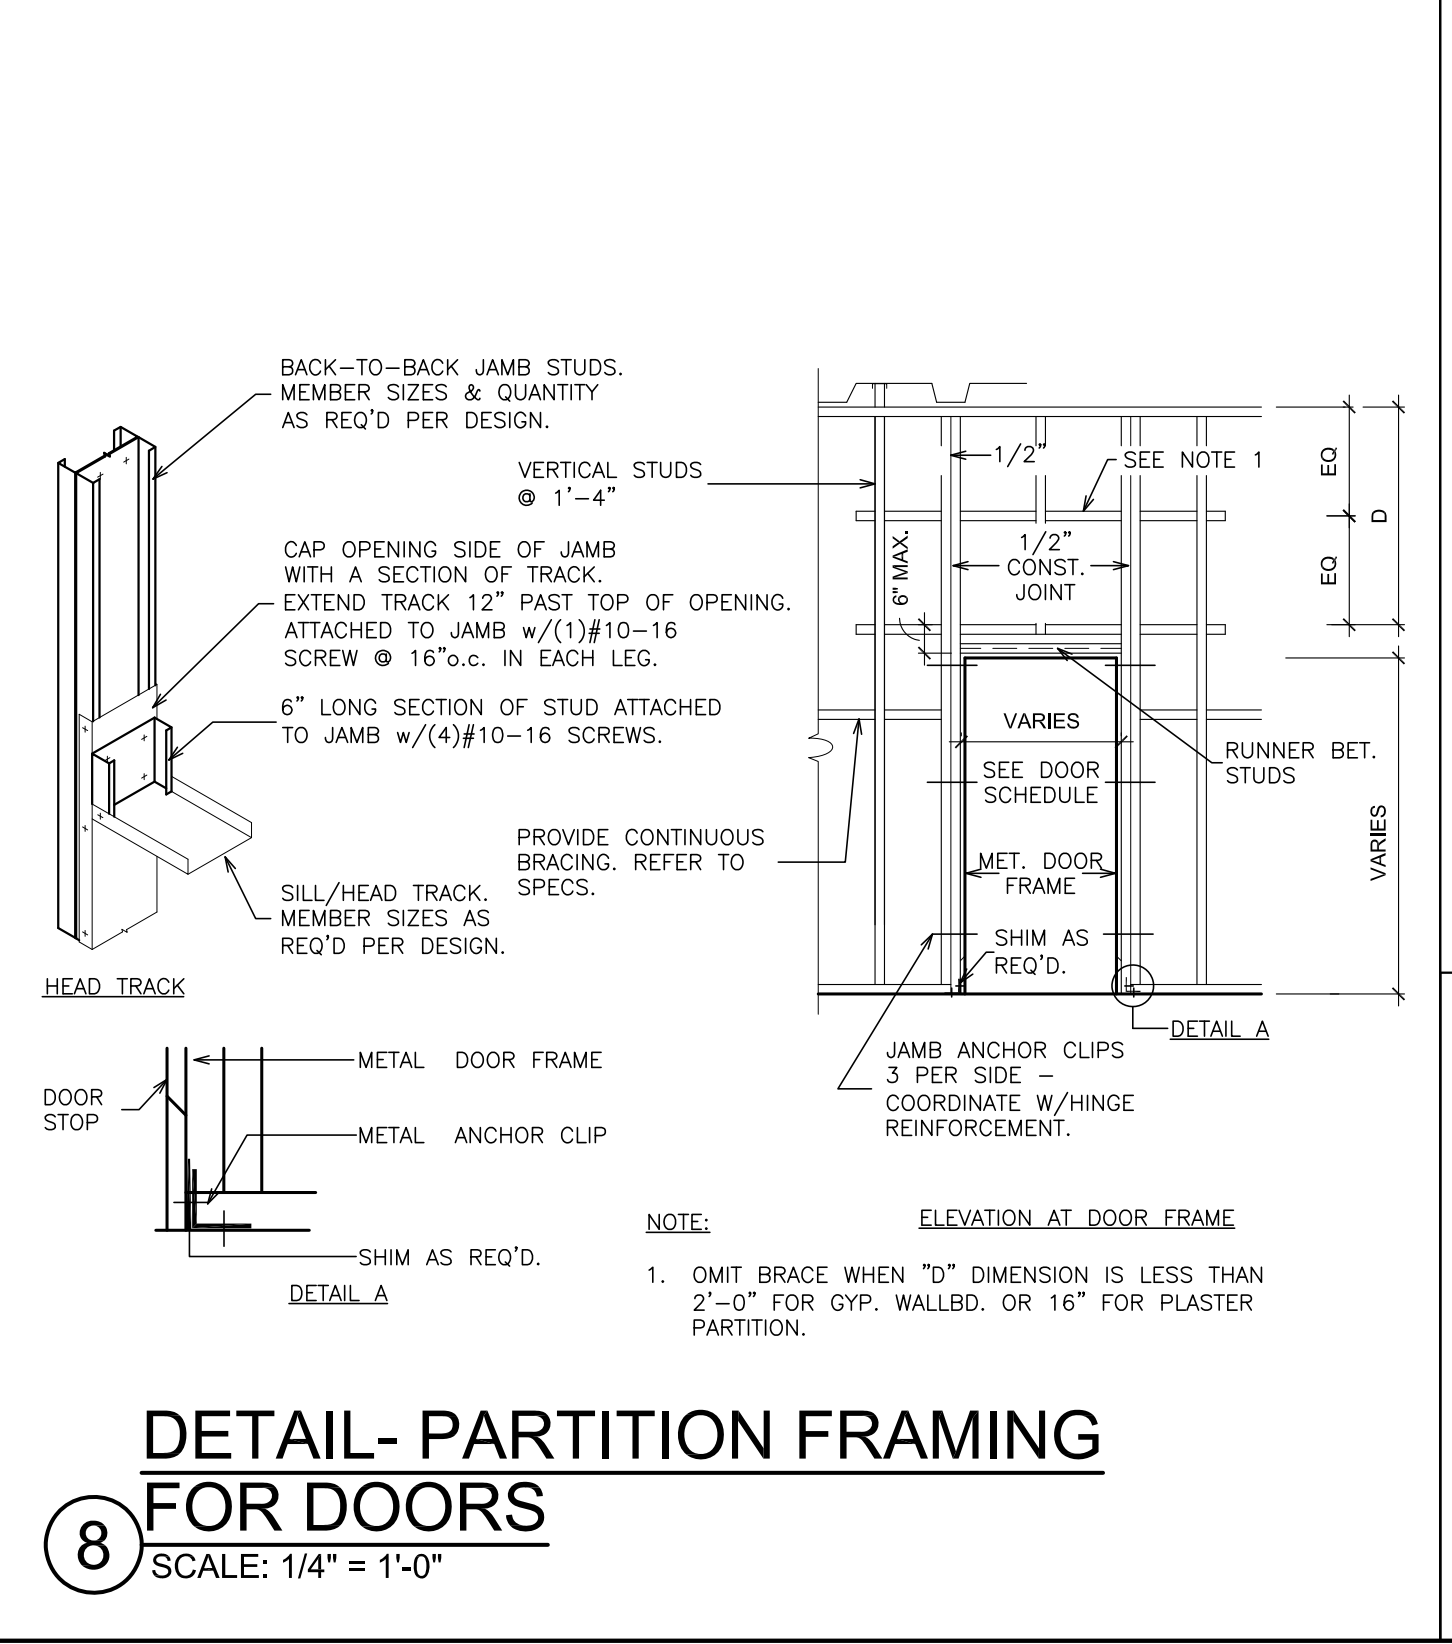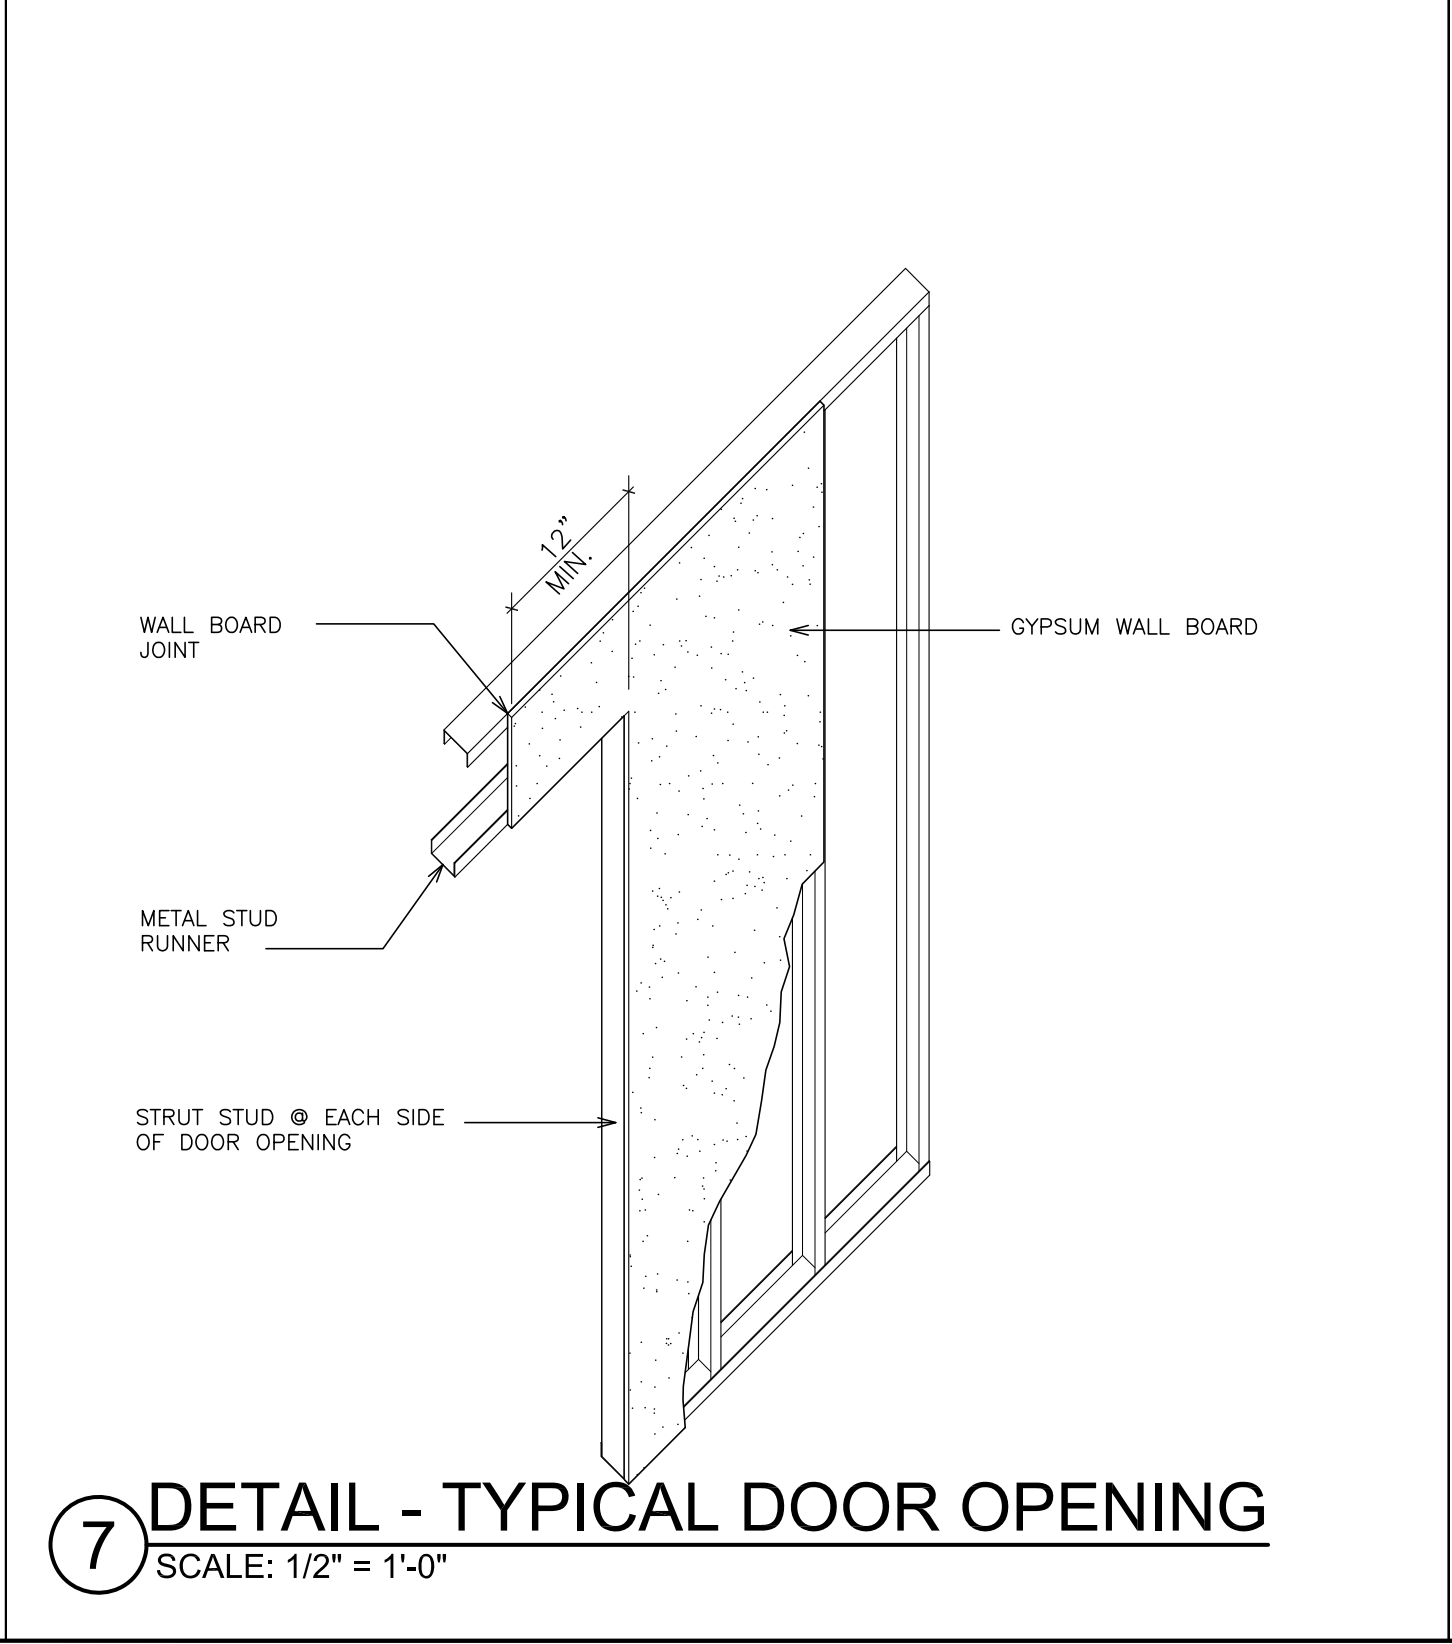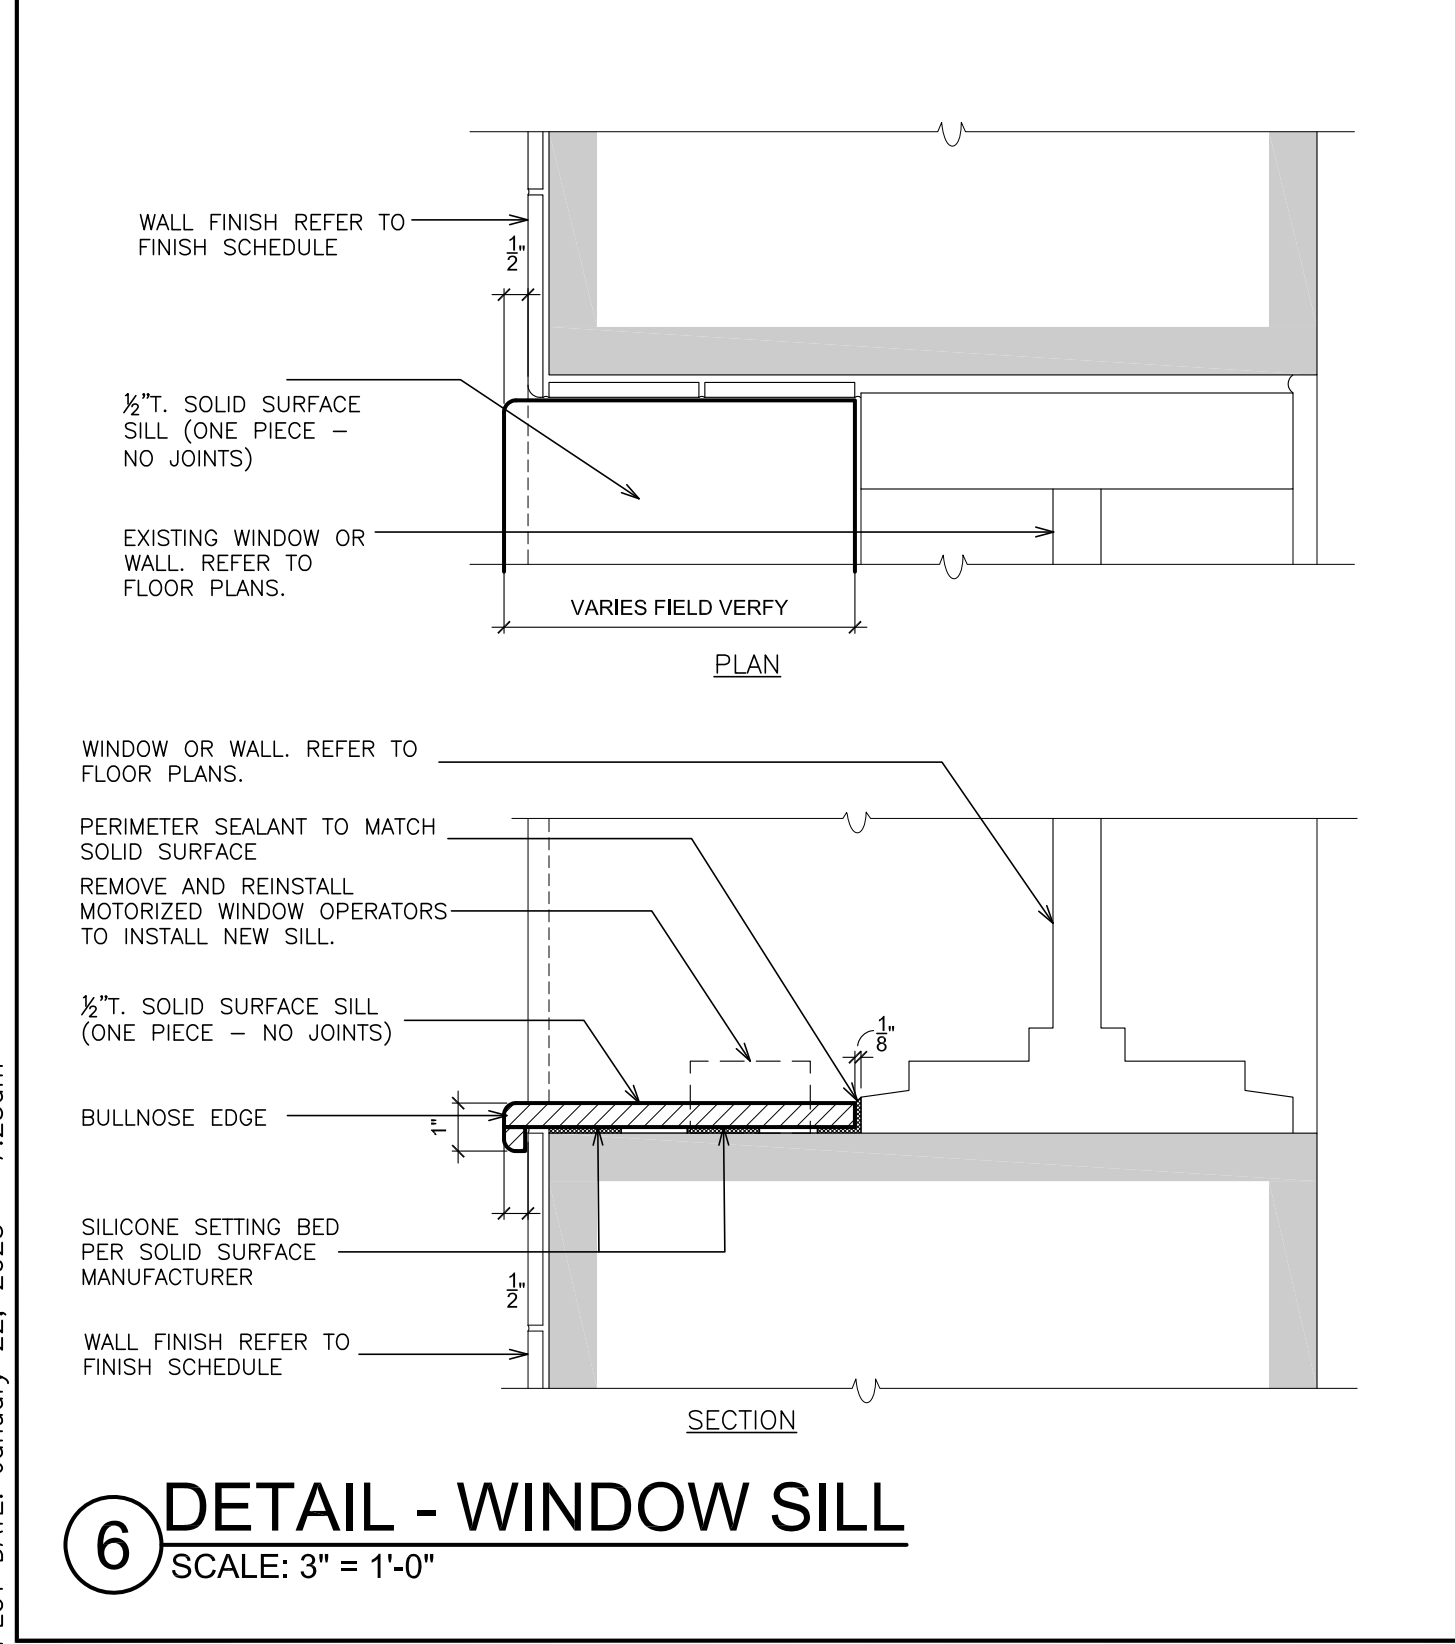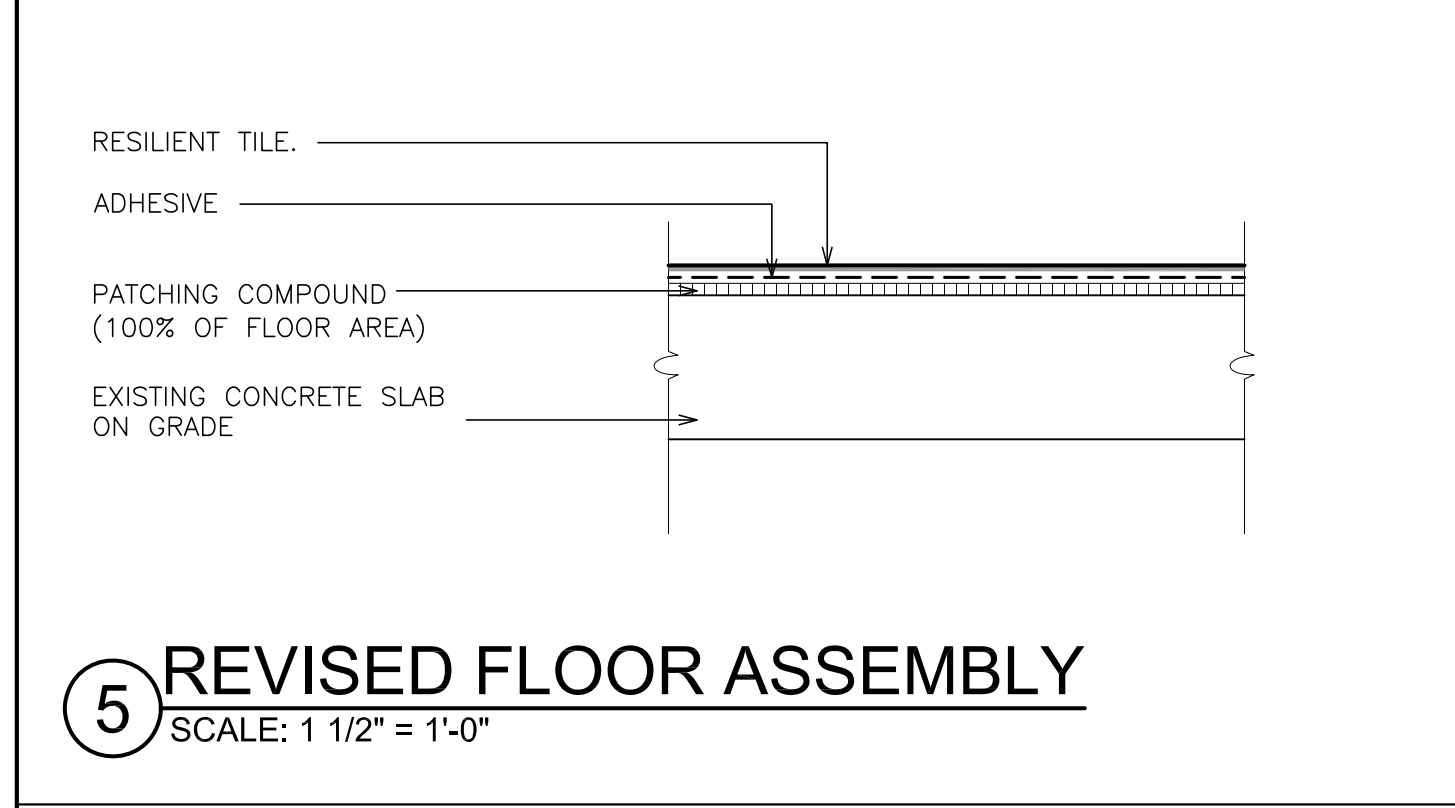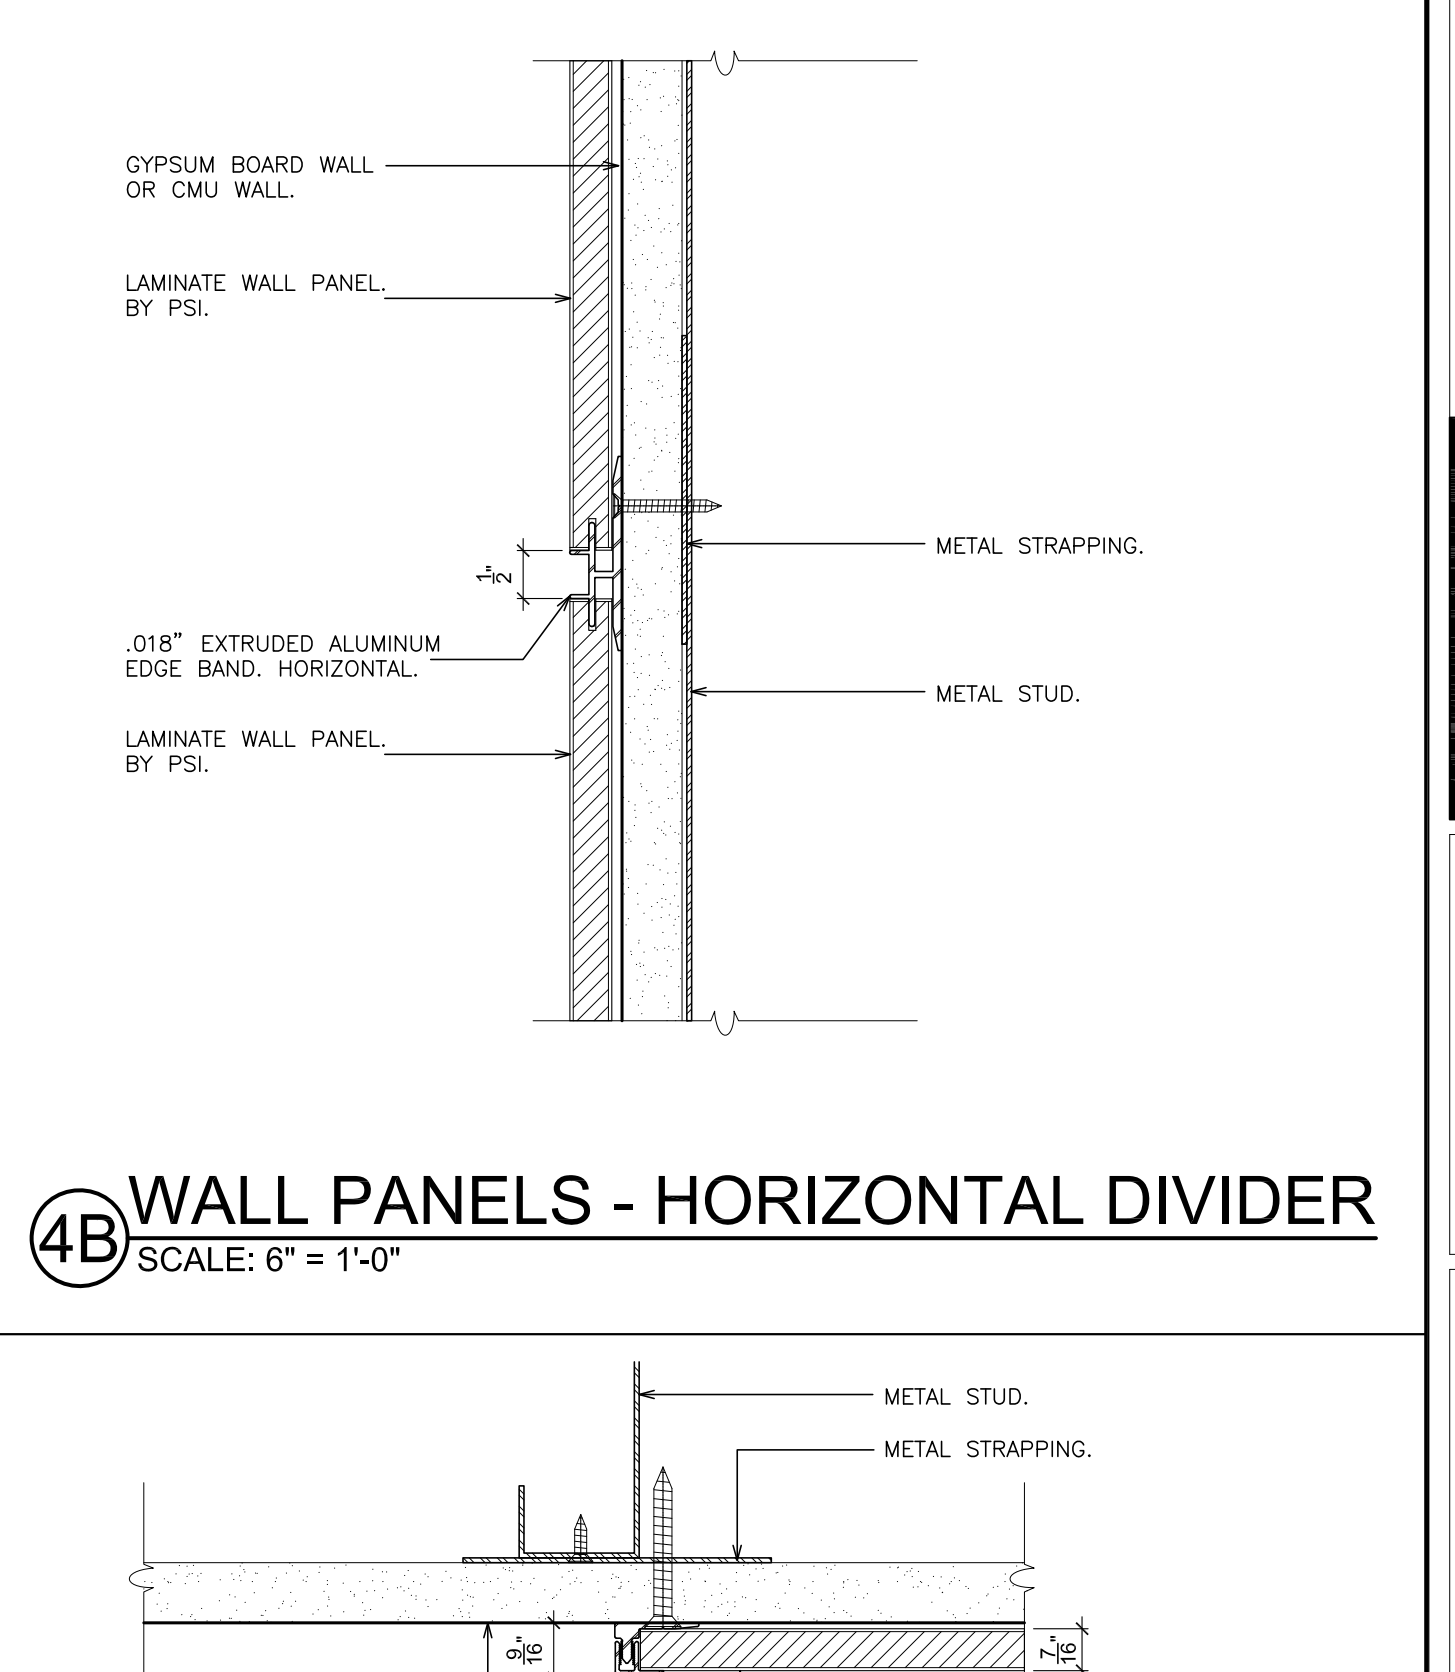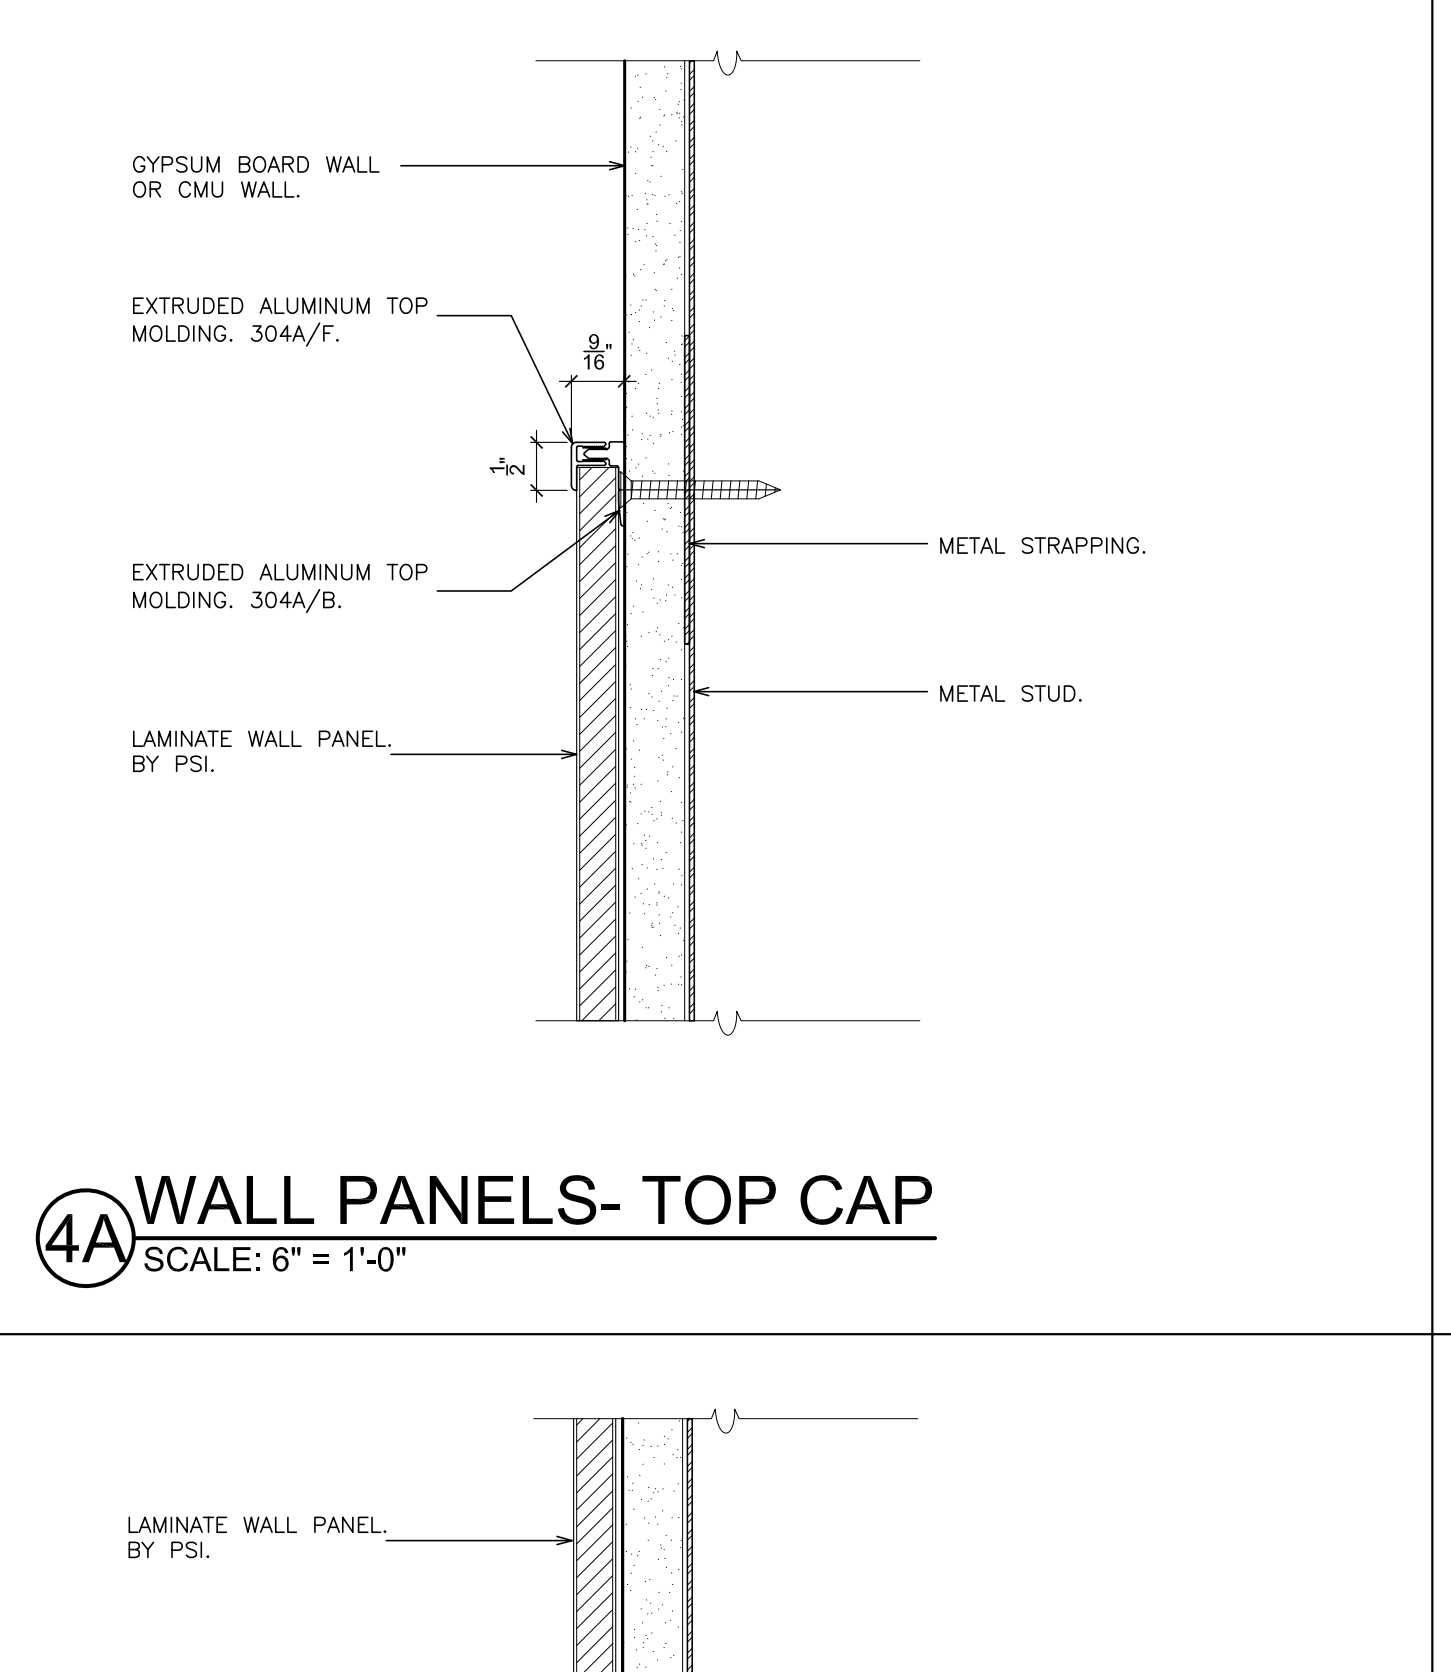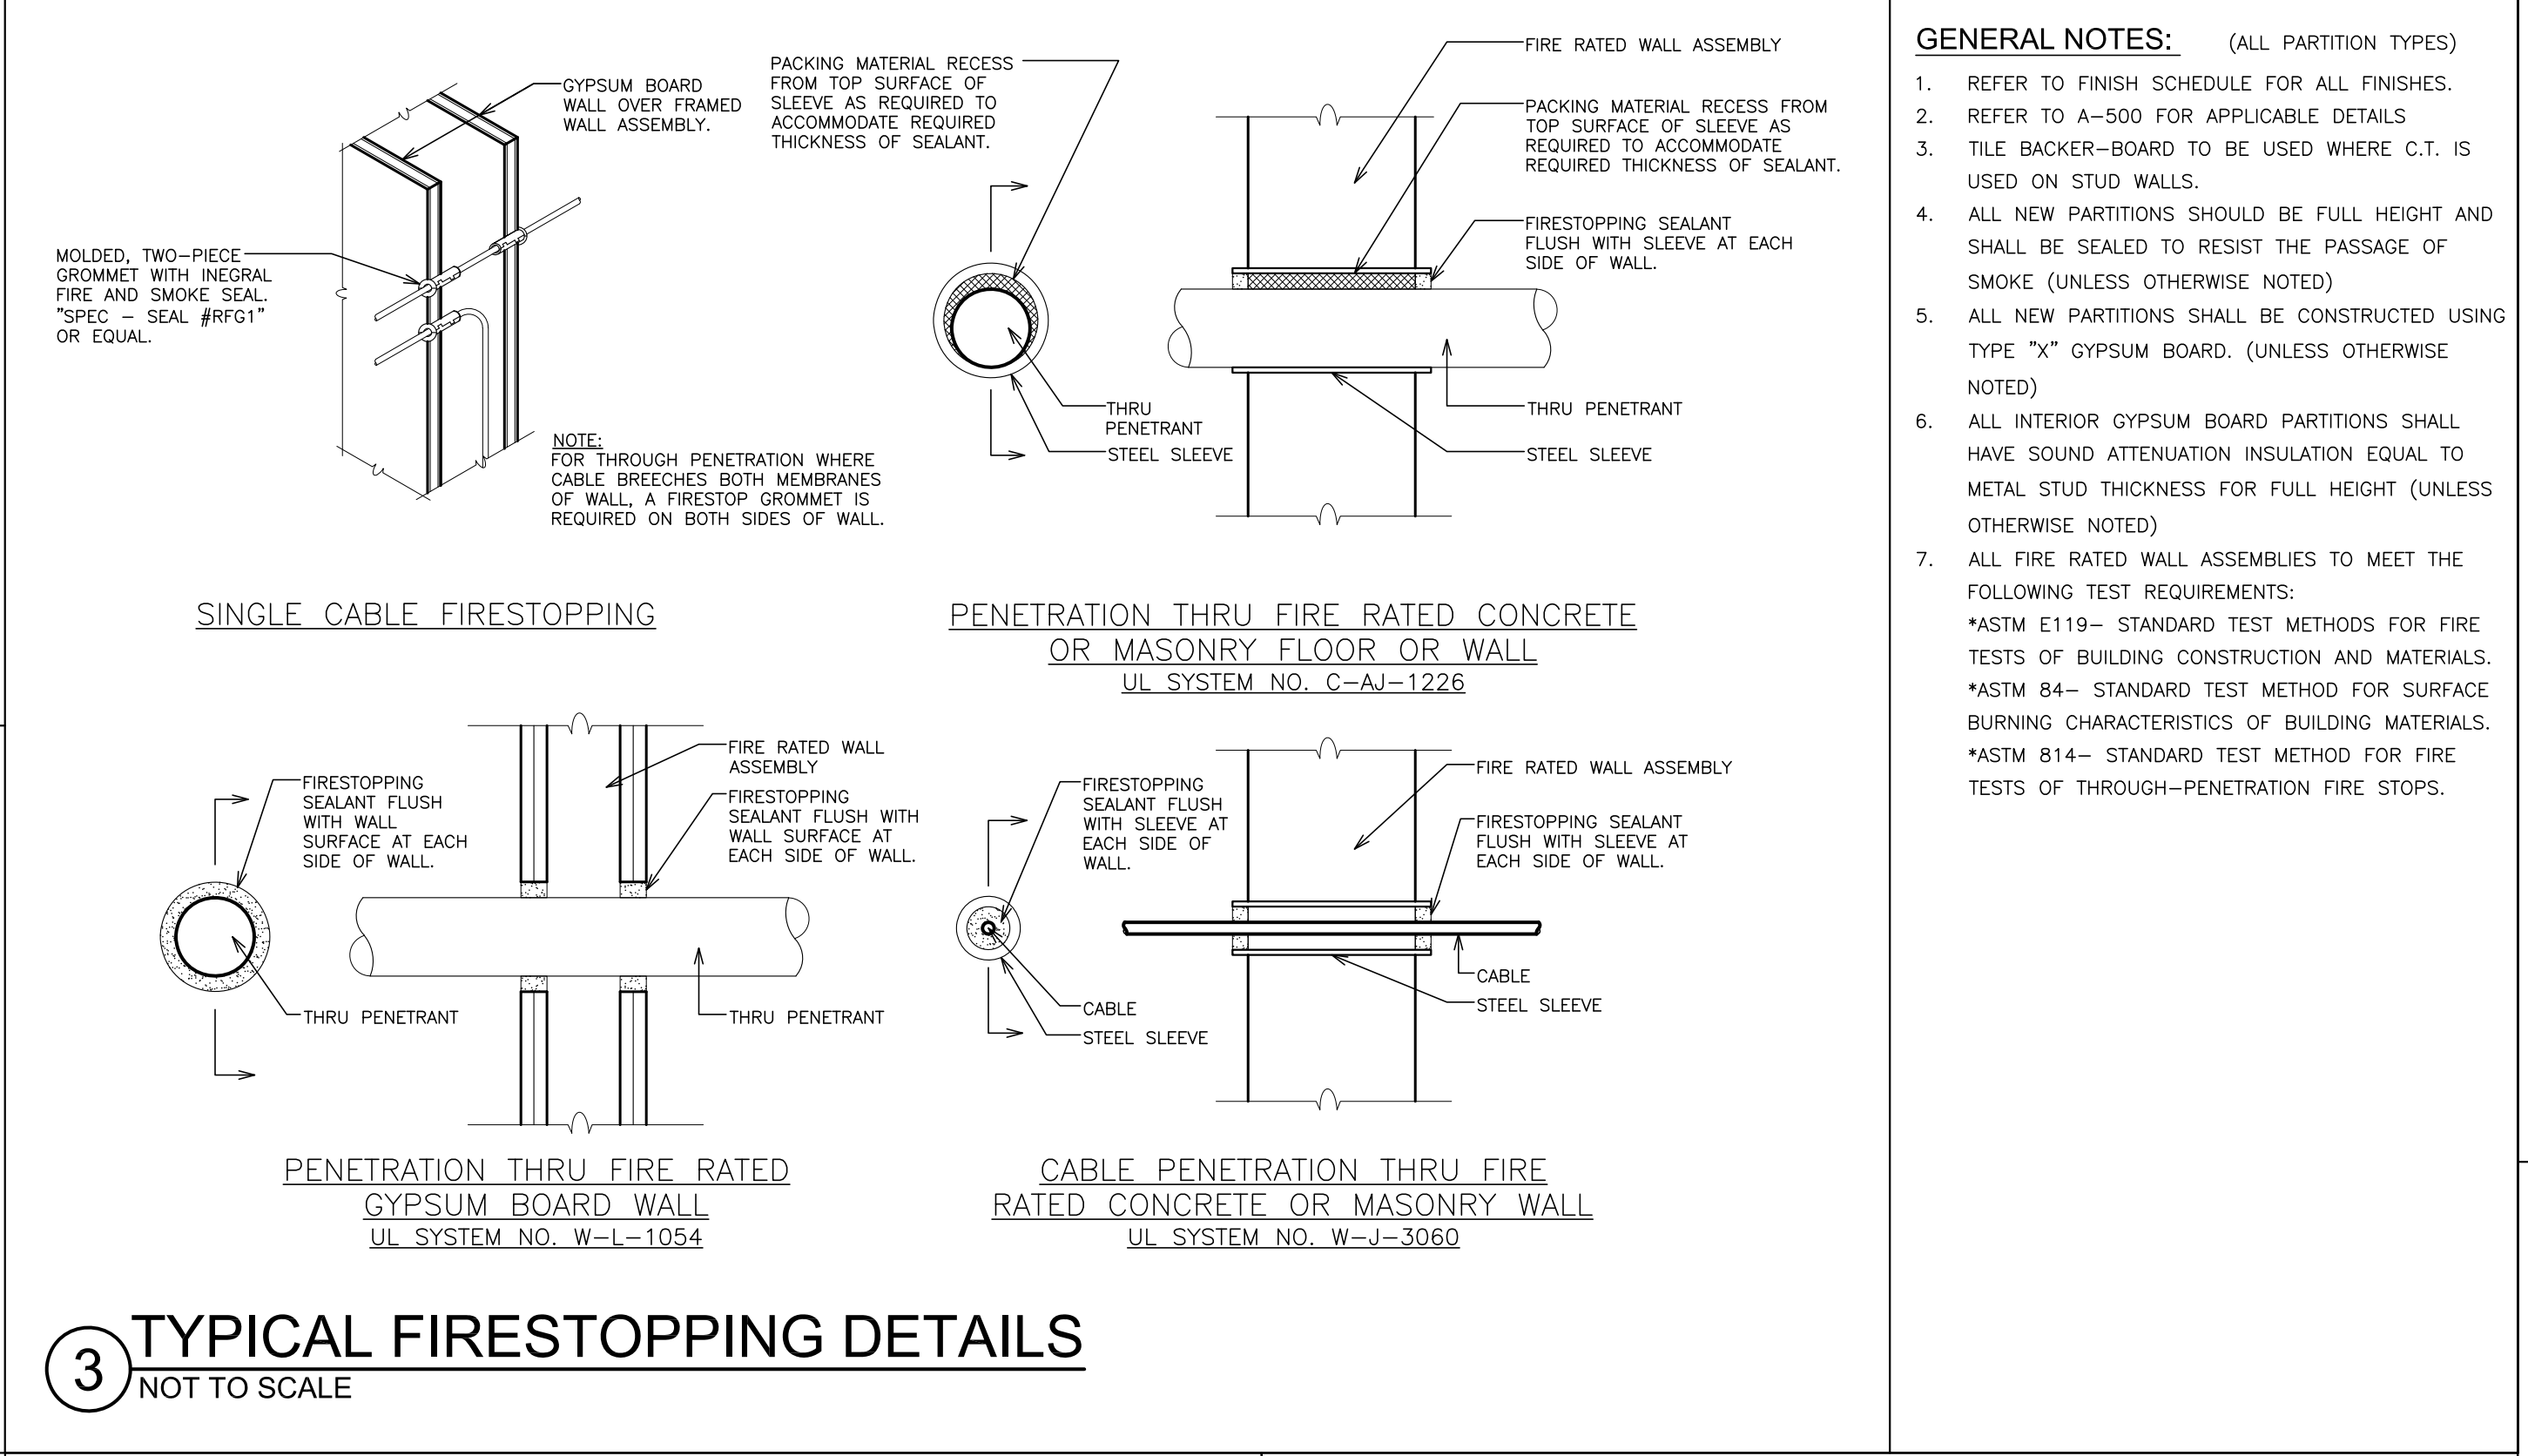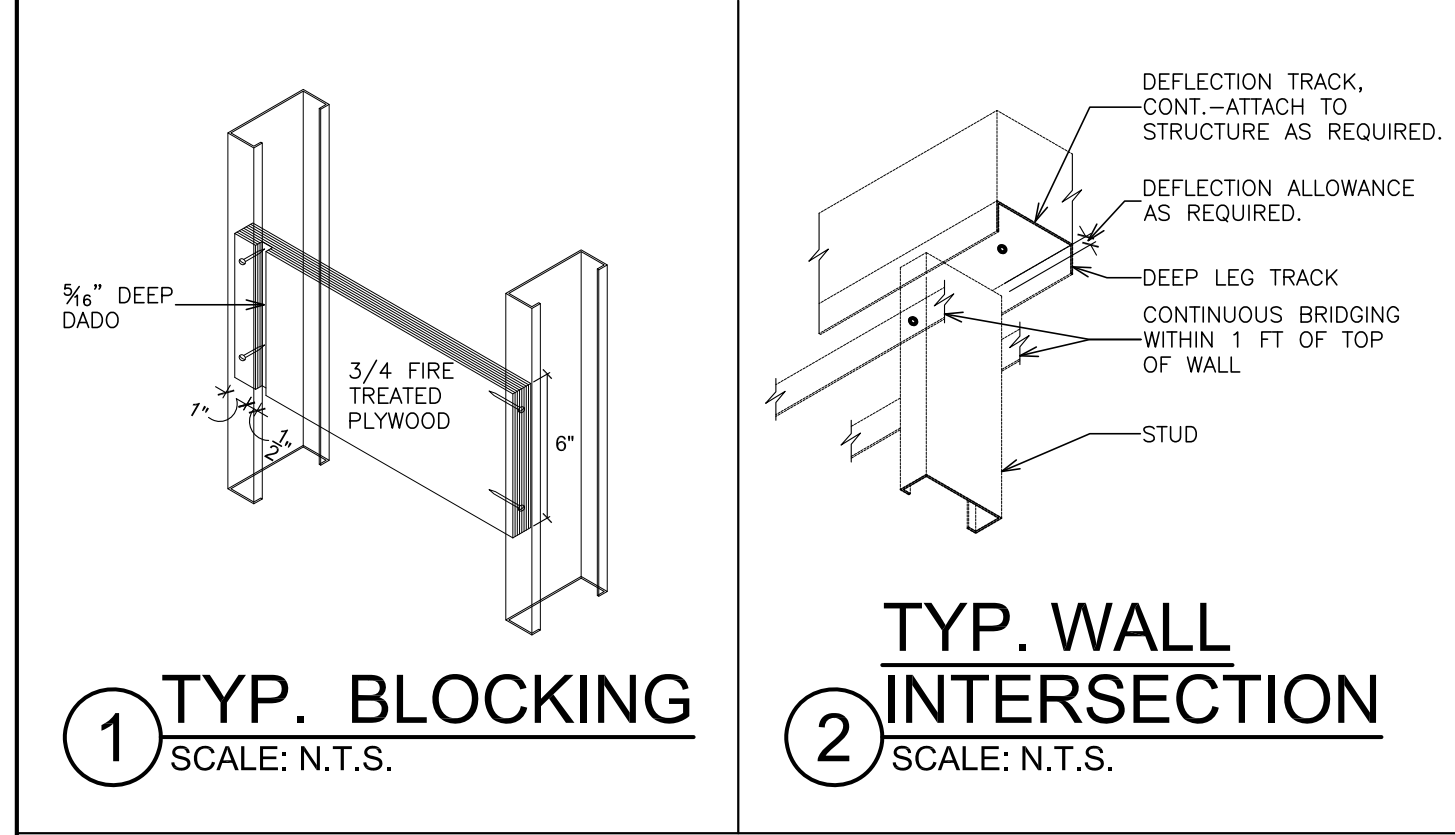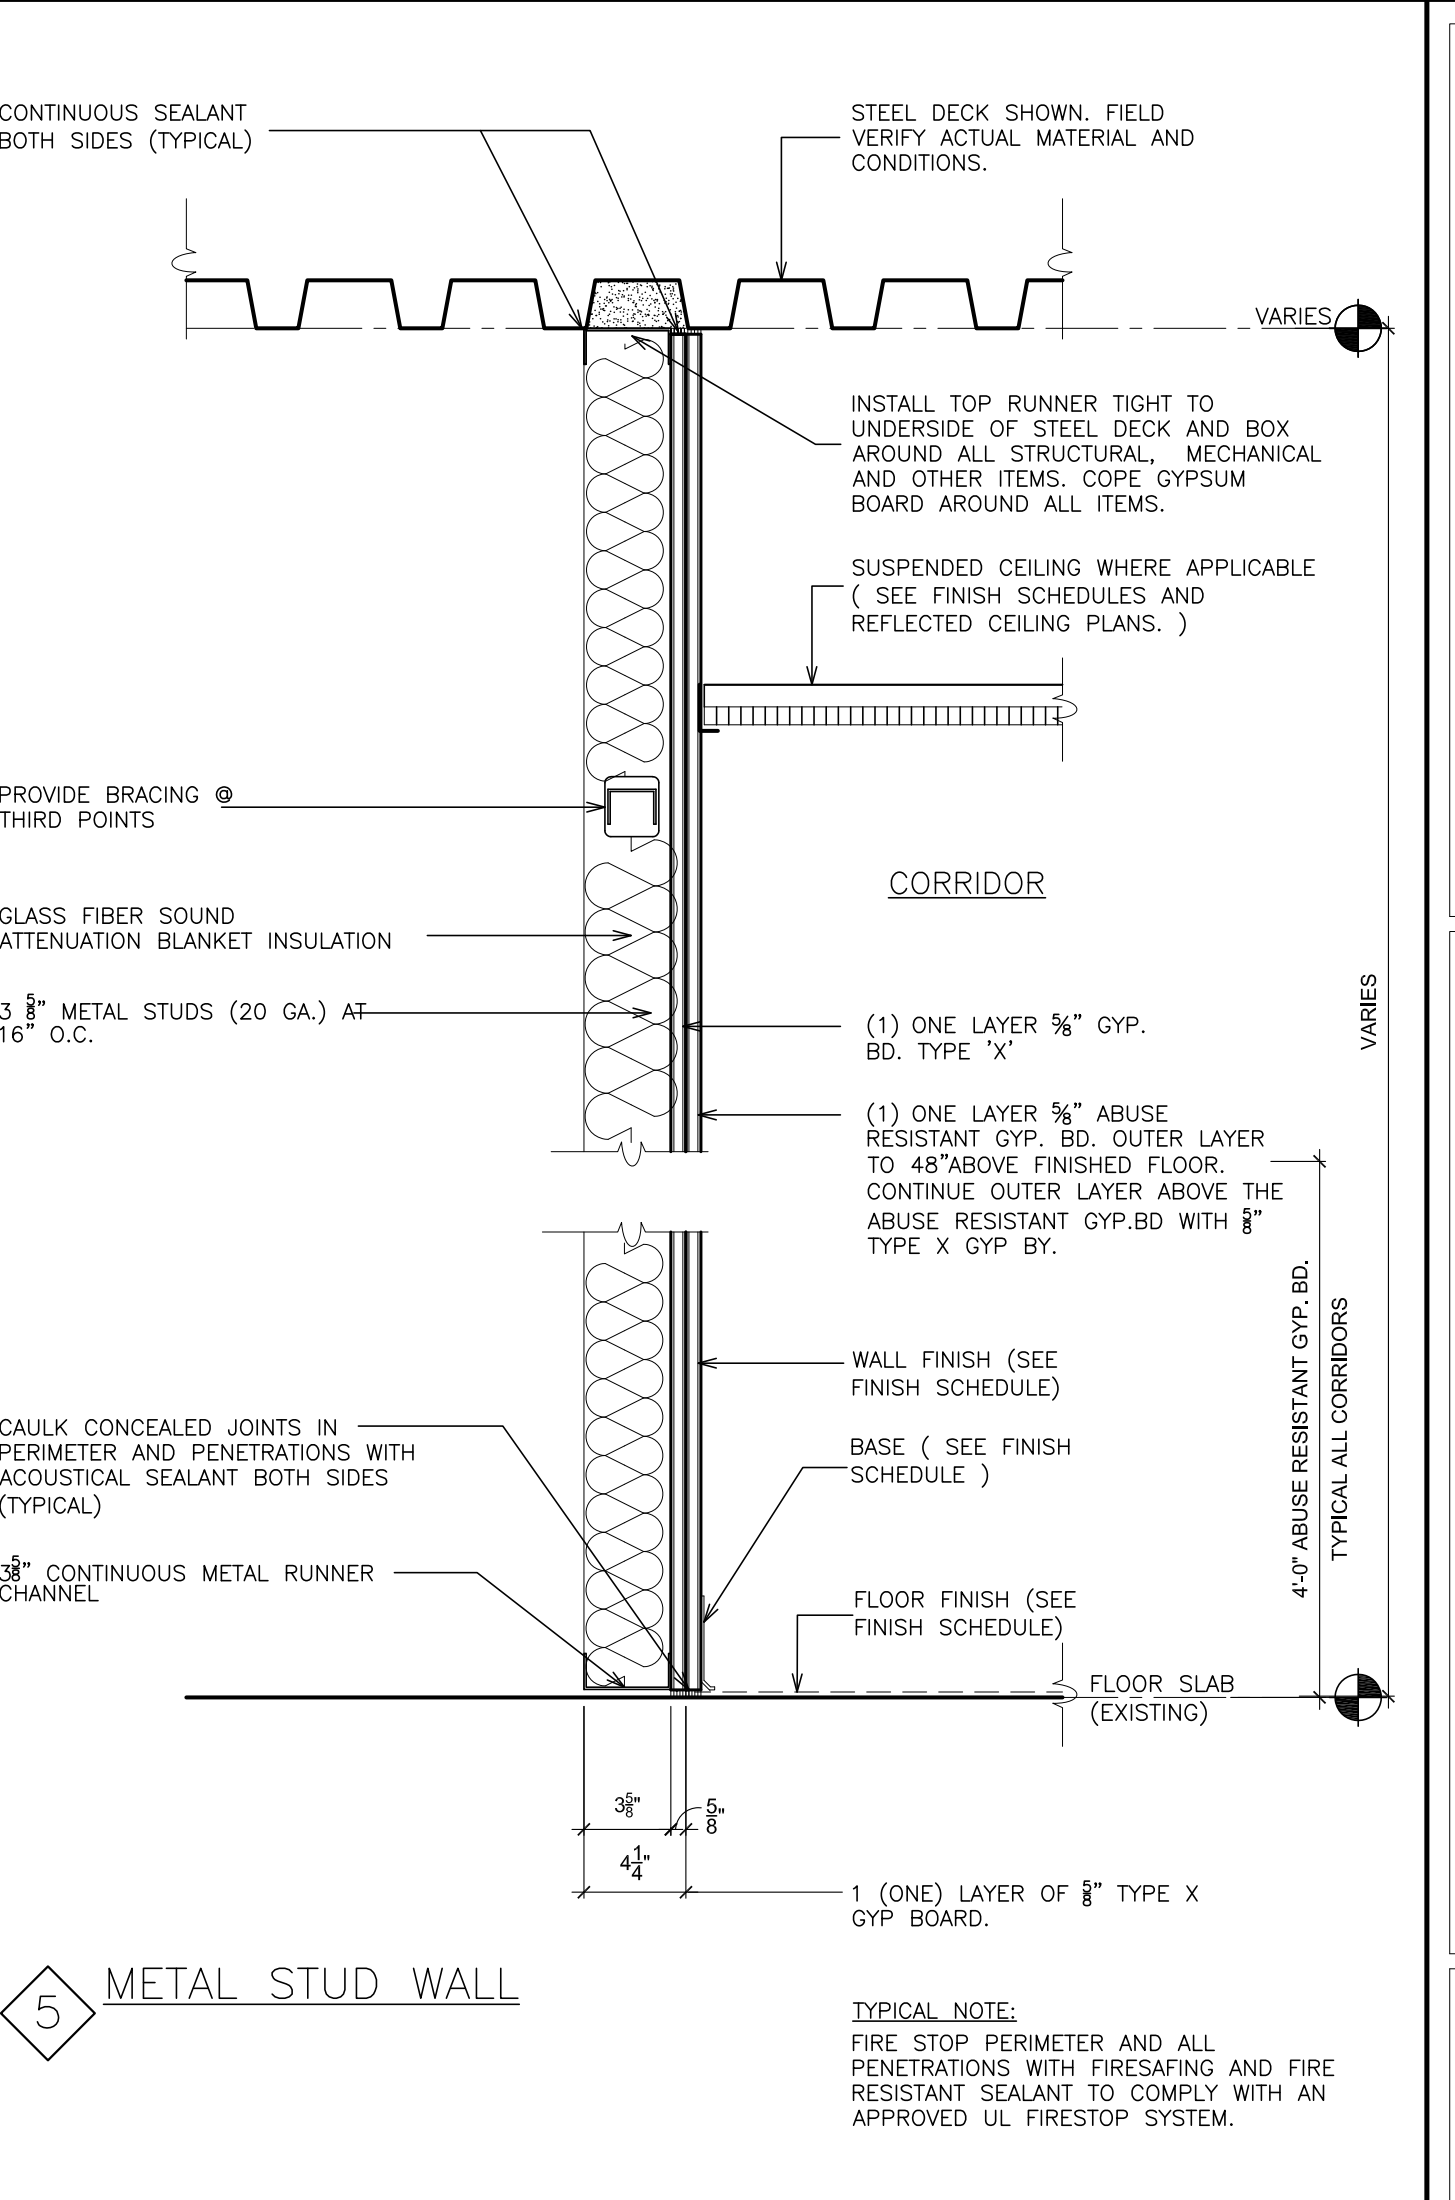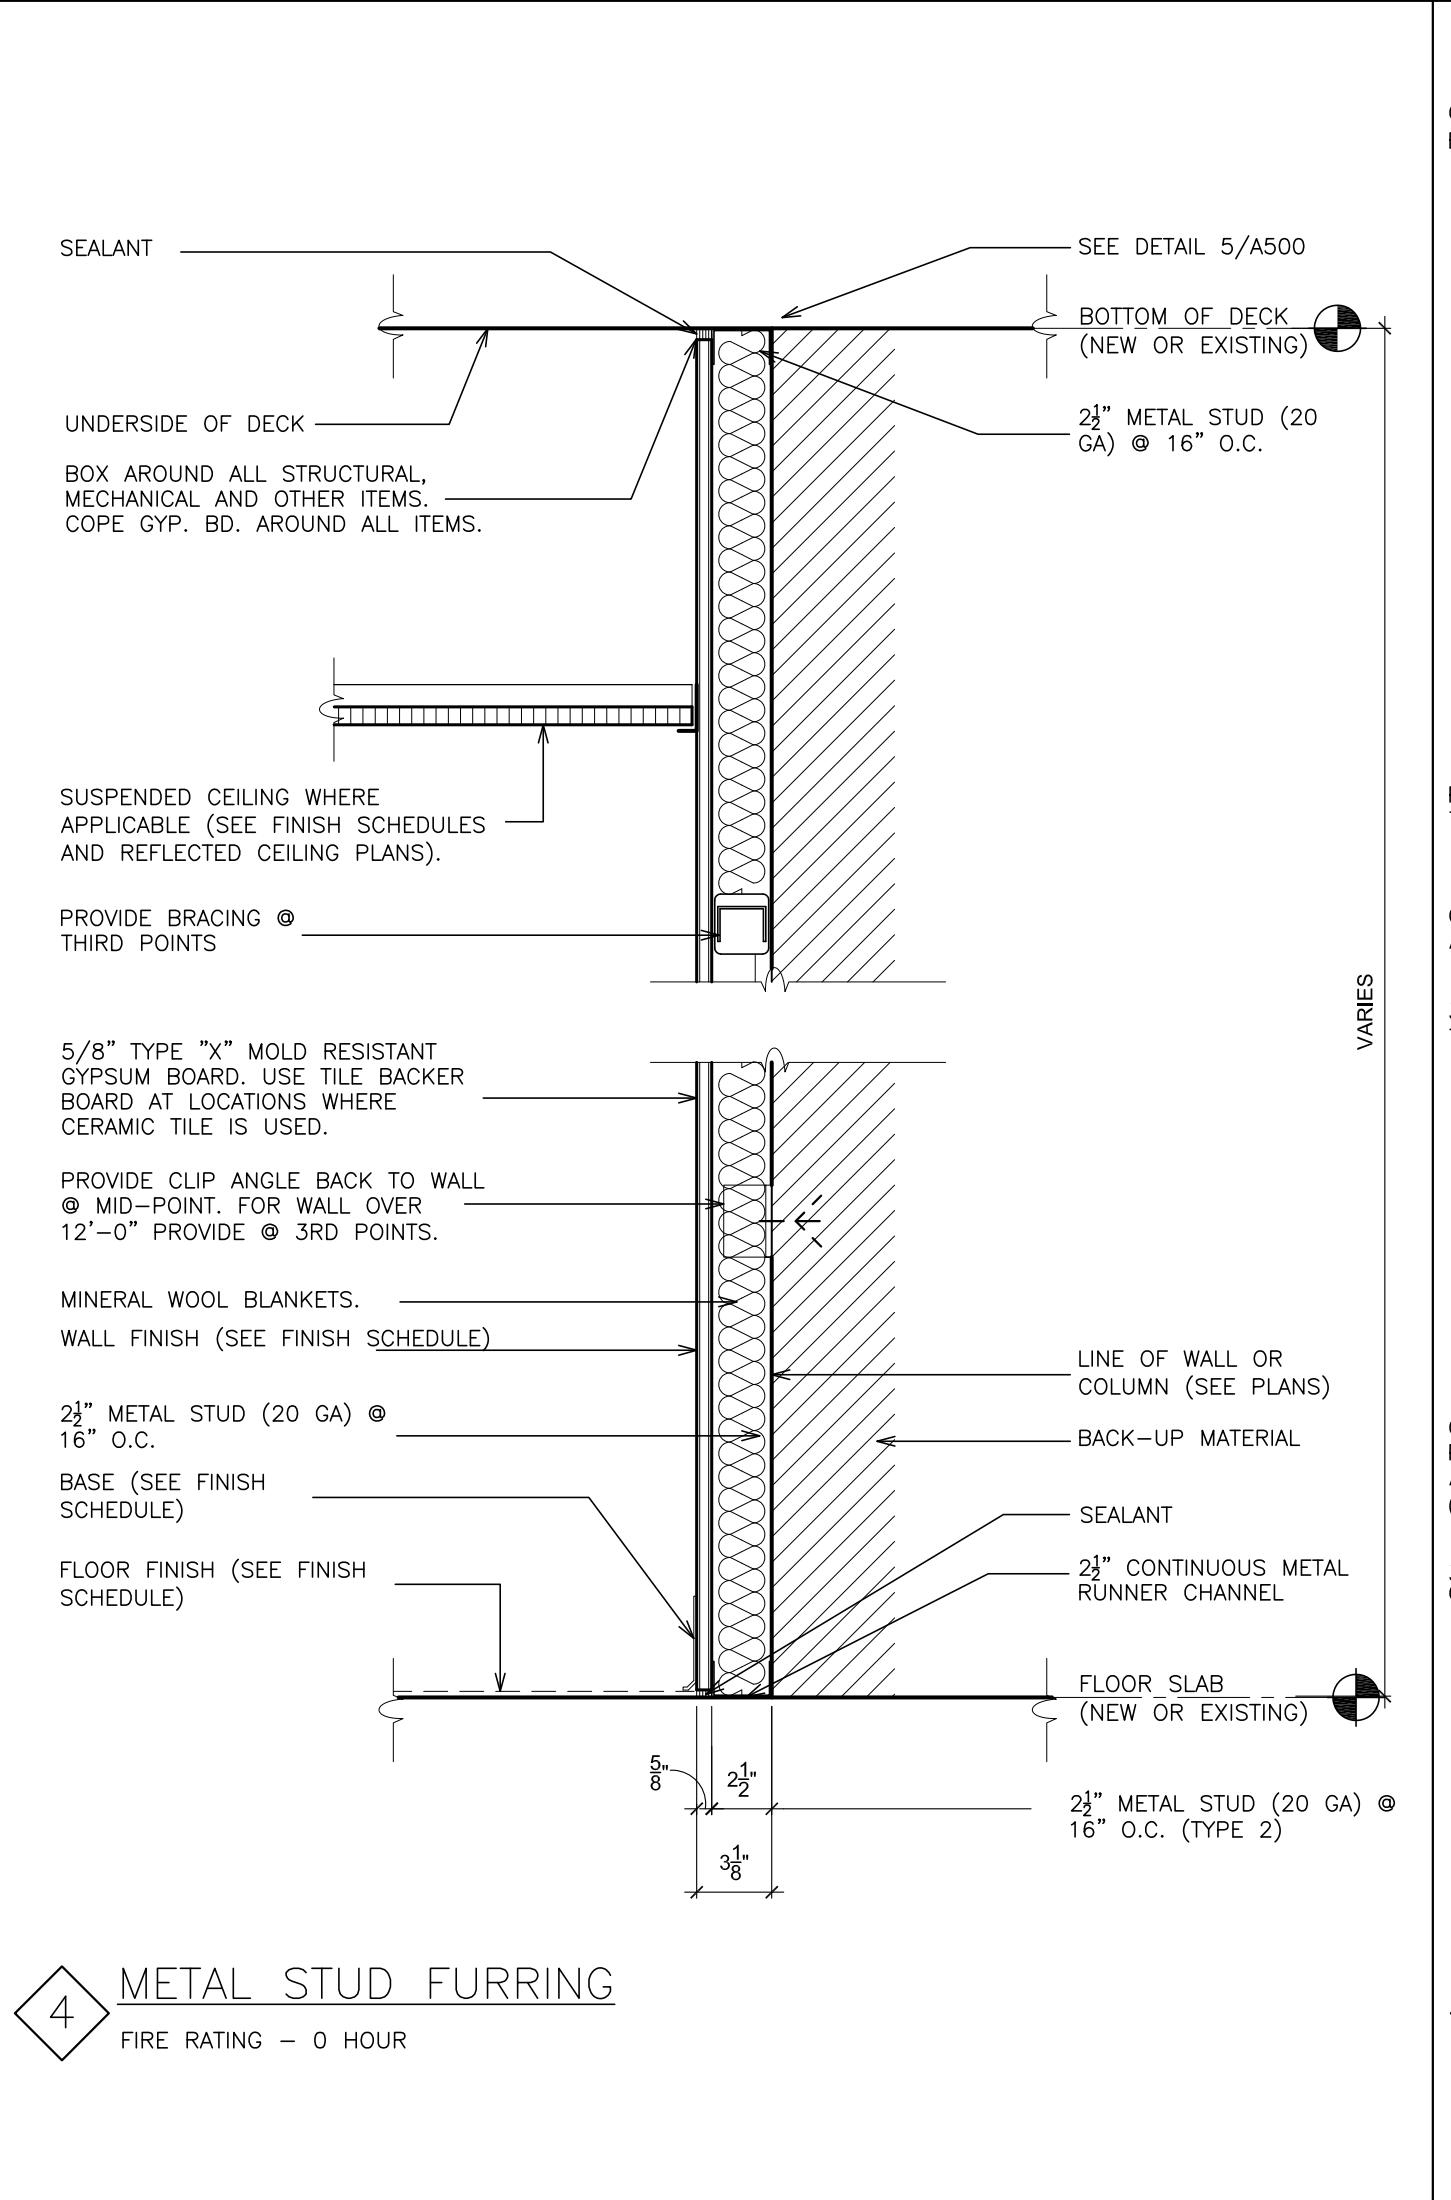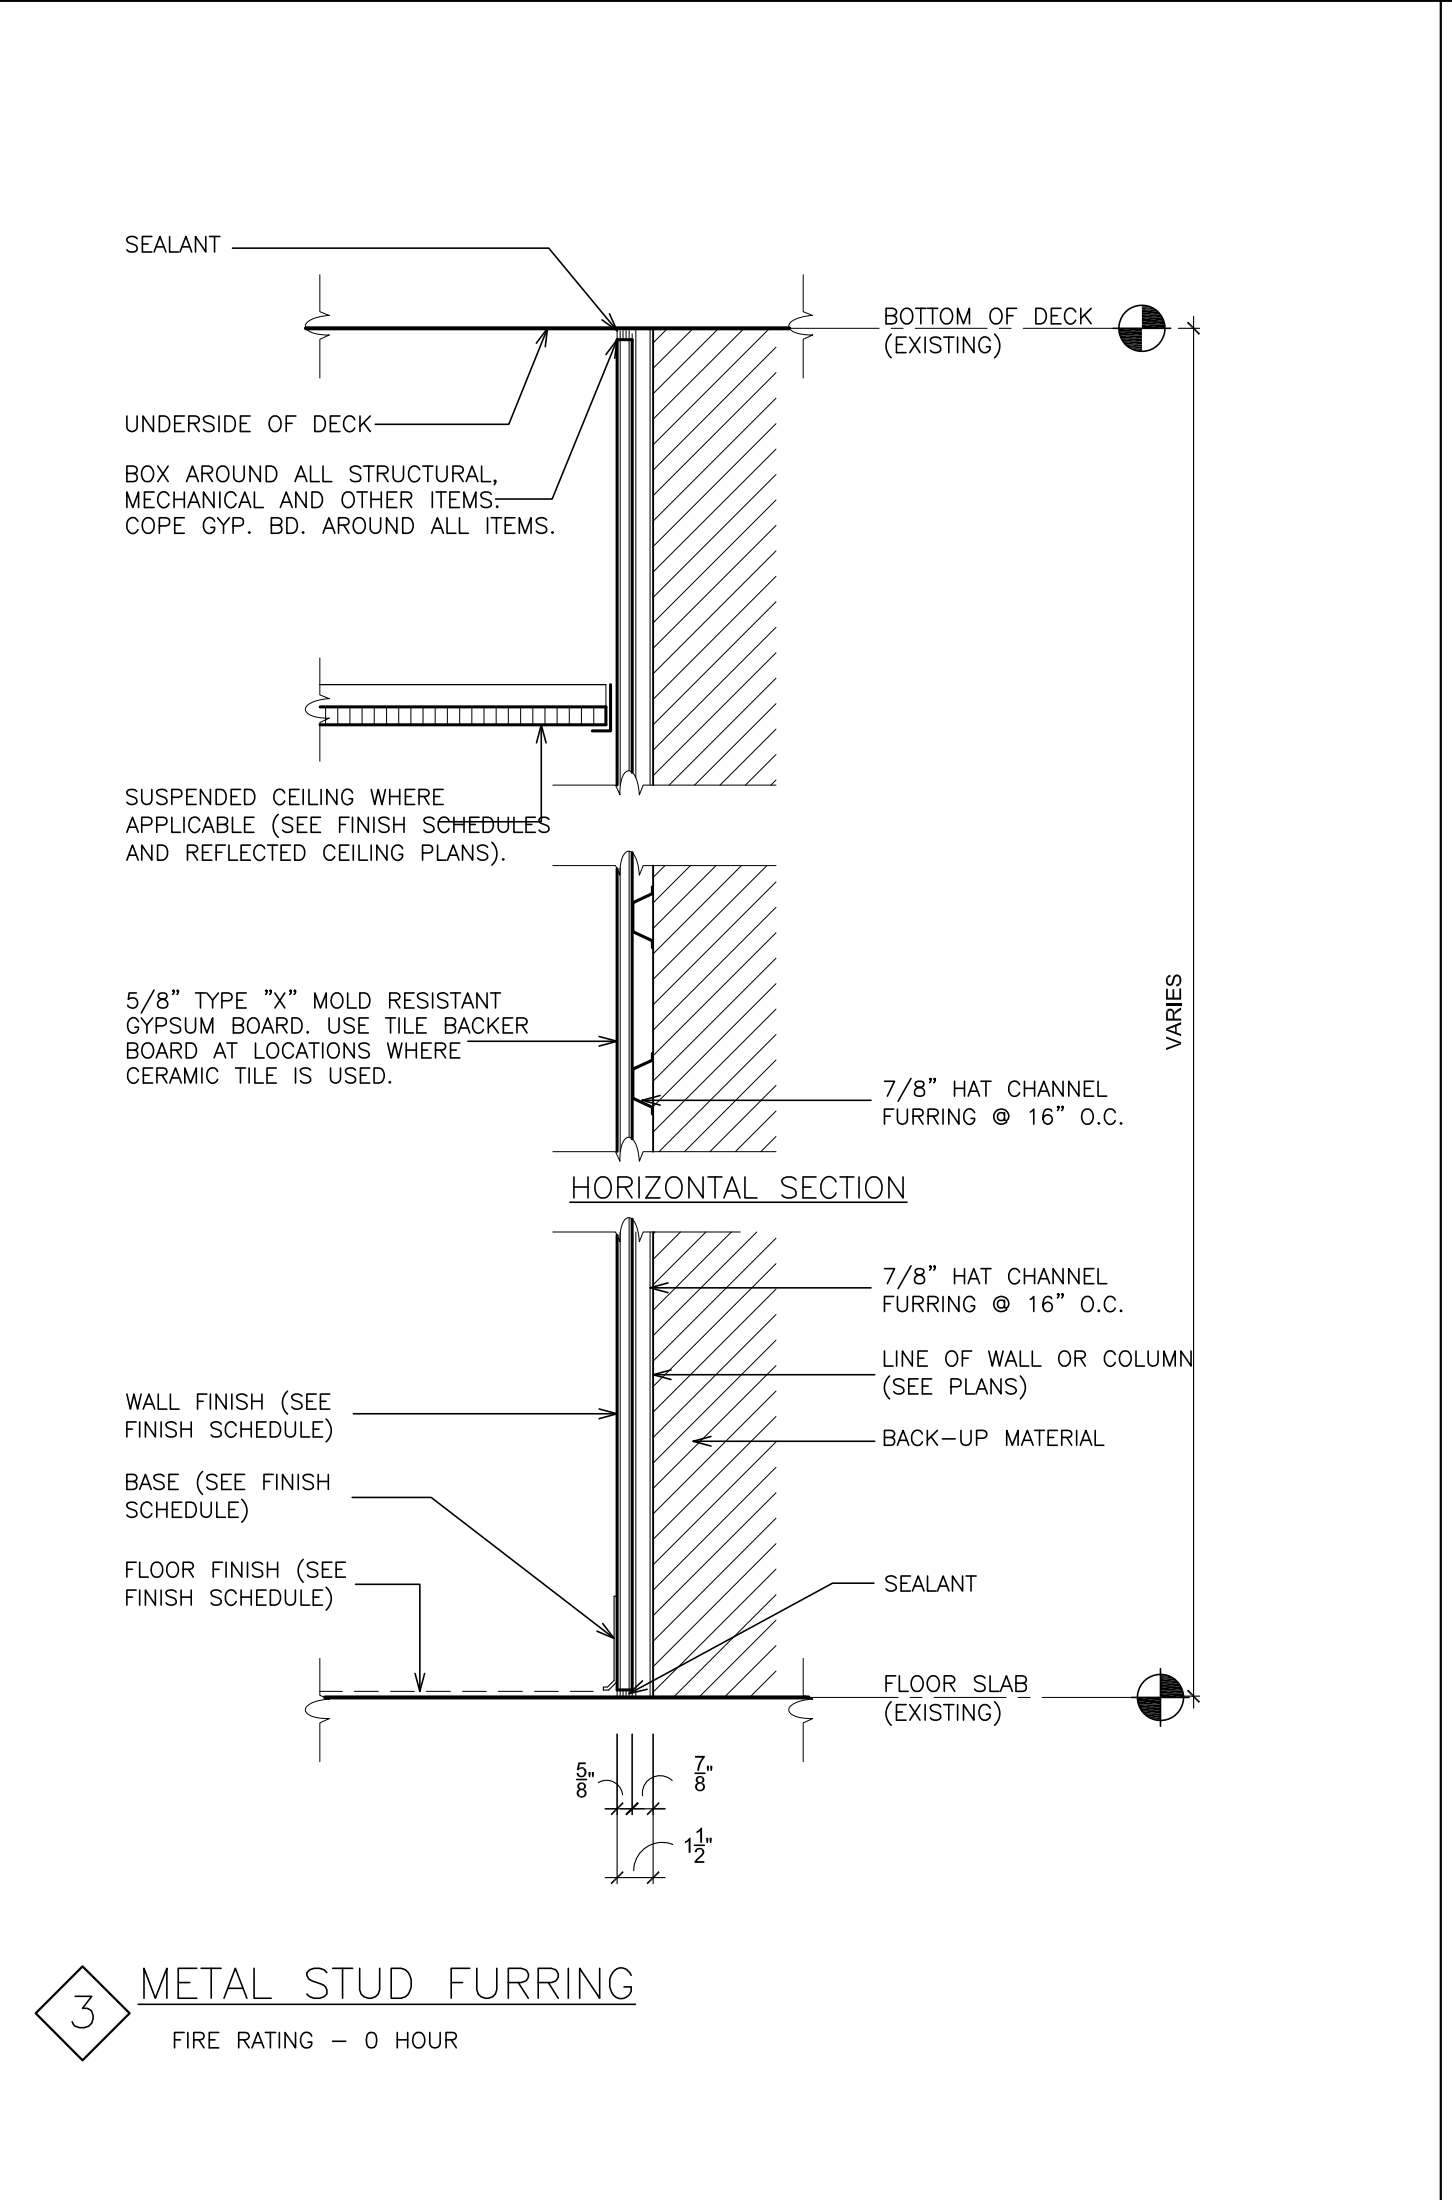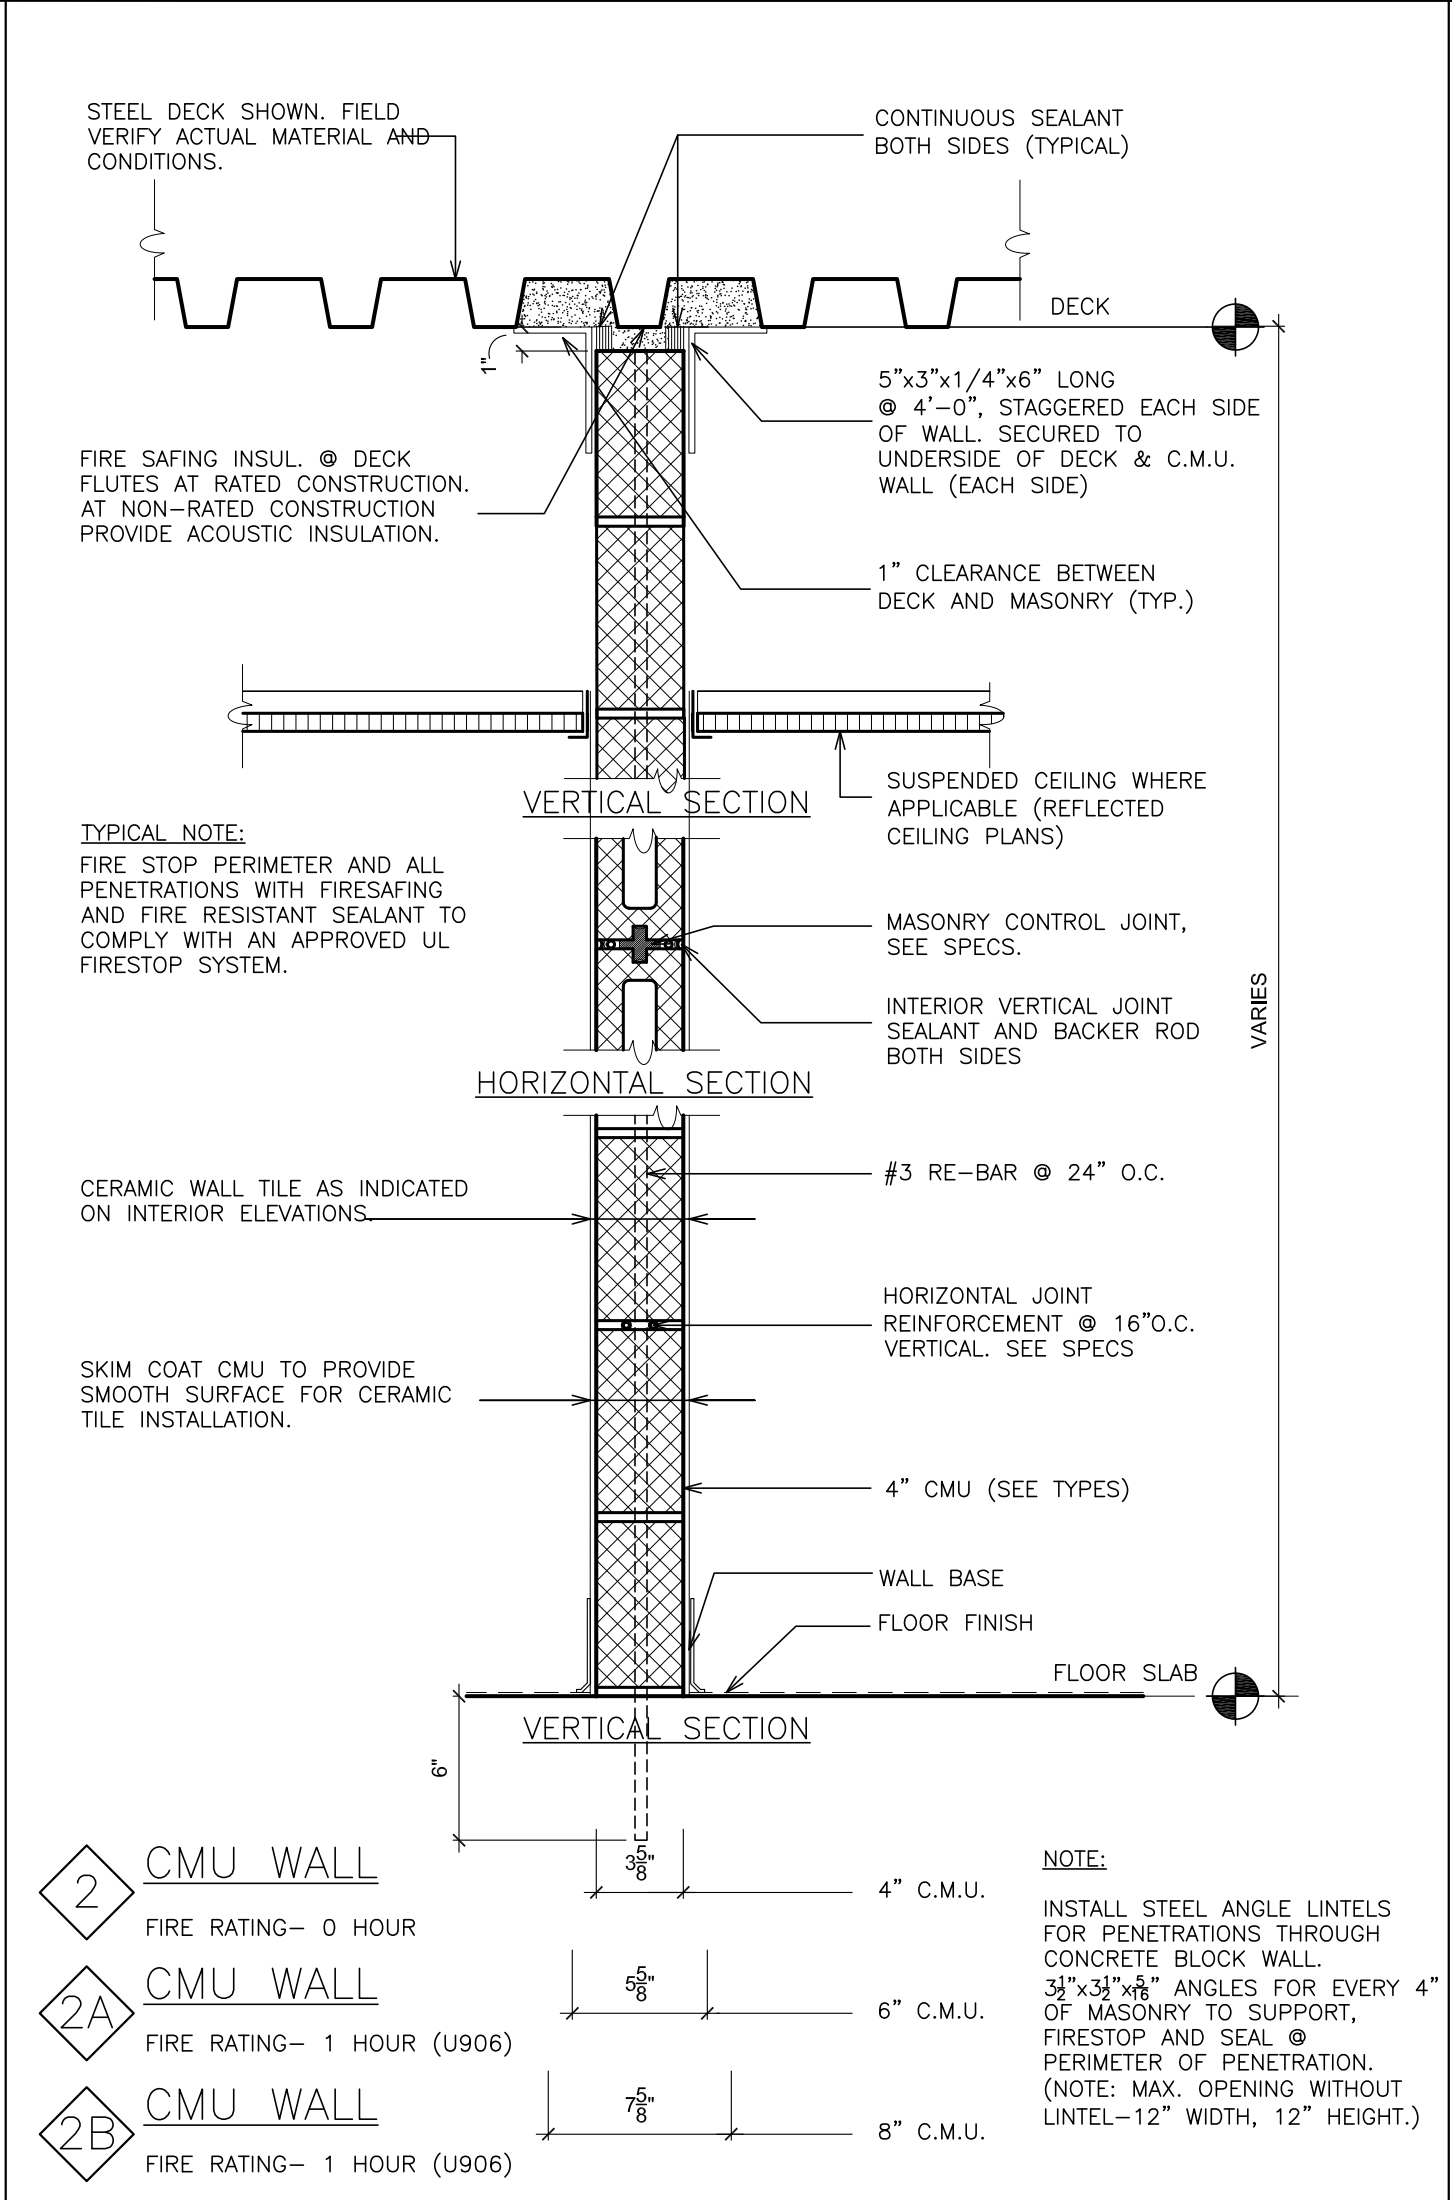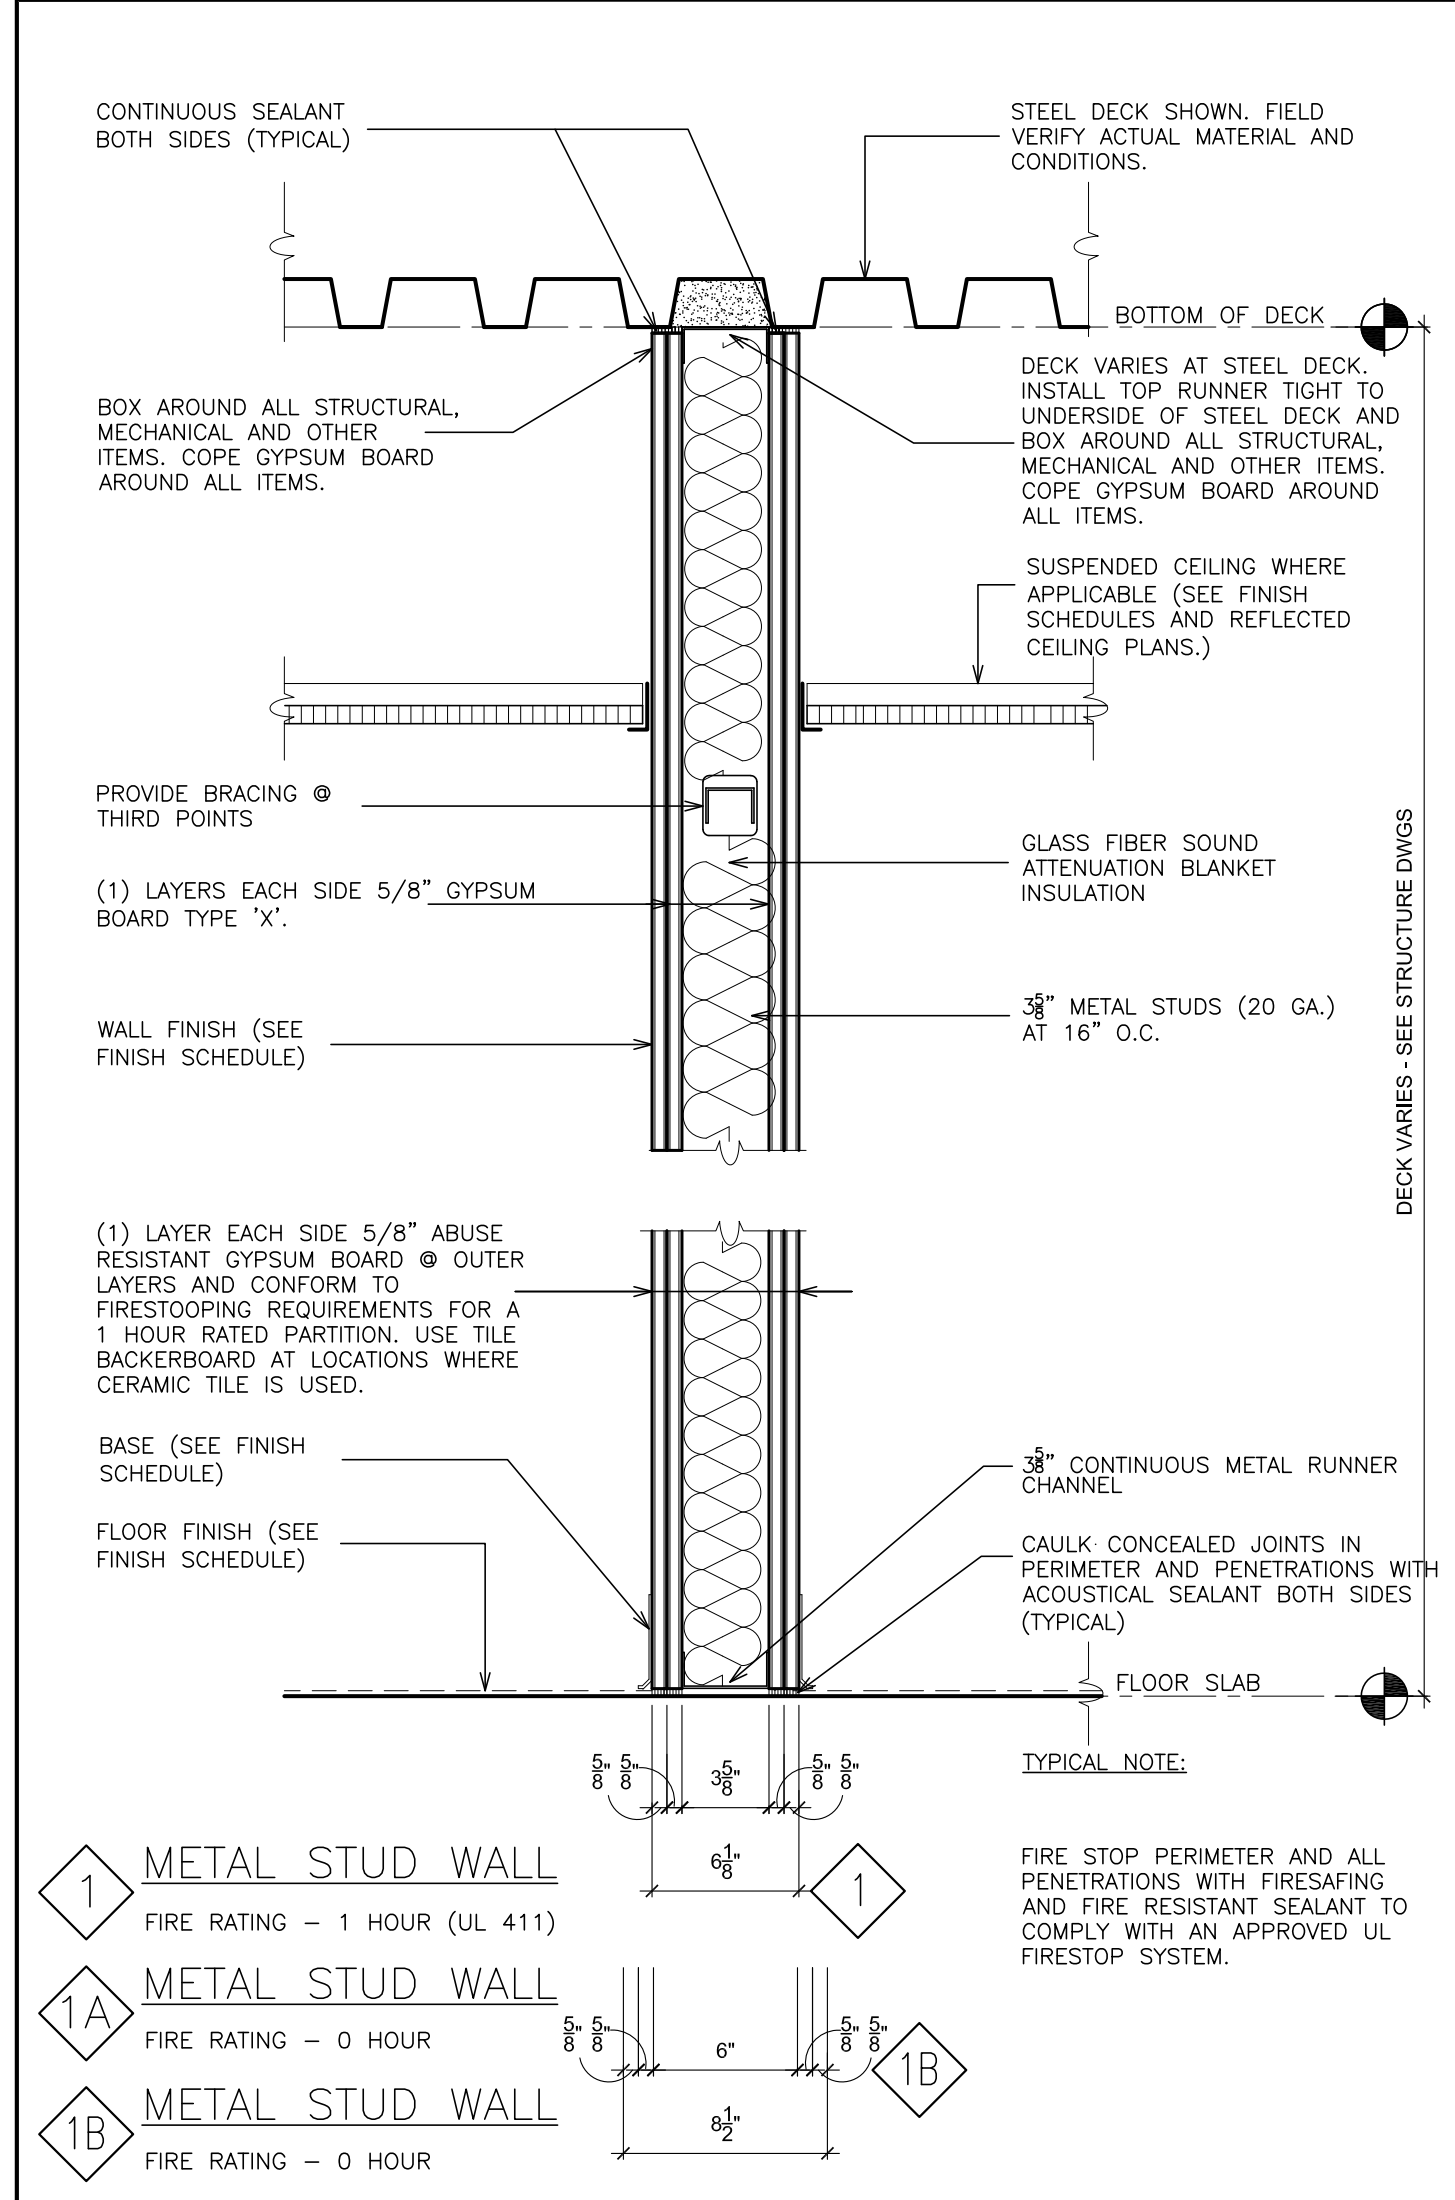

AS PER USA CONGRESS ARCHITECTURAL WORKS COPYRIGHT PROTECTION ACT OF 1990 ALL IDEAS AND DESIGNS INCLUDING DERIVATIVES THEREOF, ALL DRAWINGS AND SPECIFICATIONS CONSTITUTE THE ORIGINAL COPYRIGHT WORK BY FULLER AND DANIELO, P.C. (F&D). THE DRAWINGS AND SPECIFICATIONS AS INSTRUMENTS OF SERVICE BY F&D ARE CREATED BY F&D FOR THIS PROJECT ONLY AND REMAIN THE PROPERTY OF F&D. ANY REPRODUCTION WITHOUT THE PRIOR CONSENT OF F&D IS PROHIBITED.

48 KENWOOD ROAD ELMSFORD NEW YORK 10523
TEL 914.899.4444 FAX 914.899.1917
Copyright 2022 All Rights Reserved By FULLER & DANIELO, P.C.

FULLER & DANIELO P.C.
ARCHITECTS & PLANNERS


LICENSE EXP. DATE: 02-28-2027

S.E.D. CONTROL NUMBER:
GREENVILLE ELEMENTARY SCHOOL
66-04-06-03-0-008-021


PROJECT TITLE:
GREENVILLE ELEMENTARY SCHOOL
CAFETERIA RENOVATION

DRAWING TITLE:
PARTITION TYPE & MISCELLANEOUS DETAILS

01-31-2025	BID
01-19-2022	SED SUBMISSION
DATE	ISSUED TO
SHEET SIZE 30"x42"	DRAWING NO. A500
SCALE AS NOTED	FILE NO. 24529.01
DRAWN BY F & D	

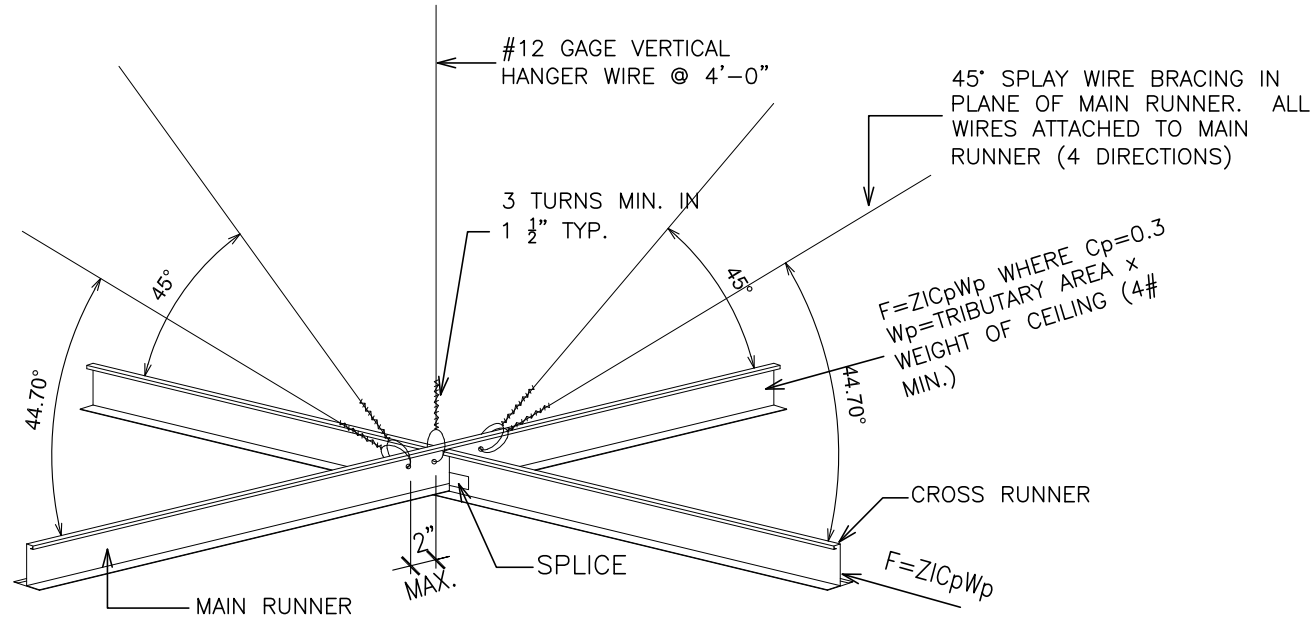


TYPICAL CEILING BRACING DETAIL

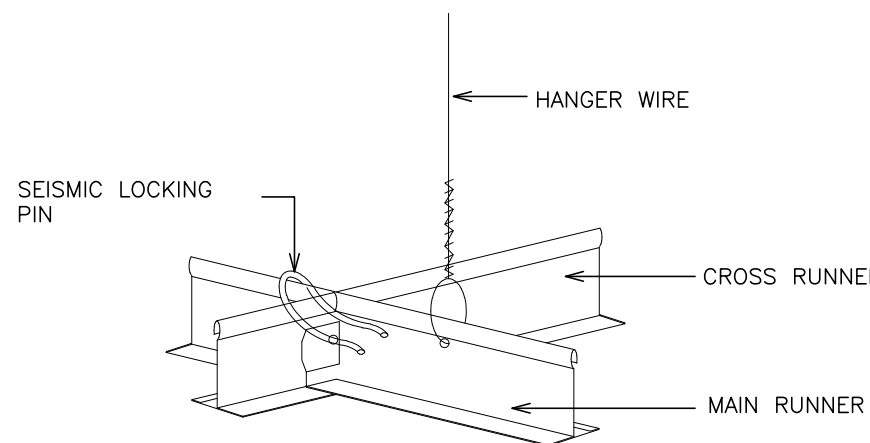


SPLICES AND INTERSECTIONS OF RUNNERS SHALL BE ATTACHED WITH MECHANICAL INTERLOCKING CONNECTORS SUCH AS POP RIVETS, SCREWS, PINS, PLATES, WITH BENT TABS, OR OTHER APPROVED CONNECTORS. DESIGN CONNECTORS FOR 2x DESIGN LOAD OR ULTIMATE AXIAL TENSION OR COMPRESSION (MINIMUM 60 POUNDS)


LOCKING PIN DETAIL

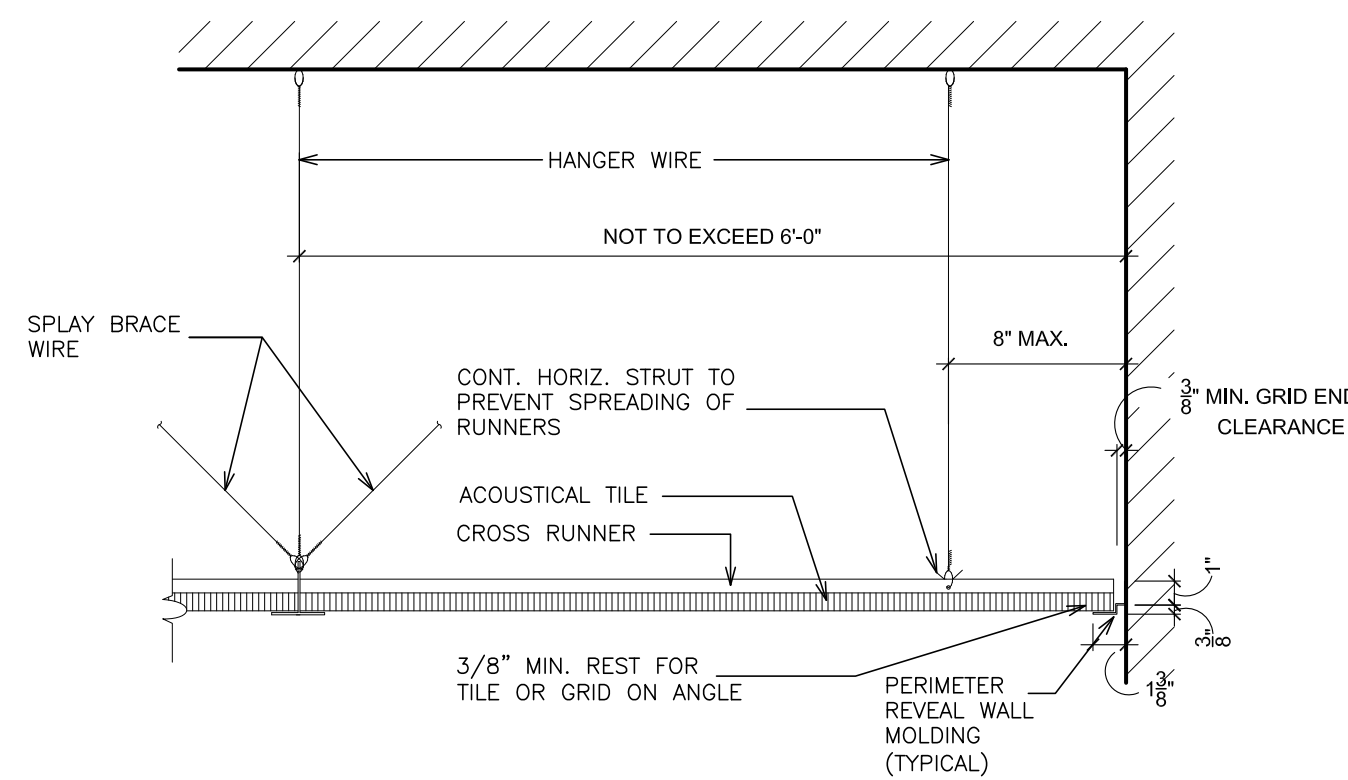


SEISMIC DETAIL @ ALL NEW SUSP. CEILINGS
1 SCALE: N.T.S.

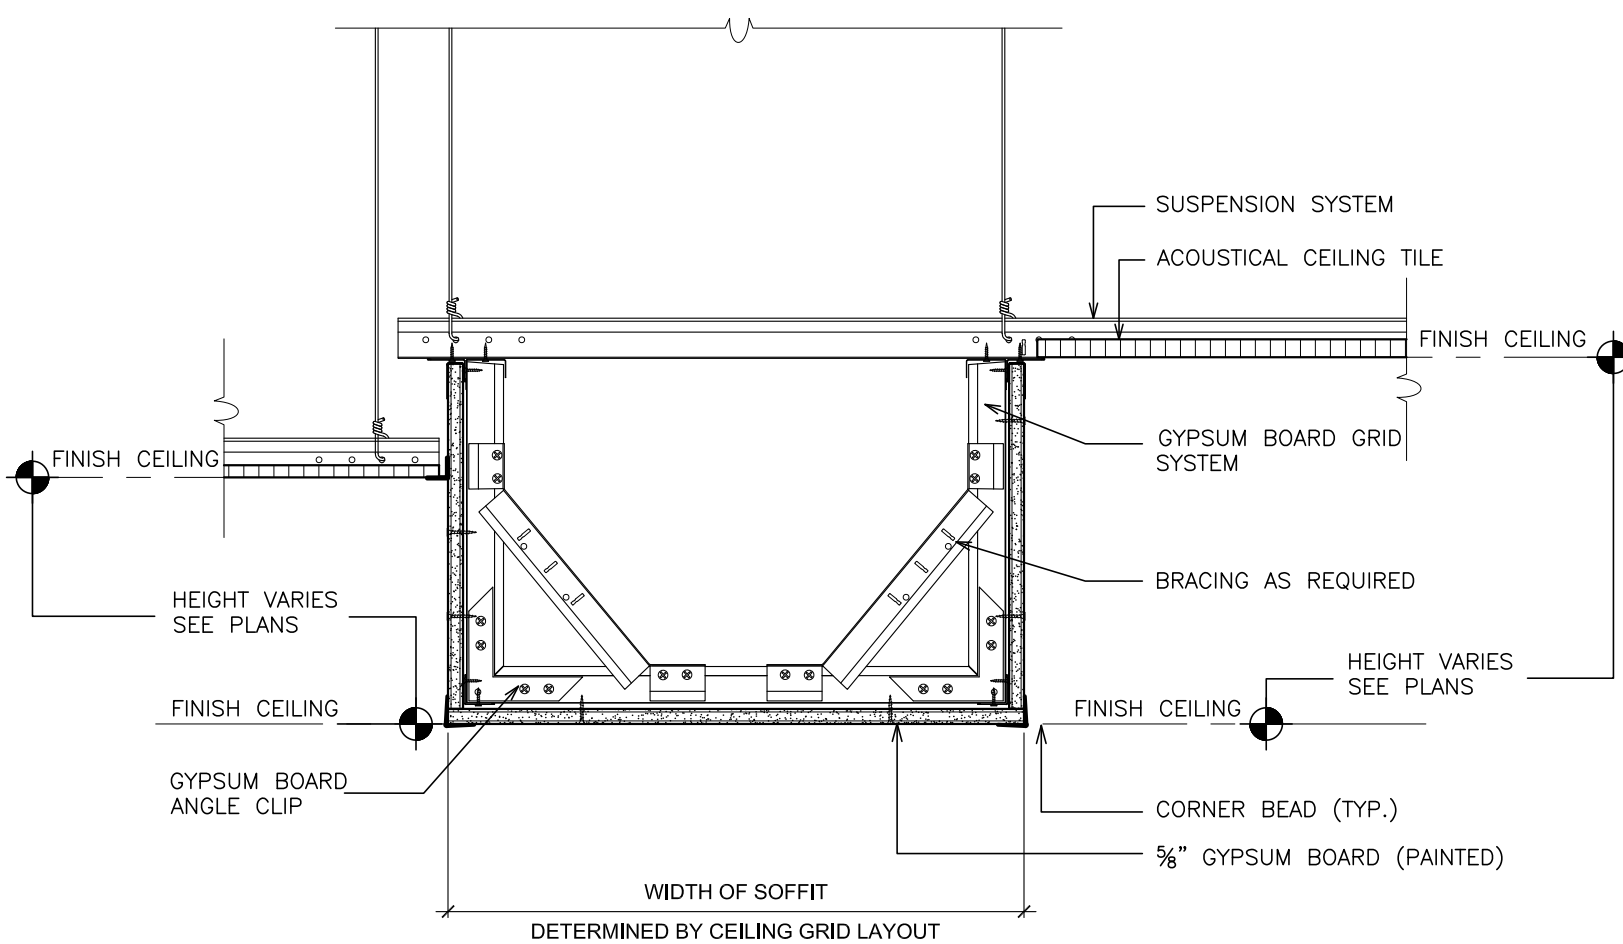


SECTION - DRYWALL SOFFIT @CEILING SYSTEM
2 SCALE: 1 1/2" = 1'-0"

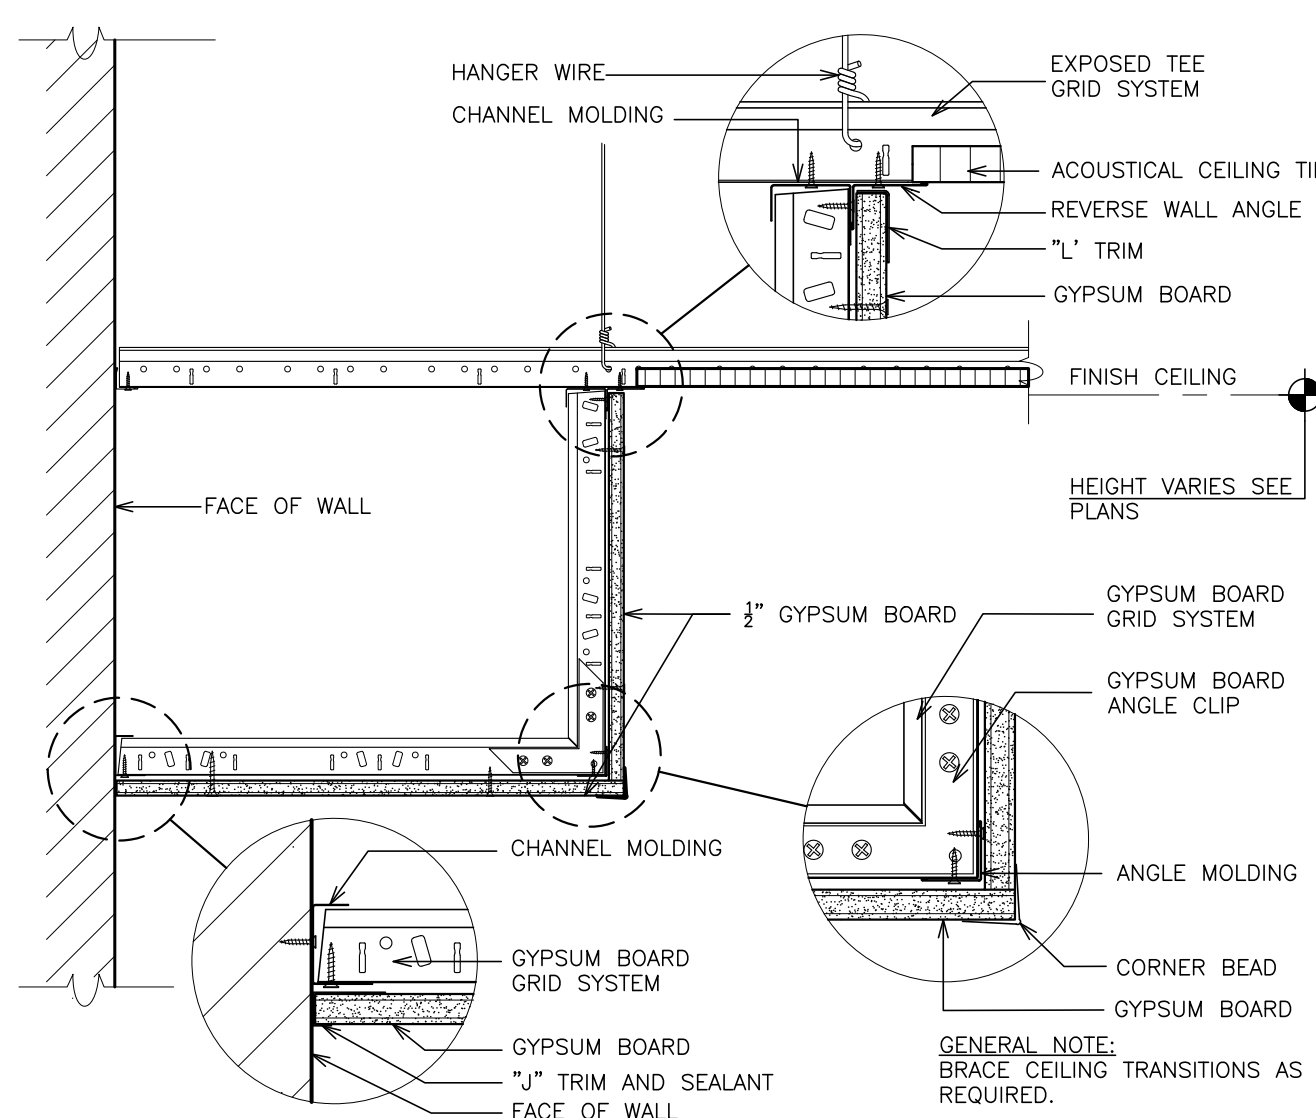


TYPICAL DETAIL - DRYWALL SOFFIT @ ACOUSTIC CEILING SYSTEM
3 SCALE: 1 1/2" = 1'-0"

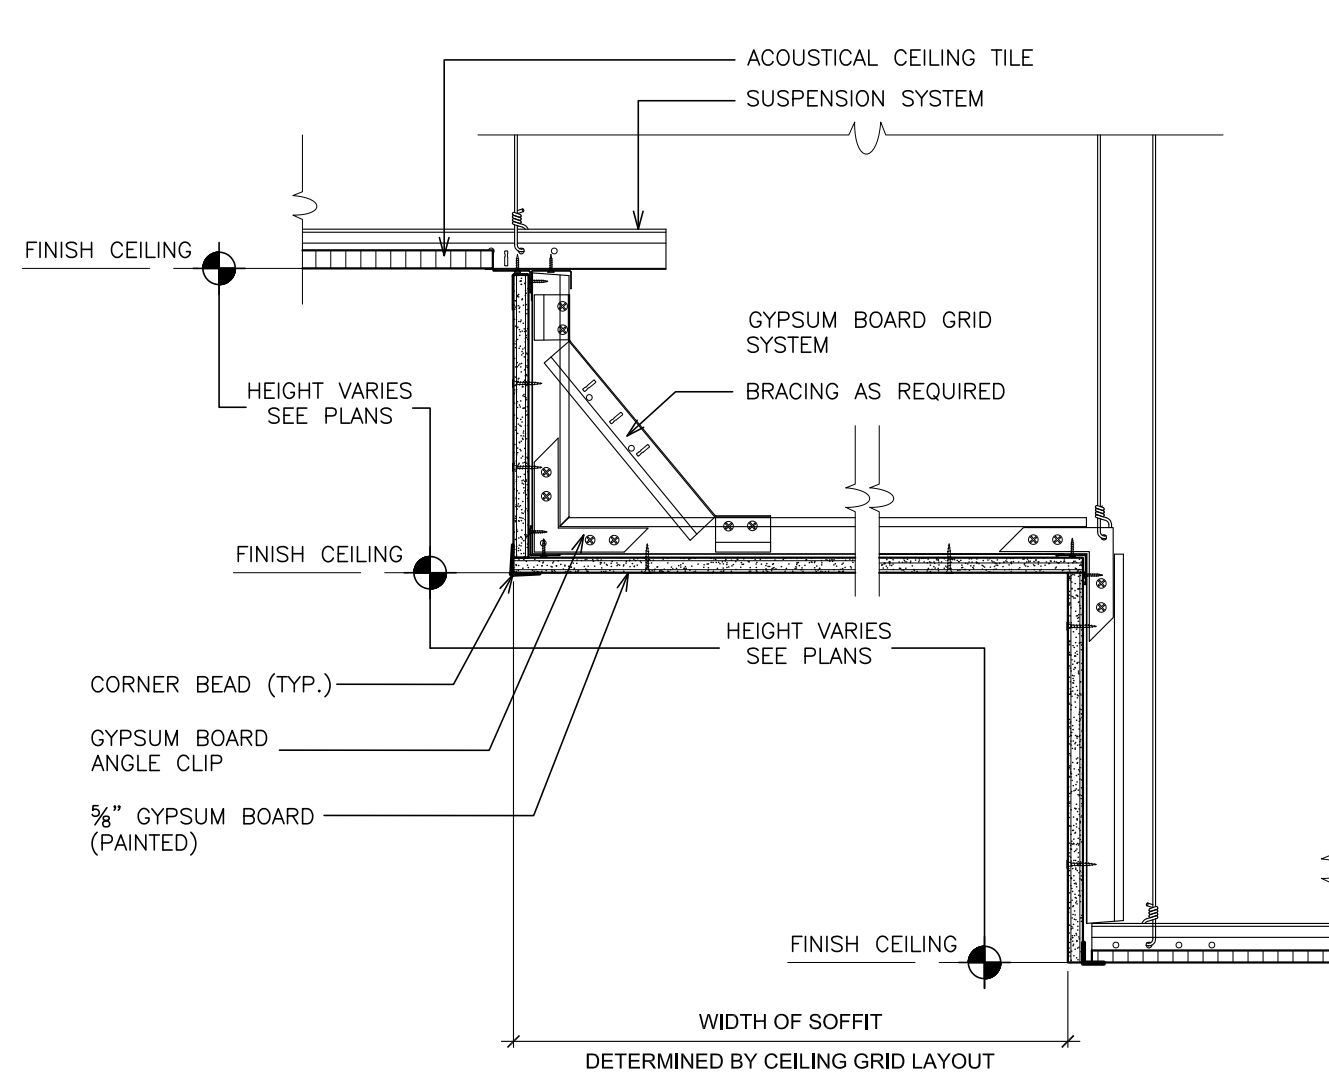


4 DRYWALL SOFFIT @CEILING SYSTEM
SCALE: 1 1/2" = 1'-0"

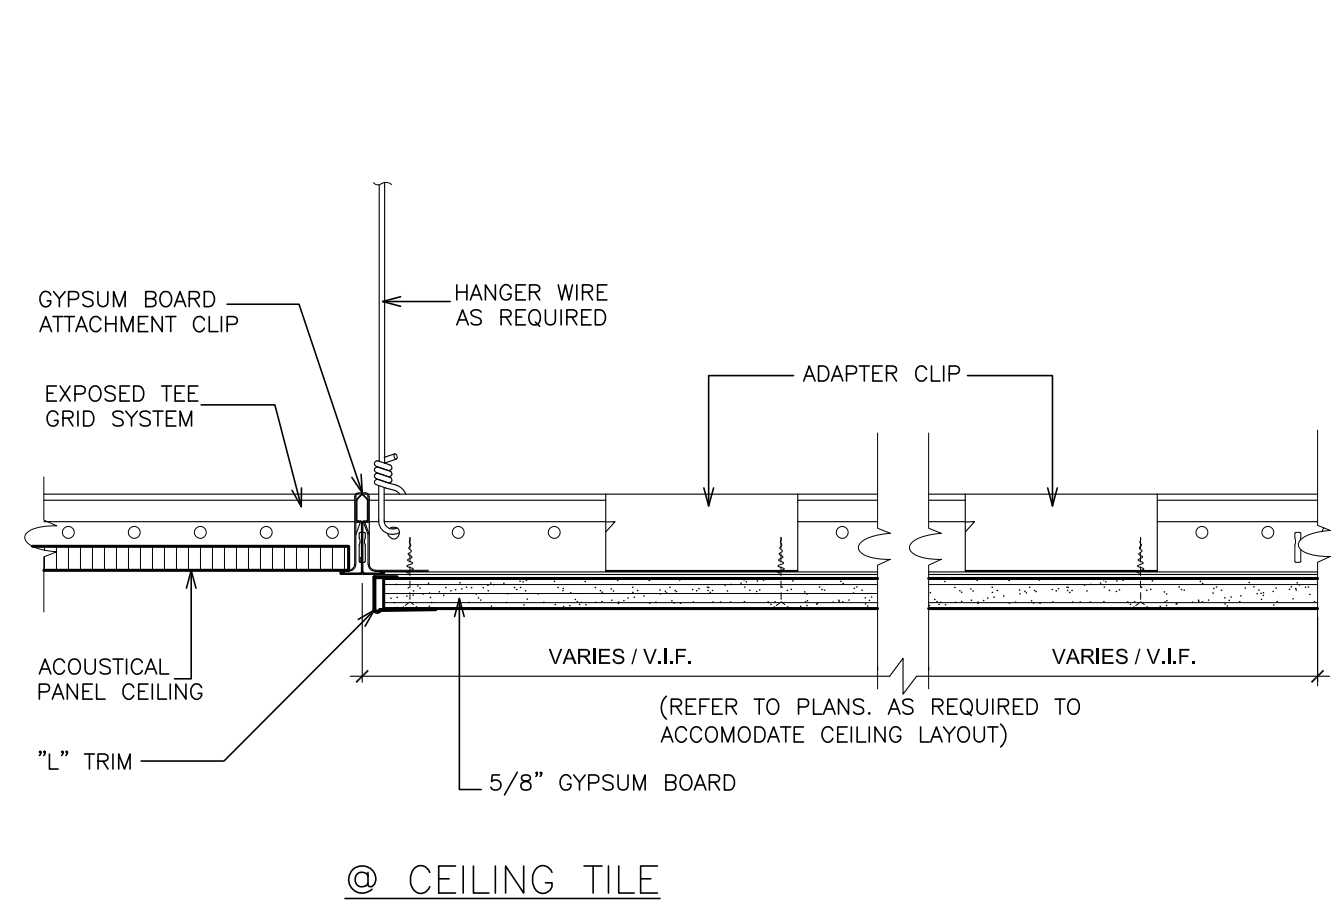


SECTION - FLUSH DRYWALL SOFFIT @ ACOUSTICAL CEILING AND WALL
5 SCALE: 3" = 1'-0"

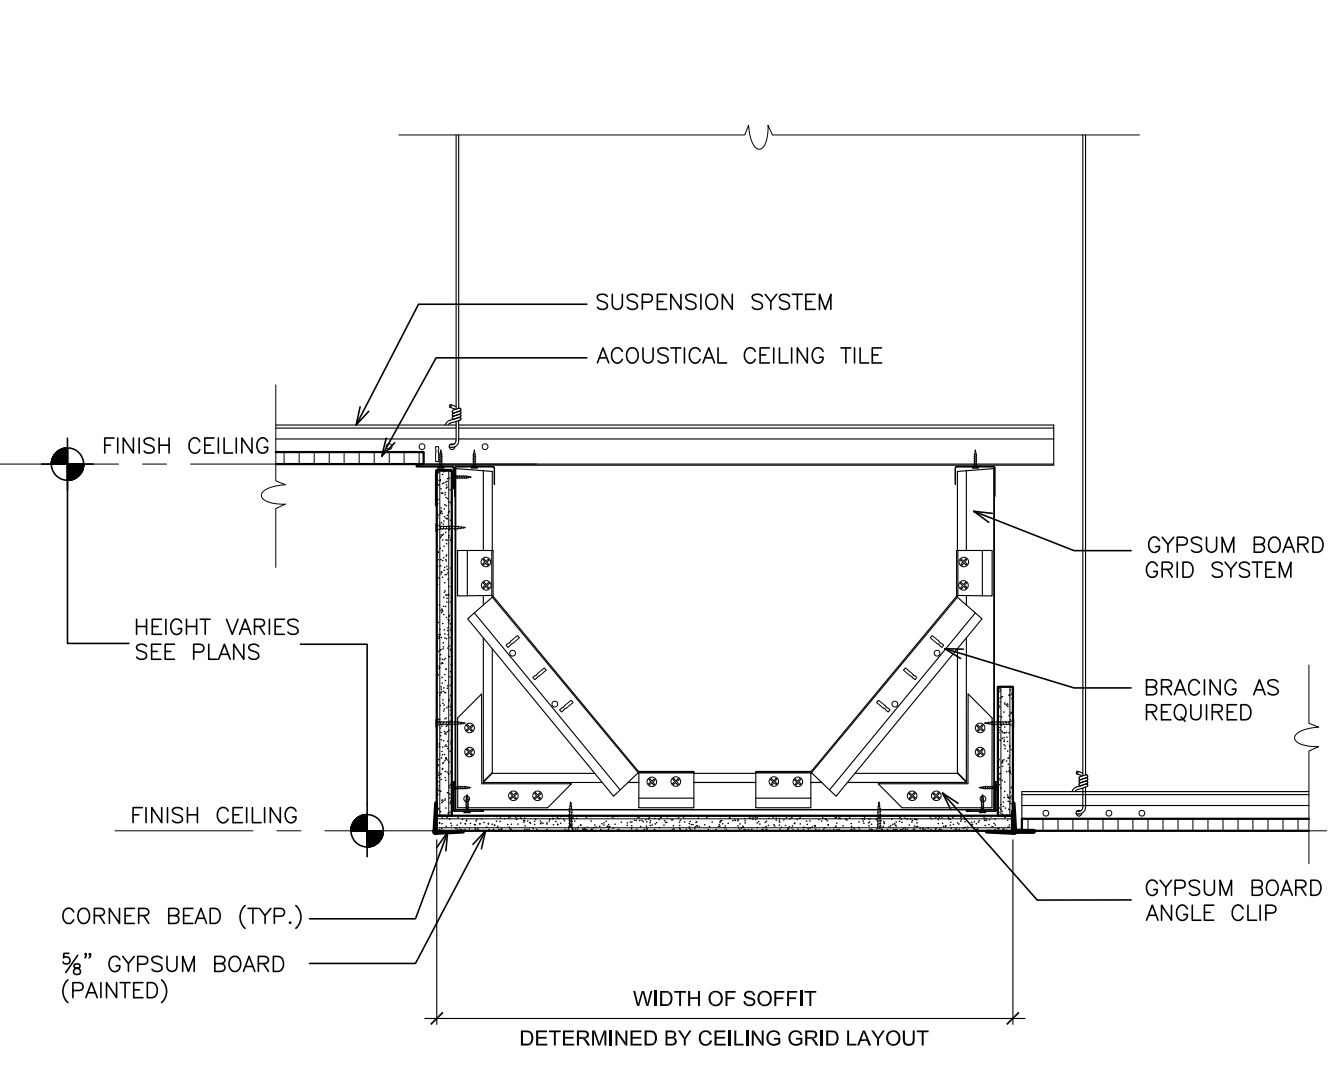

6 DRYWALL SOFFIT @CEILING SYSTEM
SCALE: 1 1/2" = 1'-0"

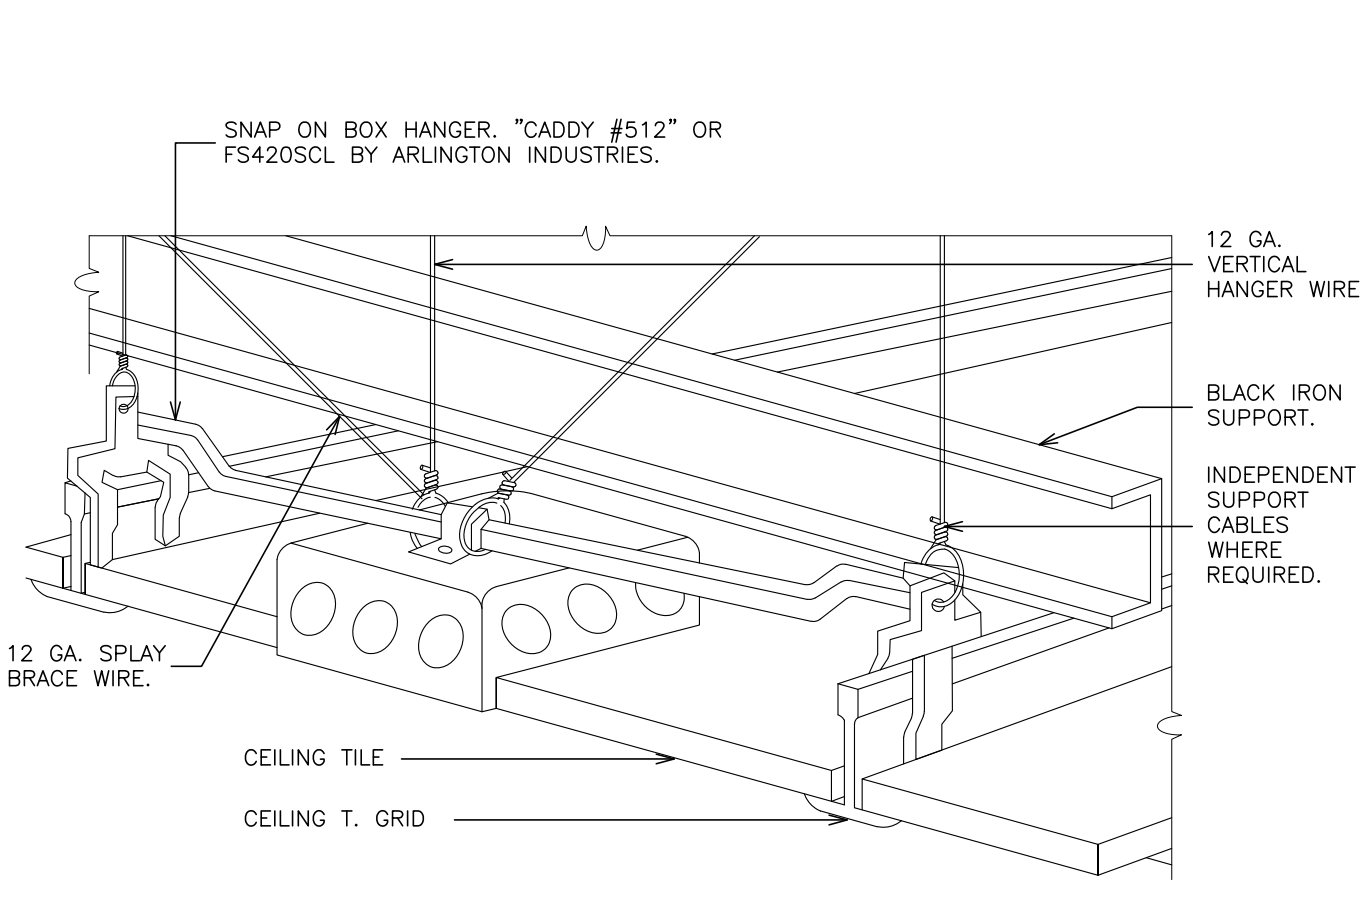

DETAIL - CEILING MOUNTED DEVICE
7 NOT TO SCALE

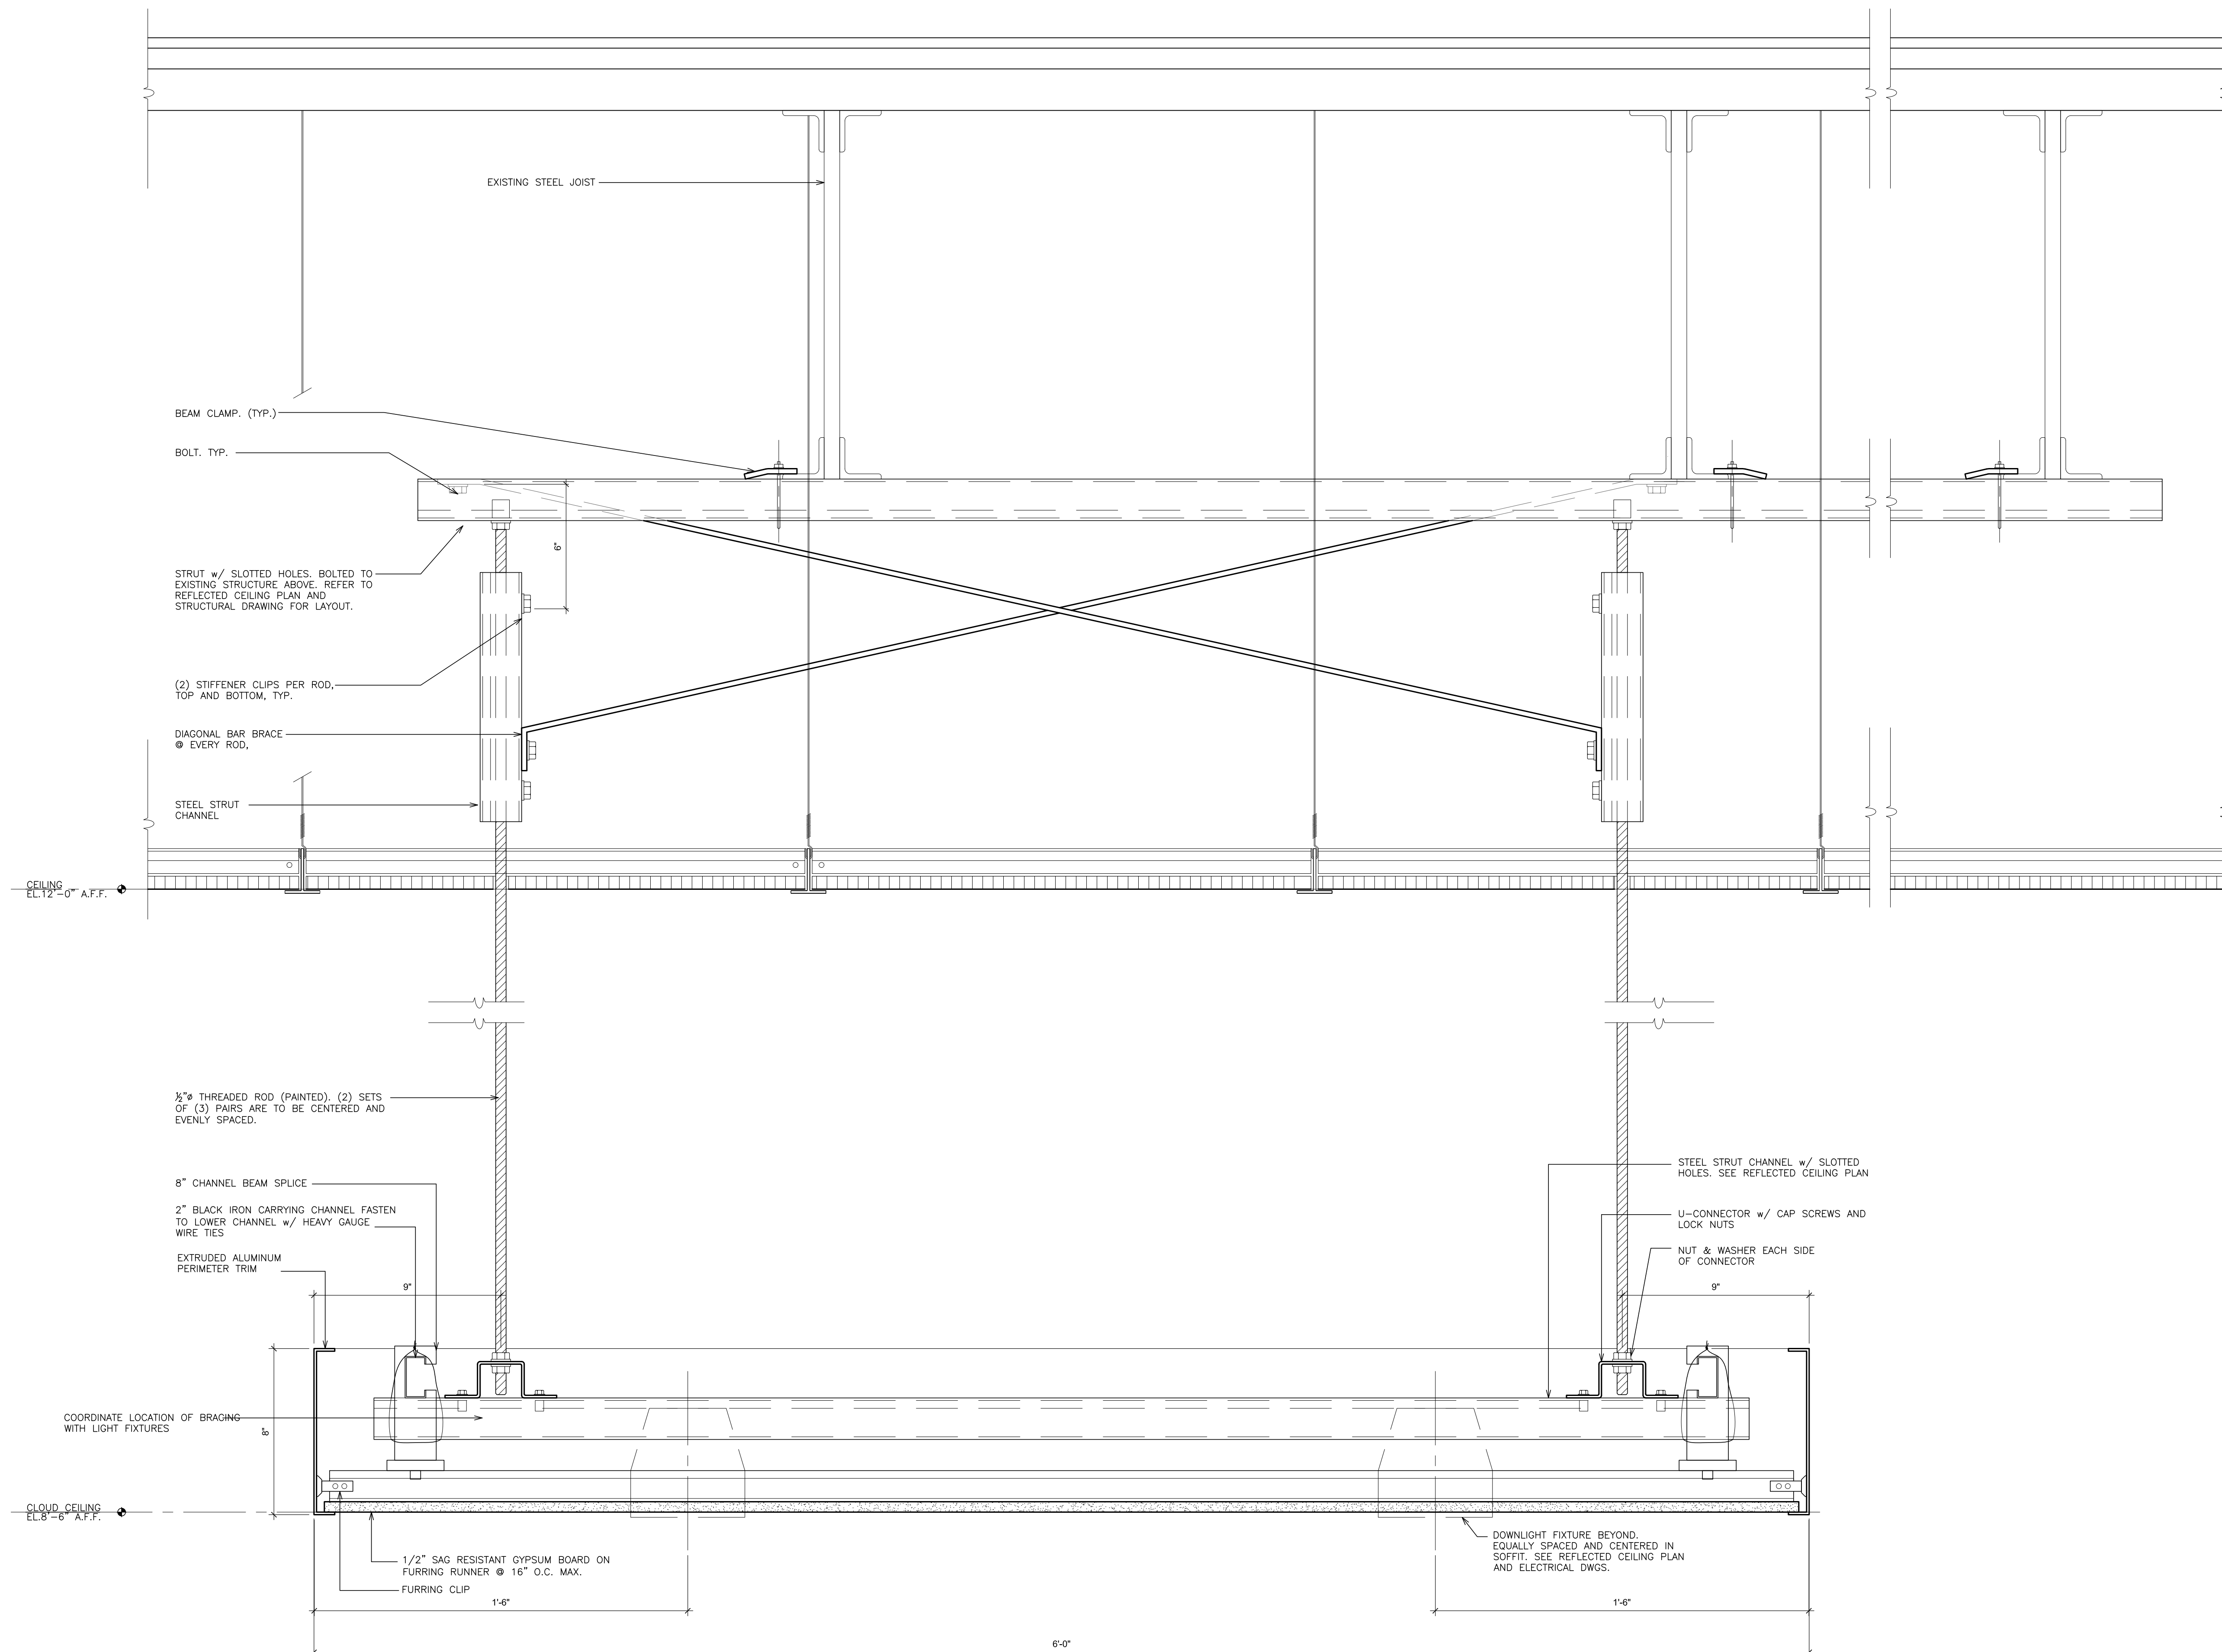

8 DETAIL - SUSPENDED DECORATIVE CEILING
SCALE: 3" = 1'-0"

AS PER USA CONGRESS ARCHITECTURAL WORKS COPYRIGHT PROTECTION ACT OF 1990 ALL IDEAS AND DESIGNS INCLUDING DERIVATIVES THEREOF, ALL DRAWINGS AND SPECIFICATIONS CONSTITUTE THE ORIGINAL COPYRIGHT WORK BY FULLER AND DANIELO, P.C. (F&D). THE DRAWINGS AND SPECIFICATIONS AS INSTRUMENTS OF SERVICE BY F&D ARE CREATED BY F&D FOR THIS PROJECT ONLY AND REMAIN THE PRODUCT AND PROPERTY OF F&D. ANY REPRODUCTION WITHOUT THE PRIOR CONSENT OF F&D IS PROHIBITED.

48 KENILWOOD ROAD ELMSFORD NEW YORK 10523
TEL 914.888.4444 FAX 914.888.1917
Copyright 2022 All Rights Reserved By FULLER & DANIELO, P.C.

FULLER
DANIELO
P.C.
ARCHITECTS
PLANNERS

LICENSE EXP. DATE: 02-28-2027

S.E.D. CONTROL NUMBER:
GREENVILLE ELEMENTARY SCHOOL
66-04-06-03-0-008-021

PROJECT TITLE
EDGEMONT SCHOOL DISTRICT
GREENVILLE ELEMENTARY SCHOOL
CAFETERIA RENOVATION
DRAWING TITLE
CEILING DETAILS, MISC. DETAILS & CEILING
DETAILS

01-31-2025	BID
01-10-2022	SED SUBMISSION
DATE	ISSUED TO
SHEET SIZE 30"x42"	DRAWING NO. A501
SCALE AS NOTED	FILE NO. 24529.01
DRAWN BY F & D	



AS PER U.S. CONGRESS ARCHITECTURAL WORKS COPYRIGHT PROTECTION ACT OF 1990, ALL IDEAS AND DESIGNS INCLUDING DERIVATIVES THEREOF, ALL DRAWINGS AND SPECIFICATIONS CONSTITUTE THE ORIGINAL COPYRIGHT WORK BY FULLER AND D'ANGELO, P.C. (F&D). THE DRAWINGS AND SPECIFICATIONS AS INSTRUMENTS OF SERVICE BY F&D ARE CREATED BY F&D FOR THIS PROJECT ONLY AND REMAIN THE PRODUCT AND PROPERTY OF F&D. ANY REPRODUCTION WITHOUT THE PRIOR CONSENT OF F&D IS PROHIBITED.

45 KNOLLWOOD ROAD ELMSFORD NEW YORK 10523
TEL 914.892.4444 FAX 914.892.1717
WWW.FULLERDANIEL.COM

FULLER
D'ANGELO
P.C.
ARCHITECTS
PLANNERS

LICENSE EXP. DATE: 02-28-2027

S.E.D. CONTROL NUMBER:
GREENVILLE ELEMENTARY SCHOOL
66-04-06-03-0-008-021


PROJECT TITLE	EDGEMONT SCHOOL DISTRICT GREENVILLE ELEMENTARY SCHOOL CAFETERIA RENOVATION
DRAWING TITLE	ROOF DETAILS

01-31-2025	BID
01-10-2022	SED SUBMISSION
DATE	ISSUED TO
SHEET SIZE 30"x42"	DRAWING NO. A625
SCALE AS NOTED	
DRAWN BY E. B.	FILE NO. 24522.04


PLOT DATE: January 22, 2025 -- 7:26am

FILE: I:\24529.01 Greenville Cafeteria Renovation\DRAWINGS\CURRENT\1-F&D\A650.dwg


1 DETAIL- BASE WALL FLASHING
SCALE: 3" = 1'-0"

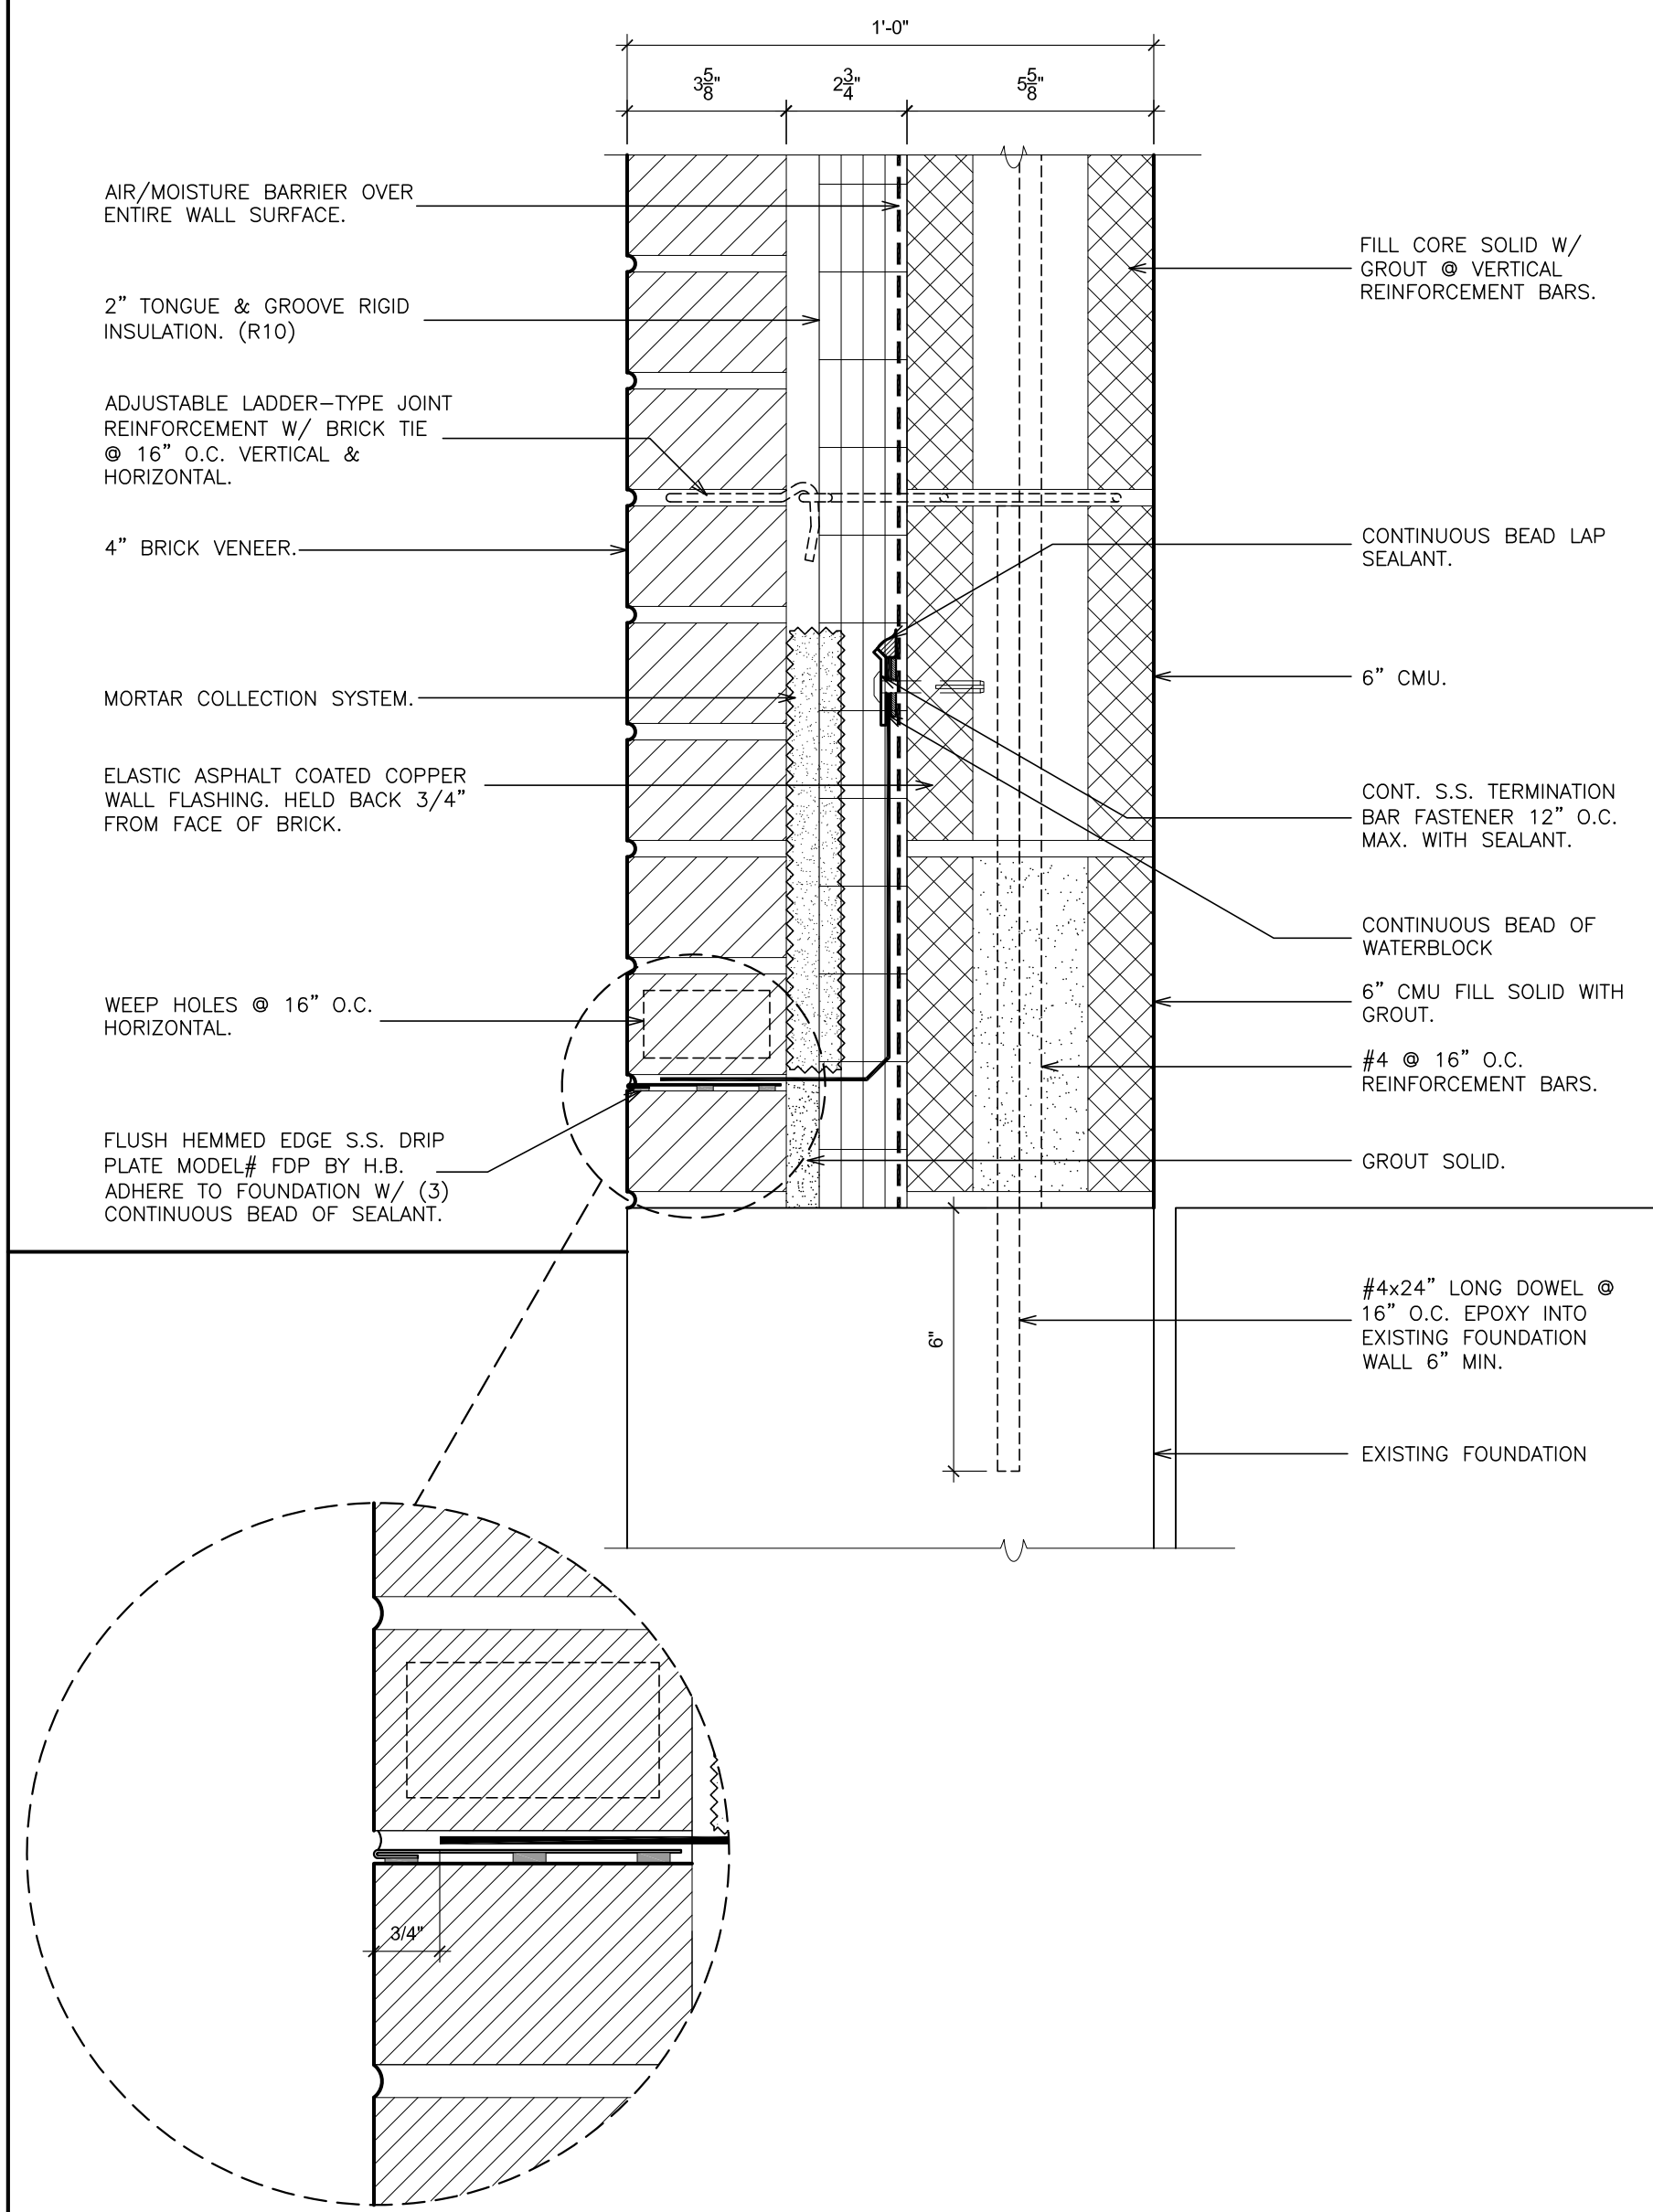


2 LOUVER
SCALE: 3" = 1'-0"

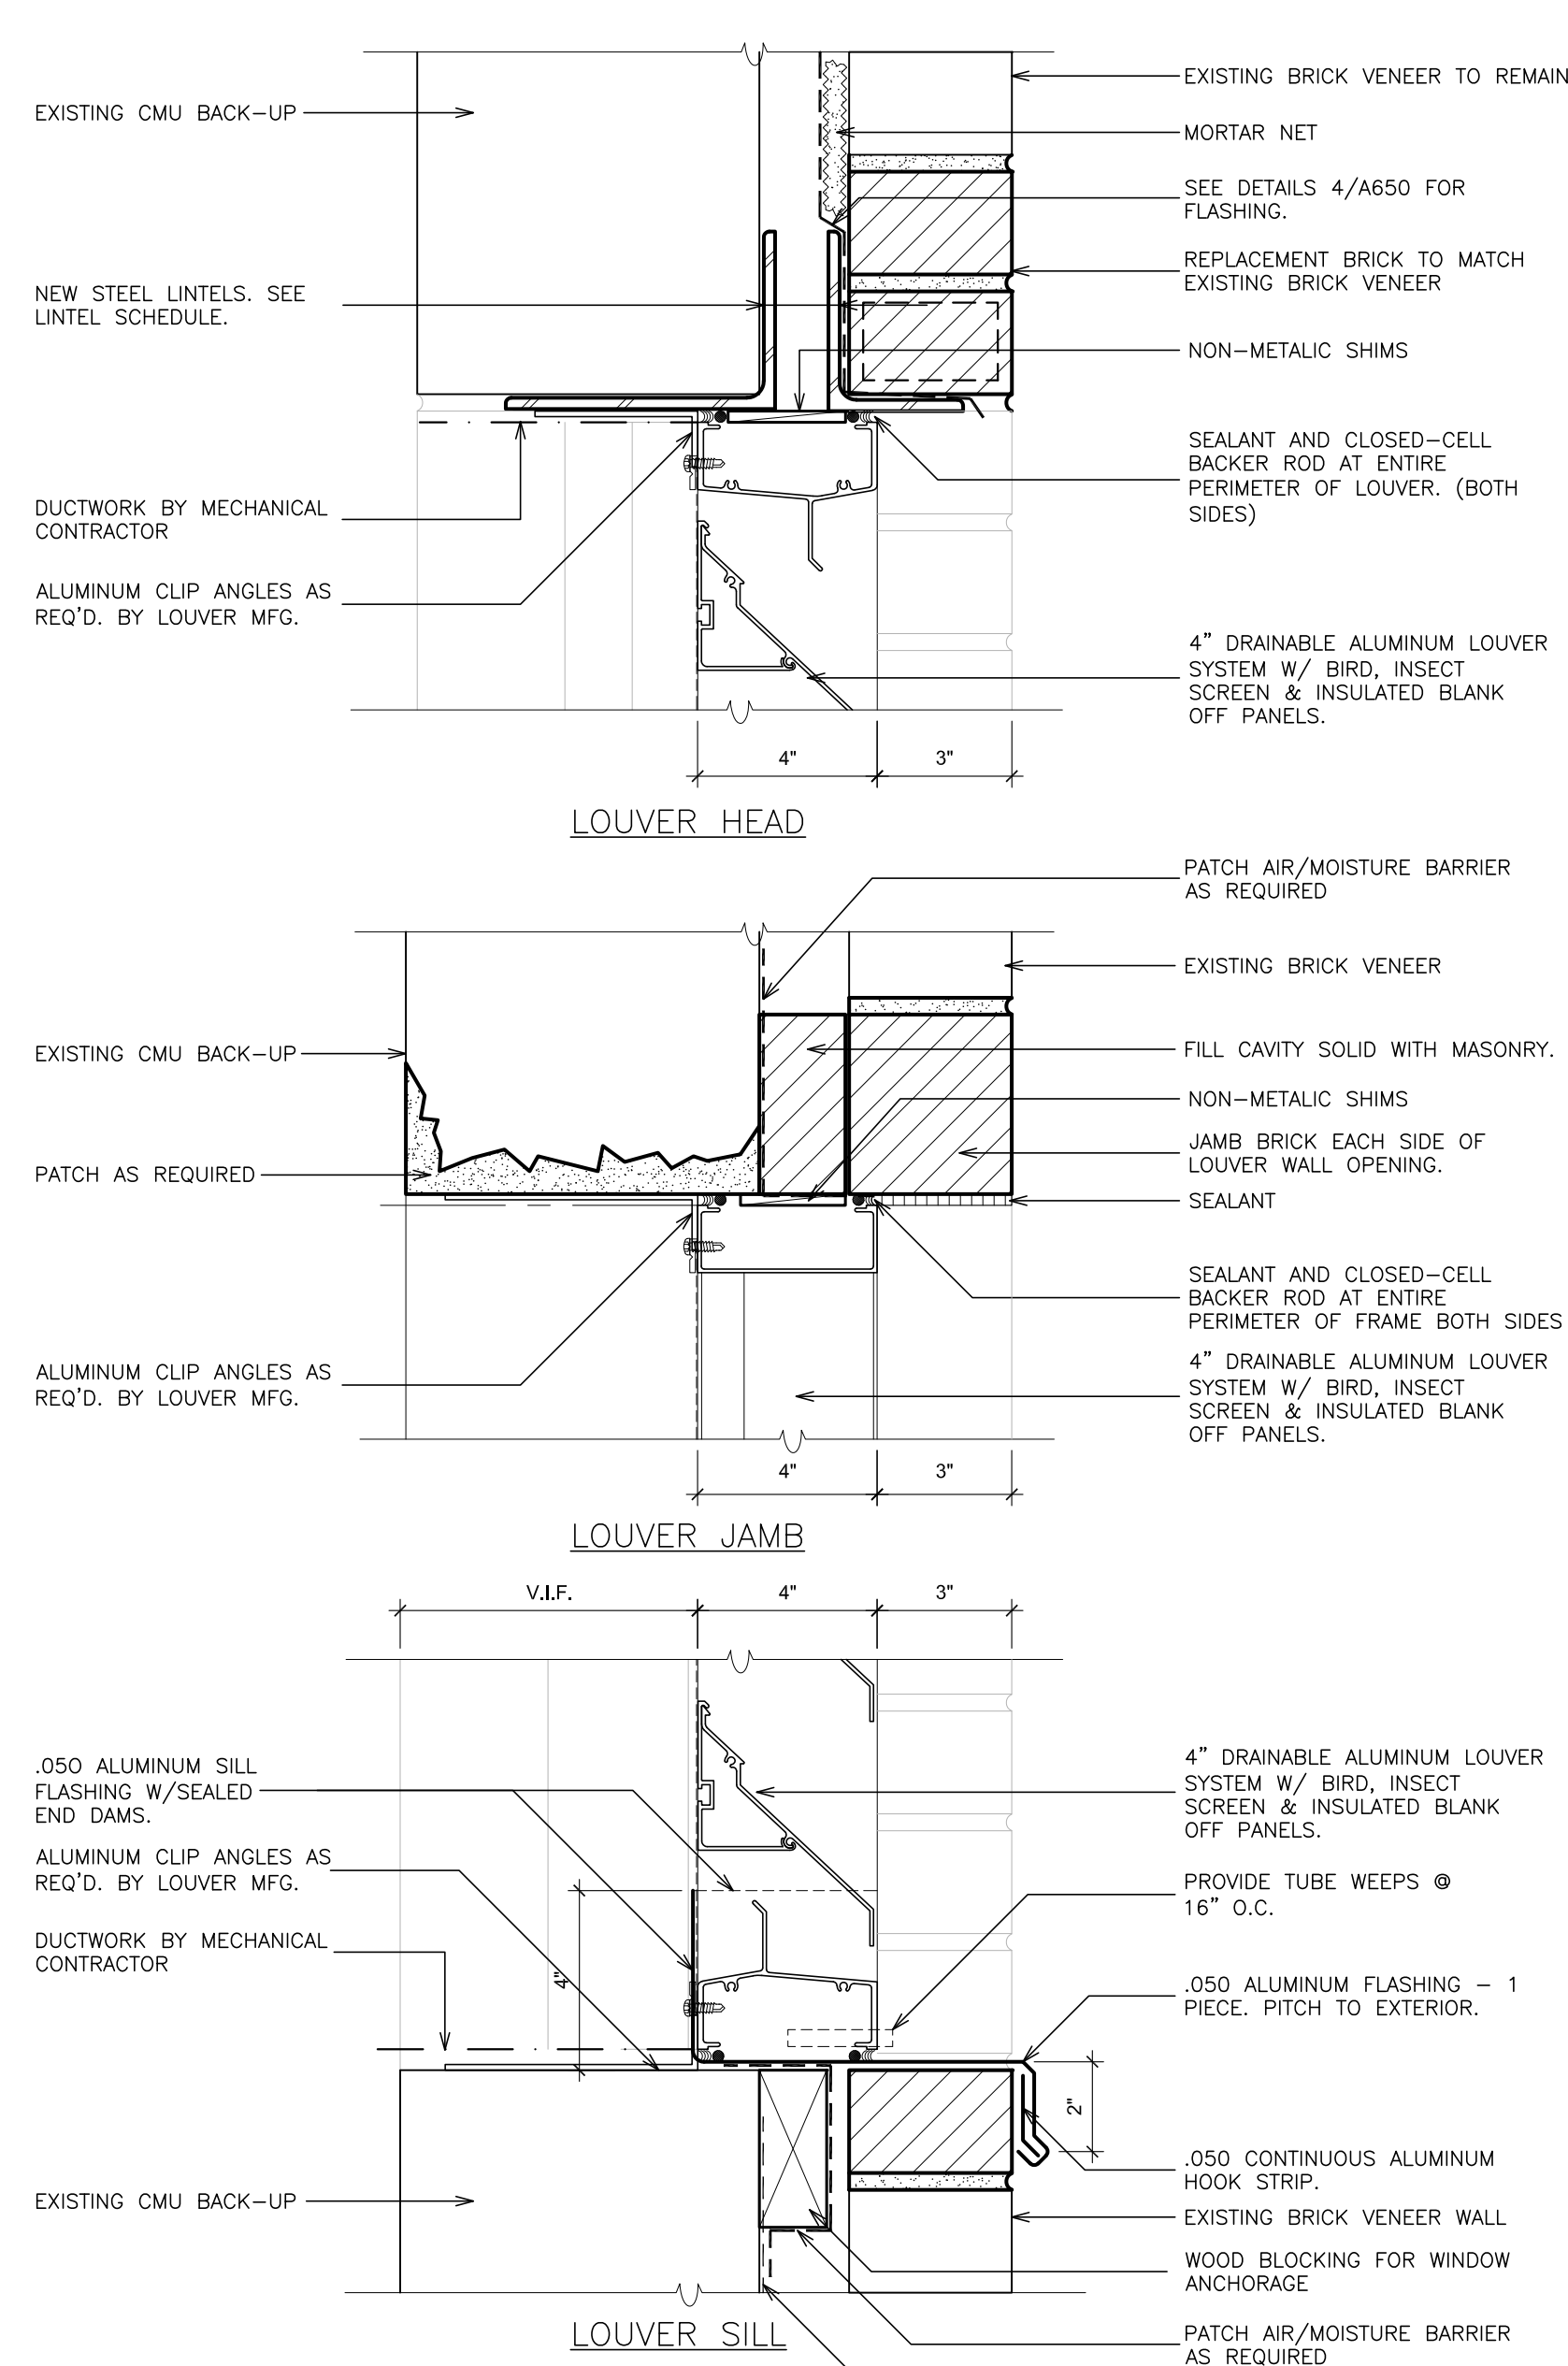


3 ELEVATION - LOUVER
SCALE: 1/2" = 1'-0"

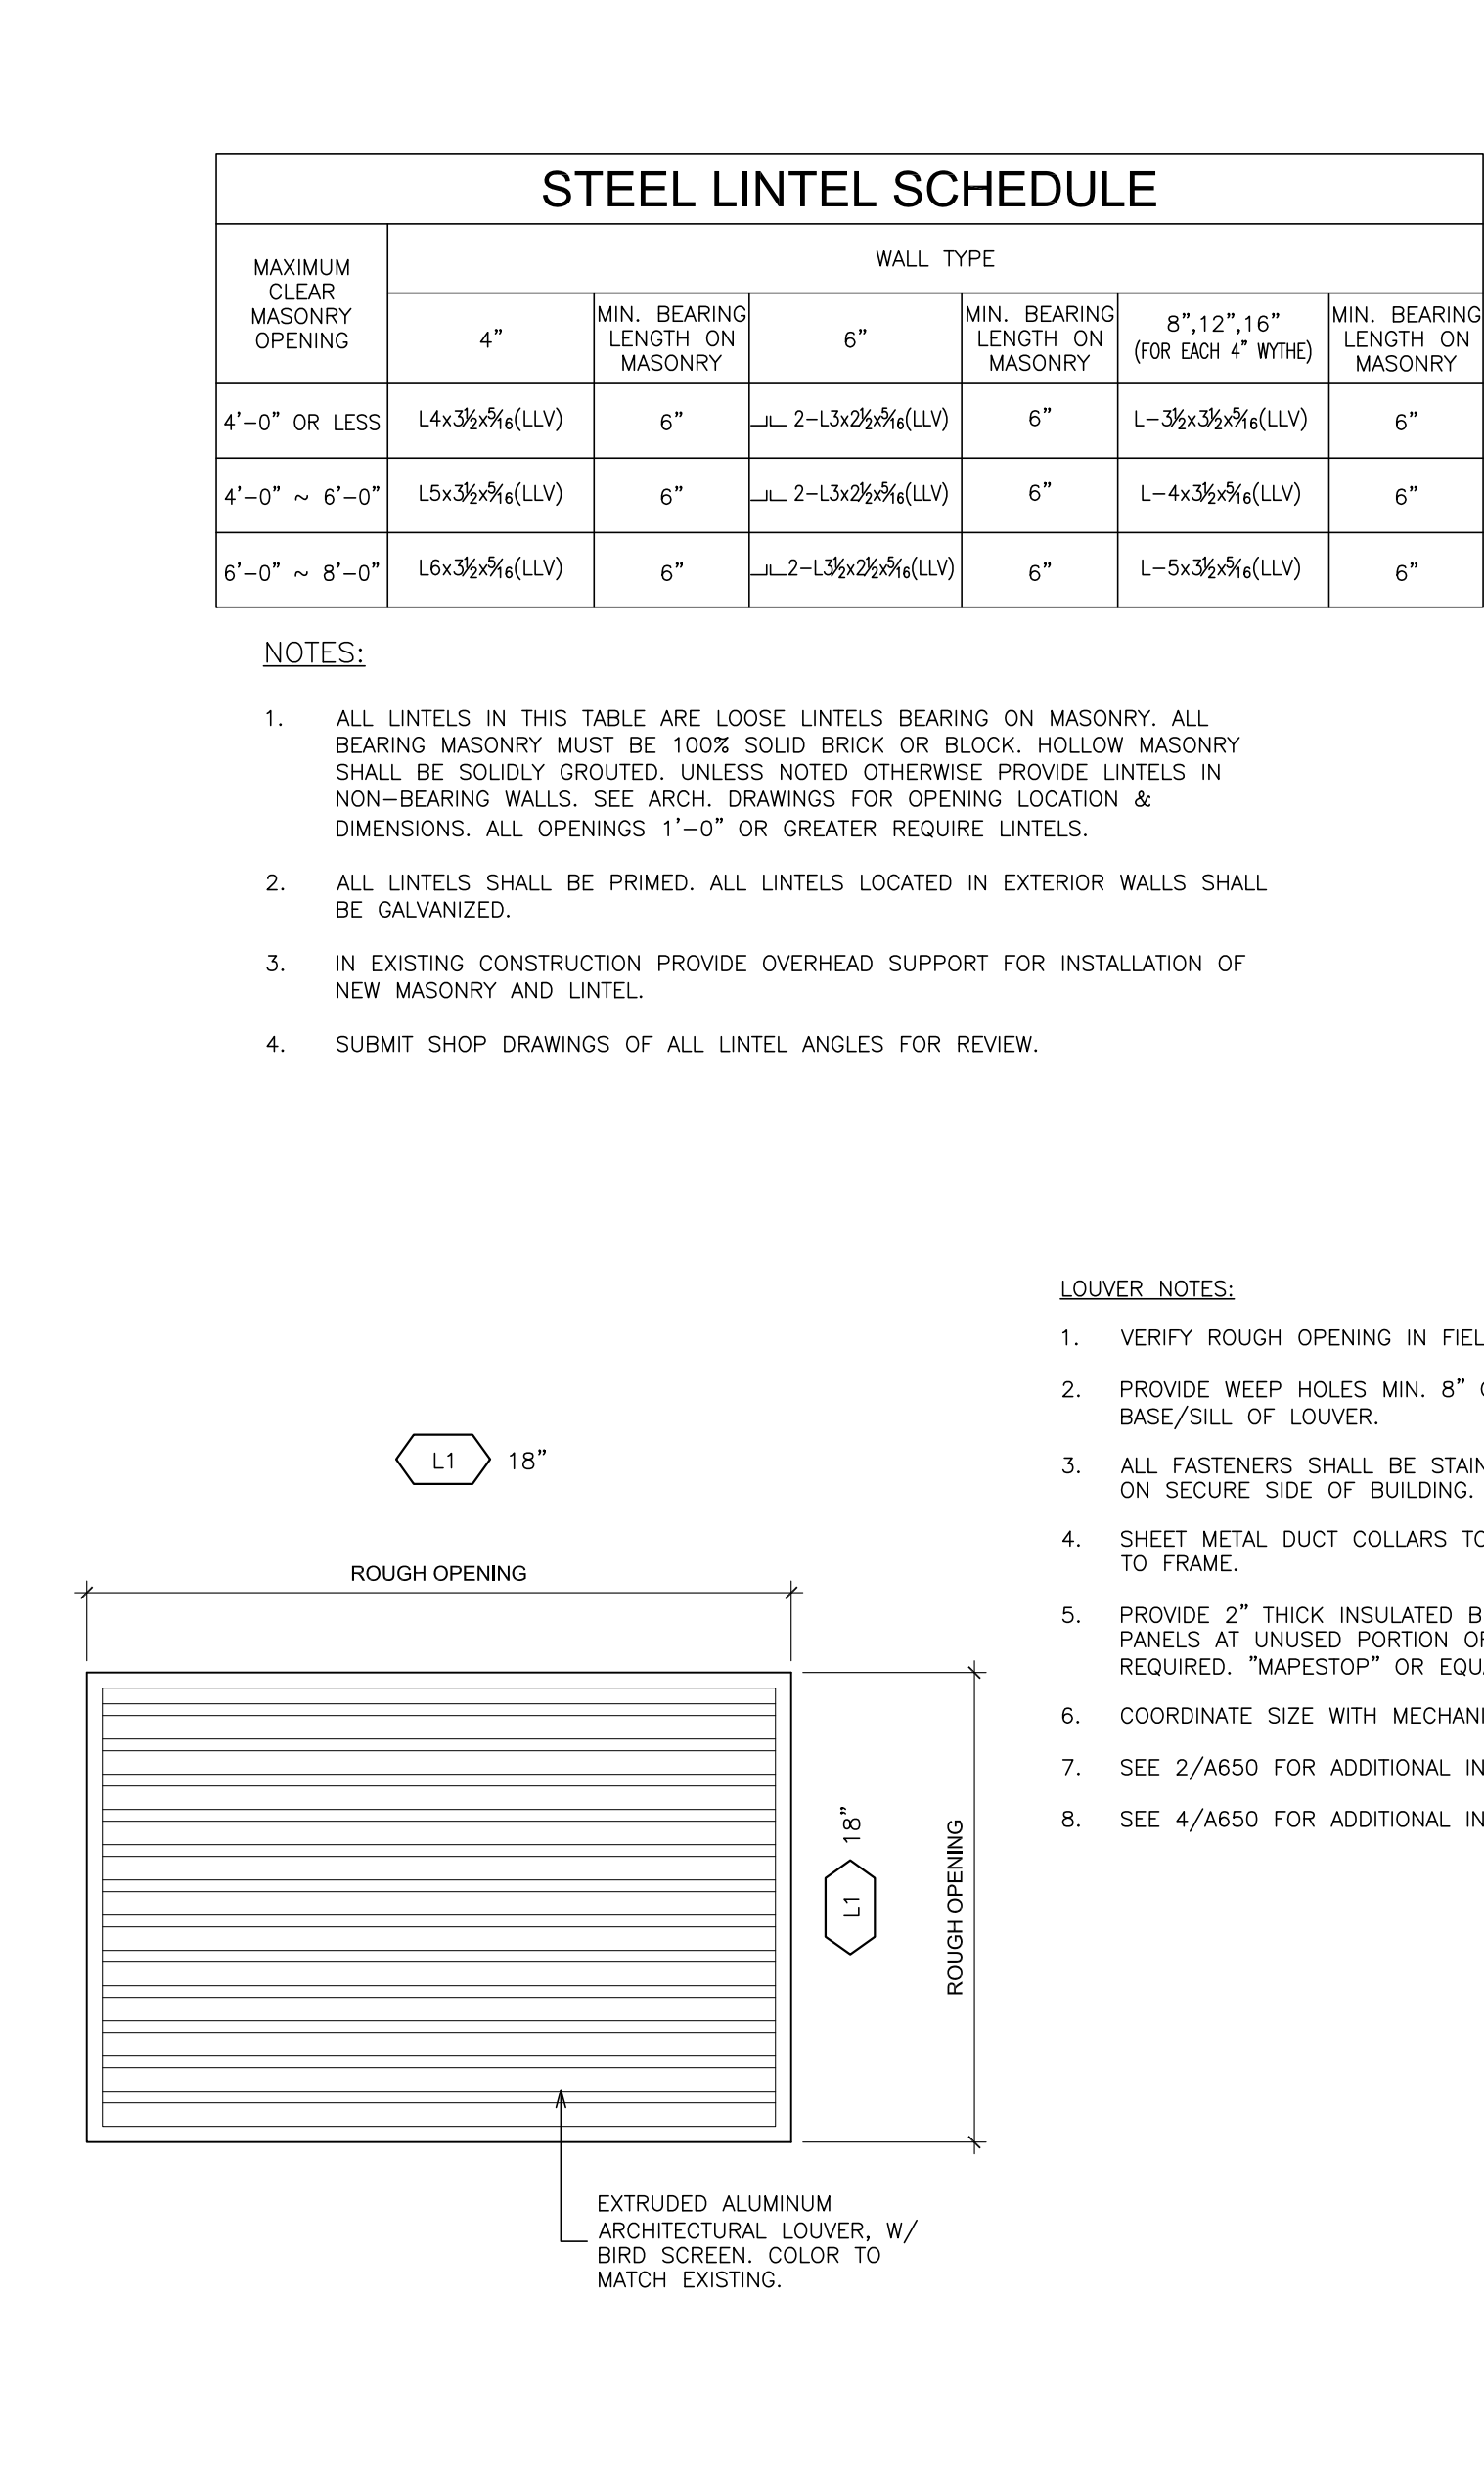

5 DETAIL - FIRE EXTINGUISHER CABINET
SCALE: 1 1/2" = 1'-0"

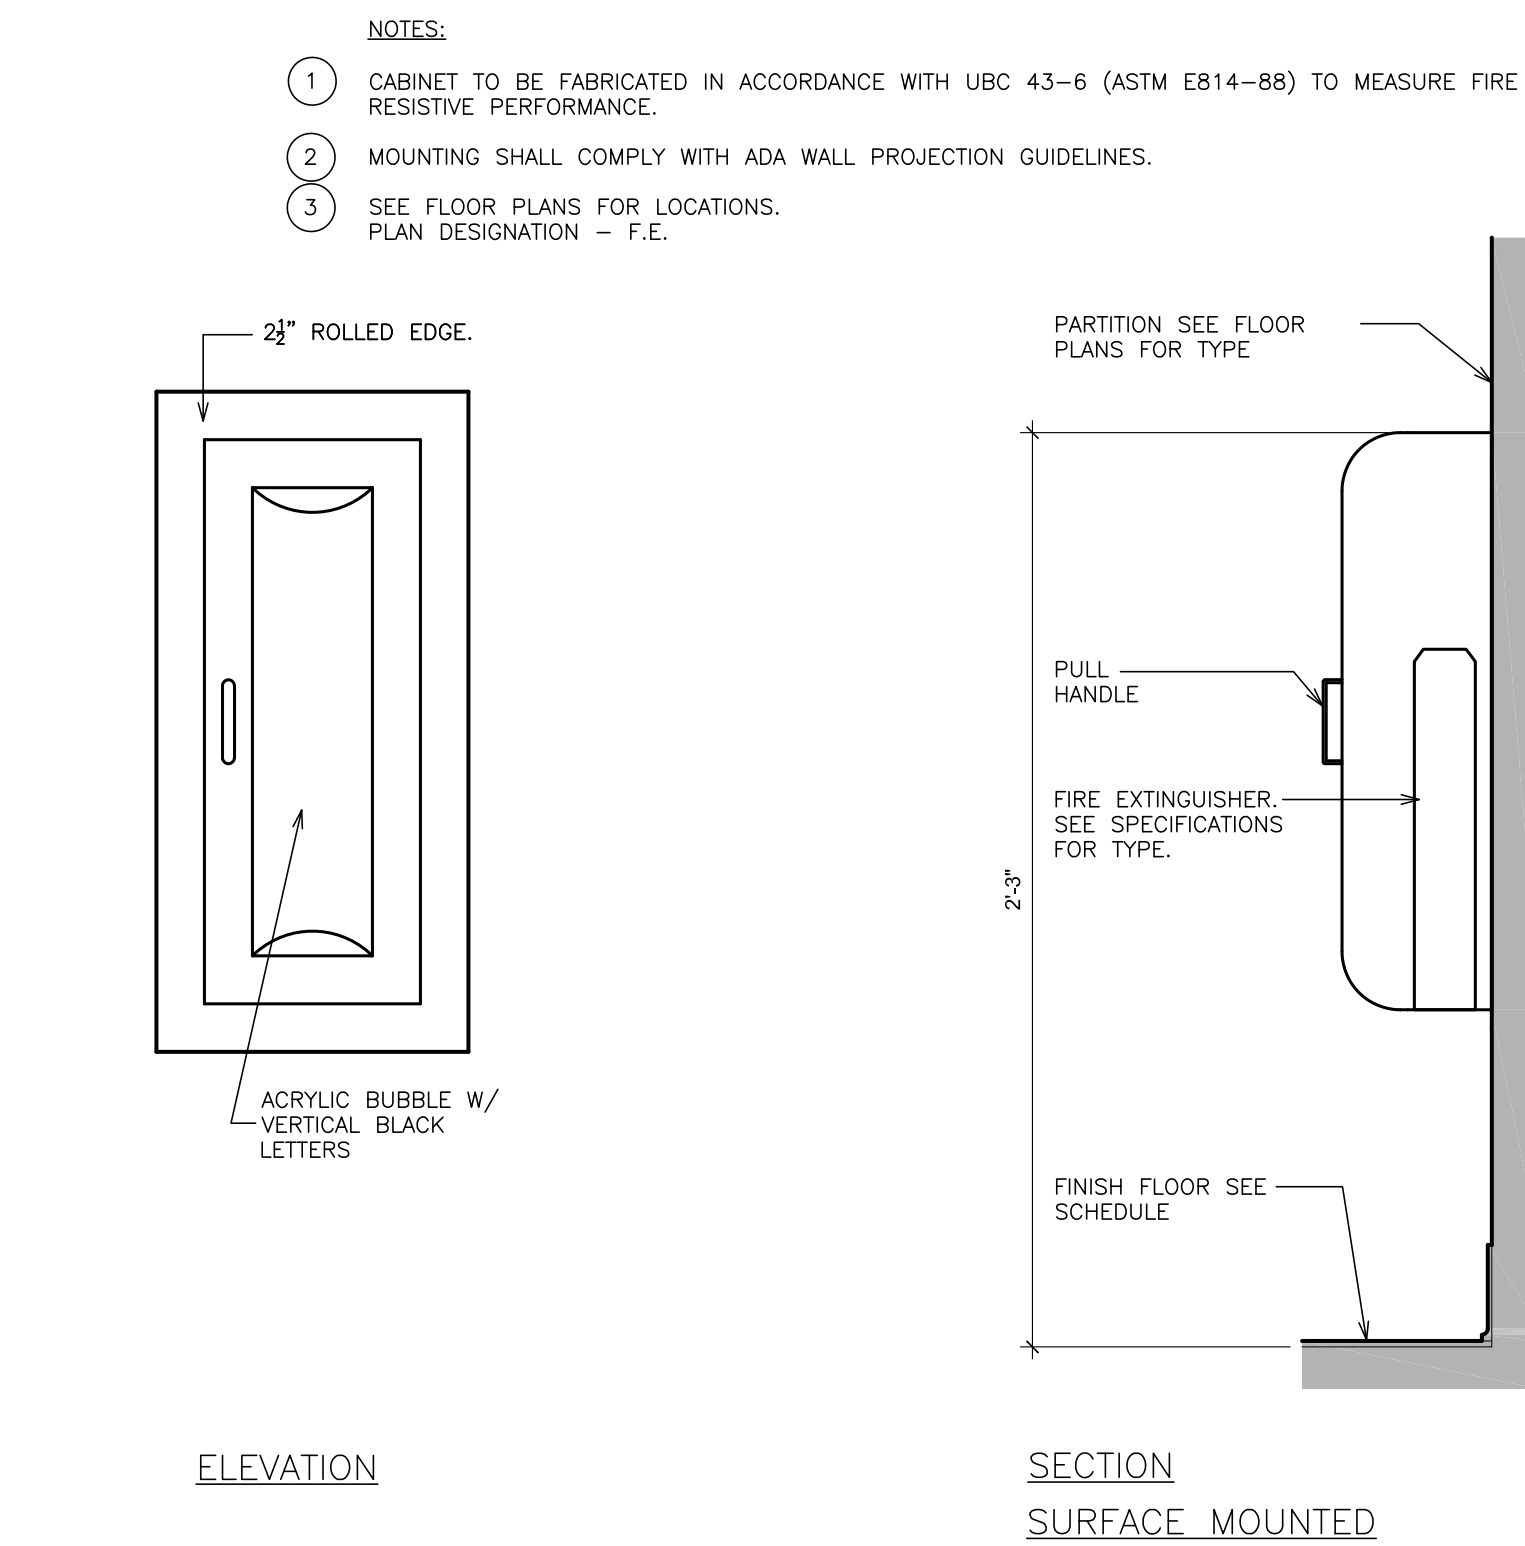

4 TYPICAL LINTEL AND END DAM FLASHING
SCALE: 1 1/2" = 1'-0"

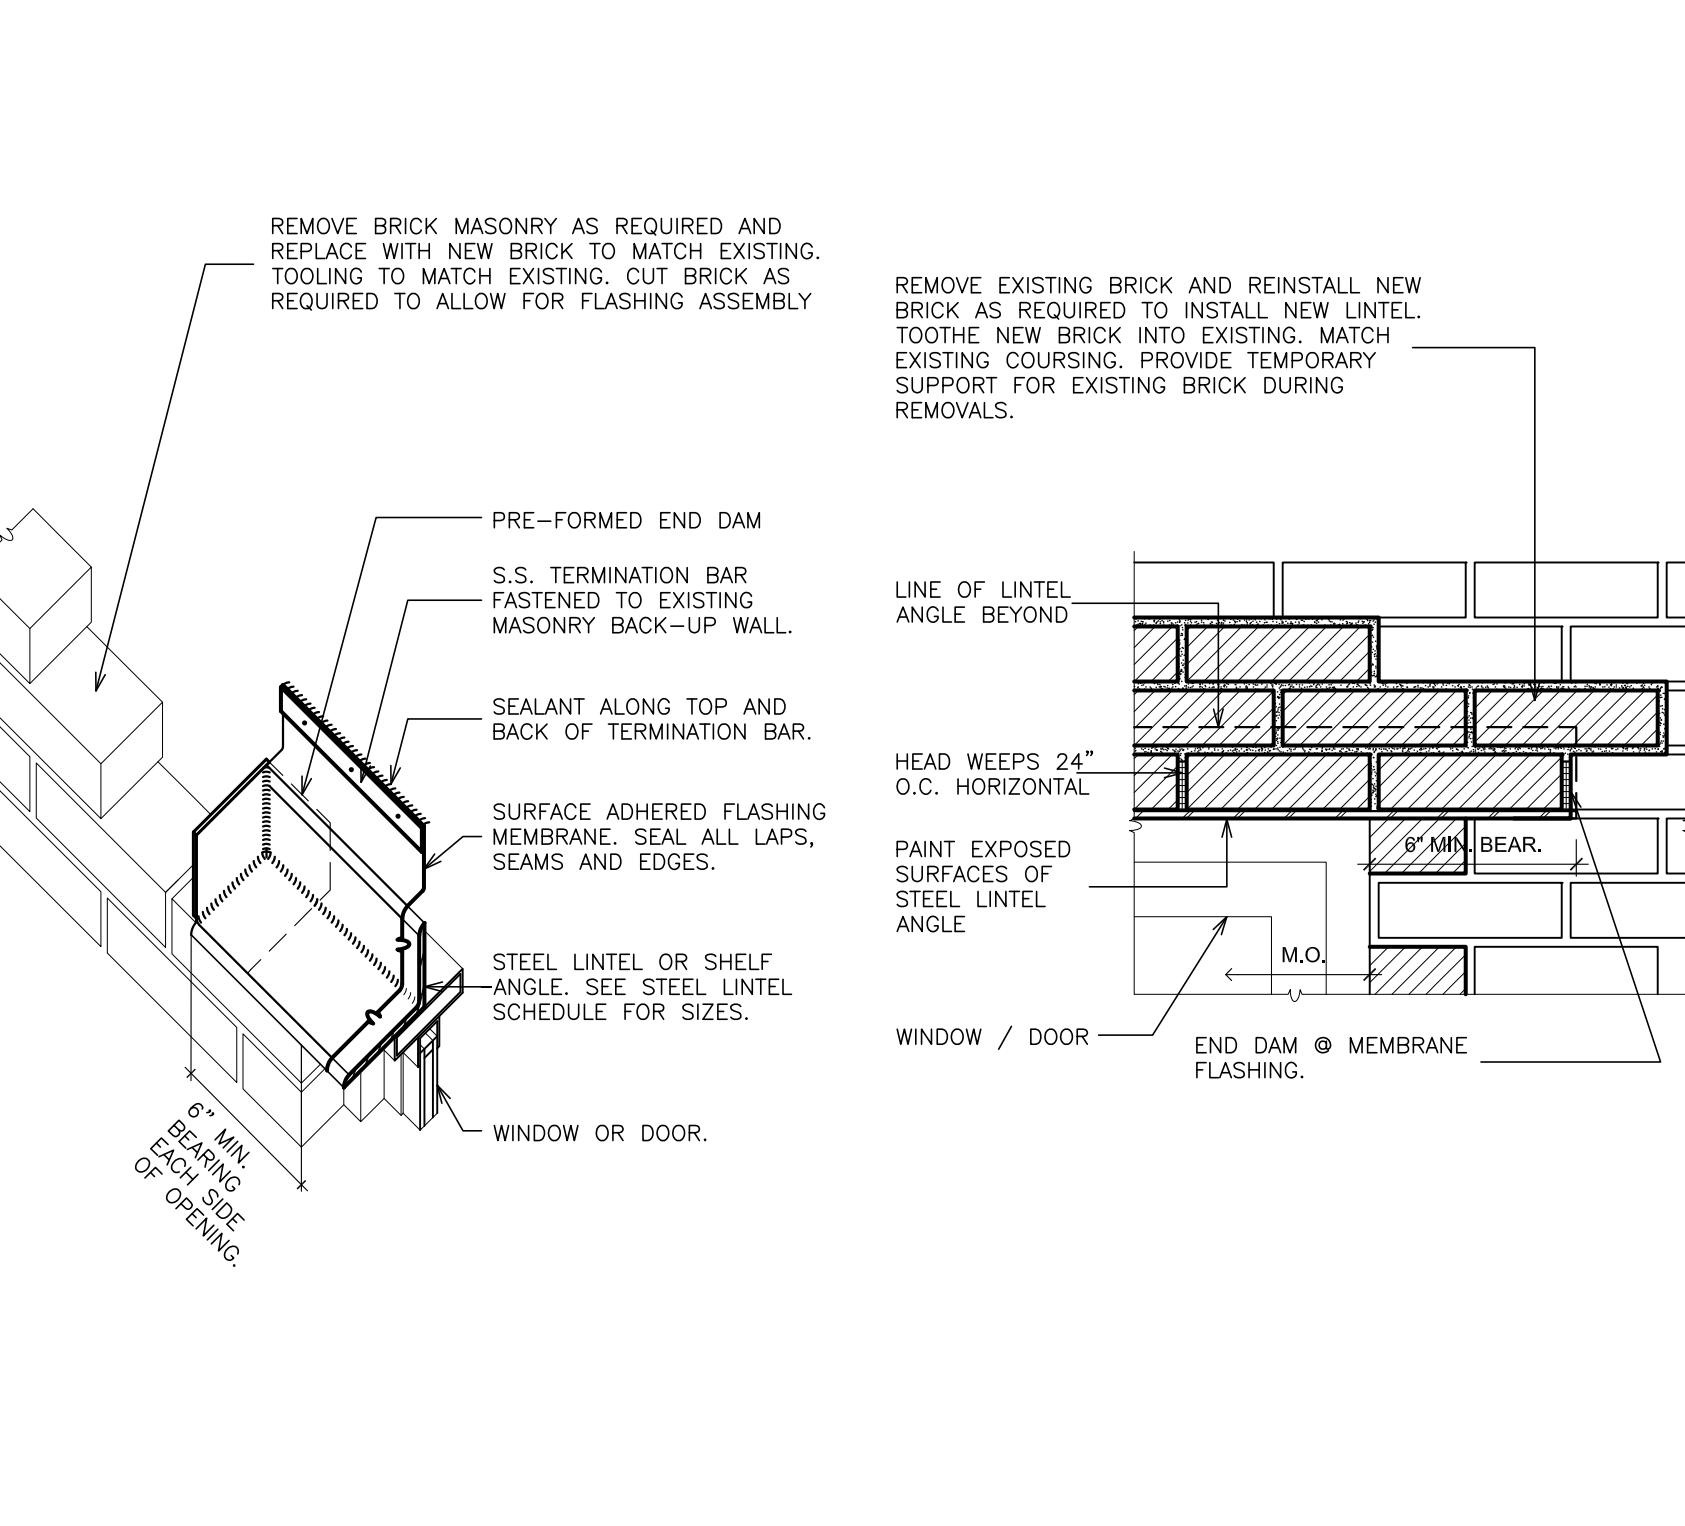

48 KNOXWOOD ROAD
TEL 914.898.4444
Copyright 2022 All Rights Reserved by FULLER & DANIELO, P.C.

FULLER
& DANIELO
P.C.
ARCHITECTS
& PLANNERS

ELMHURST NEW YORK 10833
FAX 914.898.1917

LICENSE EXP. DATE: 02-28-2027

S.E.D. CONTROL NUMBER:
GREENVILLE ELEMENTARY SCHOOL
66-04-06-03-0-008-021

PROJECT TITLE EDGEWORTH SCHOOL DISTRICT GREENVILLE ELEMENTARY SCHOOL CAFETERIA RENOVATION		DRAWING TITLE MISCELLANEOUS DETAILS	
01-31-2025	BID	01-19-2022	SED SUBMISSION
DATE	ISSUED TO		
SHEET SIZE 30"x42"	DRAWING NO.		
SCALE AS NOTED	A650		
DRAWN BY F & D	FILE NO. 24529.01		

DOOR SCHEDULE

BUILDING	LEVEL	LINE	DOOR NUMBER	DRAWING NUMBER	ROOM / RM No.	DOOR		FRAME		FIRE RATING (MIN.)	HARDWARE														REMARKS																																																																																																																																																																																																																																																																																																																																																																																																																																																																																																																																																																																																																																																																																																																																																																																																																																																																																																																																																																																																																																																																																																																																																																																																																																																																																											
						DOUBLE LEAF DOOR	SIZE	NEW DOOR	EXISTING DOOR		DETAIL	FIRE CODE	GLAZING	DISABLE REQUIREMENTS	HARDWARE TYPE	FUNCTION	MISCELLANEOUS	SECURITY																																																																																																																																																																																																																																																																																																																																																																																																																																																																																																																																																																																																																																																																																																																																																																																																																																																																																																																																																																																																																																																																																																																																																																																																																																																																																																		
GREENVILLE ELEMENTARY SCHOOL	FIRST FLOOR	01	GV100	OVES A151	CAFETERIA 129		4'-0" x 7'-0"	●	D-2	FRP	F-1	AL	H1	J1	S1																																																																																																																																																																																																																																																																																																																																																																																																																																																																																																																																																																																																																																																																																																																																																																																																																																																																																																																																																																																																																																																																																																																																																																																																																																																																																																					</

GENERAL DOOR NOTES:


- DOOR HARDWARE SHALL COMPLY TO ALL APPLICABLE HANDICAPPED CODES. CLOSERS SHALL COMPLY TO STANDARDS REGARDING CLOSING SPEED AND OPENING FORCE.
- ALL DOOR AND FRAME SIZES SHALL BE FIELD VERIFIED.
- THERE SHALL BE NO PROJECTIONS BETWEEN 34" AND 80" ABOVE THE FLOOR OR GROUND. PROJECTIONS BETWEEN 34" AND 80" ABOVE THE FLOOR OR GROUND SHALL NOT EXCEED 4".
- REFER TO SPECIFICATIONS FOR DOOR HARDWARE SETS.
- THE BOTTOM OF ALL DOOR VISION LITES SHALL BE A MAXIMUM OF 43" ABOVE THE FINISHED FLOOR.
- THE DOOR SURFACE WITHIN 10" OF THE FLOOR MEASURED VERTICALLY SHALL BE A SMOOTH SURFACE ON THE PUSH SIDE EXTENDING FULL WIDTH OF DOOR.
- ALL EXTERIOR DOORS AND AREAS ADJACENT TO DOORS TO HAVE 1" INSULATING SAFETY LAMINATED GLASS. (UNLESS NOTED OTHERWISE)
- COORDINATE ALL REMOVALS WITH ABATEMENT DOCUMENTS.
- FIRE RATED DOORS SHALL COMPLY WITH NFPA 80, PROVIDE UL LABELS.
- REFER TO SPECIFICATIONS FOR GLAZING TYPE FOR VISION PANELS. "ALL INTERIOR GLAZING SIZES AND TYPES ARE TO COMPLY WITH NFPA 80 AND/ OR ASTM-119".
- ALL GLAZING IN FIRE RATED DOOR SHALL BE LABELED GLASS. REFER TO SPECIFICATIONS. "ALL INTERIOR GLAZING SIZES AND TYPES ARE TO COMPLY WITH NFPA 80 AND/ OR ASTM-119".
- PROVIDE SILICONE SEALANT AROUND ALL NEW DOOR LIGHTS.
- NEW H.M. DOOR FRAMES TO BE PAINTED (BOTH SIDES).
- NEW H.M. DOOR FRAMES TO RECEIVE RESILIENT RUBBER SILENCERS.

DOOR SCHEDULE REMARKS:

- DOOR MANUFACTURERS ADA COMPLIANT RECESSED DOOR PULL.
- PROVIDE LOUVER IN DOOR.
- PROVIDE HINGE FILLER PLATES.
- FIELD VERIFY DOOR SIZE.
- INTERCOM WITH CAMERA.
- NOT USED.
- NIGHT LATCH RETRACTION.
- NOT USED.
- SEE DETAIL A1/A700 FOR ACCESS CONTROL REQUIREMENTS.

FRAME TYPES SCALE: 1/4"=1'-0"

DOOR TYPES SCALE: 1/4"=1'-0"


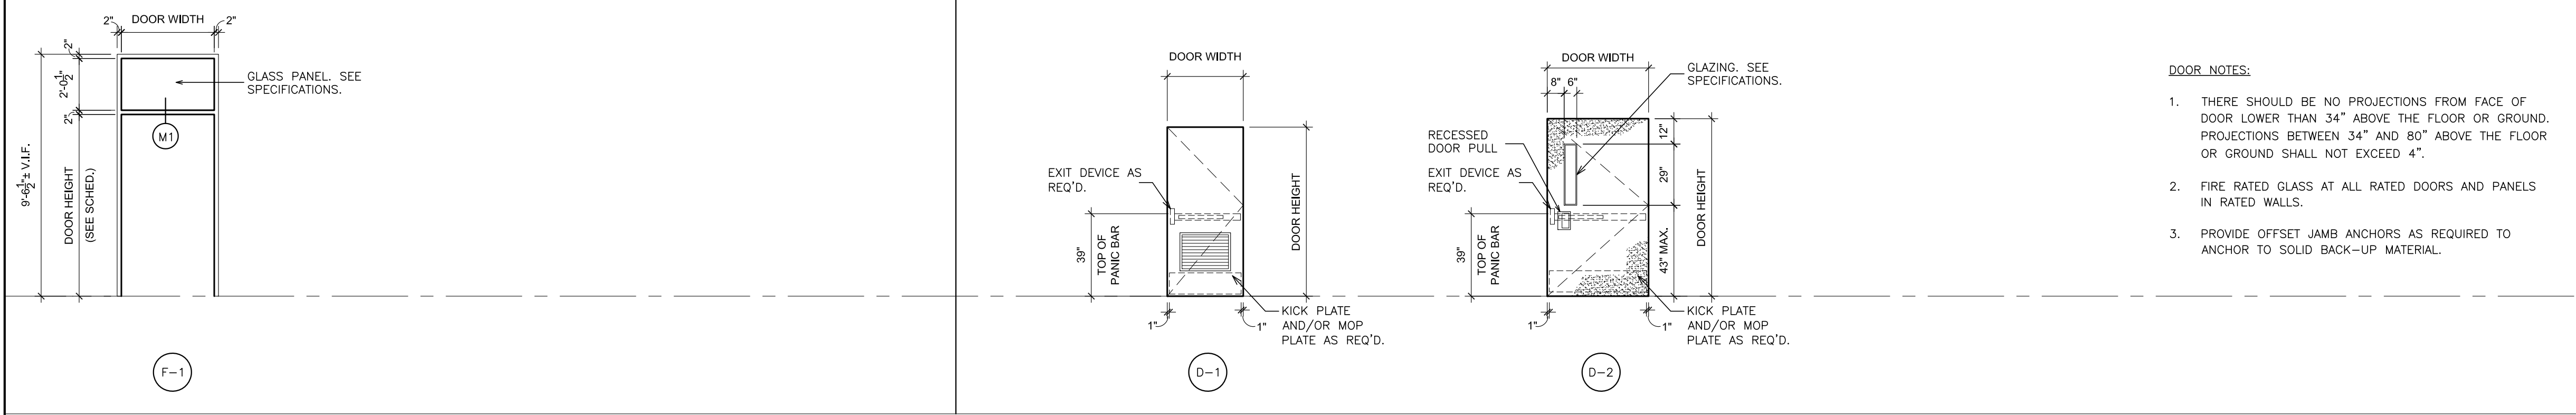


H1 DOOR HEAD SCALE: 3" = 1'-0"

J1 DOOR JAMB SCALE: 3" = 1'-0"


S1 DOOR SILL SCALE: 3" = 1'-0"

M1 MEETING RAIL SCALE: 3" = 1'-0"

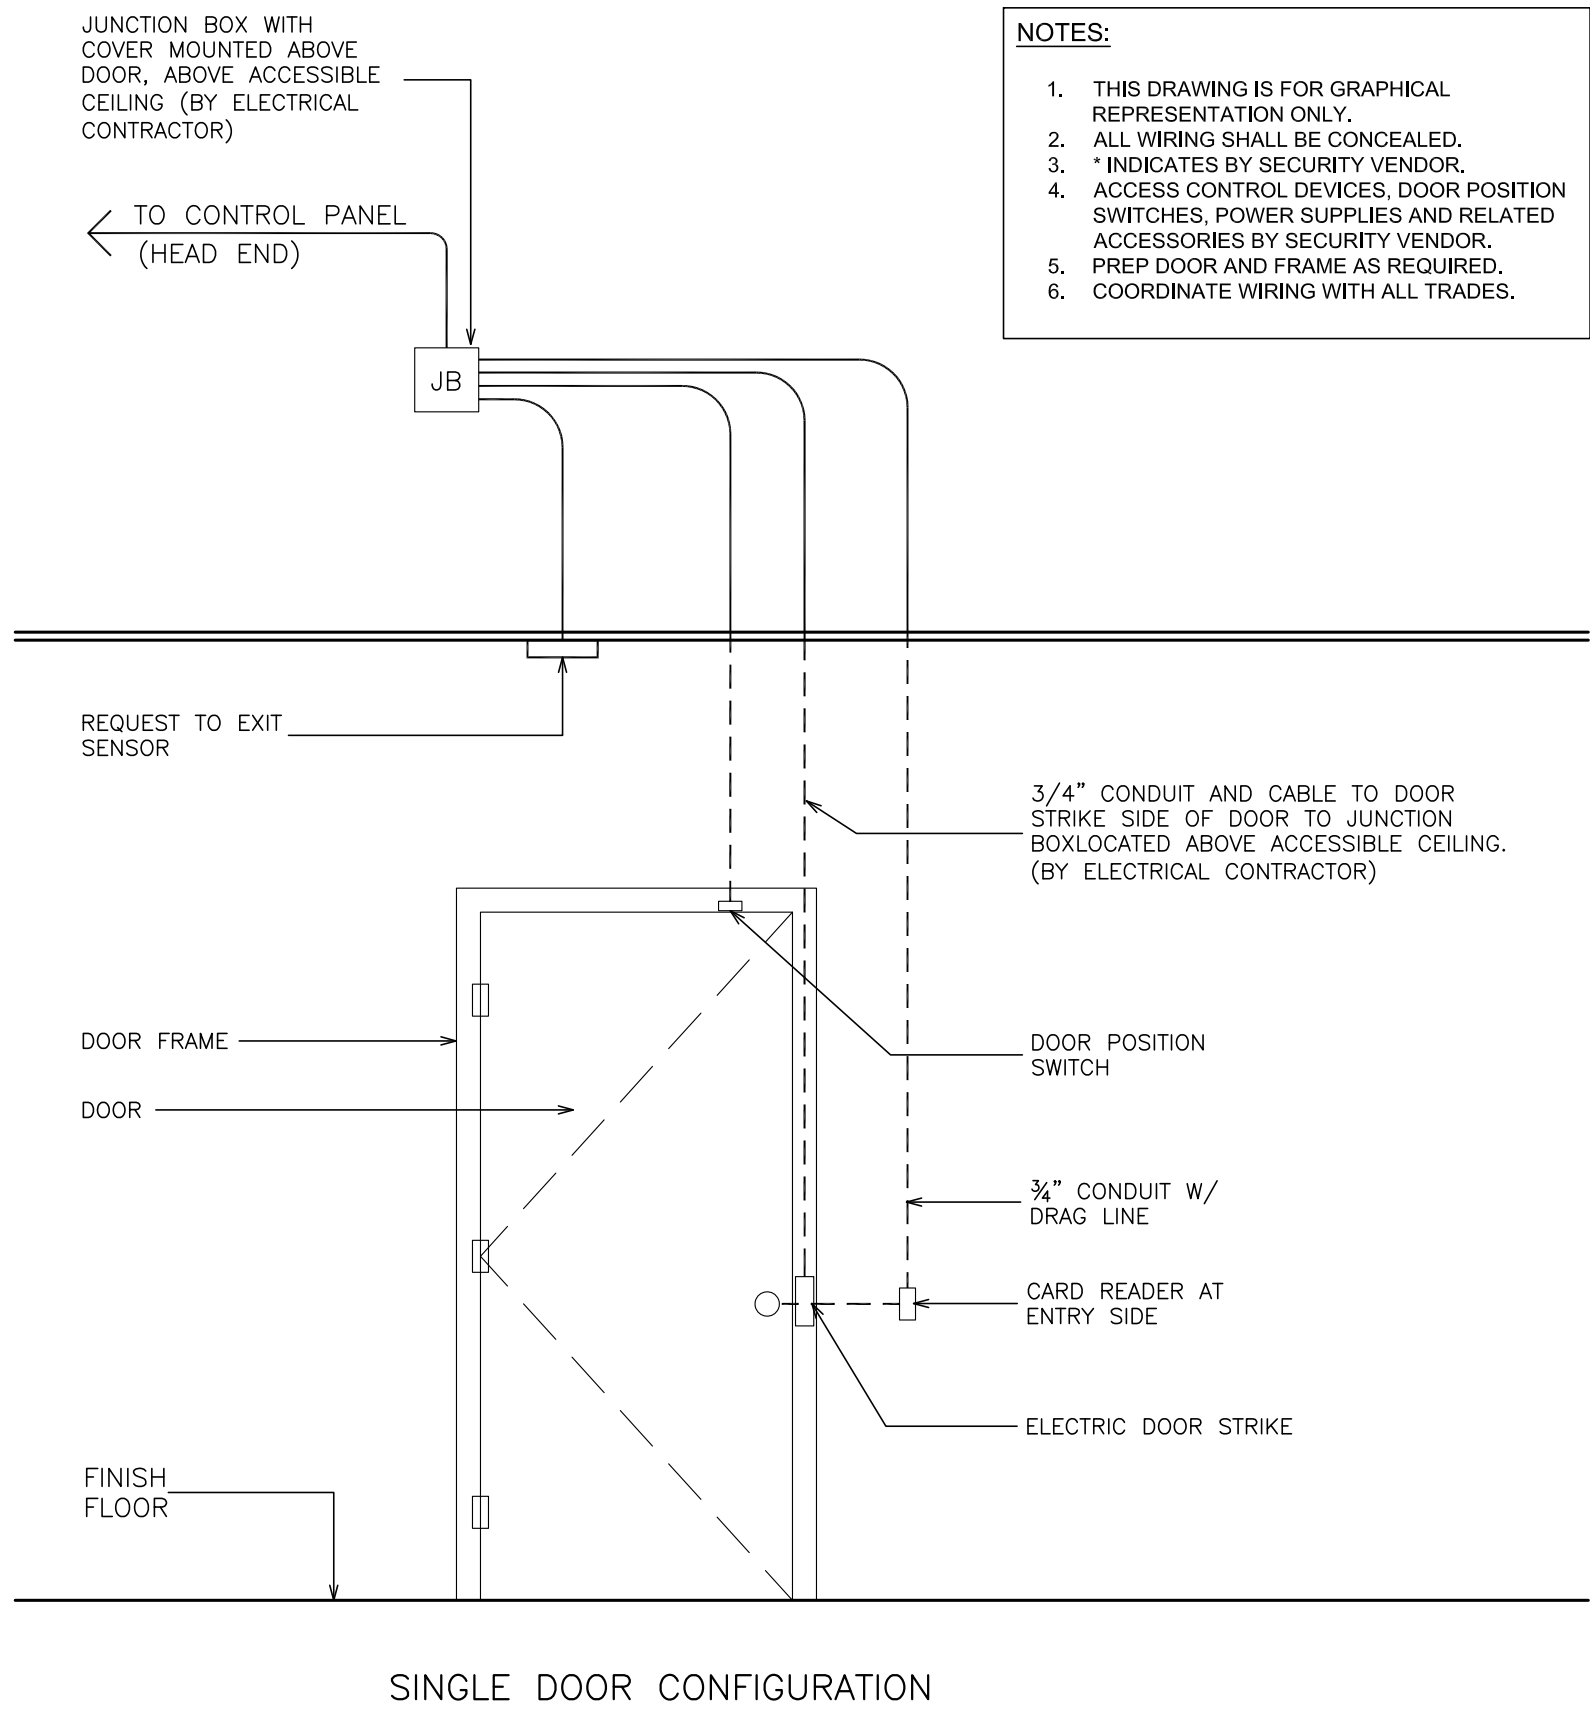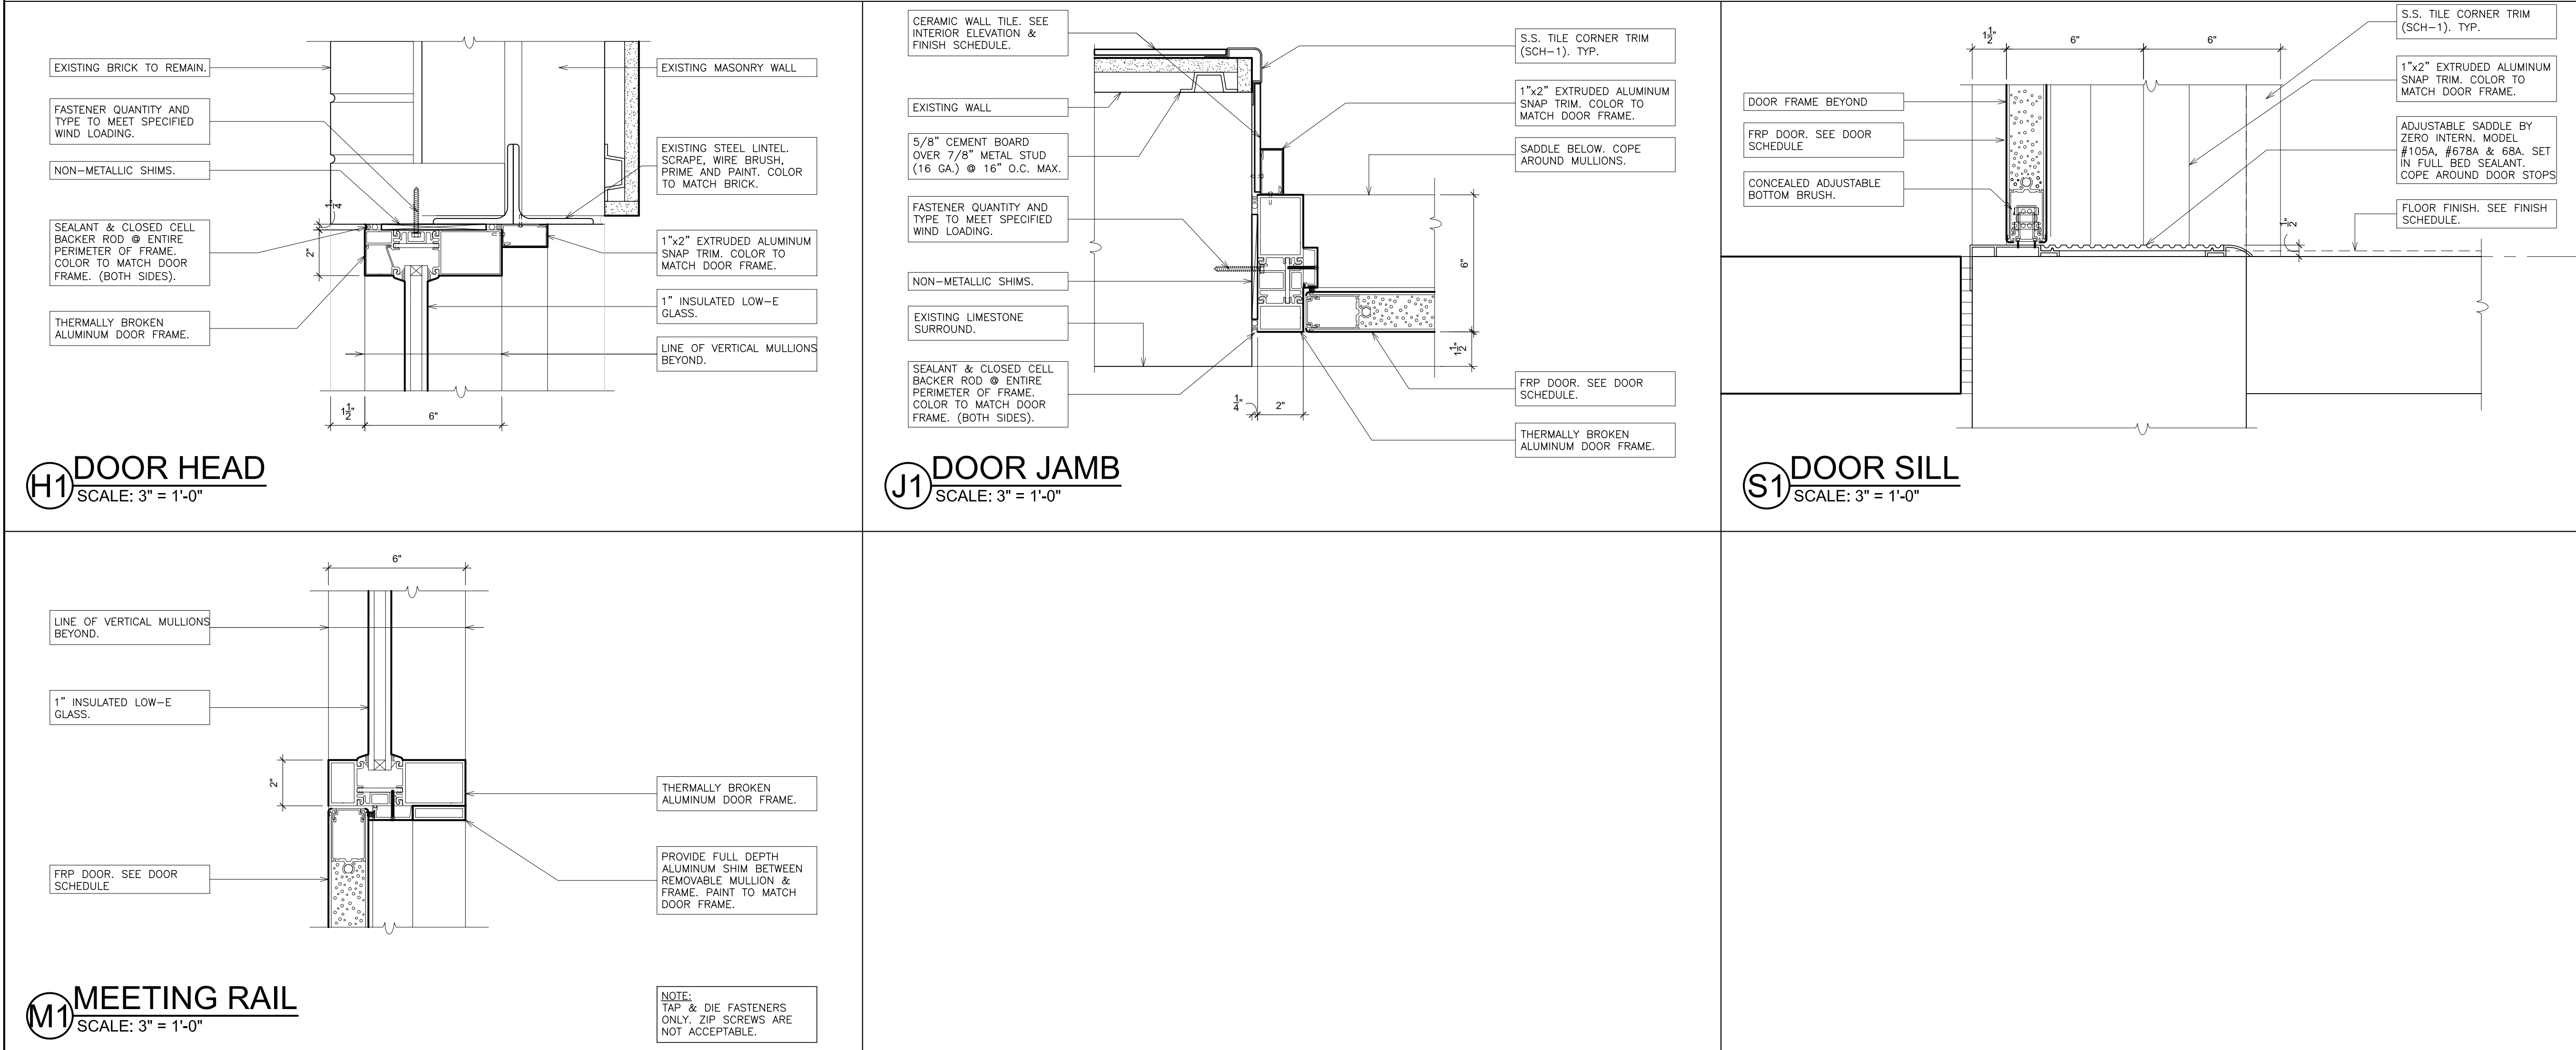

A1 TYPICAL DOOR ACCESS CONTROL SCALE: N.T.S.

FLOOR FINISH LEGEND

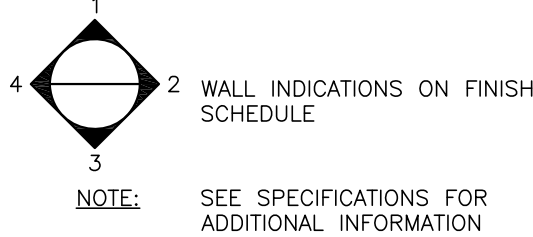

FINISH SCHEDULE

LEVEL	LINE	DESIGNATION	FLOOR	BASE (MAT.)	WALL 1	WALL 2	WALL 3	WALL 4	CLG.	TRIM					REMARKS
										DOORS	DOOR FRAMES	CABINETS	COUNTER TOPS	EDGING	
GREENVILLE ELEMENTARY SCHOOL	01	CAFETERIA	129	HVT-1&2	RB-1	WP-1,2,3,4 P-1	CT-1,2,3,4,5 P-1	WP-1,2,3,4 P-1	CT-1,2,3,4,5 P-1	ACT-1 P-2	-	PT-3&4	-	-	SCH-1 FOR TILE CORNERS COT-1 AT WINDOW STOOLS. SEE 7/A800.
	02	KITCHEN GALLEY	C13.3	HVT-1&2	RB-1	CT-1 P-1	CT-1,2,3,4,5 P-1	CT-1 P-1	CT-1 P-1	ACT-1 P-2	-	PT-3&4	-	-	SCH-1 FOR TILE CORNERS COT-1 AT WINDOW STOOLS. SEE 7/A800.
	03	CLASSROOM	C2	-	-	P-1	P-1	P-1	P-1	ACT-2 P-2	-	PT-3&4	-	-	-
	04	CORRIDOR	C11.2	-	-	P-1	P-1	P-1	P-1	ACT-2 P-2	-	-	-	-	VCT MATCH EXISTING ADJACENT TILE
	05														
	06														
	07														
	08														
	09														
	10														

FINISH SCHEDULE LEGEND

LEGEND	SIZE	MANUFACTURER	SERIES/MODEL NO / COLOR	DESCRIPTION	LOCATION / REMARKS
P-1	-	SHERWIN WILLIAMS	SW 7036 / ACCESSIBLE BEIGE	EGGSHELL PAINT	WALLS
P-2	-	SHERWIN WILLIAMS	SW 7757 / HIGH REFLECTIVE WHITE	FLAT PAINT	SOFFITS & CEILINGS
P-3	-	SHERWIN WILLIAMS	COLOR TO BE SELECTED BY ARCHITECT	SEMI-GLOSS DOOR FRAMES	CORRIDOR SIDE DOOR FRAMES
P-4	-	SHERWIN WILLIAMS	SW 6044 / OTTER	SEMI-GLOSS DOOR FRAMES	ROOM SIDE DOOR FRAMES
ACT-1	2'x2'x1/2"	ROCKFON	HYGIENIC PLUS / 31100 /LAY-IN	ACOUSTICAL CEILING TILE	CAFETERIA, GALLEY
ACT-2	2'x2'x1/2"	ROCKFON	ALASKA / 10100 /LAY-IN	ACOUSTICAL CEILING TILE	CLASSROOM, CORRIDOR
CT-1	3'x6"	DALTILE	CLASSIC/BISCUIT K175	GLAZED CERAMIC WALL TILE	MAIN COLOR. SEE ELEVATION.
CT-2	3'x6"	DALTILE	CLASSIC/MUSTARD 1012	GLAZED CERAMIC WALL TILE	ACCENT COLOR. SEE ELEVATION.
CT-3	3'x6"	DALTILE	CLASSIC/CURRENT SH17	GLAZED CERAMIC WALL TILE	ACCENT COLOR. SEE ELEVATION.
CT-4	3'x6"	DALTILE	CLASSIC/ORANGE BURST 1097	GLAZED CERAMIC WALL TILE	ACCENT COLOR. SEE ELEVATION.
CT-5	3'x6"	DALTILE	CLASSIC/CORNSILK 0160	GLAZED CERAMIC WALL TILE	ACCENT COLOR SEE ELEVATION.
SCH-1	1 1/2"	SCHLUTER	ECK-E / 8-E37 V2A EB 80/300 / BRUSHED STAINLESS STEEL	CORNER TRIM	CORNER TRIM FOR CAFETERIA & SERVERY ONLY
COT-1	-	CORIAN	DOESKIN	SOLID SURFACE WINDOW STOOL	WINDOW STOOL
WS	-	PATCRAFT	WELD ROD COLOR	SEAM WELD	
HVT-1	36"x36"	PATCRAFT	ADMIX / 00100 WHITE CORAL	HOMOGENEOUS TILE	FIELD COLOR
HVT-2	36"x36"	PATCRAFT	ADMIX / 00120 SEA STAR	HOMOGENEOUS TILE	ACCENT/BORDER COLOR
WP-1	-	P.S.I.	D439-60 / WALLABY	PLASTIC LAMINATED WALL PANEL	CAFETERIA -- MAIN COLOR
WP-2	-	P.S.I.	D307-6 / HOLLY BERRY	PLASTIC LAMINATED WALL PANEL	CAFETERIA -- ACCENT COLOR
WP-3	-	P.S.I.	D501-6 / ORANGE GROVE	PLASTIC LAMINATED WALL PANEL	CAFETERIA -- ACCENT COLOR
WP-4	-	P.S.I.	D417-18 / LAPIS BLUE	PLASTIC LAMINATED WALL PANEL	CAFETERIA -- ACCENT COLOR
RB-1	4"	JOHNSONITE	80 / FAWN	RUBBER BASE	
RBT-1	-	JOHNSONITE	80 / FAWN	RUBBER TRANSITION STRIP	

CAFETERIA
(129)

CORRIDOR
(C11.2)

 
 
GALLEY
(C13.3)

CORRIDOR
(C11)

REMOVE VCT FLOORING TO
NEXT FULL TILE. PROVIDE NEW
VCT TILE TO MATCH EXISTING
ADJACENT TILE.

CLASSROOM
(C2)

1 PARTIAL FLOORS FLOOR FINISH PLAN
SCALE: 1/4" = 1'-0"



REMOVE VCT FLOORING.
REMOVE ADHESIVE IN ITS ENTIRETY
DOWN TO SLAB AND TO THE
SATISFACTION OF THE FLOORING
MANUFACTURER.

EXISTING CONCRETE SLAB ON
DECK/ON GRADE.

3 EXISTING FLOOR ASSEMBLY
SCALE: 1 1/2" = 1'-0"

RESILIENT FLOOR TILE.

ADHESIVE.

CEMENT-BASED UNDERLAYMENT.

EXISTING CONCRETE SLAB ON
DECK/ON GRADE.

4 REVISED FLOOR ASSEMBLY
SCALE: 1 1/2" = 1'-0"

CORRIDOR

EXISTING FLOORING

RUBBER TRANSITION STRIP

CLASSROOM / ROOM

5 TYPICAL DETAIL- EXIST. FLOOR TO
RESILIENT FLOOR TRANSITION
SCALE: 1 1/2" = 1'-0"

CORRIDOR

EXISTING FLOORING

RUBBER FLOORING

RESILIENT FLOORING

CLASSROOM / ROOM

6 TYPICAL DETAIL- EXIST. FLOOR TO
RESILIENT FLOOR TRANSITION
SCALE: 1 1/2" = 1'-0"

PAINT GYPSUM BOARD
(SEE FINISH SCHEDULE)

BULL NOSE EDGE AT
UPPERMOST TILE

COVE BASE TILE

SECTION

7 TILE DETAIL - WALLS (TYP.)
NOT TO SCALE

PAINT GYPSUM BOARD
(SEE FINISH SCHEDULE)

BULL NOSE EDGE AT
UPPERMOST TILE

START POINT OF TILE.
ALIGN WITH EXISTING TILE
ON COLUMN AND WORK
DOWN TOWARDS FLOOR.

EXISTING

PART ELEVATION (CT AT GVS)

AS PER USA CONGRESS ARCHITECTURAL WORKS COPYRIGHT
PROTECTION ACT OF 1990 ALL IDEAS AND DESIGNS INCLUDING
DERIVATIVES THEREOF, ALL DRAWINGS AND SPECIFICATIONS
CONSTITUTE THE ORIGINAL COPYRIGHT WORK BY FULLER AND
DANKELO, P.C. (F&D). THE DRAWINGS AND SPECIFICATIONS AS
INSTRUMENTS OF SERVICE BY F&D ARE CREATED BY F&D FOR
THIS PROJECT ONLY AND REMAIN THE PROPERTY OF F&D. ANY REPRODUCTION WITHOUT THE PRIOR CONSENT OF
F&D IS PROHIBITED.

48 KNOXWOOD ROAD ELLENWOOD NEW YORK 10833
TEL 914.899.4444 FAX 914.899.1919
Copyright 2025 All Rights Reserved by FULLER & DANKELO, P.C.

FULLER
DANKELO
P.C.
ARCHITECTS
PLANNERS

LICENSE EXP. DATE: 02-28-2027

 
 
 
 
S.E.D. CONTROL NUMBER:
GREENVILLE ELEMENTARY SCHOOL
66-04-06-03-0-008-021


PROJECT TITLE
EDGEMONT SCHOOL DISTRICT
GREENVILLE ELEMENTARY SCHOOL
CAFETERIA RENOVATION
DRAWING TITLE
PARTIAL FINISH FLOOR PLAN, FINISH LEGEND,
FINISH SCHEDULE AND DETAILS

01-31-2025 BID
01-10-2022 SED SUBMISSION
DATE ISSUED TO

SHEET SIZE
30"x42"
SCALE
AS NOTED
DRAWING NO.
A800


DRAWN BY
F & D
FILE NO.
24529.01

SIGNAGE LEGEND			
	INDICATES SIGN TYPE A		INDICATES SIGN TYPE C
	INDICATES LOCATION OF SIGN		INDICATES LOCATION OF SIGN
	INDICATES SIGN TYPE B		INDICATES SIGN TYPE D
	INDICATES LOCATION OF SIGN		INDICATES LOCATION OF SIGN
NUMERICAL CLASSROOM SIGN		GRAPHIC SIGN	
DENOTES ROOM NUMBER TO BE PLACED ON SIGN		SIGN DESCRIPTOR	
ROOM FUNCTION SIGN		SPECIALTY SIGN	
SIGN DESCRIPTOR		SIGN DESCRIPTOR	

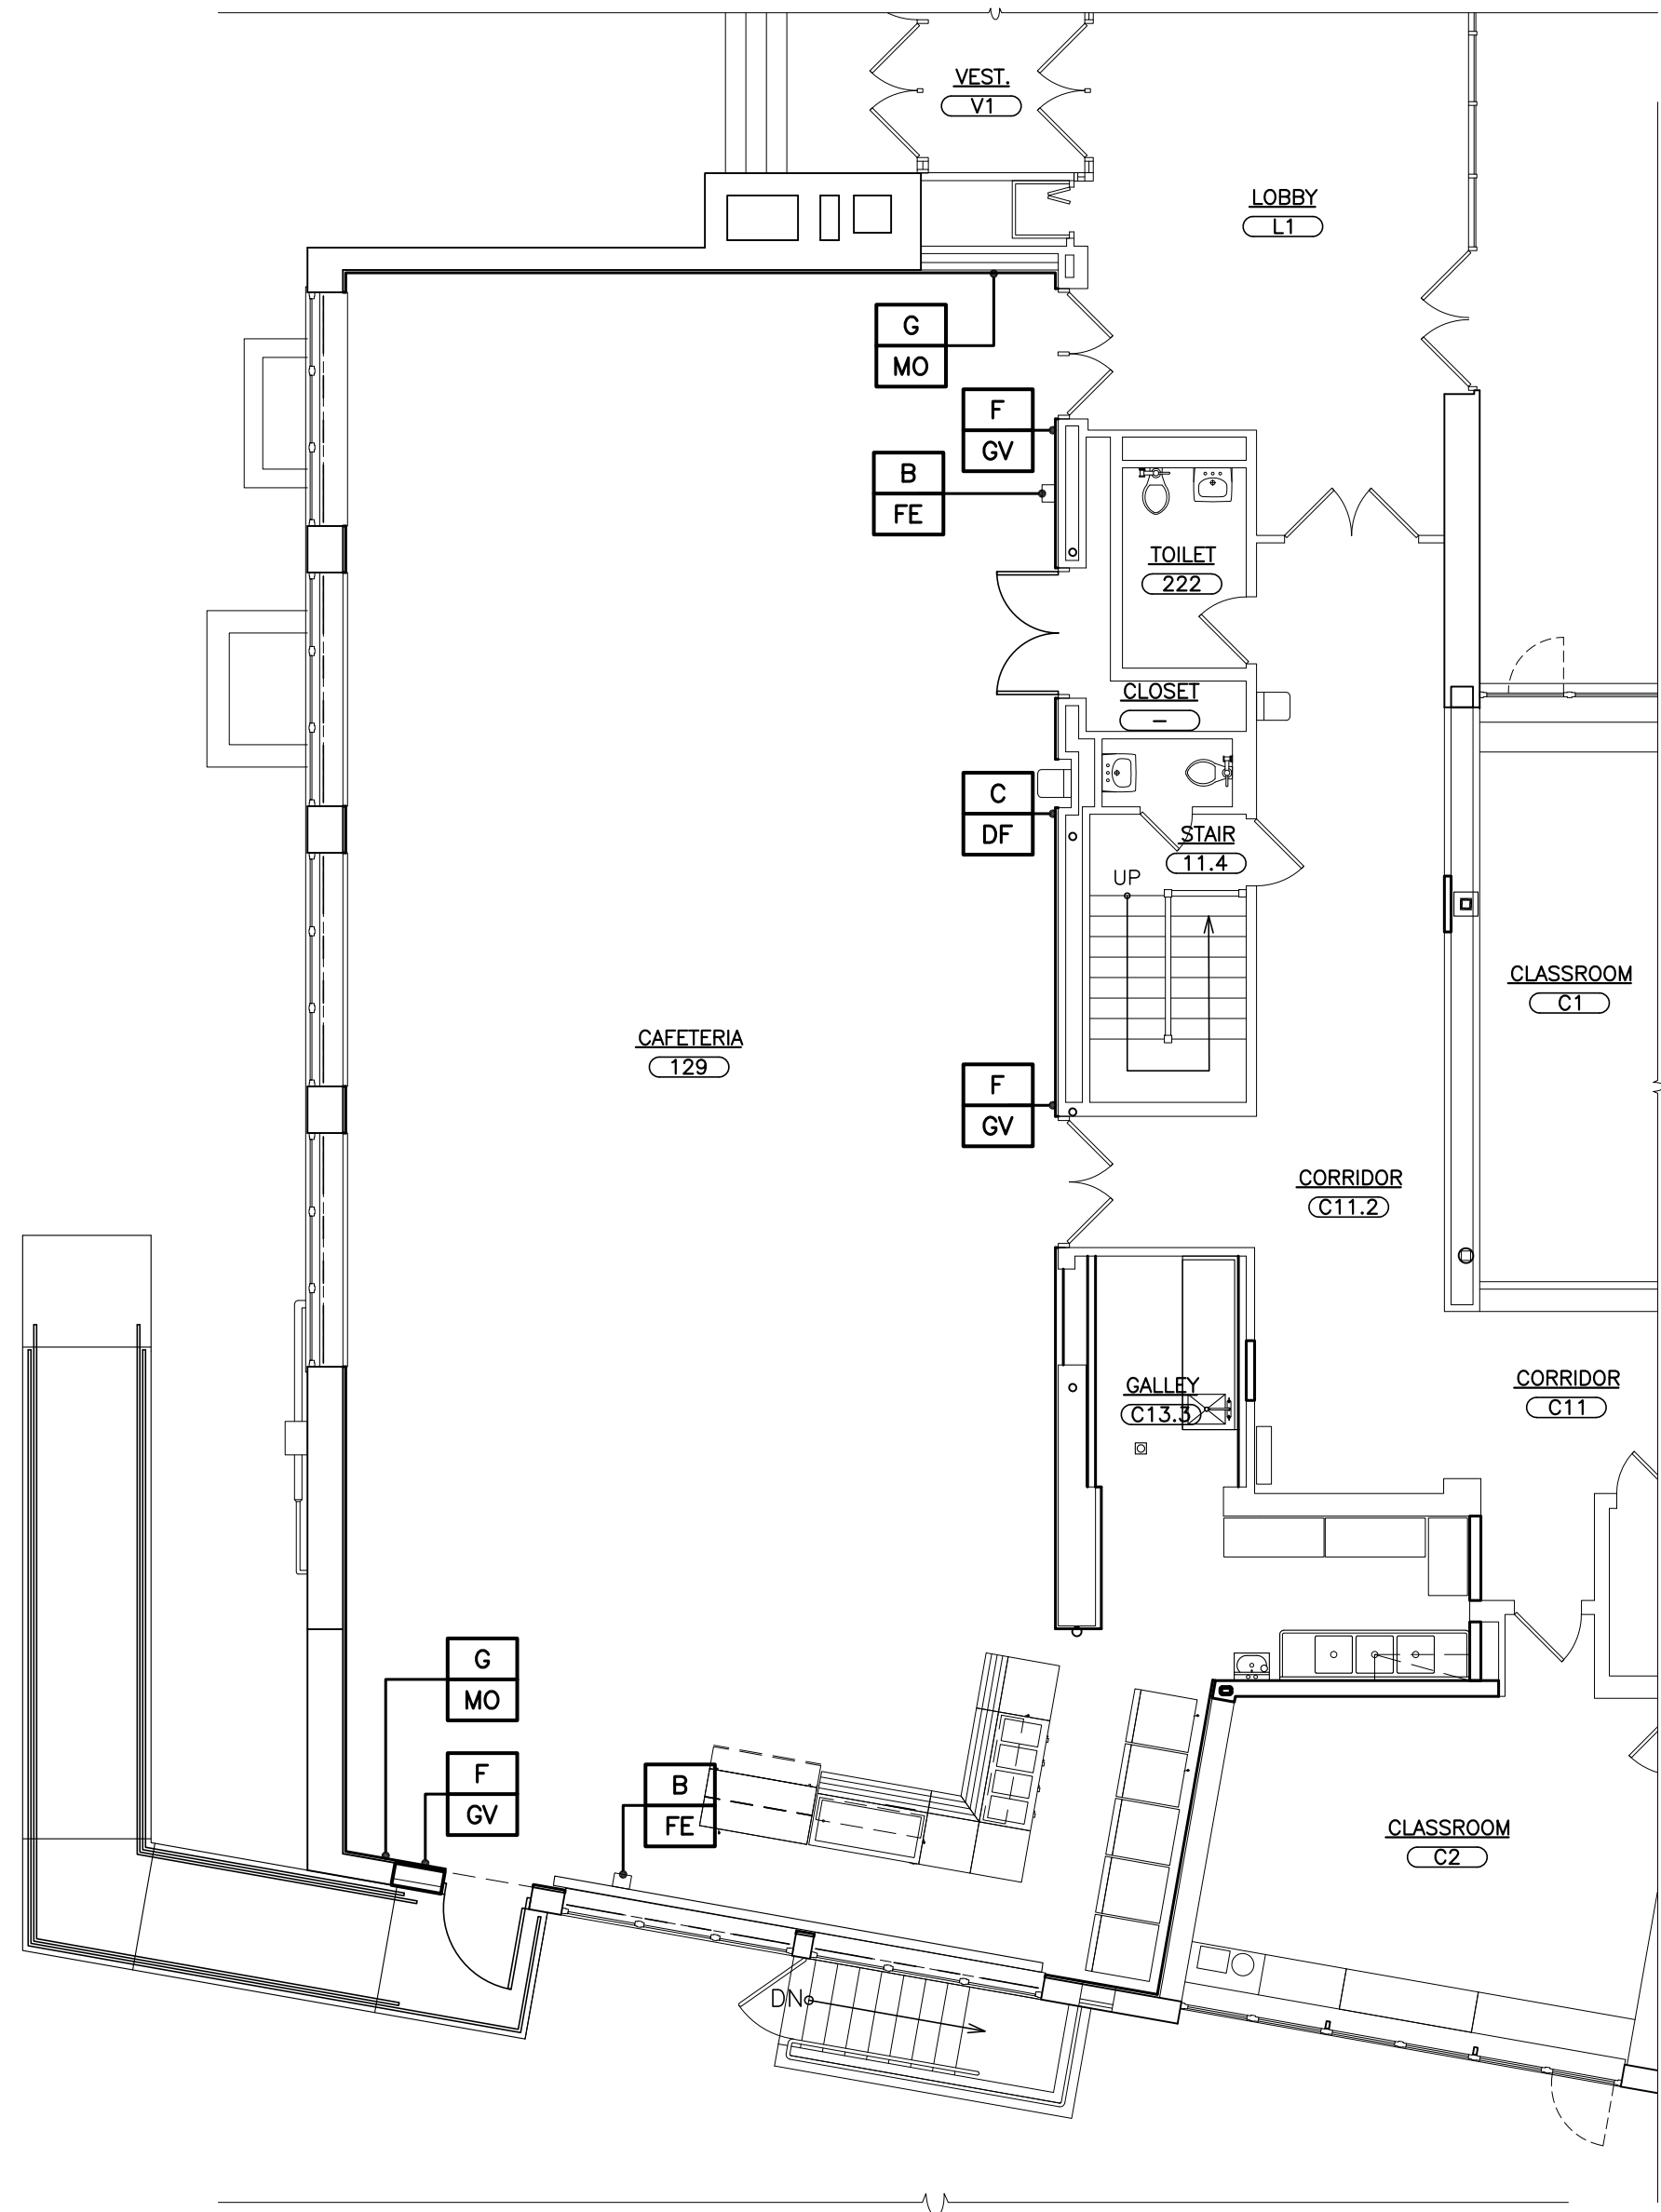

1 PARTIAL FIRST FLOOR SIGNAGE PLAN
SCALE: 1/8" = 1'-0"


SIGN TYPES: SCALE: N.T.S.

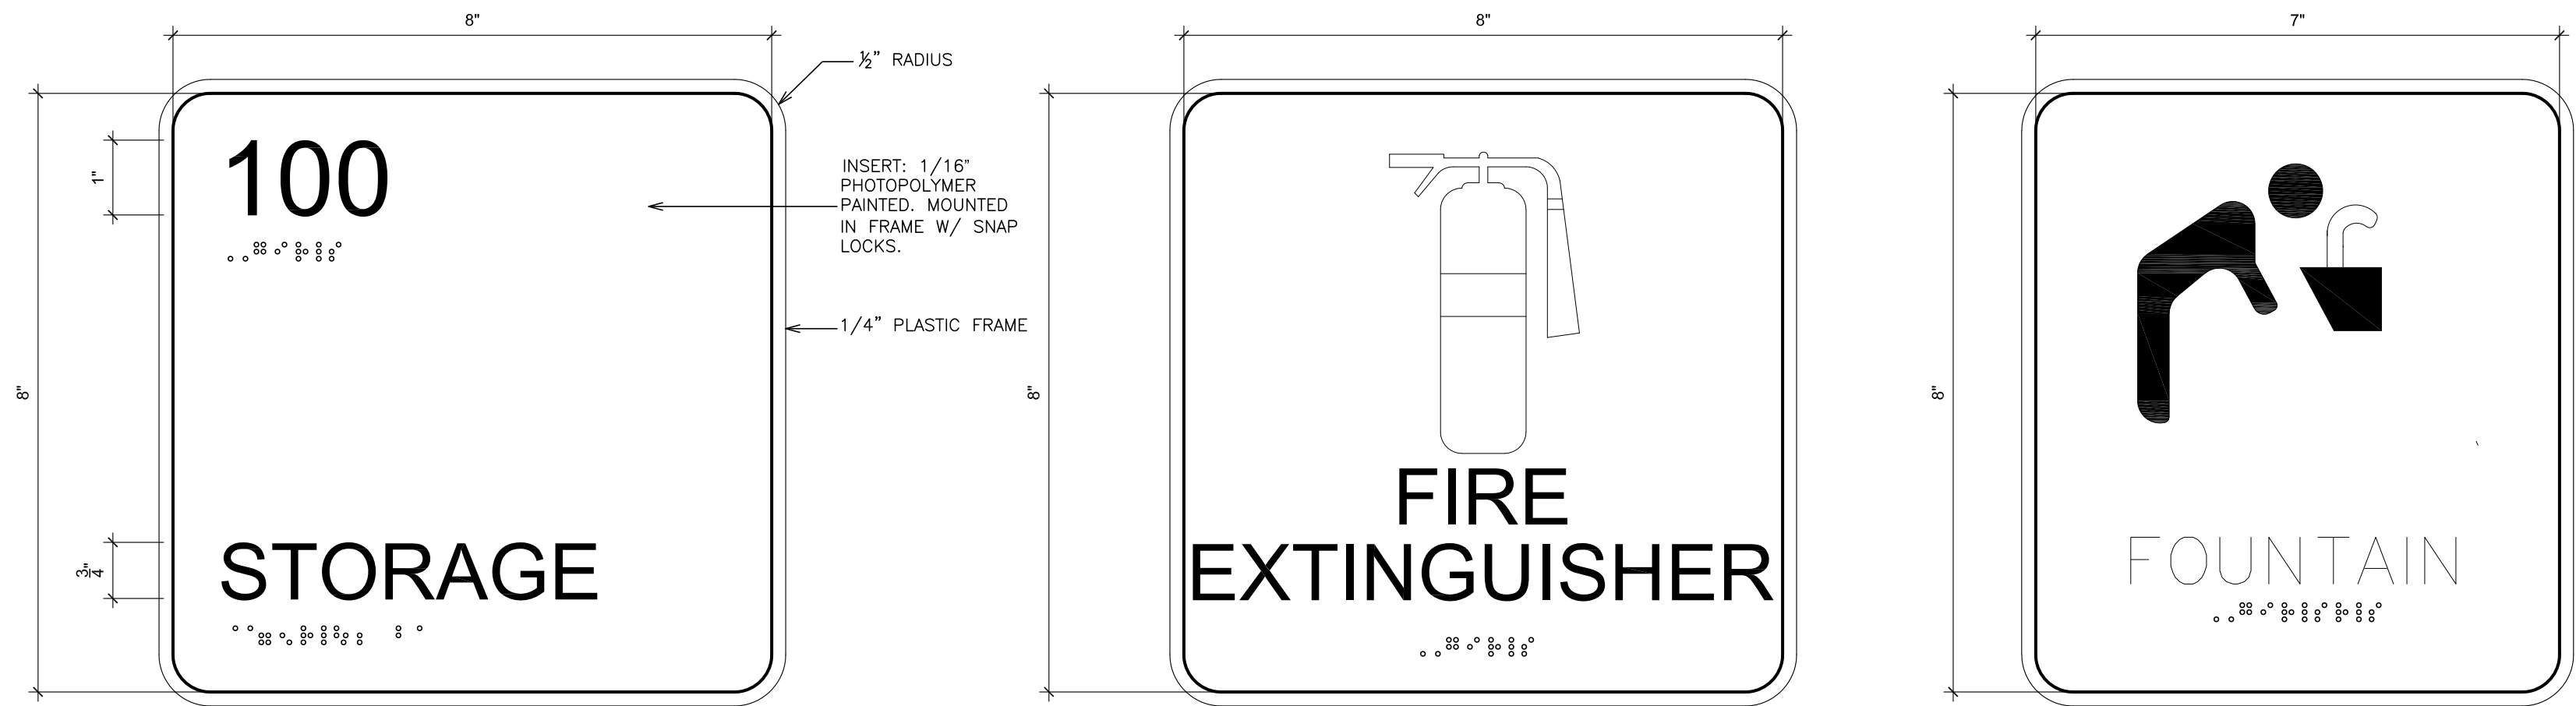

SPACE NAME
SIGN TYPE A
(PLAN DESIGNATION *)


FIRE EXTINGUISHER
SIGN TYPE B
PLAN DESIGNATION (FE)

FOUNTAIN
SIGN TYPE C
PLAN DESIGNATION (DF)

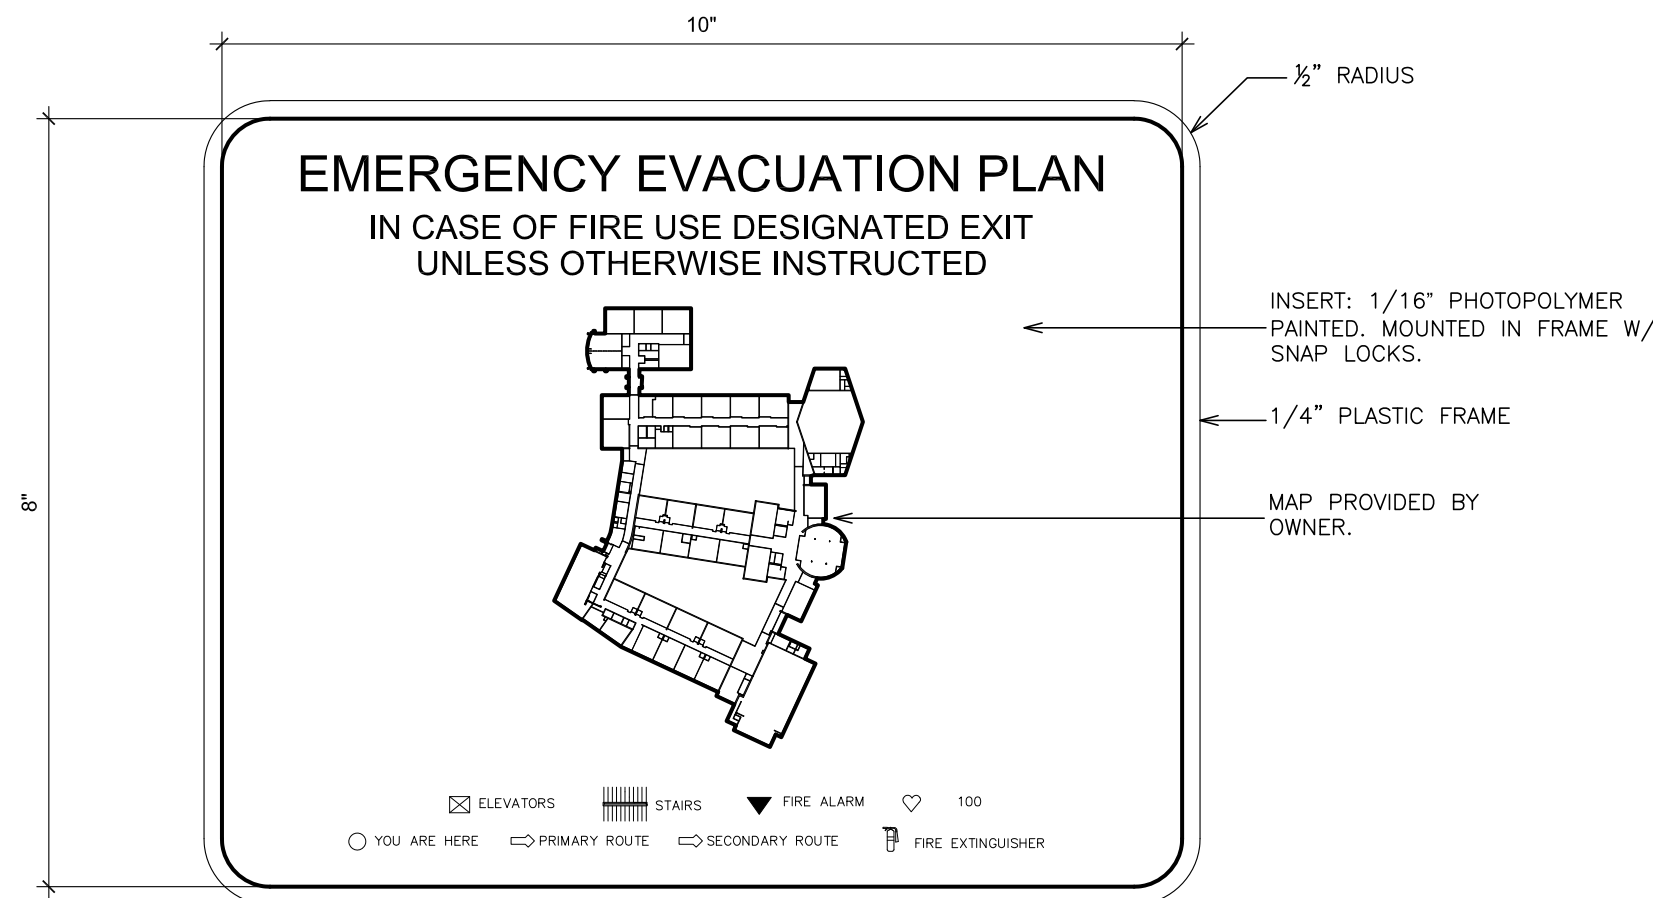

EMERGENCY EVACUATION PLAN
SIGN TYPE F
(PLAN DESIGNATION GV)


NOTE:
CONTRACTOR TO SHOW EVACUATION
ROUTES FROM EACH ROOM.

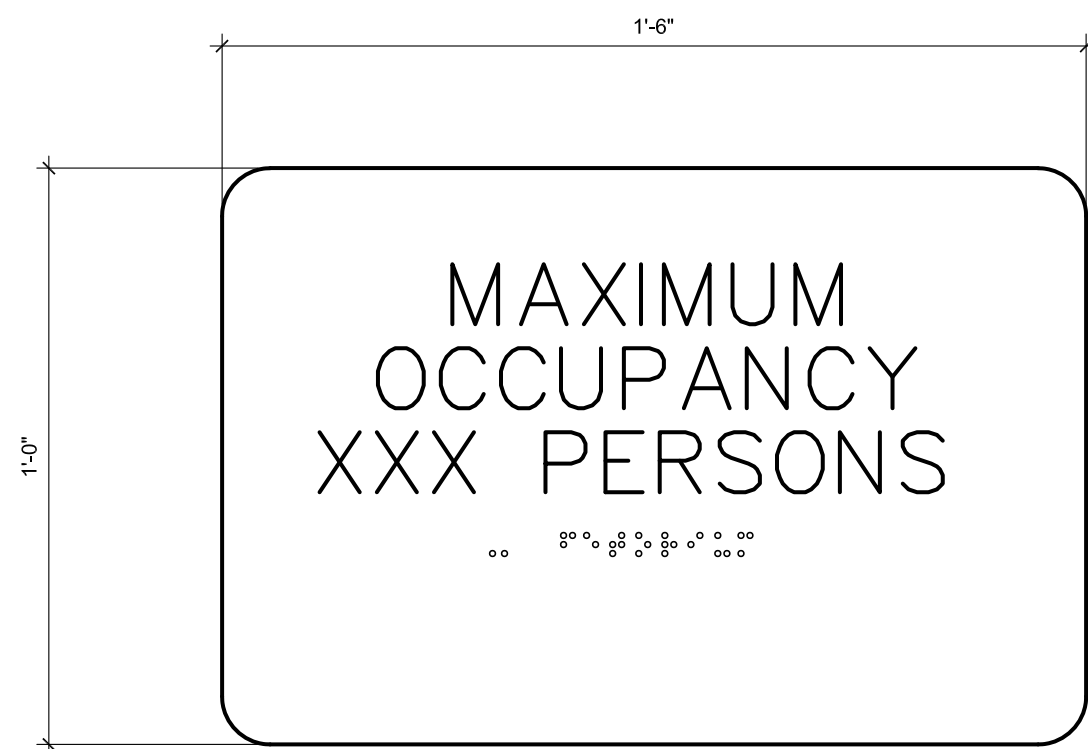

MAXIMUM OCCUPANCY
SIGN TYPE G
PLAN DESIGNATION (MO)


SIGNAGE MOUNTING LOCATIONS: NOT TO SCALE

TYPICAL SECTION OF SIGN

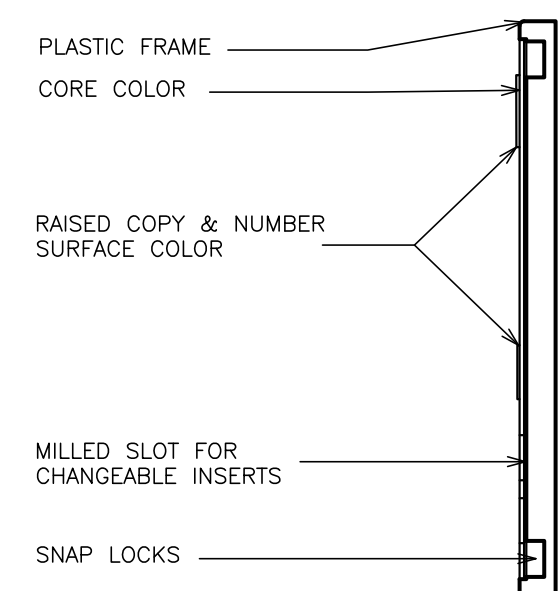


SECTION


MULTIPLE SIGNS WHERE APPLICABLE

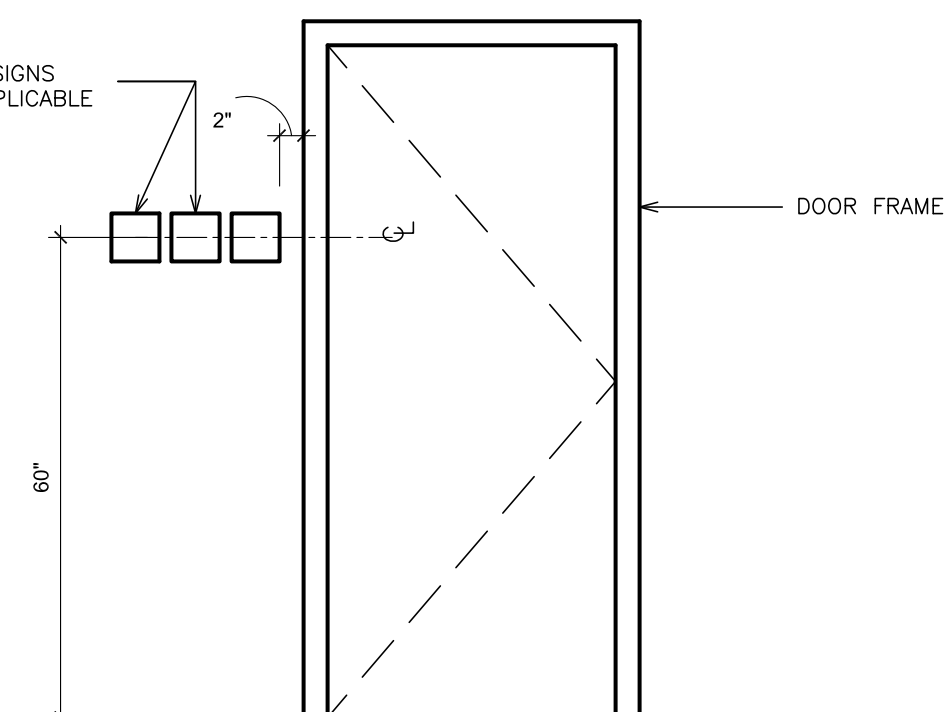


TYPE A -- SIGN LOCATION AT DOOR (TYP.)

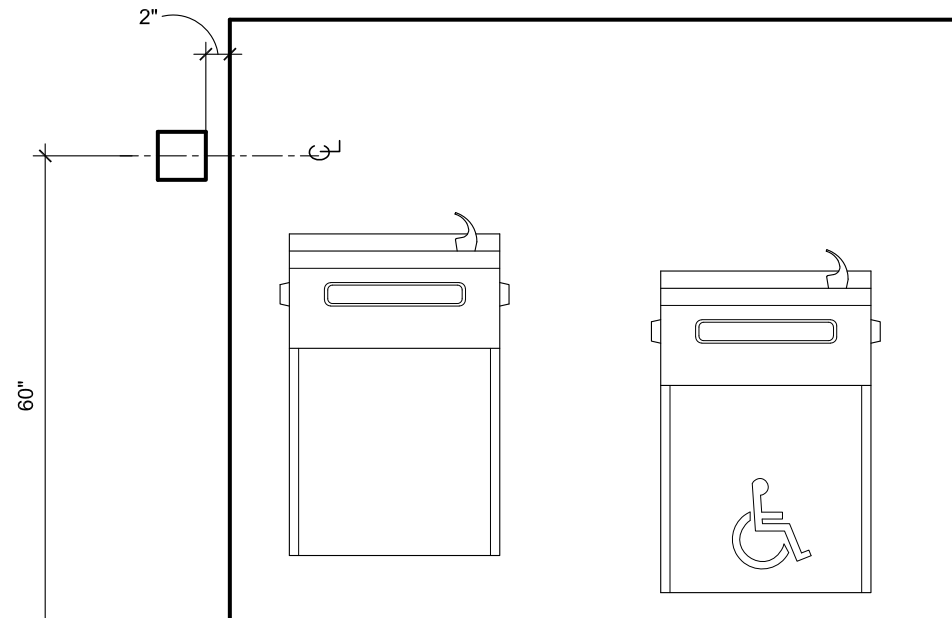

TYPE C -- SIGN LOCATION AT WATER COOLER

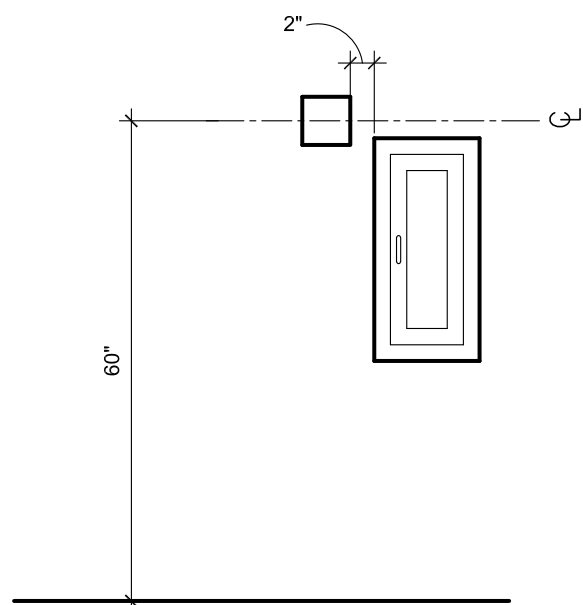

TYPE B -- SIGN LOCATION AT
FIRE EXTINGUISHER (TYP.)

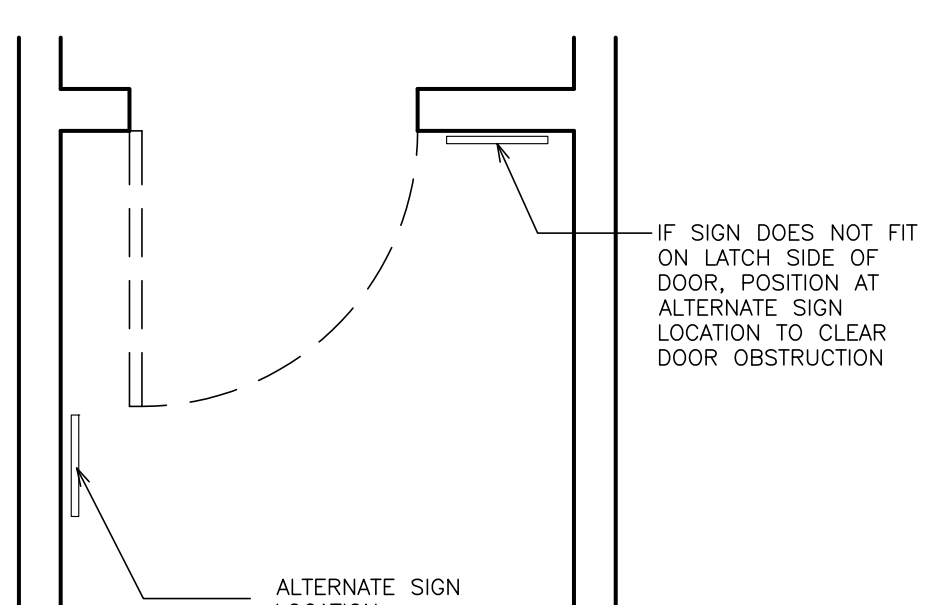

TYPE A -- SIGN LOCATION

NOTES:

- SIGN LAYOUT IS TYPICAL FOR ALL SIGNS. (ALL SIGNS SHALL HAVE BRAILLE AND RAISED LETTERS/SYMBOLS -- SEE TYPICAL SIGN SECTION)
- SIGNAGE SHALL COMPLY WITH NEW YORK STATE-- ICC/ANSI, A117.1-2009
- SIGN TEXT AND ROOM NUMBERING CONVENTION SHALL BE DETERMINED BY SCHOOL DISTRICT. ROOM MAY HAVE MULTIPLE SIGNS. SEE PLANS FOR LOCATION.
- SIGN LOCATION IS GENERALLY OUTSIDE OF ROOM. VARIATIONS MAY EXIST. SEE SIGNAGE PLANS FOR LOCATIONS.
- PROVIDE FIRE EVACUATION SIGNS IN ALL CLASSROOM/STUDENT SPACES.
- MAXIMUM OCCUPANCY COUNT SHALL MATCH EXISTING. OBTAIN APPROVAL FROM SCHOOL DISTRICT AND FIRE MARSHALL.
- MATCH COLORS AND FONTS OF EXISTING SIGNS IN GYMNASIUM WING.
- WHERE NEW SIGNS REPLACE EXISTING; CONTRACTOR SHALL REMOVE EXISTING.

AS PER USA CONGRESS ARCHITECTURAL WORKS COPYRIGHT PROTECTION ACT OF 1990 ALL IDEAS AND DESIGNS INCLUDING DERIVATIVES THEREOF, ALL DRAWINGS AND SPECIFICATIONS CONSTITUTE THE ORIGINAL COPYRIGHT WORK BY FULLER AND DANIELO, P.C. (F&D). THE DRAWINGS AND SPECIFICATIONS AS INSTRUMENTS OF SERVICE BY F&D ARE CREATED BY F&D FOR THIS PROJECT ONLY AND REMAIN THE PRODUCT AND PROPERTY OF F&D. ANY REPRODUCTION WITHOUT THE PRIOR CONSENT OF F&D IS PROHIBITED.

48 KENILWOOD ROAD ELMSFORD NEW YORK 10523
TEL 914.899.4444 FAX 914.899.1919
Copyright 2025 All Rights Reserved by FULLER & DANIELO, P.C.

FULLER
DANIELO
P.C.
ARCHITECTS
PLANNERS

LICENSE EXP. DATE: 02-28-2027

S.E.D. CONTROL NUMBER:
GREENVILLE ELEMENTARY SCHOOL
66-04-06-03-0-008-021

PROJECT TITLE
EDGEMONT SCHOOL DISTRICT
GREENVILLE ELEMENTARY SCHOOL
CAFETERIA RENOVATION
DRAWING TITLE
SIGNAGE PLANS & SIGNAGE TYPES

01-31-2025 BID
01-19-2022 SED SUBMISSION
DATE ISSUED TO

SHEET SIZE
30"x42"

SCALE
AS NOTED

DRAWN BY
F & D

FILE NO.
24529.01

AS PER USA CONGRESS ARCHITECTURAL WORKS COPYRIGHT PROTECTION ACT OF 1990 ALL IDEAS AND DESIGNS INCLUDING DERIVATIVES THEREOF, ALL DRAWINGS AND SPECIFICATIONS CONSTITUTE THE ORIGINAL COPYRIGHT WORK BY FULLER AND D'ANGELO, P.C. (F&O). THE DRAWINGS AND SPECIFICATIONS AS INSTRUMENTS OF SERVICE BY F&O ARE CREATED BY F&O FOR THIS PROJECT ONLY AND REMAIN THE PRODUCT AND PROPERTY OF F&O. ANY REPRODUCTION WITHOUT THE PRIOR CONSENT OF F&O IS PROHIBITED.



NOTE:
PROVIDE ANCHOR RODS IN ACCORDANCE WITH ASTM F1554



NOTE:
ALL STRUCTURAL ELEMENTS, SIZES, AND
LOCATION ARE TO BE VERIFIED IN FIELD BY
CONTRACTOR BEFORE ANY REMOVALS OR
RENOVATION WORK IS DONE. (TYP.)

FULLER
D'ANGELO
P.C.

ARCHITECTS
PLANNERS

LICENSE EXP. DATE: 02-28-2027

S.E.D. CONTROL NUMBER:
GREENVILLE ELEMENTARY SCHOOL
66-04-06-03-0-008-021

PROJECT TITLE	DRAWING TITLE
EDGEMONT SCHOOL DISTRICT GREENVILLE ELEMENTARY SCHOOL CAFETERIA RENOVATION	PARTIAL FIRST FLOOR FRAMING PLAN


01-31-2025	BID
01-10-2022	SED SUBMISSION
DATE	ISSUED TO

SHEET SIZE 30"x42"	DRAWING NO.
-----------------------	-------------


SCALE
AS NOTED

S1

AS NOTED	
DRAWN BY F & D	FILE NO. 24529.0

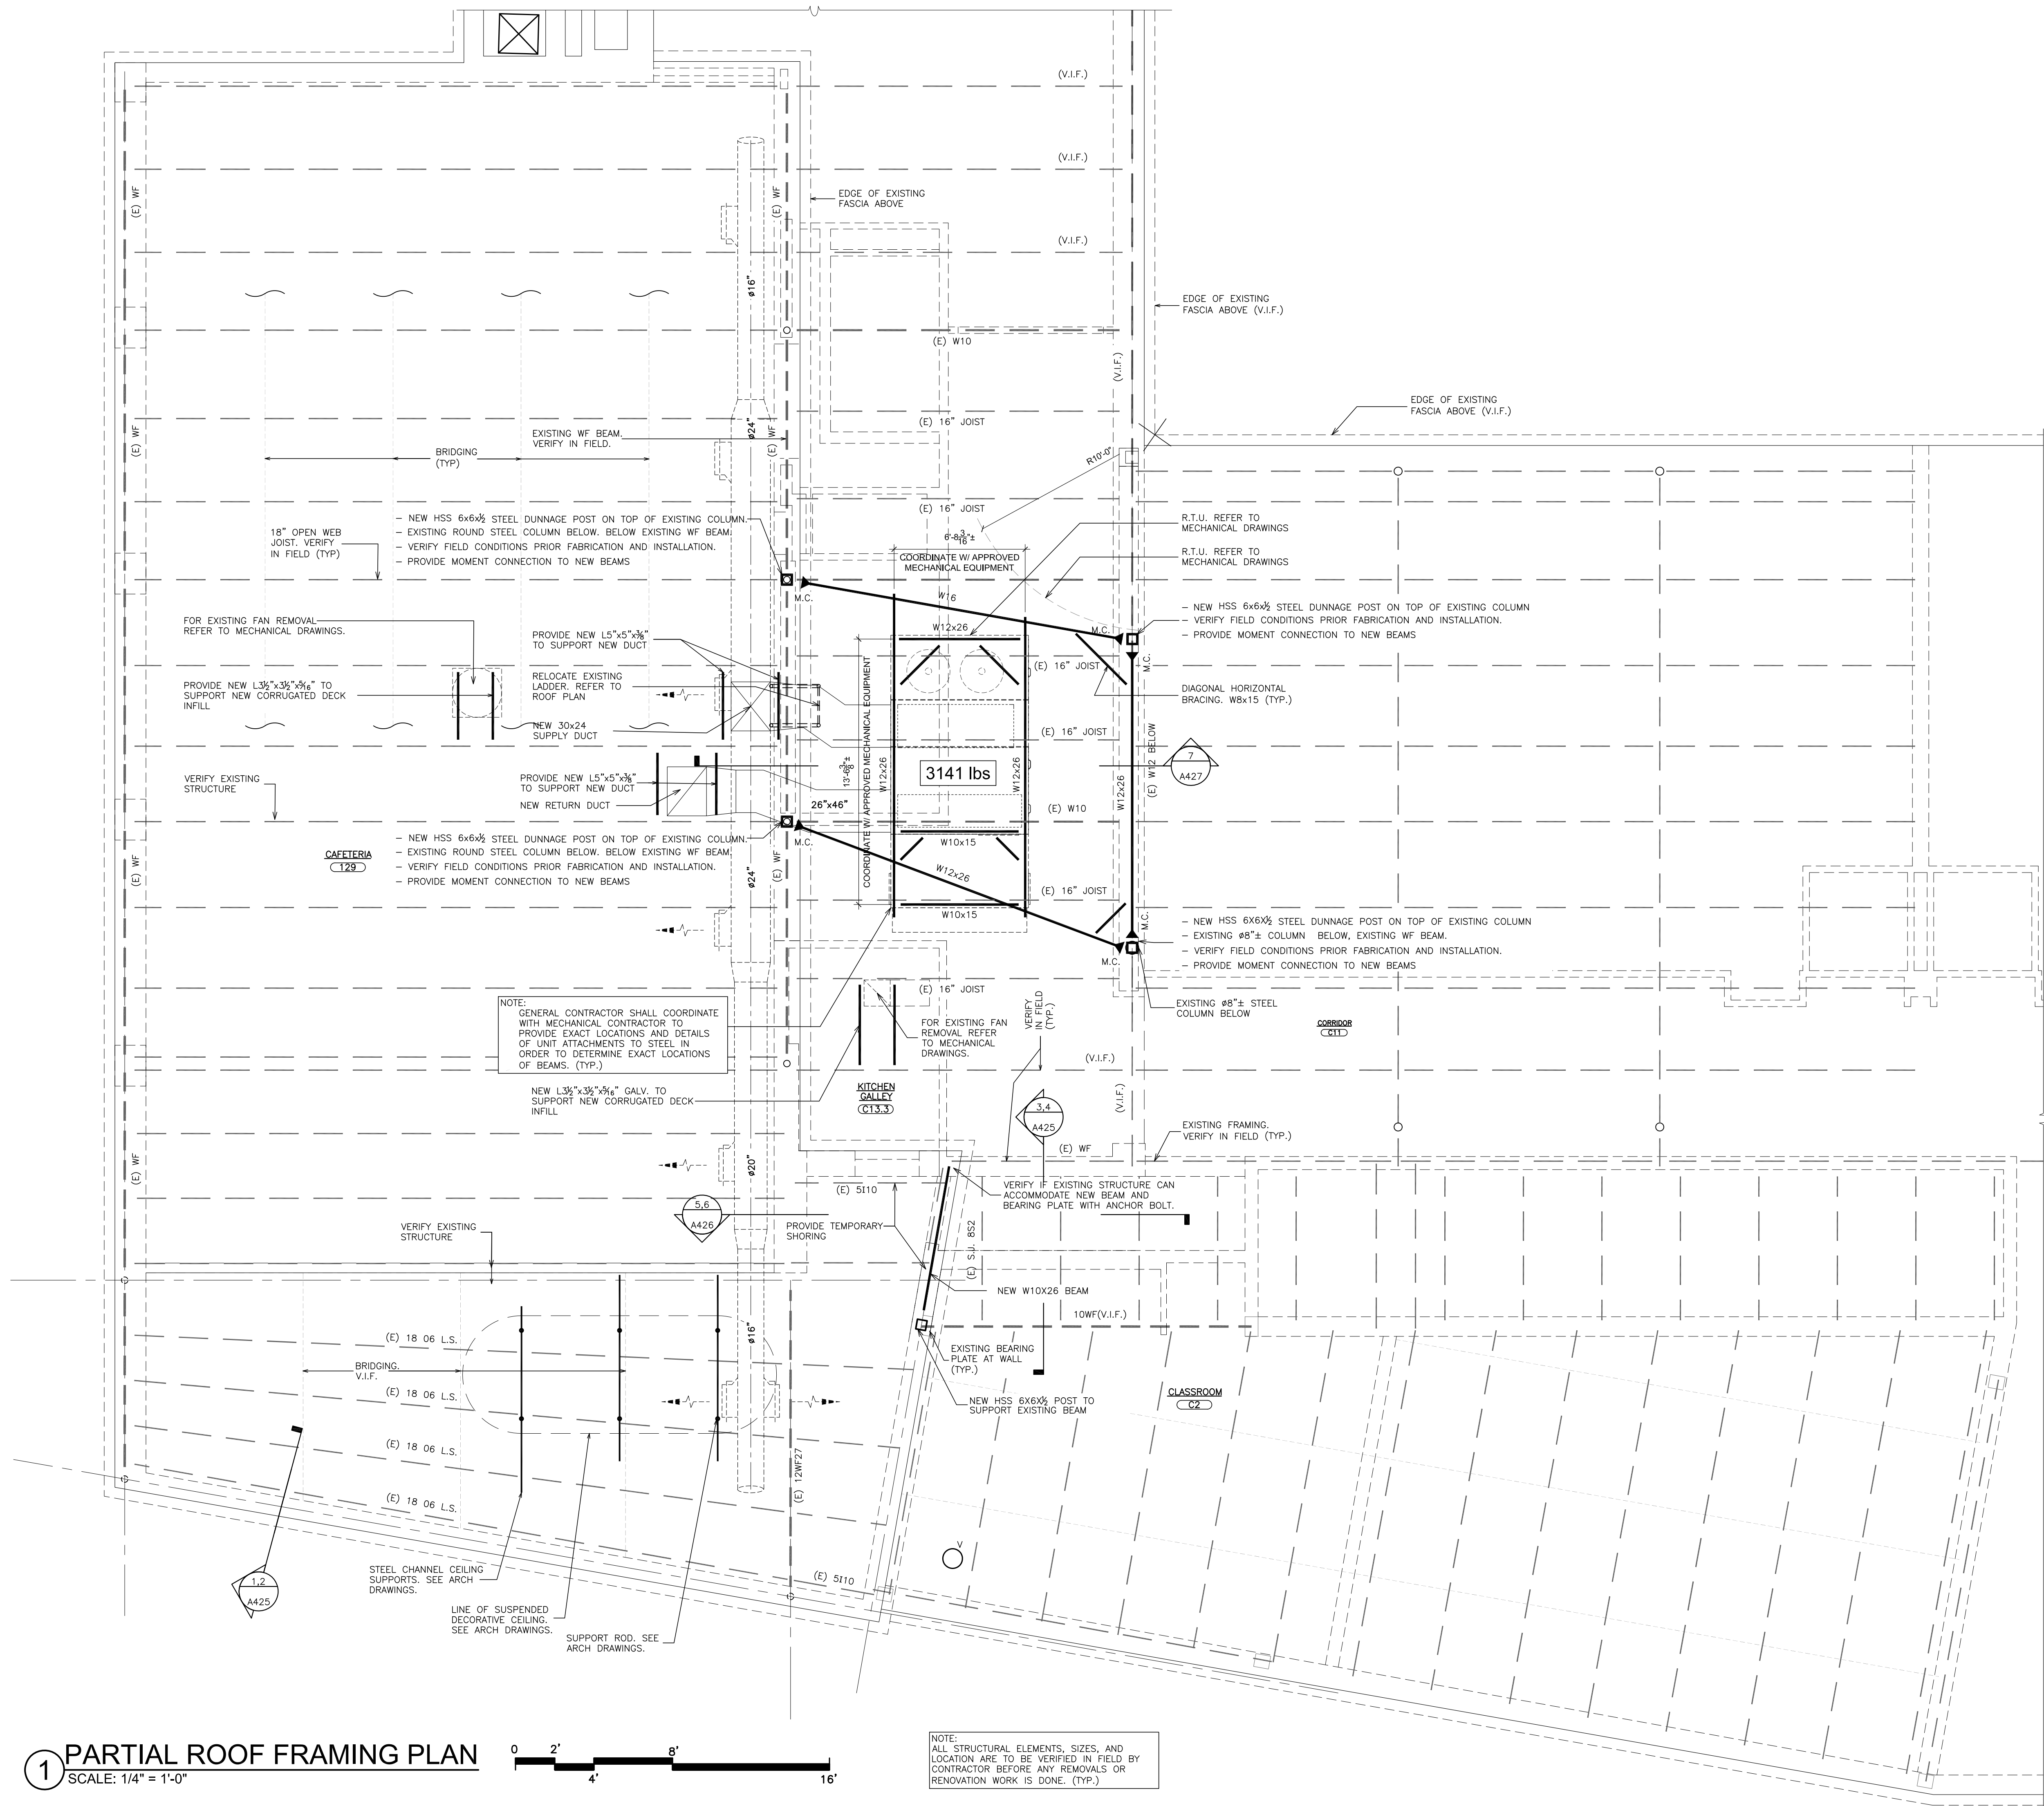

1 PARTIAL ROOF FRAMING PLAN
SCALE: 1/4" = 1'-0"

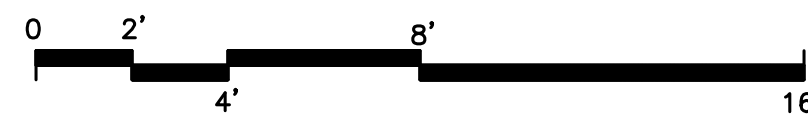

NOTE:
ALL STRUCTURAL ELEMENTS, SIZES, AND
LOCATION ARE TO BE VERIFIED IN FIELD BY
CONTRACTOR BEFORE ANY REMOVALS OR
RENOVATION WORK IS DONE. (TYP.)

NOTE: EXISTING CONDITIONS OF CONSTRUCTION SHOWN ON THIS
DRAWINGS ARE BASED ON DRAWINGS PROVIDED BY OWNER TO F&D
FOR REFERENCE ONLY (NOT AS-BUILT DRAWINGS). ALL EXISTING
CONDITIONS AND DIMENSIONS ARE TO BE FIELD VERIFIED. ANY
VARIATIONS FROM CONDITIONS AS SHOWN ON THIS DRAWINGS SHALL
BE BROUGHT TO THE ATTENTION OF THE ARCHITECT.

LEGEND (FRAMING)

- — — STEEL STRUCTURE (EXISTING)
- — — STEEL STRUCTURE (NEW)
- — — STEEL DECK DIRECTION (NEW)

DUNNAGE NOTES

- CONTRACTOR TO COORDINATE PLATFORM DIMENSIONS WITH MECHANICAL CONTRACTOR.
- ALL COMPONENTS HOT DIPPED GALVANIZED.
- STEEL TO CONFORM WITH ASTM A997 GRADE 50. POST TO CONFORM WITH ASTM A500.
- BOLTS TO BE GALVANIZED 3/4" A325 WITH GALVANIZED WASHERS. WELDS TO UTILIZE E70XX ELECTRODES.
- SECURE EQUIPMENT TO DUNNAGE WITH MECHANICAL FASTENERS.
- COORDINATE FINAL LOCATION OF MECHANICAL EQUIPMENT & DUNNAGE WITH EXISTING STRUCTURE.
- SUBMIT SHOP DRAWINGS WITH FIELD MEASURED DIMENSIONS.
- CONTRACTOR TO PROTECT EXISTING ROOF(S) DURING CONSTRUCTION. CONTRACTOR TO PROVIDE 1" RIDGE INSULATION AND 1/2" EXTERIOR PLYWOOD, WEIGH DOWN W/ SAND BAGS, ROOF PROTECTION AT ALL WORK AREAS. CONTRACTOR TO LIMIT ROOF TRAFFIC ON EXISTING ROOFS.
- ALL CONNECTIONS TO BE FILLET WELDS TO BE MINIMUM 1/4" CONTINUOUS, UNLESS NOTED OTHER WISE.
- PROVIDE WELDED SEATED CONNECTIONS AT BEAM TO COLUMN CONNECTION.
- ALL CONNECTIONS SHALL BE DESIGNED BY N.Y.S. LICENSED PROFESSIONAL ENGINEER.

ALTERATIONS AND EXISTING CONDITIONS

- WHERE EXISTING WORK IS TO BE CUT, CONTRACTOR SHALL PROVIDE ALL NEEDLING, SHORING, WELDING, AND DRY-PACKING AND SHALL BE RESPONSIBLE FOR THE SAFETY OF THE STRUCTURE DURING THE OPERATION.
- ALL NEW OPENINGS IN EXISTING STRUCTURE SHALL BE SAW CUT. CORE DRILL AT CORNERS. DO NOT OVER-CUT. REMOVAL OF EXCESS MATERIAL SHALL BE DONE BY HAND. ONLY ROTARY TOOLS SHALL BE USED.
- ADD NEW FRAMING TO HEADER OFF EXISTING FRAMING TO CREATE PENETRATION FOR NEW WORK. **VERIFY EXISTING FRAMING MEMBERS AND SIZES AND ADVISE THE ARCHITECT IN WRITING BEFORE PROCEEDING WITH ANY WORK.** COORDINATE SIZES AND LOCATIONS OF PENETRATIONS WITH MECHANICAL CONTRACTOR. VERIFY OPERATING WEIGHTS OF EQUIPMENT USED WITH WEIGHTS INDICATED ON ROOF PLAN.
- IF REQUIRED, CONTRACTOR SHALL SUBMIT SHORING DRAWINGS SIGNED AND SEALED BY A NEW YORK STATE LICENSED PROFESSIONAL ENGINEER.

GENERAL NOTES

- DIMENSIONS AND CONDITIONS ON THE FRAMING PLANS AND DETAILS ARE APPROXIMATE AND MUST BE CONFIRMED BY CONTRACTOR AND SUBMITTED ON SHOP DRAWINGS.
- ADD NEW FRAMING TO HEADER OFF EXISTING FRAMING AND TO CREATE ROOF PENETRATION FOR NEW ROOF MOUNTED EQUIPMENT. **VERIFY EXISTING FRAMING MEMBERS.** COORDINATE SIZES AND LOCATIONS OF PENETRATIONS WITH MECHANICAL CONTRACTOR. VERIFY OPERATING WEIGHTS OF EQUIPMENT USED WITH WEIGHTS INDICATED ON FRAMING PLANS.
- REINFORCE ALL PENETRATIONS. SEE PLANS.
- ALL NECESSARY TEMPORARY PROTECTION SHALL BE INSTALLED ON EXISTING BUILDING TO PREVENT DAMAGE TO FOUNDATION AND SUPER STRUCTURE DURING CONSTRUCTION OF NEW WORK.
- DRAWINGS INDICATE GENERAL AND TYPICAL DETAILS OF CONSTRUCTION. WHERE CONDITIONS ARE NOT SPECIFICALLY SHOWN, SIMILAR DETAILS SHALL BE USED, SUBJECT TO ACCEPTANCE BY THE ARCHITECT.
- CONTRACTOR SHALL BE RESPONSIBLE FOR ALL REQUIRED SHORING. JOB SAFETY AND CONSTRUCTION PROCEDURES ARE ALSO THE SOLE RESPONSIBILITY OF THE CONTRACTOR. LACK OF COMMENT BY THE ARCHITECT IS NOT TO BE INTERPRETED AS ACCEPTANCE OF THOSE ASPECTS OF THE WORK.
- NO EQUIPMENT SHALL BE HUNG FROM BRACING OR STEEL DECK.
- CONTRACTOR SHALL FIELD VERIFY SIZES OF EXISTING BEAMS AND JOISTS SHOWN ON DRAWINGS AND ADVISE ARCHITECT IN WRITING. CONTRACTOR SHALL SUBMIT SHOP DRAWINGS FOR APPROVAL OF NEW WORK SHOWN.
- COORDINATE ALL WORK WITH OTHER PRIME CONTRACTORS.
- PROVIDE TEMPORARY WEATHER PROTECTION AS NECESSARY.

AS PER USA CONGRESS ARCHITECTURAL WORKS COPYRIGHT PROTECTION ACT OF 1990 ALL IDEAS AND DESIGNS INCLUDING DERIVATIVES THEREOF, ALL DRAWINGS AND SPECIFICATIONS CONSTITUTE THE ORIGINAL COPYRIGHT WORK BY FULLER AND DANKELO, P.C. (F&D). THE DRAWINGS AND SPECIFICATIONS AS INSTRUMENTS OF SERVICE BY F&D ARE CREATED BY F&D FOR THIS PROJECT ONLY AND REMAIN THE PRODUCT AND PROPERTY OF F&D. ANY REPRODUCTION WITHOUT THE PRIOR CONSENT OF F&D IS PROHIBITED.

48 KILLWOOD ROAD ELLENFORD NEW YORK 10883
TEL 914.899.4444 FAX 914.899.1919
Copyright 2022 All Rights Reserved By FULLER & DANKELO, P.C.

FULLER
DANKELO
P.C.
ARCHITECTS
PLANNERS


LICENSE EXP. DATE: 02-28-2027

S.E.D. CONTROL NUMBER:
GREENVILLE ELEMENTARY SCHOOL
66-04-06-03-0-008-021


PROJECT TITLE
EDGEMONT SCHOOL DISTRICT
GREENVILLE ELEMENTARY SCHOOL
CAFETERIA RENOVATION

DRAWING TITLE
PARTIAL ROOF FRAMING PLAN

01-31-2025	BID
01-10-2022	SEALED SUBMISSION
DATE	ISSUED TO
SHEET SIZE 30"x42"	DRAWING NO.
SCALE AS NOTED	S2
DRAWN BY F & D	FILE NO. 24529.01


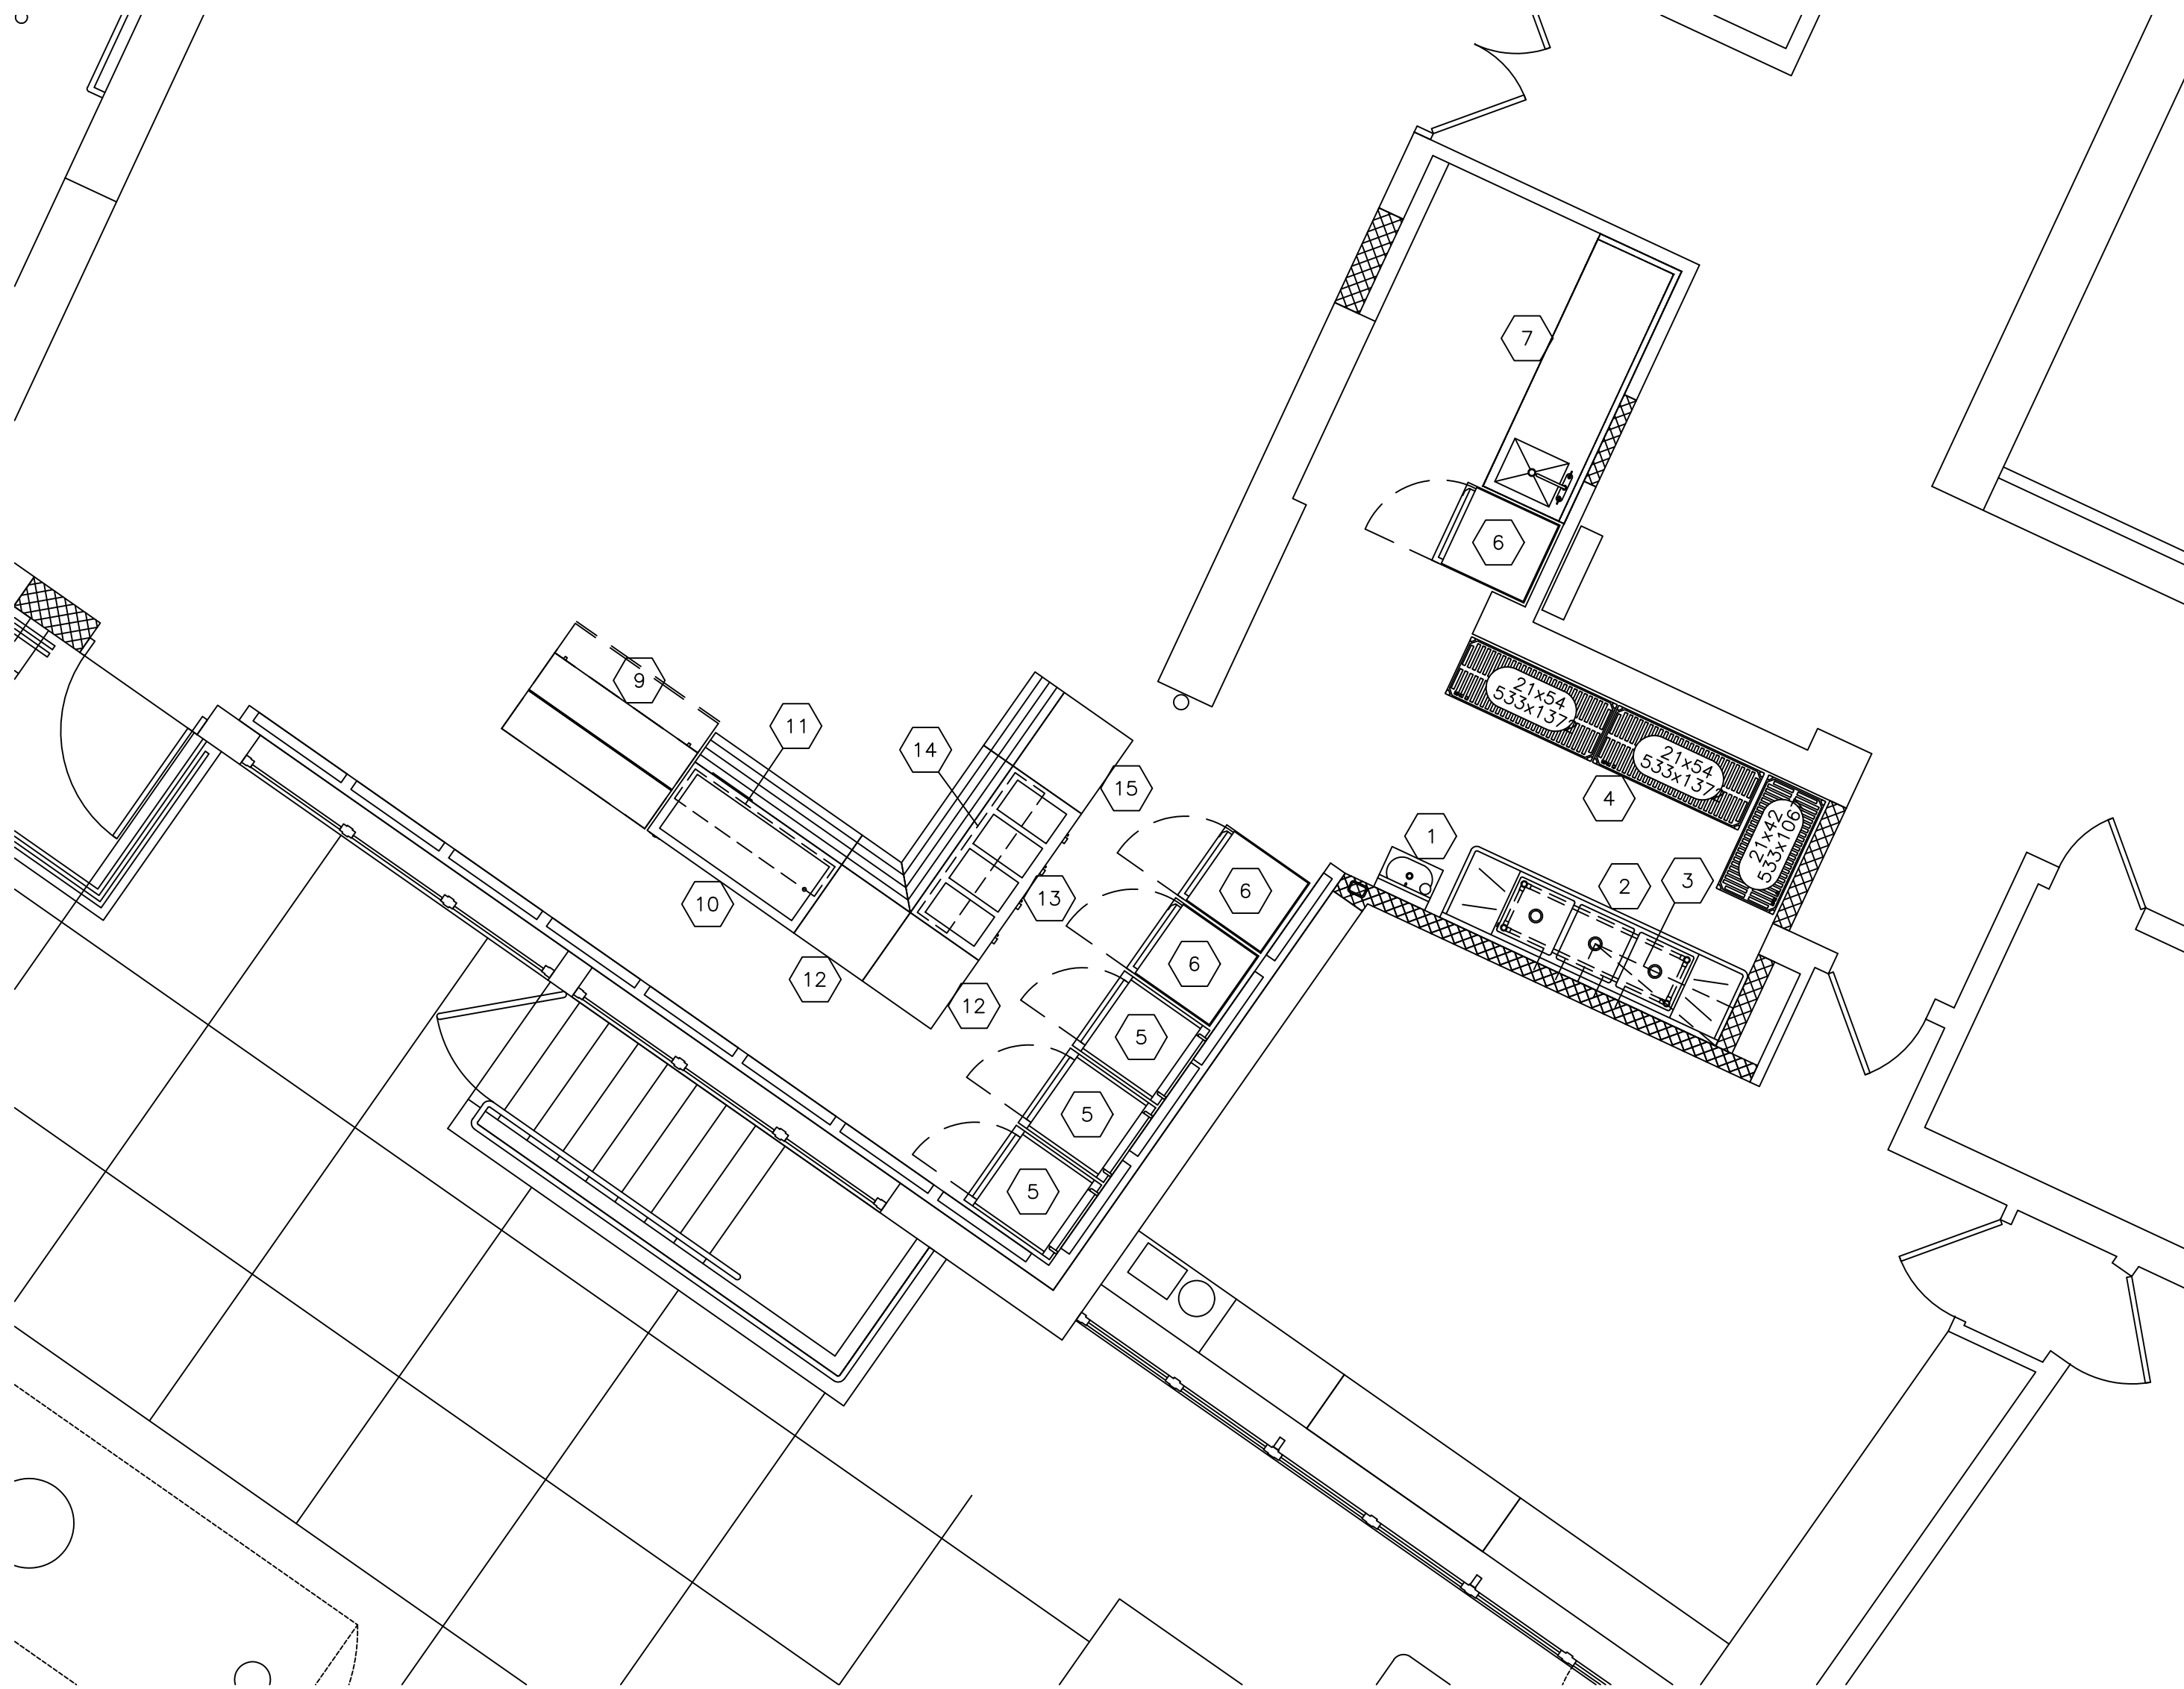


FOOD SERVICE EQUIPMENT PLAN
SCALE: 1/4"=1'-0"

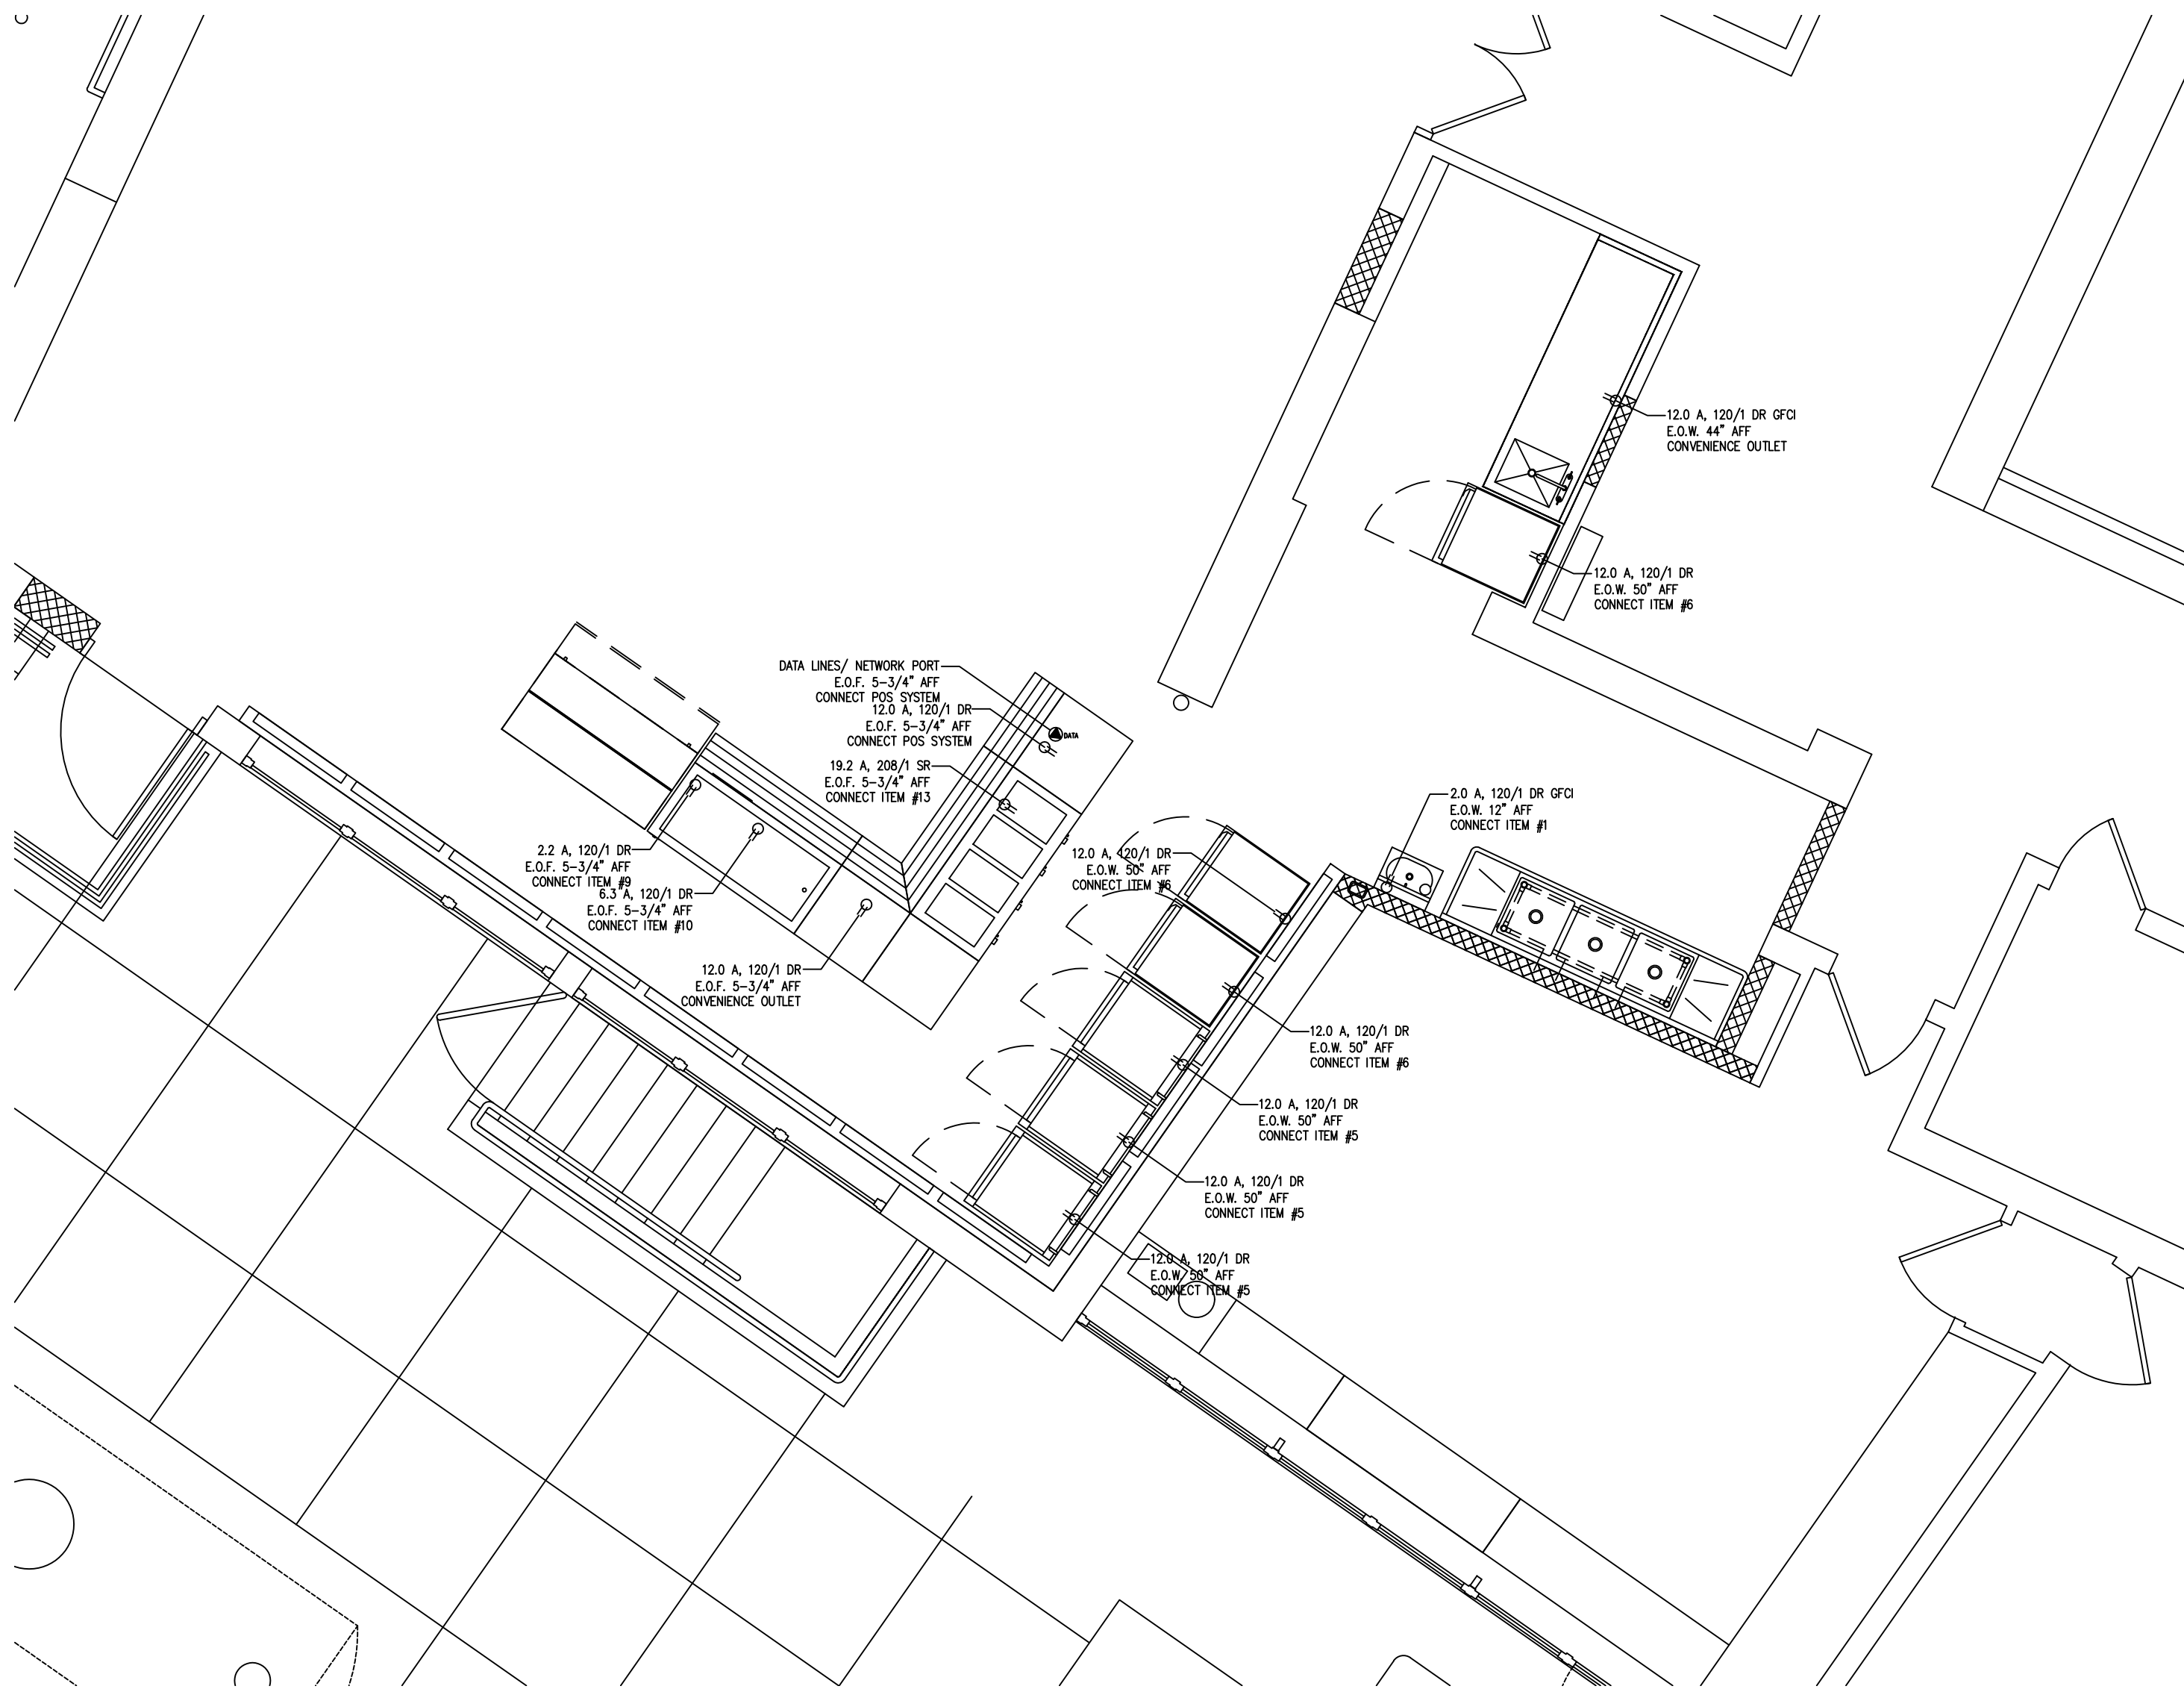

FOOD SERVICE ELECTRICAL CONNECTIONS PLAN
SCALE: 1/4"=1'-0"

EQUIPMENT SCHEDULE																	
ITEM NO	EQUIPMENT CATEGORY	QTY	HOT WATER SIZE (IN)	COLD WATER SIZE (IN)	DIRECT DRAIN SIZE (IN)	INDIR DRAIN SIZE (IN)	HP	KW	AMPS	PLUG	DIRECT	VOLTS	PHASE	NEMA	MANUFACTURER	MODEL NUMBER	EQUIPMENT REMARKS
1	HAND SINK, WALL MNTD.	1	1/2	1/2	1-1/2				2.0	X		120	1	5-15P	EAGLE GROUP/METAL MASTERS	HSA-10-FDPS	
2	3-COMPARTMENT SINK	1	1/2	1/2		1-1/2									EAGLE GROUP/METAL MASTERS	FN2060-3-18-14/3	
			1/2	1/2		1-1/2											
						1-1/2											
3	STORAGE SYSTEM, WALL MNTD.	1													EAGLE GROUP/ METAL MASTERS	WAL-STOR	
4	STORAGE SHELVING, PORTABLE	3													METRO	MQ21XXG	
5	CABINET, MOBILE, WARM/HOLD	3					1.5	12.0	X			120	1	5-15P	CRES COR	H137SUA12DSD	
6	CABINET, MOBILE, REFRIGERATED	3					0.33	12.0	X			120	1	5-15P	CRES COR	R171SUA10ESD	
7	WORK COUNTER W/ SINK	1	1/2	1/2		1-1/2									EAGLE GROUP/ METAL MASTERS	CUSTOM	
8	SPARE NUMBER	-															
9	MILK COOLER	1					0.33		2.2	X		120	1	5-15P	BEVERAGE-AIR	SM58HC-S	
10	COLD FOOD COUNTER, PORTABLE	1				1	0.33		6.3	X		120	1	5-15P	PIPER PRODUCTS	4-BCM	
11	FOOD PROTECTOR(S), ADJUSTABLE	1													PIPER PRODUCTS	CG	
12	FLAT TOP COUNTER, PORTABLE	1						12.0	X			120	1	5-15R	PIPER PRODUCTS	2-ST	
13	HOT FOOD COUNTER, PORTABLE	1				3/4	4.0	19.2	X			208	1	6-30P	PIPER PRODUCTS	4-HF	
14	FOOD PROTECTOR(S), ADJUSTABLE	1													PIPER PRODUCTS	CG	
15	CASHIER COUNTER, PORTABLE	1						12.0	X			120	1	5-15R	PIPER PRODUCTS	2-CD	

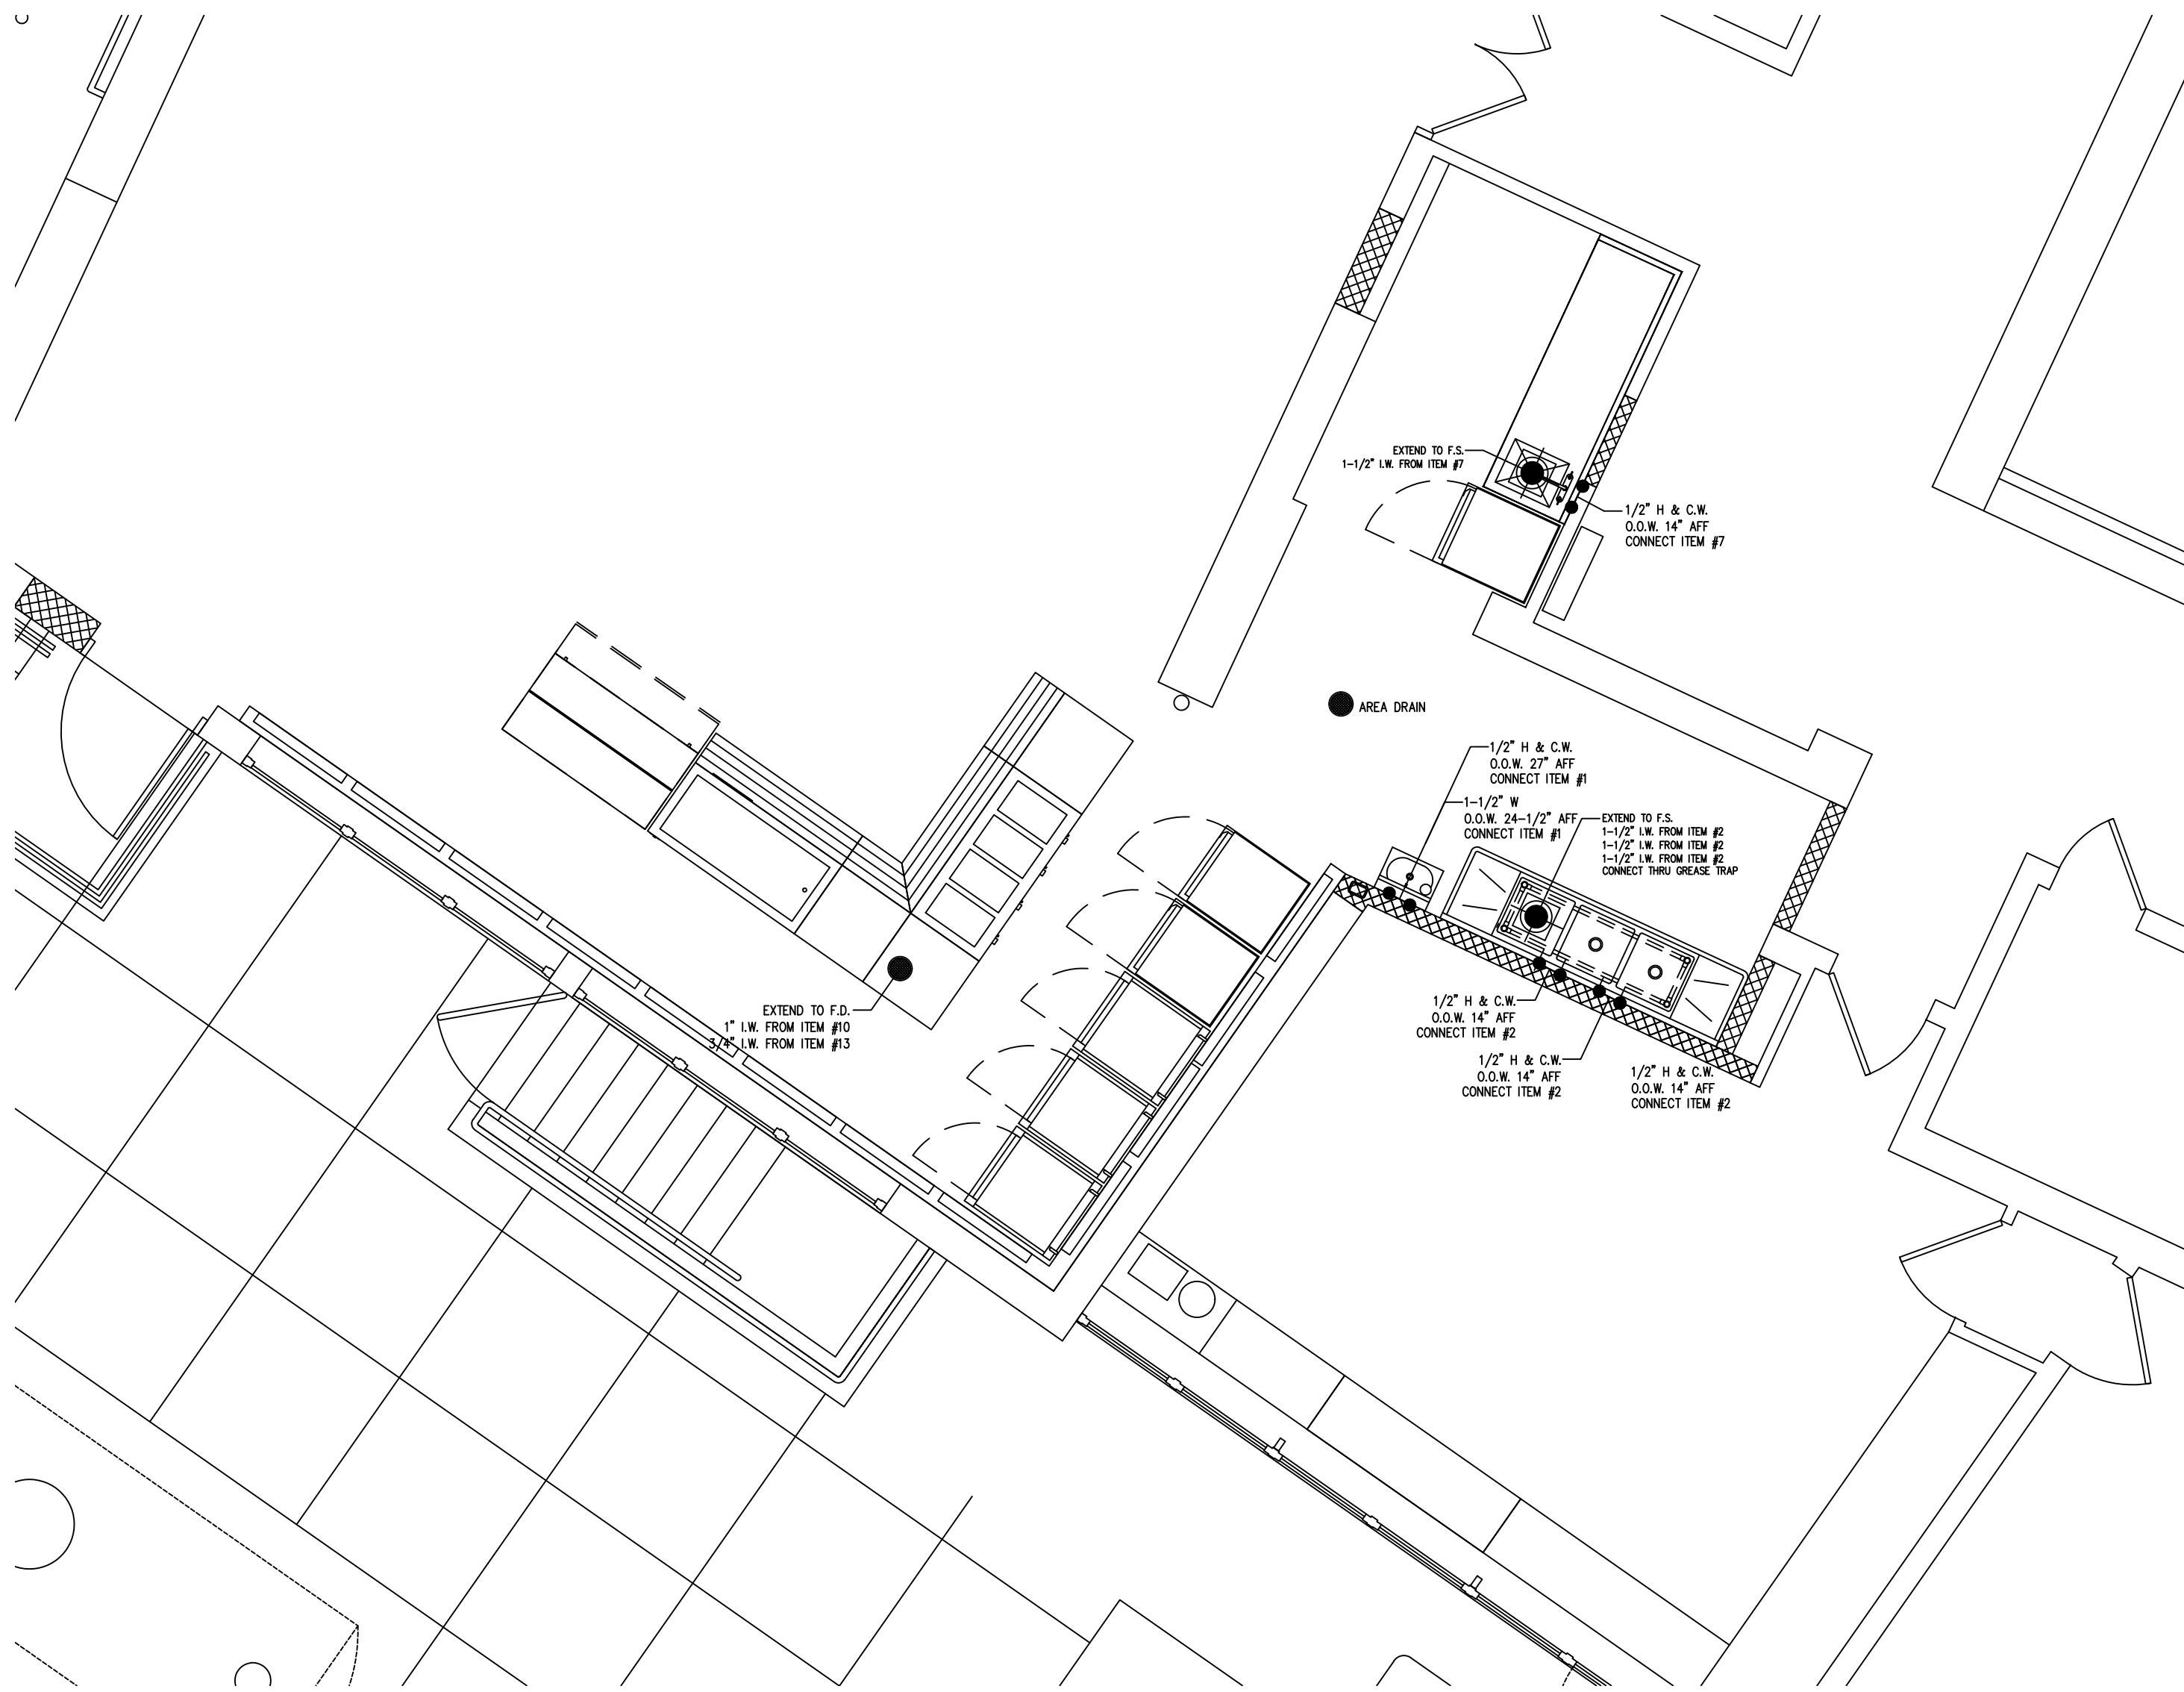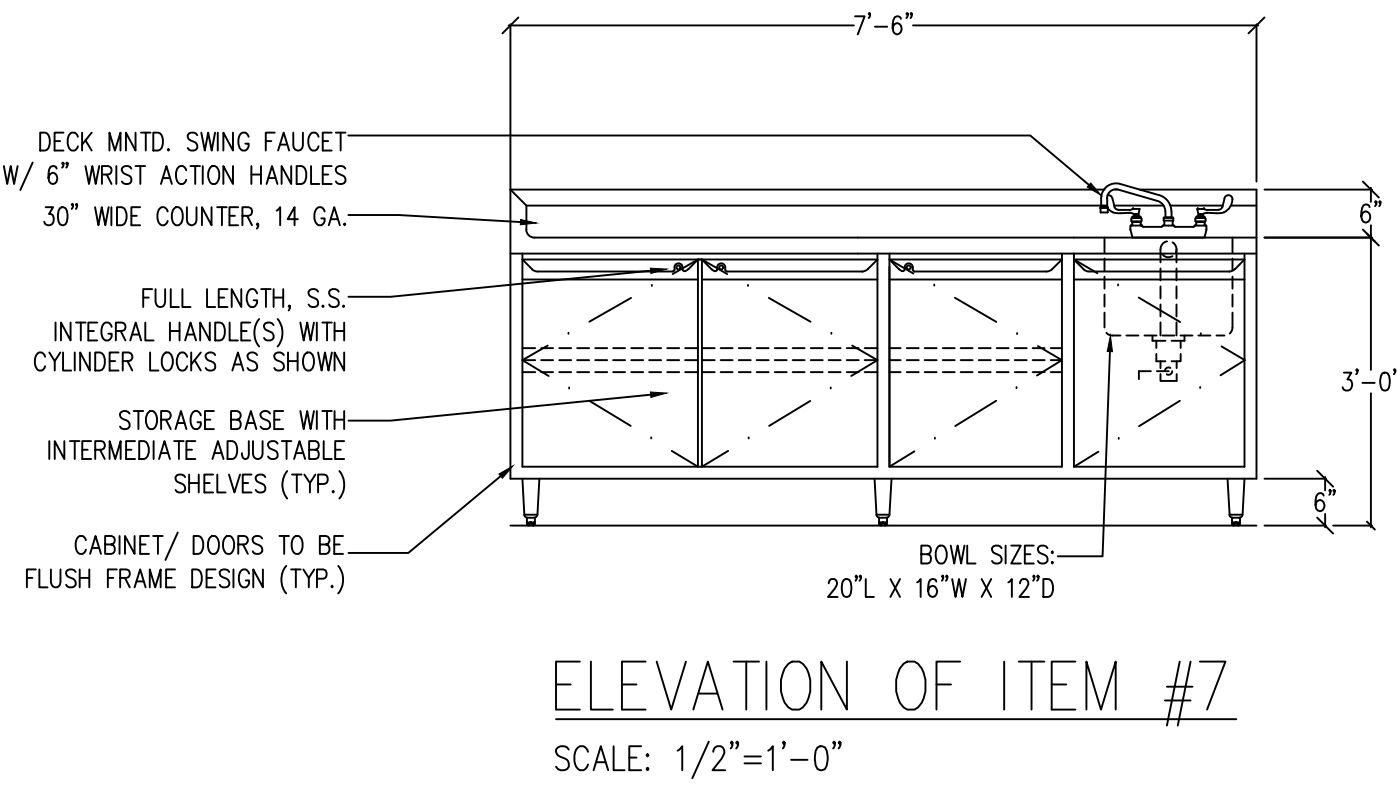

FOOD SERVICE PLUMBING CONNECTIONS PLAN
SCALE: 1/4"=1'-0"

ELECTRICAL LEGEND	
JB	JUNCTION BOX
DR	DUPLEX RECEPTACLE
SR	SIMPLEX RECEPTACLE
E.O.W.	ELECTRICAL OUT OF WALL
E.O.F.	ELECTRICAL OUT OF FLOOR
D.F.A.	DOWN FROM ABOVE
AFF	ABOVE FINISHED FLOOR
BTC	BRANCH TO CONNECTION
A	AMPS
HP	HORSEPOWER
KW	KILOWATT
E.C.	ELECTRICAL CONTRACTOR

- ELECTRICAL NOTES:
- ALL WALL OUTLETS ARE FROM AFF TO BOTTOM OF BOX.
 - E.C. TO CHECK ALL CONDITIONS AND VERIFY ALL DIMENSIONS PRIOR TO WORK.

PLUMBING LEGEND	
H.W.	HOT WATER
C.W.	COLD WATER
W	DIRECT WASTE
I.W.	INDIRECT WASTE
F.D.	FLOOR DRAIN
F.S.	FLOOR SINK
G	GAS
O.O.W.	OUT OF WALL
O.O.F.	OUT OF FLOOR
AFF	ABOVE FINISHED FLOOR
BTC	BRANCH TO CONNECTION
P.C.	PLUMBING CONTRACTOR

- PLUMBING NOTES:
- P.C. TO PROVIDE HUB DRAINS FOR ALL INDIRECT WASTE LINES AND RETAIN AIR GAPS AS REQUIRED.
 - P.C. TO CHECK ALL CONDITIONS AND VERIFY ALL DIMENSIONS PRIOR TO WORK.

AS PER USA CONGRESS ARCHITECTURAL WORKS COPYRIGHT PROTECTION ACT OF 1990 ALL IDEAS AND DESIGNS INCLUDING DERIVATIVES THEREOF, ALL DRAWINGS AND SPECIFICATIONS CONSTITUTE THE ORIGINAL COPYRIGHT WORK BY FULLER AND D'ANGELO, P.C. (FAD). THE DRAWINGS AND SPECIFICATIONS AS INSTRUMENTS OF SERVICE BY FAD ARE CREATED BY FAD FOR THE PROJECT ONLY AND REMAIN THE PRODUCT AND PROPERTY OF FAD. ANY REPRODUCTION WITHOUT THE PRIOR CONSENT OF FAD IS PROHIBITED.

PROJECT TITLE
EDGEWORTH SCHOOL DISTRICT
GREENVILLE ELEMENTARY SCHOOL
CAFETERIA RENOVATION

DRAWING TITLE
FOOD SERVICE EQUIPMENT PLAN,
SCHEDULE & NOTES

01-31-2025
01-06-2023
DATE

BID
SED SUBMISSION
ISSUED TO

SHEET SIZE
30"x42"

SCALE
1/4"=1'-0"

DRAWN BY
F & D

DRAWING NO.
GVES
FS101

FILE NO.
24529.01

48 KNOXWOOD ROAD
ELMWOOD NEW YORK 10823
TEL 914-898-4444
Copyright 2024 All Rights Reserved by FULLER & D'ANGELO P.C.

FULLER
D'ANGELO
P.C.

ARCHITECTS
PLANNERS

FILE: C:\Users\RRADesigns3\RRADesigns Dropbox\Ryan Stack\RRAServer\data\Drafting\Drawings\Schools\Edgeworth School District\Greenville ES\FS-ALL-Greenville ES.dwg
PLOT DATE: January 08, 2025 - 11:32am

GENERAL CONTRACTOR NOTES:

1. UNLESS OTHERWISE INDICATED, KITCHEN EQUIPMENT CONTRACTOR (K.E.C.) IS A SUBCONTRACTOR TO THE GENERAL CONTRACTOR.
2. IF WALLS ARE FIRE RATED, GENERAL CONTRACTOR TO USE METAL STUDS FOR WALL BLOCKING IN PLACE OF PLYWOOD.

KITCHEN EQUIPMENT CONTRACTOR (K.E.C.) NOTES:

1. COORDINATE WITH OTHER TRADES AND/OR SUB-CONTRACTORS IN ORDER THAT WHOLE INSTALLATION MAY RESULT IN THE HIGHEST GRADE POSSIBLE.
2. INSTALL FOOD SERVICE EQUIPMENT LEVEL AND PLUMB, ACCORDING TO MANUFACTURER'S WRITTEN INSTRUCTIONS, ORIGINAL DESIGN AND REFERENCED STANDARDS.
3. PROVIDE ONLY SUCH VALVES, TRAPS, FAUCETS, SHUT-OFFS, PRESSURE REDUCING VALVES, RELIEF VALVES AND OTHER SPECIALTY ITEMS REQUIRED WITHIN EQUIPMENT FOR PROPER FUNCTION AND AS HEREINAFTER SPECIFIED.
4. MAKE ALL NECESSARY CUT-OUTS AND KNOCK-OUTS WHERE REQUIRED ON EQUIPMENT TO ACCOMMODATE ELECTRICAL RECEPTACLES, SWITCHES OR OTHER ELECTRICAL OUTLETS AND EQUIPMENT, TOGETHER WITH SUCH CUT-OUTS AS REQUIRED FOR PASSAGE OF GAS OR PLUMBING PIPING, ETC.
5. STACK RUBBISH WASTE MATERIAL, CRATING, ETC., RESULTING FROM WORK AND KEEP THE PREMISES ORGANIZED AT ALL TIMES. UPON COMPLETION OF THE INSTALLATION, THOROUGHLY CLEAN ALL EQUIPMENT. FINAL SANITATION CLEANING BY OWNER.

PLUMBING CONTRACTOR NOTES:

1. PLUMBING ROUGH-INS SHOWN ON THE FOOD SERVICE DRAWINGS ARE "POINT OF CONNECTION" OR "CONNECTED LOAD" DRAWINGS ONLY. REFER TO ENGINEERING DRAWINGS FOR FURTHER DETAILS & INFORMATION.
2. FURNISH & INSTALL SHUT-OFF VALVES ON THE INLET SIDE OF THE COLD & HOT WATER LINES SERVING EACH PIECE OF EQUIPMENT.
3. IF WATER PRESSURE AT THE EQUIPMENT AREA EXCEEDS 50 POUNDS FLOW PRESSURE OWNER OR HIS CONTRACTOR MUST INSTALL A PRESSURE REDUCING VALVE ON BOTH THE MAIN HOT WATER & COLD WATER SUPPLY LINES SERVICING THE AREA.
4. CHECK WITH LOCAL CODES TO DETERMINE WHAT EQUIPMENT IS TO BE PIPED THROUGH A GREASE TRAP. EQUIPMENT NOTED ON FOOD SERVICE CONTRACT DRAWINGS ARE REQUIRED/ RECOMMENDED AND SHOULD BE VERIFIED FOR COMPLIANCE.
5. FURNISH & INSTALL GREASE TRAP(S) AS REQUIRED OR AS INDICATED ON ENGINEERING CONTRACT DOCUMENTS.
6. FURNISH & INSTALL FLOOR DRAINS AND/OR FLOOR SINKS AS PER LOCAL CODE HAVING JURISDICTION AND OWNERS REQUEST.
7. FURNISH & INSTALL ALL WATER LINES, DRAIN LINES, GAS LINES, MANIFOLDS, SHUT-OFF/GATE VALVES, PRESSURE REDUCING VALVES, BACKFLOW PREVENTERS, VACUUM BREAKERS, ETC. OR ANY OTHER PLUMBING DEVICE REQUIRED TO MAKE EQUIPMENT OPERATIONAL. THIS IS NOT PART OF THE KITCHEN EQUIPMENT CONTRACTORS SCOPE OF WORK UNLESS OTHERWISE SPECIFIED.
8. EXTEND ALL WATER LINES, DRAIN LINES & ASSOCIATED VALVES FOR DROP-IN OR BUILT-IN EQUIPMENT WITHIN COUNTERS TO WORKING SIDE FOR EASE OF ACCESSIBILITY & USE.
9. VERIFY, FURNISH & INSTALL REQUIRED PLUMBING ROUGH-INS FOR ALL EQUIPMENT BEING SUPPLIED.

ELECTRICAL CONTRACTOR NOTES:

1. ELECTRICAL ROUGH-INS SHOWN ON THE FOOD SERVICE DRAWINGS ARE "POINT OF CONNECTION" OR "CONNECTED LOAD" DRAWINGS ONLY. REFER TO ENGINEERING DRAWINGS FOR FURTHER DETAILS & INFORMATION.
2. FURNISH & INSTALL REQUIRED CONVENIENCE RECEPTACLES AS PER LOCAL CODE HAVING JURISDICTION AND PER OWNERS REQUESTS/ NEEDS.
3. VERIFY IF CONVENIENCE RECEPTACLES ARE TO BE GFCI PER LOCAL CODE HAVING JURISDICTION.
4. MOUNTING HEIGHTS GIVEN ARE TO CENTERLINE OF DEVICE UNLESS OTHERWISE NOTED.
5. FLOOR MOUNTED DEVICES ARE TO BE MOUNTED WITH A 5 3/4" MAXIMUM HEIGHT TO TOP OF BOX.
6. FURNISH & INSTALL ALL RECEPTACLES, J-BOXES, SWITCHES, INTER-WIRING, DISCONNECT SWITCHES, MOTOR STARTERS AND/OR TRANSFORMERS OR ANY OTHER ELECTRICAL DEVICE REQUIRED TO MAKE EQUIPMENT OPERATIONAL. THIS IS NOT PART OF THE KITCHEN EQUIPMENT CONTRACTORS SCOPE OF WORK UNLESS OTHERWISE SPECIFIED.
7. VERIFY, FURNISH AND INSTALL REQUIRED ELECTRICAL ROUGH-INS FOR ALL EQUIPMENT BEING SUPPLIED.

GENERAL MECHANICAL NOTES:

1. ROUGH-INS SHOWN ON THE FOOD SERVICE DRAWINGS ARE FOR EQUIPMENT BEING SUPPLIED BY KITCHEN EQUIPMENT CONTRACTOR ONLY. ADDITIONAL ROUGH-INS SHOWN OR NOT SHOWN ON THESE DRAWINGS FOR EQUIPMENT BEING RELOCATED, RE-USED OR SUPPLIED BY OTHERS WILL HAVE TO BE VERIFIED BY GENERAL CONTRACTOR PRIOR TO ROUGH-INS BEING INSTALLED.
2. THE MECHANICAL PLANS, IF APPLICABLE, ARE PREPARED AS AN ACCOMMODATION AND GUIDE ONLY, TO INDICATE MECHANICAL REQUIREMENTS NECESSARY TO OPERATE THE EQUIPMENT. DEVIATIONS FROM THE MECHANICAL WORK SHOWN ON THESE PLANS AND EXECUTION OF SUCH WORK IS WITHOUT RESPONSIBILITY OF RAYMOND/ RAYMOND ASSOCIATES. DATA ON THIS SHEET IS TO BE REVIEWED BY OWNER AND/OR ARCHITECT AND IS TO BE INCORPORATED INTO THE BUILDING MECHANICAL PLANS IN ACCORDANCE WITH LOCAL CODES AT THE SITE.
3. OWNER AND/OR ARCHITECT IS TO SUBMIT THIS PLAN SET TO LOCAL HEALTH DEPARTMENT FOR APPROVAL UNLESS OTHERWISE SPECIFIED.
4. ALL EQUIPMENT DESIGNED AND SPECIFIED, PER THIS SET OF PLANS, BY RAYMOND/ RAYMOND ASSOCIATES, HAS THE UNDERWRITERS' LABORATORIES AND NATIONAL SANITATION FOUNDATION SEALS OF APPROVAL. AND IS TO BE FURNISHED AS SUCH BY THE KITCHEN EQUIPMENT CONTRACTOR.
5. KITCHEN EQUIPMENT CONTRACTOR TO SET IN PLACE, EQUIPMENT AT THE SITE IN ACCORDANCE WITH THESE PLANS AND TERMS OF CONTRACT WITH OWNER.
6. ALL PLUMBING, ELECTRICAL AND VENTILATION WORK, INCLUDING "ROUGH-INS, INTERCONNECTIONS BETWEEN COUNTERS, CONTROLS, SWITCHES, ETC.," AND "FINAL CONNECTIONS" TO THE EQUIPMENT, IS TO BE PERFORMED BY APPROPRIATE TRADES. IT IS NOT PART OF THE KITCHEN EQUIPMENT CONTRACTORS SCOPE OF WORK UNLESS OTHERWISE SPECIFIED.
7. TO EXPEDITE AND INSURE PROPER INSTALLATION OF COOKING EQUIPMENT, IT IS RECOMMENDED THAT "ALL FINAL CONNECTIONS" ARE TO BE PERFORMED BY APPROPRIATE TRADES AT THE SAME TIME THE KITCHEN EQUIPMENT CONTRACTOR IS SETTING THE EQUIPMENT IN PLACE.

AS PER USA CONGRESS ARCHITECTURAL WORKS COPYRIGHT PROTECTION ACT OF 1990 ALL IDEAS AND DESIGNS INCLUDING DERIVATIVES THEREOF, ALL DRAWINGS AND SPECIFICATIONS CONSTITUTE THE ORIGINAL COPYRIGHT WORK BY FULLER AND D'ANGELO, P.C. (FAD). THE DRAWINGS AND SPECIFICATIONS AS INSTRUMENTS OF SERVICE BY FAD ARE CREATED BY FAD FOR THE PROJECT ONLY AND REMAIN THE PRODUCT AND PROPERTY OF FAD. ANY REPRODUCTION WITHOUT THE PRIOR CONSENT OF FAD IS PROHIBITED.

FULLER
D'ANGELO
P.C.

ARCHITECTS
PLANNERS

48 KNOLLWOOD ROAD
TEL 914.898.4444

ELMSFORD NEW YORK 10523
FAX 914.898.1917
RAYMOND ASSOCIATES, INC.
Copyright 2024 All Rights Reserved by FULLER & D'ANGELO P.C.

S.E.D. CONTROL NUMBER:
GREENVILLE ELEMENTARY SCHOOL
66-04-06-03-0-008-021

PROJECT TITLE
EDGEMONT SCHOOL DISTRICT
GREENVILLE ELEMENTARY SCHOOL
CAFETERIA RENOVATION

DRAWING TITLE
FOOD SERVICE TYPICAL TRADE
RESPONSIBILITY NOTES

01-31-2025
01-06-2023
DATE

BID
SED SUBMISSION
ISSUED TO



SHEET SIZE
30"x42"

SCALE
1/4"=1'-0"

DRAWN BY
F & D

DRAWING NO.
GVES
FS102

FILE NO.
24529.01

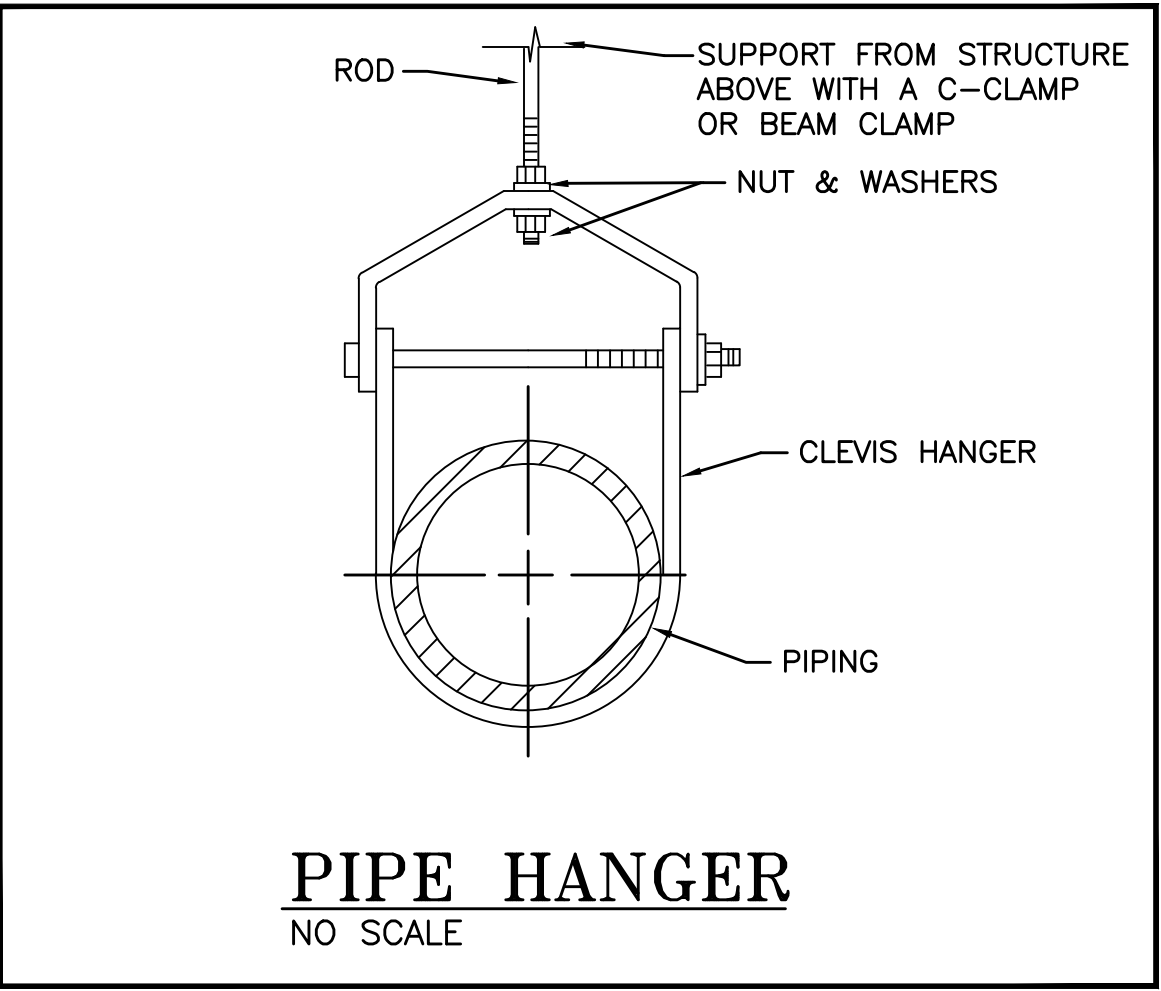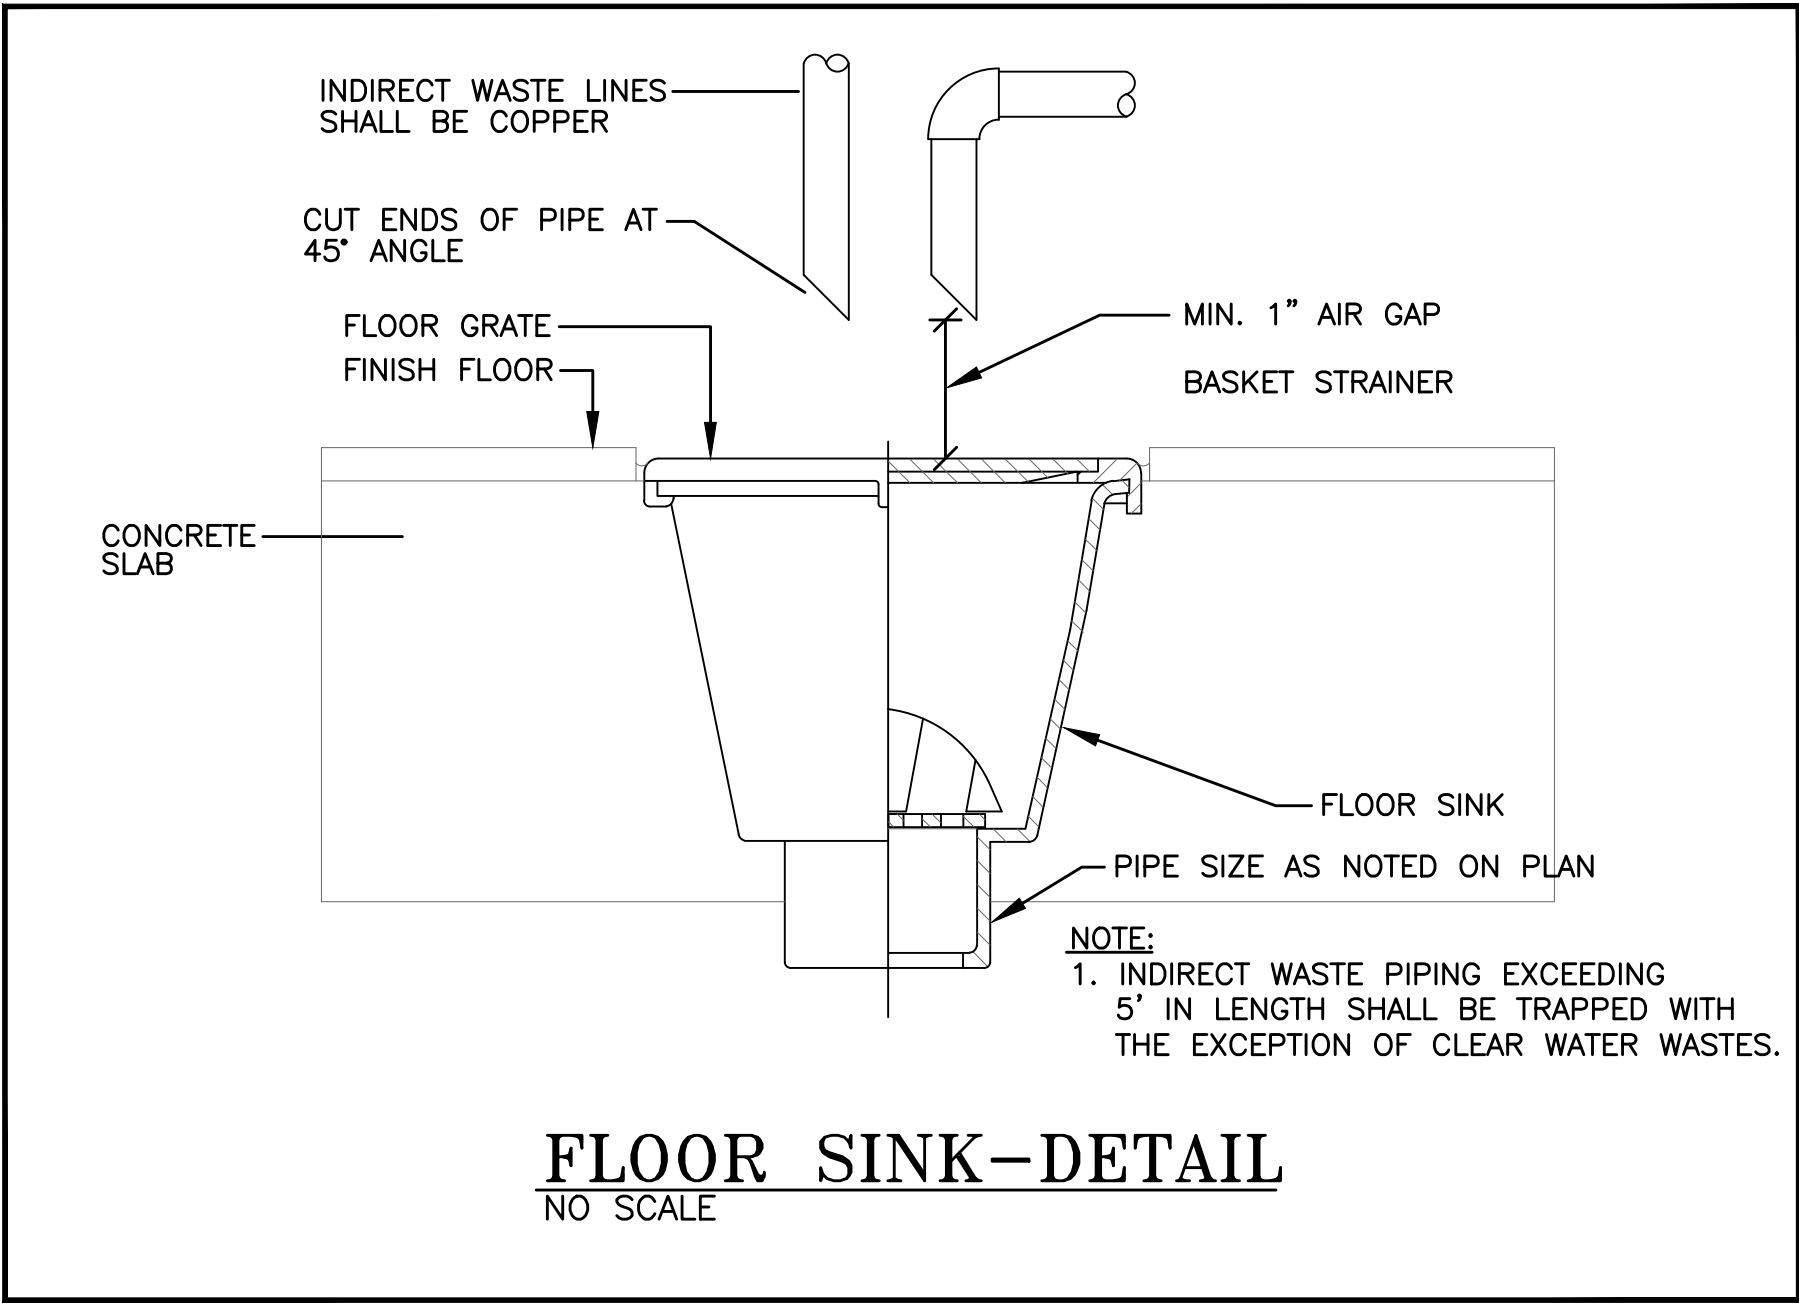


PLUMBING SYMBOL LIST	
SYMBOL	NOTE: NOT ALL SYMBOLS ARE USED
---	EXISTING PIPING TO REMAIN
-X-X-X-X-	EXISTING PIPING TO BE REMOVED
---	SANITARY PIPE BELOW FLOOR/SLAB (SAN)
---	SANITARY PIPE ABOVE FLOOR/SLAB (SAN)
---	VENT PIPE (V)
---	COLD WATER PIPING
---	HOT WATER PIPING
---	DIRECTION OF FLOW
---	PIPE RISE OR UP THRU SLAB
---	PIPE DROP OR DOWN THRU SLAB
---	BOTTOM OF PIPE TAKE-OFF CONNECTION
---	TOP OF PIPE TAKE-OFF CONNECTION
---	P-TRAP
---	CAP PIPE OUTLET
---	CLEANOUT (CO)
---	UNION
---	VALVE IN RISE / VERTICAL
---	POINT OF NEW CONNECTION
---	FLOOR DRAIN
---	FLOOR SINK

PLUMBING ABBREVIATION LIST	
SYMBOL	DESCRIPTION
AFF	ABOVE FINISHED FLOOR
CO	CLEANOUT
CV	CHECK VALVE
CLG	CEILING
CONN	CONNECT
DN	DOWN (PENETRATES FLOOR SLAB)
DR	DRAIN
DPCO	DECK PLATE CLEANOUT
EX	EXISTING
EL	ELEVATION
FL	FLOOR
HWR	HOT WATER RECIRCULATION
IW	INDIRECT WASTE
MIN	MINIMUM
NTS	NOT TO SCALE
SAN	SANITARY
GW	GREASE WASTE
TYP	TYPICAL
UP	UP (PENETRATES FLOOR SLAB)
V or VNT	VENT
VIF	VERIFY IN FIELD
W	WASTE
WCO	WALL CLEANOUT

PLUMBING EQUIPMENT SCHEDULE

- FS-1** FLOOR SINK: ZURN MODEL Z1752-NH4-Y-2, 12"x12" SQUARE TOP, 10" SUMP DEPTH, TYPE 304 STAINLESS STEEL LIGHT-DUTY SANI-FLOW RECEPTOR WITH NON-TILT, LOOSE SET FULL GRATE WITH 1/2" SQUARE OPENINGS AND ANTI-SPLASH STAINLESS STEEL INTERIOR DOME STRAINER
- FD-1** FLOOR DRAIN JAY R. SMITH MODEL #2005Y-NB, W/TYPE 'A' 6" ROUND STRAINER, 3" OUTLET, CAST IRON BODY, W/FLASHING COLLAR, WITH PROSET TRAP GUARD MODEL #1G3H

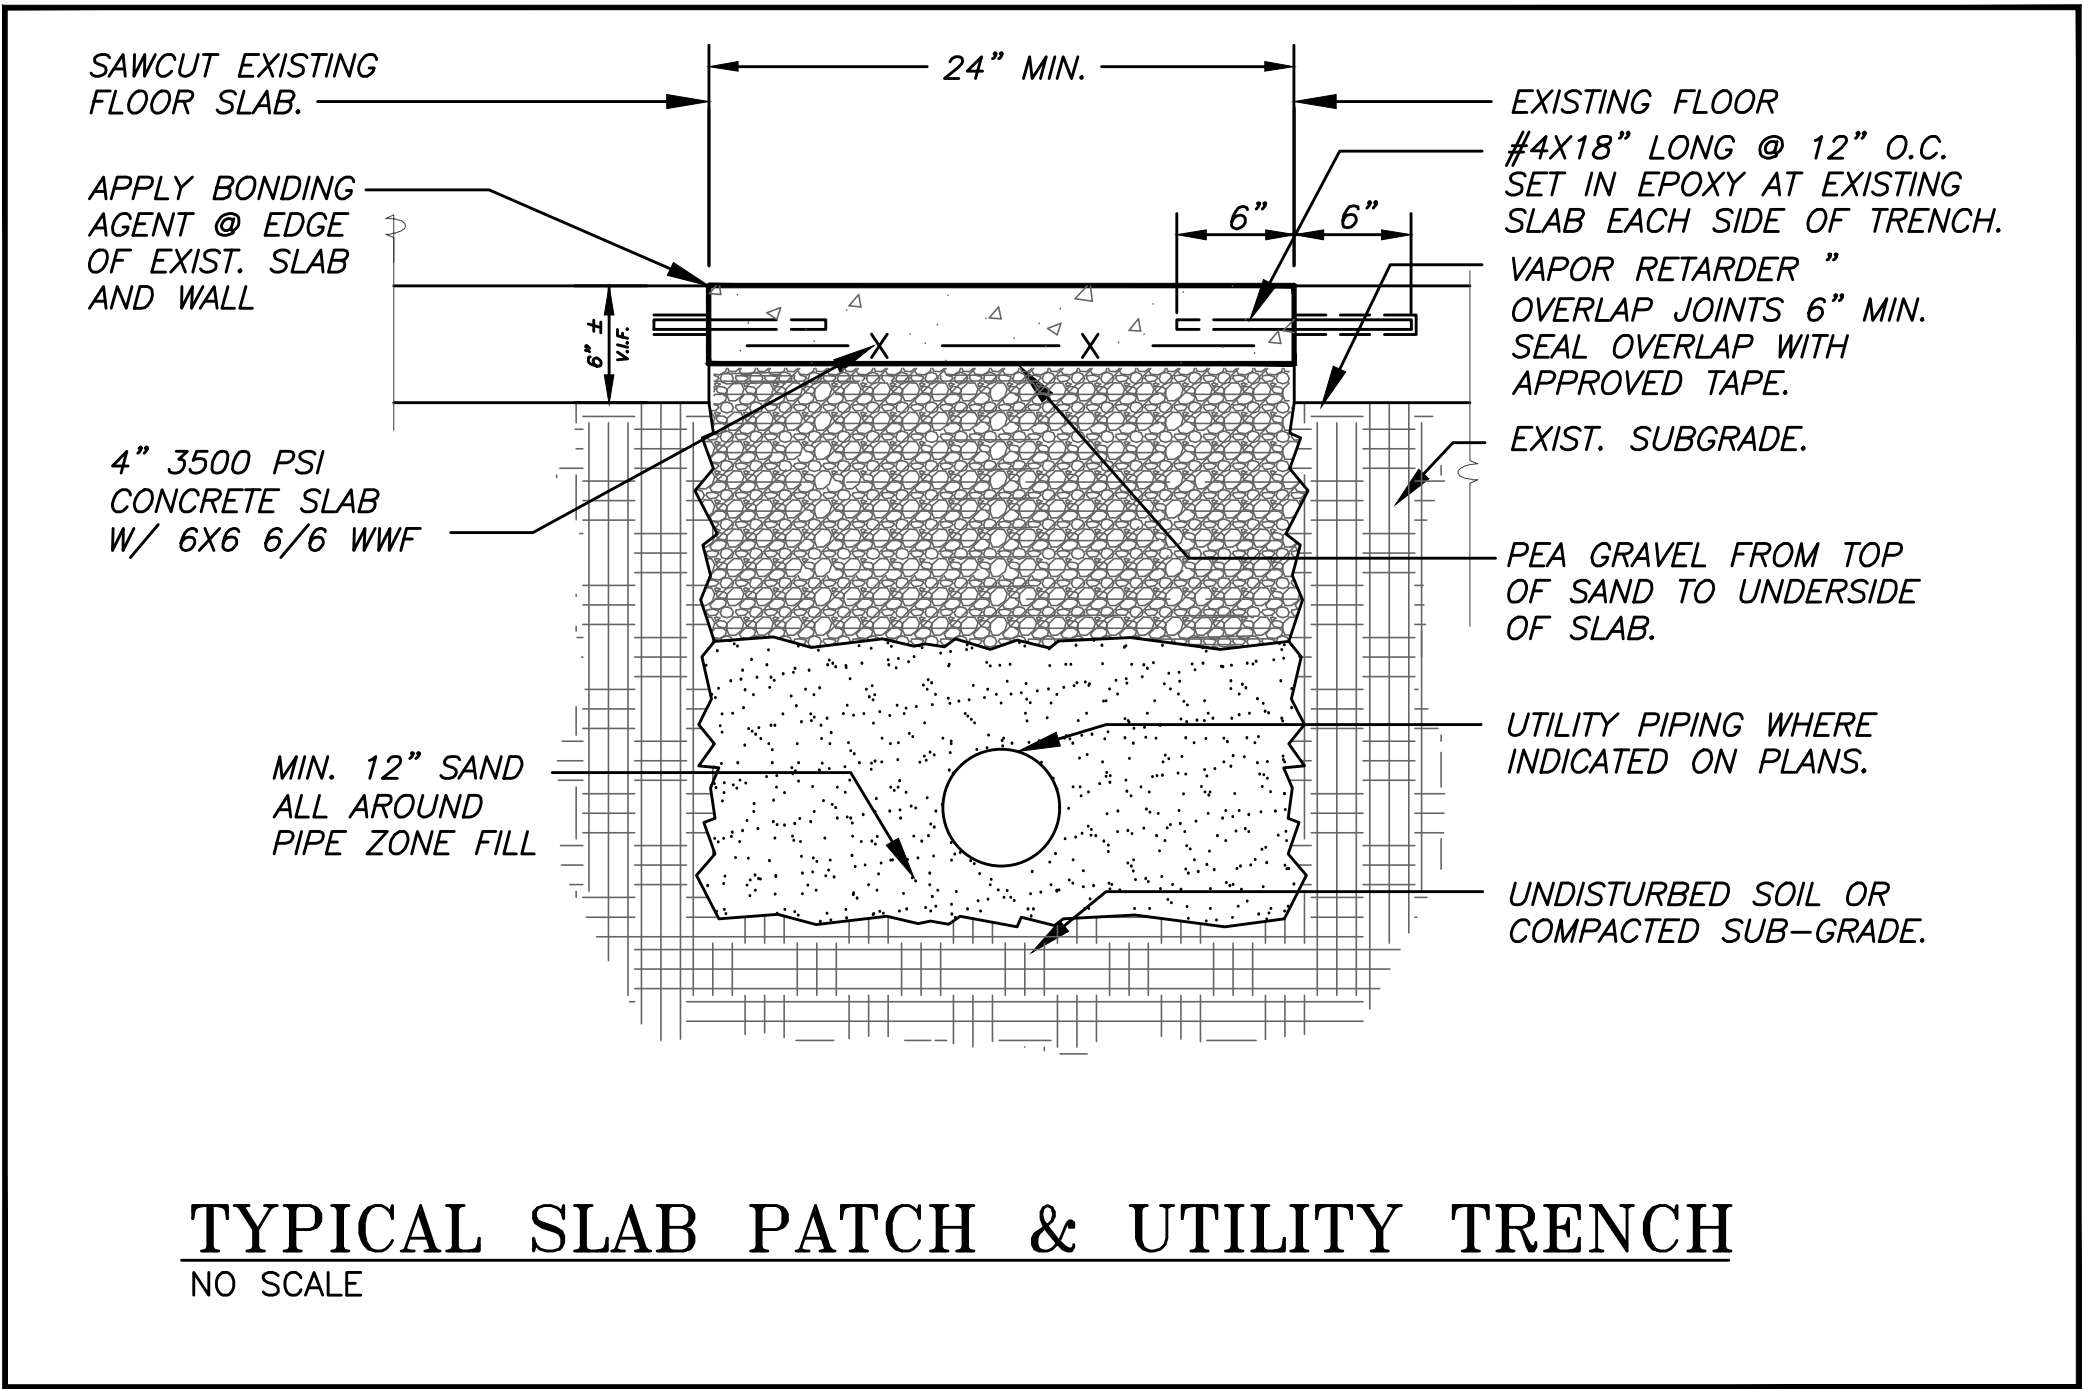

AS PER USA CONGRESS ARCHITECTURAL WORKS COPYRIGHT PROTECTION ACT OF 1990 ALL IDEAS AND DESIGNS INCLUDING DERIVATIVES THEREOF, ALL DRAWINGS AND SPECIFICATIONS CONSTITUTE THE ORIGINAL COPYRIGHT WORK BY FULLER AND DANKELO, P.C. (F&D). THE DRAWINGS AND SPECIFICATIONS AS INSTRUMENTS OF SERVICE BY F&D ARE CREATED BY F&D FOR THIS PROJECT ONLY AND REMAIN THE PRODUCT AND PROPERTY OF F&D. ANY REPRODUCTION WITHOUT THE PRIOR CONSENT OF F&D IS PROHIBITED.

408 KENNELWOOD ROAD ELLENBORO NEW YORK 12828
TEL: 814.898.4444 FAX: 814.898.1717
E-MAIL: FULLER@FULLER-AND-DANKELO.PC
Copyright 2022 All Rights Reserved by FULLER & DANKELO, P.C.

**FULLER
DANKELO
P.C.**

**ARCHITECTS
PLANNERS**

LFG
LANDMARK
FACILITIES
GROUP, INC.

252 East Avenue
Greenville, SC 29615
(253) 866-4624
(253) 866-4019 Fax

LICENSE EXP. DATE: 03-31-2026

S.E.D. CONTROL NUMBER:
GREENVILLE ELEMENTARY SCHOOL
66-04-06-03-0-008-021


PROJECT TITLE
EDGEWORTH SCHOOL DISTRICT
GREENVILLE ELEMENTARY SCHOOL
CAFETERIA RENOVATION

DRAWING TITLE
PLUMBING SYMBOLS,
ABBREVIATIONS, SCHEDULES
& DETAILS

01-31-2025 BID
01-10-2022 SED SUBMISSION
DATE ISSUED TO

SHEET SIZE
30"x42"
SCALE
AS NOTED
DRAWN BY
LFG

DRAWING NO.
**GVES
P001**
FILE NO.
24529.01

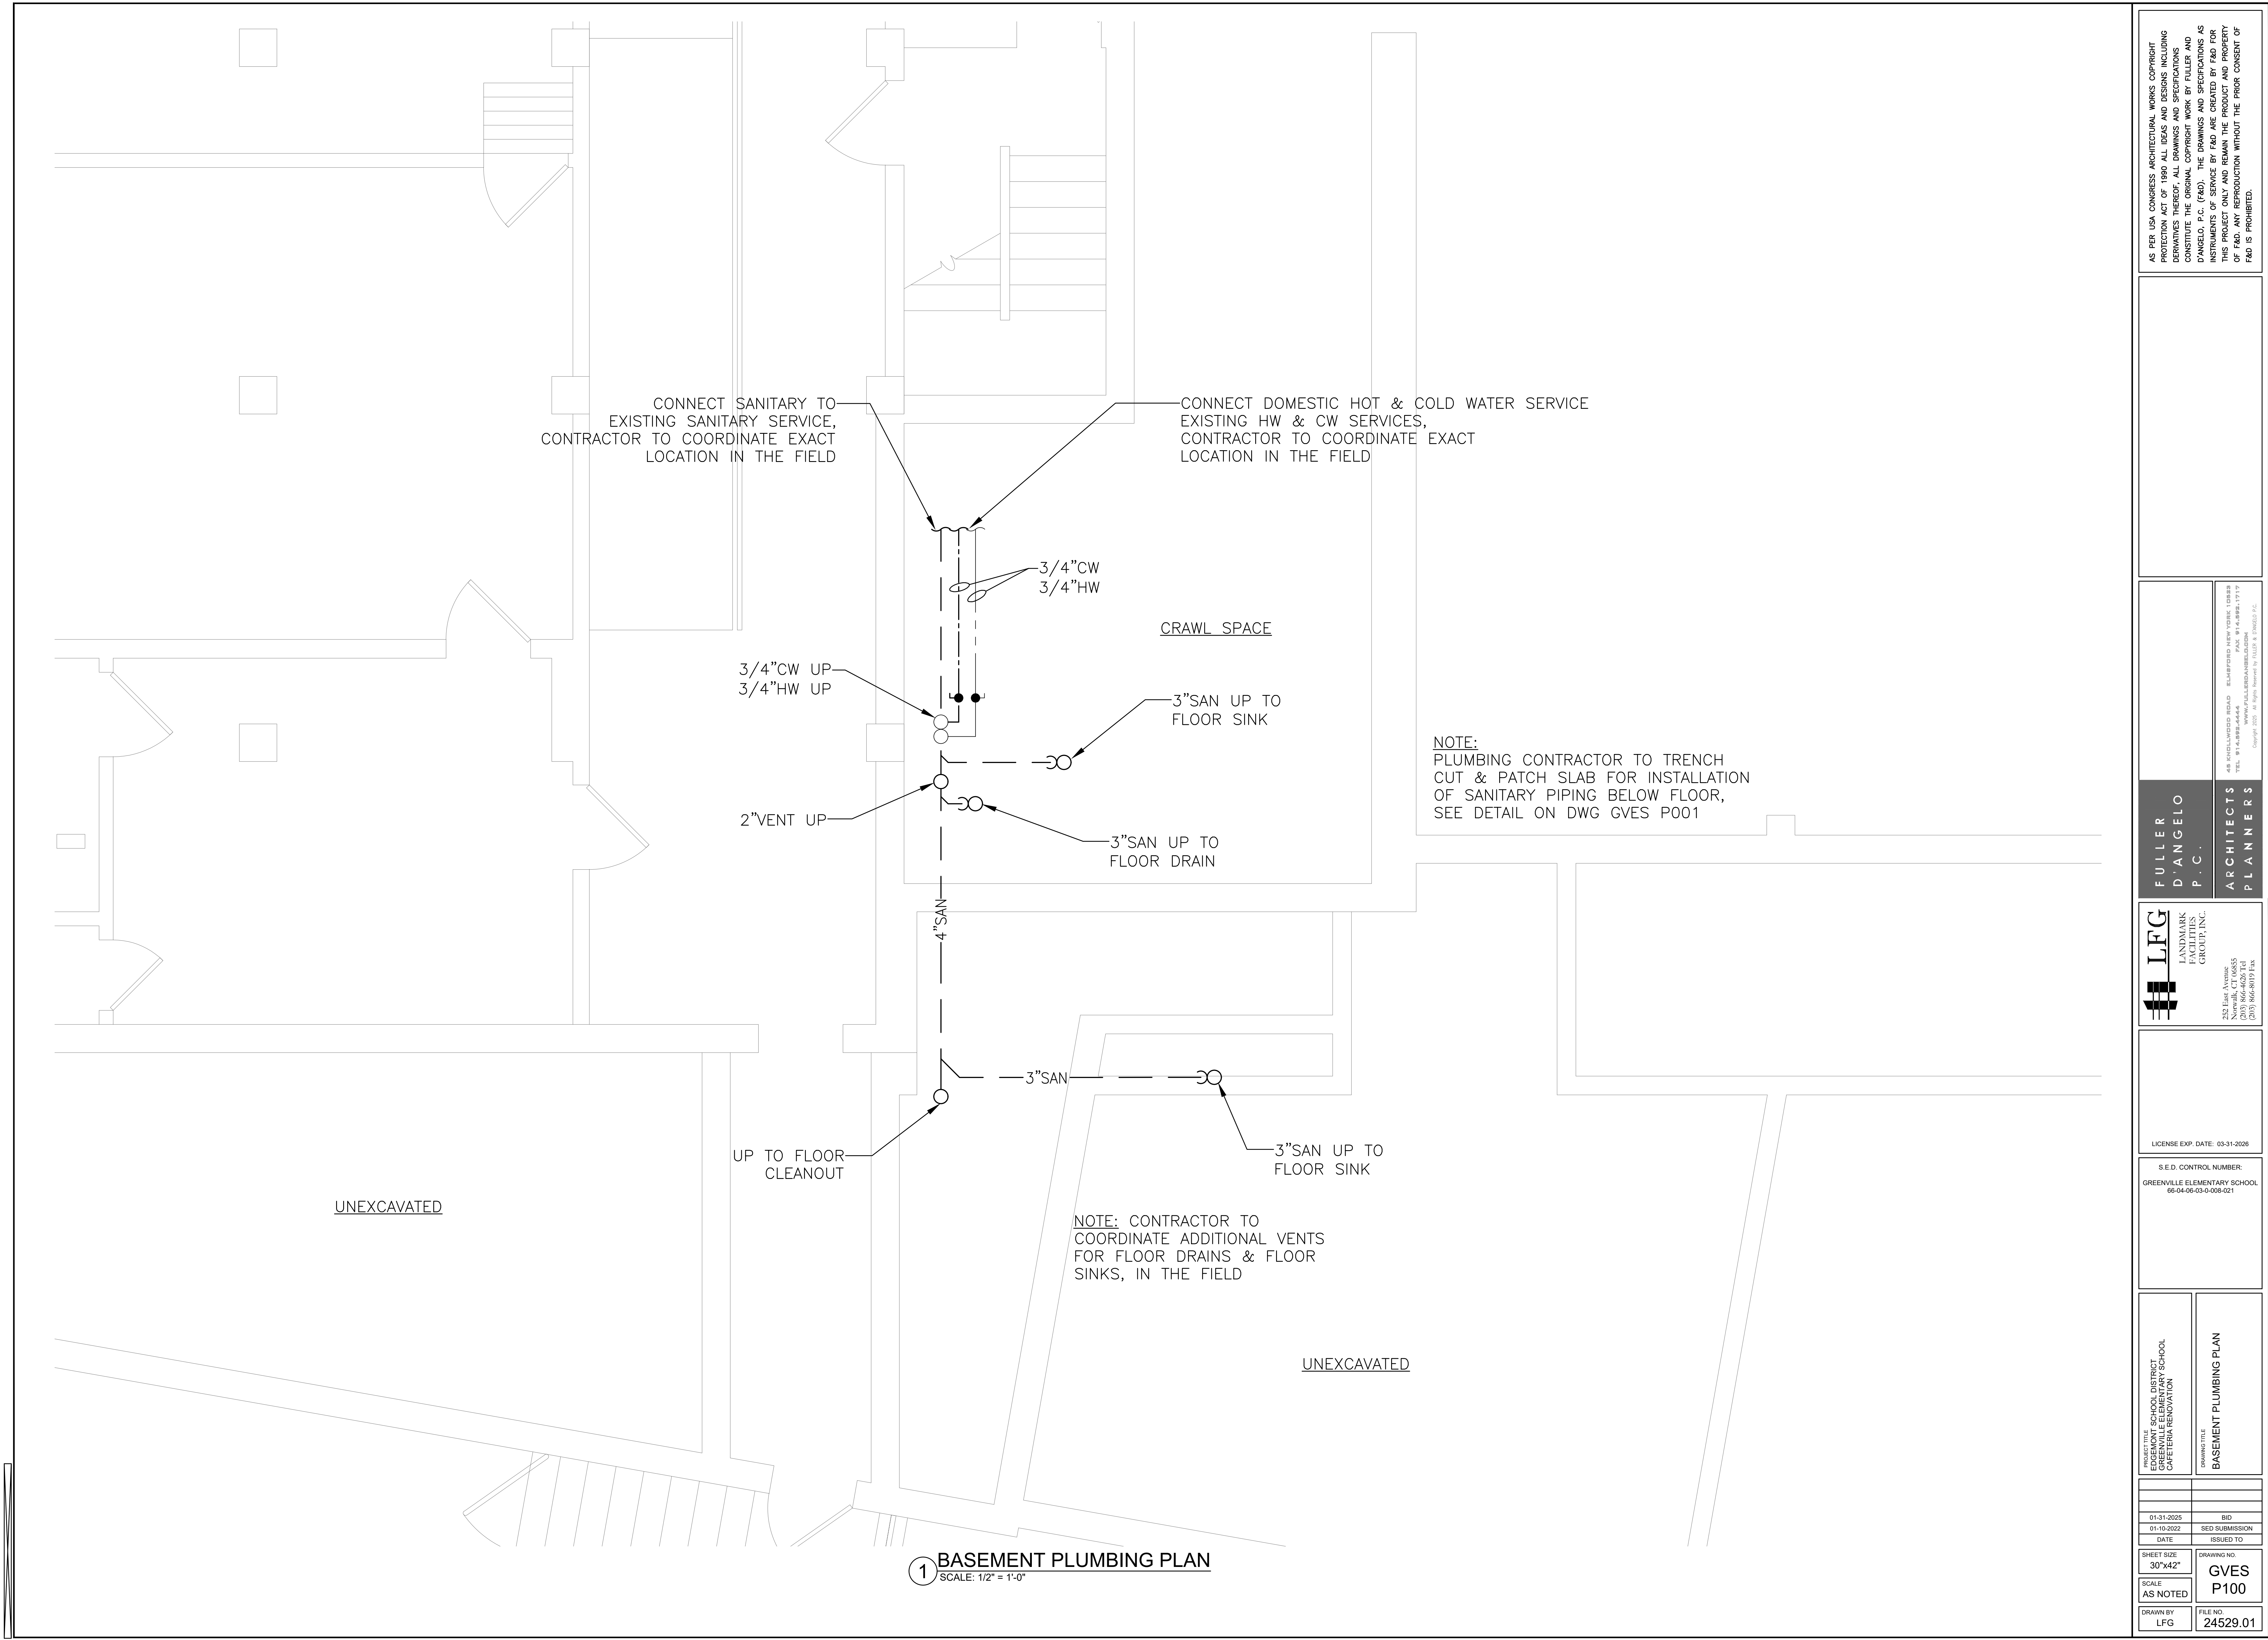

AS PER USA CONGRESS ARCHITECTURAL WORKS COPYRIGHT PROTECTION ACT OF 1990 ALL IDEAS AND DESIGNS INCLUDING DERIVATIVES THEREOF, ALL DRAWINGS AND SPECIFICATIONS CONSTITUTE THE ORIGINAL COPYRIGHT WORK BY FULLER AND D'ANGELO, P.C. (F&D). THE DRAWINGS AND SPECIFICATIONS AS INSTRUMENTS OF SERVICE BY F&D ARE CREATED BY F&D FOR THIS PROJECT ONLY AND REMAIN THE PRODUCT AND PROPERTY OF F&D. ANY REPRODUCTION WITHOUT THE PRIOR CONSENT OF F&D IS PROHIBITED.

FULLER
D'ANGELO
P.C.

ARCHITECTS
PLANNERS

LFG
LANDMARK
FACILITIES
GROUP, INC.

252 East Avenue
Greenville, South Carolina 29605
(253) 866-4628 FAX
(253) 866-4819 Fax

LICENSE EXP. DATE: 03-31-2026

S.E.D. CONTROL NUMBER:
GREENVILLE ELEMENTARY SCHOOL
66-04-06-03-0-008-021

PROJECT:
EDGEWORTH SCHOOL DISTRICT
GREENVILLE ELEMENTARY SCHOOL
CAFETERIA RENOVATION

DRAWING TITLE:
BASEMENT PLUMBING PLAN

01-31-2025	BID
01-10-2022	SED SUBMISSION
DATE	ISSUED TO


SHEET SIZE:
30"x42"

SCALE:
AS NOTED


DRAWN BY:
LFG

DRAWING NO.:
**GVES
P100**

FILE NO.:
24529.01

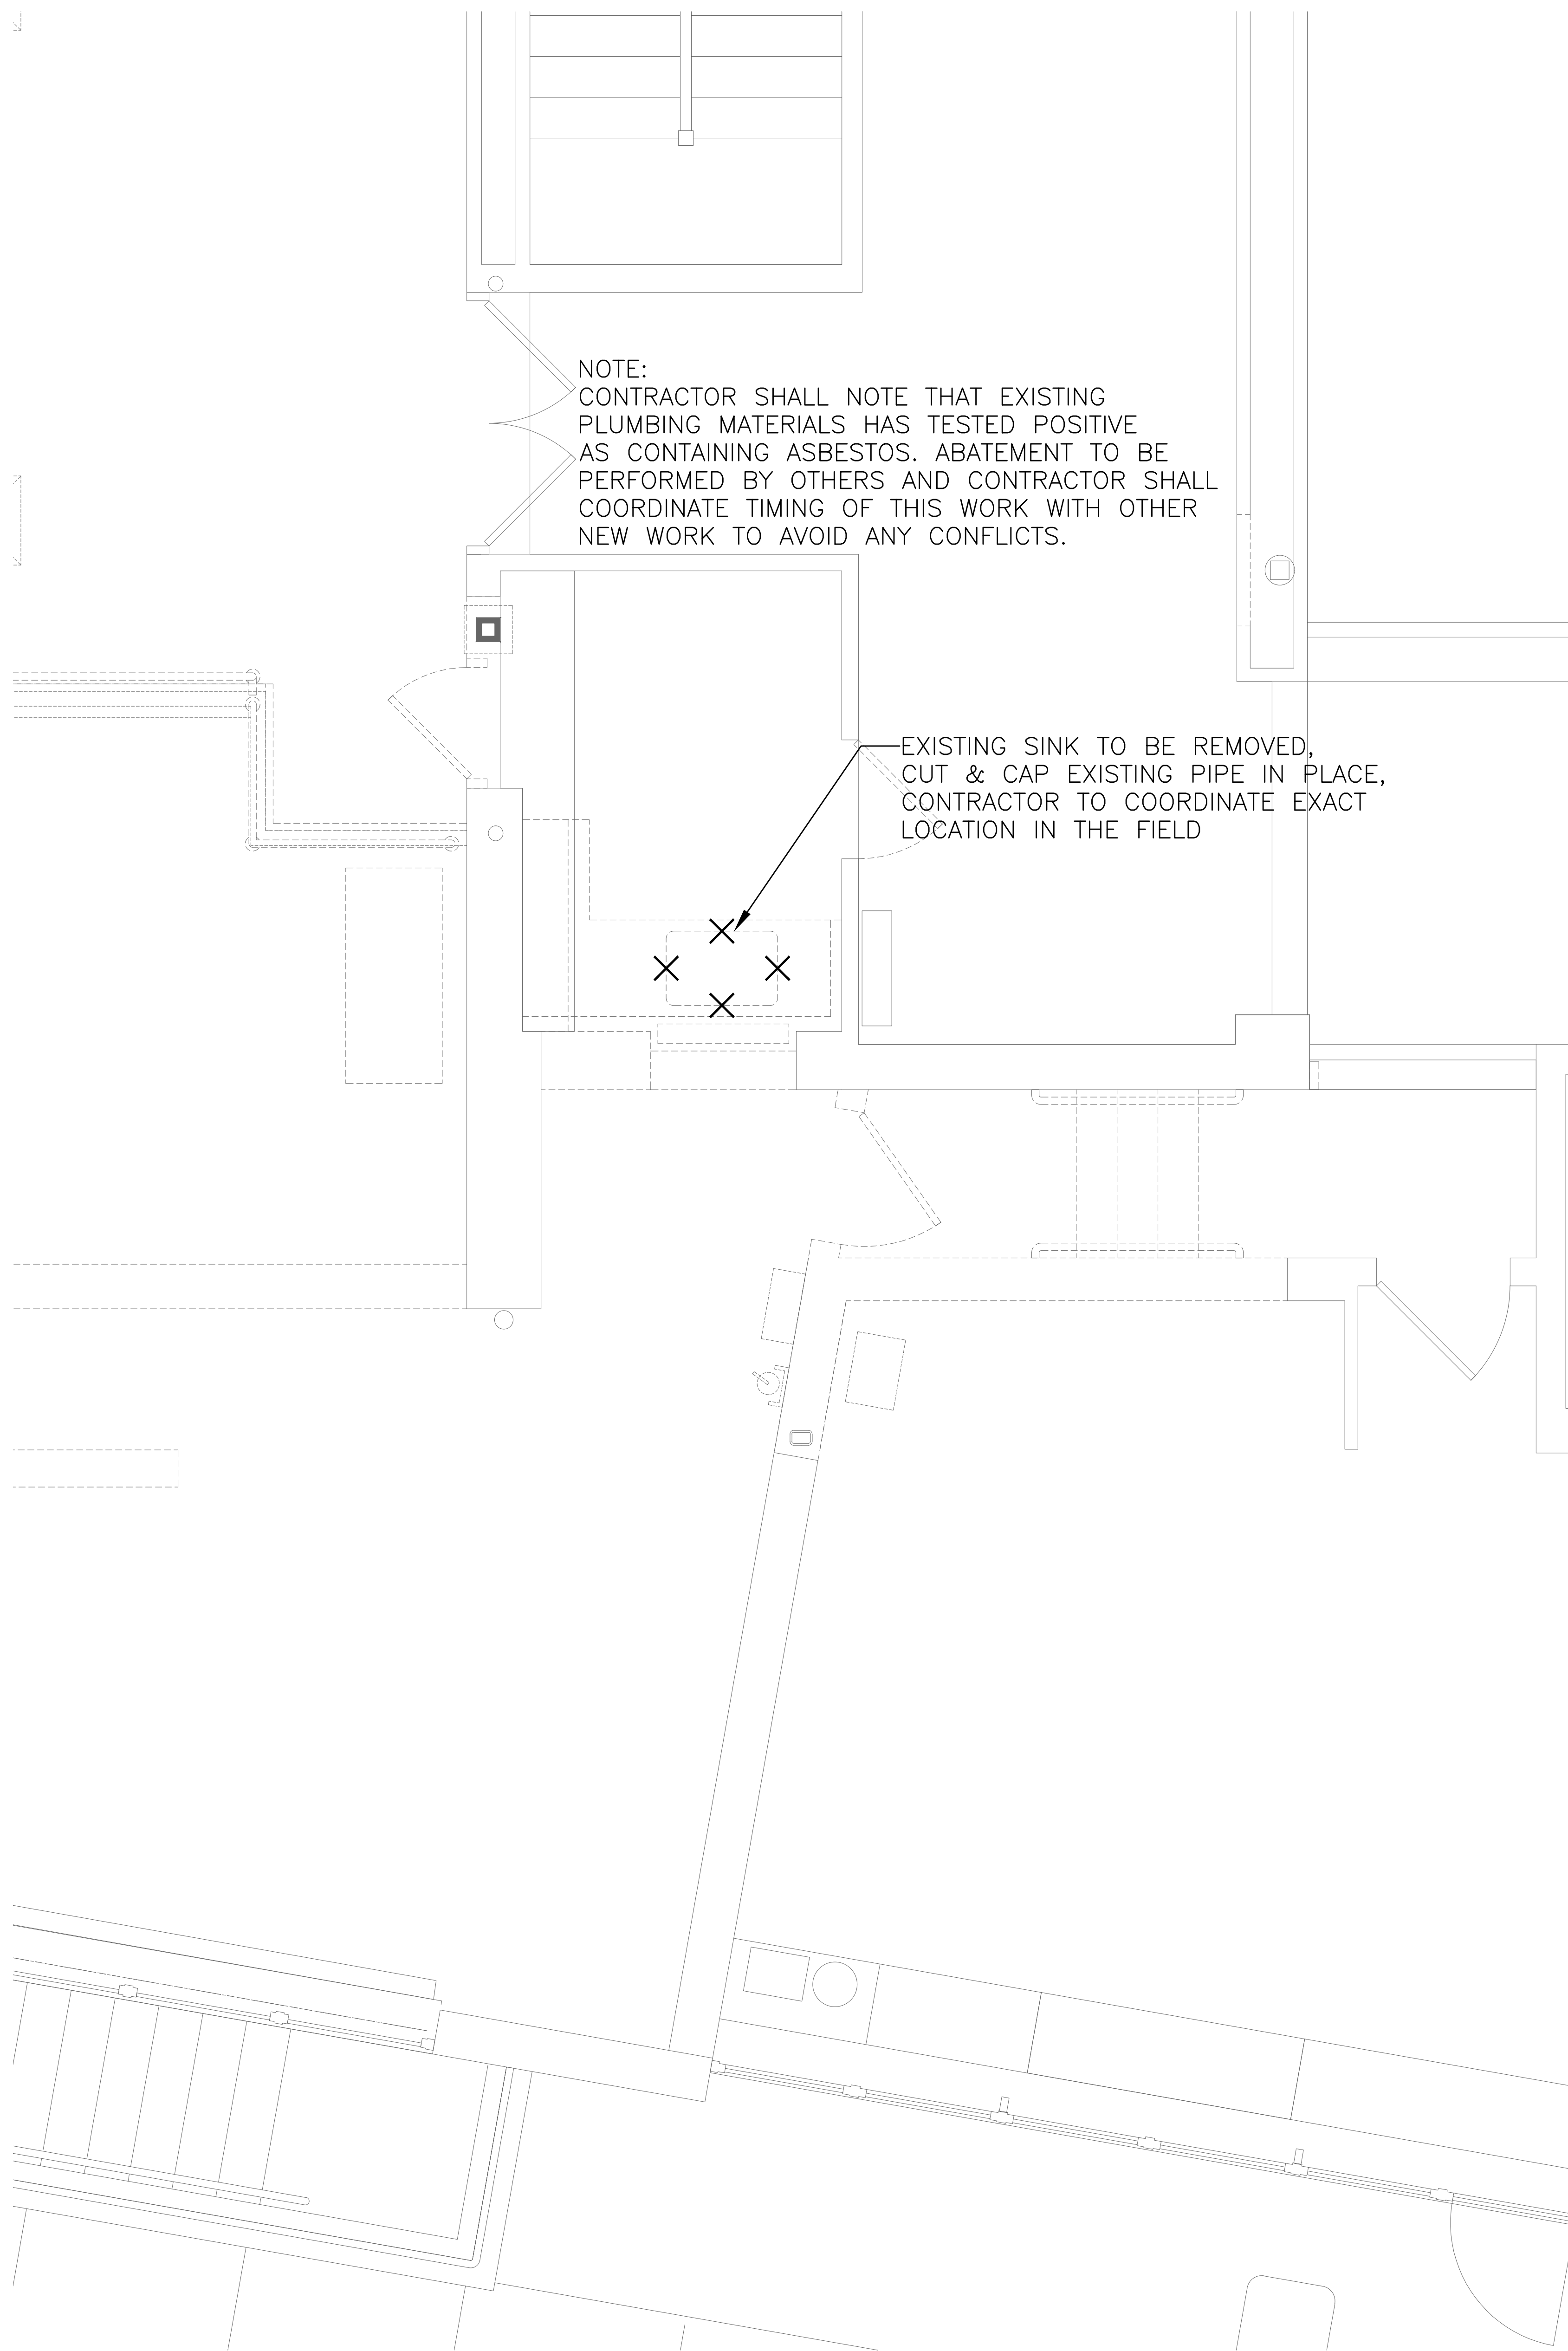

1 FIRST FLOOR PLUMBING DEMOLITION PLAN
SCALE: 1/2" = 1'-0"

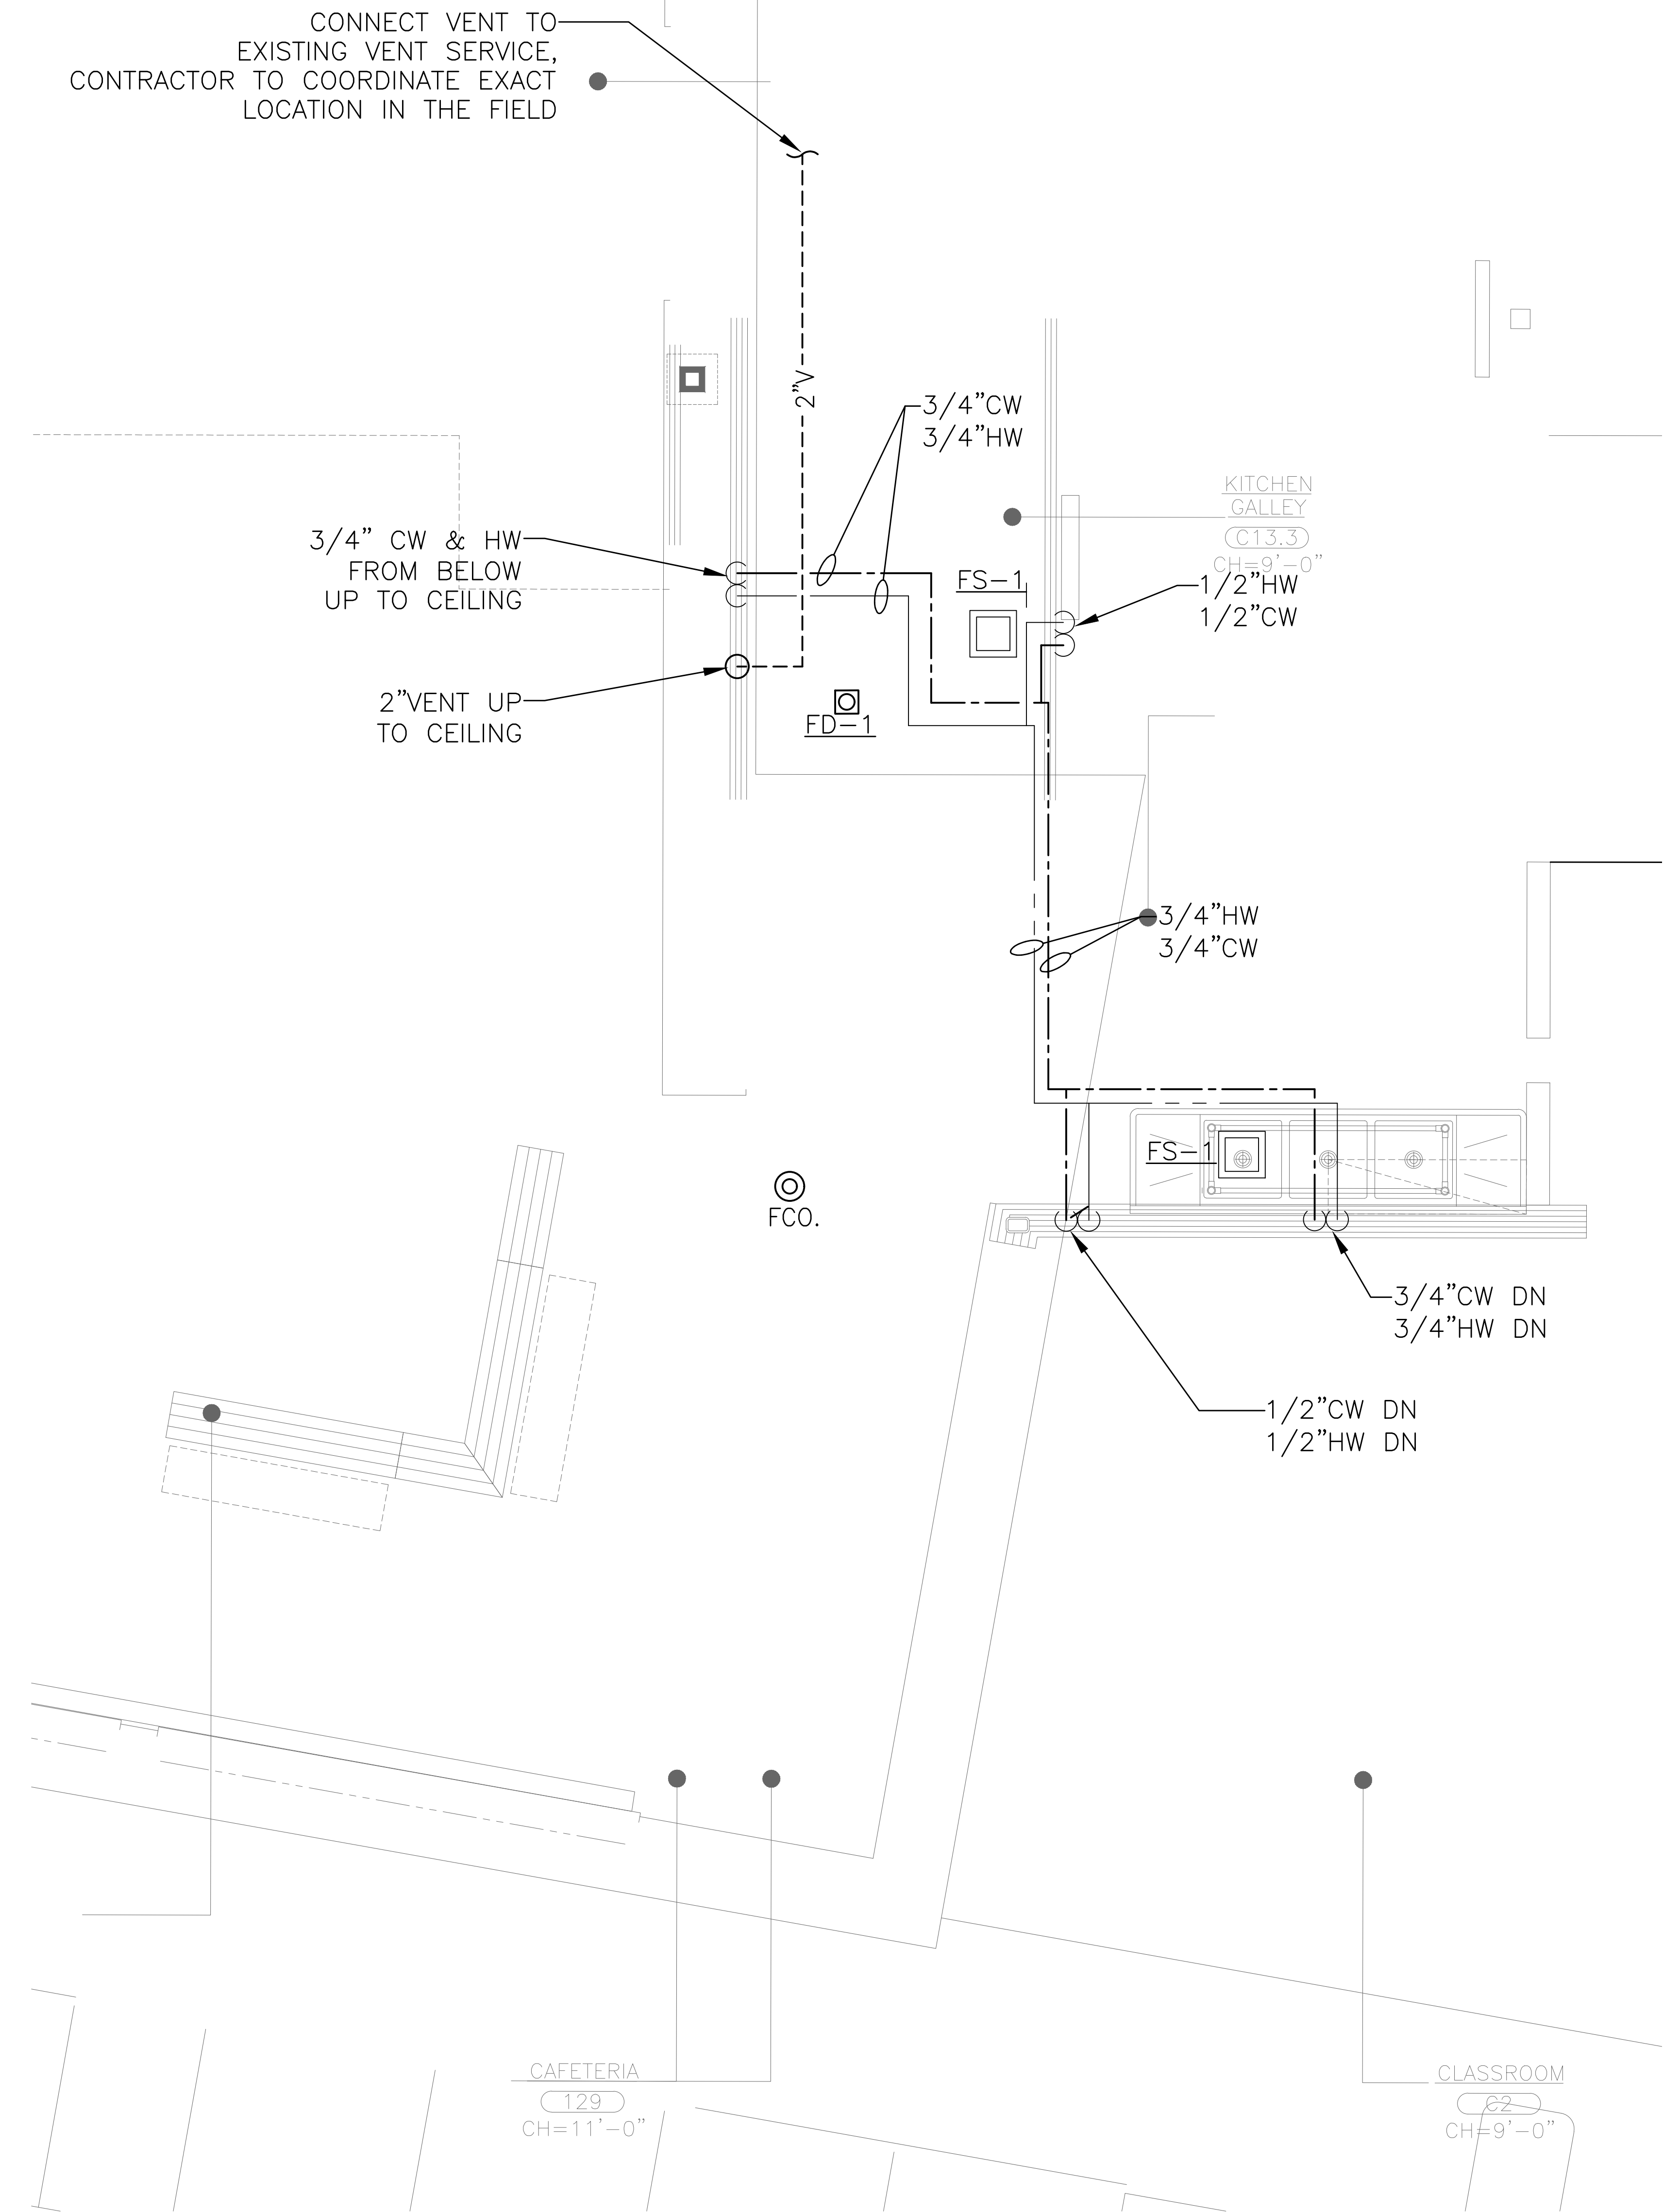

2 FIRST FLOOR PLUMBING PLAN
SCALE: 1/2" = 1'-0"

AS PER USA CONGRESS ARCHITECTURAL WORKS COPYRIGHT PROTECTION ACT OF 1990 ALL IDEAS AND DESIGNS INCLUDING DERIVATIVES THEREOF, ALL DRAWINGS AND SPECIFICATIONS CONSTITUTE THE ORIGINAL COPYRIGHT WORK BY FULLER AND DANIELO, P.C. (F&D). THE DRAWINGS AND SPECIFICATIONS AS INSTRUMENTS OF SERVICE BY F&D ARE CREATED BY F&D FOR THIS PROJECT ONLY AND REMAIN THE PROPERTY OF F&D. ANY REPRODUCTION WITHOUT THE PRIOR CONSENT OF F&D IS PROHIBITED.

408 CHILWELLWOOD ROAD ELLENBURGH NEW YORK 10888 FAX: 914.899.1179
TEL: 914.899.4444 FULLER & DANIELO, P.C.
Copyright 2022 All Rights Reserved by FULLER & DANIELO, P.C.

FULLER
DANIELO
P.C.
ARCHITECTS
PLANNERS










LFG
LANDMARK
FACILITIES
GROUP, INC.
252 East Avenue
New York, NY 10002
(212) 866-4020
(212) 866-4019 Fax


LICENSE EXP. DATE: 03-31-2026

S.E.D. CONTROL NUMBER:
GREENVILLE ELEMENTARY SCHOOL
66-04-06-03-0-008-021

EDMONT SCHOOL DISTRICT
GREENVILLE ELEMENTARY SCHOOL
CAFETERIA RENOVATION
DRAWING TITLE
FIRST FLOOR PLUMBING PLANS

01-31-2025	BID
01-10-2022	SED SUBMISSION
DATE	ISSUED TO
SHEET SIZE 30"x42"	DRAWING NO. GVES P101
SCALE AS NOTED	FILE NO. 24529.01
DRAWN BY LFG	

         LEGEND	
	MD MOTORIZED DAMPER
ARCH	ARCHITECT
UP	DUCT UP
DN	DUCT DOWN
FCU	FAN COIL UNIT
LD	LINEAR DIFFUSER
CFM	CUBIC FEET PER MINUTE, AIR
R/A	RETURN AIR
S/A	SUPPLY AIR
OA	OUTSIDE AIR
EXH	EXHAUST
EG	EXHAUST GRILLE
(E)	EXISTING
(N)	NEW
(CD)	CEILING DIFFUSER
TYP.	TYPICAL
WMS	WIRE MESH SCREEN
Ø	DIAMETER OF ROUND DUCT
RTU	ROOF-TOP UNIT
ERV	ENERGY RECOVERY VENTILATOR
HWC	HOT WATER COIL
MANU.	MANUFACTURER
TEMP	TEMPERATURE
MCA	MINIMUM CIRCUIT AMPACITY
RFS	RECOMMENDED FUSE SIZE
FLA	FULL LOAD AMPERES
MOCP	MAXIMUM OVERCURRENT PROTECTION
QTY	QUANTITY
EF	EXHAUST FAN
ESP	EXTERNAL STATIC PRESSURE
EWI	ENTERING WATER TEMPERATURE
LWT	LEAVING WATER TEMPERATURE
EAT	ENTERING AIR TEMPERATURE
LAT	LEAVING AIR TEMPERATURE
	DEMOLISH HIGHLIGHTED DUCTWORK AND EQUIPMENT
FD	FIRE DAMPER
COD	CABLE-OPERATED DAMPER
HP	HEAT PUMP
	THERMOSTAT
	DUCT SMOKE DETECTOR
	CARBON DIOXIDE SENSOR
#X#	DUCT DIMENSIONS (CLEAN INSIDE DIM.)
RAG	RETURN AIR GRILLE
	NEW LOW PRESS. STEAM PIPING
	NEW LOW PRESS. CONDENSATE PIPING
	VOLUME DAMPER ACROSS DUCTWORK
	POINT OF CONNECTION, NEW WORK TO EXISTING
	SECTION LINE

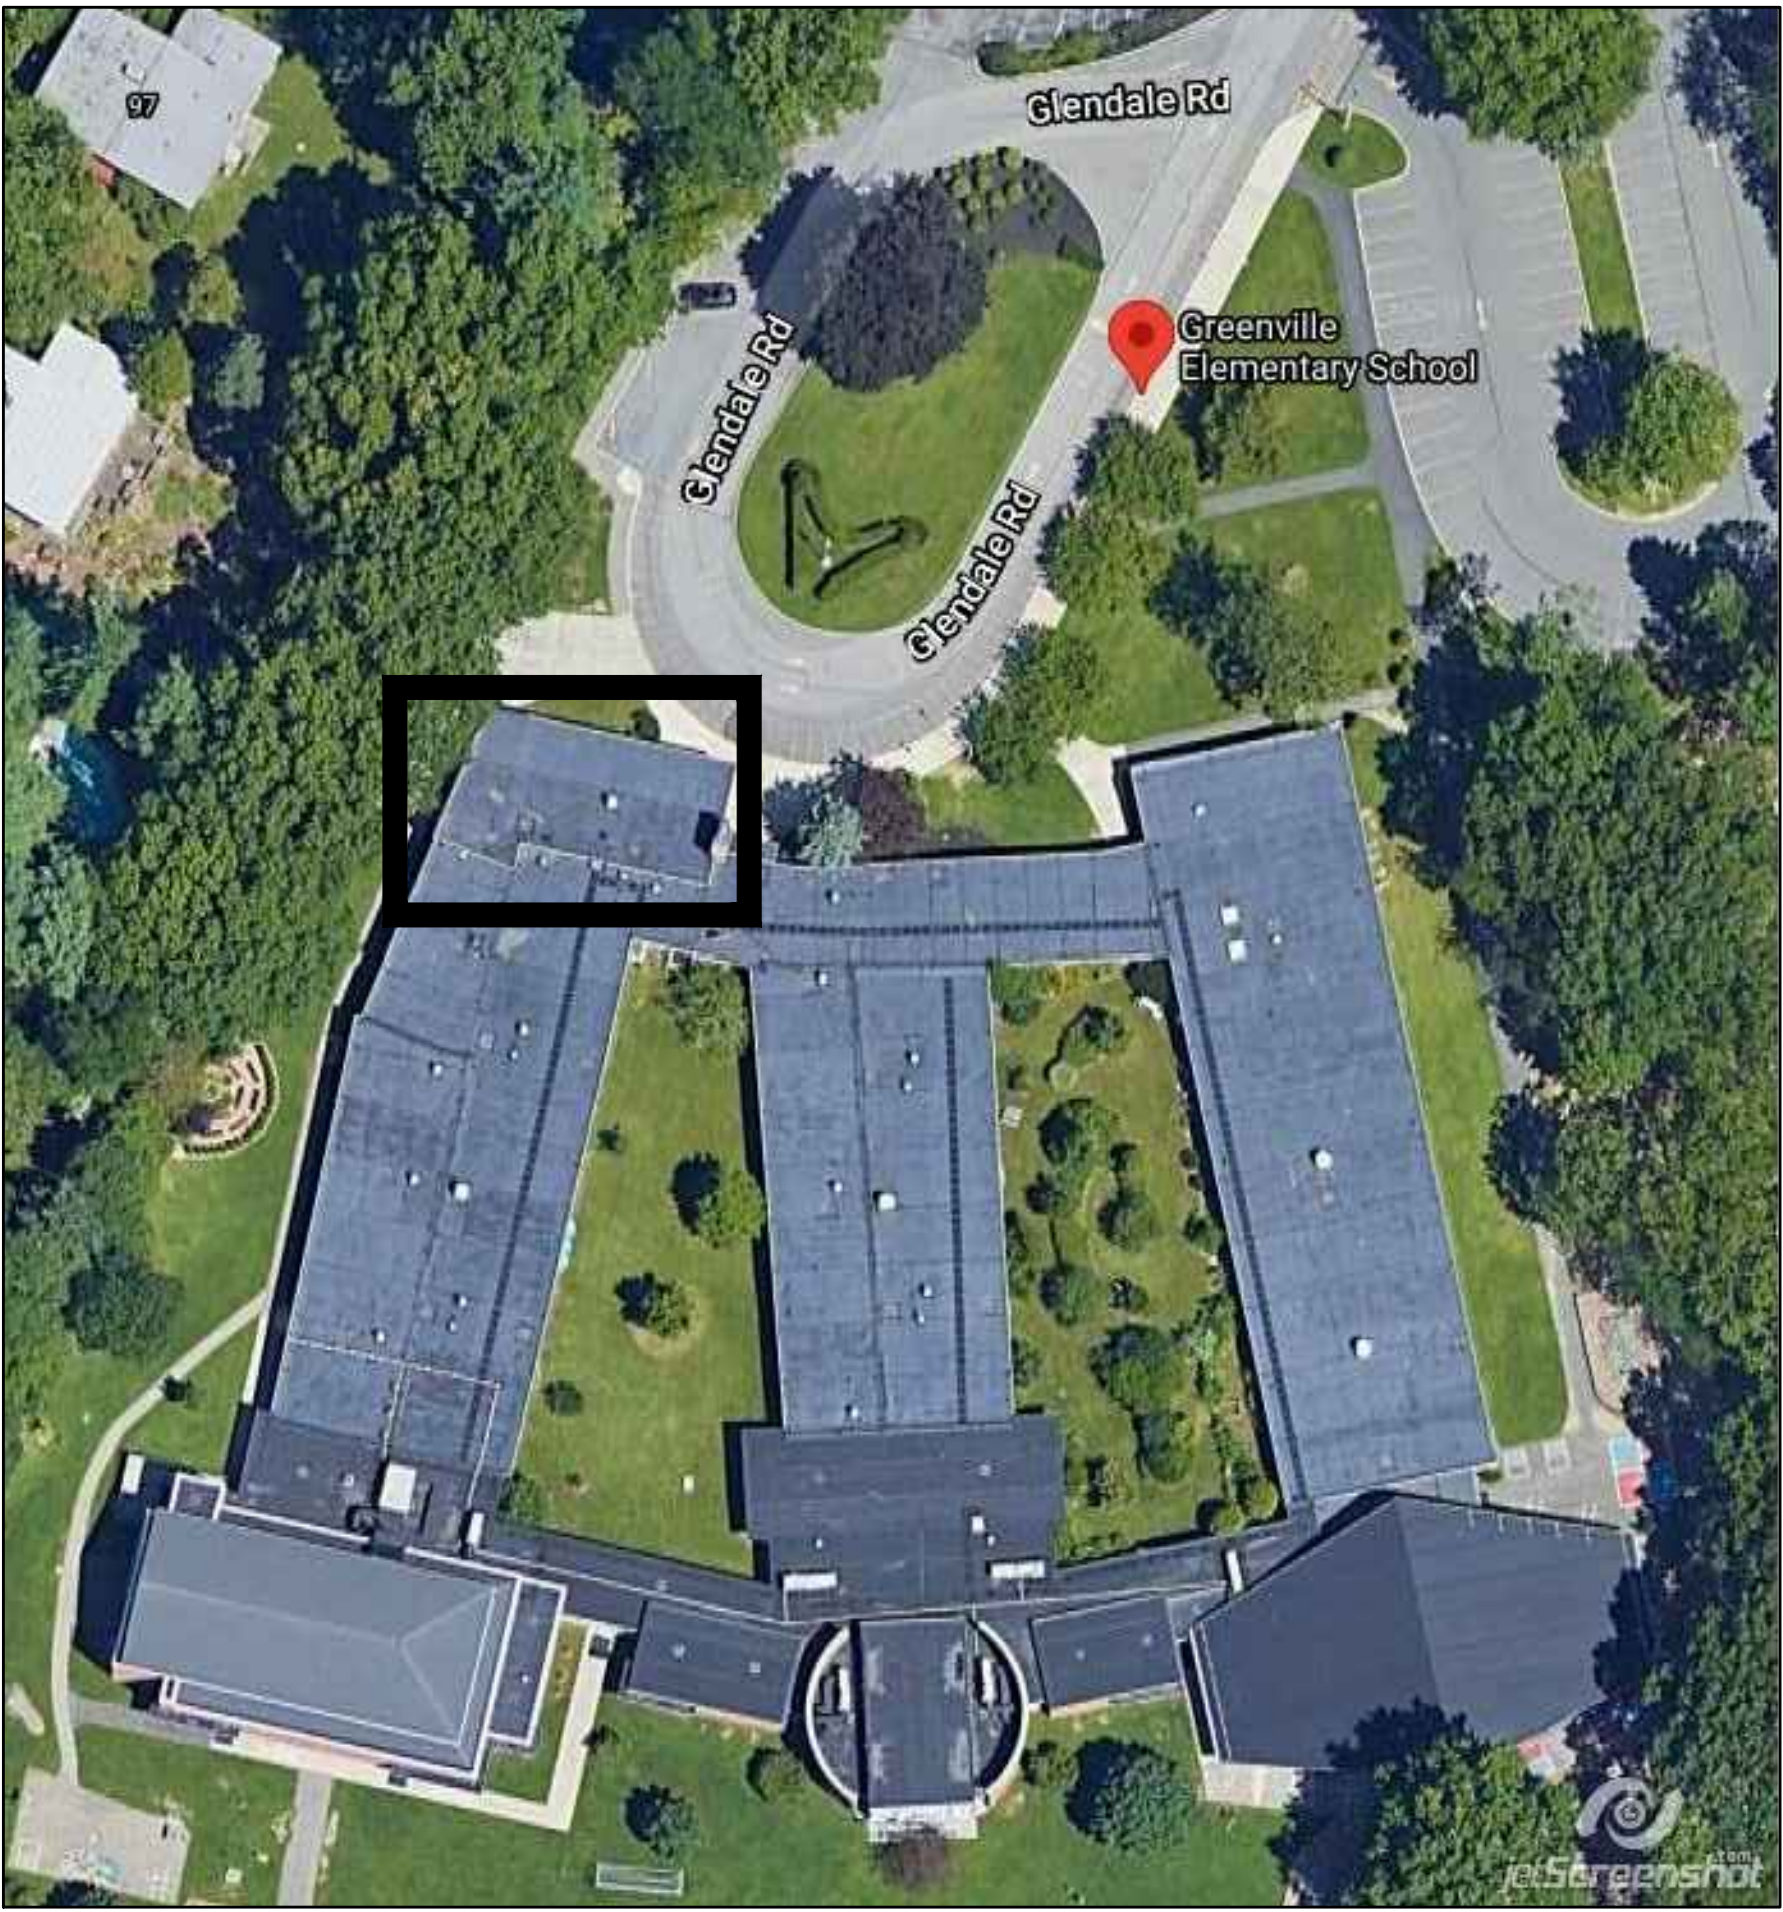

PROJECT DESCRIPTION

1. THE INTENT OF THIS PROJECT IS TO UPGRADE EXISTING HVAC SYSTEMS IN THE BUILDING. THIS INCLUDES, BUT IS NOT LIMITED TO, THE FOLLOWING WORK:

- RIGGING OF NEW EQUIPMENT ONTO ROOF OF BUILDING
- NEW STRUCTURAL STEEL DUNNAGE (REFER TO STRUCTURAL PLANS)
- NEW GALVANIZED SHEET METAL DUCTWORK WHERE INDICATED
- NEW DUCT MOUNTED STEAM COIL WHERE INDICATED
- AIR TESTING AND BALANCING
- NEW DDC CONTROLS FOR ALL EQUIPMENT, EQUIPMENT STARTUP AND TESTING BY FACTORY AUTHORIZED REPRESENTATIVES.
- CLOSEOUT PACKAGE INCLUDING CUT SHEETS, AS BUILT DRAWINGS AND WARRANTY INFORMATION.
- OWNER TRAINING ON NEW EQUIPMENT AND CONTROLS.

2. IN ADDITION TO EQUIPMENT SUBMITTALS CONTRACTOR SHALL ISSUE A 3/8" SCALE PIPING SHOP DRAWING TO ENGINEER FOR REVIEW AND APPROVAL PRIOR TO COMMENCEMENT OF WORK.

3. CONTRACTOR SHALL NOTE THAT EXISTING BAS HARDWARE IS MANUFACTURED BY ANDOVER. CONTRACTOR SHALL PROVIDE ALLOWANCE FOR HVAC CONTROLS AS INDICATED IN FRONT END SPECIFICATIONS.

ATC CONTRACTOR SHALL FURNISH AND INSTALL ALL HARDWARE AND WIRING REQUIRED FOR CONTROL AND MONITORING OF NEW HVAC EQUIPMENT. ATC CONTRACTOR SHALL DO ALL PROGRAMMING, BUILD ALL GRAPHICS FOR NEW EQUIPMENT AND UPDATE THERMAL FLOOR PLANS FOR NEW TEMPERATURE ZONES. ESTABLISH OCCUPANCY SCHEDULES WITH OWNER AND ROUTING OF ALARMS.

REFER TO CONTROLS DIAGRAM (SHEET M-102) FOR ADDITIONAL INFORMATION.

PROJECT NOTES:

1. ALL BIDDERS SHALL VISIT PROJECT SITE TO THOROUGHLY FAMILIARIZE THEMSELVES WITH EXISTING CONDITIONS. CLAIMS FOR EXTRA PAYMENTS FOR WORK, WHICH COULD HAVE BEEN IDENTIFIED VIA CAREFUL SITE INSPECTION, WILL NOT BE ACKNOWLEDGED.

2. PRIOR TO COMMENCEMENT OF WORK, CONTRACTOR SHALL PREPARE EQUIPMENT SUBMITTALS PER SPECIFICATIONS AND SUBMIT TO DESIGN ENGINEER FOR REVIEW/APPROVAL.

3. UPON COMPLETION OF WORK, CONTRACTOR SHALL SUBMIT AS-BUILTS DRAWINGS IN ACCORDANCE WITH SPECIFICATIONS.

4. PRIOR TO CLOSEOUT, CONTRACTOR SHALL SUBMIT OPERATION AND MAINTENANCE MANUAL TO ENGINEER FOR APPROVAL. FOLLOWING APPROVAL, CONTRACTOR SHALL DELIVER (1) HARD COPY AND (1) DIGITAL COPY ON THUMB DRIVE TO OWNER.

AS PER USA CONGRESS ARCHITECTURAL WORKS COPYRIGHT PROTECTION ACT OF 1990 ALL IDEAS AND DESIGNS INCLUDING DERIVATIVES THEREOF, ALL DRAWINGS AND SPECIFICATIONS CONSTITUTE THE ORIGINAL COPYRIGHT WORK BY FULLER AND DANKELO, P.C. (F&D). THE DRAWINGS AND SPECIFICATIONS AS INSTRUMENTS OF SERVICE BY F&D ARE CREATED BY F&D FOR THIS PROJECT ONLY AND REMAIN THE PROPERTY OF F&D. ANY REPRODUCTION WITHOUT THE PRIOR CONSENT OF F&D IS PROHIBITED.

408 KNEELANDWOOD ROAD ELLENBURGH NEW YORK 10889 FAX: 914.899.1179
TEL: 914.899.4444
Copyright 2025 All Rights Reserved by FULLER & DANKELO P.C.

FULLER
D'ANGELO
P.C.
ARCHITECTS
PLANNERS

LFG
LANDMARK
FACILITIES
GROUP, INC.
252 East Avenue
New Rochelle, NY 10801
(203) 866-4624 FAX
(203) 866-4019 Fax

LICENSE EXP. DATE: 03-31-2026

S.E.D. CONTROL NUMBER:
GREENVILLE ELEMENTARY SCHOOL
66-04-06-03-0-008-021


PROJECT NAME
EDGEMONT SCHOOL DISTRICT
GREENVILLE ELEMENTARY SCHOOL
CAFETERIA RENOVATION
DRAWING TITLE
MECHANICAL NOTES & LEGEND

01-31-2025	BID
01-10-2022	SED SUBMISSION
DATE	ISSUED TO

SHEET SIZE 30"x42"	DRAWING NO. GVES M001
SCALE AS NOTED	
DRAWN BY LFG	FILE NO. 24529.01

PLOT DATE: January 17, 2025 -- 5:09pm

FILE: N:\Edgemont School District\Greenville Elementary\Cafeteria Reno\ACAD\Mechanical\GV CAFE_M001_M300.dwg

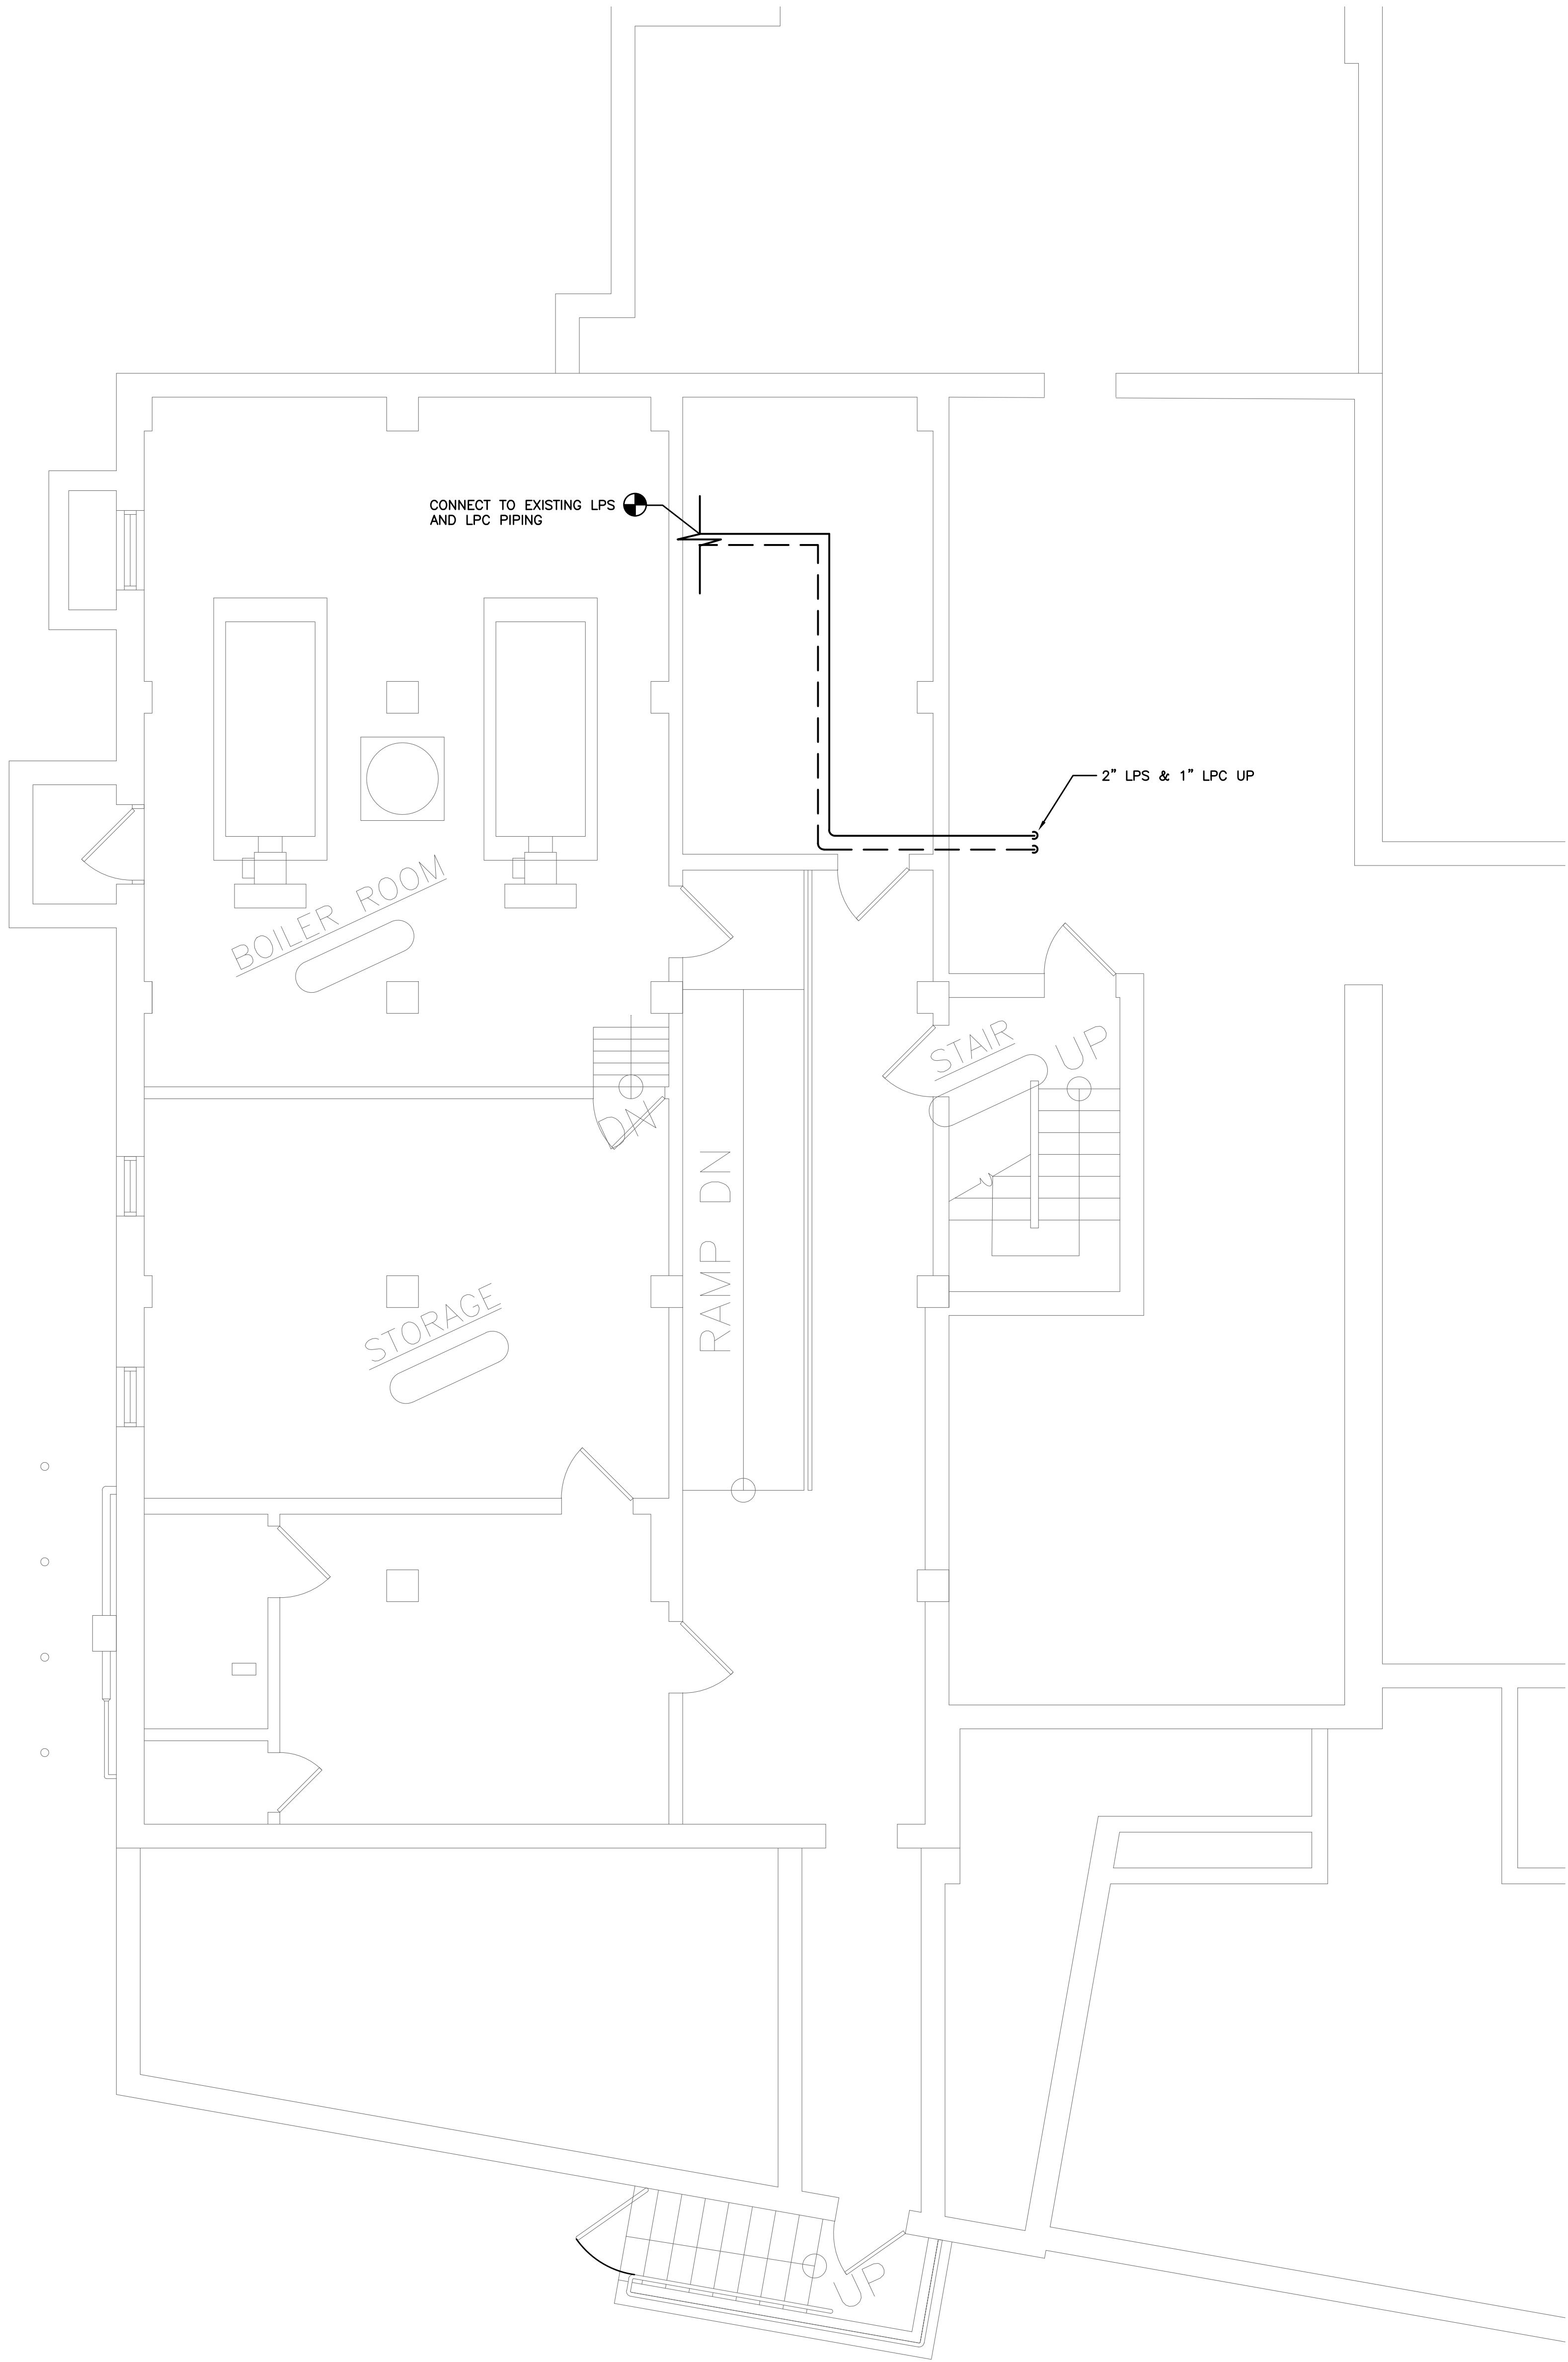

**BASEMENT
MECHANICAL PLAN**
SCALE: 1/4" = 1'-0"

NOTES:

1. REFER TO WRITTEN (BOOK) SPECS FOR ADDITIONAL INFORMATION.
2. CONTRACTOR SHALL NOTE THAT EXISTING PIPE AND DUCT INSULATION HAS TESTED POSITIVE AS CONTAINING ASBESTOS. ABATEMENT TO BE PERFORMED BY OTHERS AND CONTRACTOR SHALL COORDINATE TIMING OF THIS WORK WITH NEW MECHANICAL WORK TO AVOID ANY CONFLICTS.

AS PER USA CONGRESS ARCHITECTURAL WORKS COPYRIGHT PROTECTION ACT OF 1990 ALL IDEAS AND DESIGNS INCLUDING DERIVATIVES THEREOF, ALL DRAWINGS AND SPECIFICATIONS CONSTITUTE THE ORIGINAL COPYRIGHT WORK BY FULLER AND D'ANGELO, P.C. (F&D). THE DRAWINGS AND SPECIFICATIONS AS INSTRUMENTS OF SERVICE BY F&D ARE CREATED BY F&D FOR THIS PROJECT ONLY AND REMAIN THE PRODUCT AND PROPERTY OF F&D. ANY REPRODUCTION WITHOUT THE PRIOR CONSENT OF F&D IS PROHIBITED.

408 CHILLOWOOD ROAD ELLENBORO NEW YORK 12828
TEL: 814-898-4444 FAX: 814-898-1179
Copyright 2022 All Rights Reserved by FULLER & D'ANGELO P.C.

**FULLER
D'ANGELO
P.C.**
**ARCHITECTS
PLANNERS**

LFG
LANDMARK
FACILITIES
GROUP, INC.
252 East Avenue
Greenville, SC 29615
(253) 866-4024 FAX
(253) 866-4019 Fax

LICENSE EXP. DATE: 03-31-2026


S.E.D. CONTROL NUMBER:
GREENVILLE ELEMENTARY SCHOOL
66-04-06-03-0-008-021

PROJECT:
EDGEMONT SCHOOL DISTRICT
GREENVILLE ELEMENTARY SCHOOL
CAFETERIA RENOVATION
DRAWING TITLE:
**BASEMENT
MECHANICAL PLAN**

01-31-2025	BID
01-10-2022	SED SUBMISSION
DATE	ISSUED TO
SHEET SIZE: 30"x42"	DRAWING NO. GVES M100
SCALE: AS NOTED	FILE NO. 24529.01
DRAWN BY: LFG	

PLOT DATE: January 17, 2025 -- 5:10pm

FILE: N:\Edgemont School District\Greenville Elementary\Cafeteria Reno\ACAD\Mechanical\GV CAFE_M001_M300.dwg

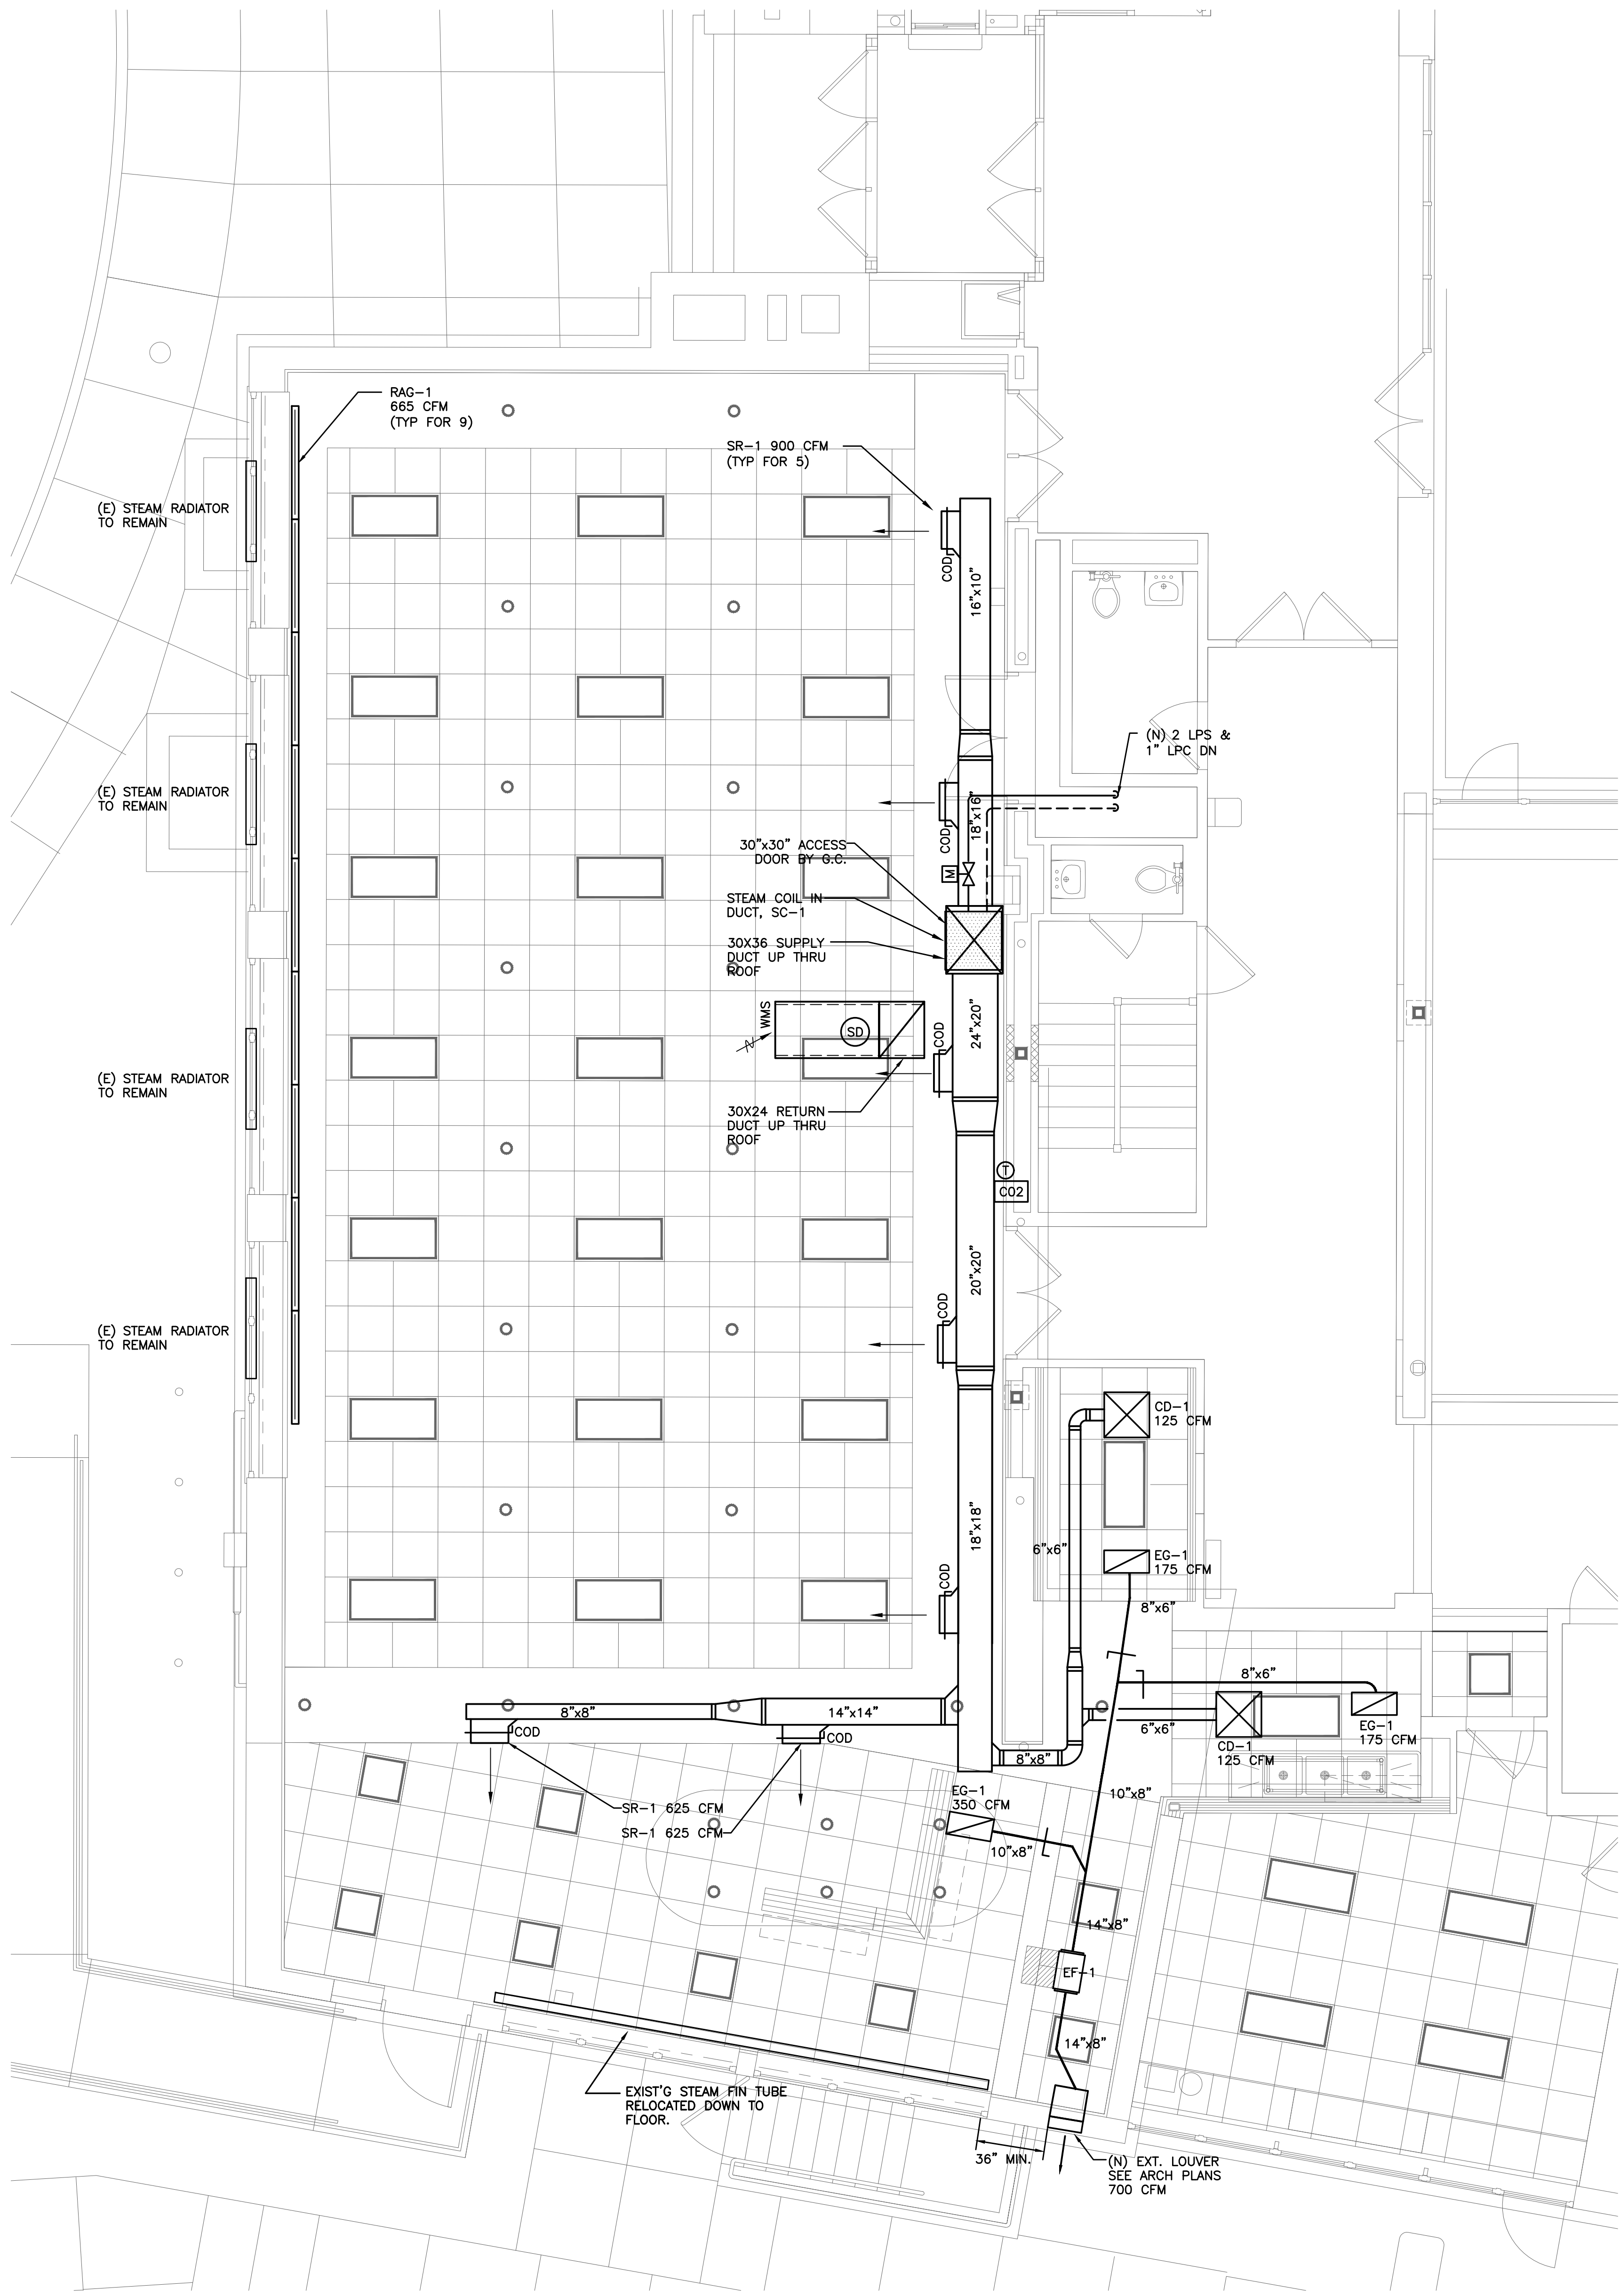

NOTES:

1. REFER TO WRITTEN (BOOK) SPECS FOR ADDITIONAL INFORMATION.
2. DUCTWORK SHALL BE INSTALLED TIGHT TO HUNG CEILING AS POSSIBLE. MAKE TRANSITIONS TO INLET AND OUTLET OF STEAM COIL IN LEAST AMOUNT OF VERTICAL SPACE. EXPOSED SPIRAL DUCT SHALL BE FURNISHED WITH 'PAINT GRIP' FINISH SUITABLE FOR FIELD PAINTING BY GC. DUCTWORK SHALL BE DOUBLE WALL TYPE WITH INTEGRAL INSULATION.
3. CONTRACTOR SHALL COORDINATE INSTALLATION OF ALL WALL MOUNTED DEVICES (IE. THERMSTATS) WITH ARCHITECT & DESIGN ENGINEER PRIOR TO ROUGHING WIRING.
4. ALL BRANCH DUCTS SHALL BE EQUIPPED WITH VOLUME DAMPERS WHETHER INDICATED ON PLANS OR NOT. DUCTS ABOVE HARD CEILINGS (INCLUDING SOFFITS) SHALL BE CABLE-OPERATED DAMPERS.
5. ALL DUCTWORK WITHIN 15 FT. OF FANS SHALL BE INTERNALLY LINED WITH 1" LINER FOR ACOUSTICS.

**FIRST FLOOR
MECHANICAL PLAN**
SCALE: 1/4" = 1'-0"

AS PER USA CONGRESS ARCHITECTURAL WORKS COPYRIGHT PROTECTION ACT OF 1990 ALL IDEAS AND DESIGNS INCLUDING DERIVATIVES THEREOF, ALL DRAWINGS AND SPECIFICATIONS CONSTITUTE THE ORIGINAL COPYRIGHT WORK BY FULLER AND DANIELO, P.C. (F&D). THE DRAWINGS AND SPECIFICATIONS AS INSTRUMENTS OF SERVICE BY F&D ARE CREATED BY F&D FOR THIS PROJECT ONLY AND REMAIN THE PRODUCT AND PROPERTY OF F&D. ANY REPRODUCTION WITHOUT THE PRIOR CONSENT OF F&D IS PROHIBITED.

408 KNEELANDWOOD ROAD ELLENBURGH NEW YORK 10523 FAX: 914.899.1179
TEL: 914.899.4444
Copyright 2022 All Rights Reserved by FULLER & DANIELO P.C.

**FULLER
DANIELO
P.C.**
**ARCHITECTS
PLANNERS**

LFG
**LANDMARK
FACILITIES
GROUP, INC.**
252 East Avenue
Greenville, SC 29615
(203) 866-4028 FAX
(203) 866-4019 Fax

LICENSE EXP. DATE: 03-31-2026

S.E.D. CONTROL NUMBER:
GREENVILLE ELEMENTARY SCHOOL
66-04-06-03-0-008-021


PROJECT NAME:
EDGEMONT SCHOOL DISTRICT
GREENVILLE ELEMENTARY SCHOOL
CAFETERIA RENOVATION
DRAWING TITLE:
FIRST FLOOR
MECHANICAL RCP

01-31-2025	BID
01-10-2022	SED SUBMISSION
DATE	ISSUED TO
SHEET SIZE: 30"x42"	DRAWING NO. GVES M101
SCALE: AS NOTED	FILE NO. 24529.01
DRAWN BY: LFG	



- CONTROL SYSTEM DIAGRAM
NOT TO SCALE


01-31-2025	BID
01-10-2022	SED SUBMISSION
DATE	ISSUED TO
SHEET SIZE 30"x42"	DRAWING NO. GVES M102
SCALE AS NOTED	
DRAWN BY LFG	FILE NO. 24529.01

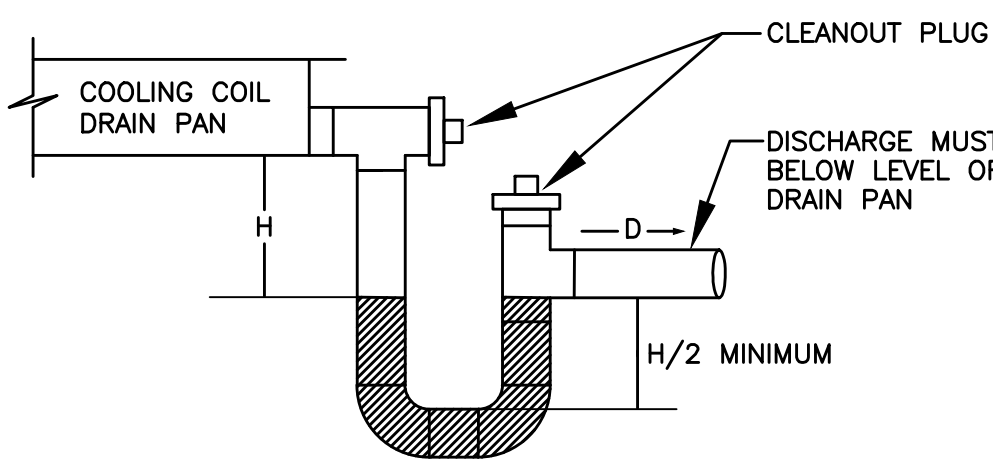


H = FAN INLET PRESSURE (IN. W.C.) + 1 IN.

CONDENSATE TRAP DETAIL
DRAW-THRU UNIT
NO SCALE


- NOTES:
1. ALLOW SUFFICIENT SPACE BELOW DRAIN PAN FOR TRAP.
 2. PITCH DRAIN FOR PROPER RUN-OFF.
 3. MANUALLY PRIME FILL TRAP BEFORE START-UP TO FORM INITIAL DRAIN SEAL.
 4. SUPPORT LENGTHY DRAIN LINES TO PREVENT SAG AND CONDENSATE OVERFLOW.
 5. FOR PIPING ON ROOF, ROUTE CONDENSATE PIPING TO WITHIN 5FT OF ROOF DRAIN.

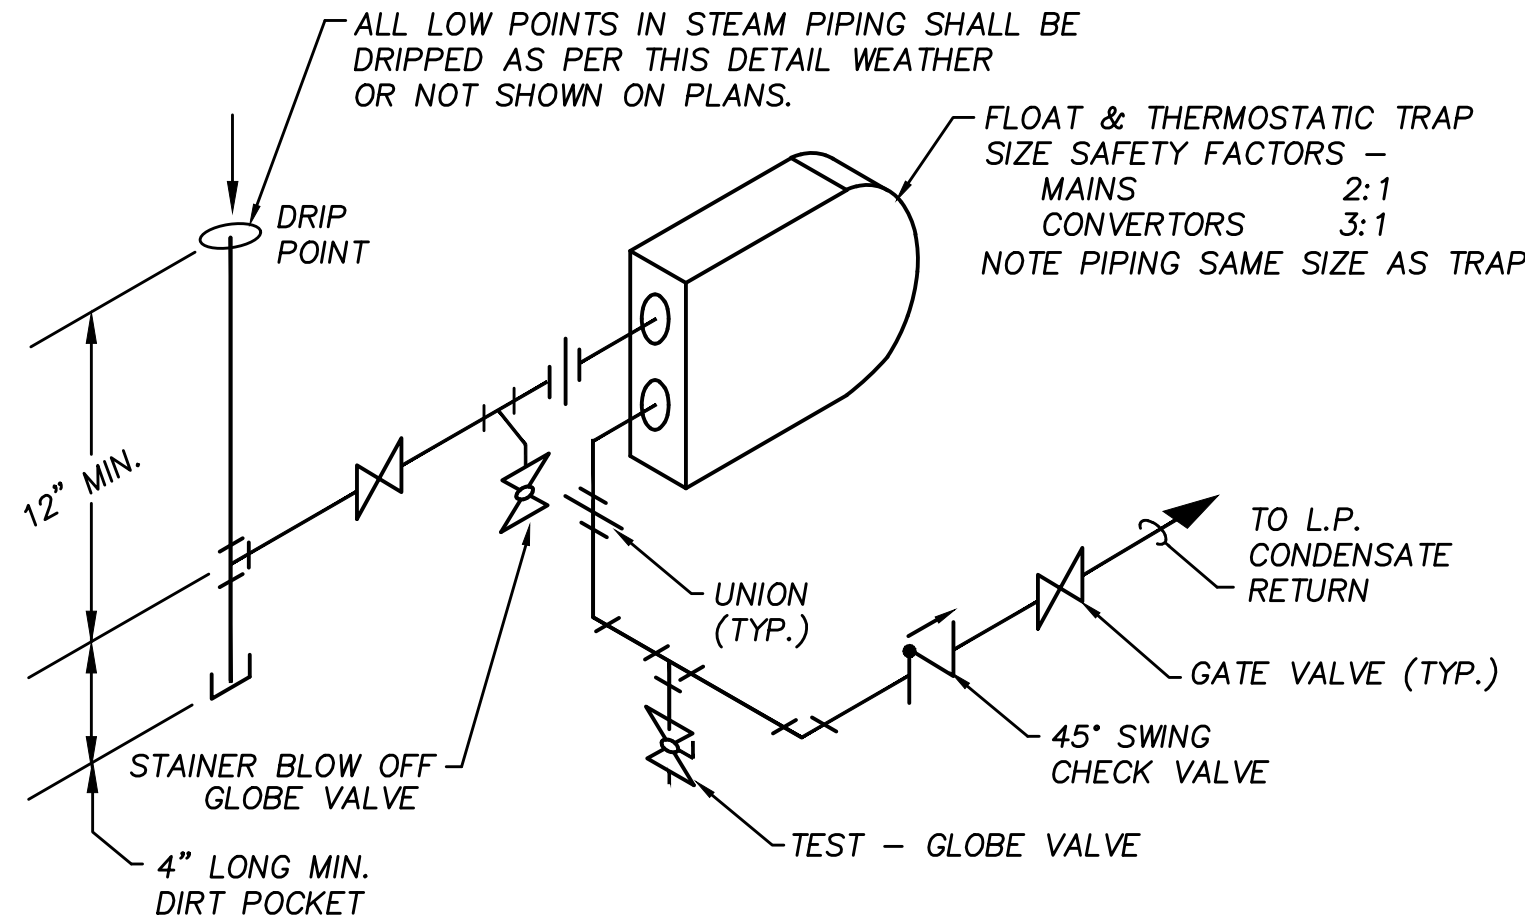


LOW PRESSURE STEAM MAIN DRIP DETAIL
N.T.S.

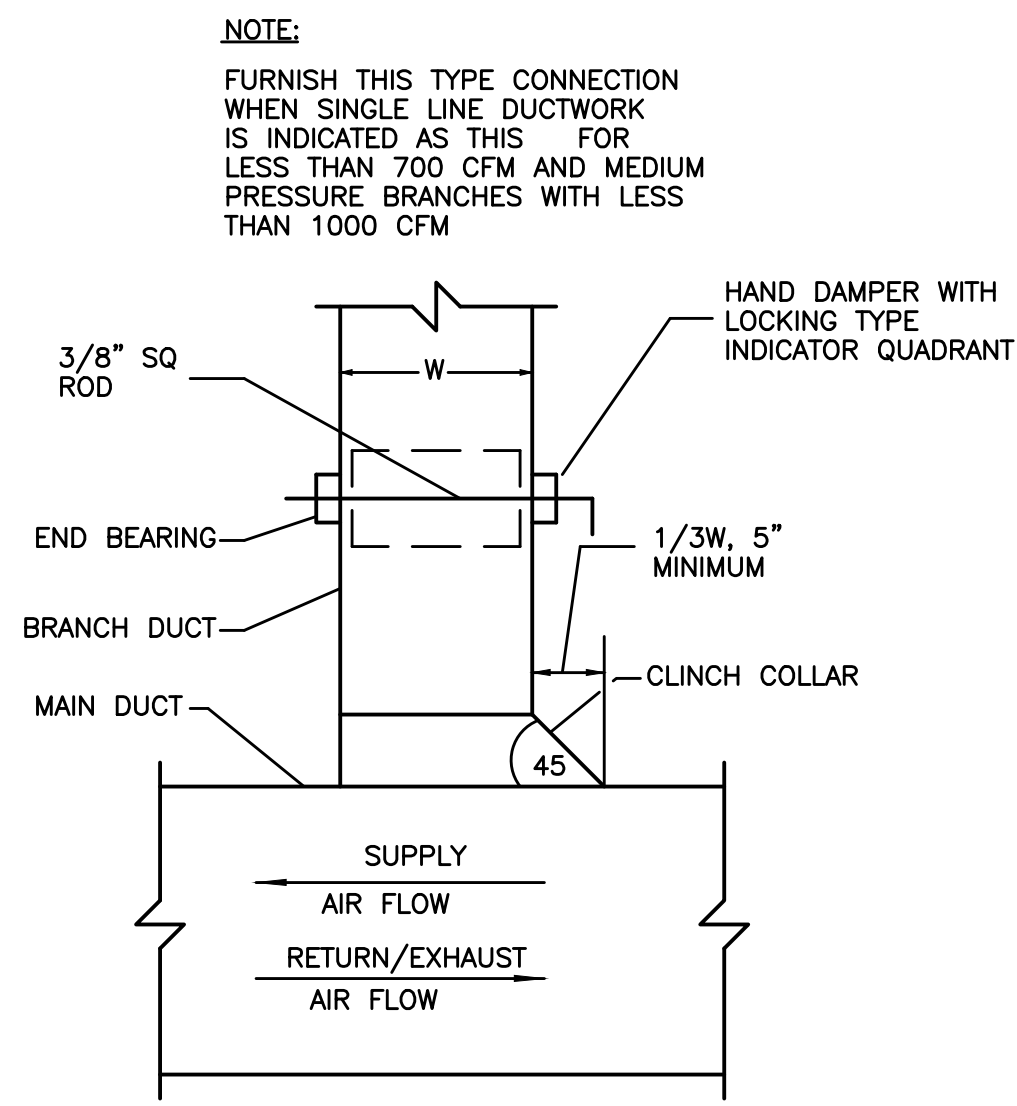


RECTANGULAR DUCT TAP
NO SCALE

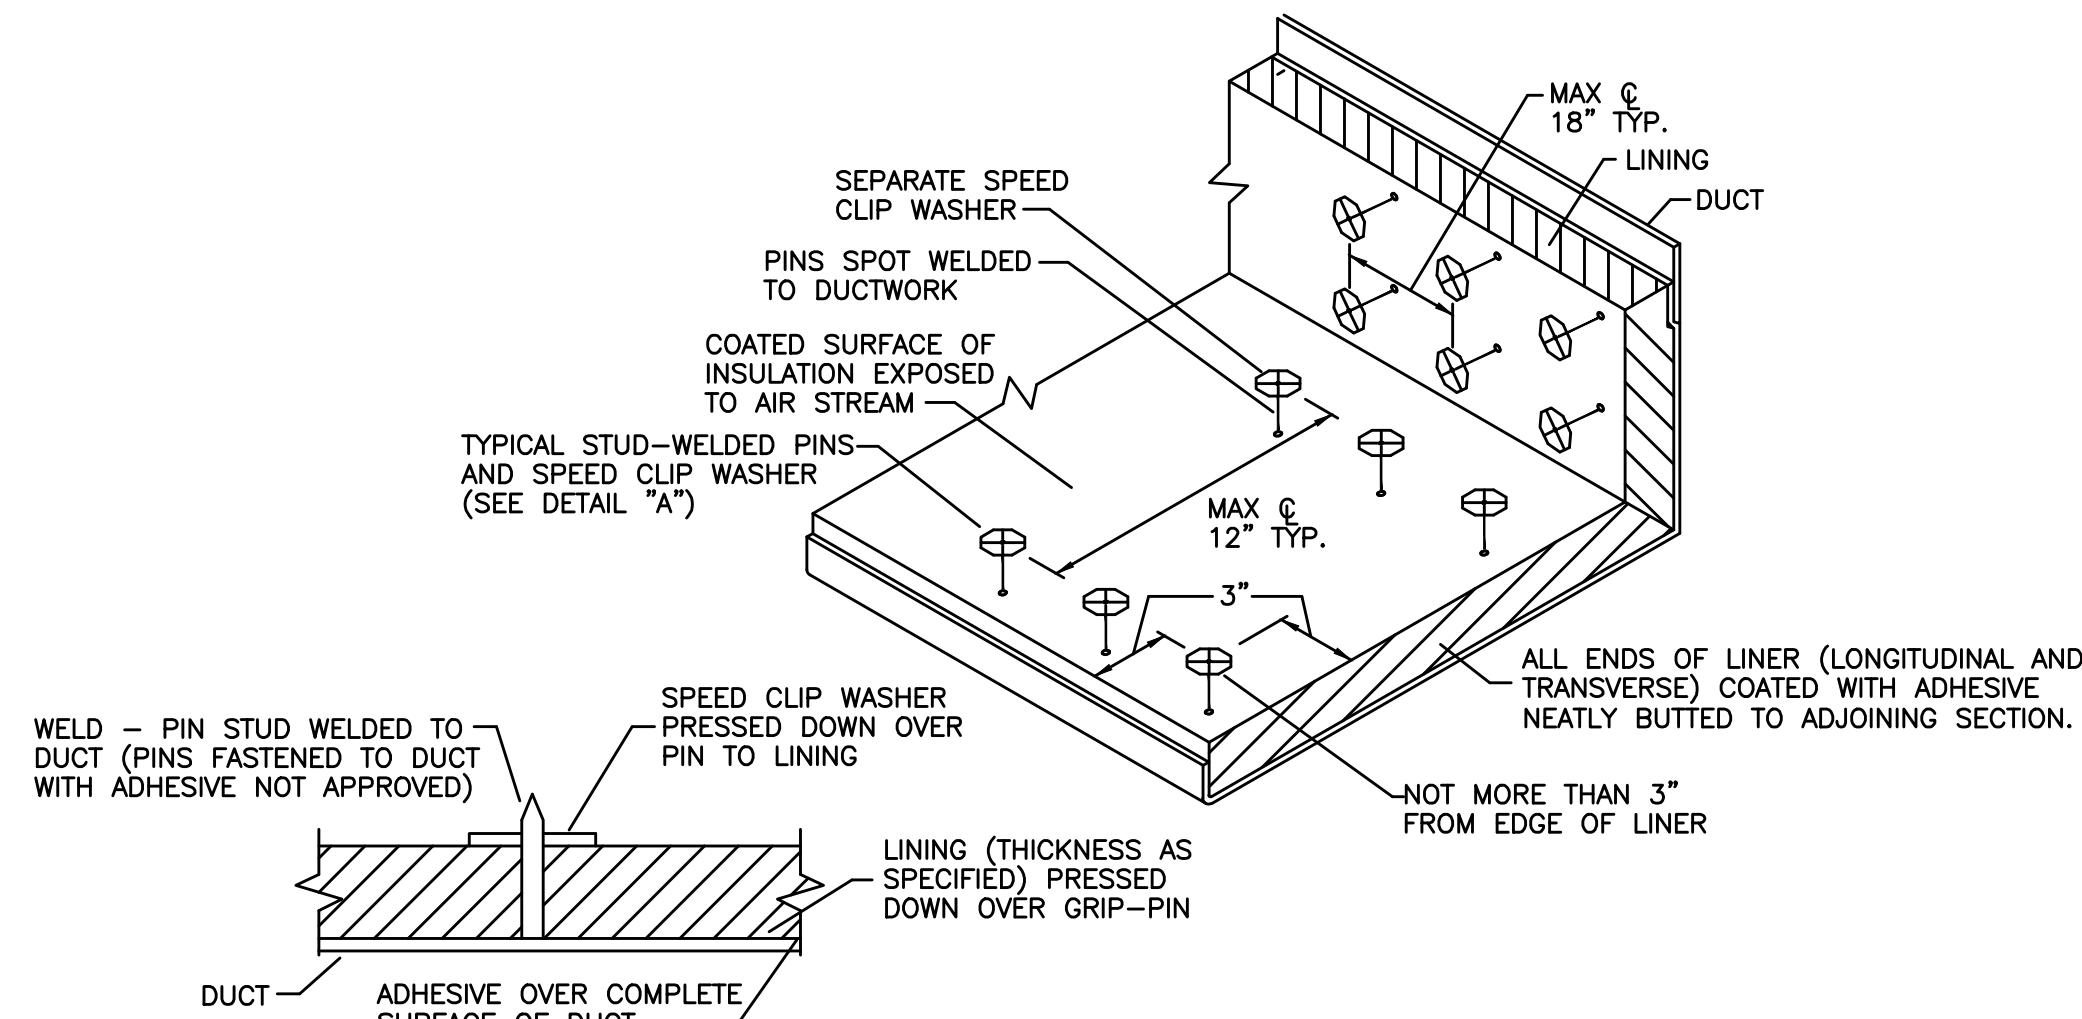

SOUND LINING INSTALLATION DETAIL
NO SCALE

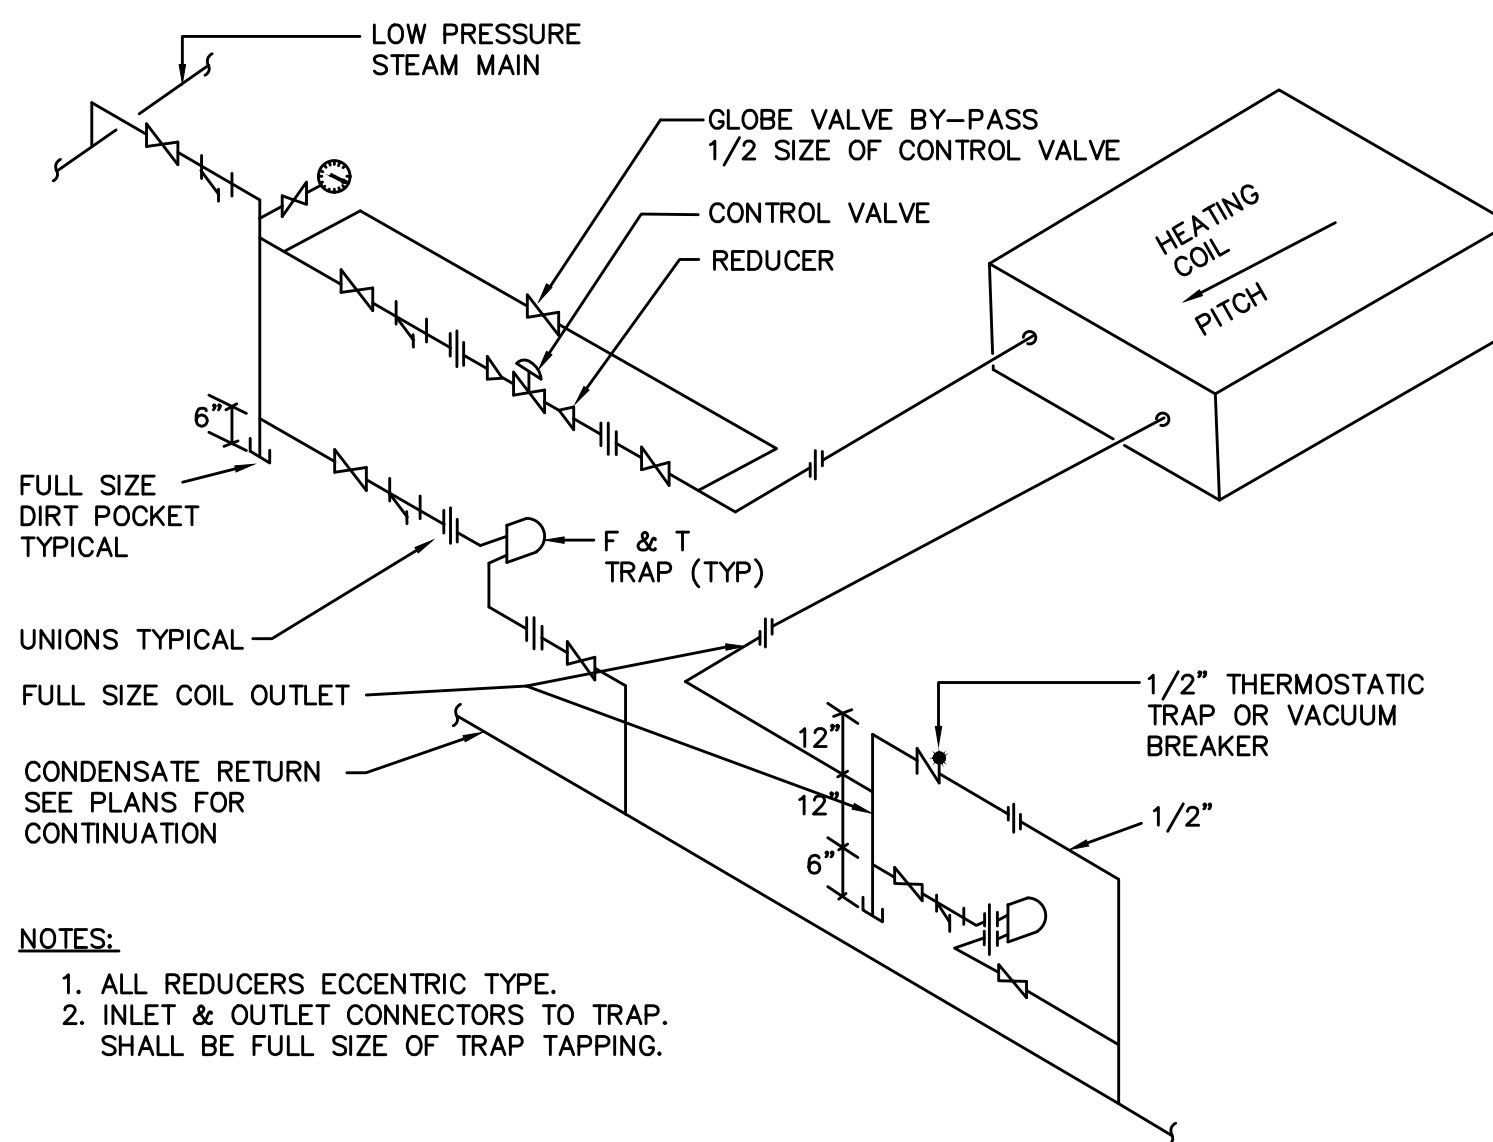


HORIZONTAL STEAM HEATING COIL PIPING
N.T.S.

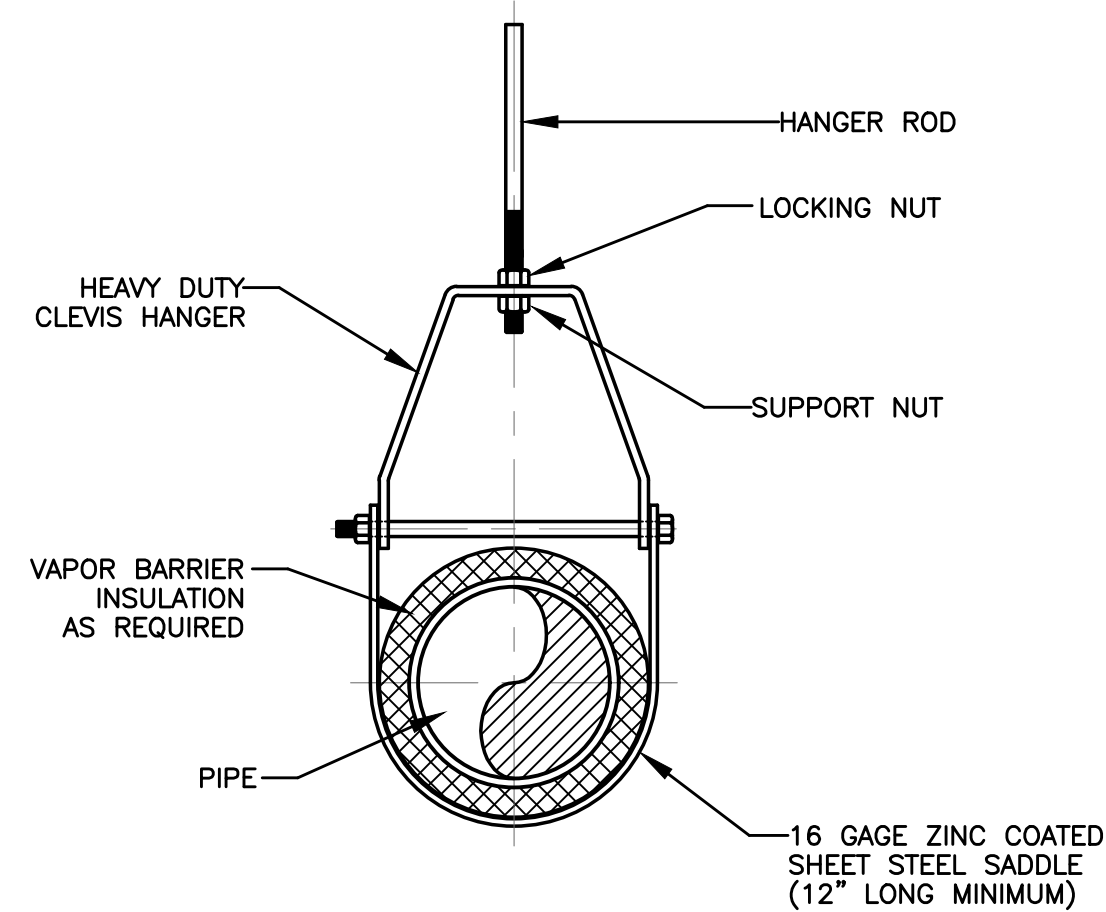


HANGER ROD SCHEDULE			
PIPE SIZE	ROD SIZE	PIPE SIZE	ROD SIZE
UP TO 2"	3/8" DIA.	4" THRU 5"	5/8" DIA.
2 1/2" THRU 3"	1/2" DIA.	6" THRU 12"	7/8" DIA.

CLEVIS HANGER
HORIZONTAL RUNS

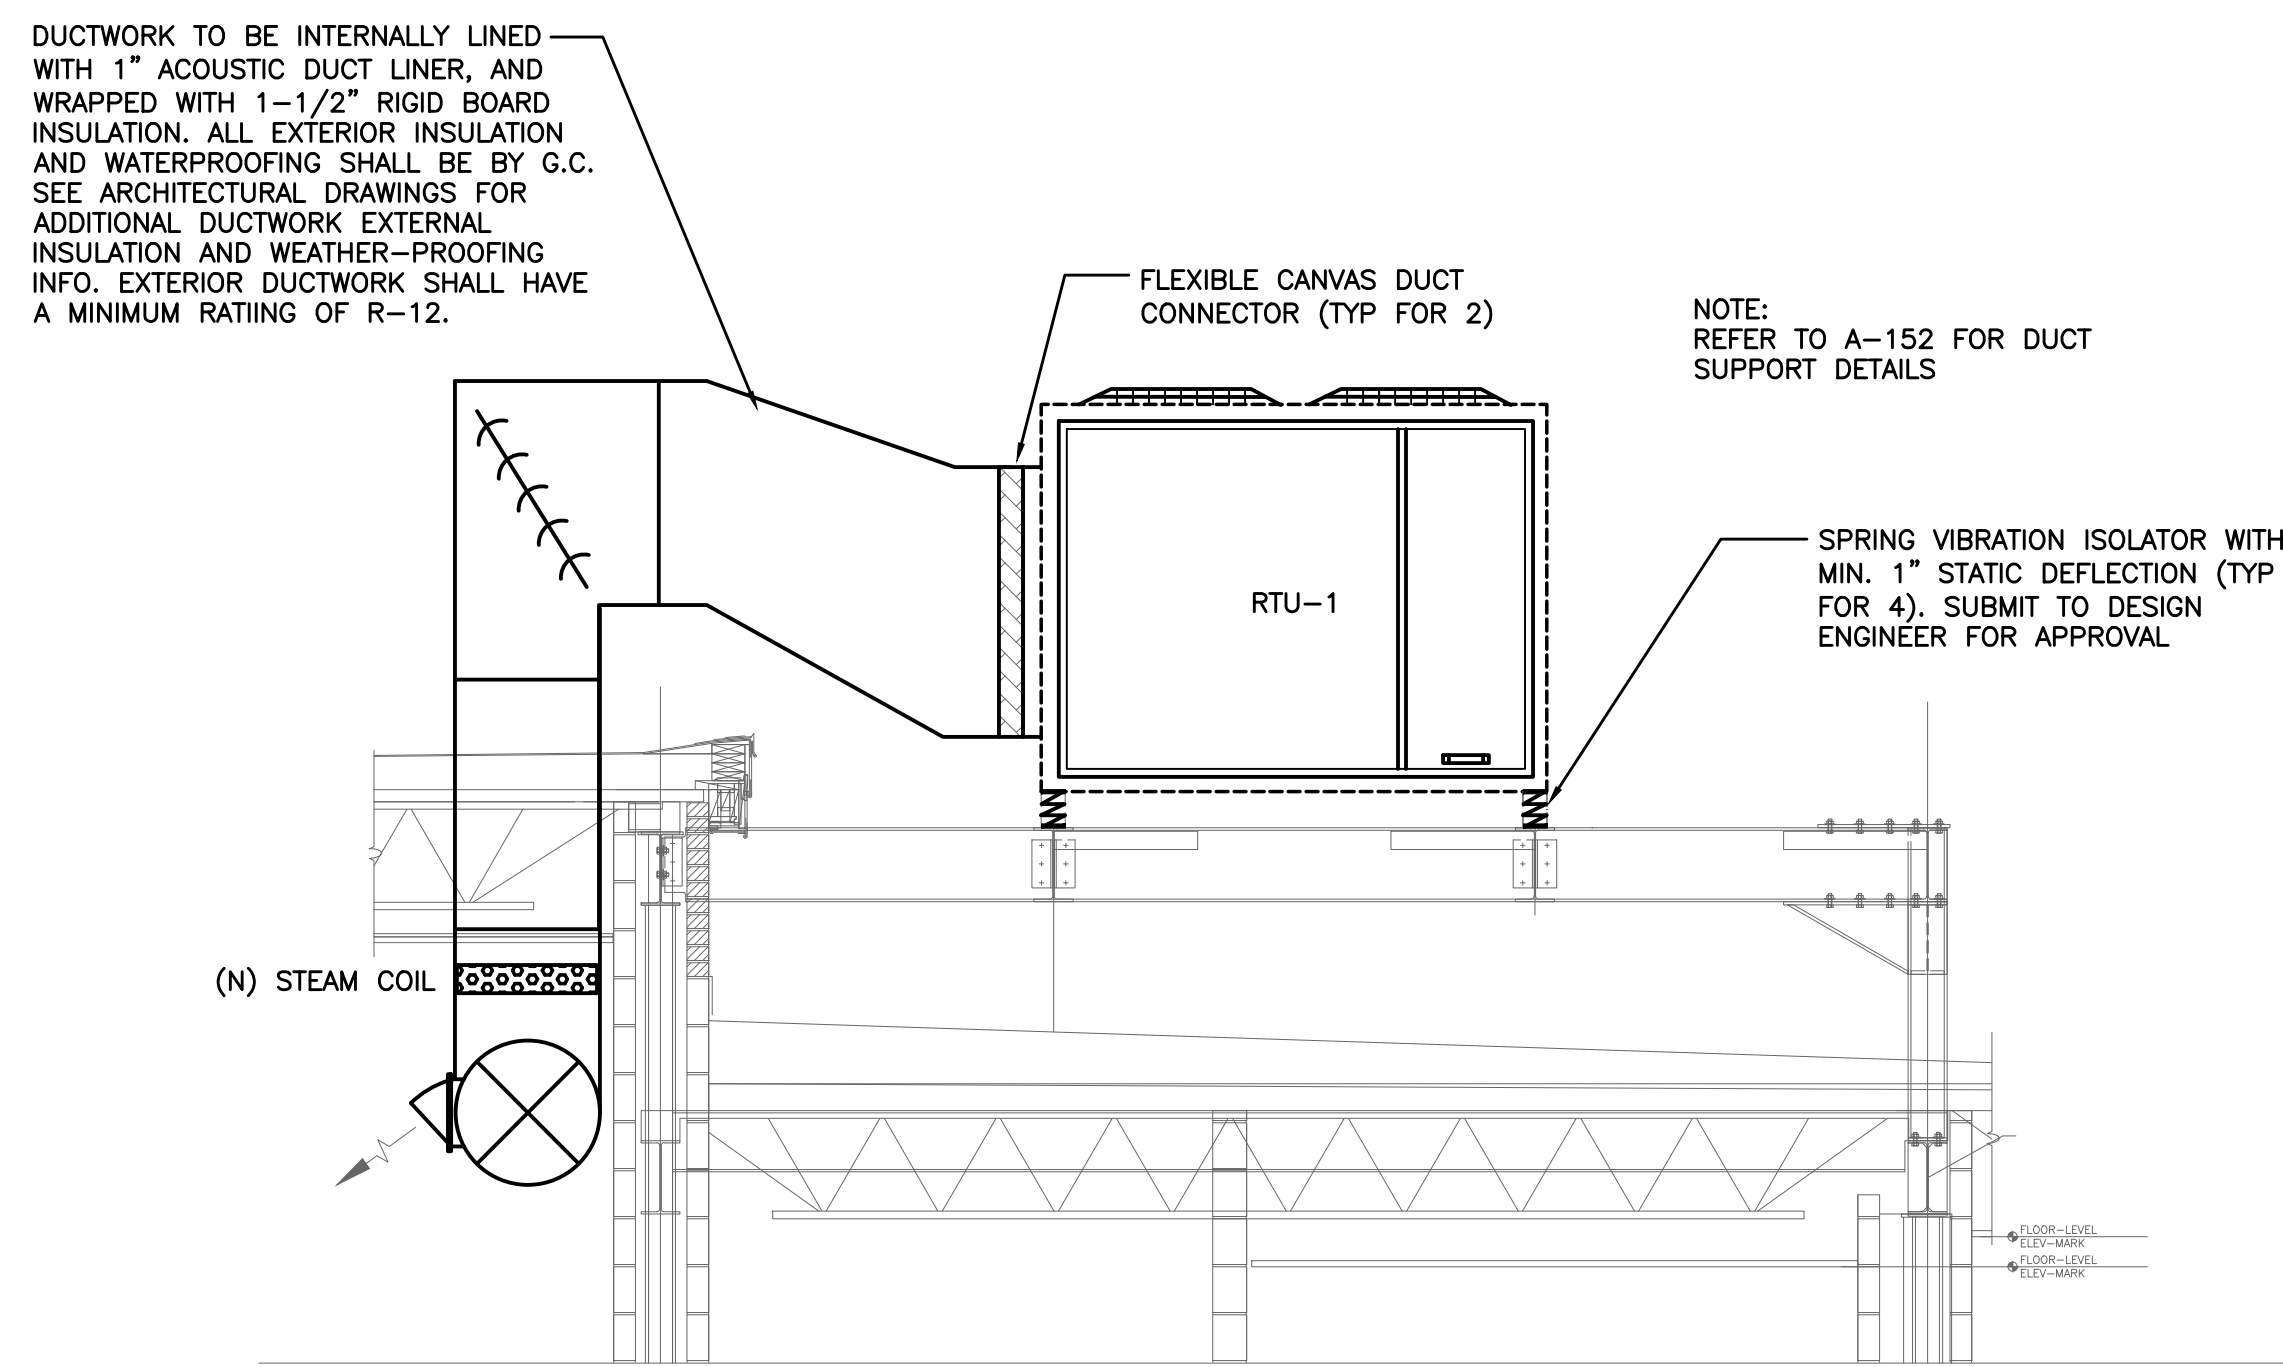

ROOFTOP UNIT INSTALLATION DETAIL
NO SCALE

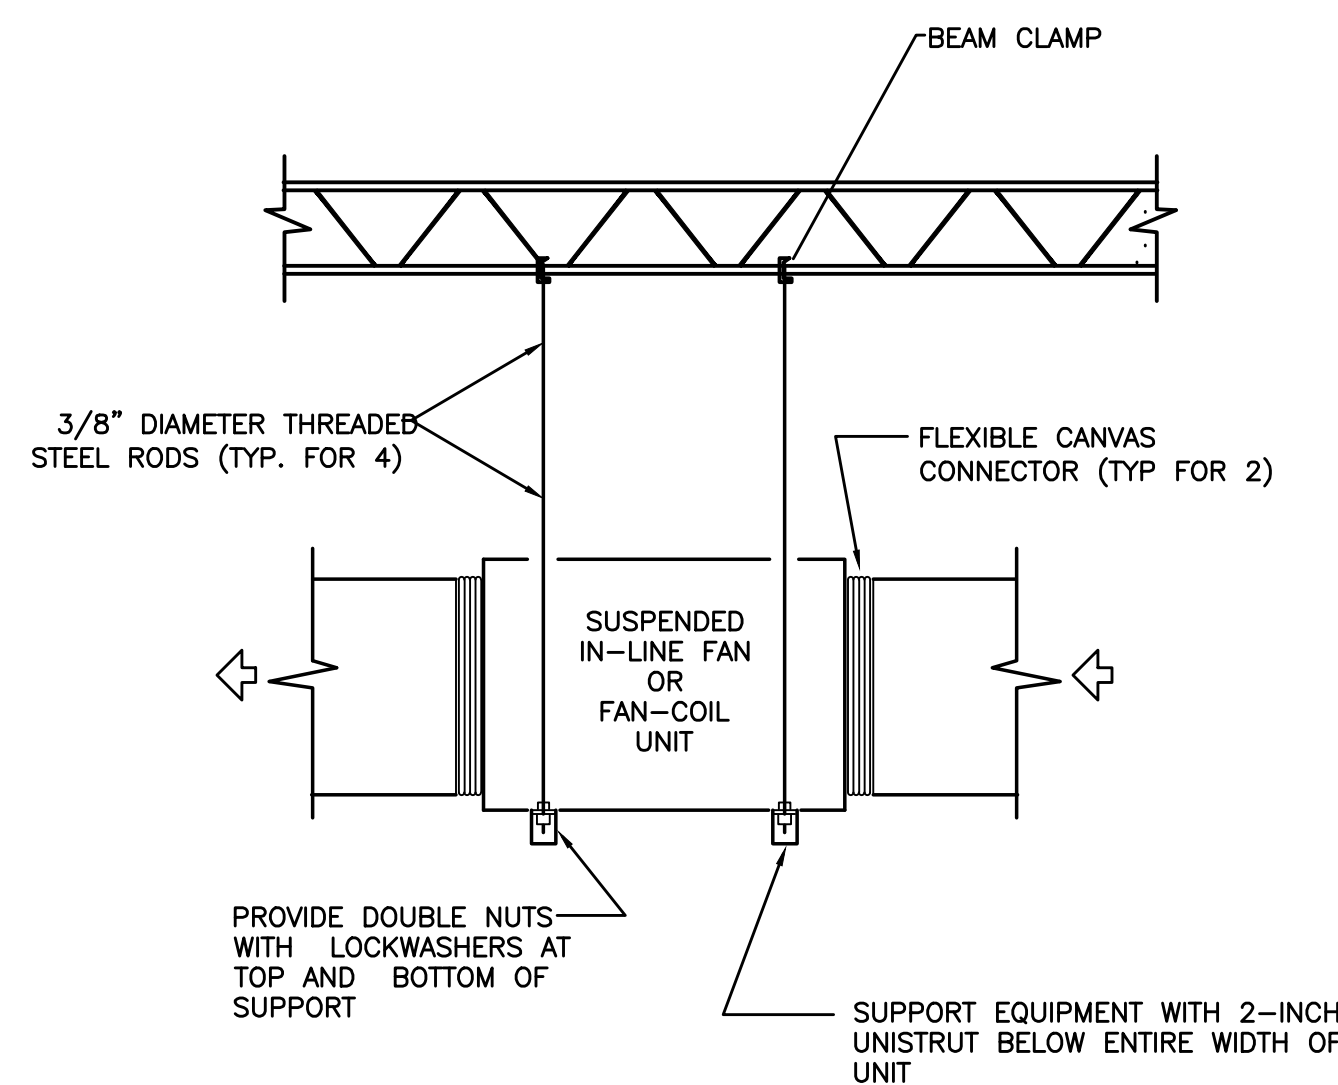

INLINE FAN SUPPORT DETAIL
TYPICAL FOR CEILING-MOUNTED FAN-COIL UNITS
AND EXHAUST FANS
NO SCALE

NEW PACKAGED ROOFTOP UNIT WITH ENERGY RECOVERY SCHEDULE																					
TAG	MFG	MODEL NO.	AIR FLOW (CFM)		MOTOR HP	ESP (IN. WC)	COOLING								OUTSIDE AIR TEMP	SUPPLY AIR TEMP (DB/WB)	VOLTAGE/PH	MCA	MOCP	WEIGHT (LBS)	NOTES
			TOTAL	OUTDOOR			TOTAL (MBH)	SENSIBLE (MBH)	ENT DB	AIR WB	LEAV. DB	AIR WB	EER								
RTU-1	TRANE	THH180G3R0D	6065	2995	3.0	1.5	182.62	148.32	79.4	66.3	59.96	57.95	12.1	95.0	62.06/58.75	208/3	73.0	100.0	3141	1,2,3,4,5,6	
NOTES: 1. UNIT SHALL BE EQUIPPED WITH ENERGY RECOVERY WHEEL. 2. PROVIDE WALL MOUNT CO2 SENSOR FOR DEMAND CONTROL VENTILATION. 3. REFER TO RTU MOUNTING DETAIL FOR ADDITIONAL INFORMATION. 4. UNIT SHALL BE FURNISHED WITH FACTORY BAGNET CARD. COORDINATE WITH ATC VENDOR PRIOR TO ORDERING. 5. MAINTAIN MANUFACTURER'S RECOMMENDED SERVICE CLEARANCE ON ALL SIDES. 6. UNIT SHALL BE FURNISHED WITH FACTORY GFI RECEPTACLE FOR SERVICE.																					

STEAM HEATING COIL SCHEDULE											
TAG	MFG	MODEL	TYPE	CFM	P.D. (IN. WC)	CAPACITY (MBH)	EAT DB	LAT DB	STEAM PRESS. (PSI)	AIR VELOCITY (FPM)	ROWS
SC-1	CAPITOL COIL	M8-3024-14A-HCA-R	HORIZONTAL	6000	0.69	233.2	50.6	86.5	2.0	1200	1
NOTES: 1. REFER TO STEAM COIL DETAIL FOR ADDITIONAL INFORMATION. 2. PROVIDE MOTORIZED MODULATING CONTROL VALVE AS MANUFACTURED BY BELIMO.											

EXHAUST FAN SCHEDULE										
TAG	SERVICE	LOCATION	MFG	MODEL	AIR FLOW (CFM)	STATIC PRESS. (IN. H2O)	RPM	HP	VOLTAGE	FLA
EF-1	CAFETERIA	CEILING	COOK	100SQN17DEC	700	0.40	1725	1/4	115-1-60	5.8
NOTES: 1. PROVIDE FACTORY BACKDRAFT DAMPER. 2. PROVIDE VARIABLE SPEED ECM MOTOR WITH SPEED CONTROL. 3. FAN SHALL BE TIED TO BAS AND SCHEDULED TO RUN ONLY DURING SERVING TIMES (IE. 11:30A-1P).										

EXTERIOR LOUVER SCHEDULE	
TAG	EL-1
PRODUCT TYPE	DRAINABLE LOUVER
MANUFACTURER	AIROLITE
MODEL	K6744
AREA (IN. X IN.)	18 X 18
DEPTH (IN.)	4
FREE AREA (%)	56
NOTES: 1. LOUVER SHALL BE FURNISHED WITH INSECT SCREEN. 2. PROVIDE KYNAR FINISH & REFER TO ARCHITECTURAL PLANS FOR COLOR.	

VENTILATION AIR REQUIREMENTS									
Project: Greenville Elementary Cafeteria Renovation				State:	New York	Relevant Code:		IMC 2020	
HVAC ZONE	AREA SERVED	OCCUPANCY CLASSIFICATION	OCCUPANT DENSITY (#/1000 SQFT)	OCCUPANT LOAD Pz (Az)	REQUIRED VENTILATION Rp / Ra	ZONE AIR DIST. EFFECTIVENESS (Ez)	O./E.A. REQUIRED (CFM) Vbz	O./E.A. DESIGN (CFM)	REMARKS
Zone 1	[129] CAFETERIA	Cafeteria	-	161 (2547.94 SF)	7.5 CFM/PERSON 0.18 CFM/SF	0.8	2083	2085	1
	[C13.3] KITCHEN GALLEY	Kitchens	20	2 (71.18 SF)	7.5 CFM/PERSON 0.12 CFM/SF	0.8	29	30	
	CALCULATED OUTSIDE/MAKEUP AIR FOR SYSTEM TOTAL						2112	2115	
REMARKS: 1. OCCUPANCY DETERMINED BY EXPECTED NUMBER OF SEATS IN THE SPACE									

AIR OUTLET SCHEDULE					
TAG	MFG	MODEL	AIRFLOW (CFM)	SIZE	NOTES
SR-1	TITUS	DL	SEE DWGS	20X12	
CD-1	TITUS	OMNI	SEE DWGS	24X24	
RAG-1	TITUS	MLR-39	SEE DWGS	5FT LONG (3) 1" SLOTS	
EG-1	TITUS	350RL	SEE DWGS	24X12	
NOTES: 1. ALL AIR OUTLETS SHALL BE WHITE UNLESS OTHERWISE NOTED ON PLANS.					

BRANCH DUCT SCHEDULE	
AIR FLOW (CFM)	ROUND DUCT SIZE (IN.)
0 -105	6
106-160	7
161-230	8
231-320	9
321-420	10
421-685	12
686-1025	14
1026-1450	16
1451-2000	18
NOTES: 1. WHETHER OR NOT INDICATED ON PLANS, CONTRACTOR SHALL FURNISH AND INSTALL MANUAL VOLUME DAMPERS IN ALL SUPPLY AND RETURN BRANCH DUCTS.	

AS PER USA CONGRESS ARCHITECTURAL WORKS COPYRIGHT PROTECTION ACT OF 1990 ALL IDEAS AND DESIGNS INCLUDING DERIVATIVES THEREOF, ALL DRAWINGS AND SPECIFICATIONS CONSTITUTE THE ORIGINAL COPYRIGHT WORK BY FULLER AND DANIELO, P.C. (F&D). THE DRAWINGS AND SPECIFICATIONS AS INSTRUMENTS OF SERVICE BY F&D ARE CREATED BY F&D FOR THIS PROJECT ONLY AND REMAIN THE PRODUCT AND PROPERTY OF F&D. ANY REPRODUCTION WITHOUT THE PRIOR CONSENT OF F&D IS PROHIBITED.

408 SHELLEWORTH ROAD ELLENFORD NEW YORK 12838
TEL: 814.898-4444 FAX: 814.898-1313
Copyright 2025 All Rights Reserved by FULLER & DANIELO P.C.

FULLER
D'ANGELO
P.C.
ARCHITECTS
PLANNERS

LFG
LANDMARK
FACILITIES
GROUP, INC.
252 East Avenue
Greenville, PA 16125
(717) 866-4024
(717) 866-4019 Fax


LICENSE EXP. DATE: 03-31-2026

S.E.D. CONTROL NUMBER:
GREENVILLE ELEMENTARY SCHOOL
66-04-06-03-0-008-021


PROJECT: EDGEMONT SCHOOL DISTRICT GREENVILLE ELEMENTARY SCHOOL CAFETERIA RENOVATION	DRAWING TITLE MECHANICAL SCHEDULES	
	01-31-2025	BID
	01-10-2022	SED SUBMISSION
DATE		ISSUED TO
SHEET SIZE 30"x42"	DRAWING NO. GVES M300	
SCALE AS NOTED		
DRAWN BY LFG	FILE NO. 24529.01	

PLOT DATE: January 17, 2025 — 7:13pm

FILE: N:\Edgemont School District\Greenville Elementary\Cafeteria Reno\ACAD\Electrical\GV CAFE_E001_E100_E200.dwg

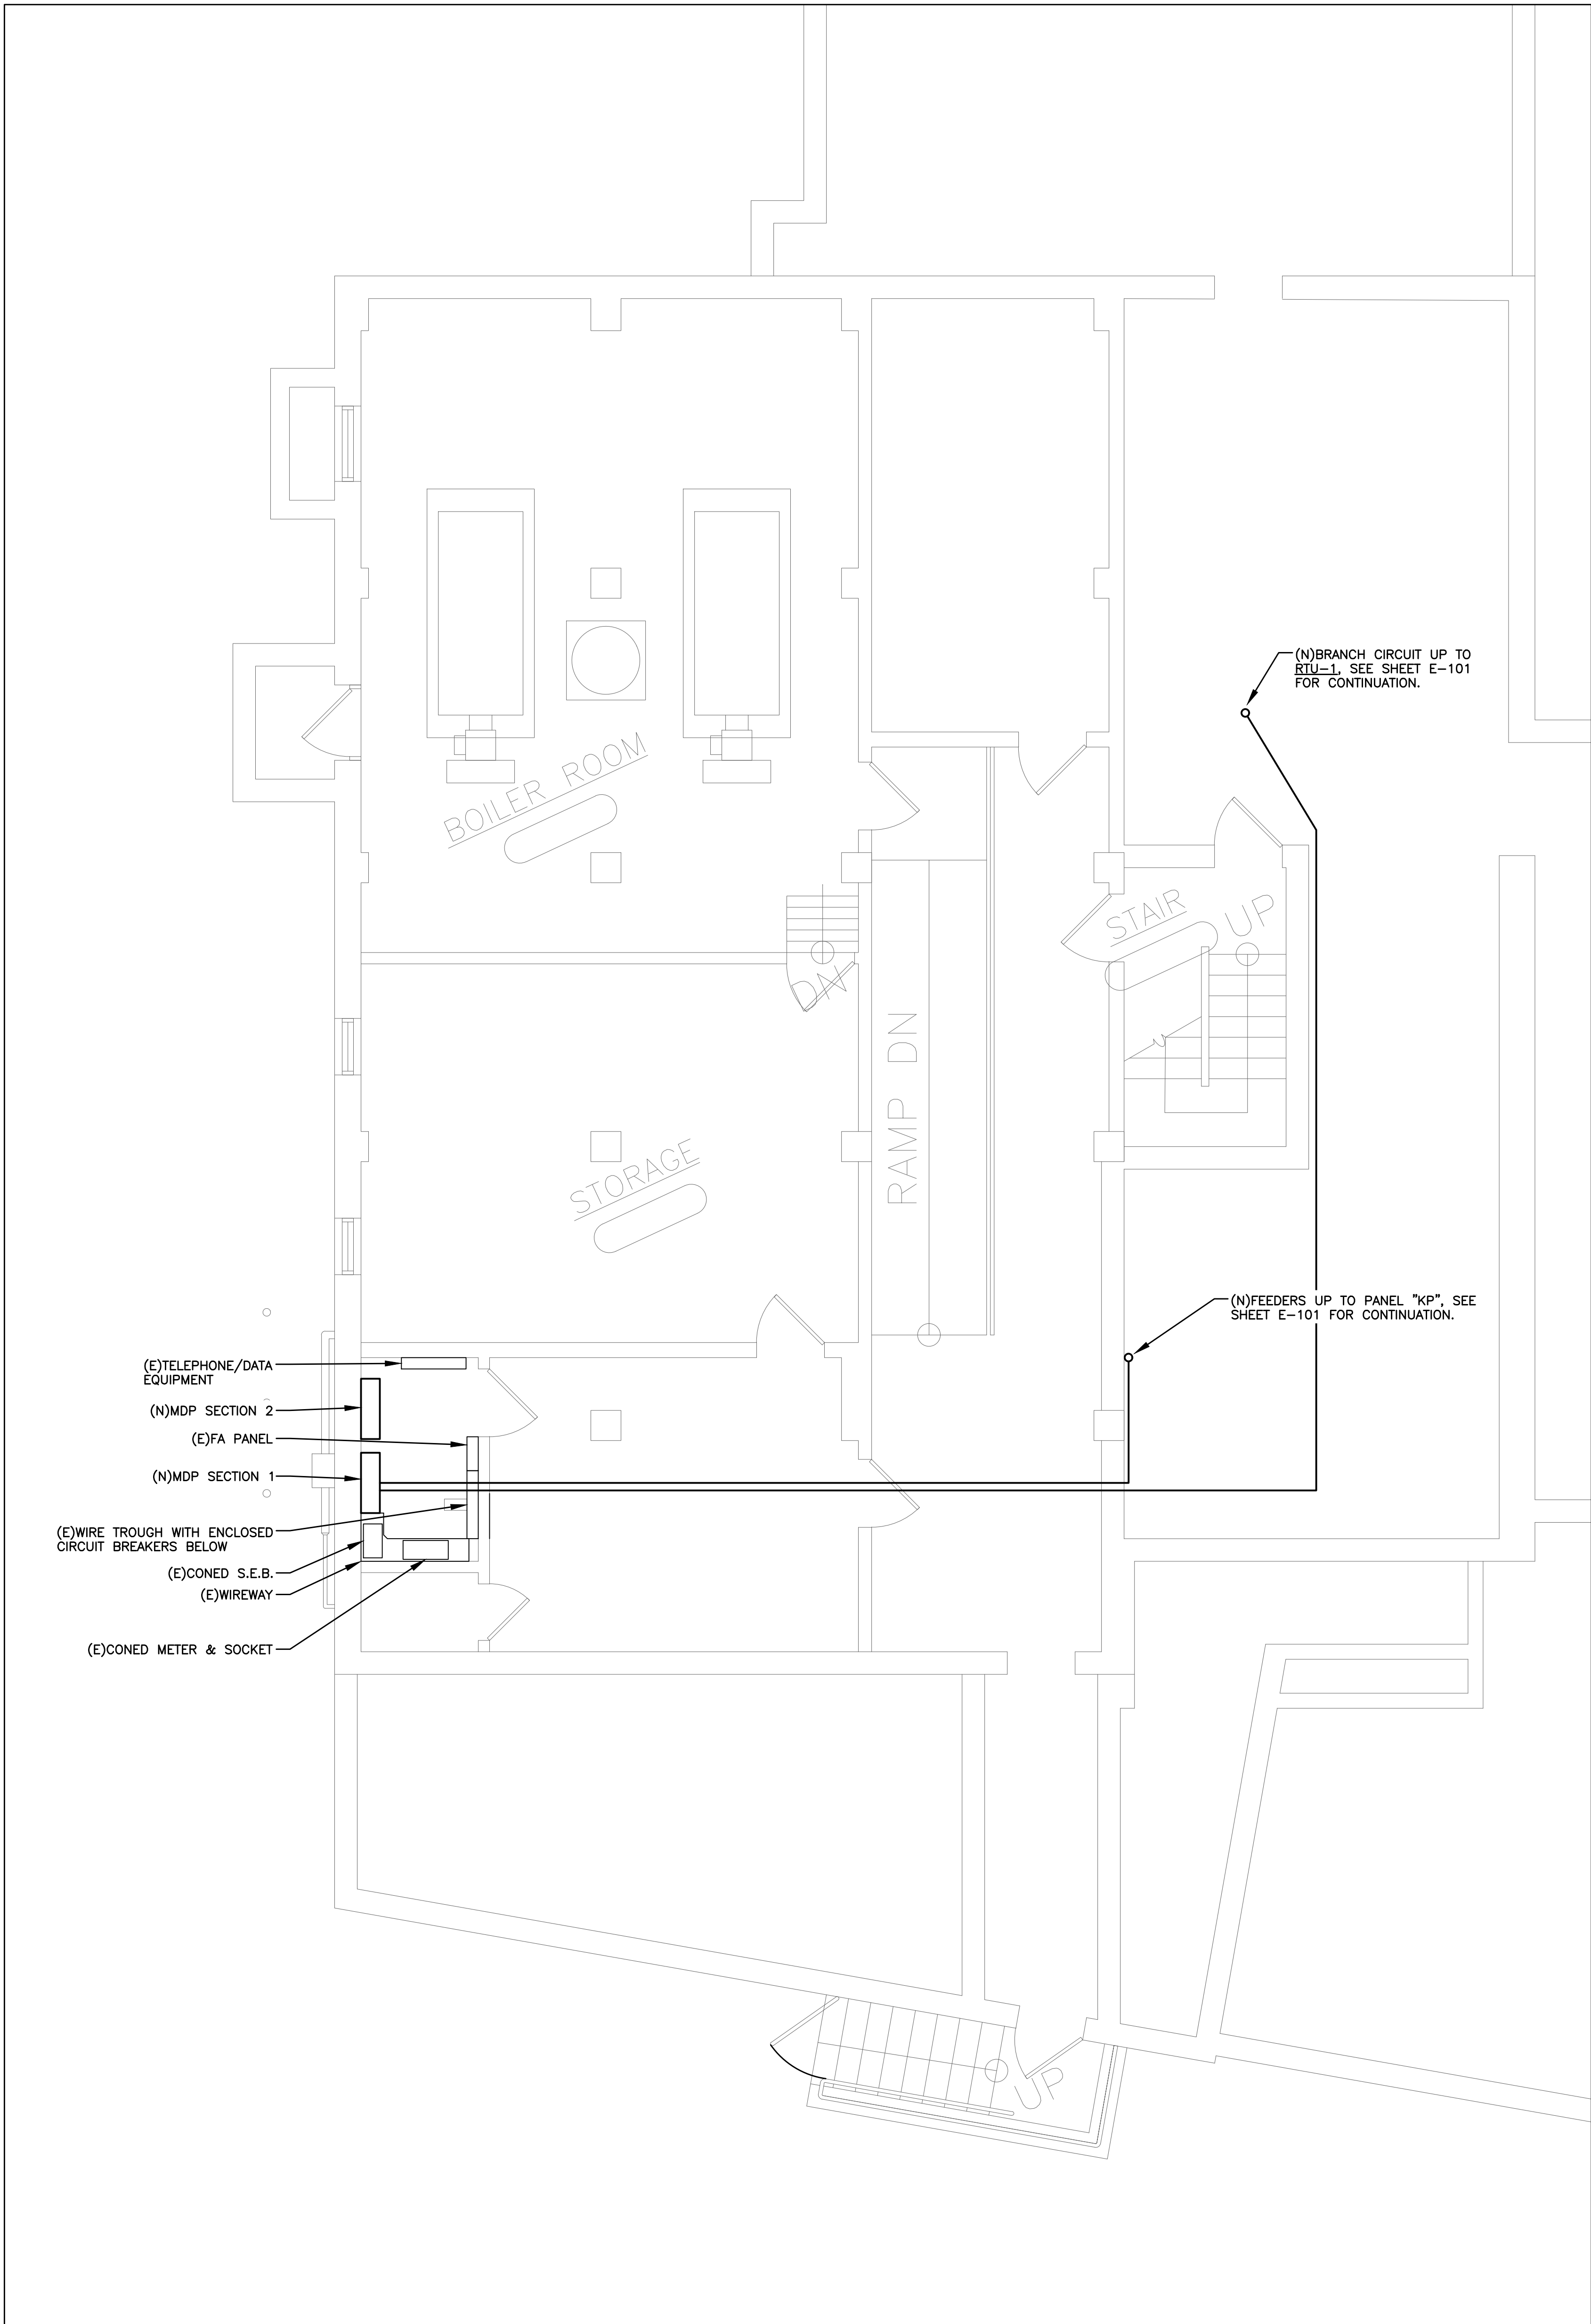

1 BASEMENT ELECTRICAL PLAN
SCALE: 1/4" = 1'-0"

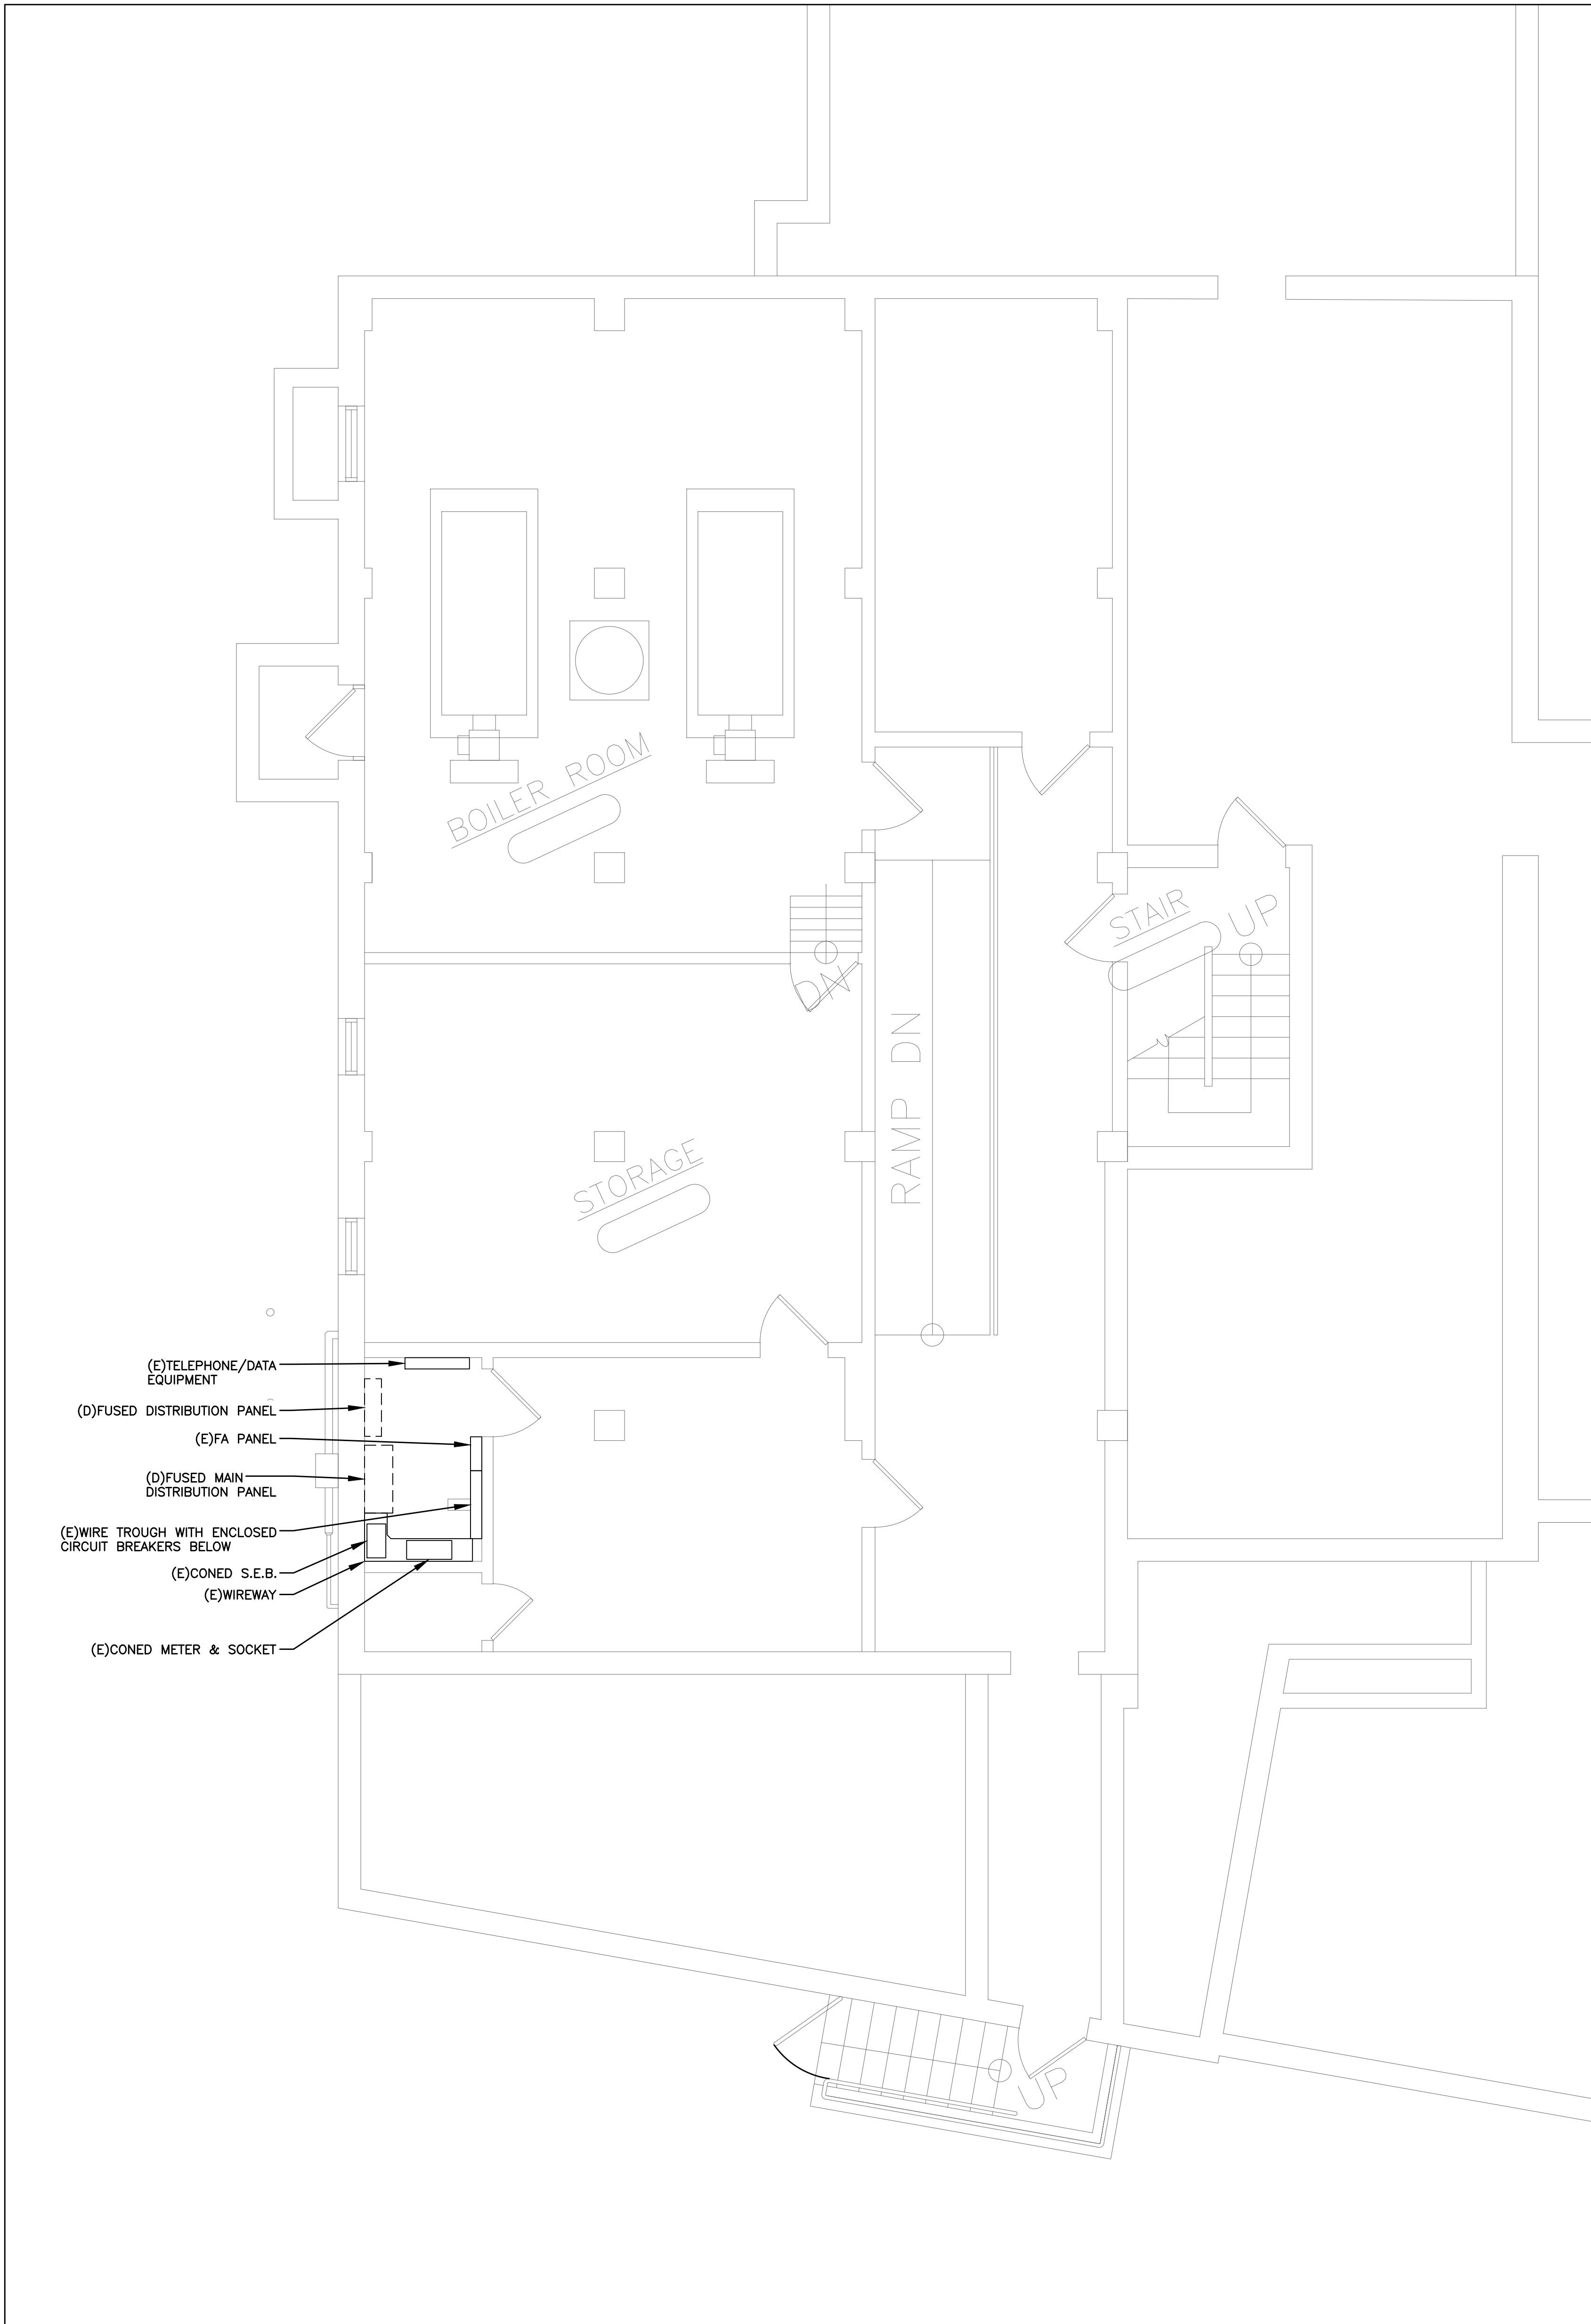

2 BASEMENT ELECTRICAL DEMO PLAN
SCALE: 1/4" = 1'-0"

AS PER USA CONGRESS ARCHITECTURAL WORKS COPYRIGHT PROTECTION ACT OF 1990 ALL IDEAS AND DESIGNS INCLUDING DERIVATIVES THEREOF, ALL DRAWINGS AND SPECIFICATIONS CONSTITUTE THE ORIGINAL COPYRIGHT WORK BY FULLER AND D'ANGELO, P.C. (F&D). THE DRAWINGS AND SPECIFICATIONS AS INSTRUMENTS OF SERVICE BY F&D ARE CREATED BY F&D FOR THIS PROJECT ONLY AND REMAIN THE PROPERTY OF F&D. ANY REPRODUCTION WITHOUT THE PRIOR CONSENT OF F&D IS PROHIBITED.

FULLER
D'ANGELO
P.C.

ARCHITECTS
PLANNERS

48 CHOLLWOOD ROAD ELLENBURG NEW YORK 12829
TEL: 814-898-4444 FAX: 814-898-1717
Copyright 2025 All Rights Reserved by FULLER & D'ANGELO P.C.


LFG
LANDMARK
FACILITIES
GROUP, INC.

252 East Avenue
Greenville, SC 29605
(203) 866-4029 FAX
(203) 866-8018 Fax


LICENSE EXP. DATE: 03-31-2026
S.E.D. CONTROL NUMBER:
GREENVILLE ELEMENTARY SCHOOL
66-04-06-03-0-008-021

PROJECT:
EDGEMONT SCHOOL DISTRICT
GREENVILLE ELEMENTARY SCHOOL
CAFETERIA RENOVATION
DRAWING TITLE:
BASEMENT ELECTRICAL PLAN

01-31-2025	BID
01-10-2022	SED SUBMISSION
DATE	ISSUED TO
SHEET SIZE: 30"x42"	DRAWING NO. GVES E100
SCALE: AS NOTED	FILE NO. 24529.01
DRAWN BY: LFG	

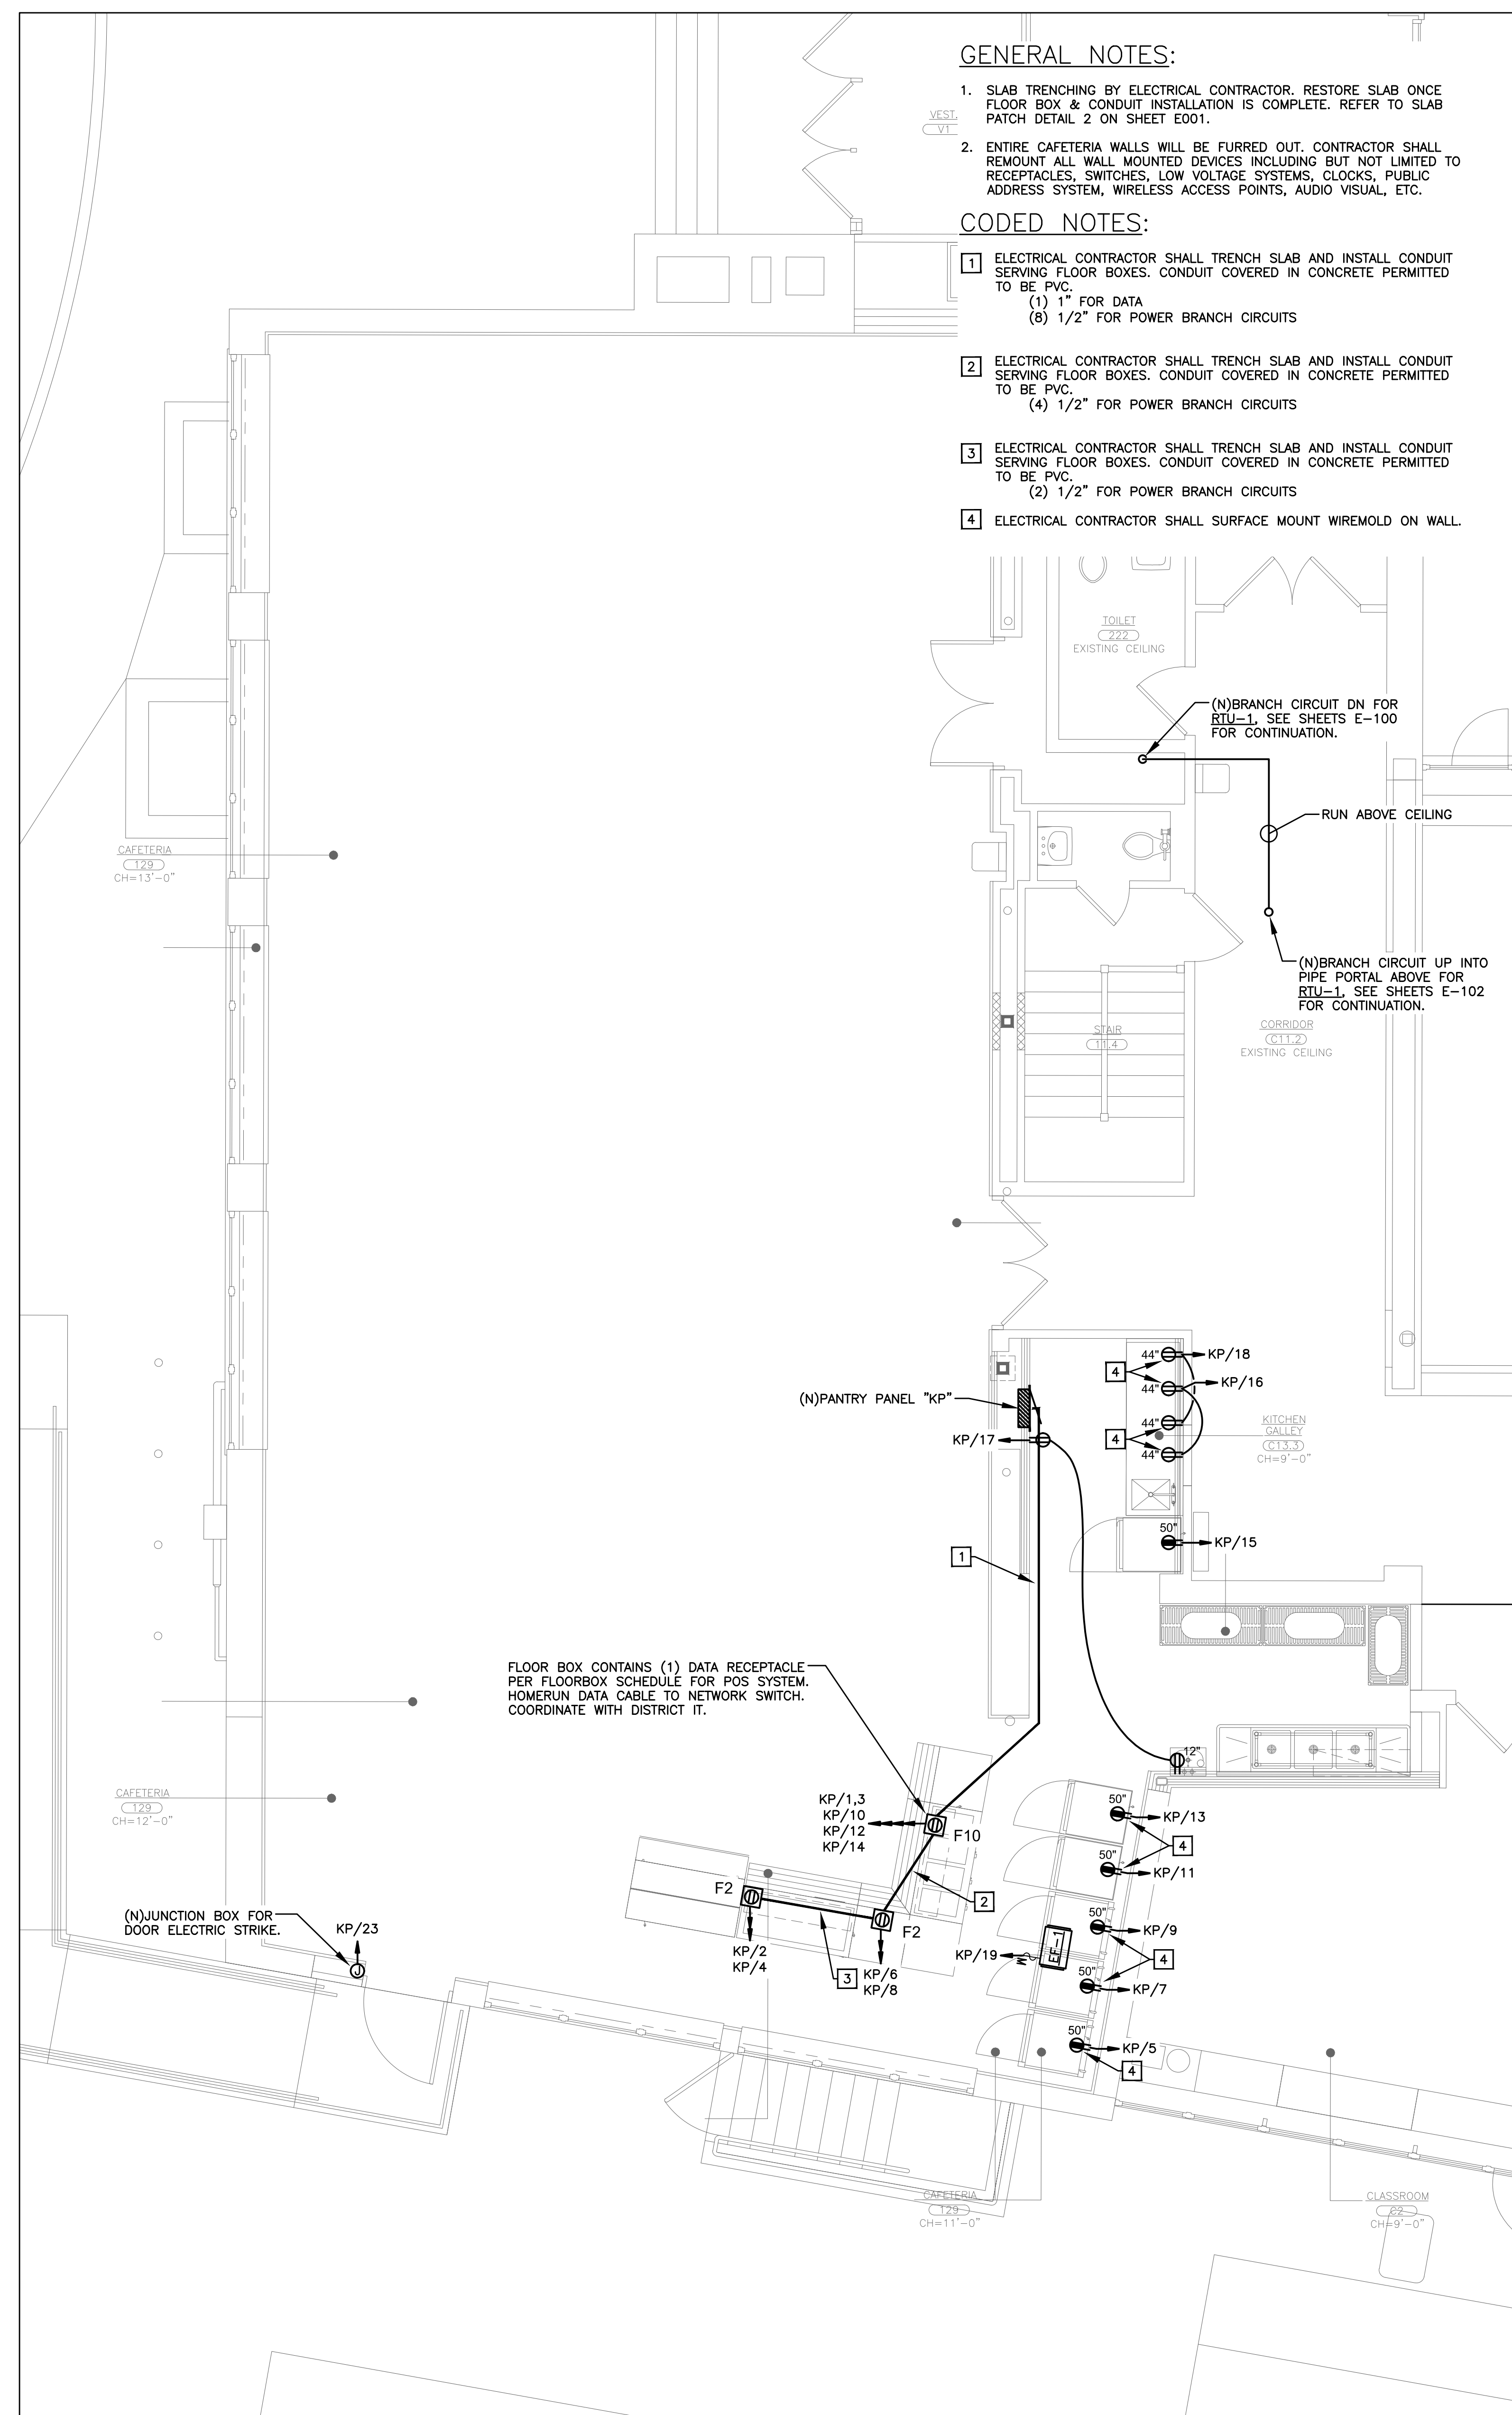

1 FIRST FLOOR ELECTRICAL PLAN
SCALE: 1/4" = 1'-0"

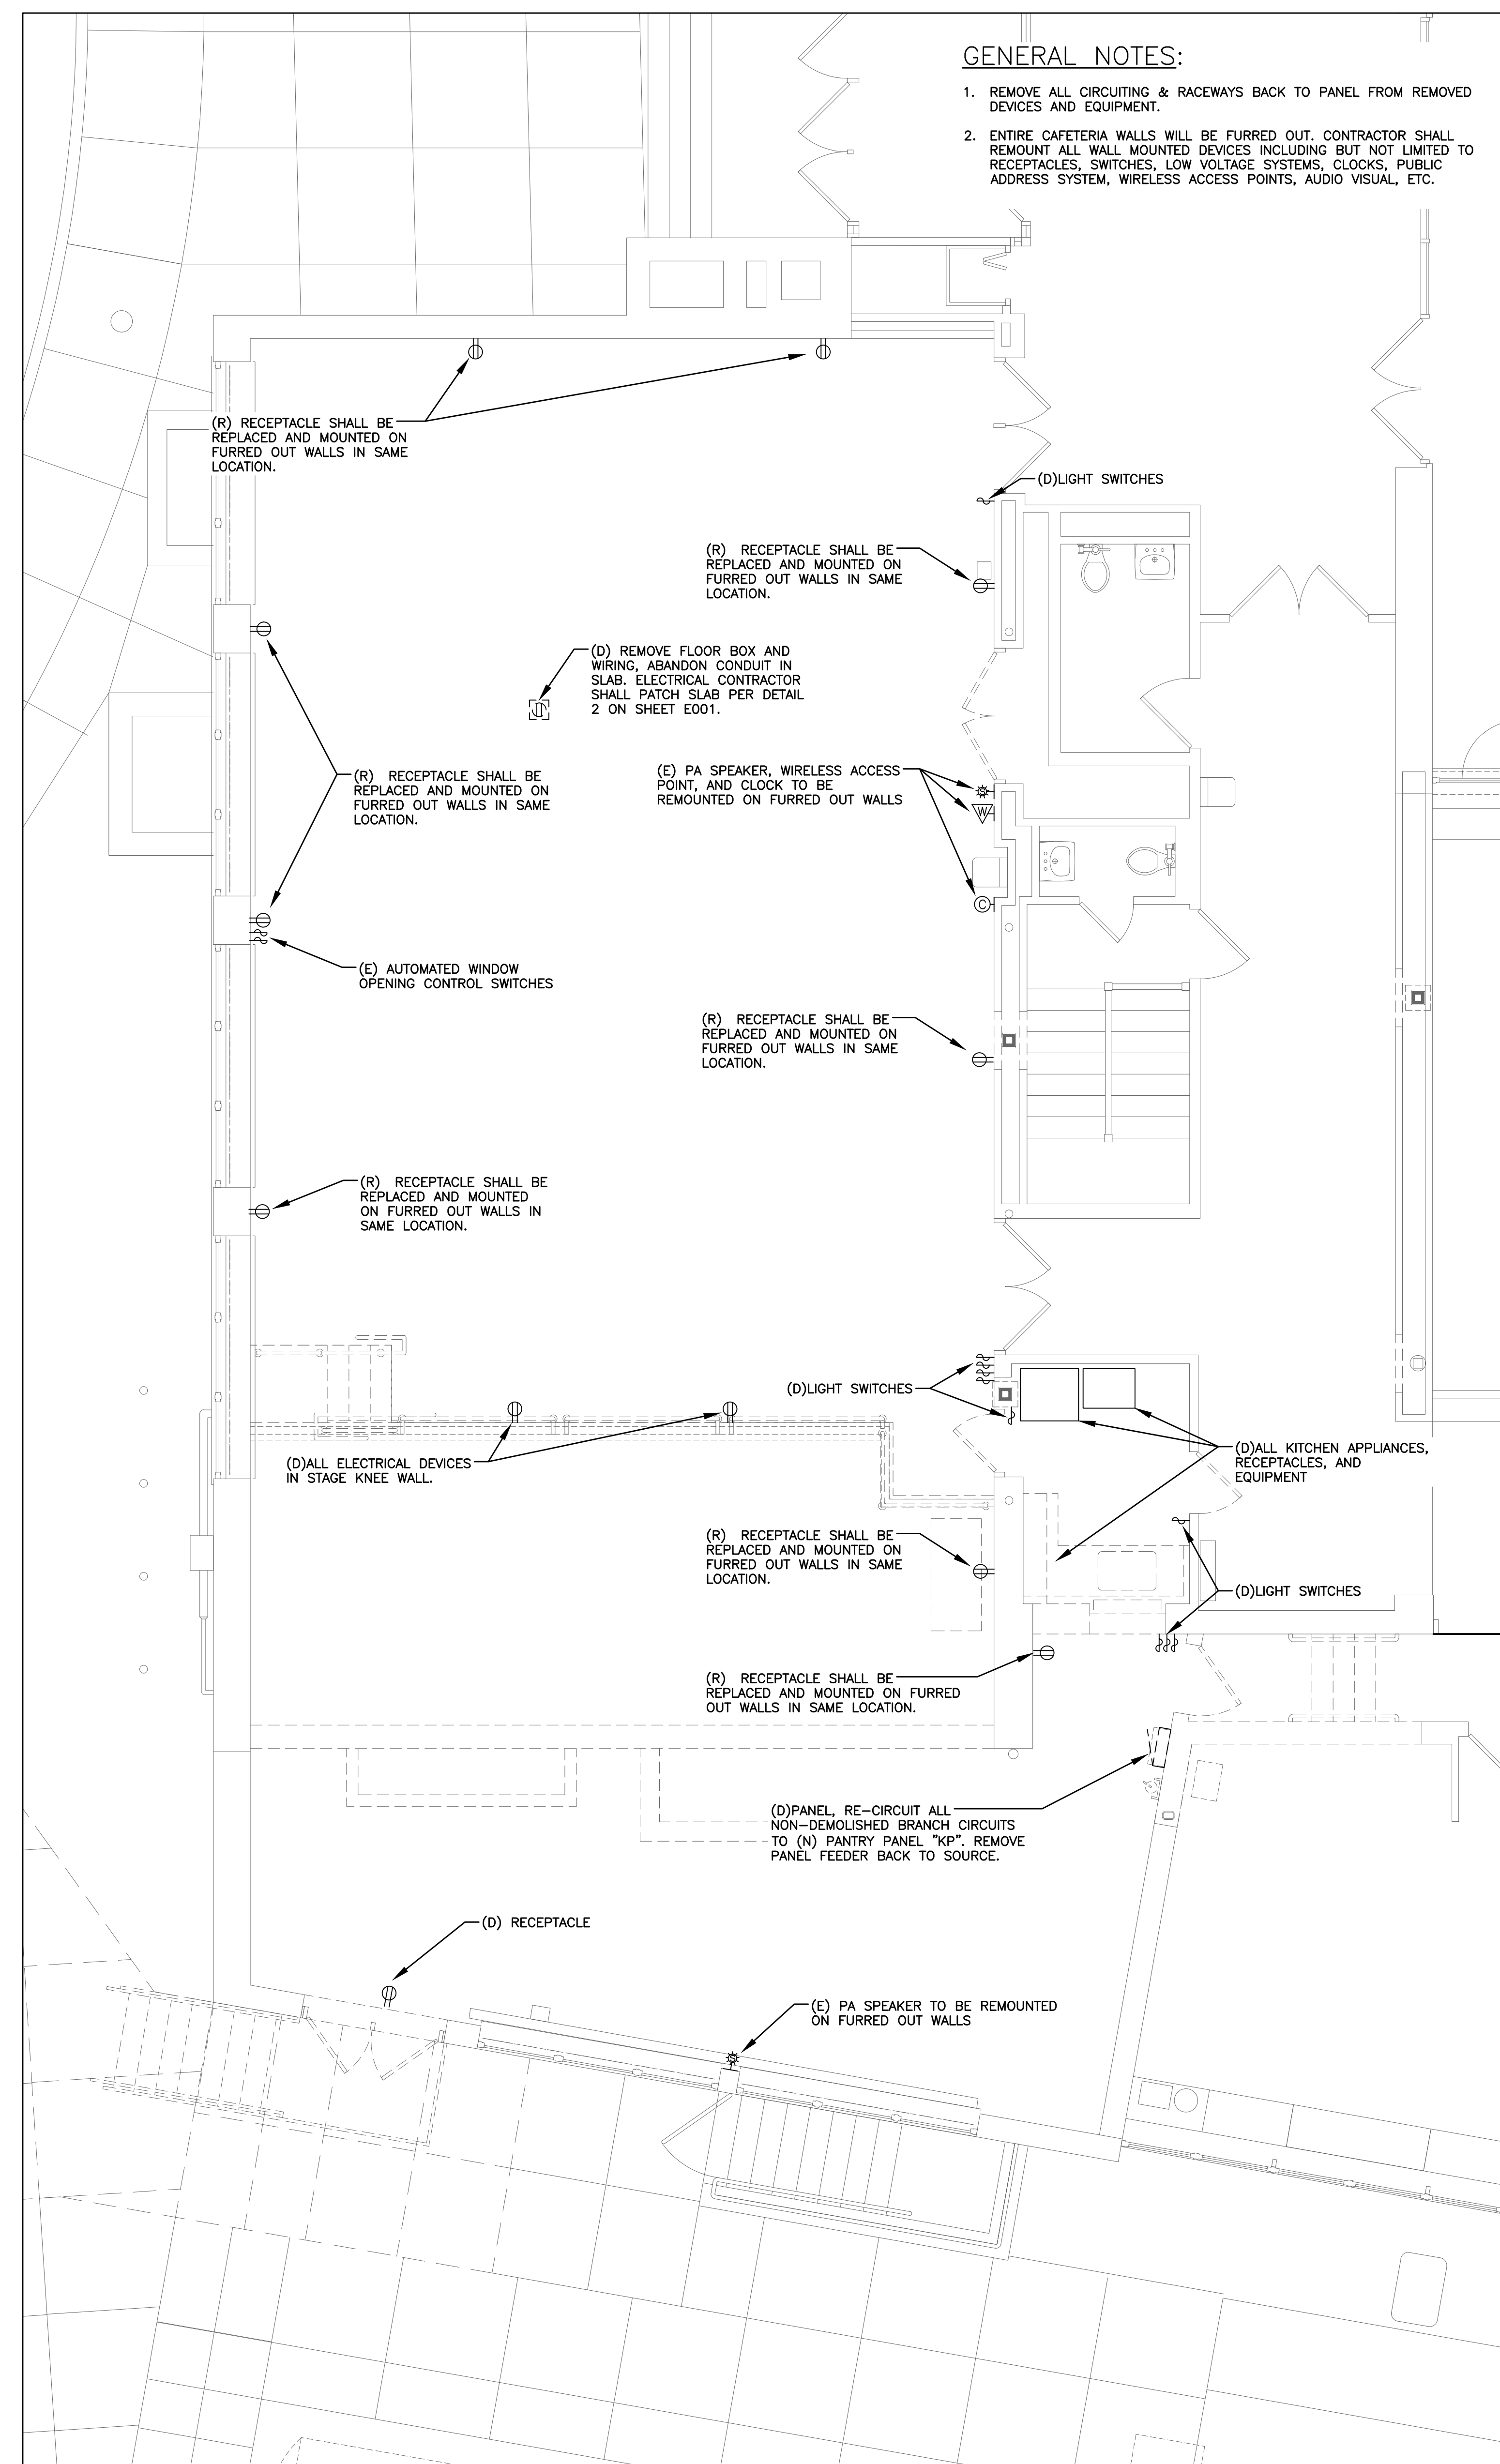

2 FIRST FLOOR ELECTRICAL REMOVALS PLAN
SCALE: 1/4" = 1'-0"

PLOT DATE: January 17, 2025 - 7:16pm

FILE: N:\Edgemont School District\Greenville Elementary\Cafeteria Reno\ACAD\Electrical\GV CAFE_E101.dwg

AS PER USA CONGRESS ARCHITECTURAL WORKS COPYRIGHT PROTECTION ACT OF 1990 ALL IDEAS AND DESIGNS INCLUDING DERIVATIVES THEREOF, ALL DRAWINGS AND SPECIFICATIONS CONSTITUTE THE ORIGINAL COPYRIGHT WORK BY FULLER AND D'ANGELO, P.C. (F&D). THE DRAWINGS AND SPECIFICATIONS AS INSTRUMENTS OF SERVICE BY F&D ARE CREATED BY F&D FOR THIS PROJECT ONLY AND REMAIN THE PRODUCT AND PROPERTY OF F&D. ANY REPRODUCTION WITHOUT THE PRIOR CONSENT OF F&D IS PROHIBITED.

FULLER D'ANGELO P.C.	ARCHITECTS PLANNERS ENGINEERS	48 KIDWOOD ROAD ELMSFORD NEW YORK 10523 TEL 914/835-1100 FAX 914/835-1717 WWW.FULLERDANGELO.COM
--	---	--

LFG
LANDMARK
FACILITIES
GROUP, INC.

52 East Avenue
Storwalk, CT 06855
(203) 866-4626 Tel

LICENSE EXP. DATE: 03-31-2028

S.E.D. CONTROL NUMBER:
GREENVILLE ELEMENTARY SCH
66-04-06-03-0-008-021


PROJECT TITLE	DRAWING TITLE
EDGEMONT SCHOOL DISTRICT GREENVILLE ELEMENTARY SCHOOL CAFETERIA RENOVATION	FIRST FLOOR ELECTRICAL PLAN

01-31-2025	BID
01-10-2022	SED SUBMISSION
DATE	ISSUED TO
SHEET SIZE 30"x42"	DRAWING NO. GVS E101
SCALE AS NOTED	
DRAWN BY LFG	FILE NO. 24529.0

01-31-2025	BID
01-10-2022	SED SUBMISSIO
DATE	ISSUED TO

PLOT DATE: January 17, 2025 -- 7:17pm

FILE: N:\Edgemont School District\Greenville Elementary\Cafeteria Reno\ACAD\Electrical\GV CAFE_E102.dwg

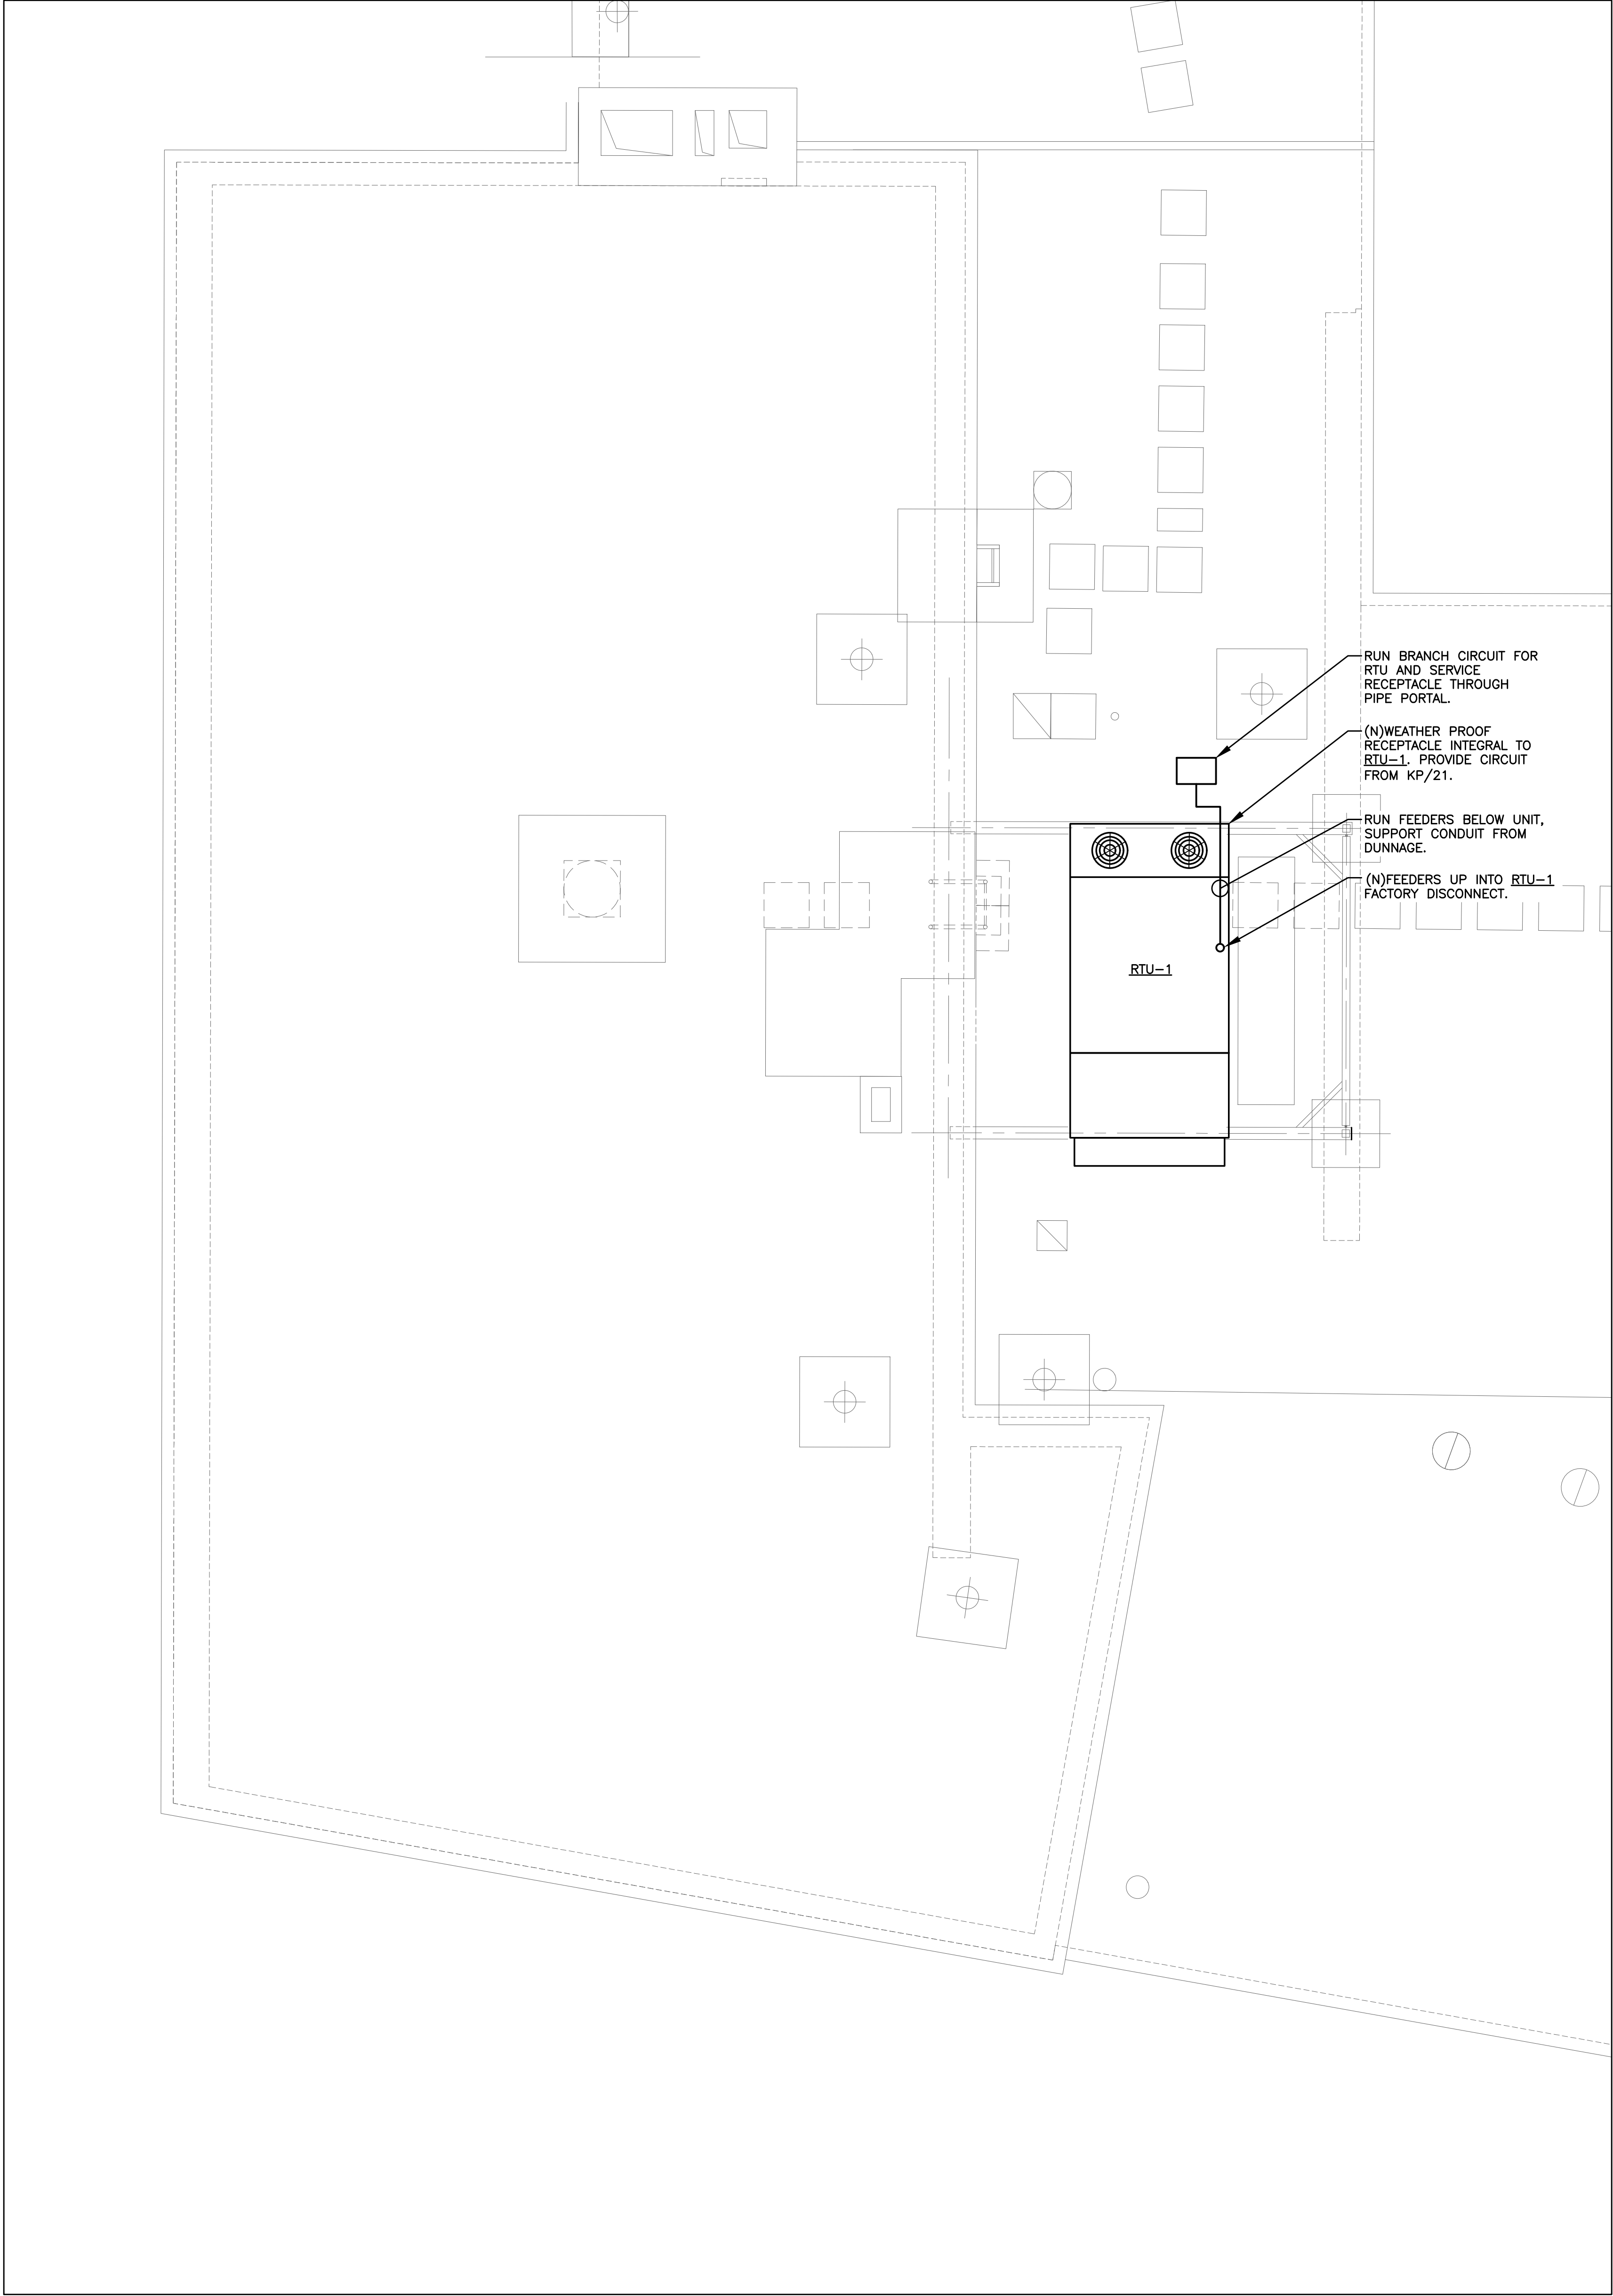


1 ROOF ELECTRICAL PLAN
SCALE: 1/4" = 1'-0"

AS PER USA CONGRESS ARCHITECTURAL WORKS COPYRIGHT PROTECTION ACT OF 1990 ALL IDEAS AND DESIGNS INCLUDING DERIVATIVES THEREOF, ALL DRAWINGS AND SPECIFICATIONS CONSTITUTE THE ORIGINAL COPYRIGHT WORK BY FULLER AND D'ANGELO, P.C. (F&D). THE DRAWINGS AND SPECIFICATIONS AS INSTRUMENTS OF SERVICE BY F&D ARE CREATED BY F&D FOR THIS PROJECT ONLY AND REMAIN THE PROPERTY AND PROPERTY OF F&D. ANY REPRODUCTION WITHOUT THE PRIOR CONSENT OF F&D IS PROHIBITED.	
428 CHOLLWOOD ROAD ELAMBERTON NEW YORK 10829 TEL: 914-898-4444 FAX: 914-898-1919 Copyright 2022 All Rights Reserved by FULLER & D'ANGELO P.C.	
FULLER D'ANGELO P.C.	ARCHITECTS PLANNERS
LFG LANDMARK FACILITIES GROUP, INC. 252 East Avenue New Rochelle, NY 10801 (203) 866-4000 FAX (203) 866-8009 Fax	
LICENSE EXP. DATE: 03-31-2026	
S.E.D. CONTROL NUMBER: GREENVILLE ELEMENTARY SCHOOL 66-04-06-03-0-008-021	
PROJECT: EDGEMONT SCHOOL DISTRICT GREENVILLE ELEMENTARY SCHOOL CAFETERIA RENOVATION	DRAWING TITLE: ROOF ELECTRICAL PLAN
01-31-2025	BID
01-10-2022	SED SUBMISSION
DATE	ISSUED TO
SHEET SIZE: 30"x42"	DRAWING NO. GVES E102
SCALE: AS NOTED	FILE NO. 24529.01
DRAWN BY: LFG	

PLOT DATE: January 17, 2025 -- 7:18pm

FILE: N:\Edgemont School District\Greenville Elementary\Cafeteria Reno\ACAD\Electrical\GV CAFE_E103.dwg

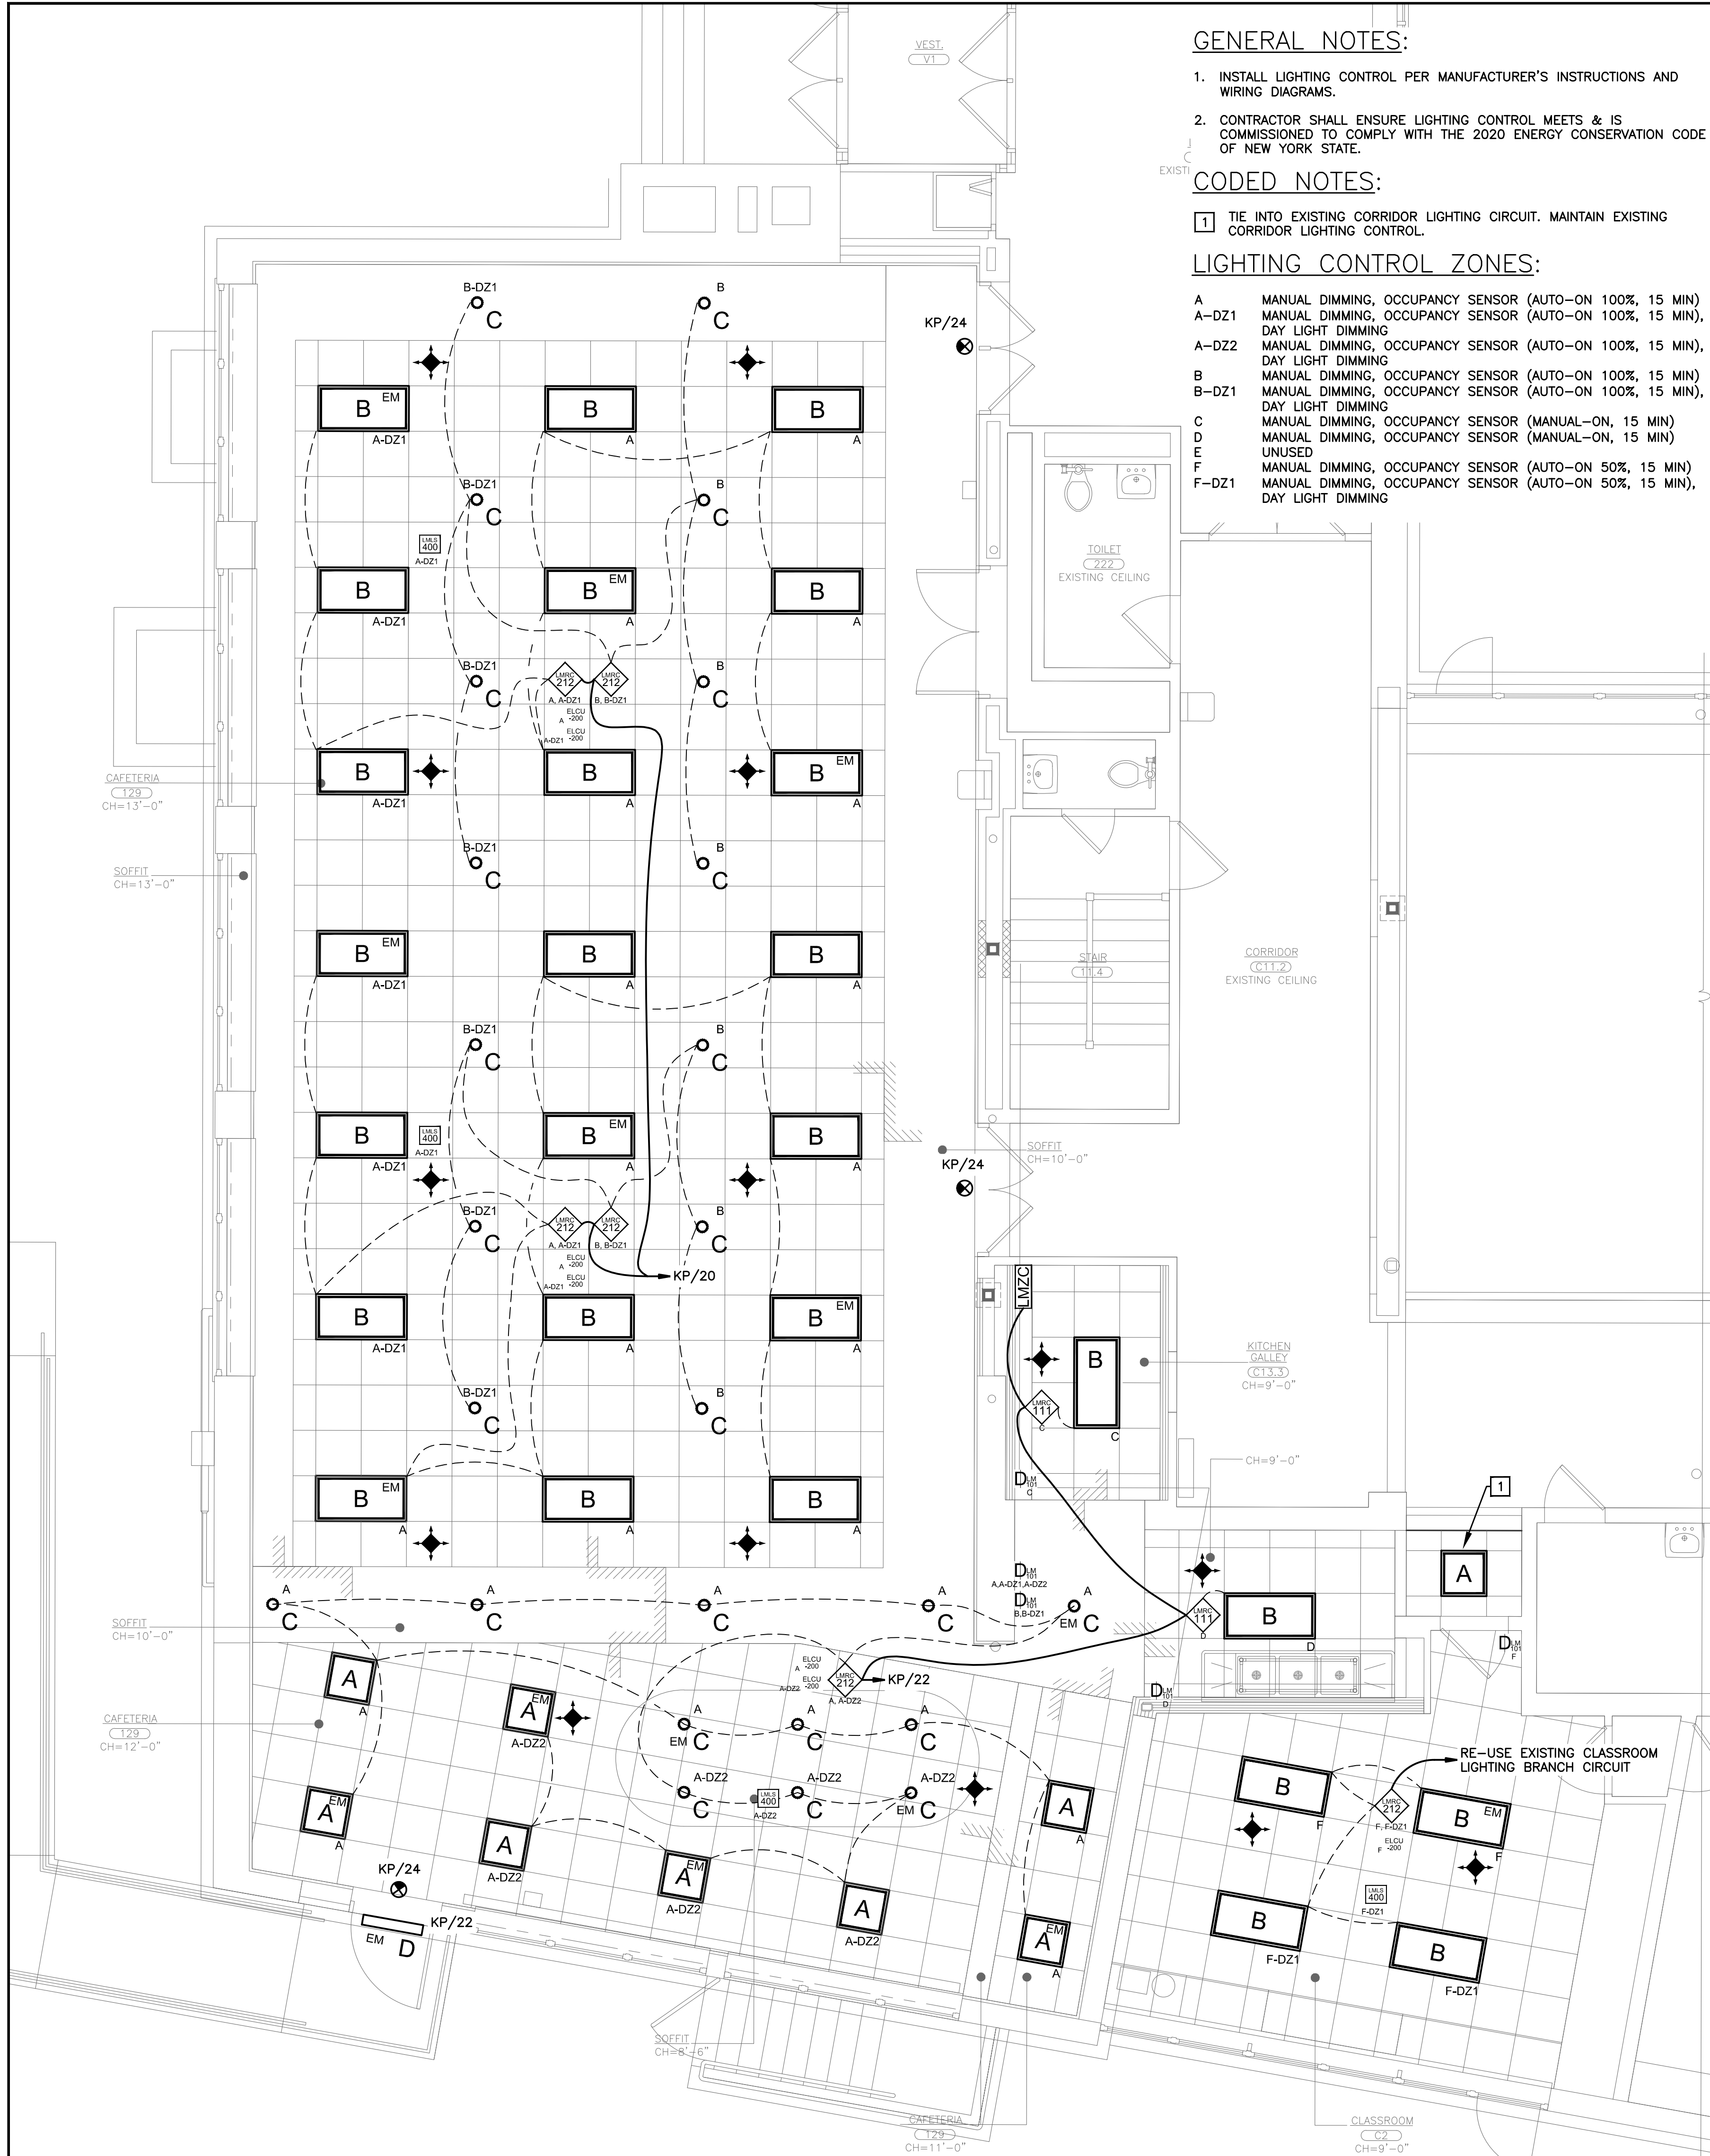

GENERAL NOTES:

1. INSTALL LIGHTING CONTROL PER MANUFACTURER'S INSTRUCTIONS AND WIRING DIAGRAMS.
2. CONTRACTOR SHALL ENSURE LIGHTING CONTROL MEETS & IS COMMISSIONED TO COMPLY WITH THE 2020 ENERGY CONSERVATION CODE OF NEW YORK STATE.

CODED NOTES:


- 1 TIE INTO EXISTING CORRIDOR LIGHTING CIRCUIT. MAINTAIN EXISTING CORRIDOR LIGHTING CONTROL.

LIGHTING CONTROL ZONES:

- A MANUAL DIMMING, OCCUPANCY SENSOR (AUTO-ON 100%, 15 MIN)
A-DZ1 MANUAL DIMMING, OCCUPANCY SENSOR (AUTO-ON 100%, 15 MIN), DAY LIGHT DIMMING
A-DZ2 MANUAL DIMMING, OCCUPANCY SENSOR (AUTO-ON 100%, 15 MIN), DAY LIGHT DIMMING
B MANUAL DIMMING, OCCUPANCY SENSOR (AUTO-ON 100%, 15 MIN)
B-DZ1 MANUAL DIMMING, OCCUPANCY SENSOR (AUTO-ON 100%, 15 MIN), DAY LIGHT DIMMING
C MANUAL DIMMING, OCCUPANCY SENSOR (MANUAL-ON, 15 MIN)
D MANUAL DIMMING, OCCUPANCY SENSOR (MANUAL-ON, 15 MIN)
E UNUSED
F-DZ1 MANUAL DIMMING, OCCUPANCY SENSOR (AUTO-ON 50%, 15 MIN), DAY LIGHT DIMMING

CODED NOTES:

- 1 REMOVE ALL LIGHT FIXTURES & LIGHTING BRANCH CIRCUIT IN CAFETERIA.
- 2 REMOVE ALL LIGHT FIXTURES & RETAIN BRANCH CIRCUIT FOR REUSE.
- 3 SMOKE DETECTOR TO BE RETAINED AND REMOUNTED ON NEW CEILING. REFER TO FIRE ALARM SHEETS.
- 4 SMOKE DETECTOR TO BE REMOVED & RELOCATED ON NEW CEILING. REFER TO FIRE ALARM SHEETS.
- 5 WIRELESS ACCESS POINT TO BE RETAINED AND REMOUNTED ON NEW CEILING.
- 6 PUBLIC ADDRESS SYSTEM SPEAKER TO BE RETAINED AND REMOUNTED ON NEW CEILING.

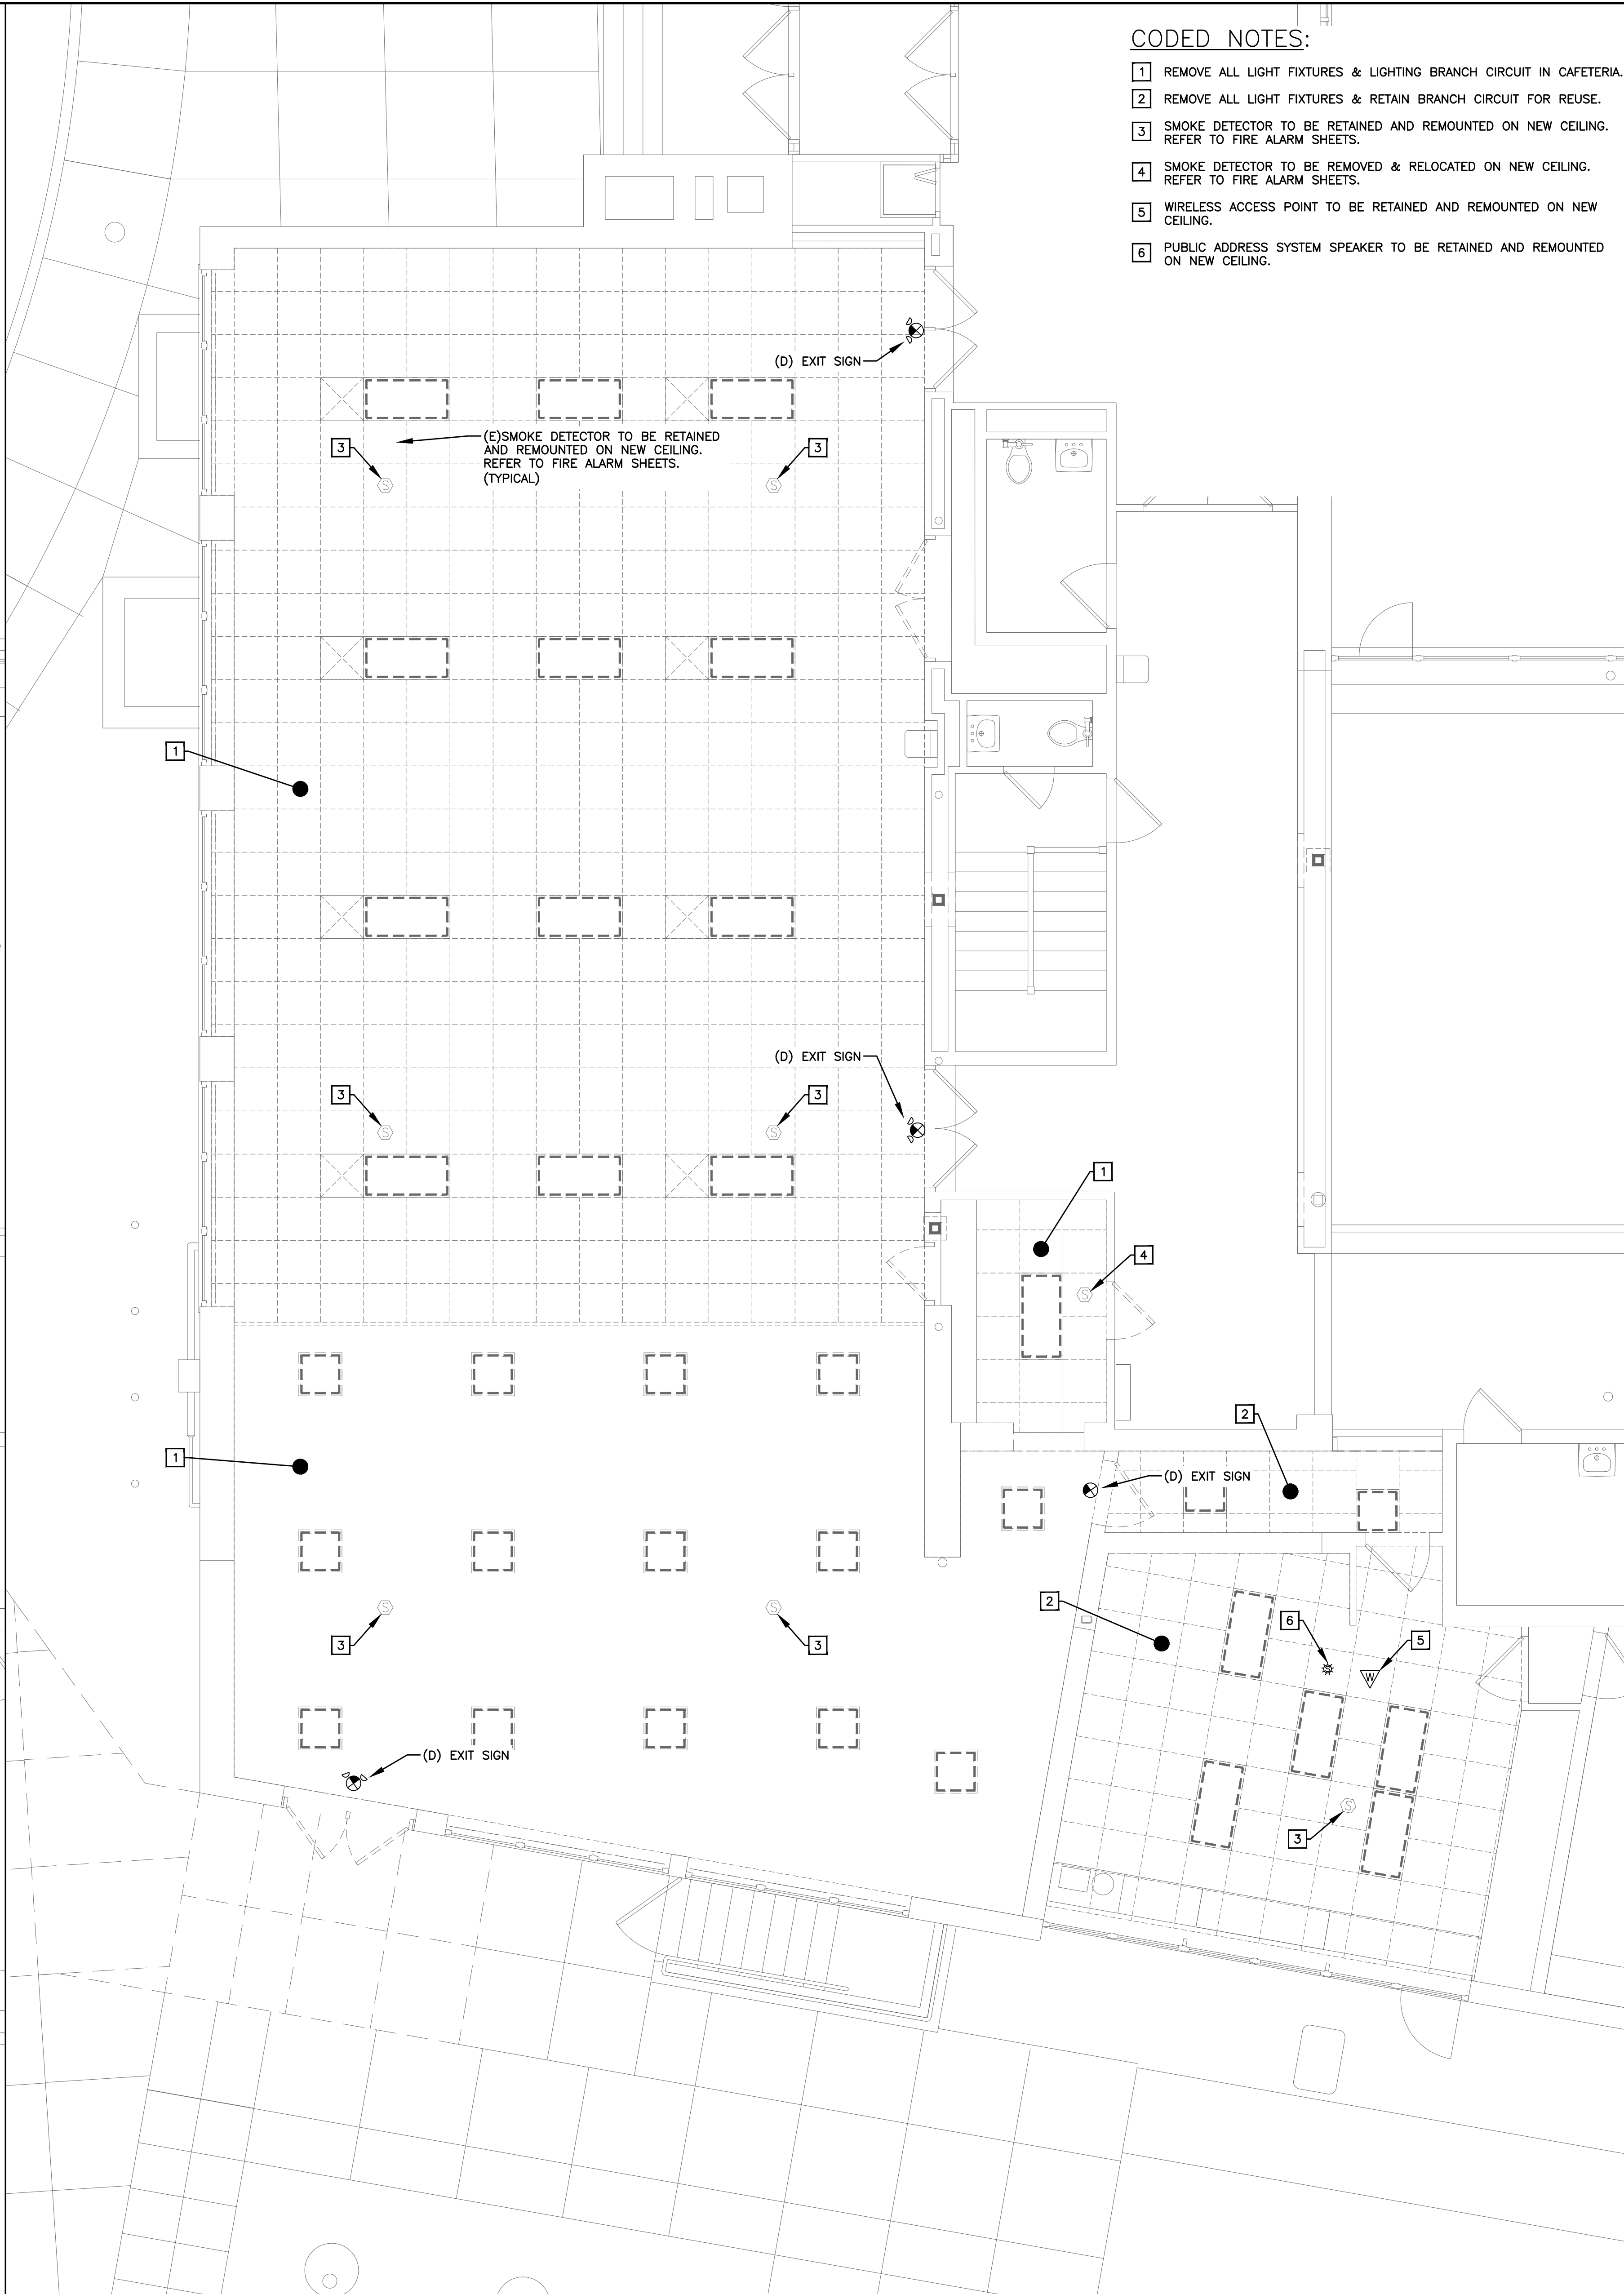

AS PER USA CONGRESS ARCHITECTURAL WORKS COPYRIGHT PROTECTION ACT OF 1990 ALL IDEAS AND DESIGNS INCLUDING DERIVATIVES THEREOF, ALL DRAWINGS AND SPECIFICATIONS CONSTITUTE THE ORIGINAL COPYRIGHT WORK BY FULLER & D'ANGELO, P.C. (F&D). THE DRAWINGS AND SPECIFICATIONS AS INSTRUMENTS OF SERVICE BY F&D ARE CREATED BY F&D FOR THIS PROJECT ONLY AND REMAIN THE PRODUCT AND PROPERTY OF F&D. ANY REPRODUCTION WITHOUT THE PRIOR CONSENT OF F&D IS PROHIBITED.

48 SHOLLWOOD ROAD ELLENBURG NEW YORK 12829
TEL: 814-898-4444 FAX: 814-898-1917
Copyright 2025 All Rights Reserved by FULLER & D'ANGELO P.C.

FULLER
& D'ANGELO
P.C.
ARCHITECTS
PLANNERS

LFG
LANDMARK
FACILITIES
GROUP, INC.
252 East Avenue
Greenville, SC 29601
(253) 866-4029 FAX
(253) 866-8019 Fax

LICENSE EXP. DATE: 03-31-2026

S.E.D. CONTROL NUMBER:
GREENVILLE ELEMENTARY SCHOOL
66-04-06-03-0-008-021

PROJECT:
EDGEMONT SCHOOL DISTRICT
GREENVILLE ELEMENTARY SCHOOL
CAFETERIA RENOVATION

DRAWING TITLE
FIRST FLOOR ELECTRICAL
LIGHTING PLAN

01-31-2025	BID
01-10-2022	SED SUBMISSION
DATE	ISSUED TO
SHEET SIZE: 30"x42"	DRAWING NO. GVES E103
SCALE: AS NOTED	FILE NO. 24529.01
DRAWN BY: LFG	

CIRCUIT BREAKER ANNOTATION IS AS FOLLOWS:

Diagram illustrating the correct annotation for a circuit breaker. The diagram shows a horizontal line representing a busbar with two vertical lines representing circuit breakers. The left circuit breaker is labeled "125A" and "FRAME SIZE". The right circuit breaker is labeled "250A" and "FRAME SIZE". Below the busbar, there is a label "SPACE" with an arrow pointing to the gap between the two circuit breakers. To the right of the busbar, there is a label "TRIP RATING" with an arrow pointing to the gap between the busbar and the right circuit breaker. A large text block below the diagram states: "A PREPARED SPACE FOR A FUTURE CIRCUIT BREAKER WITH-IN THE SPECIFIED FRAME SIZE SHALL BE PROVIDED".

1. ELECTRICAL CONTRACTOR SHALL COORDINATE WITH MECHANICAL CONTRACTOR TO REMOVE BRANCH CIRCUITS BACK TO PANELBOARD FOR EACH DEMOLISHED MECHANICAL EQUIPMENT. ELECTRICAL CONTRACTOR SHALL TURN OFF AND MARK THE CIRCUIT BREAKER THAT THE DEMOLISHED BRANCH CIRCUIT USED AS SPARE IN EACH PLACE THAT CIRCUITS ARE LABELED.
2. CONTRACTOR SHALL DEMOLISH EXISTING PANELBOARDS EDS-1 AND EDS-2. CONTRACTOR SHALL RETAIN ALL FEEDERS AND BRANCH CIRCUITS CONNECTED TO EDS-1 AND EDS-2 FOR RECONNECTION TO NEW MAIN DISTRIBUTION PANEL MDP.

- 1 RECONNECT EXISTING CONDUCTORS TO NEW MDP. CONTRACTOR SHALL VERIFY CIRCUIT BREAKER TRIP RATINGS MATCH THE FUSE RATING PREVIOUSLY PROTECTING THE CONDUCTORS.
- 2 DISCONNECT EXISTING CONDUCTORS AND RETAIN FOR RECONNECTION TO NEW MPD. CONTRACTOR SHALL VERIFY CIRCUIT BREAKER TRIP RATINGS MATCH THE FUSE RATING PREVIOUSLY PROTECTING THE CONDUCTORS.

The diagram illustrates a power distribution system with two main distribution panels (MDP) and their associated equipment.

MDP (SECTION 1) Equipment:

- (E) 1 SET: 4-500MCM OF CONED CONDUCTORS
- (E) SERVICE END BOX
- (E) 2 SETS: 4-500MCM
- (E) CT CAB & METER
- (N) 2 SETS: 4-500MCM
- (N) 800A MCB, 208/120V, 3Ø, 4 WIRE, 100kAIC, MAIN DISTRIBUTION PANEL 'MDP' (SECTION 1)
- 800A MAIN SERVICE DISCONNECT SWITCH
- 1 400A 400A
- 2
- 3 250A 200A
- 4 250A 200A
- 5 250A 175A
- 6 250A 150A
- 7 125A 125A
- 8 125A 100A
- 9 125A 70A
- 10 125A 100A
- 11 125A 100A
- 12 125A 100A
- 13 SPACE
- 14 125A
- 15 125A

MDP (SECTION 2) Equipment:

- (N) 2 SETS: 4-500MCM & #1/0 GND IN 3" EMT
- (N) 800A MLO, 208/120V, 3Ø, 4 WIRE, 100kAIC, MAIN DISTRIBUTION PANEL 'MDP' (SECTION 2)
- 1 400A
- 2
- 3 250A 200A
- 4 250A 200A
- 5 250A 200A
- 6 250A 200A
- 7 125A 100A
- 8 125A 100A
- 9 125A 60A
- 10 125A 30A
- 11 125A
- 12 125A

Other Equipment:

- (E) PANEL 100A MLO 208/120VAC 3Ø, 4W 24P
- (N) PANEL "KP" 125A MLO 208/120VAC 3Ø, 4W 42P
- (N) RTU=1 WITH FACTORY DISCONNECT
- (N) 3-#2/0 & #6 GND IN 2" EMT
- (N) 3-#3 & #8 GND IN 1-1/4" EMT
- (N) 4-#4 & #8 GND IN 1-1/4" EMT
- (N) 3-#3 & #8 GND IN 1-1/4" EMT
- (N) 4-#3 & #8 GND IN 1-1/4" EMT
- 70A/3
- 175A/3
- 100A/3

FROM CONED

(E) 1 SET: 4-500MCM OF CONED CONDUCTORS

(E) SERVICE END BOX

(E) 2 SETS: 4-500MCM

(E) CT CAB & METER

(E) 2 SETS: 4-500MCM

(D)

(D) 800A MLO, 208/120V, 3Φ, 4 WIRE MAIN DISTRIBUTION PANEL 'EDS-2'

1 2 3 4 5 6

400A 200A 200A 200A 400A 200A

400A 200A 150A 125A 400A 200A

(E)LOAD (E)LOAD (E)LOAD (E)LOAD (E)LOAD (E)LOAD

2

(D)

(D) WIRE TROUGH

70A/3 175A/3 100A/3

(E)PANEL
100A MLO
208/120VAC
3PH, 4W
24P

(D) 400A MLO, 208/120V, 3Φ, 4 WIRE MAIN DISTRIBUTION PANEL 'EDS-1'

1 2 3 4 5 6 7

30A 60A 100A 100A 200A 200A 200A

?A ?A ?A ?A ?A ?A ?A

(E)LOAD (E)LOAD (E)LOAD (E)LOAD (E)LOAD (E)LOAD (E)LOAD

2

(D) STAGE PANEL
100A MLO
208/120VAC
3PH, 4W
20P

11

FULLER
D'ANGELO
P.C.

ARCHITECTS
PLANNERS

111	224

LICENSE EXP. DATE: 03-31-2028

S.E.D. CONTROL NUMBER:
GREENVILLE ELEMENTARY SCHOO
66-04-06-03-0-008-021

PROJECT TITLE EDGEMONT SCHOOL DISTRICT GREENVILLE ELEMENTARY SCHOOL CAFETERIA RENOVATION	DRAWING TITLE ELECTRICAL ONE LINE DIAGRAM
---	--

01-31-2025	BID
01-10-2022	SED SUBMISSION
DATE	ISSUED TO
SHEET SIZE 30"x42"	DRAWING NO. GVES E200
SCALE AS NOTED	
DRAWN BY LFG	FILE NO. 24529.01

NEW

MAIN DISTRIBUTION PANEL SCHEDULE "MDP" (SECTION 1)

PANEL	PANEL MDP	BUS		800 AMP MAIN CIRCUIT BREAKER		VOLTAGE		120/208V, 3PH, 4 WIRE								
FEED	TOP FED	UNIT SPACE		60"		DIMENSIONS		90"H x 32" W x 12.75"D								
MOUNTING/TRIM	SURFACE (DOOR-IN-DOOR)	SPEC		SIEMENS P5C90WN800ETS		AIC SYMM		100,000								
DESCRIPTION	WIRE	GRD.	COND.	FRAME	TRIP	CKT.	A PHASE	B PHASE	C PHASE	CTP.	TRIP	FRAME	COND.	GRD.	WIRE	DESCRIPTION
					8.75"		800A MAIN CIRCUIT BREAKER SERVICE RATED (6.75" UNIT SPACE)					8.75"				
(E) A.P.R. FEED				400A 6.25"	400A	1	-	-	-	-	2	400A 6.25"				400A C/B ONLY SINGLE MOUNT
(E) BOILER 1 & 2				250A 5"	200A	3	-	-	-	-	4	250A 5"				(E) LOAD ?
(E) LOAD				250A 5"	175A	5	-	-	-	-	6	150A 5"				(E) LOAD
(E) LOAD				125A 3.75"	125A	7	-	-	-	-	8	100A 3.75"				(E) LOAD
(E) LOAD				125A 3.75"	70A	-	17571	-	-	-	10	100A 3.75"	1-1/4"	8	3	(N) PANTRY PANEL "KP"
(N) CAFETERIA RTU	3	8	1-1/4"	100A	100A	8760	-	8760	-	6520	12	125A 3.75"				SPACE
SPACE				125A 3.75"		13	-	-	-	-	14	125A 3.75"				SPACE
					17.5"		800A FEED THROUGH LUGS (17.5" UNIT SPACE)					17.5"				
SUBTOTAL						-	-	-	-	-						
TOTAL CONNECTED LOAD						-	va	-	-	-		(xxx KVA / 208V * 73) = AMPERES				
TOTAL DESIGN LOAD						-	va	-	-	-						
125% TOTAL LOAD						-	kva	-	-	-						

LOAD SUMMARY:		
LOADS:	POWER	SOURCE
EXISTING BUILDING	116,222KVA	07/2019-06/2021 UTILITY BILL PEAK DEMAND
(N) RTU-1	026,280KVA	(106,400KW AT ESTIMATED 0.9PF = 118,222KVA)
(N) PANTRY PANEL "KP"	023,852KVA	MECHANICAL SCHEDULES/PANEL SCHEDULE
		PANTRY PANEL "KP" SCHEDULE
TOTAL CONNECTED LOAD:	168,354KVA	
TOTAL DESIGN LOAD:	174,924KVA	
TOTAL CURRENT:	486A	LOAD < 800A SERVICE SIZE (CALCULATED AT 208Y/120VAC, 3PH, 4W)

LIGHTING FIXTURE SCHEDULE

TAG	SYMBOL	DESCRIPTION	EQUIVALENT MANUFACTURERS AND CATALOG NUMBER	MOUNTING OR LAMPS	QUANTITY	REMARKS
A	A	2'x2' LED TROFFER 0-10V DIMMING	WILLIAMS AT1 AT1-2-2-L40-8-35-D-DIM-UNV	34.2W 3500K	*	
A-EM	A	2'x2' LED TROFFER WITH INTEGRAL EMERGENCY BATTERY 0-10V DIMMING	WILLIAMS AT1 AT1-2-2-L40-8-35-D-EM/10W-DIM-UNV	34.2W 3500K	*	WIRE EMERGENCY BATTERY AHEAD OF LOCAL SWITCHING
B	B	2'x4' LED TROFFER 0-10V DIMMING	WILLIAMS AT1 AT1-2-4-L40-8-35-D-EM/10W-DIM-UNV	37.2W 3500K	*	
B-EM	B	2'x4' LED TROFFER WITH INTEGRAL EMERGENCY BATTERY 0-10V DIMMING	WILLIAMS AT1 AT1-2-4-L40-8-35-D-EM/10W-DIM-UNV	37.2W 3500K	*	WIRE EMERGENCY BATTERY AHEAD OF LOCAL SWITCHING
C	C	RECESSED CAN LIGHT FIXTURE 0-10V DIMMING	USAI LIGHTING B4RDF-16C3-35KS-50-SF-WH-FT-UNV	16W 3500K	*	
C-EM	C	RECESSED CAN LIGHT FIXTURE WITH INTEGRAL EMERGENCY BATTERY 0-10V DIMMING	USAI LIGHTING B4RDF-16C3-35KS-50-SF-WH-FT-UNV-D6E	16W 3500K	*	WIRE EMERGENCY BATTERY AHEAD OF LOCAL SWITCHING
D-EM	D	EXTERIOR EGRESS FIXTURE WITH INTEGRAL EMERGENCY BATTERY 0-10V DIMMING	LUMINAIRE LED AEL AEL-24-MIN1-30W-40K-MVOLT-DP-SVH-EMB310-PC	30W 4000K	1	WIRE EMERGENCY BATTERY AHEAD OF LOCAL SWITCHING
EXIT	EXIT	EXIT SIGN WITH WHICH FACE AND GREEN LETTERS WITH SELF DIAGNOSTICS	LITHONIA LIGHTING LGM S W 3 G MVOLT EL N SD	5W LED MAX GREEN	**	

NOTE: * - FINAL QUANTITIES PER PLANS


NEW MAIN DISTRIBUTION PANEL SCHEDULE "MDP" (SECTION 2)																
PANEL	PANEL MDP		BUS		800 AMP MAIN LUGS ONLY		VOLTAGE		120/208V, 3PH, 4 WIRE							
FED	BOTTOM FED		UNIT SPACE		30"		DIMENSIONS		60"H x 32"W x 10"D							
MOUNTING	SURFACE (DOOR-IN-DOOR)		SPEC		SIEMENS P5C60ML800ERS		AIC SYMM		100,000							
DESCRIPTION	WIRE	GRD.	COND.	FRAME	TRIP	CKT.	VA A PHASE	VA B PHASE	VA C PHASE	CKT.	TRIP	FRAME	COND.	GRD.	WIRE	DESCRIPTION
SPACE					400A 6.25"	1	-	-	-	-	2		6.25"			400A C/B ONLY SINGLE MOUNT
(E)A-HALLWAY					250A 5"	3	-	-	-	-	4	200A 5"	250A 5"			(E)BOILER RM PNL
(E)NURSE OFFICE/HALL LIGHTS					250A 5"	5	-	-	-	-	6		250A 5"			SPACE
(E)KINDERGARTEN OLD WING					125A 3.75"	7	-	-	-	-	8	100A 3.75"	125A 3.75"			(E)LOAD ?
(E)CELLAR/BOILER RM LIGHTS					125A 3.75"	9	-	-	-	-	10	30A 3.75"	125A 3.75"			(E)LOAD ?
SPACE					125A 3.75"	11	-	-	-	-	12		125A 3.75"			SPACE
					0"		800A MAIN LUGS (0" UNIT SPACE)								0"	
				SUBTOTAL		-		-		-						
				TOTAL CONNECTED LOAD		-		va		-		amps				(XXX KVA 208V * 73) = AMPERES
				TOTAL DESIGN LOAD		-		va		-		amps				
				125% TOTAL LOAD		-		kva		-		amps				

NEW PANTRY PANEL SCHEDULE "KP"																			
PANEL		"KP"		BUS 125 AMP MAIN LUGS ONLY						VOLTAGE 120/208V, 3PH, 4 WIRE									
FEED		BOTTOM		POLES 42						DIMENSIONS 20" x 5.75"D									
MOUNTING/TRIM		FLUSH (DOOR-IN-DOOR)		SPEC SIEMENS P1C42ML125ABSN						AIC SYMM 22,000									
DESCRIPTION		WIRE	GRD.	COND.	TRIP	CKT.	A PHASE	B PHASE	C PHASE	CTP.	TRIP	COND.	GRD.	WIRE	DESCRIPTION				
FLRBOX-HOT FOOD COUNTER		4	10	10	1/2"	25A	1	1997	264	3	1997	756	2	20A	1/2"	12	12	FLRBOX-MILK COOLER	4
RCPT-WARM HOLDING CABINET		4	12	12	1/2"	20A	5				1500	1500	6	20A	1/2"	12	12	FLRBOX-COLD FOOD COUNTER	4
RCPT-WARM HOLDING CABINET		4	12	12	1/2"	20A	7				1500	1500	8	20A	1/2"	12	12	FLRBOX-FLAT TOP COUNTER	4
RCPT-REFRIGERATED CABINET		4	12	12	1/2"	20A	9				1500	1500	10	20A	1/2"	12	12	FLRBOX-CASHIER COUNTER	4
RCPT-REFRIGERATED CABINET		4	12	12	1/2"	20A	11				1500	1500	12	20A	1/2"	12	12	FLRBOX-SPARE	4
RCPT-REFRIGERATED CABINET		4	12	12	1/2"	20A	13				1500	1500	14	20A	1/2"	12	12	FLRBOX-SPARE	4
RCPT-REFRIGERATED CABINET		4	12	12	1/2"	20A	15				360	1500	16	20A	1/2"	12	12	RCPT-COUNTER	4
RCPT-CONV.		4	12	12	1/2"	20A	17				20	20	18	20A	1/2"	12	12	RCPT-COUNTER	4
KITCHEN EXHAUST FAN		12	12	1/2"	20A	19	528	11425					20	20A	1/2"	12	12	LTG-CAFETERIA NORTH	
RCPT-ROOF MECH.		12	12	1/2"	20A	21					360	585	22	20A	1/2"	12	12	LTG-CAFETERIA SOUTH	
ELEC. DOOR HARDWARE		12	12	1/2"	20A	23					20	20	24	20A	1/2"	12	12	CAFETERIA EXIT SIGNS	2
SPARE					20A	25	-	-	-	-			26	20A				SPARE	
SPARE					20A	27	-	-	-	-			28	20A				SPARE	
SPARE					20A	29	-	-	-	-			30	20A				SPARE	
SPARE					20A	31	-	-	-	-			32	20A				SPARE	
SPARE					20A	33	-	-	-	-			34	20A				SPARE	
SPARE					20A	35	-	-	-	-			36	20A				SPARE	
SPARE					20A	37	-	-	-	-			38	20A				SPARE	
SPARE					20A	39	-	-	-	-			40	20A				SPARE	
SPARE					20A	41	-	-	-	-			42	20A				SPARE	
		SUB TOTAL					7574		9698				6580						
		TOTAL CONNECTED LOAD					23852		9698		66	amps	(XXX KVA / 208V * 73) = AMPERES						
		TOTAL DESIGN LOAD					23852		9698		66	amps							
		125% TOTAL LOAD					-		kva		-	amps							

- KEYED NOTES:
1. PROVIDE HACR TYPE CIRCUIT BREAKERS
 2. PROVIDE LOCKING CLIPS
 3. VERIFY POWER REQUIREMENTS FOR ACTUAL EQUIPMENT BEFORE INSTALLATION.
 4. PROVIDE CFI CIRCUIT BREAKER
 5. CIRCUIT CONTROLLED VIA TIMECLOCK

FLOORBOX SCHEDULE

TAG	DESCRIPTION	EQUIVALENT MANUFACTURERS AND CATALOG NUMBER	REMARKS
F2	2 GANG FLOOR BOX, RECTANGULAR BRUSHED ALUMINUM COVER, WITH TWO TAMPER RESISTANT SIMPLEX RECEPTACLES.	HUBBELL WIRING DEVICE-KELLEMS SYSTEMONE BOX: CFB2G30 COVER: 24GT0VRALU DEVICE PLATES: (2) FBMP139 DEVICES: (2) HBL5361BK	CONTRACTOR SHALL LABEL EACH RECEPTACLE. LABEL SHALL CONTAIN PANEL, CIRCUIT NUMBER, AND EQUIPMENT SERVED.
F10	10 GANG FLOOR BOX, RECTANGULAR BRUSHED ALUMINUM COVER, WITH ONE NEMA 6-30R RECEPTACLE, THREE TAMPER RESISTANT SIMPLEX RECEPTACLES, AND ONE GANG FOR DATA.	HUBBELL WIRING DEVICE-KELLEMS SYSTEMONE BOX: CFB10G55 COVER: 610GT0VRALU DEVICE PLATES: (1) FB10MP3GAPP, (1) FB10TLZ, (1) FB10MPKEY, (1) FB10MPBNK DEVICES: (1) HBL9330, (3) HBL5361BK	CONTRACTOR SHALL LABEL EACH RECEPTACLE. LABEL SHALL CONTAIN PANEL, CIRCUIT NUMBER, AND EQUIPMENT SERVED.

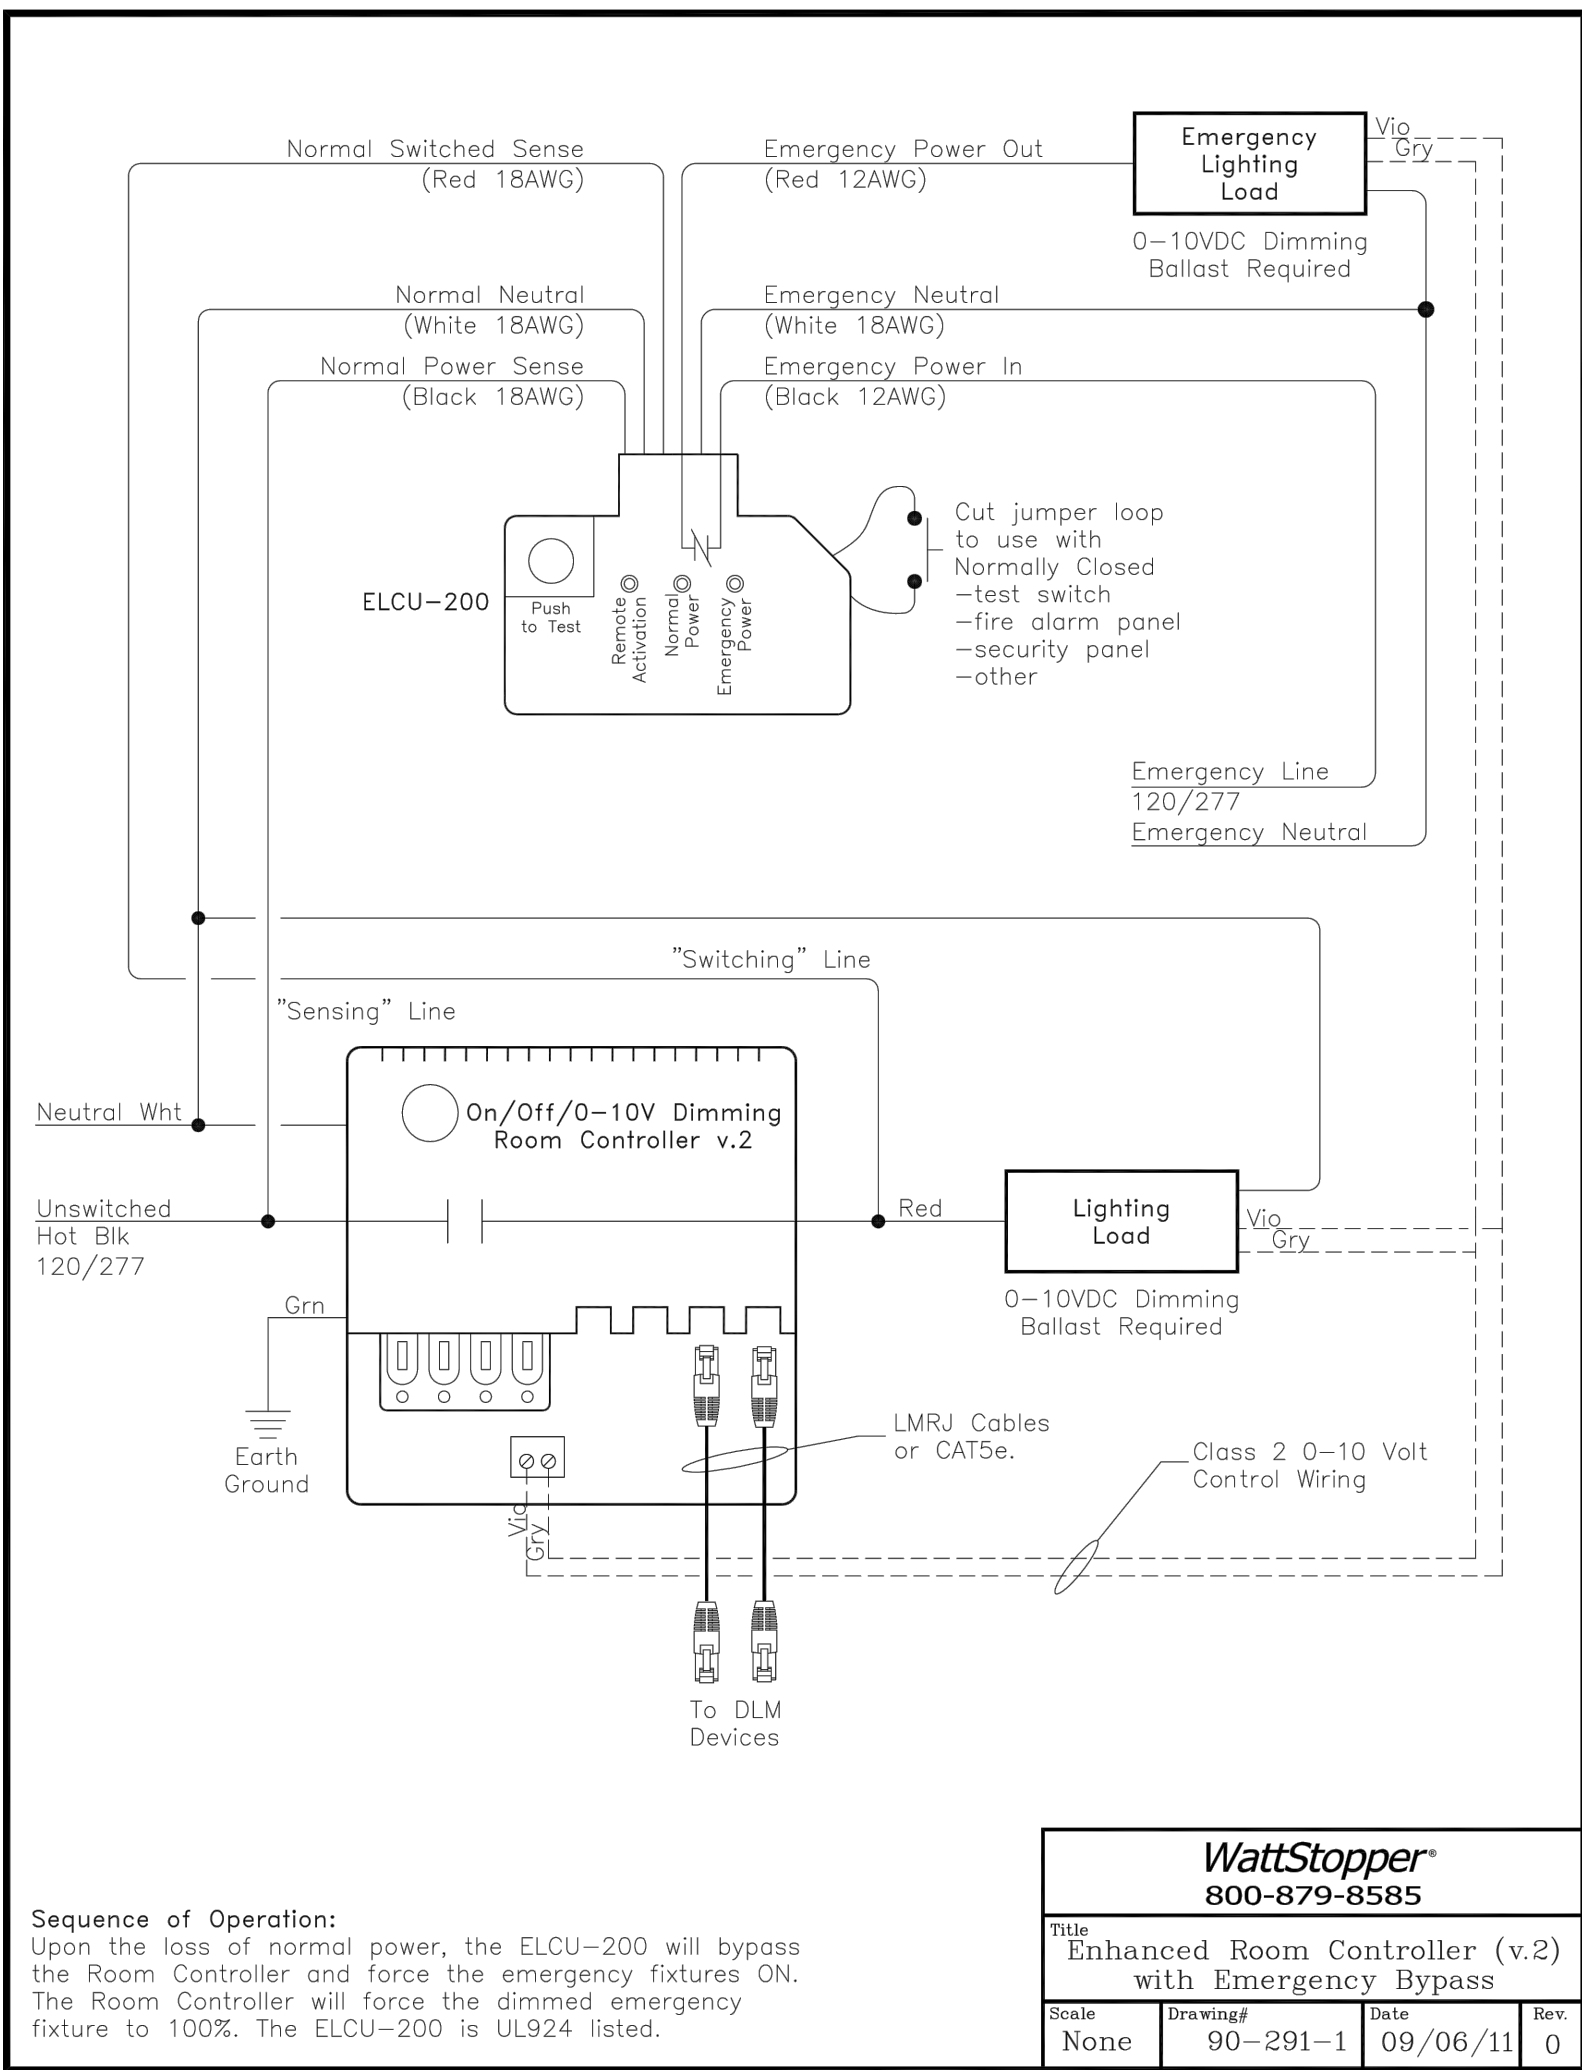


GENERAL NOTES

- CONTRACTOR SHALL BE RESPONSIBLE FOR PROVIDING AND INSTALLING ALL NEW COMPATIBLE AND ADDRESSABLE FIRE ALARM DEVICES AND ASSOCIATED EQUIPMENT, CABLING AND CONDUIT TO EXISTING FIRE ALARM CONTROL PANEL FOR A FULLY COMPLETE AND OPERABLE SYSTEM.
- ALL EQUIPMENT SHALL BE INSTALLED IN ACCORDANCE WITH THE BUILDING CODE OF NEW YORK STATE, THE ELECTRICAL CODE OF NEW YORK STATE AND REQUIREMENTS SET FORTH BY THE NEW AMERICANS WITH DISABILITIES ACT (A.D.A.).
- THE PROPRIETARY BASE BUILDING FIRE ALARM VENDOR IS JOHNSON CONTROLS SIMPLEX GRINNELL.
- COMPLETE INSTALLATION OF THE FIRE ALARM SYSTEM SHALL BE COORDINATED WITH THE BUILDING'S FIRE ALARM SYSTEM VENDOR. EXISTING DEVICES OUTSIDE INDICATED AREA OF WORK TO BE REPLACED OR UPGRADED AS NEEDED TO MEET CODE OR FUNCTIONAL REQUIREMENTS. CONTRACTOR TO VERIFY CAPACITY OF EXISTING FA PANELS AND PROVIDE EXPANSION HARDWARE IF NECESSARY.
- THE ELECTRICAL CONTRACTOR MUST SUBMIT WIRING DIAGRAMS TO THE ENGINEER FOR ANY MODIFICATIONS TO THE FIRE ALARM SYSTEM.
- THE ELECTRICAL CONTRACTORS BID SHALL INCLUDE PROGRAMMING AND TESTING BY THE BUILDING FA VENDOR.
- ANY RELATED CONNECTION CHARGES AND PROGRAMMING CHARGES SHALL BE INCLUDED IN THE ELECTRICAL CONTRACTOR'S BID.
- ALL 120V REQUIREMENTS FOR ADDITIONAL EQUIPMENT REQUIRED BY THE FA CONTRACTOR SHALL BE INCLUDED IN THE ELECTRICAL CONTRACTOR'S BID.
- ELECTRICAL CONDUITS SHALL ENTER ONLY AT THE SIDES OR BOTTOM OF THE FIRE ALARM TERMINAL BOXES, CONTROL PANELS ETC, UNLESS DESIGNED AND APPROVED FOR ENTRY ON THE TOP.
- ALL WIRING TYPES SHALL BE COORDINATED WITH THE BUILDING DEPARTMENT, SHALL BE APPROVED BY THE LOCAL FIRE DEPARTMENT AND ALL AUTHORITIES HAVING JURISDICTION.
- ALL INTERIOR EXPOSED WIRING SHALL BE IN WIREMOLD IN FINISHED SPACES.
- ALL EXTERIOR WIRING SHALL BE IN RIGID GALVANIZED STEEL CONDUIT. CONTRACTOR SHALL PROVIDE SLEEVE AND SEAL FOR ALL BUILDING PENETRATIONS.
- DUCT DETECTOR FURNISHED BY ELECTRICAL CONTRACTOR. MECHANICAL CONTRACTOR IS RESPONSIBLE FOR INSTALLING SAMPLING TUBES & HOUSING. ELECTRICAL CONTRACTOR IS RESPONSIBLE FOR INSTALLING DETECTOR AND WIRING. CONTROL RELAYS FURNISHED & INSTALLED BY ELECTRICAL CONTRACTOR. COORDINATE WITH MECHANICAL CONTRACTOR.

FIRE ALARM LEGEND


- DUCT SMOKE DETECTOR, WITH WEATHERPROOF ENCLOSURE
- CONTROL RELAY, WITHIN DUCT SMOKE DETECTOR ENCLOSURE
- REMOTE TEST STATION
- FIRE ALARM CONTROL PANEL
- FAN SHUTDOWN
- SMOKE DETECTOR
- PULL STATION
- STROBE
- SPEAKER STROBE
- NEW
- EXISTING TO REMAIN
- RELOCATED EXISTING
- REMOVE EXISTING

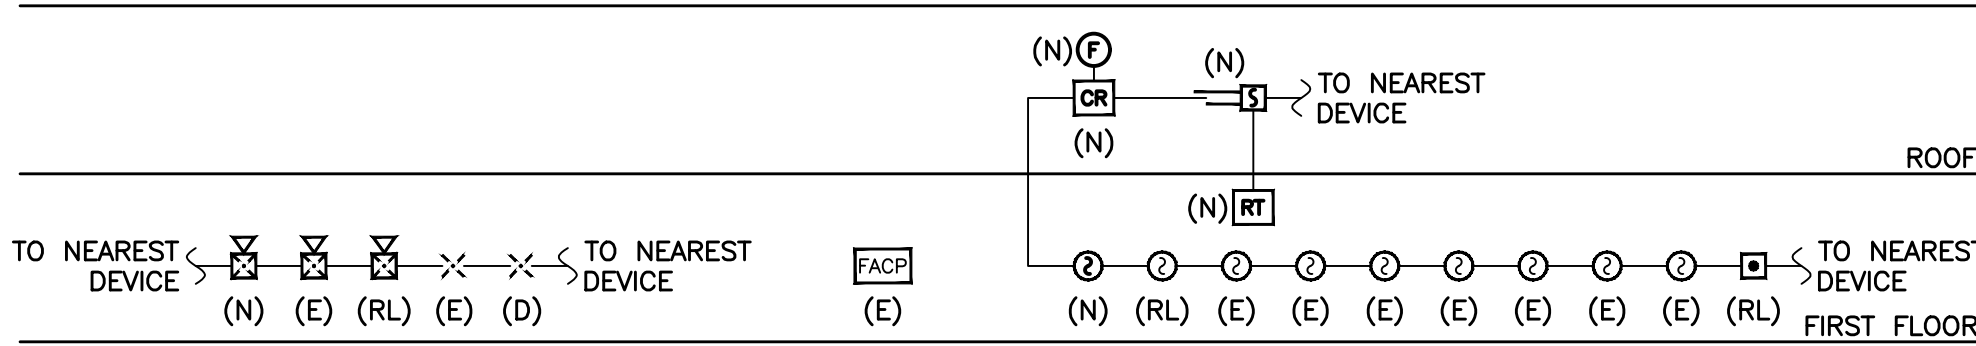


FIRE ALARM PART RISER DIAGRAM

SYSTEM INPUTS	CONTROL UNIT ANNUNCIATOR						NOTIFICATION		REQUIRED FIRE SAFETY CONTROL	CENTRAL OFFICE NOTIFICATION			
	ACTIVATE COMMON ALARM SIGNAL INDICATOR (LED)	ACTIVATE AUDIBLE ALARM SIGNAL (BUZZER ON YES)	ACTIVATE COMMON TROUBLE SIGNAL INDICATOR (LED)	ACTIVATE COMMON TROUBLE SIGNAL (BUZZER ON FCS)	ANNUNCIATE ALARM DEVICE (LCD DISPLAY)	ANNUNCIATE TROUBLE DEVICE (LCD DISPLAY)	ACTIVATE ALL FLOOR SPEAKERS	ACTIVATE ALL FLOOR STROBES	SHUT DOWN AC UNIT (OVER 2000 CFM)	ACTIVATE DOOR RELEASE	TRANSMIT SMOKE DETECTOR ALARM SIGNAL	TRANSMIT HEAT DETECTOR ALARM SIGNAL	TRANSMIT MANUAL ALARM SIGNAL
AREA SMOKE DETECTOR	1	X	X		X		X	X	X	X	X		
DUCT SMOKE DETECTOR	2	X	X		X		X	X	X	X	X		

FIRE ALARM SEQUENCE OF OPERATIONS

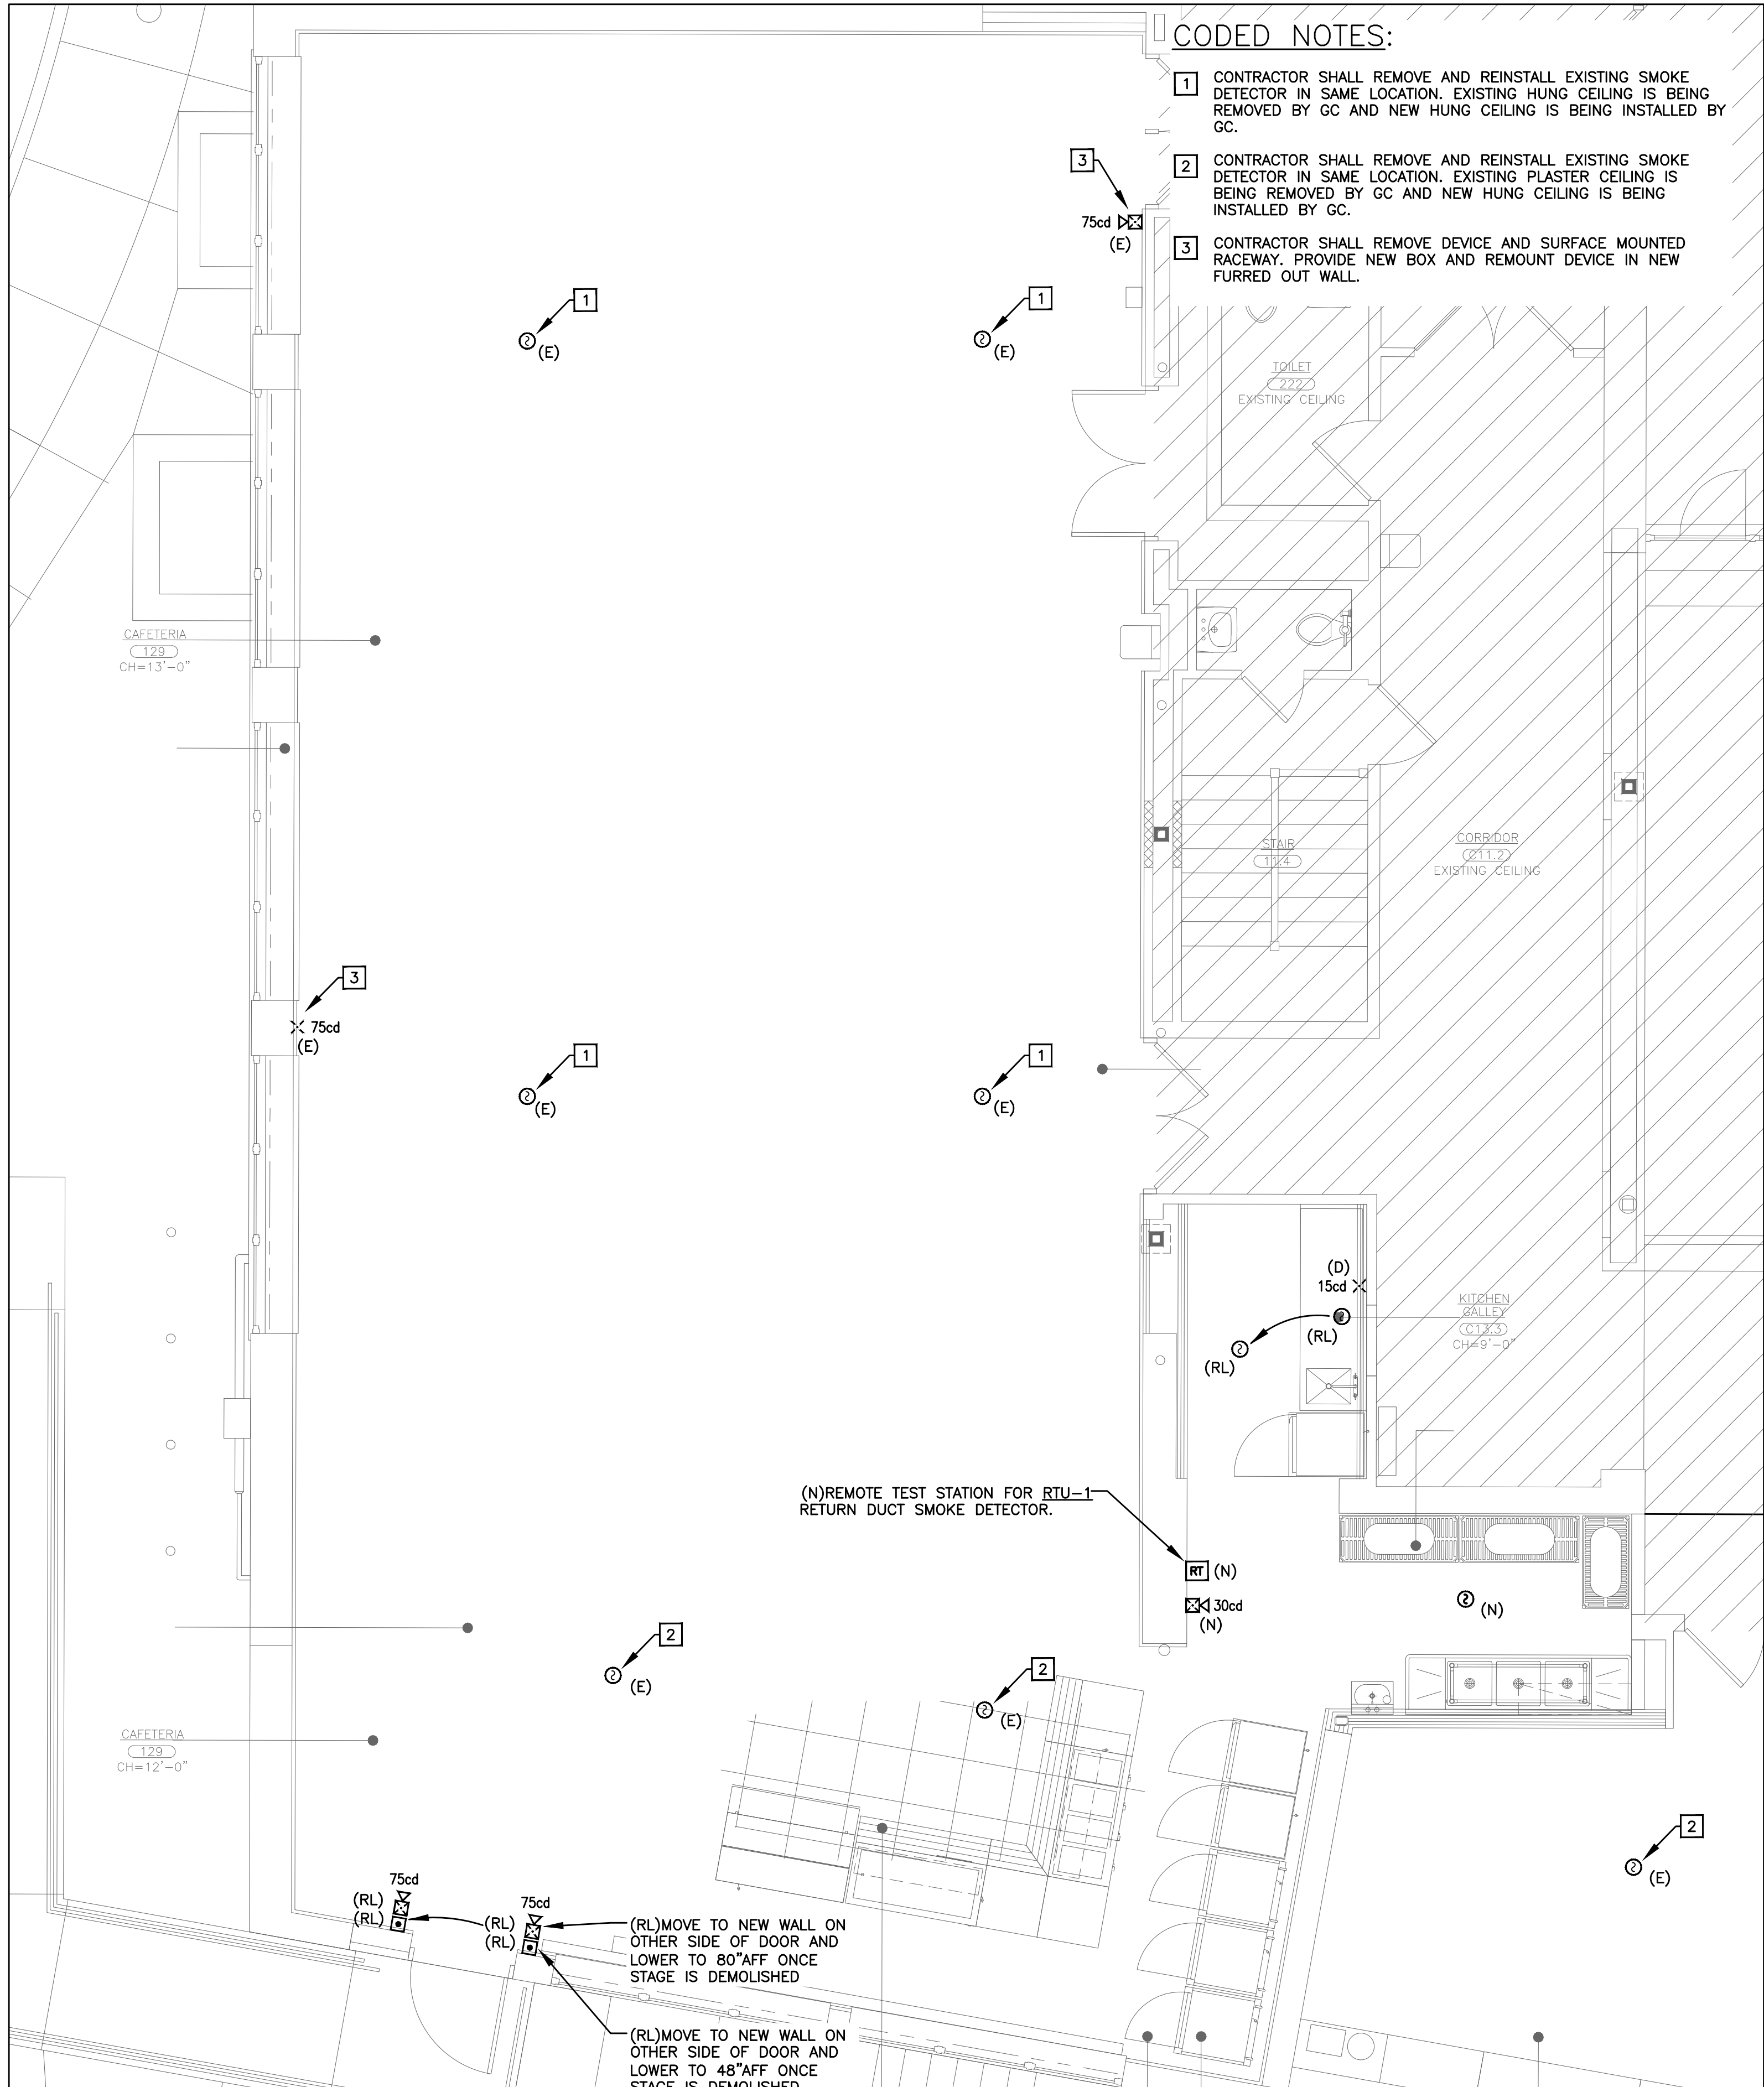

1 FIRST FLOOR FIRE ALARM PLAN
SCALE: 1/4" = 1'-0"

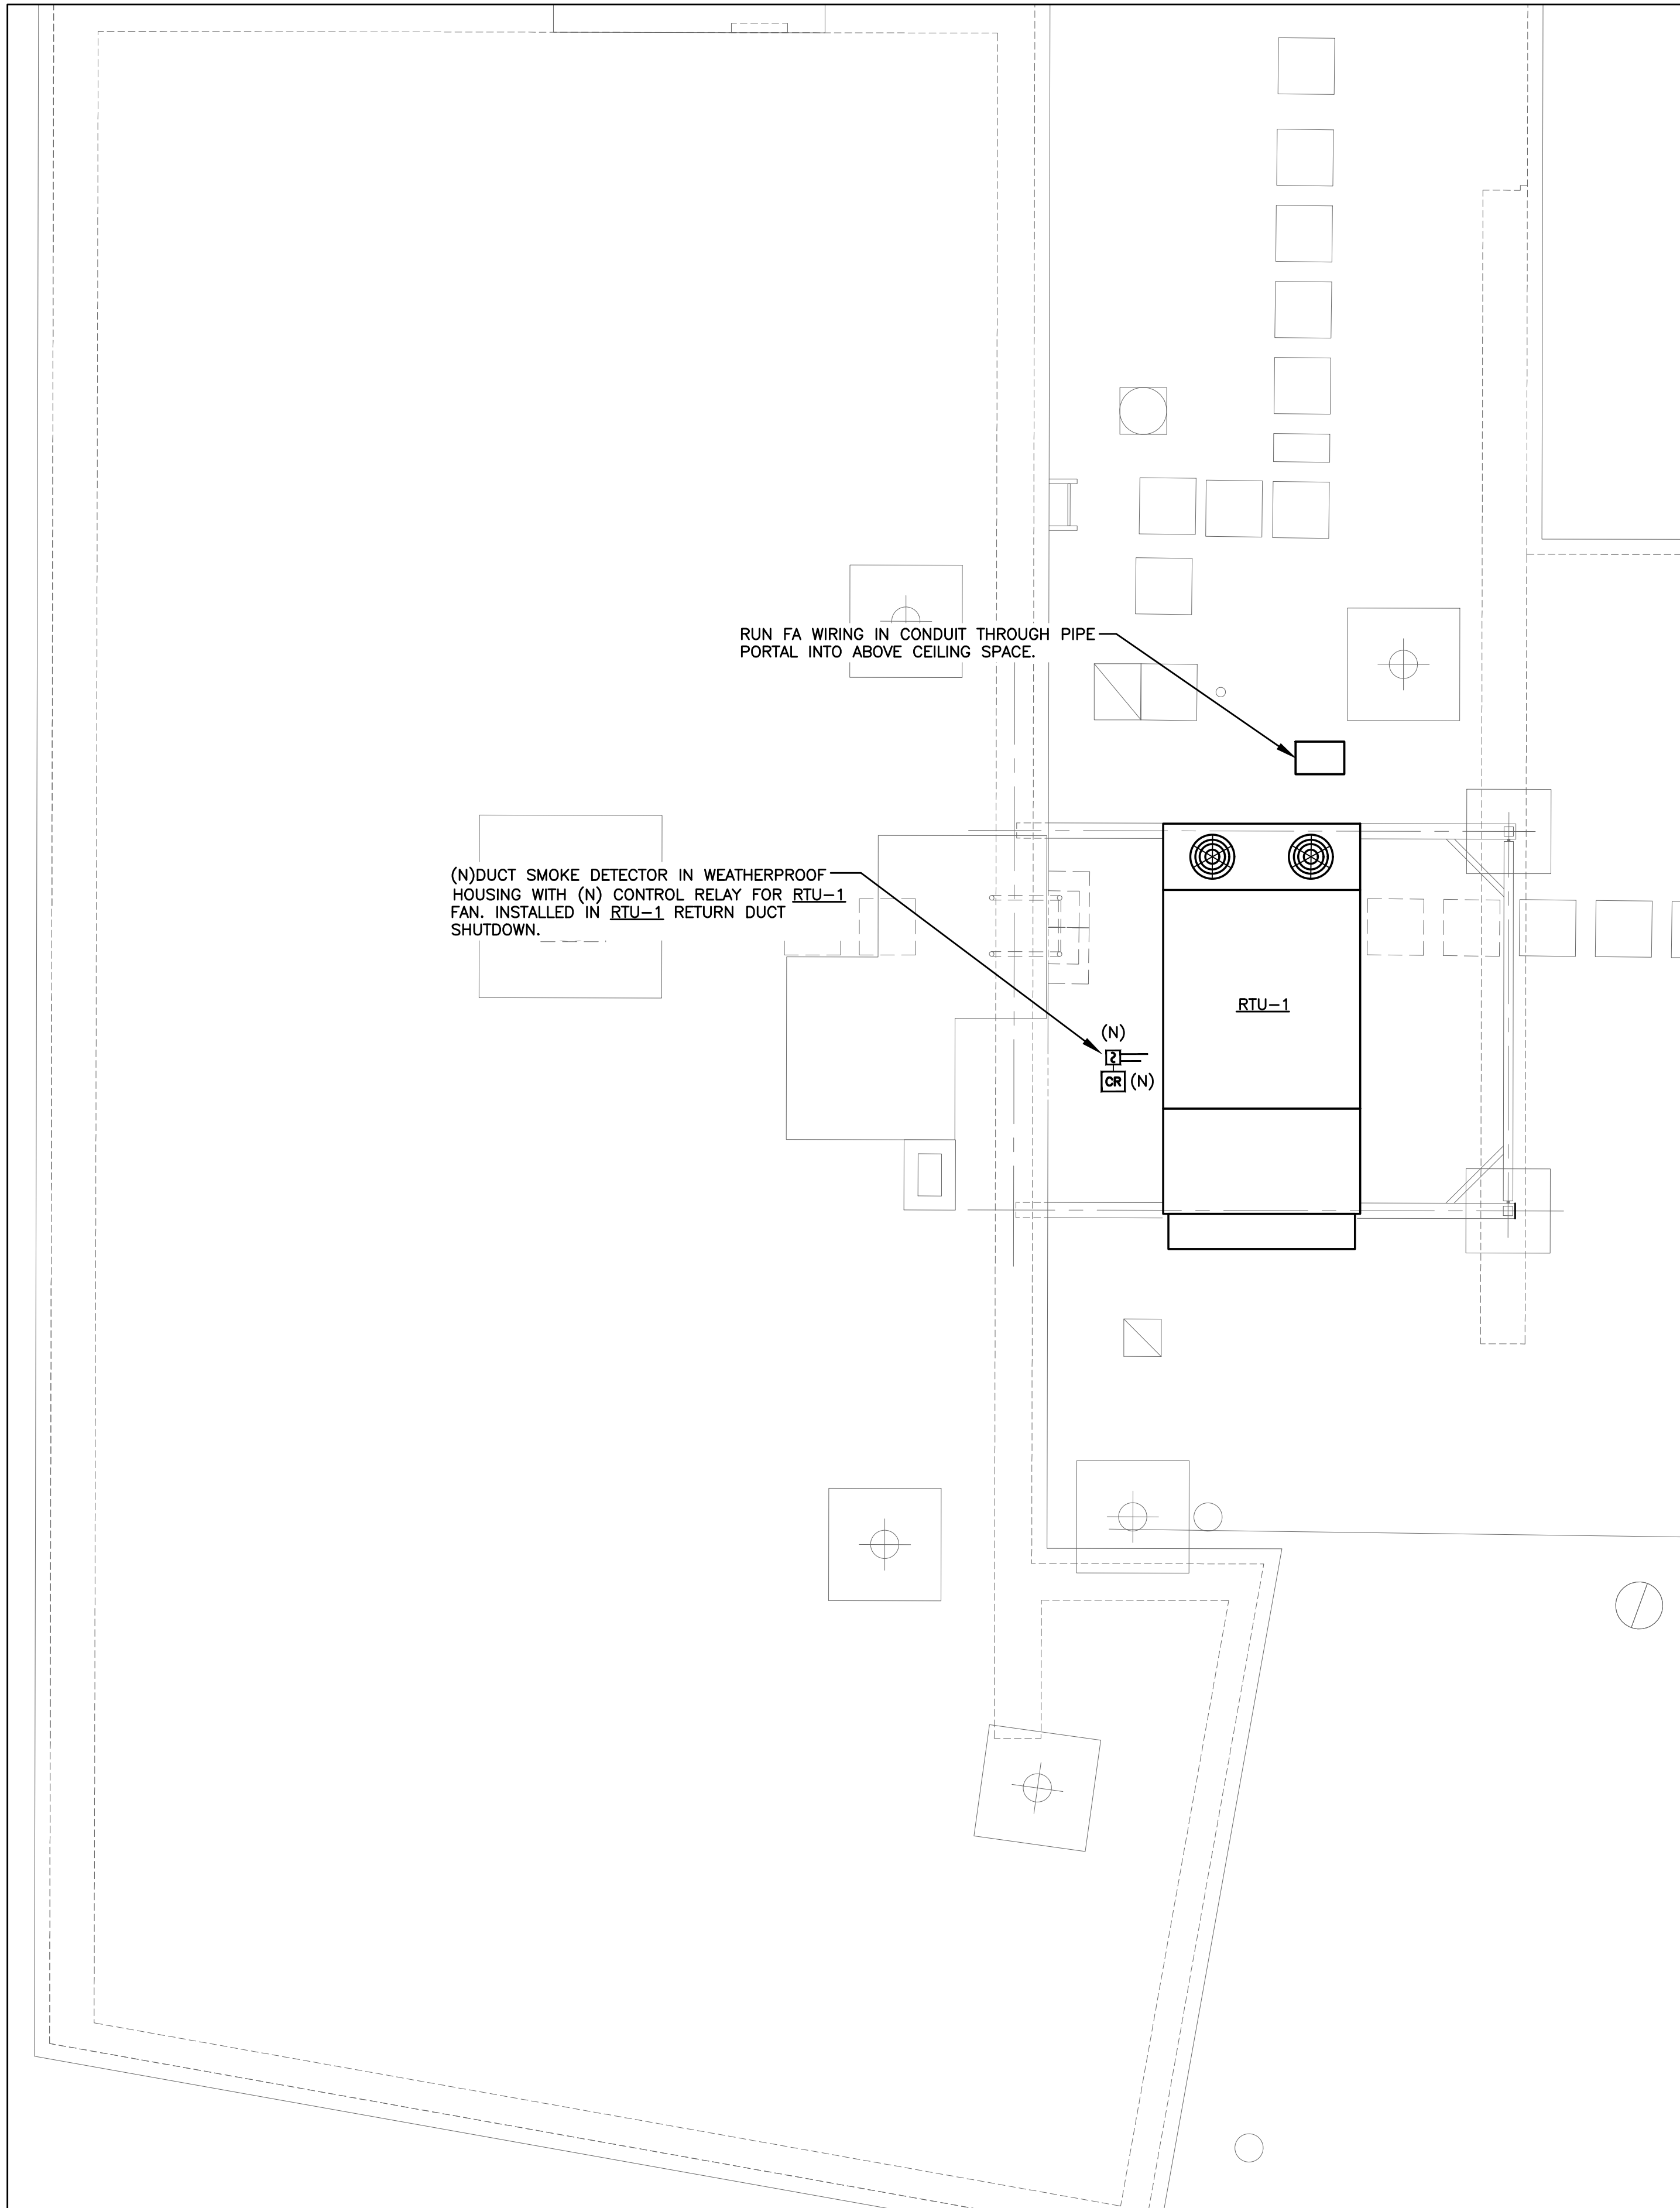

1 ROOF FIRE ALARM PLAN
SCALE: 1/4" = 1'-0"