


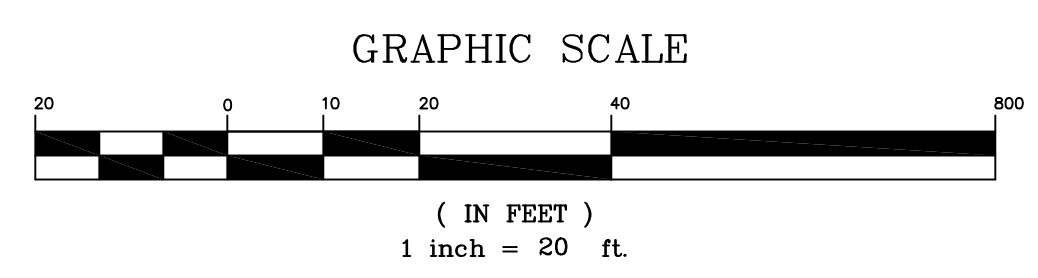

GENERAL PHOTOMETRIC SCHEDULE	
AVERAGE FOOT-CANDLES	0.30
MAXIMUM FOOT-CANDLES	4.0
MINIMUM FOOT-CANDLES	0.0
MINIMUM TO MAXIMUM FC RATIO	0.00
MAXIMUM TO MINIMUM FC RATIO	3.97 / 0.00
AVERAGE TO MINIMUM FC RATIO	0.30 / 0.00

LUMINAIRE SCHEDULE								
CALLOUT	SYMBOL	LAMP	DESCRIPTION	BALLAST	MOUNTING	MODEL	VOLTS	NOTE 1
LP-1		(1) /	Size 1 Viper w/ 80L Type IV-W Polished Acrylic Optics and 90° Shield Blocking Right Side of Distribution (when viewed from behind the pole)	ELECTRONIC	POLE	BEACON, VP-1-160L-75-3K7-4W-HSS-90-SR	120V 1P 2W	AC347-480V,50/60H2
								5

ALL LIGHTING FIXTURES WILL HAVE THE 4" DEEP VPR24 HSS-360-DBT SHIELDS ON ALL SIDES FOR FULL CUT-OFF. BUG RATING = B2-U0-G2



Dig Safely.

New York

Dig Safely and Dig Safely, New York are used under license from Dig Safe System, Inc.

Call Before You Dig

Wait The Required Time

Confirm Utility Response

Respect The Marks

Dig With Care

800-962-7962

www.digsafelynewyork.com

IT IS A VIOLATION OF NEW YORK STATE EDUCATION LAW FOR ANY PERSONS TO ALTER THESE PLANS, SPECIFICATIONS, OR REPORTS IN ANY WAY, UNLESS ACTING UNDER THE DIRECTION OF A LICENSED PROFESSIONAL ENGINEER OR LAND SURVEYOR.

Mark A. Day, PE	
05-03-24	
04-17-24	
03-19-24	
02-20-24	
01-24-24	
2021/288	License No. 069646

DAY STOKOSA
ENGINEERING P.C.

3 Van Wyck Lane
Wappingers Falls, New York
(845)-223-3202

PROJECT
Peekskill Firehouse Kitchen Incubator
701 Washington Street
City of Peekskill
Westchester County, New York

DRAWING		
Proposed Lighting Plan		
SCALE 1" = 20'	DRAWN BY MAD	LP.1
DATE 11-02-23	CHECKED BY MAD	