


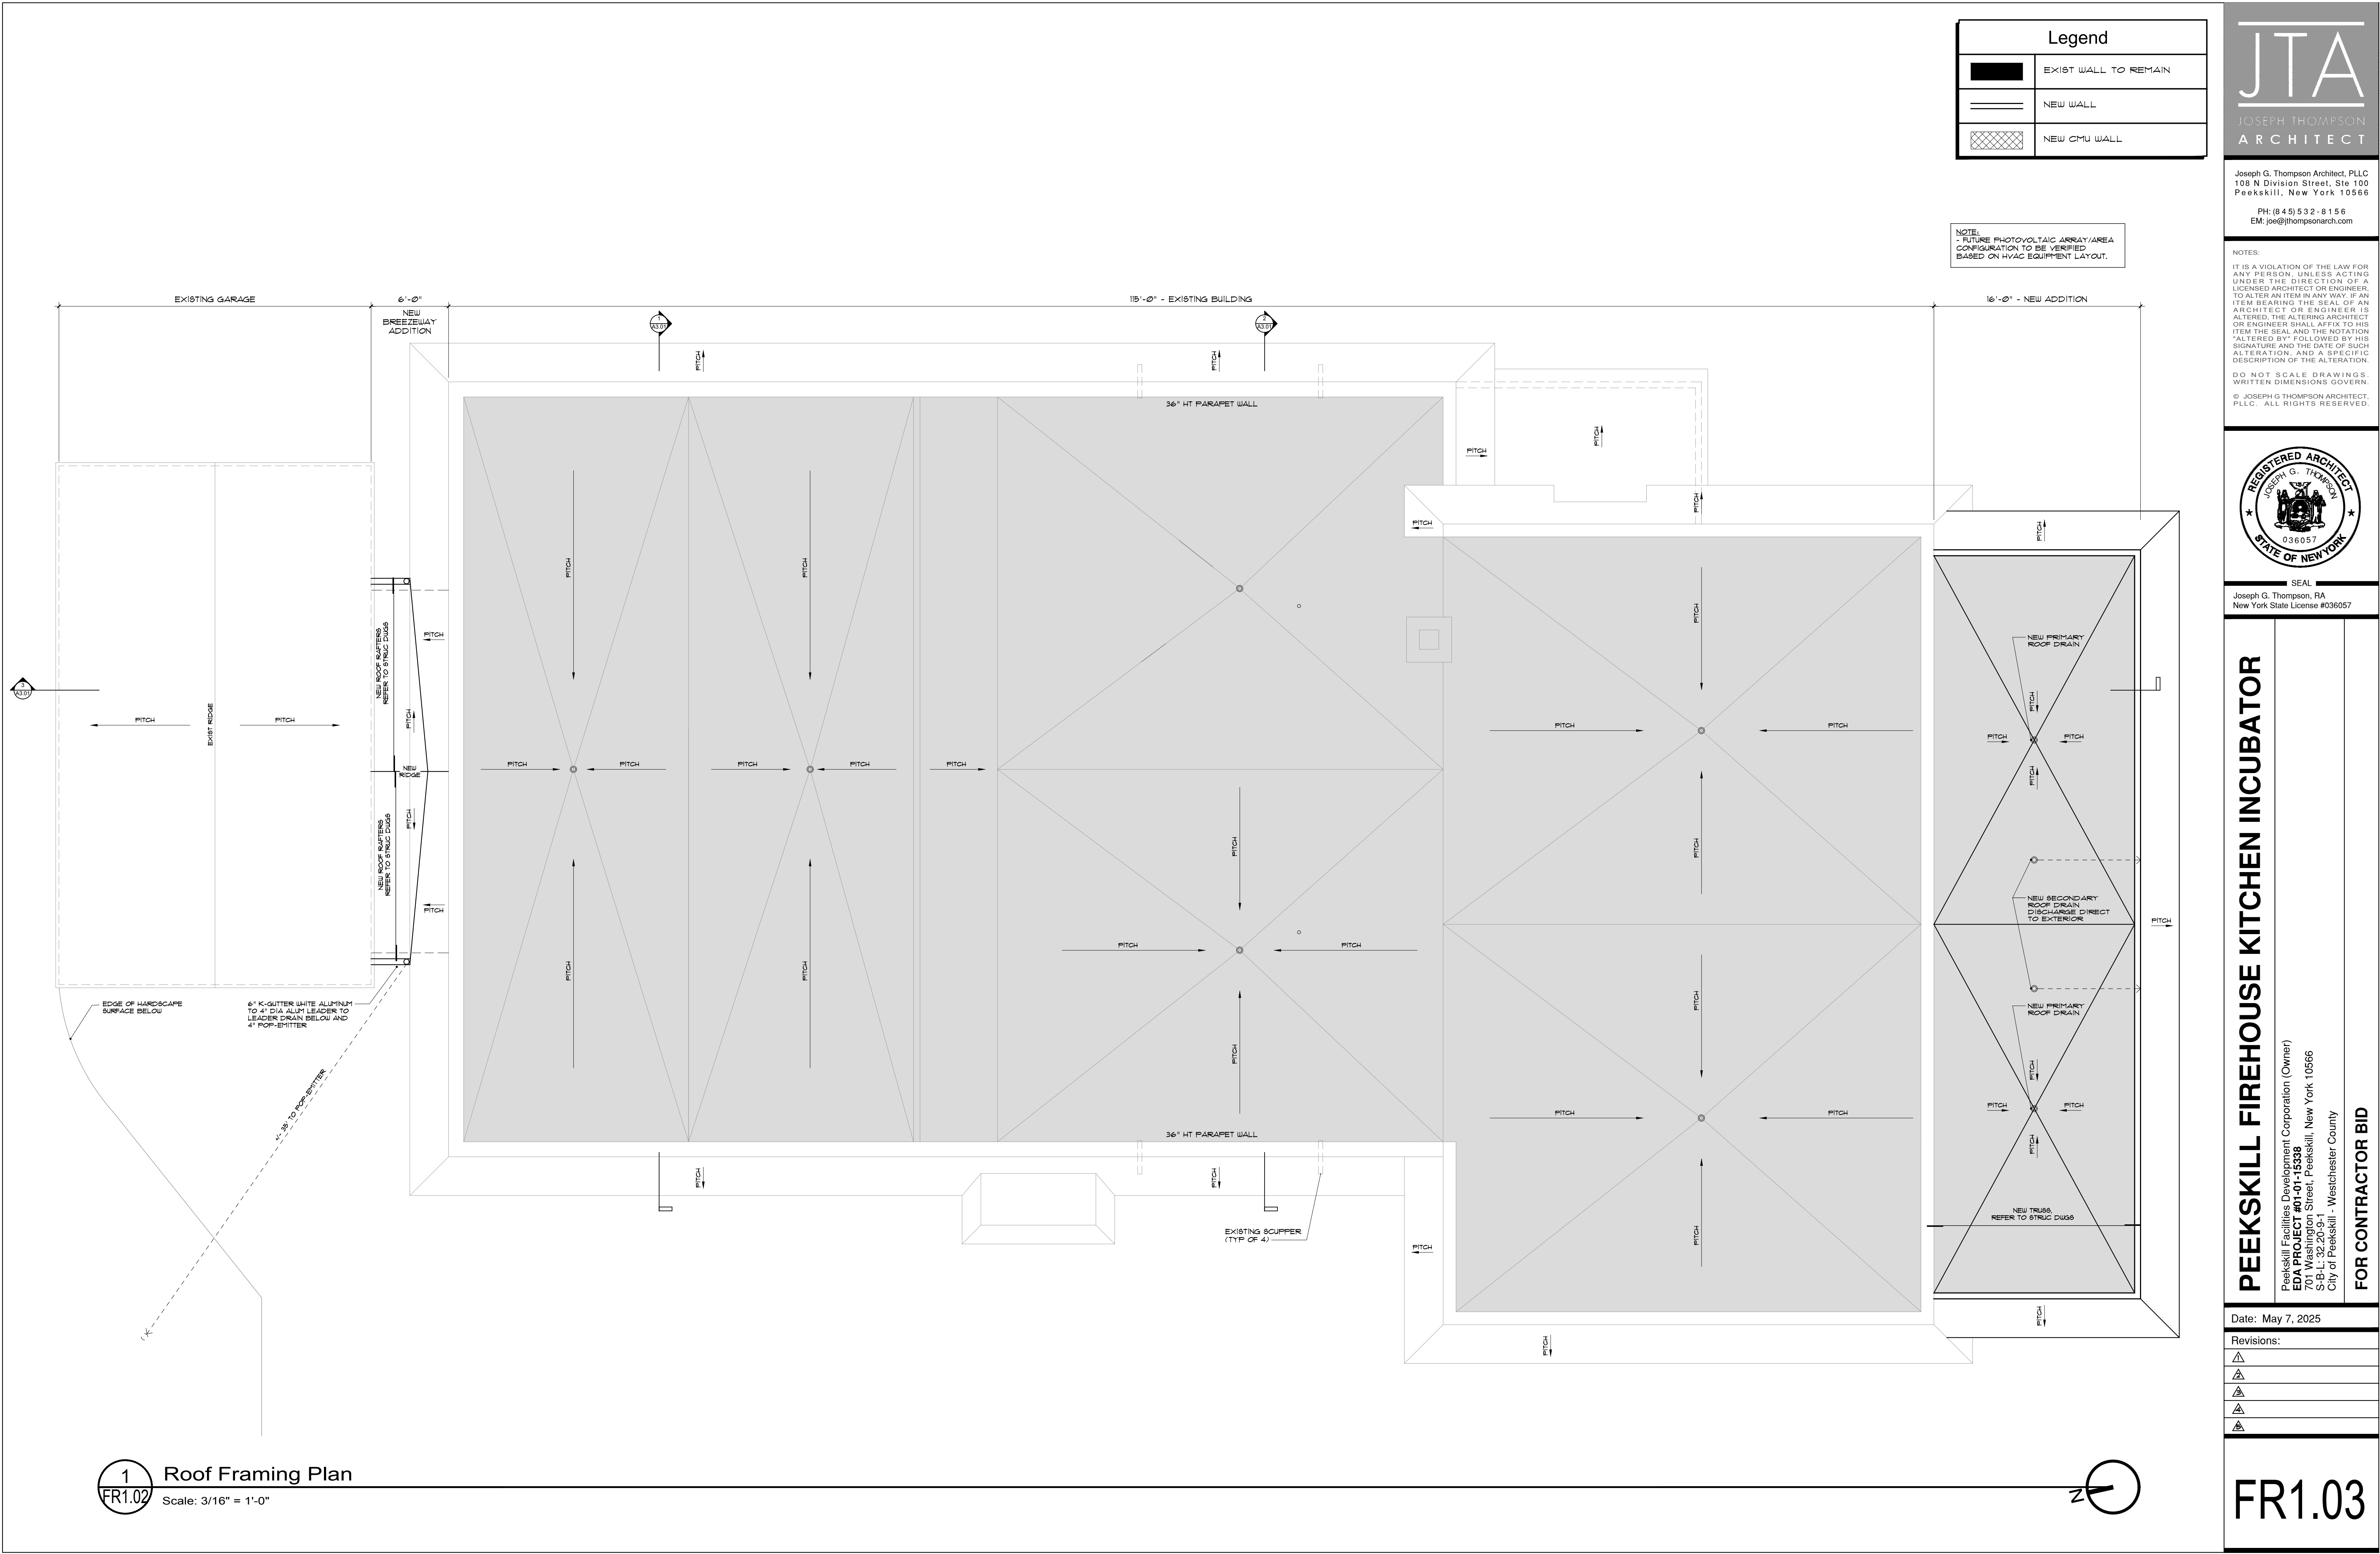

Legend	
	EXIST WALL TO REMAIN
	NEW WALL
	NEW CMU WALL

NOTE:
- FUTURE PHOTOVOLTAIC ARRAY/AREA
CONFIGURATION TO BE VERIFIED
BASED ON HVAC EQUIPMENT LAYOUT.

JTA

JOSEPH THOMPSON

ARCHITECT

Joseph G. Thompson Architect, PLLC
108 N Division Street, Ste 100
Peekskill, New York 10566

PH: (845) 532-8156
EM: joe@jthompsonarch.com

NOTES:
IT IS A VIOLATION OF THE LAW FOR ANY PERSON, UNLESS ACTING UNDER THE DIRECTION OF A LICENSED ARCHITECT OR ENGINEER, TO ALTER AN ITEM IN ANY WAY. IF AN ITEM BEARING THE SEAL OF AN ARCHITECT OR ENGINEER IS ALTERED, THE ALTERING ARCHITECT OR ENGINEER SHALL AFFIX TO HIS ITEM THE SEAL AND THE NOTATION ALTERED BY FOLLOWED BY HIS SIGNATURE AND THE DATE OF SUCH ALTERATION, AND A SPECIFIC DESCRIPTION OF THE ALTERATION.

DO NOT SCALE DRAWINGS. WRITTEN DIMENSIONS GOVERN.
© JOSEPH G THOMPSON ARCHITECT, PLLC. ALL RIGHTS RESERVED.

SEAL
Joseph G. Thompson, RA
New York State License #036057

PEEKSKILL FIREHOUSE KITCHEN INCUBATOR

Peekskill Facilities Development Corporation (Owner)
EDA PROJECT #01-01-15338
701 Washington Street, Peekskill, New York 10566
S-B-L: 32-20-9-1
City of Peekskill - Westchester County

FOR CONTRACTOR BID

Date: May 7, 2025

Revisions:

1	
2	
3	
4	
5	

1

FR1.02

Roof Framing Plan

Scale: 3/16" = 1'-0"

FR1.03