


1 Wall Section at New Breezeway Addition
A3.02 Scale: 1" = 1'-0"

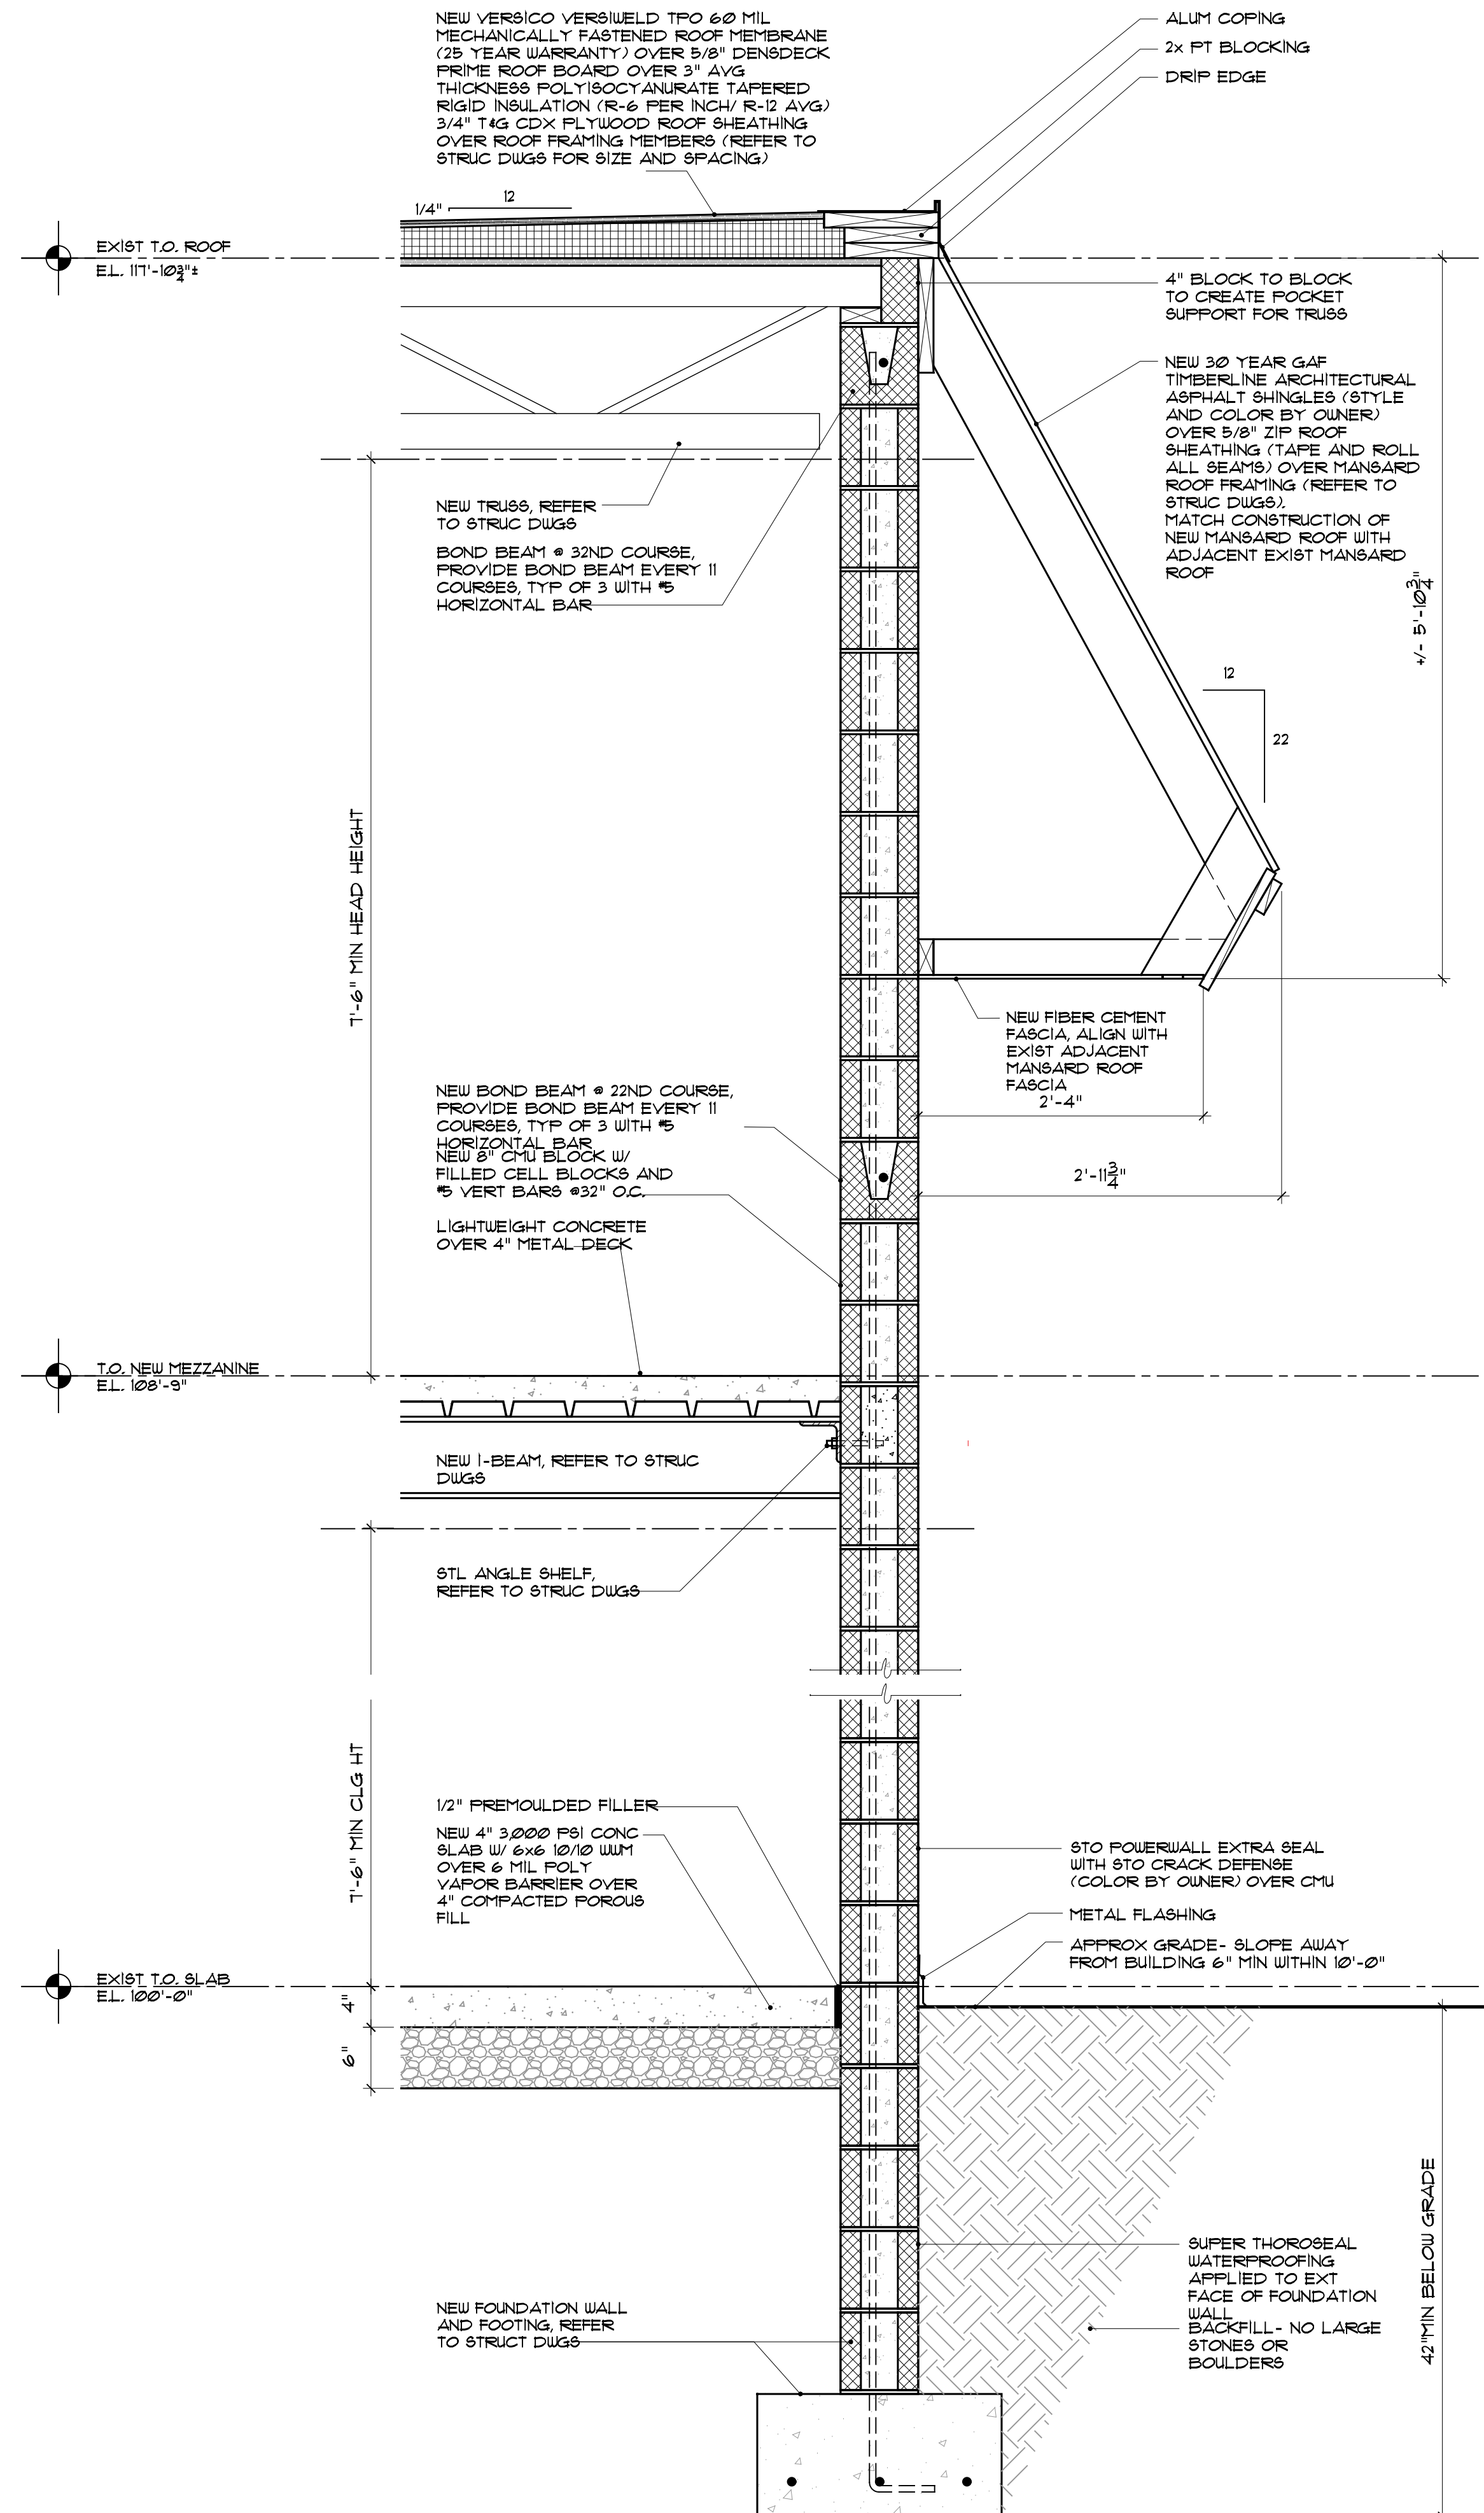

1 Wall Section at New Storage Addition
A3.03 Scale: 1" = 1'-0"

PEEKSKILL FIREHOUSE KITCHEN INCUBATOR

Peekskill Facilities Development Corporation (Owner)
EDA PROJECT #01-01-15338
701 Washington Street, Peekskill, New York 10566
S-B-L: 32-20-9-1
City of Peekskill - Westchester County

FOR CONTRACTOR BID

Date: May 7, 2025

Revisions:

1	
2	
3	
4	
5	