

NOTES:

IT IS A VIOLATION OF THE LAW FOR ANY PERSON, UNLESS ACTING UNDER THE DIRECTION OF A LICENSED ARCHITECT OR ENGINEER, TO ALTER AN ITEM IN ANY WAY. IF AN ITEM BEARING THE SEAL OF AN ARCHITECT OR ENGINEER IS ALTERED, THE ALTERING ARCHITECT OR ENGINEER SHALL AFFIX TO HIS ITEM THE SEAL AND THE NOTATION ALTERED BY FOLLOWED BY HIS SIGNATURE AND THE DATE OF SUCH ALTERATION, AND A SPECIFIC DESCRIPTION OF THE ALTERATION.

DO NOT SCALE DRAWINGS. WRITTEN DIMENSIONS GOVERN.

© JOSEPH G THOMPSON ARCHITECT, PLLC. ALL RIGHTS RESERVED.



SEAL
ERIC D. FELLENZER, P.E.
NY PROFESSIONAL ENGINEER
NO. 073044-1
ISSUED 1995 EXP. 8/25

PEEKSKILL FIREHOUSE KITCHEN INCUBATOR

City of Peekskill (Owner)
701 Washington Street
Peekskill, New York 10566
S-B-L: 32.20-9-1
City of Peekskill - Westchester County

DRAFT CONSTRUCTION DOCUMENT - NOT FOR PERMIT OR CONSTRUCTION

Date: September 17, 2024

Revisions:

UNAUTHORIZED ALTERATION OR ADDITION TO A PLAN BEARING A LICENSED PROFESSIONAL ENGINEER'S SEAL IS A VIOLATION OF SECTION 7209, SUB-DIVISION 2 OF THE N.Y. STATE EDUCATION LAW.
FELLENZER ENGINEERING, LLP
CERTIFICATE OF AUTHORIZATION #: 0017795


FELLENZER III
ENGINEERING LLP

www.fellp.com

22 Mulberry St., Suite 2A,
Middletown, NY 10940
t 845-343-1481 fx 845-343-4986

181 Church St., Suite 100,
Poughkeepsie, NY 12601
t 845-454-9704 fx 855-320-8735

DESIGNED BY: RW DRAWN BY: WPB APPROVED BY: EDF FE PROJECT #: 23-369

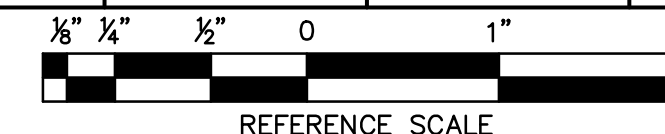

REFERENCE SCALE

1 HVAC: DEMOLITION FIRST FLOOR DUCTWORK PLAN


SCALE: 3/16"=1'-0"

DEMOLITION NOTE:

1. COORDINATE DEMOLITION, INCLUDING PATCHING, SEALING, AND REPAIR WORK, WITH ARCHITECTURAL WORK.

DEMOLITION KEYED NOTES:

- 1 DEMOLISH PTAC UNIT AND LOUVER. G.C. TO INFILL OPENING WITH BLOCK TO MATCH EXISTING. PATCH, SEAL AND REPAIR INTERIOR AND EXTERIOR WALLS TO MATCH EXISTING.
- 2 EXISTING THROUGH-WINDOW AIR CONDITIONER TO BE REMOVED. G.C. TO REMOVE EXTERIOR SUPPORTS IF PRESENT, THEN PATCH, SEAL, AND REPAIR TO MATCH EXISTING.
- 3 EXISTING DISHWASHER HOOD AND ASSOCIATED DUCTWORK TO BE REMOVED.
- 4 DEMOLISH PTAC UNIT AND LOUVER. CLEAN AND PREPARE OPENING TO RECEIVE NEW LOUVER AND UNIT.
- 5 DEMOLISH FAN AND CONTROLS. G.C. TO INFILL OPENING TO MATCH EXISTING. PATCH, SEAL AND REPAIR INTERIOR AND EXTERIOR WALLS TO MATCH EXISTING.
- 6 REMOVE EXHAUST FAN AND DUCTWORK BACK TO COMMON EXHAUST DUCT TO ROOF. PATCH AND SEAL COMMON DUCT FOR AIR-TIGHT OPERATION OF
- 7 REMAINING FANS BEING REPLACED. REMOVE THERMOSTAT AND CONTROL WIRING IN THEIR ENTIRETY.
- 8 REMOVE EXHAUST FAN AND DUCTWORK BACK TO COMMON EXHAUST DUCT TO ROOF. PREPARE OPENING TO RECEIVE NEW DUCTWORK FROM NEW EXHAUST FAN.
- 9 REMOVE FLUE/BREECHING DUCTING BACK TO CHIMNEY OPENING. GC TO PATCH AND REPAIR OPENING TO RECEIVE NEW FLUE.

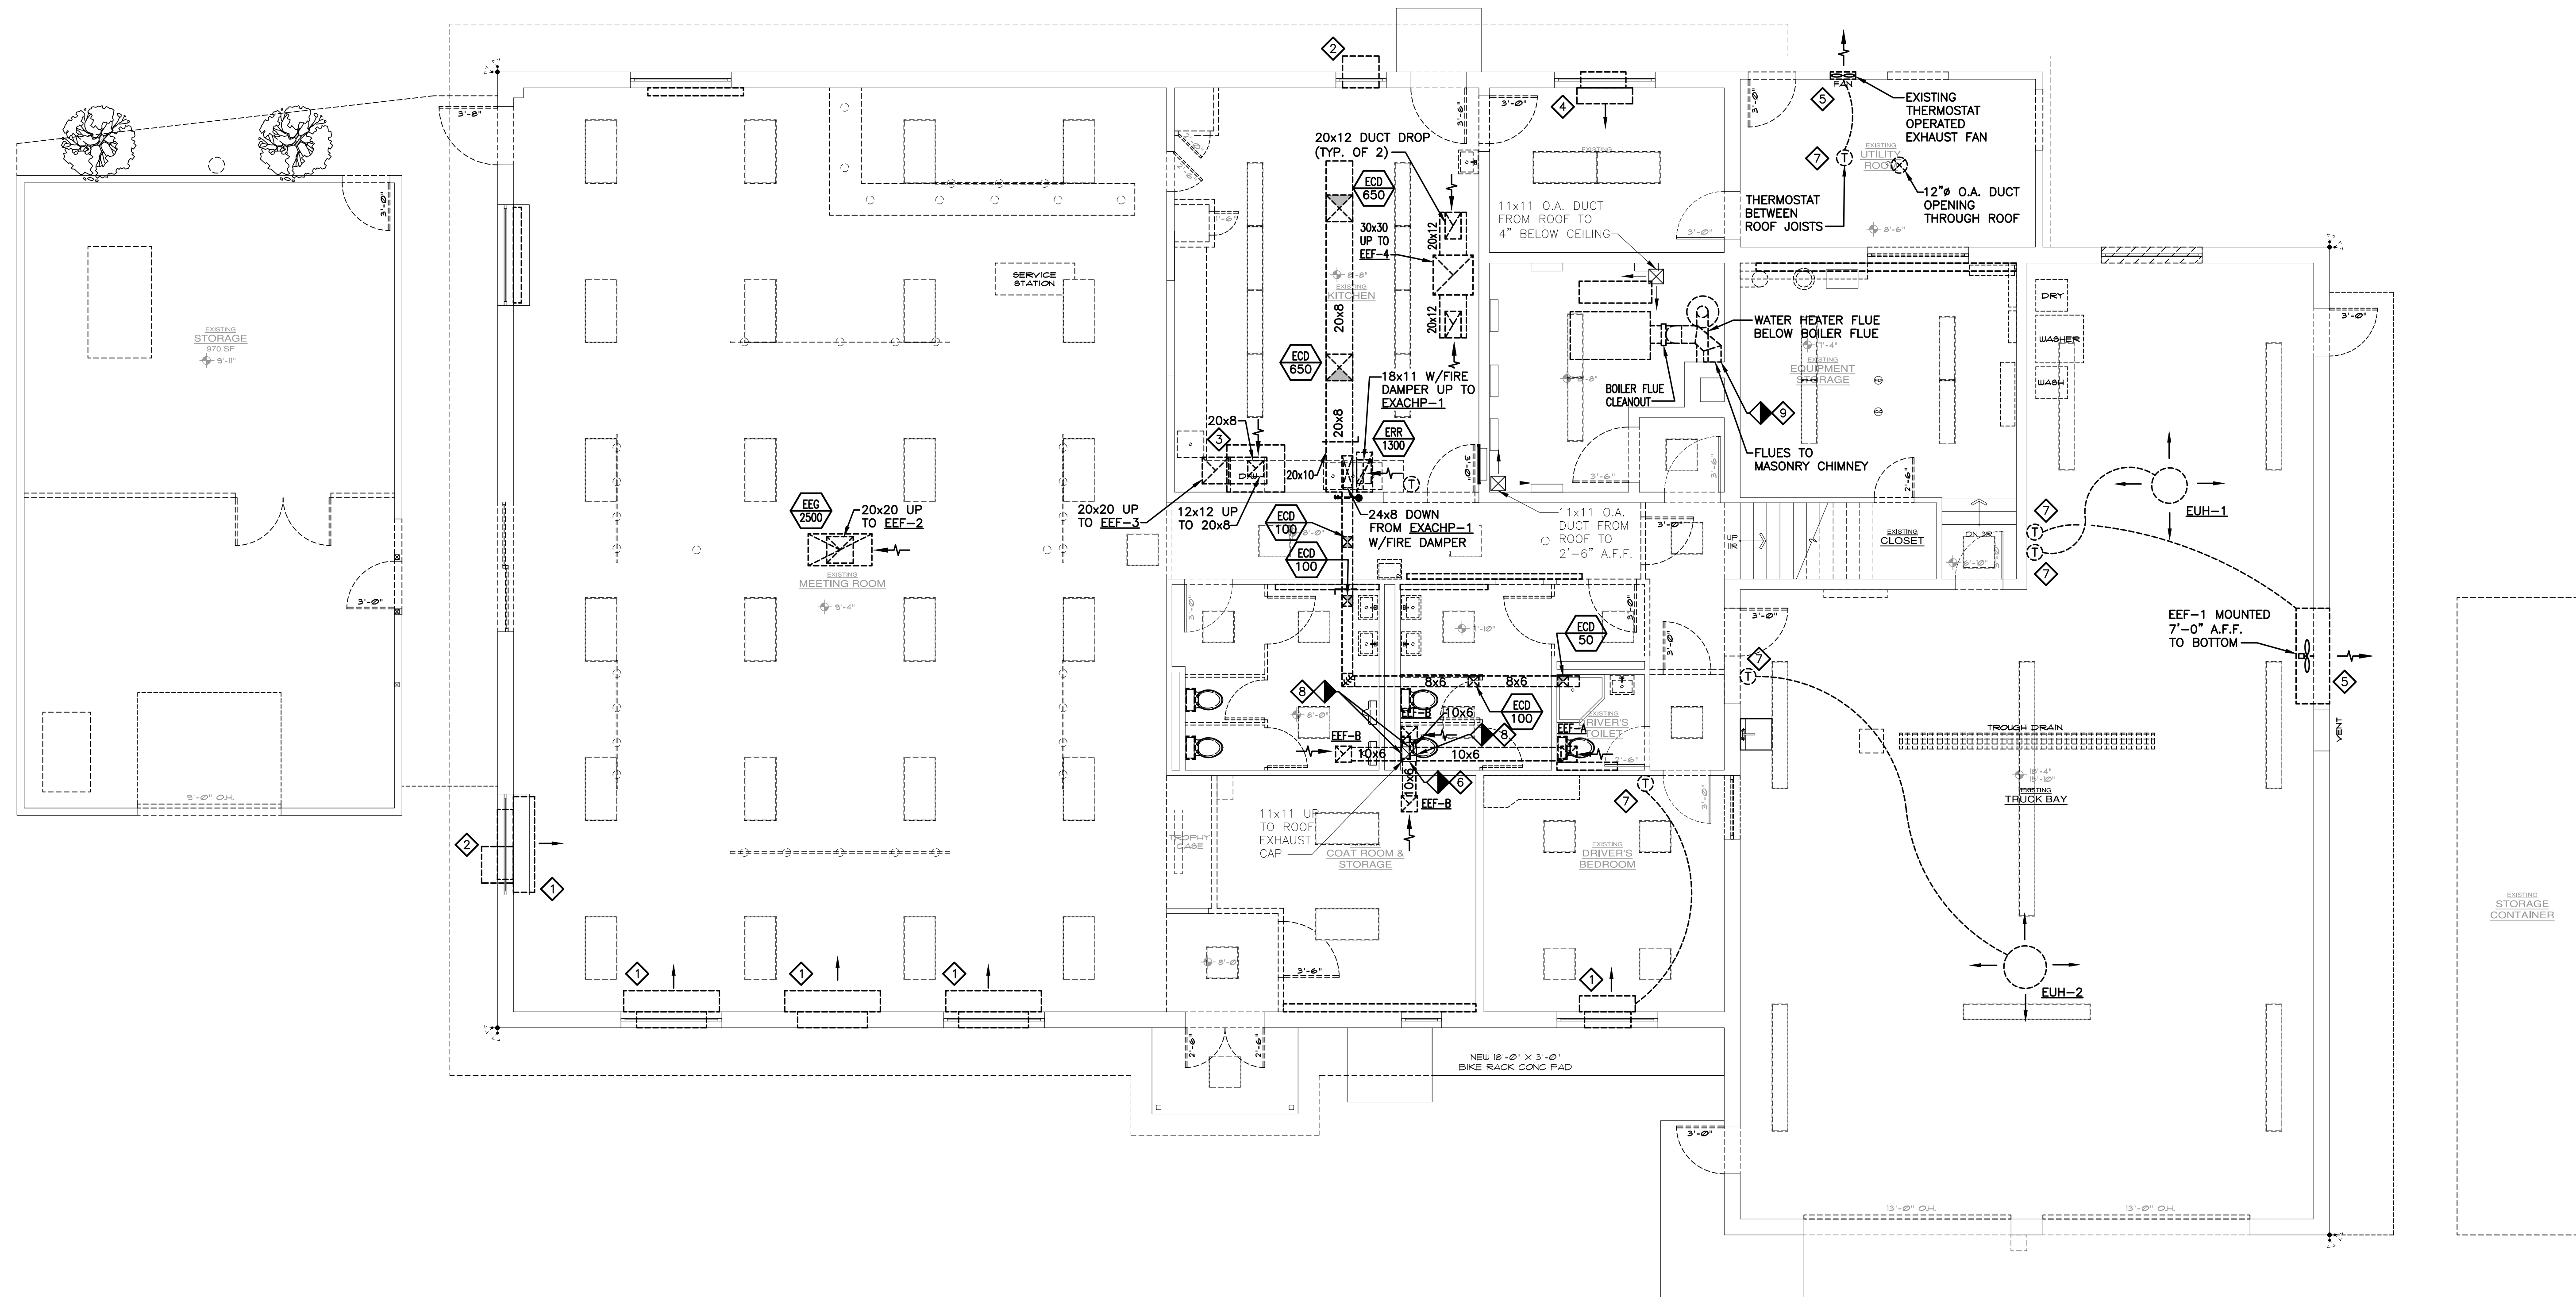

HD1.01