


LOOMIS AVENUE

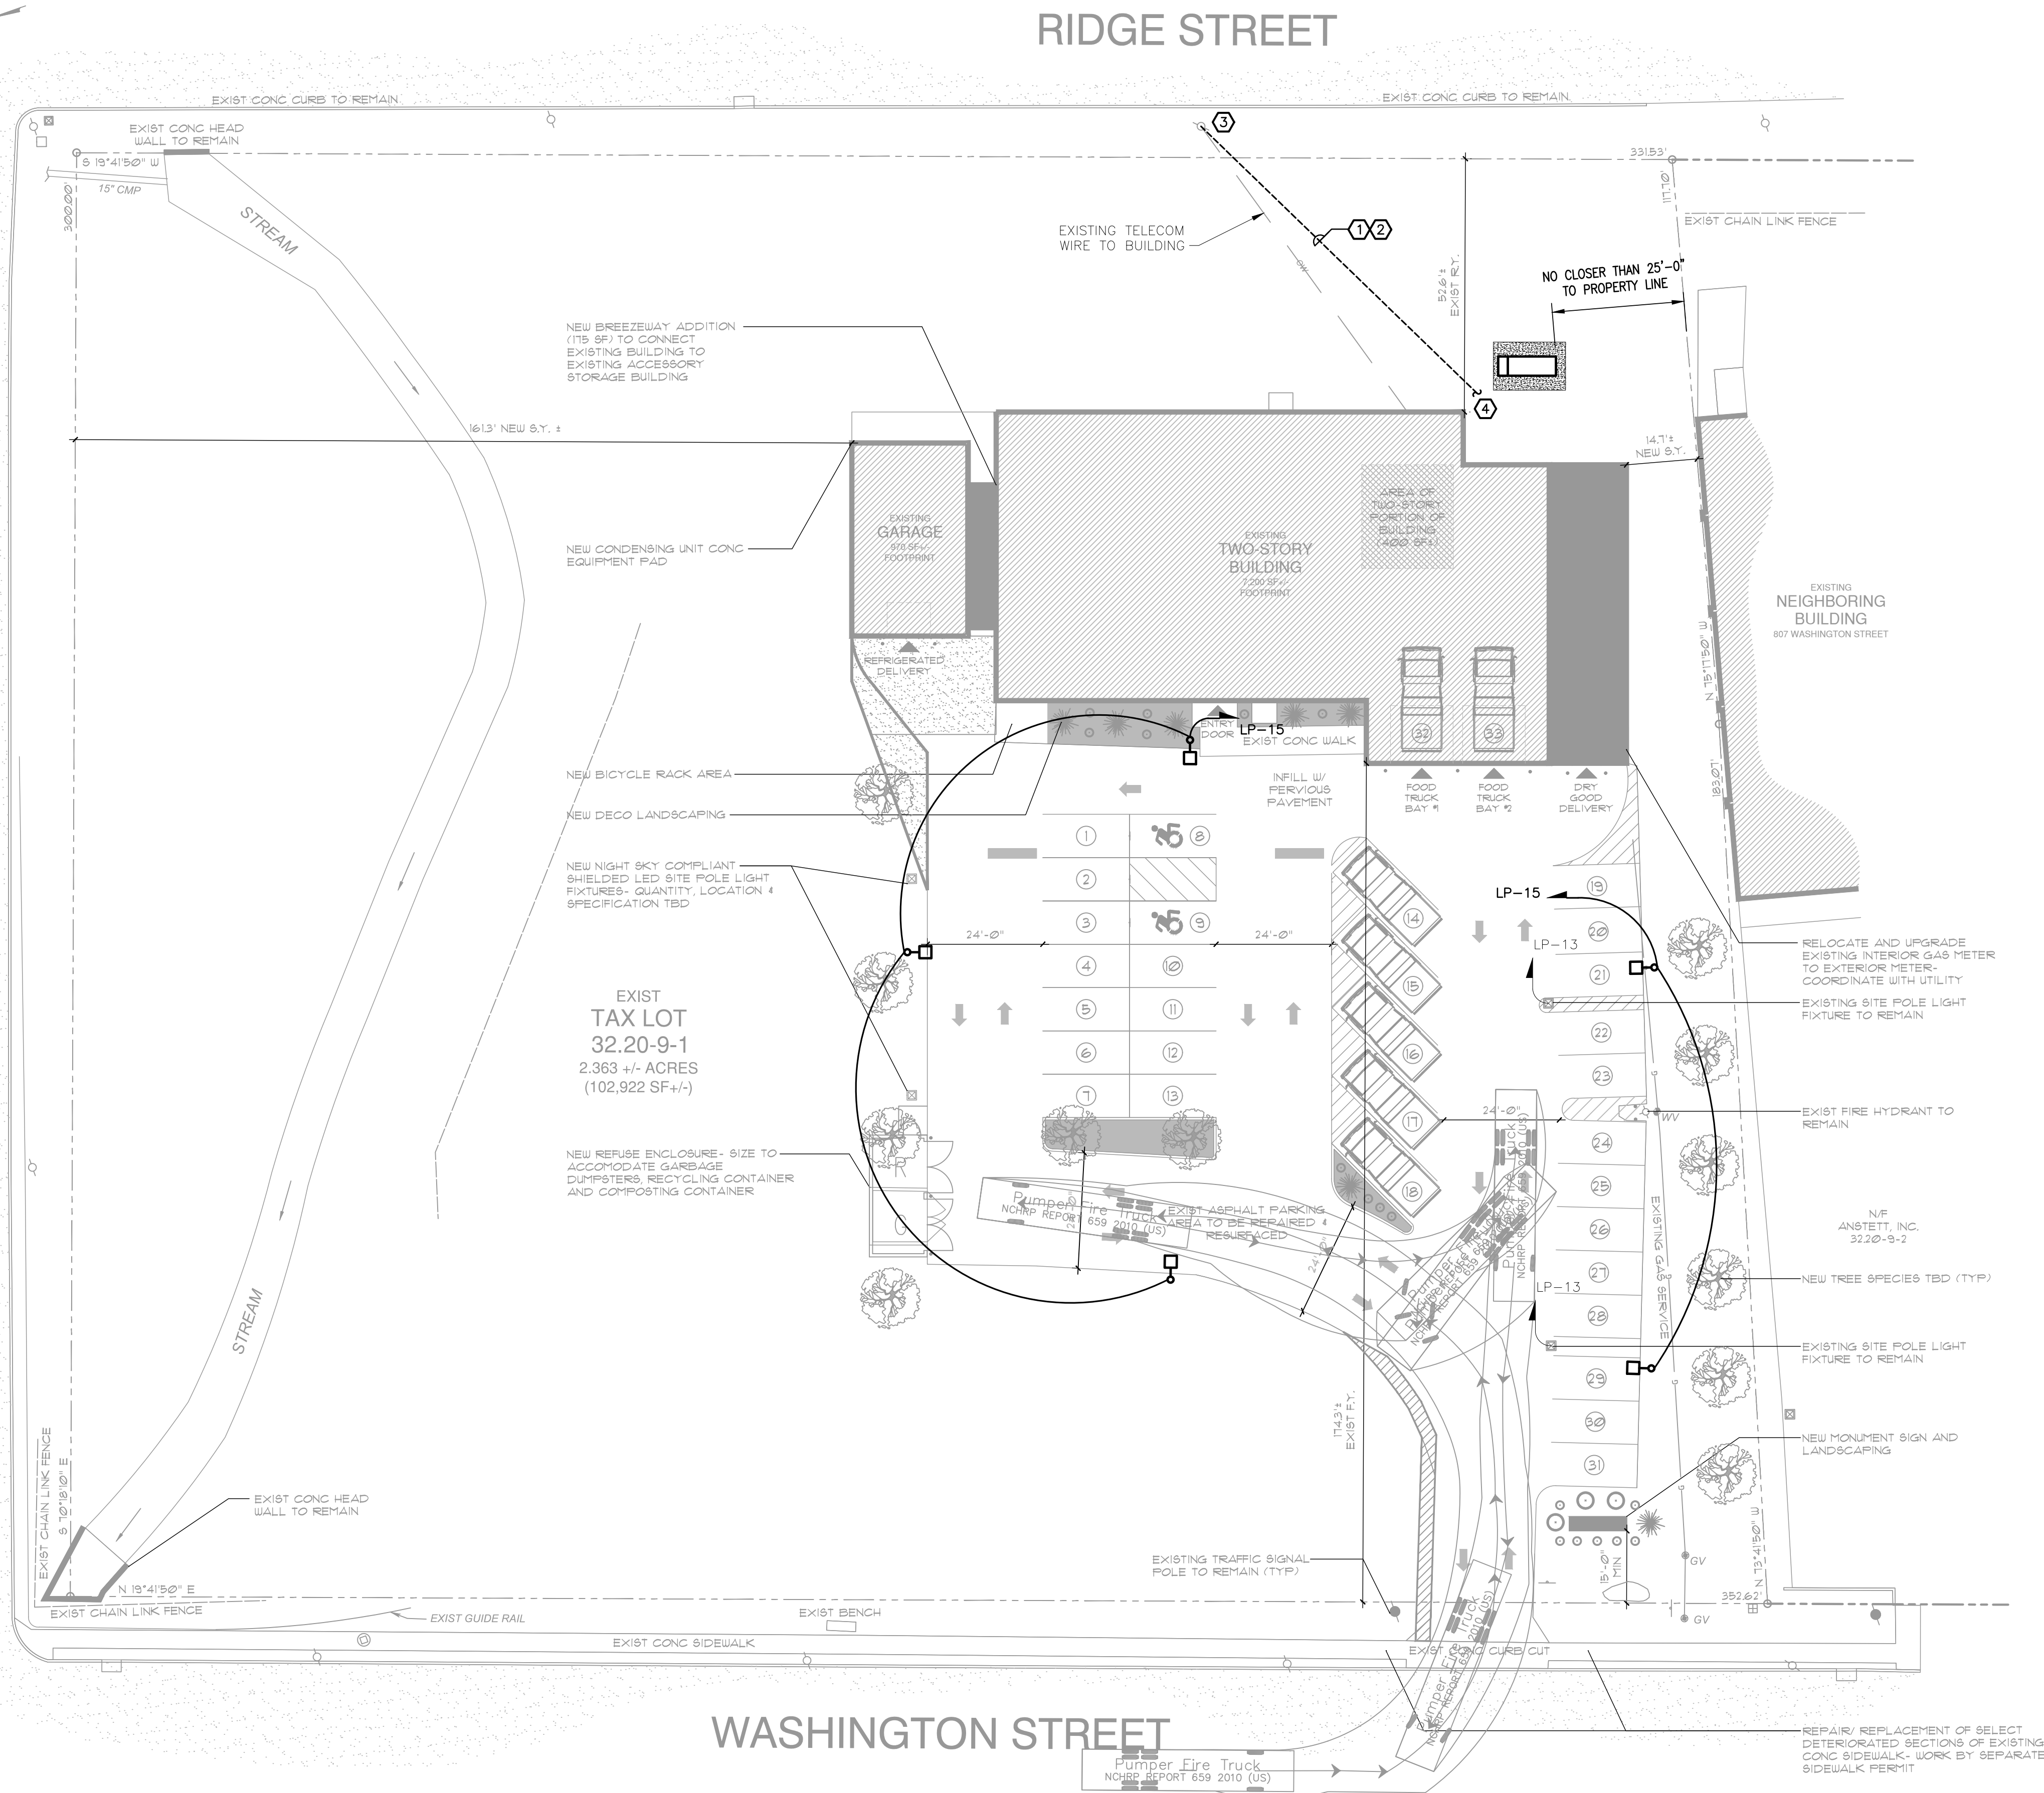


WASHINGTON STREET

NEW WORK KEYED NOTES:

- CONDUIT RUN BELOW GRADE.
- (4) SETS OF (3) 3/0 IN (1) 4" CONDUIT.
- PROVIDE NEW CONDUIT AT UTILITY POLE. RUN CABLES WITH SUFFICIENT SLACK FOR UTILITY COMPANY TO MAKE FINAL CONNECTIONS.
- SEE E-101 FOR CONTINUATION.

1 ELECTRICAL: SITE LIGHTING PLAN
SCALE: 1"=20'

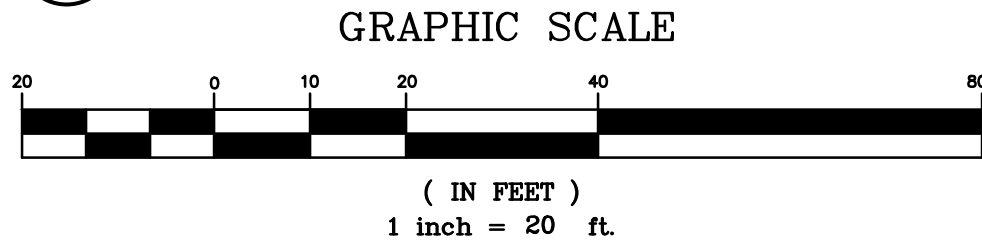

SITE NOTE:

- SIZE WIRES & CONDUITS FOR SITE LIGHTING BASED ON NEC GUIDELINES WITH NO MORE THAN 3% VOLTAGE DROP FROM PANEL TO FURTHEST FIXTURE.



NOTE: CONTRACTOR SHALL MARK OUT AND LOCATE ALL UNDERGROUND UTILITIES AND STRUCTURES ON THE PREMISES. NO ADDITIONAL COMPENSATION SHALL BE PROVIDED FOR ALTERATIONS TO DESIGN PLANS DUE TO LACK OF LOCATING. CONTRACTOR SHALL BE RESPONSIBLE FOR PAYING FOR RE-LOCATING OR DAMAGES RESULTING FROM LACK OF LOCATING.

UNAUTHORIZED ALTERATION OR ADDITION TO A PLAN BEARING A LICENSED PROFESSIONAL ENGINEER'S SEAL IS A VIOLATION OF SECTION 7209, SUB-DIVISION 2 OF THE N.Y. STATE EDUCATION LAW. FELLENER ENGINEERING, LLP CERTIFICATE OF AUTHORIZATION #: 0017795


FELLENER ENGINEERING LLP

www.fellp.com

22 Mulberry St., Suite 2A,
Middletown, NY 10940
t 845-343-1481 fx 845-343-4986

181 Church St., Suite 100,
Poughkeepsie, NY 12601
t 845-454-9704 fx 855-320-8735

DESIGNED BY: RW DRAWN BY: JCL APPROVED BY: EDF FE PROJECT #: 23-369

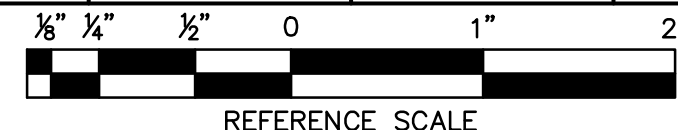

PEEKSKILL FIREHOUSE KITCHEN INCUBATOR

City of Peekskill (Owner)
701 Washington Street
Peekskill, New York 10566
S-B-L: 32.20-9-1
City of Peekskill - Westchester County

DRAFT CONSTRUCTION DOCUMENT - NOT FOR PERMIT OR CONSTRUCTION

Date: September 17, 2024

Revisions:

ES1.01

JTA
JOSEPH THOMPSON
ARCHITECT

Joseph G. Thompson Architect, PLLC
108 N Division Street, Ste 100
Peekskill, New York 10566
PH: (845) 532-8156
EM: joe@jthompsonarch.com

NOTES:

IT IS A VIOLATION OF THE LAW FOR ANY PERSON, UNLESS ACTING UNDER THE DIRECTION OF A LICENSED ARCHITECT OR ENGINEER, TO ALTER AN ITEM IN ANY WAY, IF AN ITEM BEARING THE SEAL OF AN ARCHITECT OR ENGINEER IS ALTERED. THE ALTERING ARCHITECT OR ENGINEER SHALL AFFIX TO HIS ITEM THE SEAL AND THE NOTATION ALTERED BY FOLLOWED BY HIS SIGNATURE AND THE DATE OF SUCH ALTERATION, AND A SPECIFIC DESCRIPTION OF THE ALTERATION.

DO NOT SCALE DRAWINGS. WRITTEN DIMENSIONS GOVERN.
© JOSEPH G THOMPSON ARCHITECT, PLLC. ALL RIGHTS RESERVED.



SEAL
ERIC D. FELLENER, P.E.
NY PROFESSIONAL ENGINEER
NO. 073084-1
ISSUED 1995 EXP. 8/25