


File Name: F:\2023\23-389 Peekskill Firehouse Kitchen Incubator\ELECTRICAL\ED1.01 & E1.01 (FIRST FLOOR POWER).dwg (Layout: ED1.01)
Date: Tue, Sep 17, 2024 - 10:10 AM (Name: wpb)

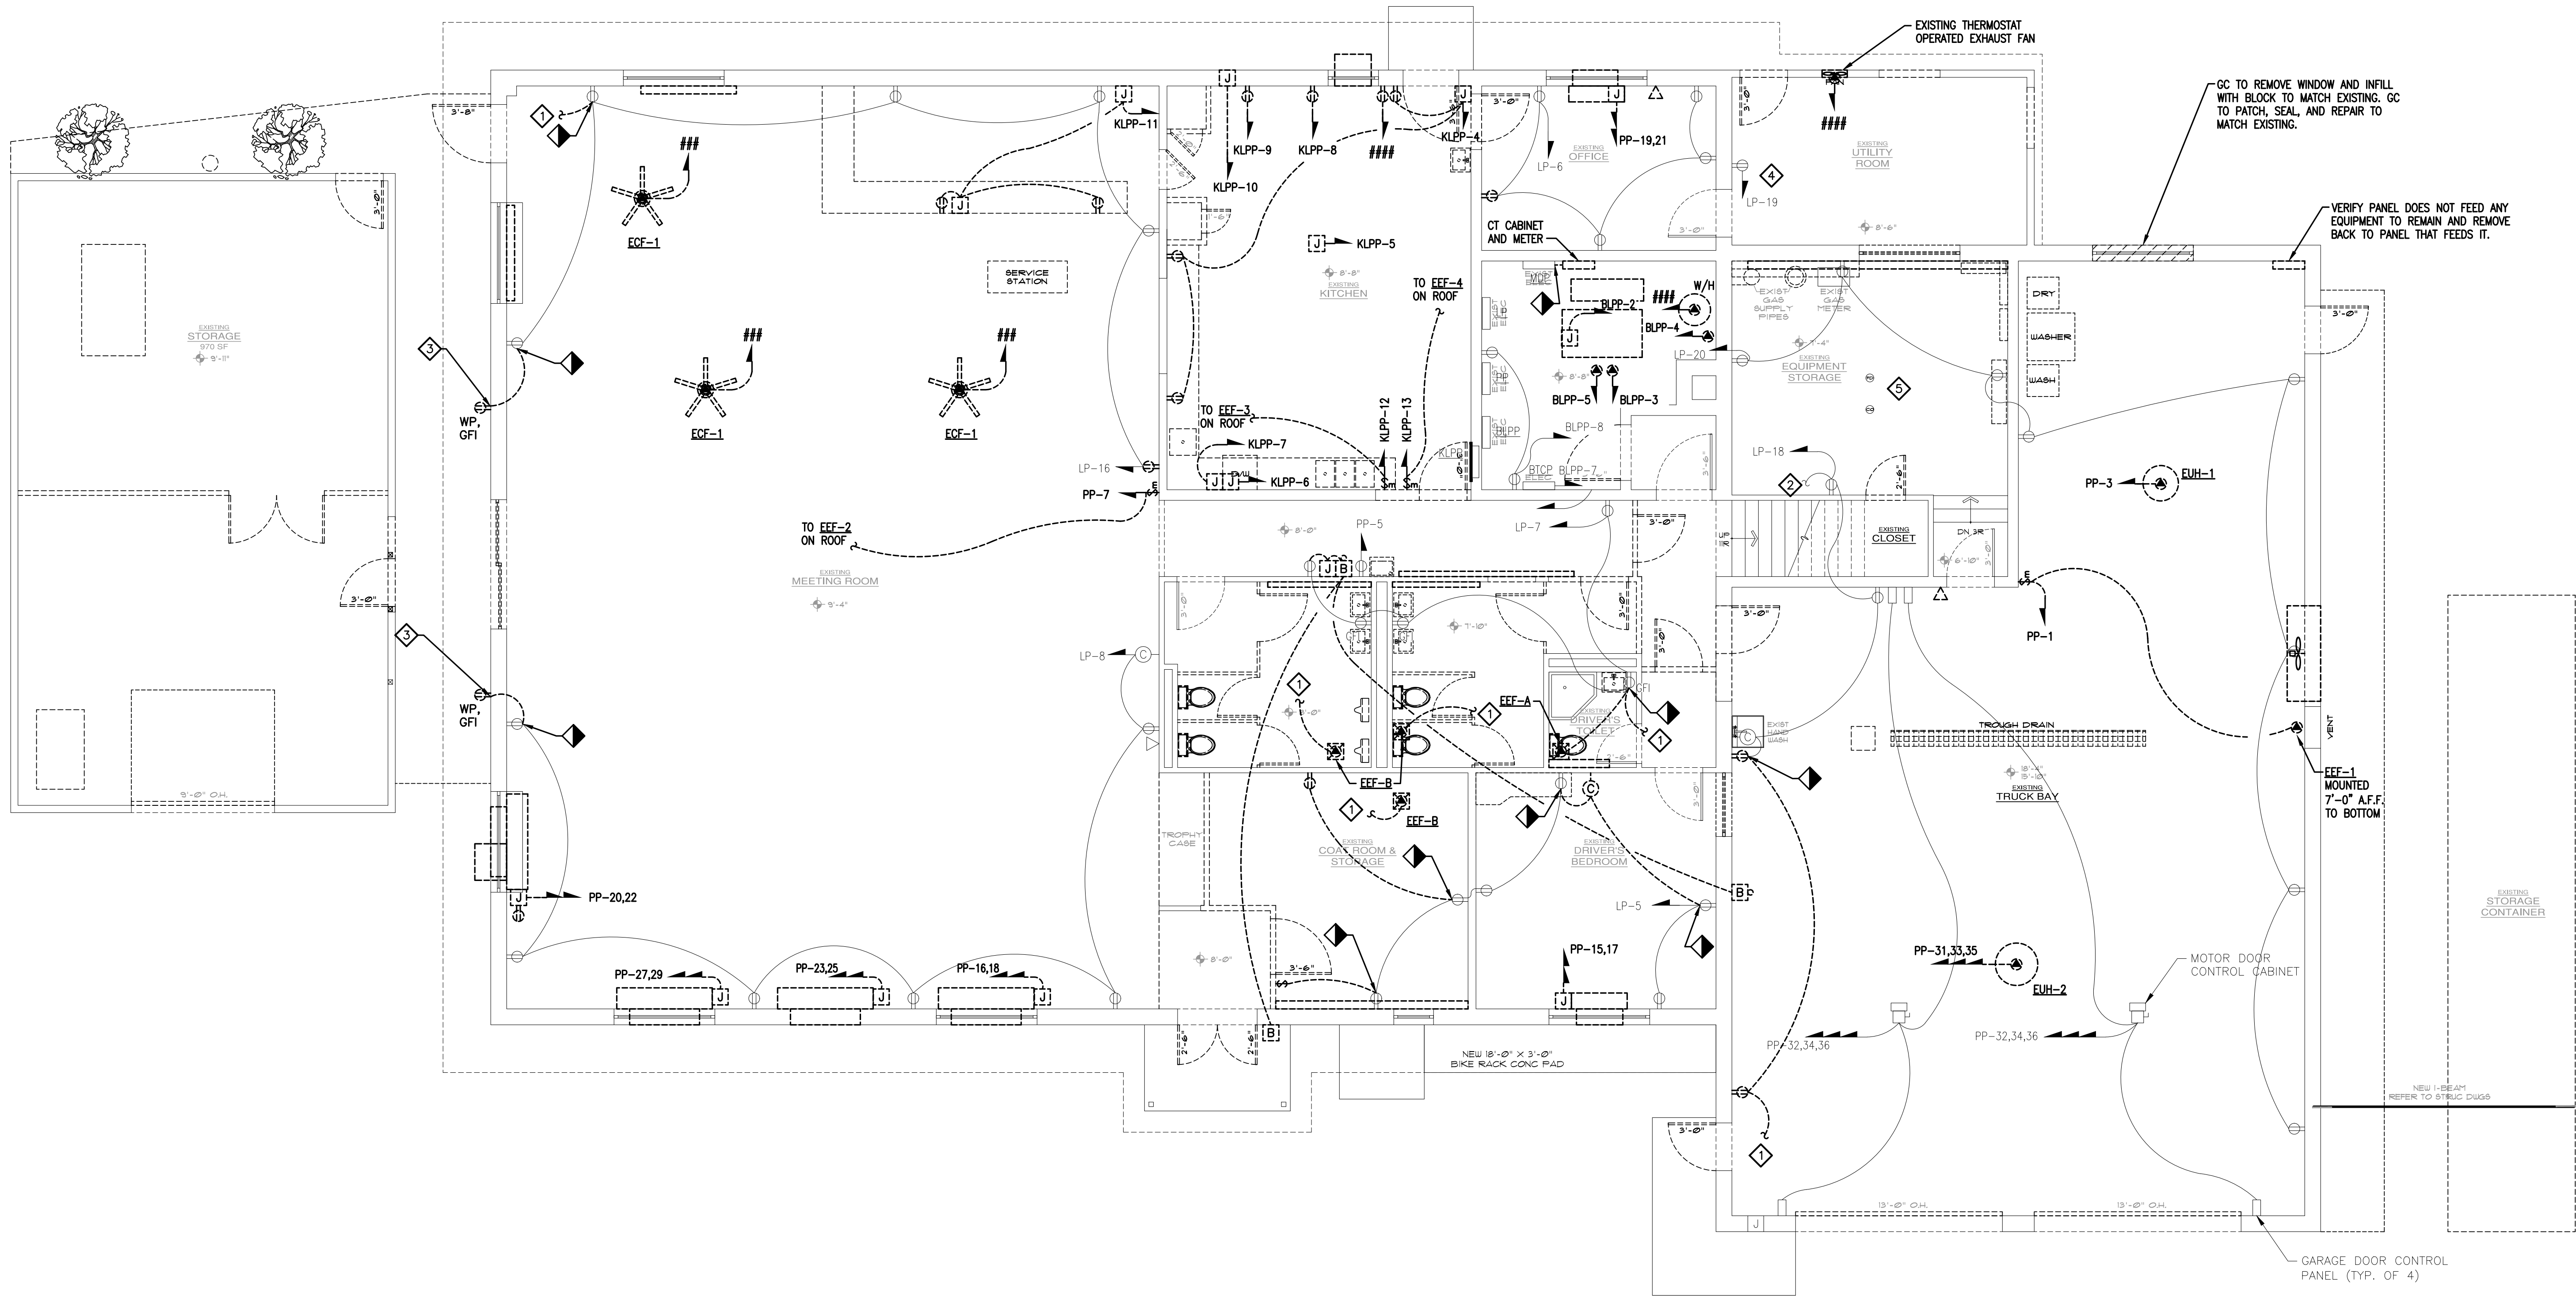

1 ELECTRICAL: DEMOLITION FIRST FLOOR POWER PLAN
SCALE: 3/16"=1'-0"

DEMOLITION KEYED NOTES:

- SEE ED2.01 FOR CONTINUATION.
- TO 2ND FLOOR RECEPTACLES.
- REMOVE EXTERIOR-GRADE RECEPTACLE.
- RECEPTACLE ON UNKNOWN CIRCUIT TO REMAIN. CONTRACTOR TO TRACE LINE BACK TO PANEL & UPDATE CIRCUIT REGISTRY TO CIRCUIT INDICATED
- REMOVE ALL TELECOM CABLES, OUTLETS, AND BOXES IN THIS ROOM BACK TO THEIR ENTRANCE TO THE BUILDING. PREPARE ENTRANCE FOR CONNECTION TO NEW.

DEMOLITION NOTES:

- DEMOLISH ALL RECEPTACLES AND CIRCUITS MARKED AS DEMO BACK TO PANEL. G.C. TO PATCH, SEAL, AND REPAIR WALLS, FLOORS, AND CEILINGS TO MATCH EXISTING.
- DEMOLISH ALL TELECOM CABLES AND OUTLETS BACK TO ENTRANCE TO BUILDING. G.C. TO PATCH, SEAL, AND REPAIR WALLS, FLOORS, AND CEILINGS TO MATCH EXISTING.



NOTE: CONTRACTOR SHALL MARK OUT AND LOCATE ALL UNDERGROUND UTILITIES AND STRUCTURES ON THE PREMISES. NO ADDITIONAL COMPENSATION SHALL BE PROVIDED FOR ALTERATIONS TO DESIGN PLANS DUE TO LACK OF LOCATING. CONTRACTOR SHALL BE RESPONSIBLE FOR PAYING FOR RE-LOCATING OR DAMAGES RESULTING FROM LACK OF LOCATING.


UNAUTHORIZED ALTERATION OR ADDITION TO A PLAN BEARING A LICENSED PROFESSIONAL ENGINEER'S SEAL IS A VIOLATION OF SECTION 7209, SUB-DIVISION 2 OF THE N.Y. STATE EDUCATION LAW. FELLENGER ENGINEERING, LLP CERTIFICATE OF AUTHORIZATION #: 0017795

FELLENGER ENGINEERING LLP
www.fellp.com

22 Mulberry St., Suite 2A, Middletown, NY 10940
t 845-343-1481 fx 845-343-4986

181 Church St., Suite 100, Poughkeepsie, NY 12601
t 845-454-9704 fx 855-320-8735

DESIGNED BY: RW
DRAWN BY: WPB
APPROVED BY: EDF
FE PROJECT #: 23-369

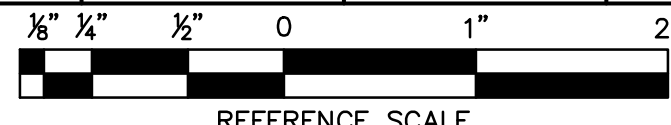

PEEKSKILL FIREHOUSE KITCHEN INCUBATOR

City of Peekskill (Owner)
701 Washington Street
Peekskill, New York 10566
S-B-L: 32.20-9-1
City of Peekskill - Westchester County

DRAFT CONSTRUCTION DOCUMENT - NOT FOR PERMIT OR CONSTRUCTION

JTA
JOSEPH THOMPSON
ARCHITECT

Joseph G. Thompson Architect, PLLC
108 N Division Street, Ste 100
Peekskill, New York 10566

PH: (845) 532-8156
EM: joe@jthompsonarch.com

NOTES:

IT IS A VIOLATION OF THE LAW FOR ANY PERSON, UNLESS ACTING UNDER THE DIRECTION OF A LICENSED ARCHITECT OR ENGINEER TO ALTER AN ITEM IN ANY WAY. IF AN ITEM BEARING THE SEAL OF AN ARCHITECT OR ENGINEER IS ALTERED, THE ALTERING ARCHITECT OR ENGINEER SHALL AFFIX TO HIS ITEM THE SEAL AND THE NOTATION ALTERED BY FOLLOWED BY HIS SIGNATURE AND THE DATE OF SUCH ALTERATION, AND A SPECIFIC DESCRIPTION OF THE ALTERATION.

DO NOT SCALE DRAWINGS. WRITTEN DIMENSIONS GOVERN.

© JOSEPH G THOMPSON ARCHITECT, PLLC. ALL RIGHTS RESERVED.



SEAL
ERIC D. FELLENGER, P.E.
NY PROFESSIONAL ENGINEER
NO. 073044-1
ISSUED 1995 EXP. 8/25

Date: September 17, 2024

Revisions:

ED1.01