


PEEKSKILL FIREHOUSE KITCHEN INCUBATOR

City of Peekskill (Owner)
701 Washington Street
Peekskill, New York 10566
S-B-L: 32.20.9-1
City of Peekskill - Westchester County

DRAFT CONSTRUCTION DOCUMENT - NOT FOR PERMIT OR CONSTRUCTION

Date: September 17, 2024

Revisions:

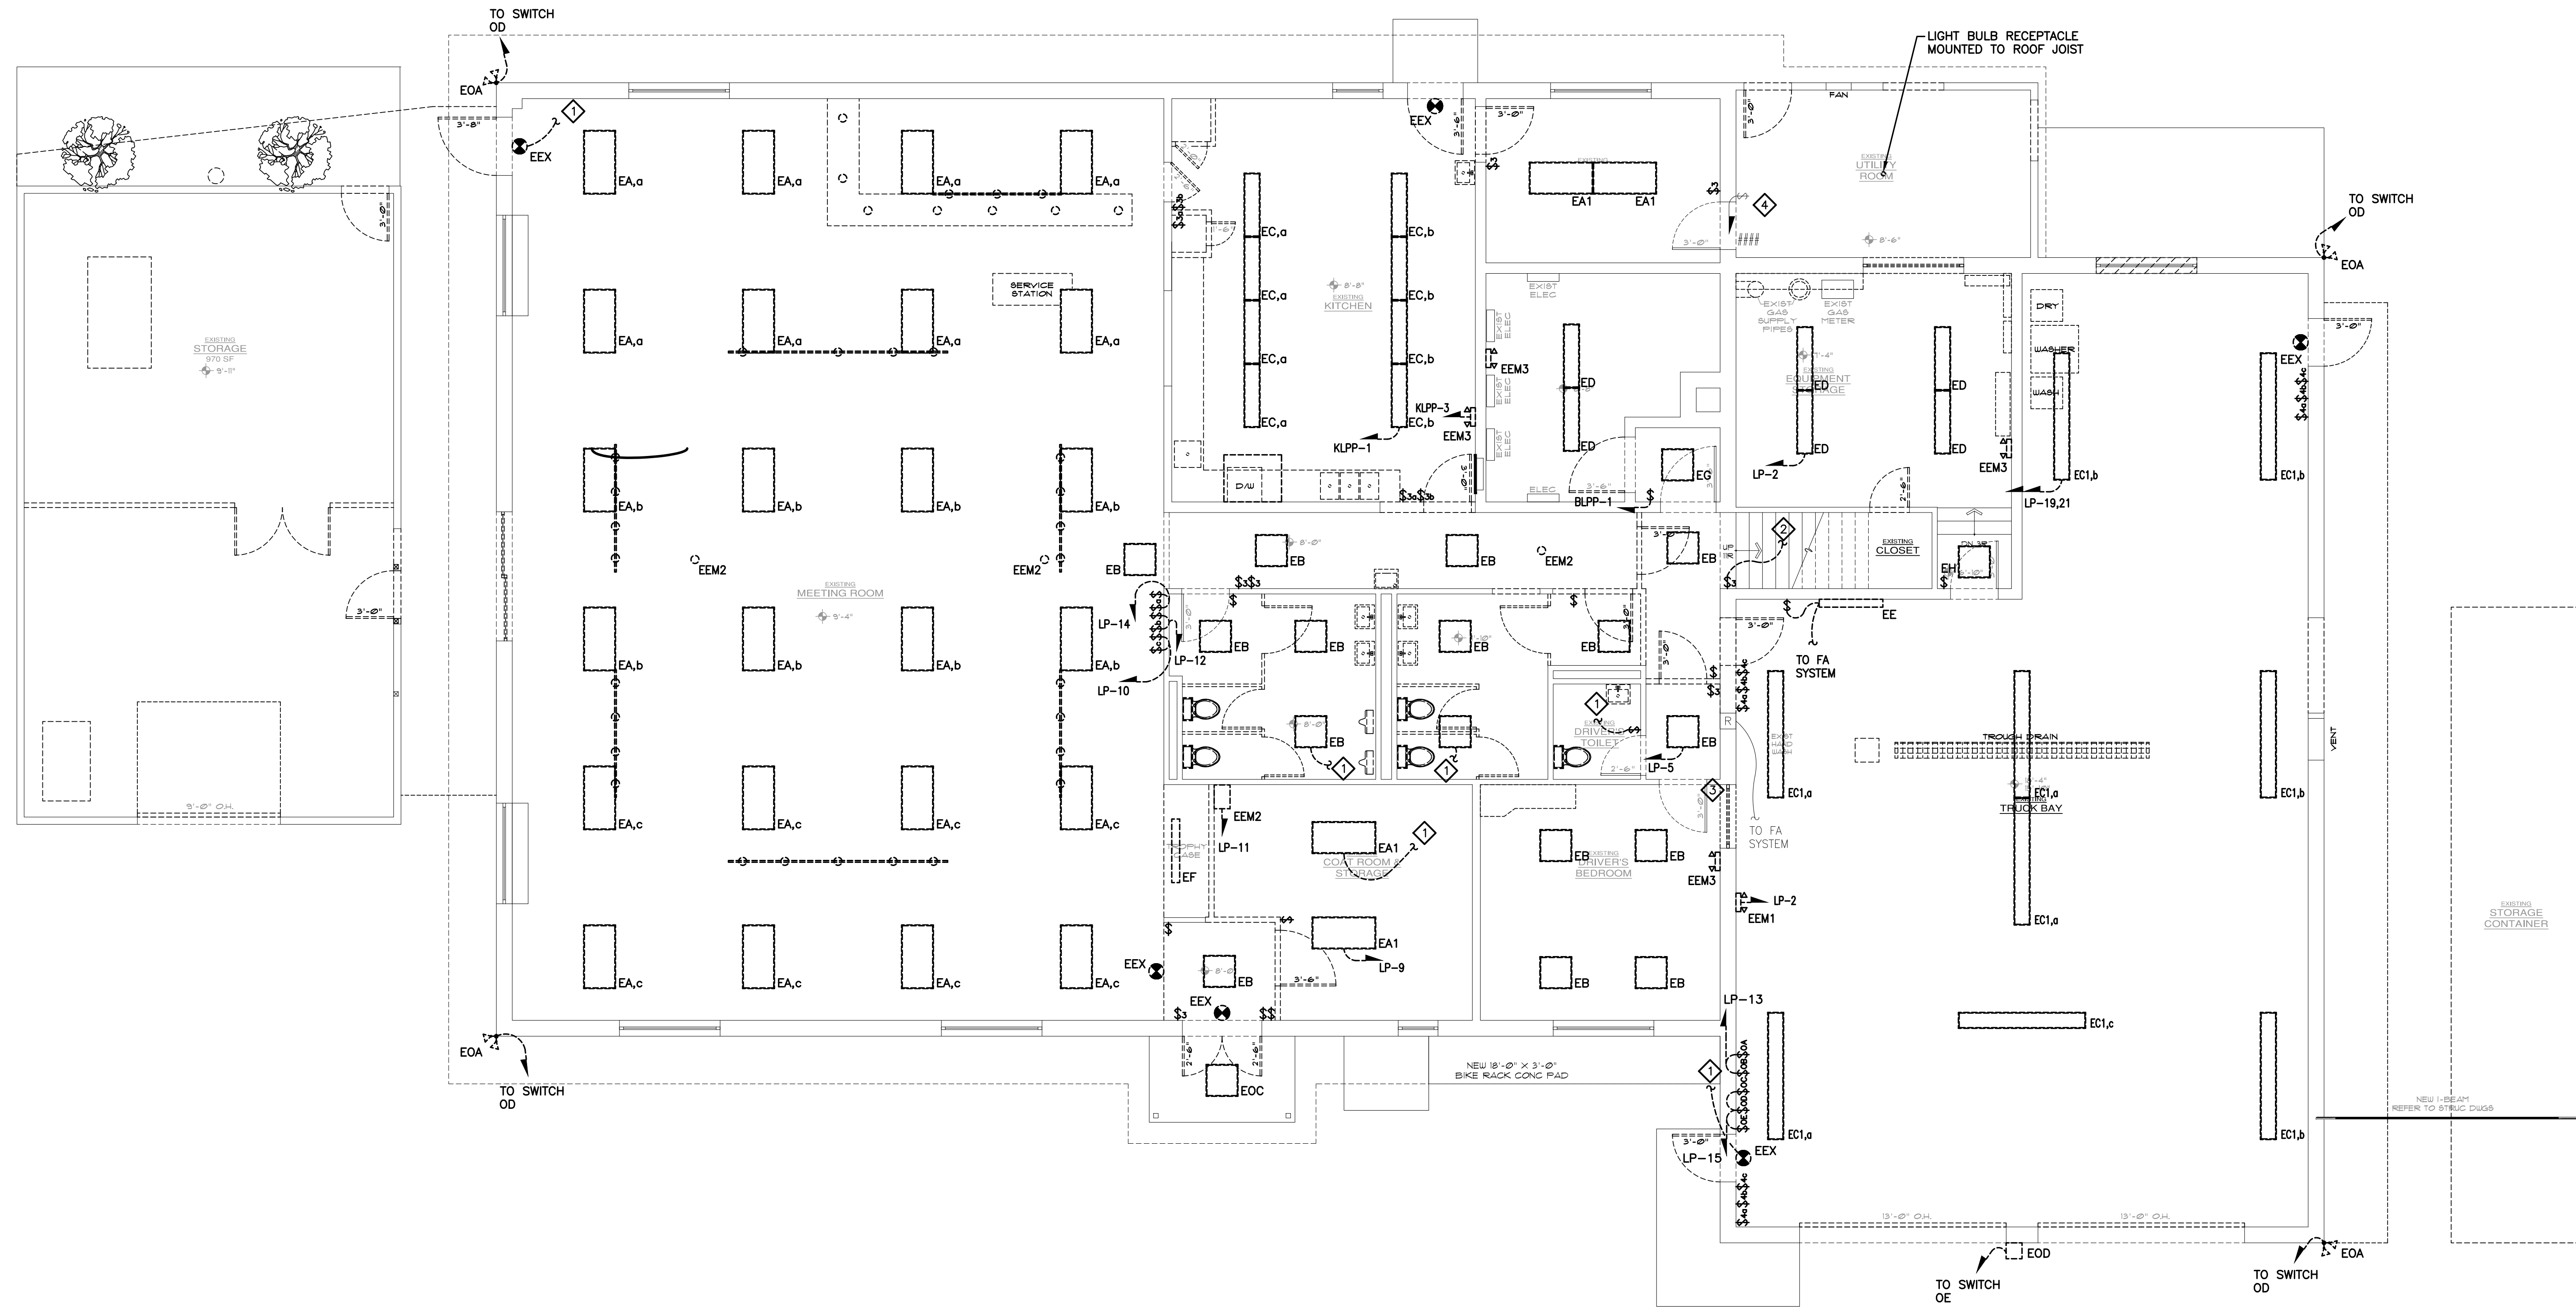

1 ELECTRICAL: DEMOLITION FIRST FLOOR LIGHTING & FIRE ALARM PLAN
SCALE: 3/16"=1'-0"

DEMOLITION KEYED NOTES:

- SEE ED1.01 FOR CONTINUATION.
- TO ED2.02 FOR CONTINUATION.
- REFER TO DETAIL 3/E7.01 FOR WIRING IN THIS AREA.
- LIGHT SWITCH ON UNKNOWN CIRCUIT TO REMAIN. CONTRACTOR TO TRACE LINE BACK TO PANEL & UPDATE CIRCUIT REGISTRY.

DEMOLITION NOTES:

- DEMOLISH ALL LIGHTING FIXTURES AND CIRCUITS MARKED AS DEMO BACK TO PANEL.
- REMOVE EXISTING FIRE ALARM SYSTEM IN ITS ENTIRETY.



NOTE: CONTRACTOR SHALL MARK OUT AND LOCATE ALL UNDERGROUND UTILITIES AND STRUCTURES ON THE PREMISES. NO ADDITIONAL COMPENSATION SHALL BE PROVIDED FOR ALTERATIONS TO DESIGN PLANS DUE TO LACK OF LOCATING. CONTRACTOR SHALL BE RESPONSIBLE FOR PAYING FOR RE-LOCATING OR DAMAGES RESULTING FROM LACK OF LOCATING.

UNAUTHORIZED ALTERATION OR ADDITION TO A PLAN BEARING A LICENSED PROFESSIONAL ENGINEER'S SEAL IS A VIOLATION OF SECTION 7209, SUB-DIVISION 2 OF THE N.Y. STATE EDUCATION LAW. FELLENER ENGINEERING, LLP CERTIFICATE OF AUTHORIZATION #: 0017795

FELLENER III
ENGINEERING LLP

www.fellp.com

22 Mulberry St., Suite 2A,
Middletown, NY 10940
t 845-343-1481 fx 845-343-4986

181 Church St., Suite 100,
Poughkeepsie, NY 12601
t 845-454-9704 fx 855-320-8735

DESIGNED BY:	DRAWN BY:	APPROVED BY:	FE PROJECT #:
RW	WPB	EDF	23-369

1" = 2'

REFERENCE SCALE

ED2.01