


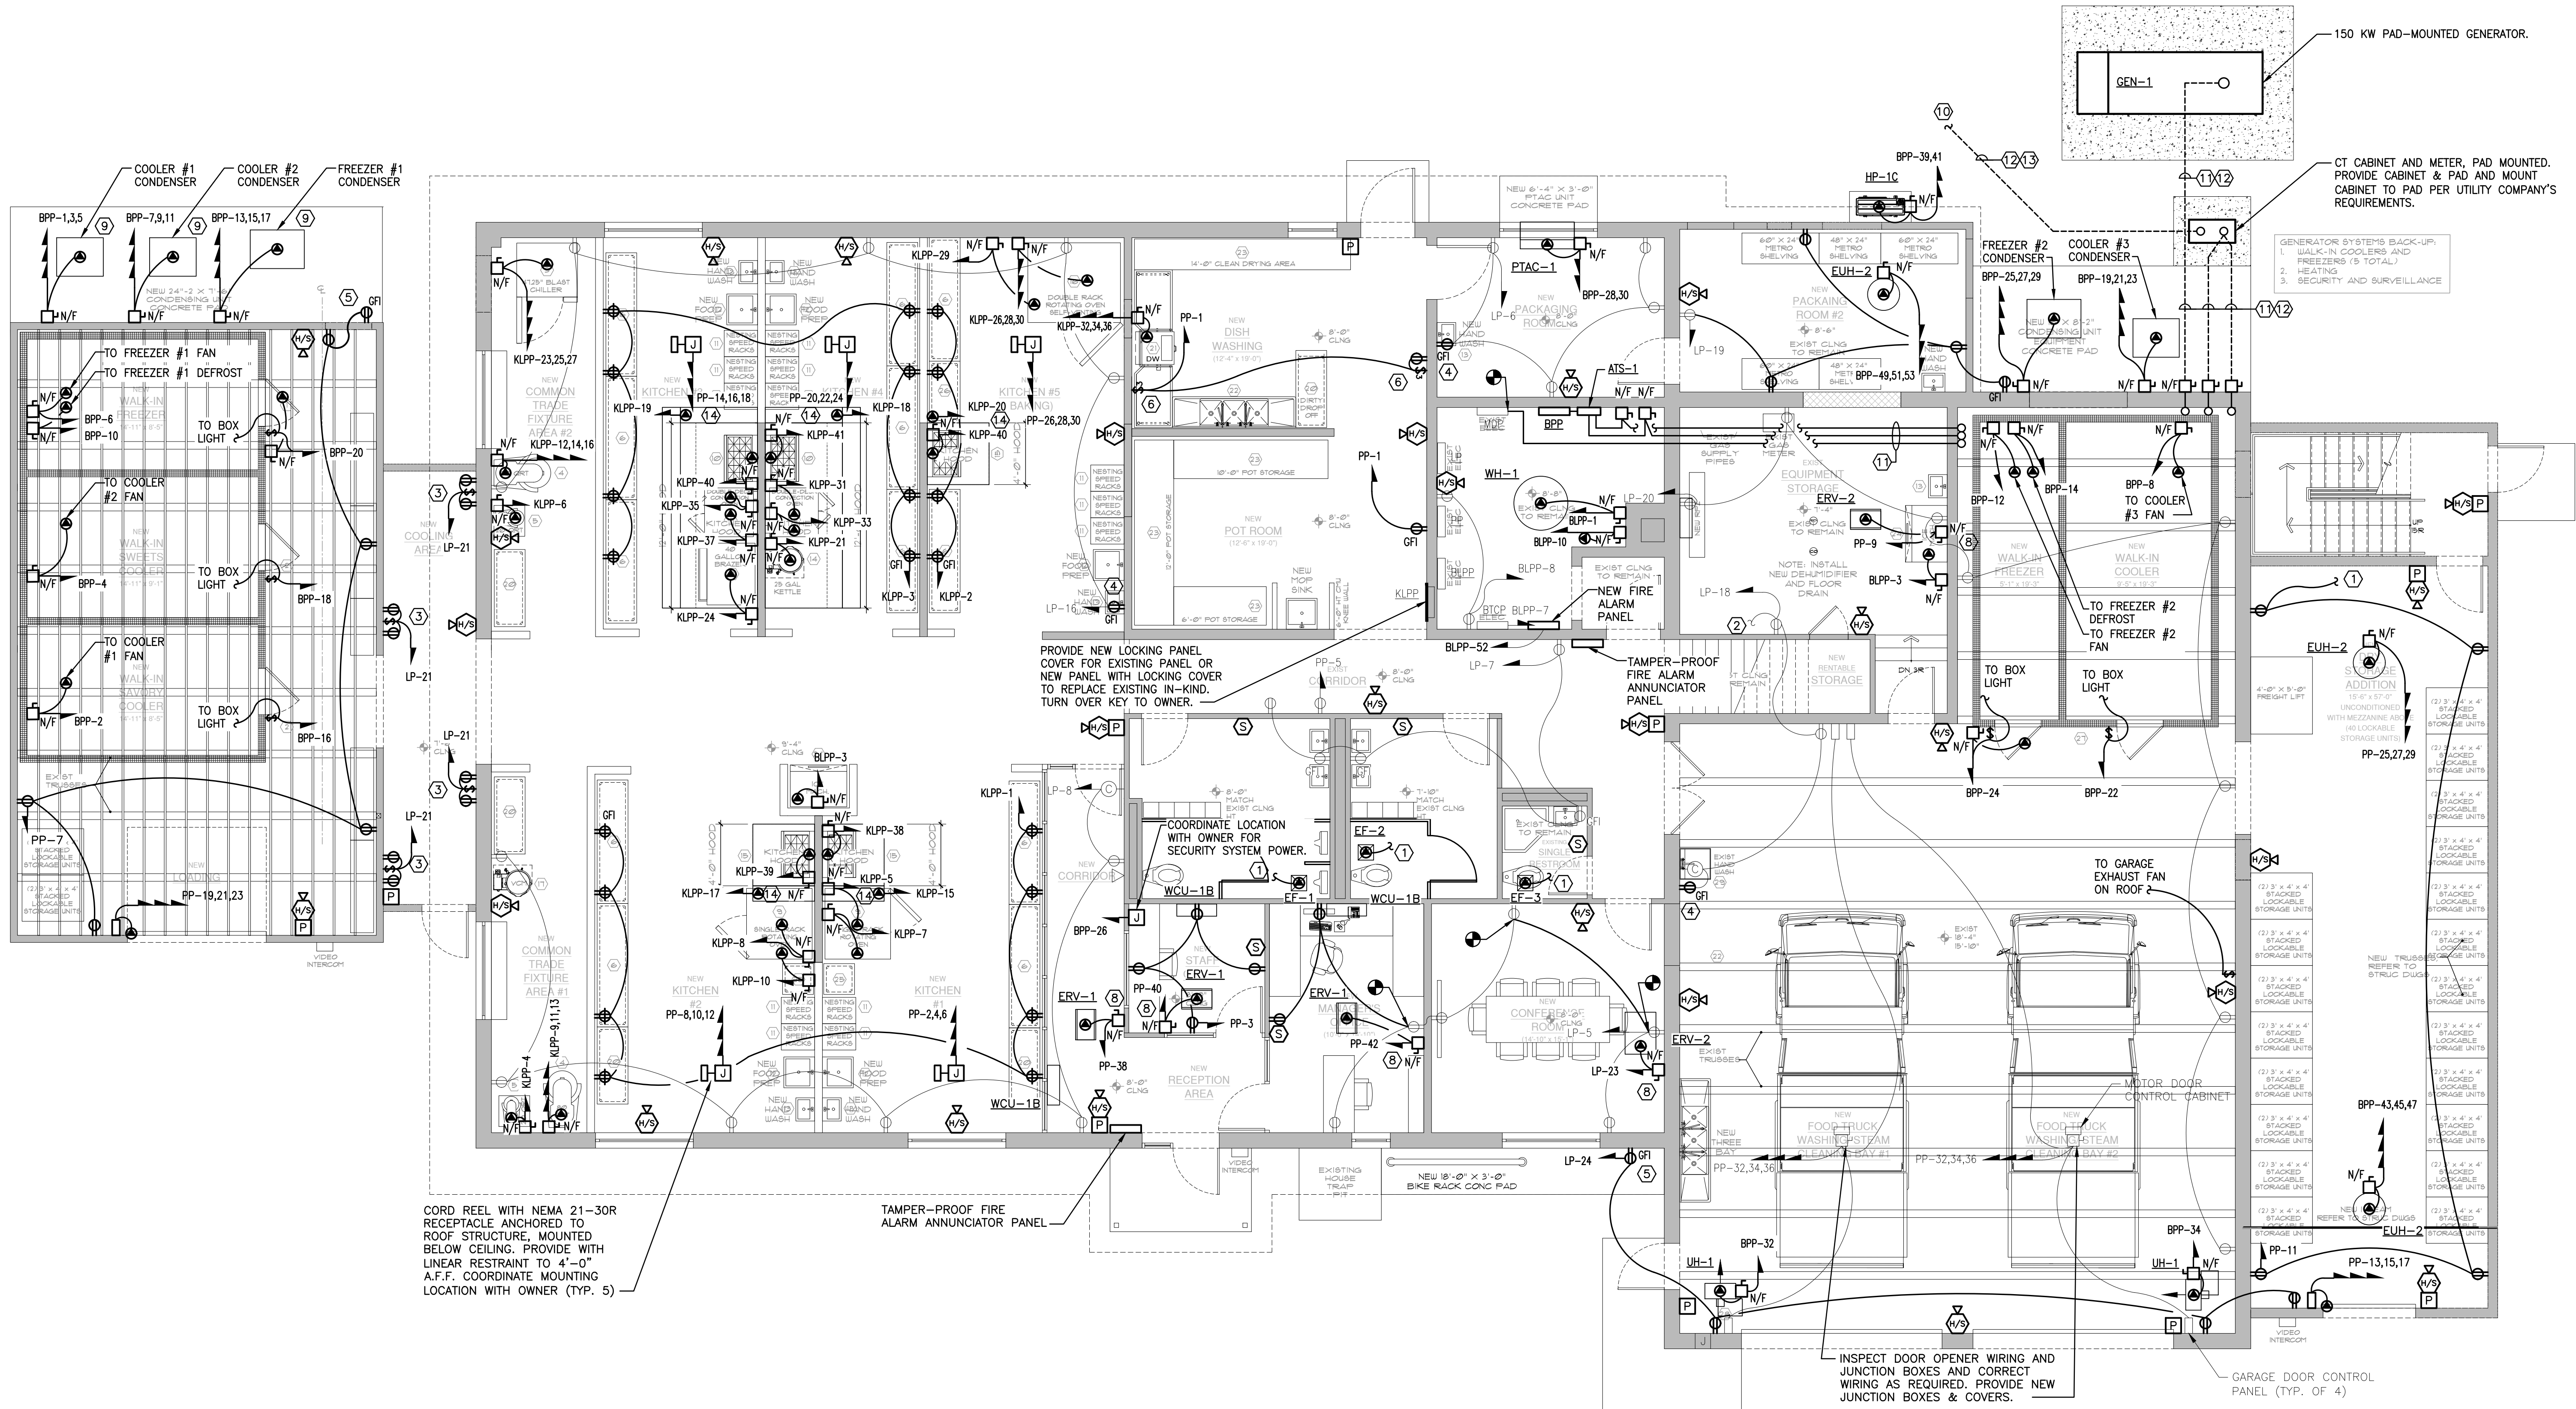

1 ELECTRICAL: CONSTRUCTION FIRST FLOOR POWER PLAN

SCALE: 3/16"=1'-0"

FIRE ALARM NOTE:

1. PROVIDE END-OF-LINE RESISTORS FOR ALL DETECTION AND ANNUNCIATION DEVICES.

NEW WORK KEYED NOTES:

1. SEE E2.01 FOR CONTINUATION.
2. SEE E1.02 FOR CONTINUATION.
3. MOUNT RECEPTACLES 6'-0" A.F.F. OR AS DIRECTED BY OWNER.
4. REPLACE EXISTING WITH GFI RECEPTACLE. ADJUST LOCATION AS REQUIRED FOR CODE COMPLIANCE.
5. PROVIDE RECEPTACLE WITH OUTDOOR ENCLOSURE.
6. SWITCH & RECEPTACLES MOUNTED 84" A.F.F. OR AS DIRECTED BY OWNER.
7. NEW SURFACE-MOUNTED PANEL WITH LOCKING COVER SIZED PER PANEL SCHEDULE. TURN OVER KEY TO OWNER. ALL CONDUITS TO/FROM PANEL SHALL GO UP TO THE CEILING; NO CONDUITS SHALL GO DOWN TO BELOW SLAB.

8. DISCONNECT SWITCH LOCATED ABOVE CEILING.
9. LOCATE OUTDOOR UNIT AS REQUIRED BY MANUFACTURER.
10. SEE ES-101 FOR CONTINUATION UTILITY COMPANY'S POLE.
11. (2) SETS OF (3) 3/0 IN (1) 3" CONDUIT.
12. CONDUIT RUN BELOW GRADE.
13. (4) SETS OF (3) 3/0 IN (1) 4" CONDUIT.
14. PROVIDE RELAY FROM KITCHEN HOOD FIRE SYSTEM TO BUILDING FIRE ALARM SYSTEM. COORDINATE WITH MECHANICAL CONTRACTOR.

NEW WORK GENERAL NOTE:

1. PROVIDE EQUIPMENT DISCONNECT SWITCHES FOR ALL KITCHEN EQUIPMENT REQUIRING DISCONNECTS. REFER TO KITCHEN EQUIPMENT DRAWINGS FOR REQUIREMENTS.
2. ALL DISCONNECTS LOCATED OUTDOORS TO BE NEMA-3R RATED OUTDOOR USE.



NOTE: CONTRACTOR SHALL MARK OUT AND LOCATE ALL UNDERGROUND UTILITIES AND STRUCTURES ON THE PREMISES. NO ADDITIONAL COMPENSATION SHALL BE PROVIDED FOR ALTERATIONS TO DESIGN PLANS DUE TO LACK OF LOCATING. CONTRACTOR SHALL BE RESPONSIBLE FOR PAYING FOR RE-LOCATING OR DAMAGES RESULTING FROM LACK OF LOCATING.

UNAUTHORIZED ALTERATION OR ADDITION TO A PLAN BEARING A LICENSED PROFESSIONAL ENGINEER'S SEAL IS A VIOLATION OF SECTION 7209, SUB-DIVISION 2 OF THE N.Y. STATE EDUCATION LAW. FELLENER ENGINEERING, LLP CERTIFICATE OF AUTHORIZATION #: 0017795

FELLENER III
ENGINEERING LLP

22 Mulberry St., Suite 2A, Middletown, NY 10940
1845-343-1481 fx 845-343-4986

181 Church St., Suite 100, Poughkeepsie, NY 12601
845-454-9704 fx 855-320-8735

DESIGNED BY: RW
DRAWN BY: WPB
APPROVED BY: EDF
PROJECT #: 23-369

REFERENCE SCALE: 1"=20'

PEEKSKILL FIREHOUSE KITCHEN INCUBATOR

City of Peekskill (Owner)
701 Washington Street
Peekskill, New York 10566
S-B-L: 32.20-9-1
City of Peekskill - Westchester County

Date: September 17, 2024
Revisions:

E1.01

JTA
JOSEPH THOMPSON
ARCHITECT

Joseph G. Thompson Architect, PLLC
109 N Division Street, Ste 100
Peekskill, New York 10566
PH: (845) 532-8156
EM: joe@jthompsonarch.com

NOTES:
IT IS A VIOLATION OF THE LAW FOR ANY PERSON, UNLESS ACTING UNDER THE DIRECTION OF A LICENSED ARCHITECT OR ENGINEER, TO ALTER AN ITEM IN ANY WAY, IF AN ITEM BEARING THE SEAL OF AN ARCHITECT OR ENGINEER IS ALTERED, THE ALTERING ARCHITECT OR ENGINEER SHALL AFFIX TO HIS SIGNATURE AND THE DATE OF SUCH ALTERATION, AND A SPECIFIC DESCRIPTION OF THE ALTERATION.
DO NOT SCALE DRAWINGS. WRITTEN DIMENSIONS GOVERN.
© JOSEPH G THOMPSON ARCHITECT, PLLC. ALL RIGHTS RESERVED.



SEAL
ERIC D. FELLENER, P.E.
NY PROFESSIONAL ENGINEER
NO. 073064-1
ISSUED 1995 EXP. 2025

DRAFT CONSTRUCTION DOCUMENT - NOT FOR PERMIT OR CONSTRUCTION