


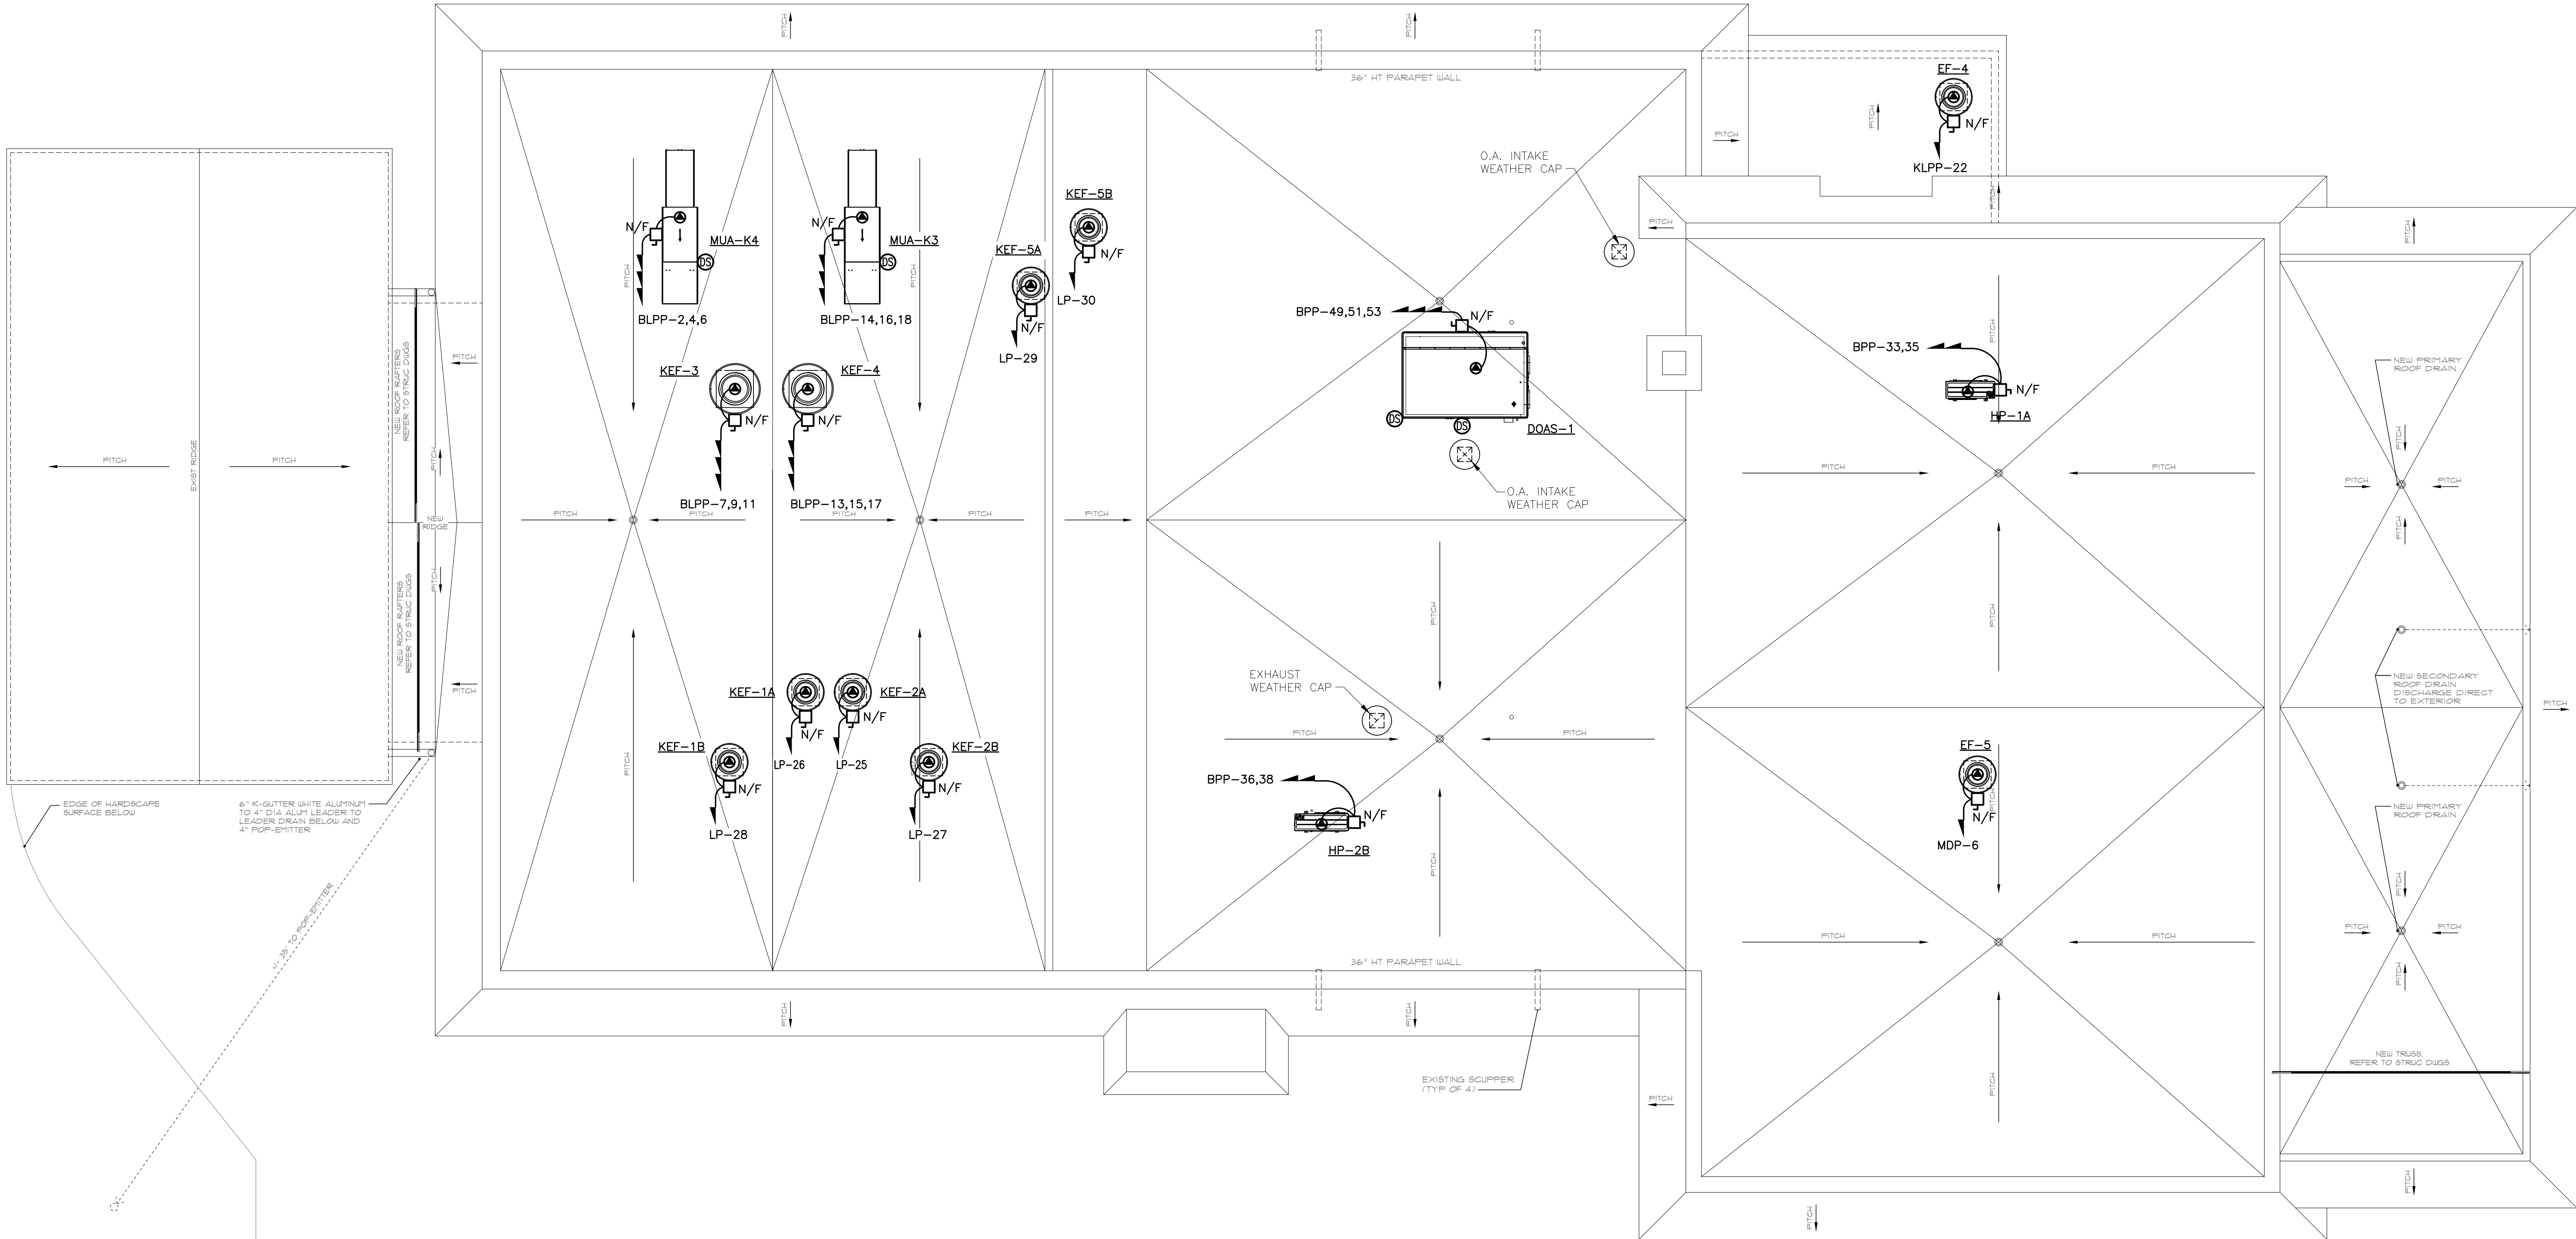

1 ELECTRICAL: CONSTRUCTION ROOF EQUIPMENT POWER PLAN
SCALE: 3/16"=1'-0"

NEW WORK GENERAL NOTE:

1. ALL DISCONNECTS LOCATED OUTDOORS TO BE NEMA-3R
RATED FOR OUTDOOR USE.

UNAUTHORIZED ALTERATION OR ADDITION TO A PLAN BEARING A
LICENSED PROFESSIONAL ENGINEER'S SEAL IS A VIOLATION OF
SECTION 7209, SUB-DIVISION 2 OF THE N.Y. STATE EDUCATION LAW.
FELLENZER ENGINEERING, LLP
CERTIFICATE OF AUTHORIZATION #: 0017795


FELLENZER III
ENGINEERING LLP

www.fellp.com

22 Mulberry St., Suite 2A,
Middletown, NY 10940
t 845-343-1481 fx 845-343-4986

181 Church St., Suite 100,
Poughkeepsie, NY 12601
t 845-454-9704 fx 855-320-8735

DESIGNED BY: RW DRAWN BY: WPB APPROVED BY: EDF FE PROJECT #: 23-369

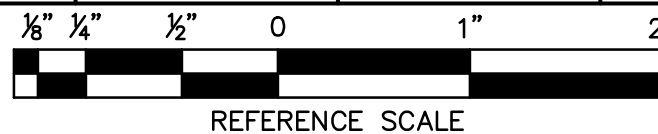

PEEKSKILL FIREHOUSE KITCHEN INCUBATOR

City of Peekskill (Owner)
701 Washington Street
Peekskill, New York 10566
S-B-L: 32-20-9-1
City of Peekskill - Westchester County

DRAFT CONSTRUCTION DOCUMENT - NOT FOR PERMIT OR CONSTRUCTION

Date: September 17, 2024

Revisions:

E1.03

JTA
JOSEPH THOMPSON
ARCHITECT

Joseph G. Thompson Architect, PLLC
109 N Division Street, Ste 100
Peekskill, New York 10566

PH: (845) 532-8156
EM: joe@jthompsonarch.com

NOTES:

IT IS A VIOLATION OF THE LAW FOR
ANY PERSON, UNLESS ACTING
UNDER THE DIRECTION OF A
LICENSED ARCHITECT OR ENGINEER
TO ALTER AN ITEM IN ANY WAY. IF AN
ITEM BEARING THE SEAL OF AN
ARCHITECT OR ENGINEER IS
ALTERED, THE ALTERING ARCHITECT
OR ENGINEER SHALL AFFIX TO HIS
ITEM THE SEAL AND THE NOTATION
ALTERED BY FOLLOWED BY HIS
SIGNATURE AND THE DATE OF SUCH
ALTERATION, AND A SPECIFIC
DESCRIPTION OF THE ALTERATION.

DO NOT SCALE DRAWINGS.
WRITTEN DIMENSIONS GOVERN.
© JOSEPH G THOMPSON ARCHITECT, PLLC. ALL RIGHTS RESERVED.



SEAL
ERIC D. FELLENZER, P.E.
NY PROFESSIONAL ENGINEER
NO. 073044-1
ISSUED 1995 EXP. 8/25