


File Name: F:\2023\23-389 Peekskill Firehouse Kitchen Incubator\ELECTRICAL\E7.01 (DETAILS).dwg (Layout: E7.01)
Date: Tue, Sep 17, 2024 - 10:11 AM (Name: wpb)

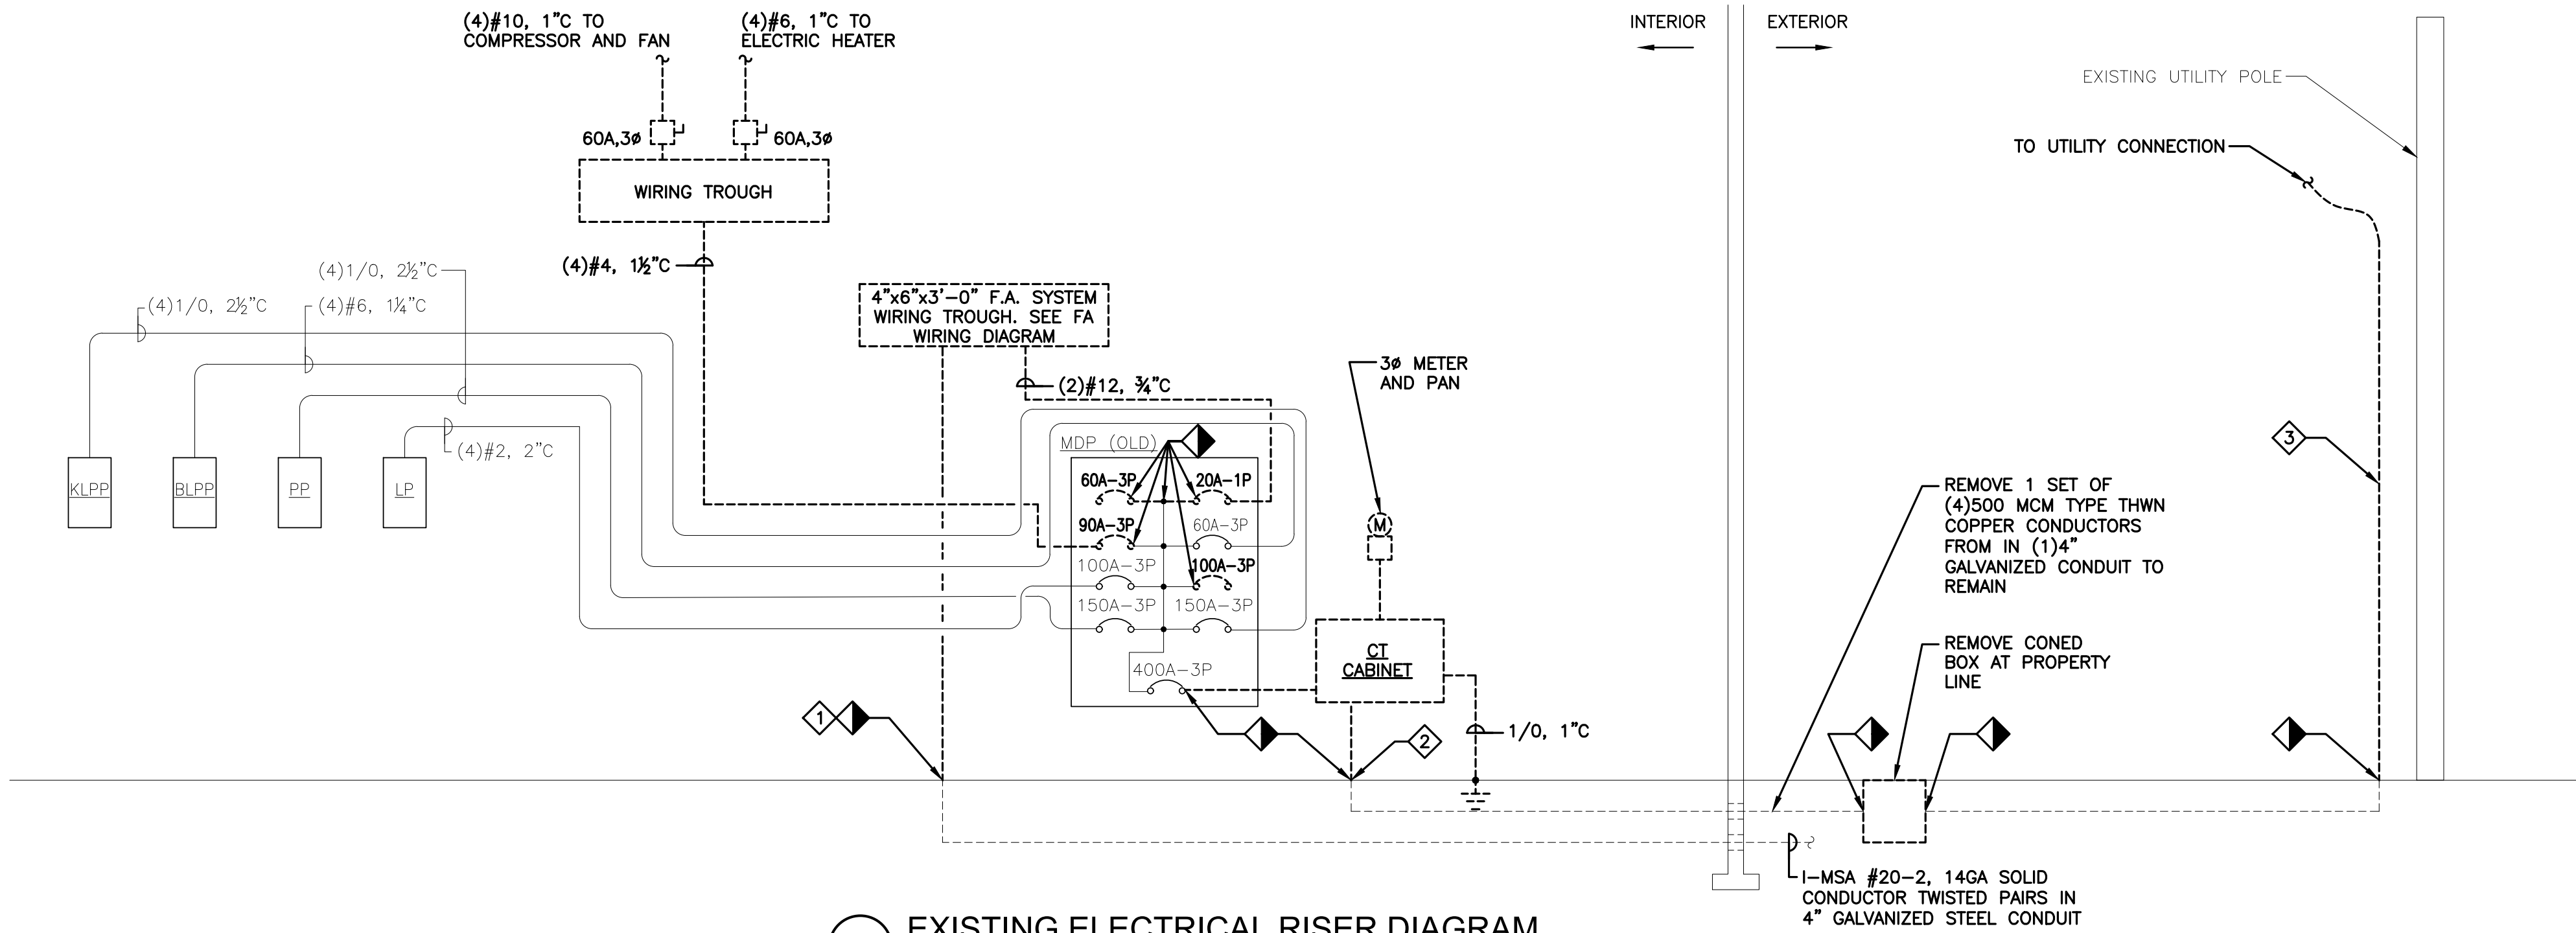


1 EXISTING ELECTRICAL RISER DIAGRAM

N.T.S.

DEMOLITION KEYED NOTES:

- 1 DISCONNECT WIRE AND CONDUIT AT BUILDING EXIT. CAP AND SEAL LINE BELOW FLOOR. GC TO PATCH, SEAL, AND REPAIR FLOOR TO MATCH EXISTING.
- 2 EXISTING CONDUIT TO BE ABANDONED IN-PLACE BELOW GRADE. REMOVE CONDUIT ABOVE GRADE. REMOVE ALL WIRING BACK TO UTILITY POLE. CAP AND SEAL CONDUIT BELOW FLOOR. GC TO PATCH, SEAL, AND REPAIR FLOOR TO MATCH EXISTING. COORDINATE REMOVAL WITH LOCAL UTILITY COMPANY.
- 3 REMOVE WIRE AND CONDUIT AT UTILITY POLE UP TO POINT INDICATED BY AND UNDER DIRECTION FROM LOCAL UTILITY COMPANY.

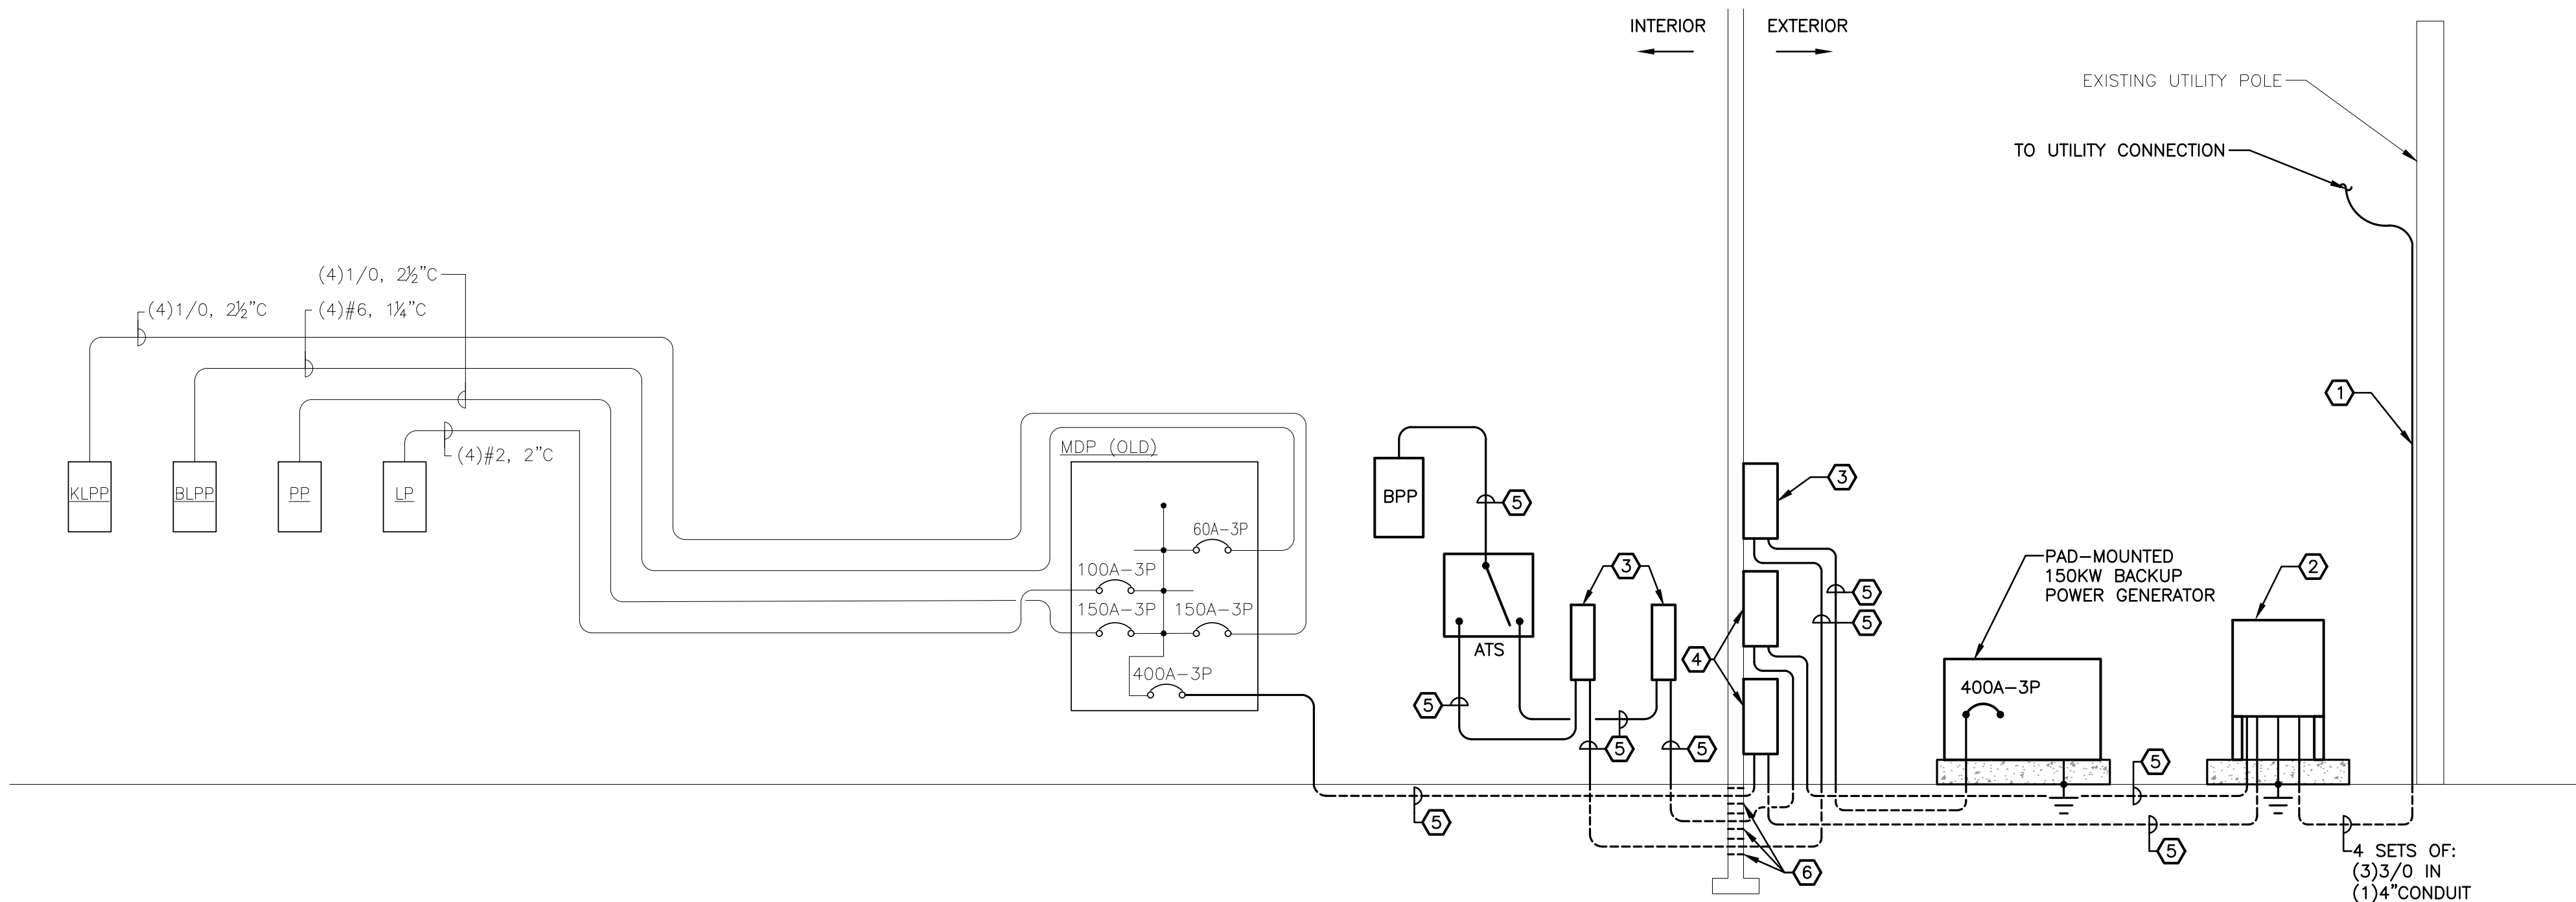

2 NEW WORK ELECTRICAL RISER DIAGRAM

N.T.S.

NEW WORK KEYED NOTES:

- 1 PROVIDE NEW CONDUIT AT POLE AND SUFFICIENT SLACK FOR UTILITY COMPANY TO MAKE WIRING CONNECTION AT POLE.
- 2 PAD MOUNTED CT CABINET PER LOCAL UTILITY COMPANY'S REQUIREMENTS.
- 3 400A NON-FUSED DISCONNECT.
- 4 400A FUSED DISCONNECT.
- 5 (2) SETS OF: (3)3/0 IN (1) 3" CONDUIT.
- 6 PROVIDE NEW WATER-TIGHT PASS-THROUGHS & SEAL EXISTING TO ENSURE THEY ARE WATER TIGHT.



NOTE: CONTRACTOR SHALL MARK OUT AND LOCATE ALL UNDERGROUND UTILITIES AND STRUCTURES ON THE PREMISES. NO ADDITIONAL COMPENSATION SHALL BE PROVIDED FOR ALTERATIONS TO DESIGN PLANS DUE TO LACK OF LOCATING. CONTRACTOR SHALL BE RESPONSIBLE FOR PAYING FOR RE-LOCATING OR DAMAGES RESULTING FROM LACK OF LOCATING.

UNAUTHORIZED ALTERATION OR ADDITION TO A PLAN BEARING A LICENSED PROFESSIONAL ENGINEER'S SEAL IS A VIOLATION OF SECTION 7209, SUB-DIVISION 2 OF THE N.Y. STATE EDUCATION LAW. FELLENER ENGINEERING, LLP CERTIFICATE OF AUTHORIZATION #: 0017795


FELLENER ENGINEERING LLP

www.fellp.com

22 Mulberry St., Suite 2A,
Middletown, NY 10940
t 845-343-1481 fx 845-343-4986

181 Church St., Suite 100,
Poughkeepsie, NY 12601
t 845-454-9704 fx 855-320-8735

DESIGNED BY: RW DRAWN BY: WPB APPROVED BY: EDF FE PROJECT #: 23-369

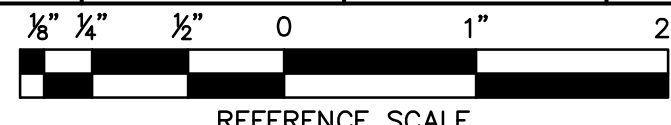

PEEKSKILL FIREHOUSE KITCHEN INCUBATOR

City of Peekskill (Owner)
701 Washington Street
Peekskill, New York 10566
S-B-L: 32.20.9-1
City of Peekskill - Westchester County

DRAFT CONSTRUCTION DOCUMENT - NOT FOR PERMIT OR CONSTRUCTION

Date: September 17, 2024

Revisions:

E7.01

JTA
JOSEPH THOMPSON
ARCHITECT

Joseph G. Thompson Architect, PLLC
109 N Division Street, Ste 100
Peekskill, New York 10566

PH: (845) 532-8156
EM: joe@jthompsonarch.com

NOTES:

IT IS A VIOLATION OF THE LAW FOR ANY PERSON, UNLESS ACTING UNDER THE DIRECTION OF A LICENSED ARCHITECT OR ENGINEER, TO ALTER AN ITEM IN ANY WAY, IF AN ITEM BEARING THE SEAL OF AN ARCHITECT OR ENGINEER IS ALTERED. THE ALTERING ARCHITECT OR ENGINEER SHALL AFFIX TO HIS ITEM THE SEAL AND THE NOTATION ALTERED BY FOLLOWED BY HIS SIGNATURE AND THE DATE OF SUCH ALTERATION, AND A SPECIFIC DESCRIPTION OF THE ALTERATION.

DO NOT SCALE DRAWINGS. WRITTEN DIMENSIONS GOVERN.
© JOSEPH G THOMPSON ARCHITECT, PLLC. ALL RIGHTS RESERVED.



SEAL
ERIC D. FELLENER, P.E.
NY PROFESSIONAL ENGINEER
NO. 073044-1
ISSUED 1995 EXP. 8/25