


File Name: F:\2023\23-389 Peekskill Firehouse Kitchen Incubator\ELECTRICAL\E7.02 (DETAILS).dwg (Layout: E7.02)
Date: Tue, Sep 17, 2024 - 10:11 AM (Name: wpb)

1 EXISTING FIRE ALARM ACTUATED BED ROOM LIGHT FLASHING WIRING DIAGRAM N.T.S.


NOTE:

1. RELAY TO BE ACTUATED BY FIRE ALARM SYSTEM AND LIGHTS TO BE LIT IF NOT ILLUMINATED.

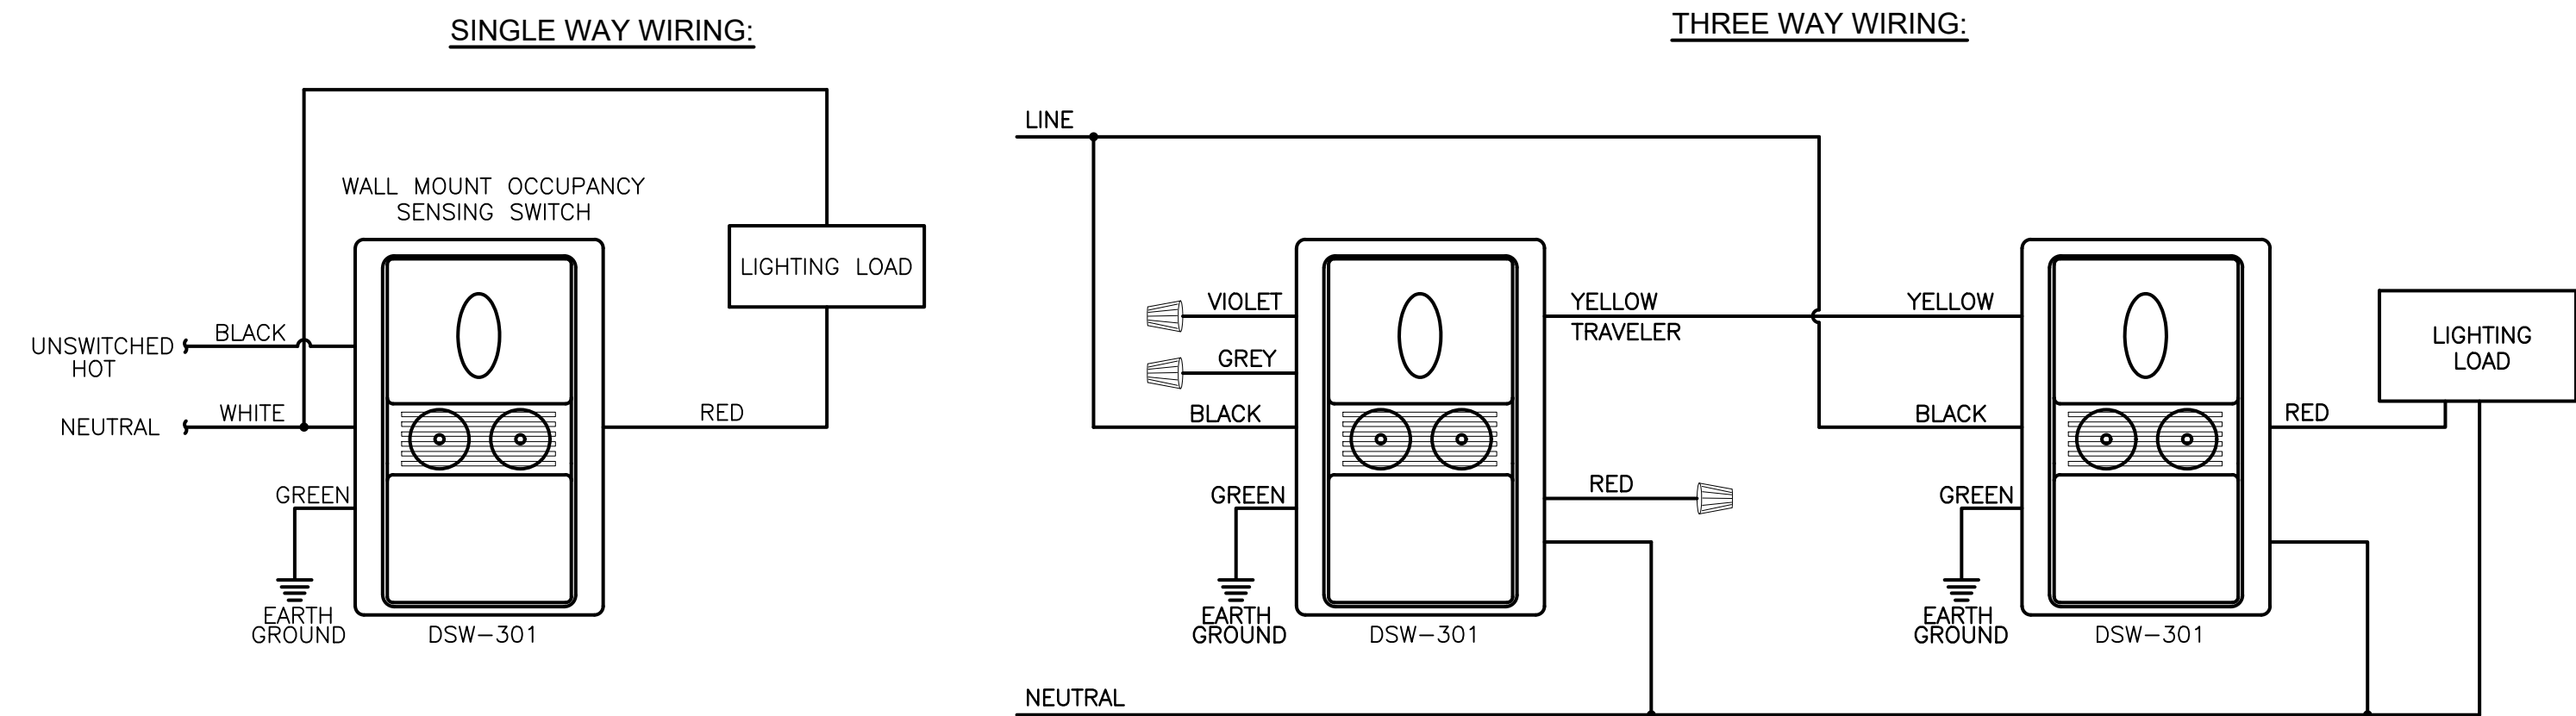

- GENERAL NOTES:
1. BASIS OF DESIGN: WATTSTOPPER - DSW-301.

4 TYPICAL WALL MOUNT OCCUPANCY SENSOR SWITCH DETAIL N.T.S.

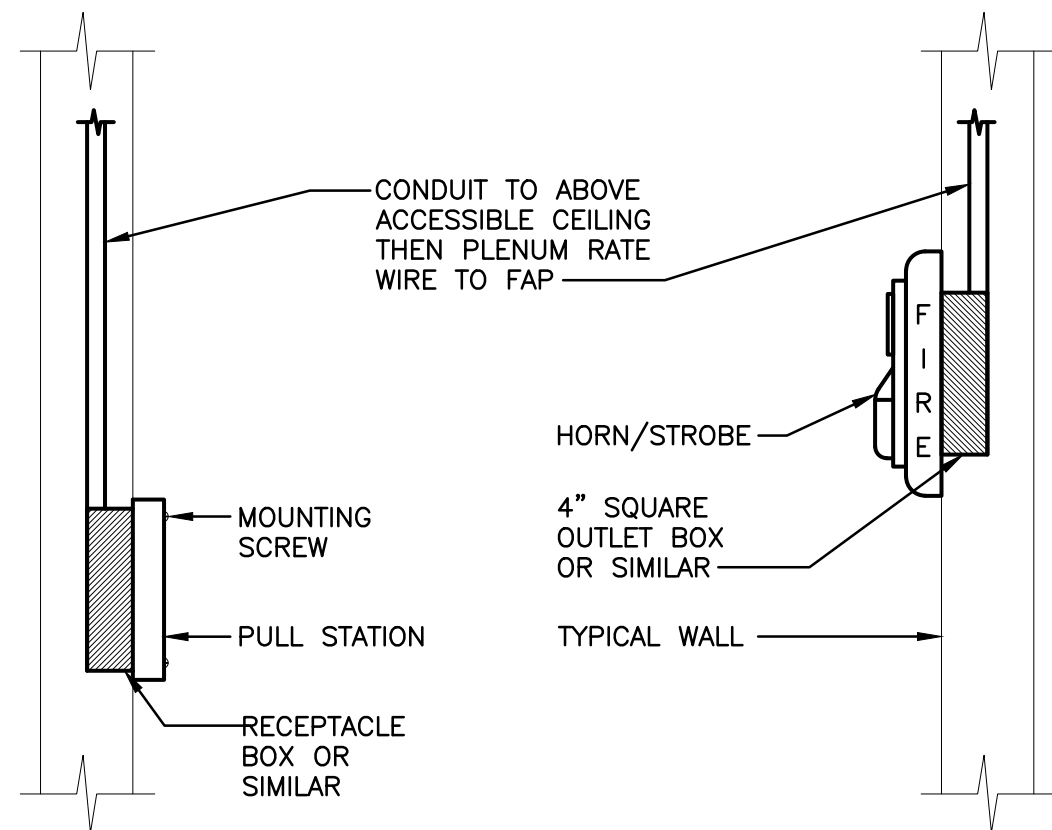


NOTES:


1. FOR SURFACE MOUNT INSTALLATIONS, INSTALL WIREMOLD & WIREMOLD RECEPTACLE BOX ONLY AT THE DISCRETION OF THE OWNER.
2. THIS DETAIL PERTAINS TO NEW CONSTRUCTION ONLY. WHEN NEW DEVICES ARE BEING INSTALLED WHERE JUNCTION BOXES EXIST ALREADY, UTILIZE THE JUNCTION BOX.

6 TYPICAL PULL STATION & HORN STROBE DETAIL N.T.S.

2 EXISTING FIRE ALARM SYSTEM WIRING (TO BE REMOVED) N.T.S.

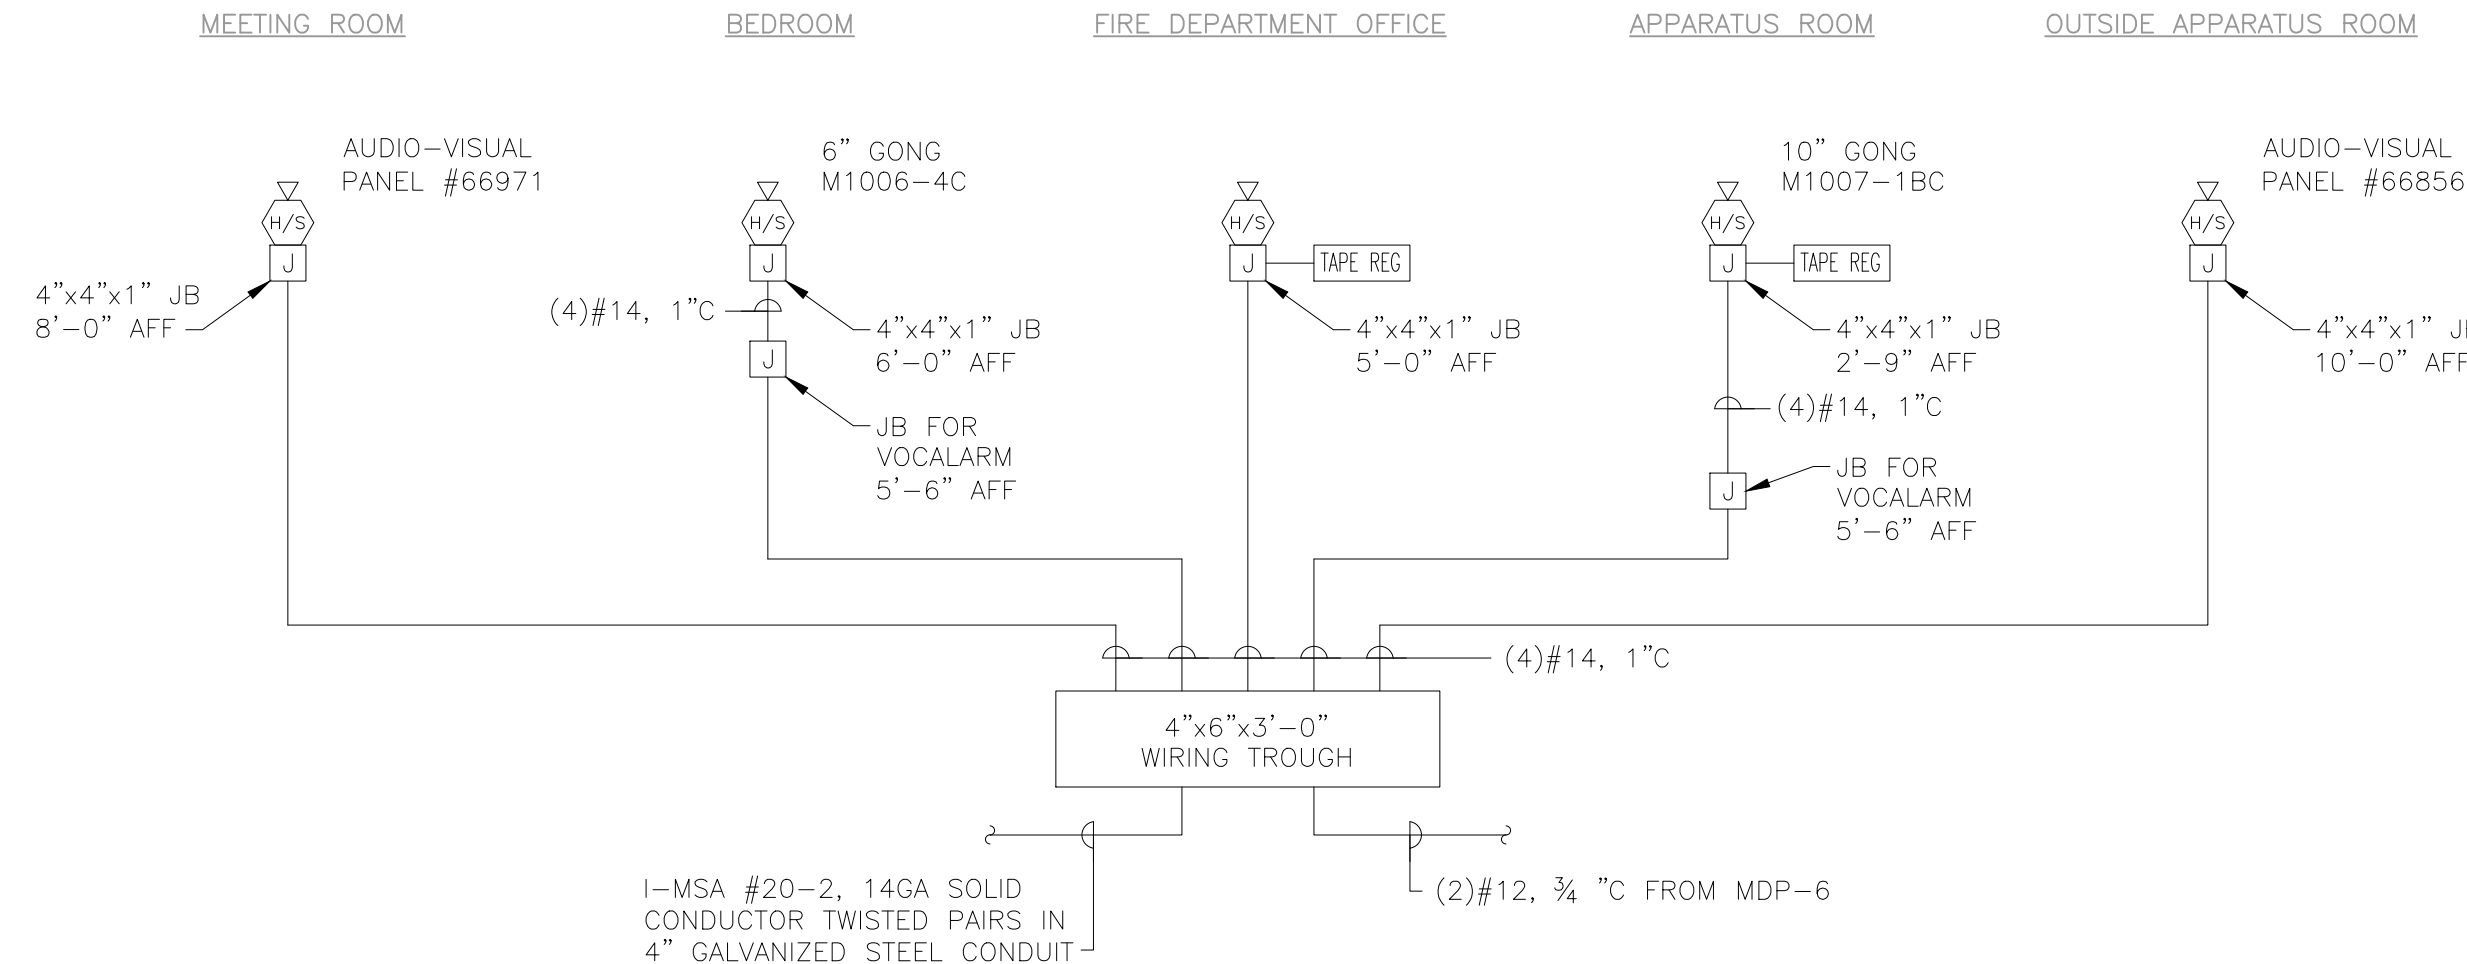


7 EXHAUST FAN DETAIL N.T.S.

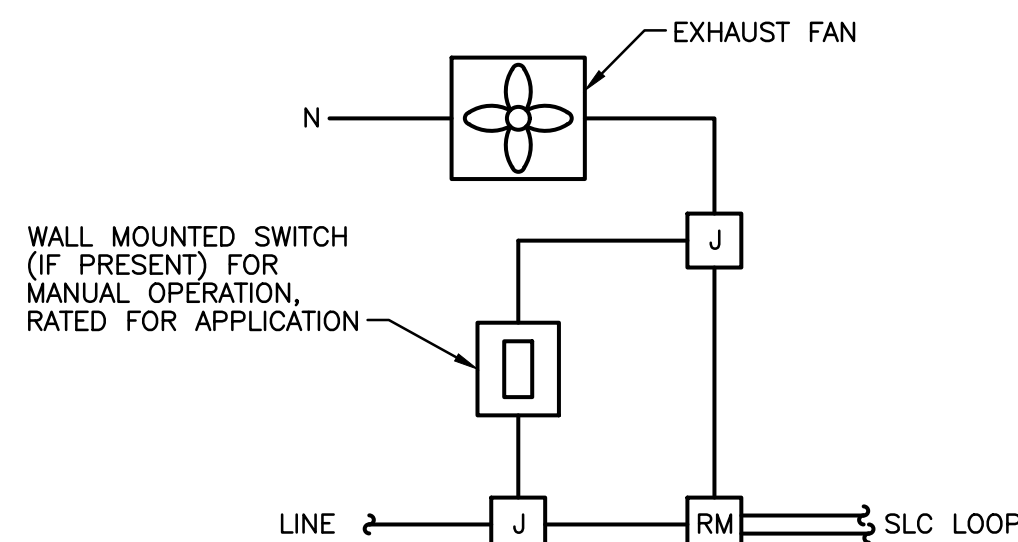

NOTES:

1. PROVIDE INDEPENDENT RELAY MODULE FOR EACH EXHAUST FAN.
2. EXHAUST FAN SHALL OPERATE AUTOMATICALLY WHEN FIRE ALARM SYSTEM DETECTS CARBON MONOXIDE OF 25 PPM.


3 TYPICAL SINGLE ZONE AUTOMATIC SWITCHING ROOM CONTROLLER (LARGE ROOMS & CORRIDORS) N.T.S.

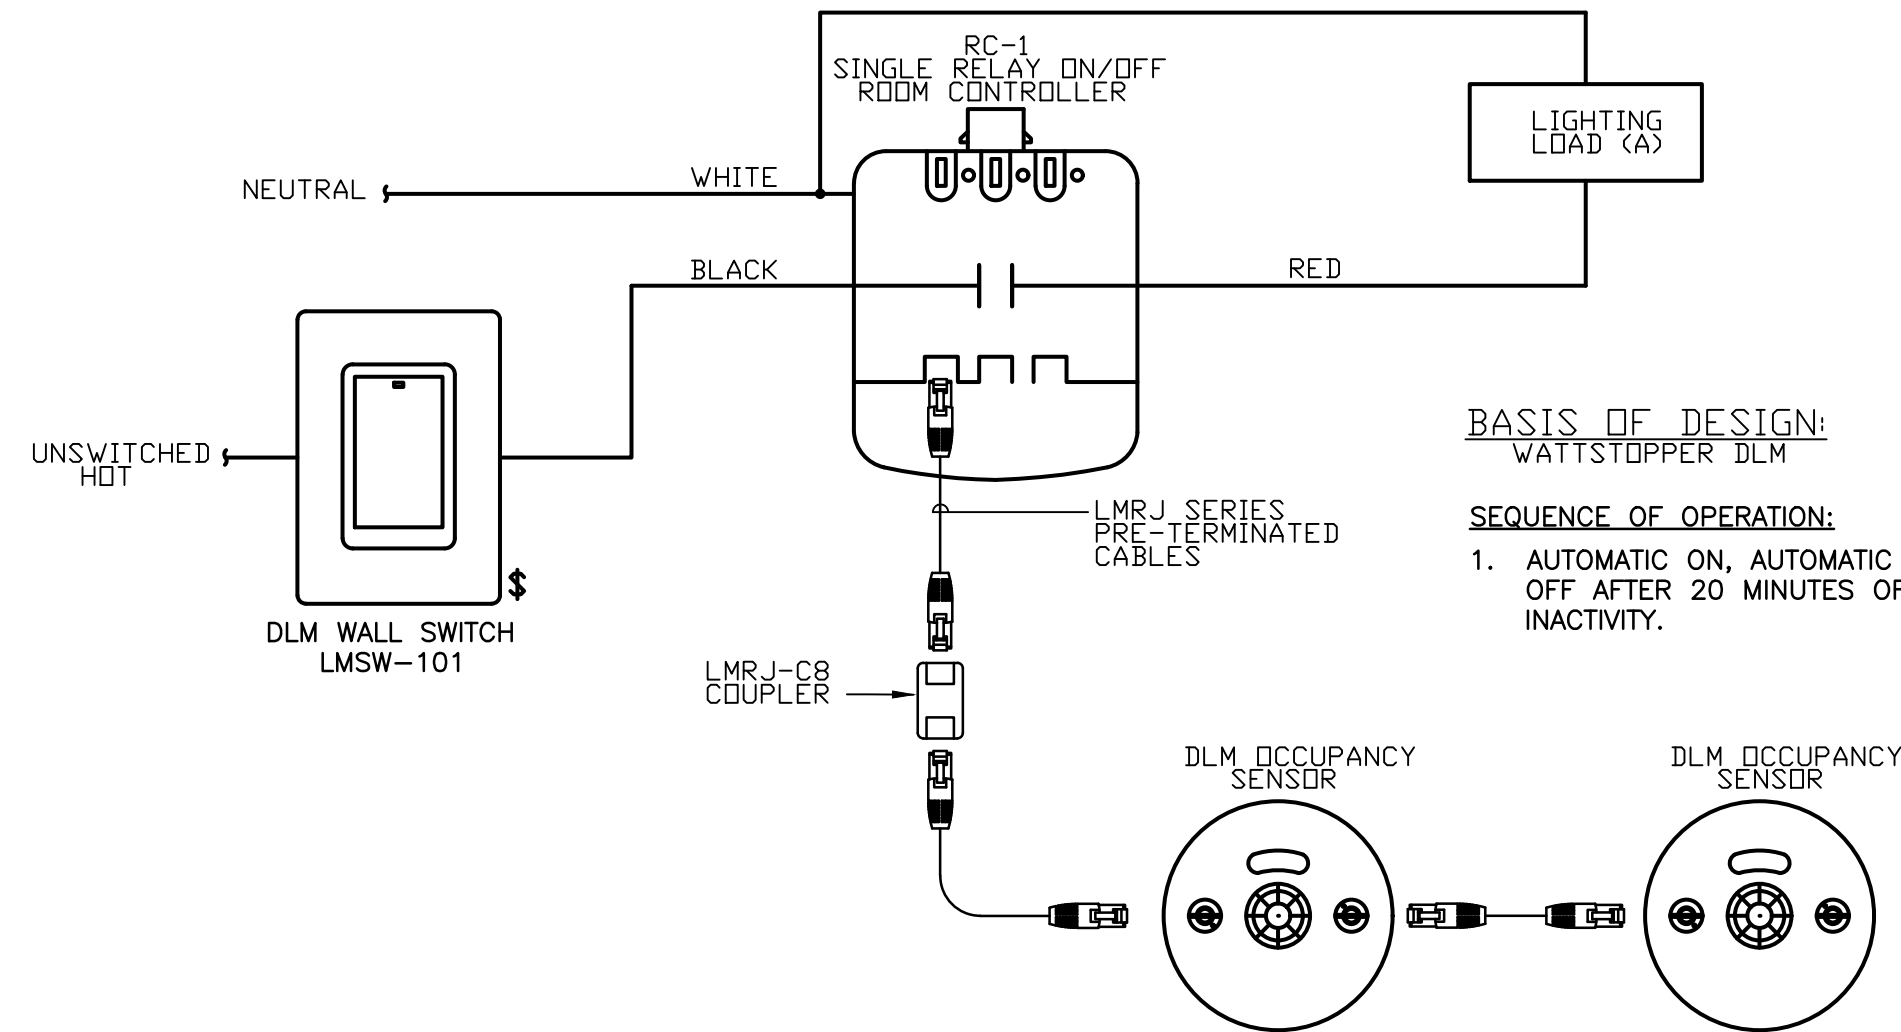

BASIS OF DESIGN:

SEQUENCE OF OPERATION:

1. AUTOMATIC ON, AUTOMATIC OFF AFTER 20 MINUTES OF INACTIVITY.

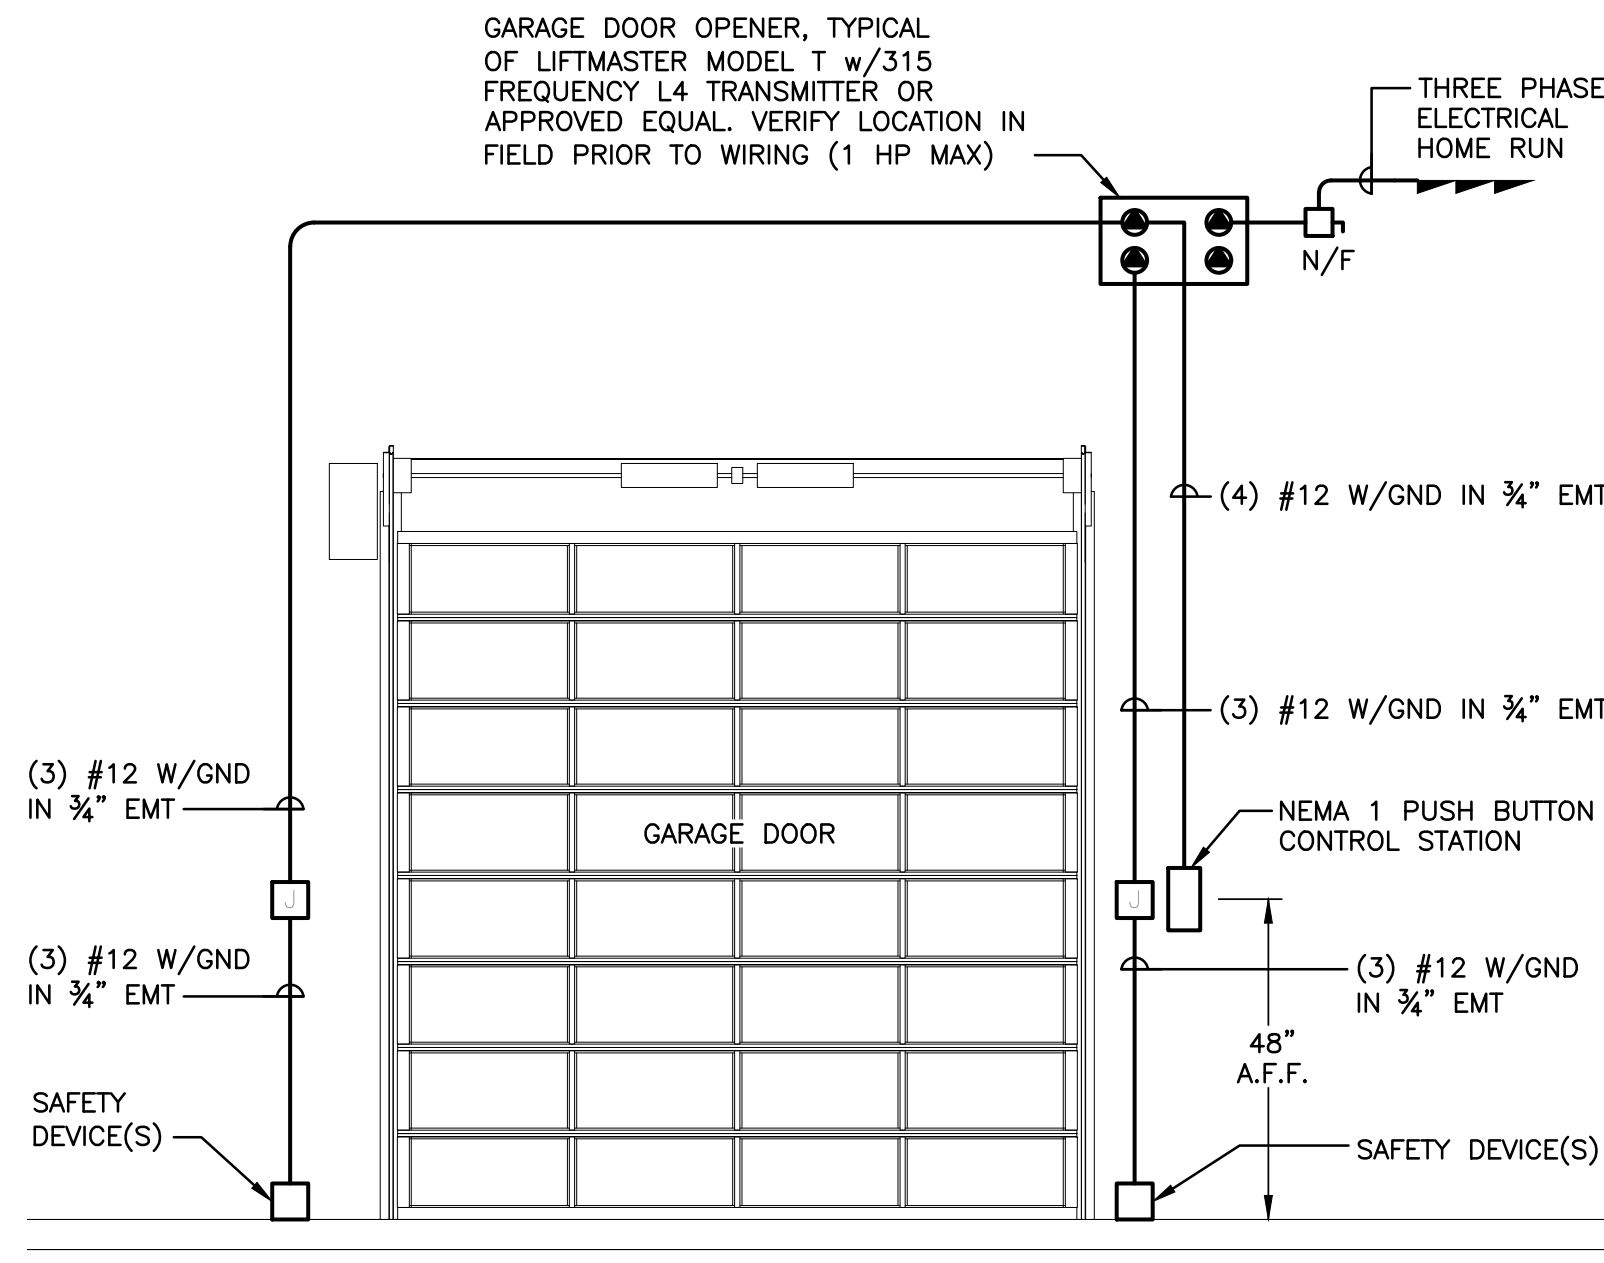

5 TYPICAL GARAGE DOOR WIRING DIAGRAM N.T.S.



NOTE: CONTRACTOR SHALL MARK OUT AND LOCATE ALL UNDERGROUND UTILITIES AND STRUCTURES ON THE PREMISES. NO ADDITIONAL COMPENSATION SHALL BE PROVIDED FOR ALTERATIONS TO DESIGN PLANS DUE TO LACK OF LOCATING. CONTRACTOR SHALL BE RESPONSIBLE FOR PAYING FOR RE-LOCATING OR DAMAGES RESULTING FROM LACK OF LOCATING.

UNAUTHORIZED ALTERATION OR ADDITION TO A PLAN BEARING A LICENSED PROFESSIONAL ENGINEER'S SEAL IS A VIOLATION OF SECTION 7209, SUB-DIVISION 2 OF THE N.Y. STATE EDUCATION LAW. FELLENZER ENGINEERING, LLP CERTIFICATE OF AUTHORIZATION #: 0017795

FELLENZER III
ENGINEERING LLP

www.fellp.com

22 Mulberry St., Suite 2A, Middletown, NY 10940 t 845-343-1481 fx 845-343-4986

181 Church St., Suite 100, Poughkeepsie, NY 12601 t 845-454-9704 fx 855-320-8735

DESIGNED BY: RW	DRAWN BY: WPB	APPROVED BY: EDF	FE PROJECT #: 23-369
-----------------	---------------	------------------	----------------------

REFERENCE SCALE

PEEKSKILL FIREHOUSE KITCHEN INCUBATOR

City of Peekskill (Owner)
701 Washington Street
Peekskill, New York 10566
S-B-L: 32-20-9-1
City of Peekskill - Westchester County

DRAFT CONSTRUCTION DOCUMENT - NOT FOR PERMIT OR CONSTRUCTION

Date: September 17, 2024

Revisions:

E7.02

JTA
JOSEPH THOMPSON
ARCHITECT

Joseph G. Thompson Architect, PLLC
108 N Division Street, Ste 100
Peekskill, New York 10566

PH: (845) 532-8156
EM: joe@jthompsonarch.com

NOTES:

IT IS A VIOLATION OF THE LAW FOR ANY PERSON, UNLESS ACTING UNDER THE DIRECTION OF A LICENSED ARCHITECT OR ENGINEER, TO ALTER AN ITEM IN ANY WAY, IF AN ITEM BEARING THE SEAL OF AN ARCHITECT OR ENGINEER IS ALTERED. THE ALTERING ARCHITECT OR ENGINEER SHALL AFFIX TO HIS ITEM THE SEAL AND THE NOTATION ALTERED BY FOLLOWED BY HIS SIGNATURE AND THE DATE OF SUCH ALTERATION, AND A SPECIFIC DESCRIPTION OF THE ALTERATION. DO NOT SCALE DRAWINGS. WRITTEN DIMENSIONS GOVERN.

© JOSEPH G THOMPSON ARCHITECT, PLLC. ALL RIGHTS RESERVED.



SEAL
ERIC D. FELLENZER, P.E.
NY PROFESSIONAL ENGINEER
NO. 073084-1
ISSUED 1995 EXP. 8/25