


DATE	ISSUE TO	PR	TO
01.18.22	ISSUANCE FOR CDBG		--
08.02.22	ISSUANCE FOR PRICING		--
06.26.25	ISSUE FOR PERMIT		--
07.07.25	ISSUE FOR BIDS		--

NO	DATE	REVISIONS	BY


ELECTRIC - POWER/ LIGHTING
PROPOSED FLOOR PLAN, PARTIAL
CELLAR PLAN & PARTIAL ROOF PLAN

PROJECT NO.:	2201
SCALE:	AS ANOTED
DRAWN BY:	
CHECKED BY:	
DATE:	12/13/21

E-100

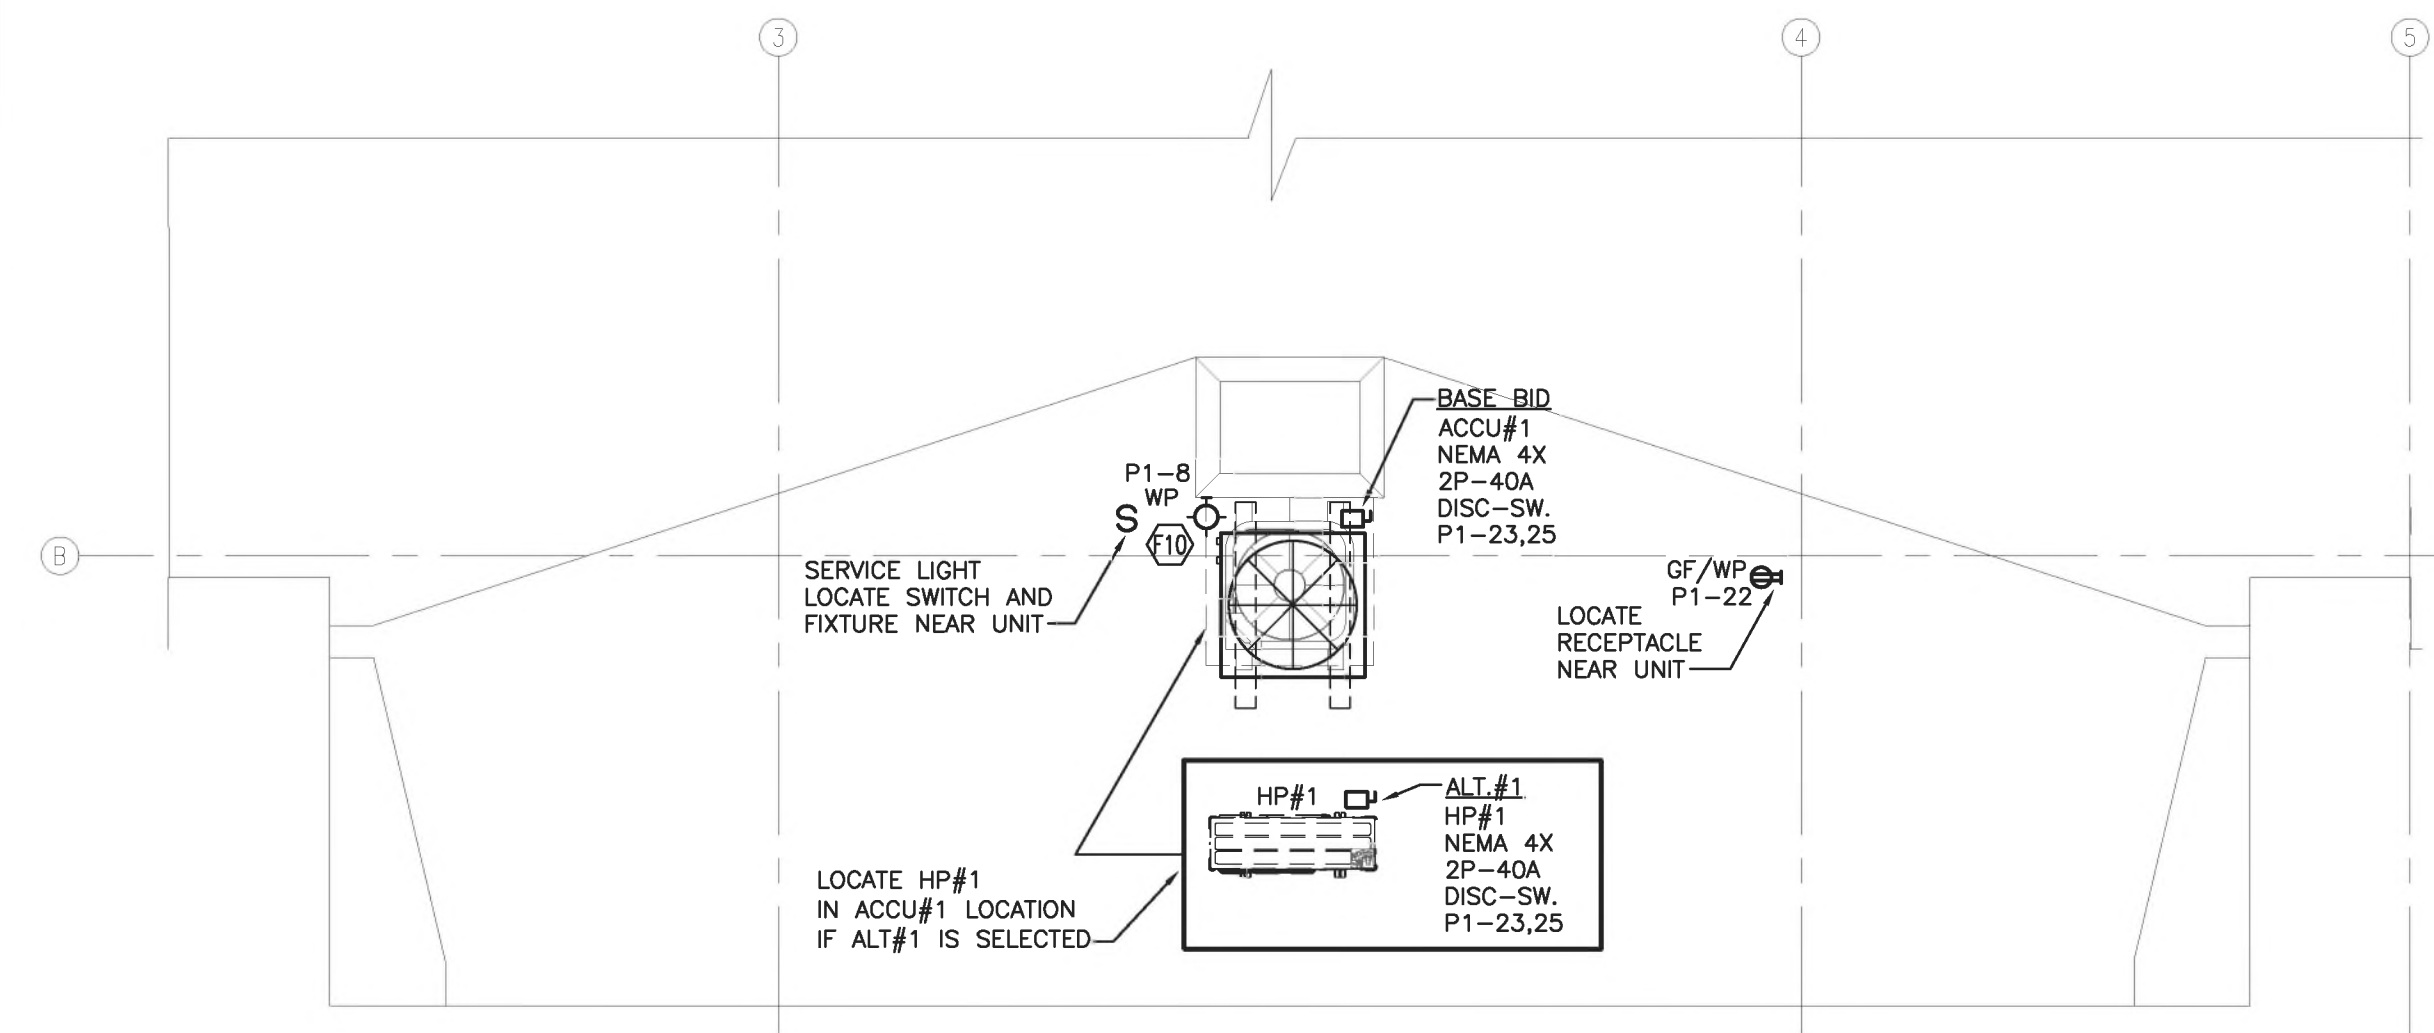


3 PARTIAL ROOF PLAN - POWER/LIGHTING
E-100 SCALE: 1/4" = 1'-0" NORTH

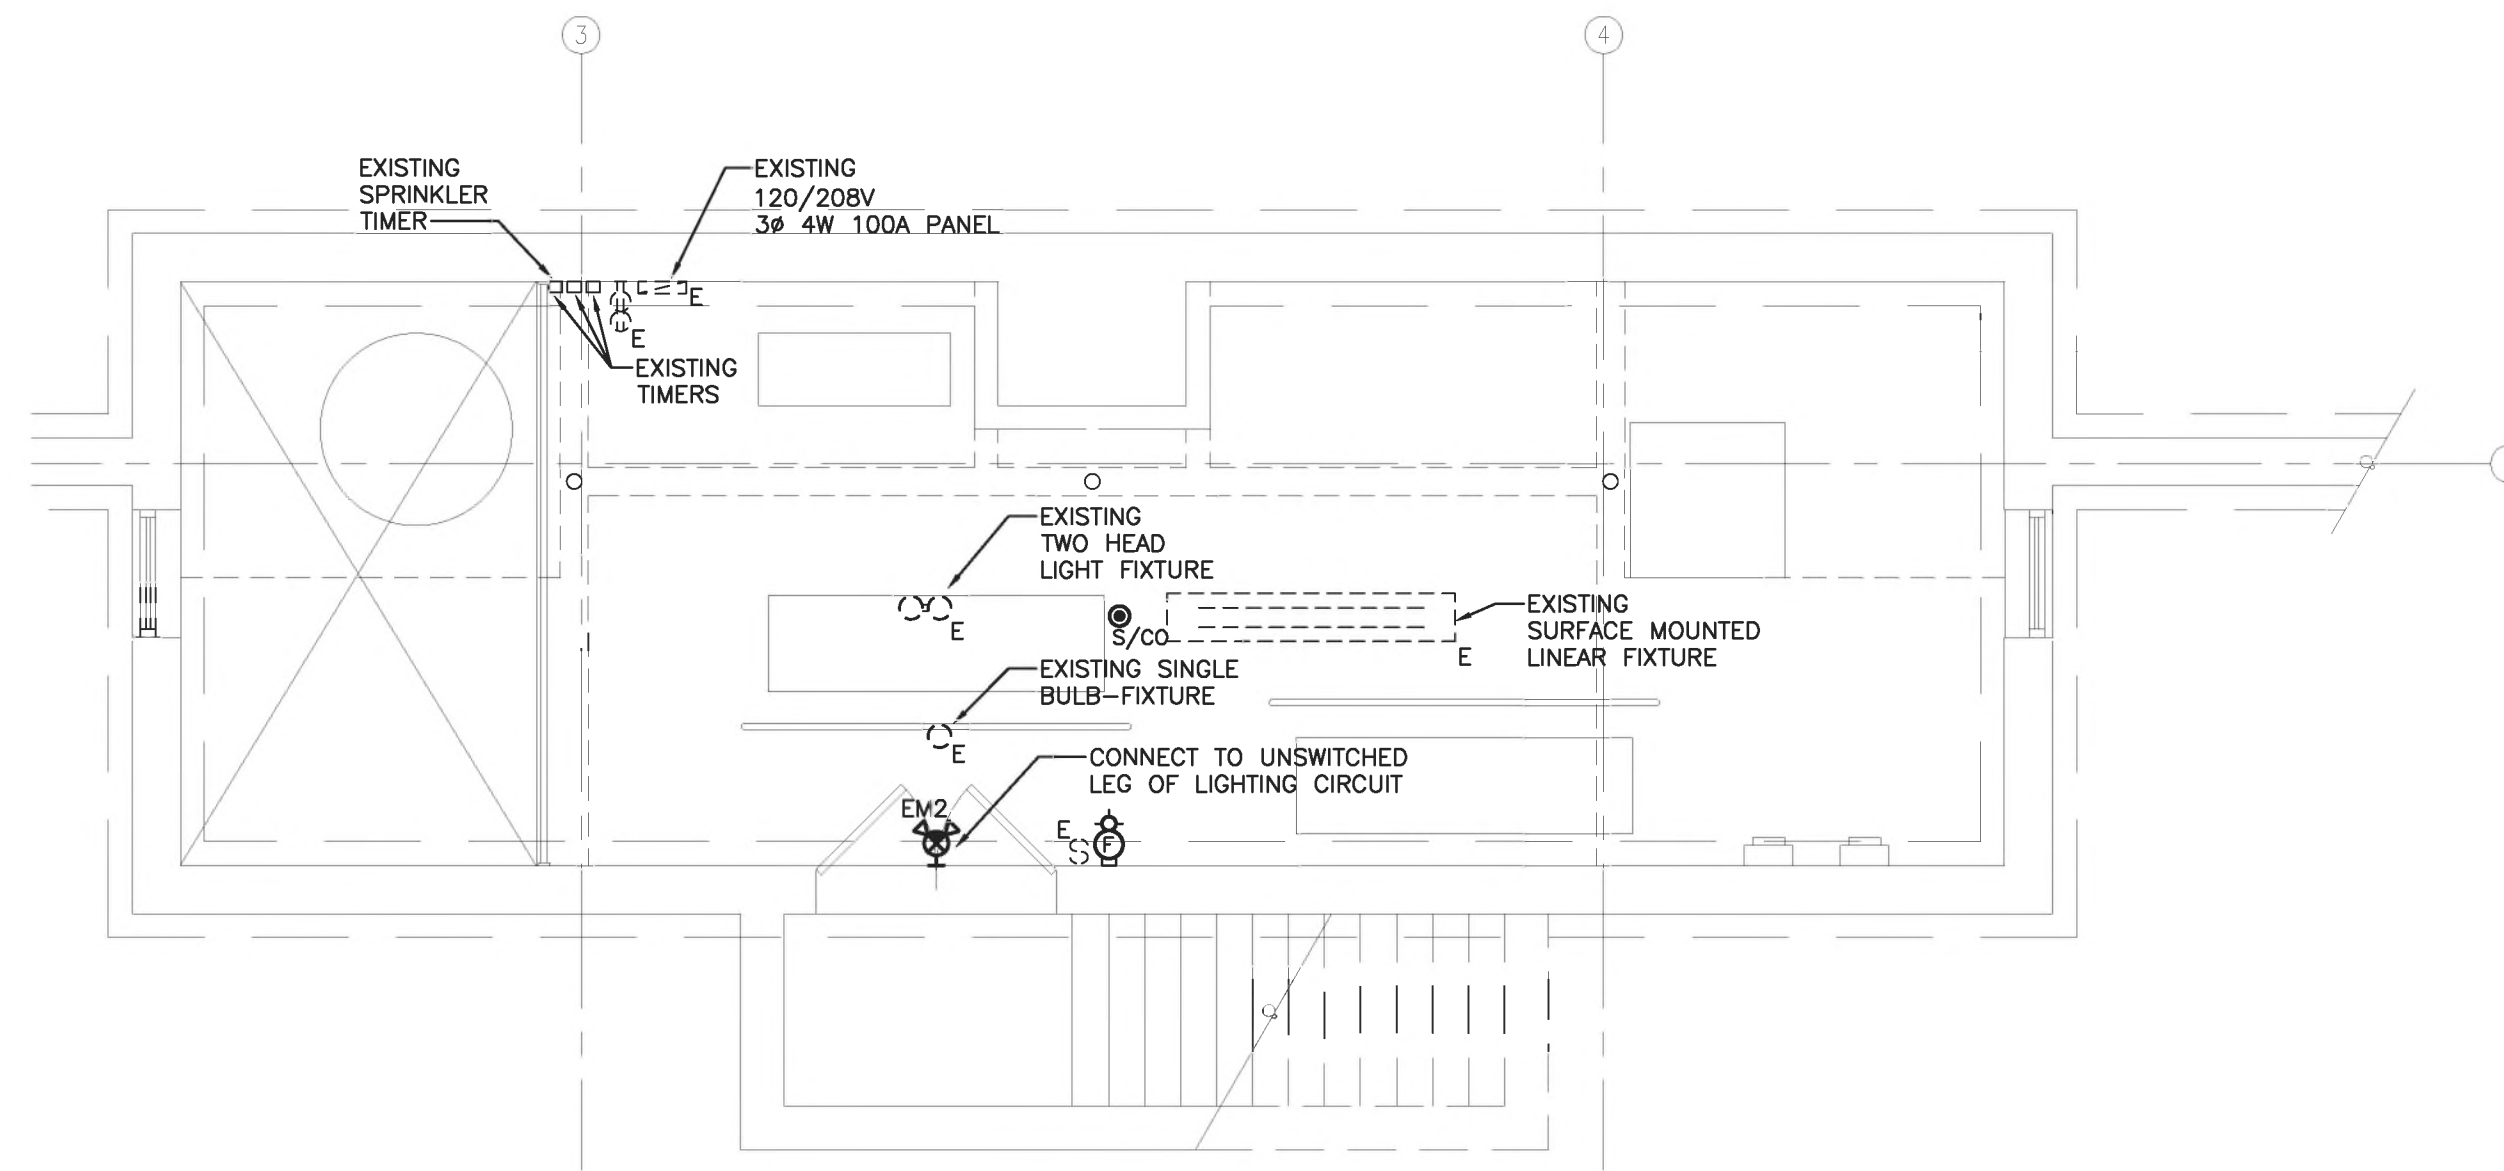

2 PARTIAL CELLAR PLAN - POWER/LIGHTING
E-100 SCALE: 1/4" = 1'-0" NORTH

WORK ITEM

- PROVIDE 4" POKE-THRU LEGRAND WIREMOLD #RC4ATCBK

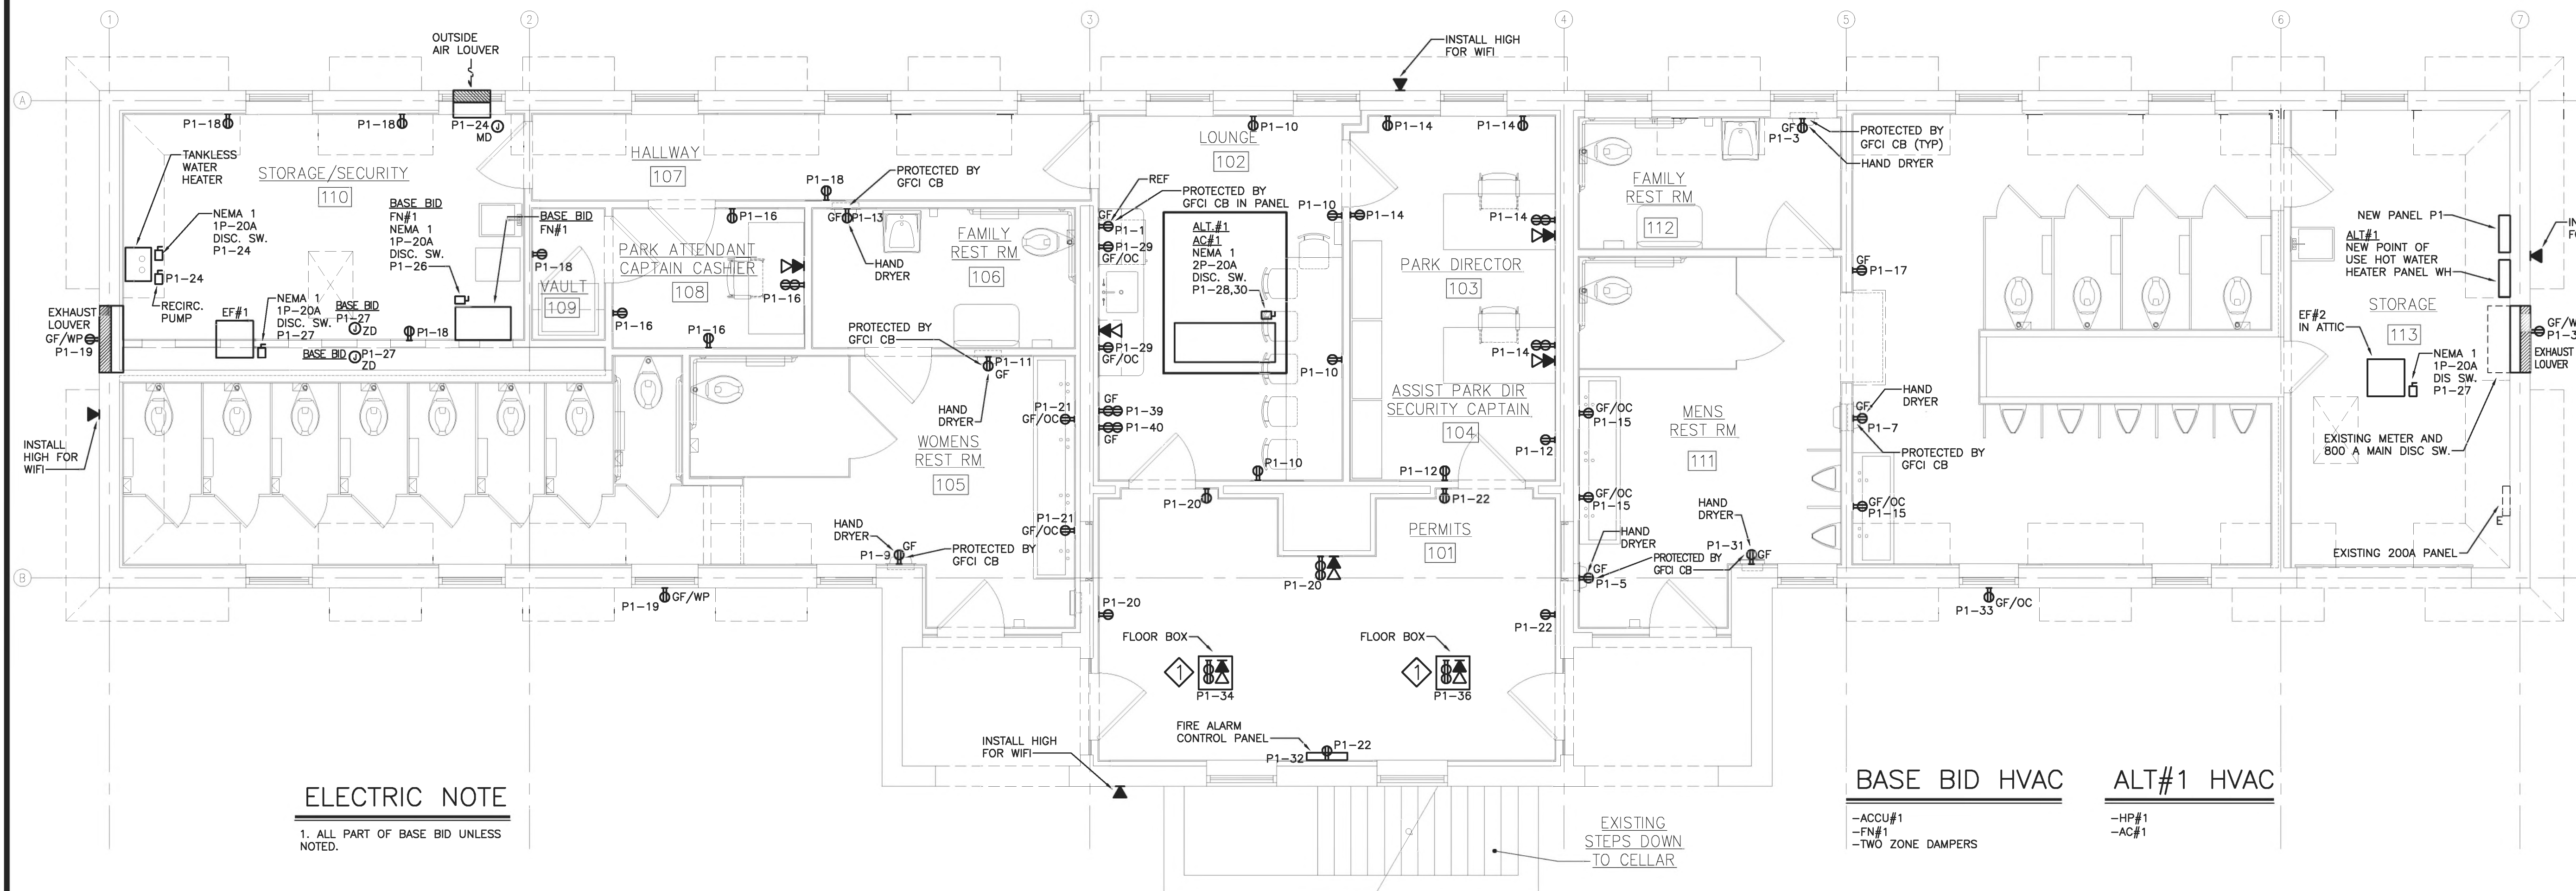

ELECTRIC NOTE
1. ALL PART OF BASE BID UNLESS NOTED.

BASE BID HVAC
-ACCU#1
-FV#1
-TWO ZONE DAMPERS

ALT#1 HVAC
-HP#1
-AC#1

1 PROPOSED FLOOR PLAN - POWER
E-100 SCALE: 1/4" = 1'-0" NORTH