



545.5 WESTCHESTER AVENUE
 RYE BROOK, NY 10573
 914-937-5596

RYE TOWN PARK BATH HOUSE
 RYE, NEW YORK, 10580


DATE	ISSUE TO	PR	TO
01.18.22	ISSUANCE FOR CDBG		--
08.02.22	ISSUANCE FOR PRICING		--
06.26.25	ISSUE FOR PERMIT		--
07.07.25	ISSUE FOR BIDS		--

NO	DATE	REVISIONS	BY


ELECTRIC - LIGHTING
PROPOSED FLOOR PLAN & LIGHTING FIXTURE SCHEDULE

PROJECT NO.: 2201
 SCALE: AS ANOTED
 DRAWN BY:
 CHECKED BY:
 DATE: 12/13/21

E-101

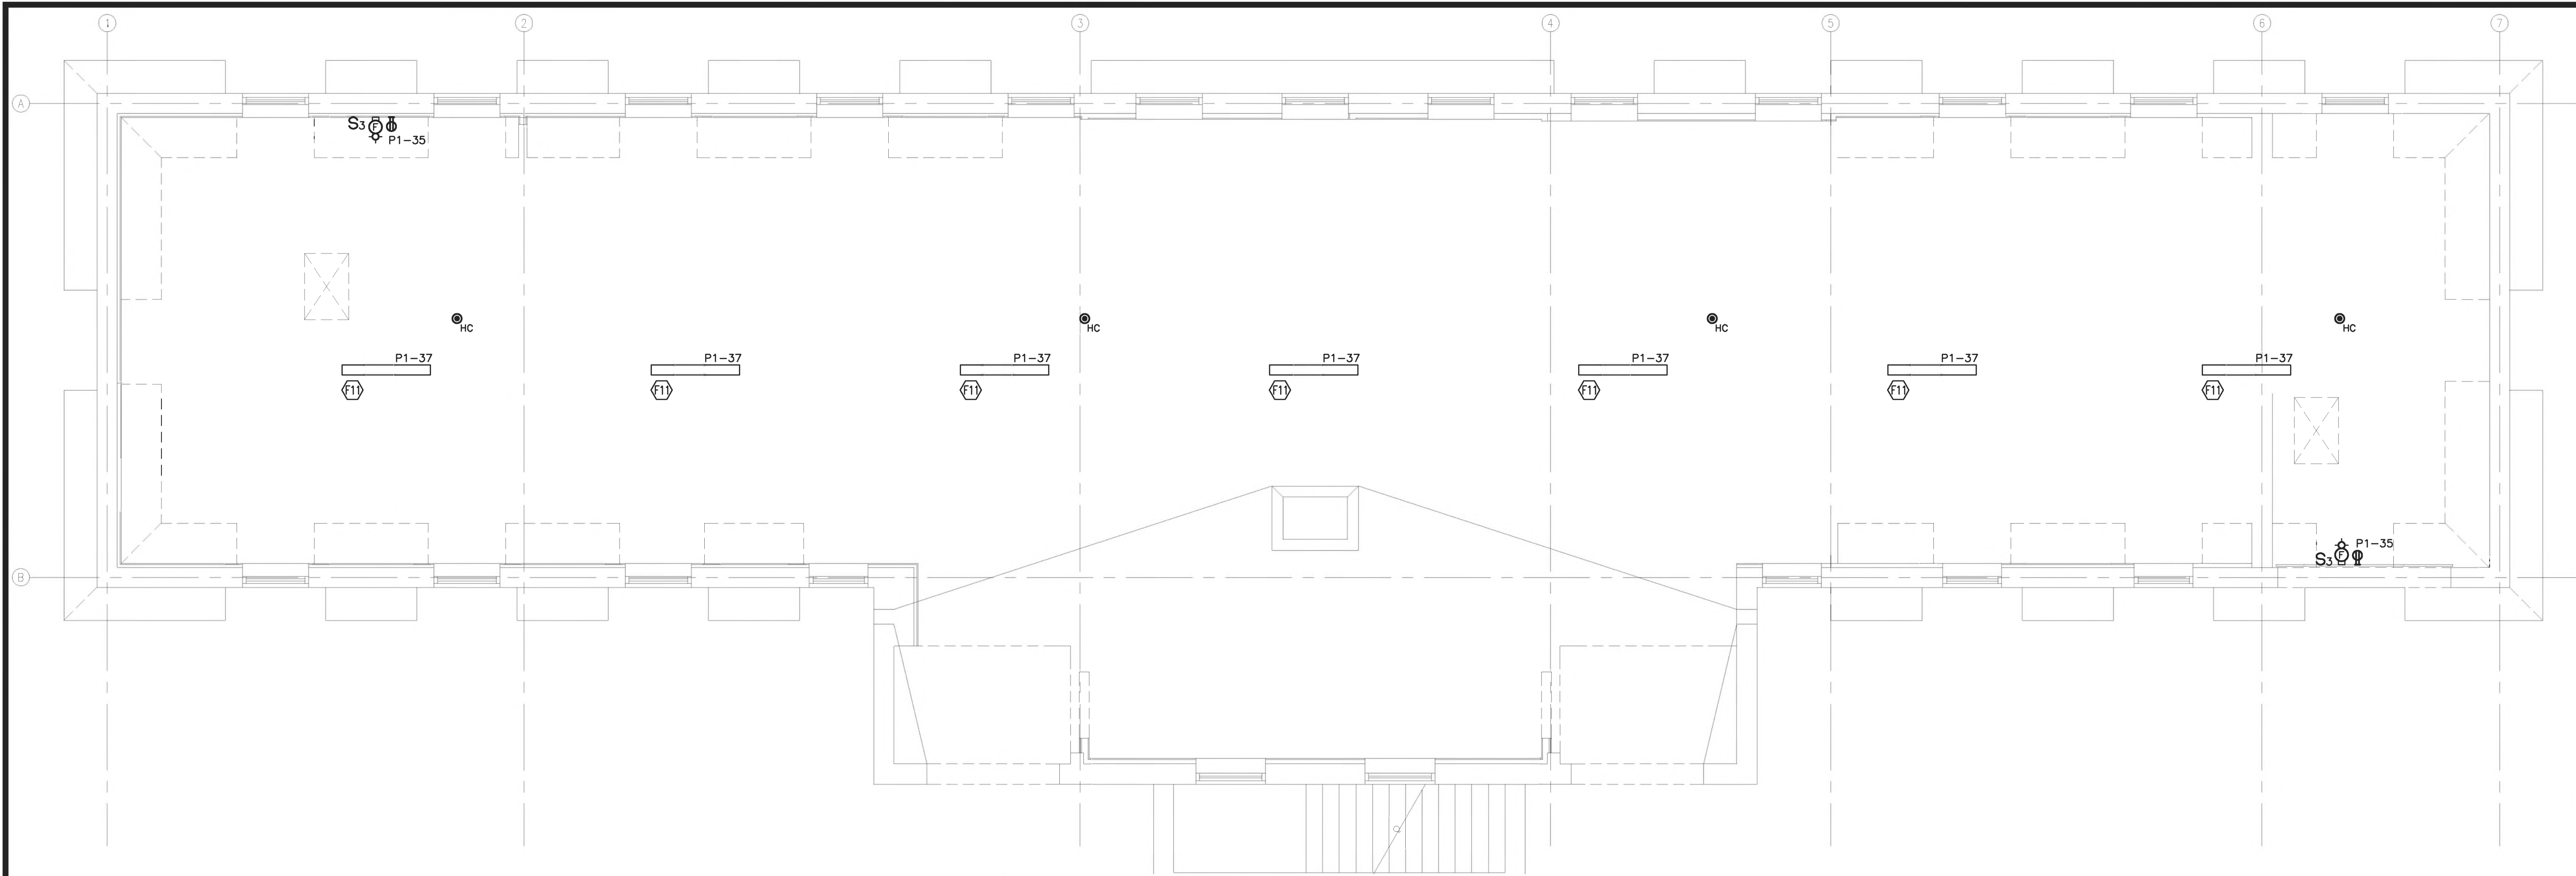

1
E-101
PROPOSED ATTIC PLAN - POWER/LIGHTING
 SCALE: 1/4" = 1'-0"

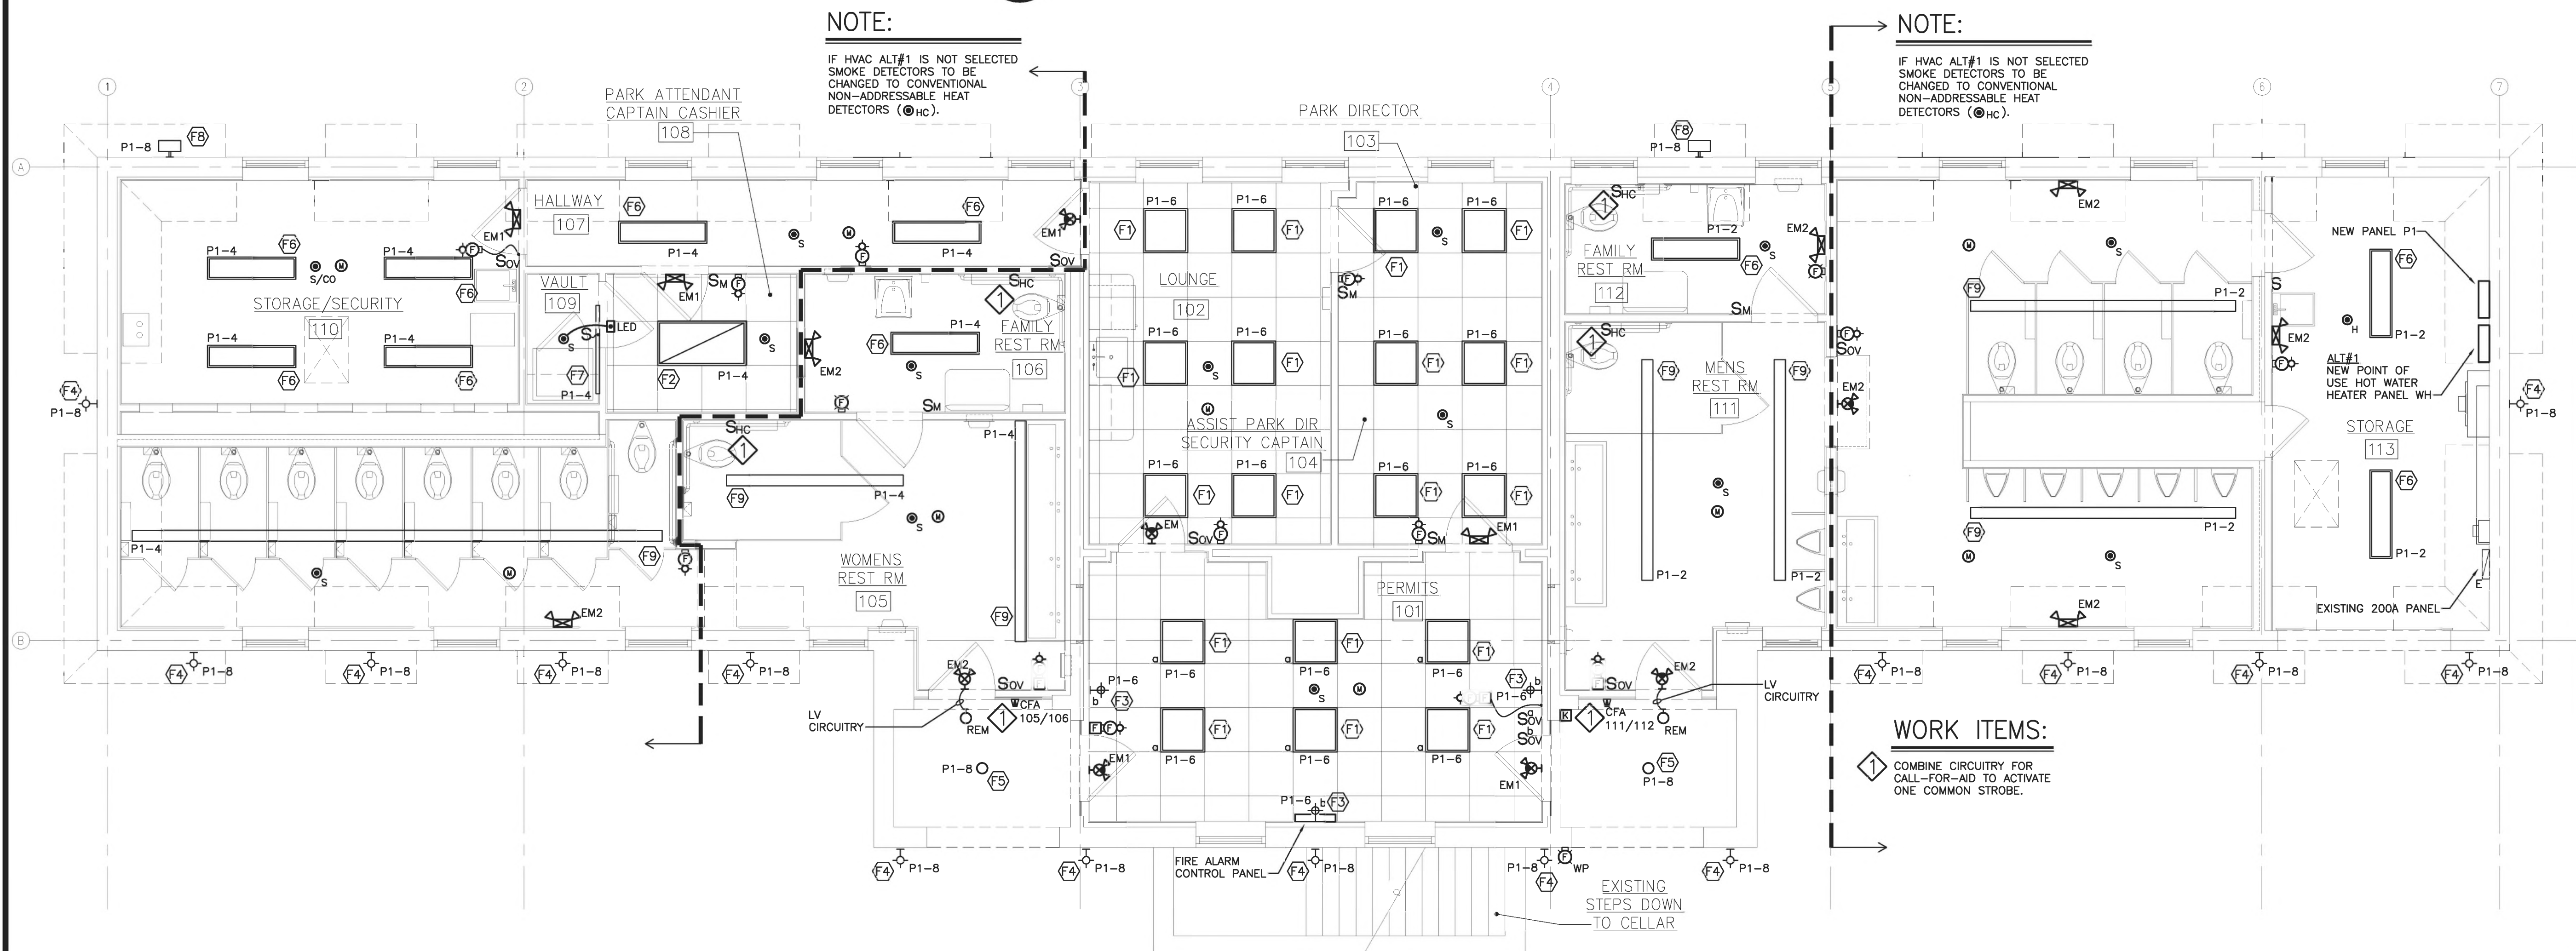

1
E-101
PROPOSED FLOOR PLAN - LIGHTING
 SCALE: 1/4" = 1'-0"