



545.5 WESTCHESTER AVENUE
 RYE BROOK, NY 10573
 914-937-5596

RYE TOWN PARK BATH HOUSE
 RYE, NEW YORK, 10580

DATE	ISSUE TO	PR	TO
01.18.22	ISSUANCE FOR CDBG		--
08.02.22	ISSUANCE FOR PRICING		--
06.26.25	ISSUE FOR PERMIT		--
07.07.25	ISSUE FOR BIDS		--

NO	DATE	REVISIONS	BY

**HVAC
 PROPOSED FLOOR PLAN , PARTIAL
 ROOF PLAN & SECTION**

PROJECT NO.: 2201
 SCALE: AS ANOTED
 DRAWN BY:
 CHECKED BY:
 DATE: 12/13/21

H-100

HVAC LEGEND


SYMBOL	DESCRIPTION	SYMBOL	DESCRIPTION
	SUPPLY DUCT		THERMOMETER W/ PETCOCK
	RETURN/EXHAUST DUCT		AIR VENT W/ PETCOCK
	FLEXIBLE CONNECTION		THERMOSTAT
	EXPANSION JOINT		SWITCH FOR EXHAUST FAN
	EXISTING		EMERGENCY DISCONNECT
	CONNECT TO EXISTING		COMBINATION BALANCING SHUT-OFF VALVE
	PRESSURE GAUGE W/ PETCOCK		GATE VALVE

ABBREVIATIONS

A.C.	AIR CONDITIONING UNIT	G.P.H.	GALLONS PER HOUR
A.C.C.U.	AIR COOLED CONDENSING UNIT	G.P.M.	GALLONS PER MINUTE
A.D.	ACCESS DOOR	H.C.	HEATING CONTRACTOR
A.F.F.	ABOVE FINISHED FLOOR	L	REFRIGERANT LIQUID
A.F.G.	ABOVE FINISHED GRADE	M.D.	MOTORIZED DAMPER
A.T.C.	AUTOMATIC TEMPERATURE CONTROL	M.V.	MOTORIZED VALVE
B.D.D.	BACKDRAFT DAMPER	N.T.S.	NOT TO SCALE
C.D.	CEILING DIFFUSER	O.A.	OUTSIDE AIR
C.F.M.	CUBIC FEET PER MINUTE	Ø	DIAMETER
CND.	CONDENSATE (COOLING)	P.C.	PLUMBING CONTRACTOR
C.U.	CONDENSING UNIT	P.S.I.	POUNDS PER SQUARE INCH
DN	DOWN	R.A.	RETURN AIR
E.R.U.	ENRGY RECOVERY UNIT	REG.	RETURN/EXHAUST REGISTER
E.A.	EXHAUST AIR	R.U.	RELIEF UNIT
E.C.	ELECTRICAL CONTRACTOR	S	REFRIGERANT SUCTION
E.F.	EXHAUST FAN	S.A.	SUPPLY AIR
F.A.I.	FRESH AIR INTAKE	S.R.	SUPPLY REGISTER
FX	FLEXIBLE CONNECTION	T	THERMOSTAT
F.U.	FAN COIL UNIT	V.D.	VOLUME DAMPER
G.C.	GENERAL CONTRACTOR		

2 PARTIAL ROOF PLAN — HVAC
 H-100 SCALE: 1/4" = 1'-0" NORTH

3 SECTION — HVAC
 H-100 SCALE: 1/4" = 1'-0"

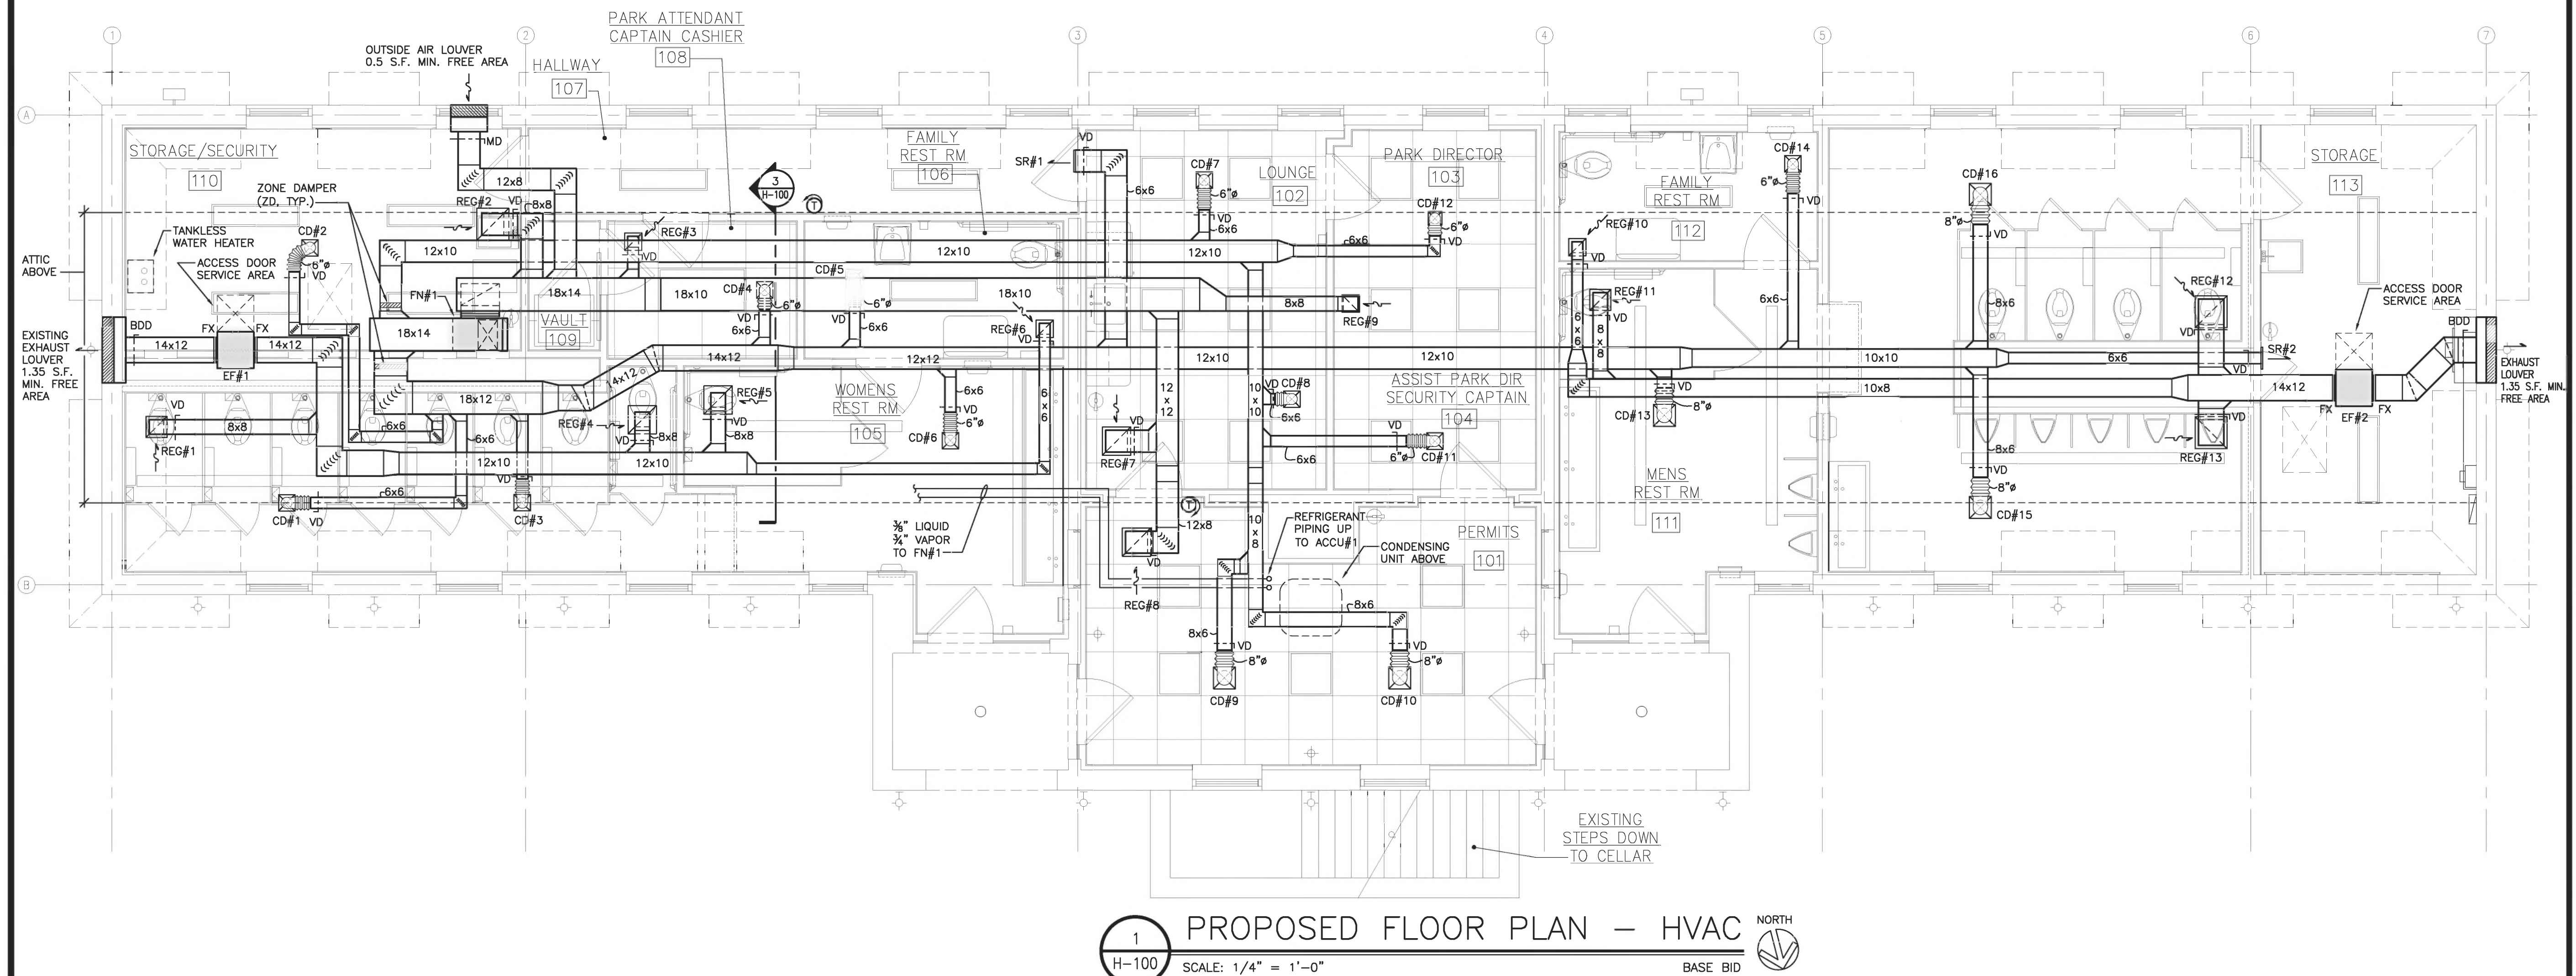

1 PROPOSED FLOOR PLAN — HVAC
 H-100 SCALE: 1/4" = 1'-0" NORTH
 BASE BID