



RYE TOWN PARK BATH HOUSE
RYE, NEW YORK, 10580

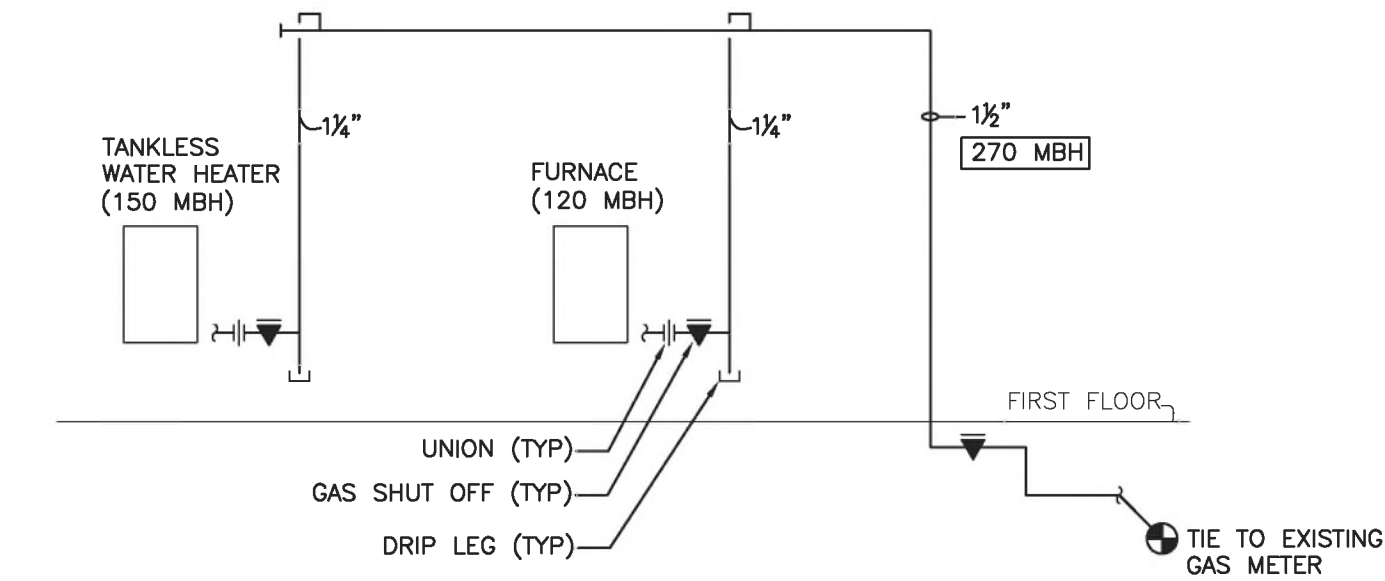


3 GAS RISER DIAGRAM
P-101 NOT TO SCALE

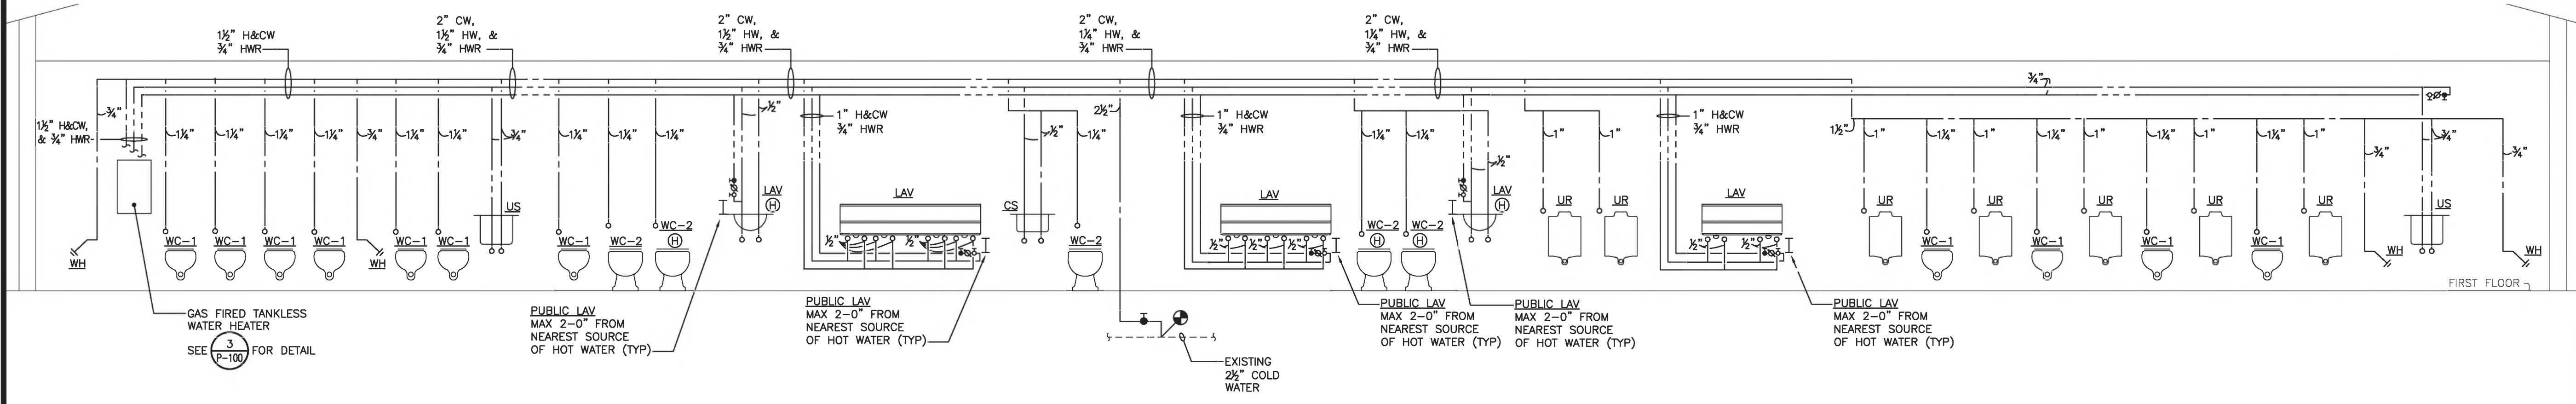

2 WATER RISER DIAGRAM
P-101 NOT TO SCALE

NOTE:
EACH HOT & COLD WATER SUPPLY TO EACH FIXTURE SHALL BE INDIVIDUALLY VALVED

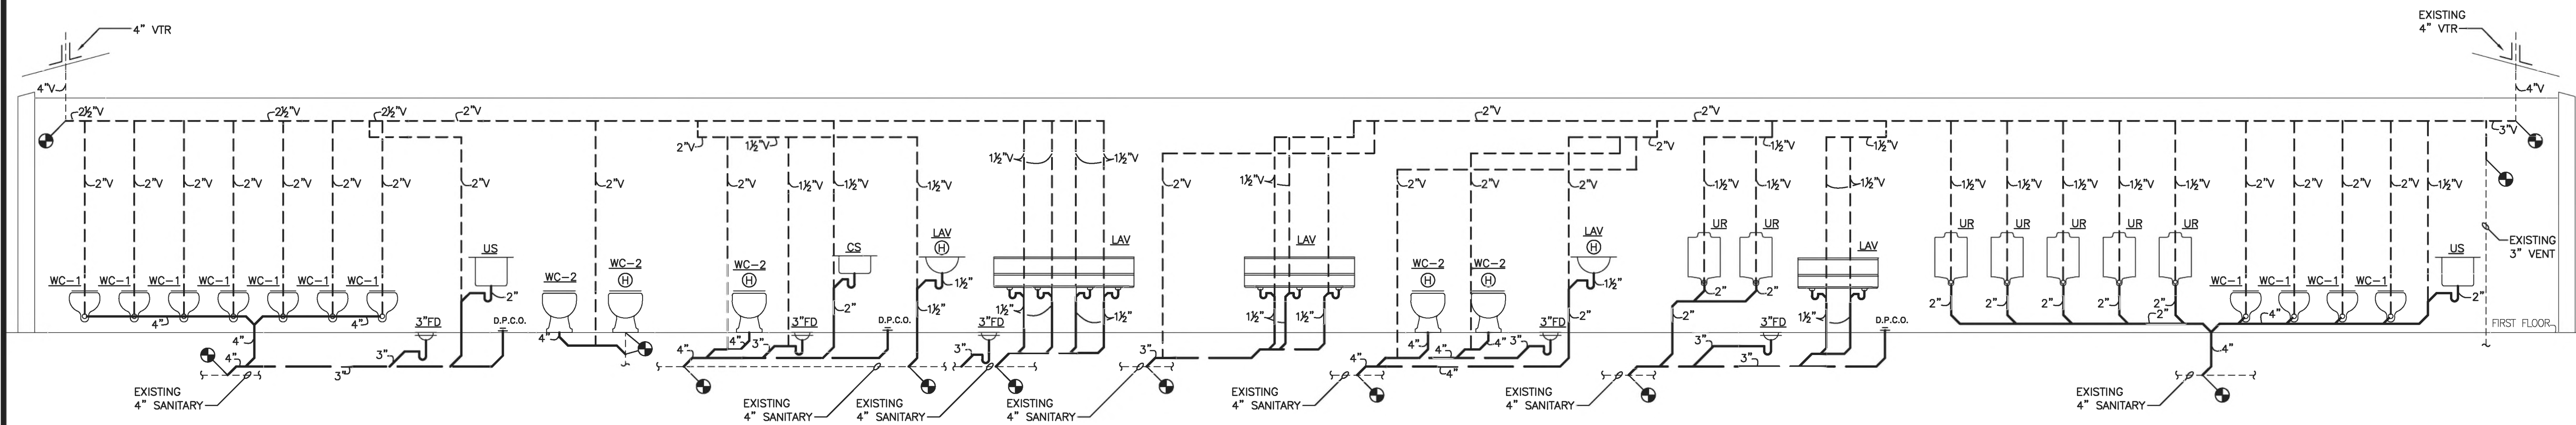

1 SANITARY RISER DIAGRAM
P-101 NOT TO SCALE

DATE	ISSUE TO	PR	TO
01.18.22	ISSUANCE FOR CDBG		--
08.02.22	ISSUANCE FOR PRICING		--
06.26.25	ISSUE FOR PERMIT		--
07.07.25	ISSUE FOR BIDS		--

NO	DATE	REVISIONS	BY

PLUMBING GAS, WATER & SANITARY RISER	PROJECT NO.:	2201
	SCALE:	AS ANOTED
	DRAWN BY:	
	CHECKED BY:	
	DATE:	12/13/21