



545.5 WESTCHESTER AVENUE
 RYE BROOK, NY 10573
 914-937-5596

RYE TOWN PARK BATH HOUSE
 RYE, NEW YORK, 10580

DATE	ISSUE TO	PR	TO
01.18.22	ISSUANCE FOR CDBG		--
08.02.22	ISSUANCE FOR PRICING		--
06.26.25	ISSUE FOR PERMIT		--
07.07.25	ISSUE FOR BIDS		--

NO	DATE	REVISIONS	BY

PLUMBING FLOOR PLAN, PARTIAL CELLAR PLAN, LEGEND & DETAIL

PROJECT NO.: 2201
 SCALE: AS ANOTED
 DRAWN BY:
 CHECKED BY:
 DATE: 12/13/21

P-100


SYMBOL	DESCRIPTION
---	ABOVE GROUND SOIL AND/OR WASTE PIPING
---	UNDERGROUND SOIL AND/OR WASTE PIPING
---	UNDERGROUND SANITARY PIPING (EXISTING)
---	VENT PIPING
---	EXISTING VENT PIPING
---	COLD WATER PIPING
---	HOT WATER PIPING (110')
---	HOT WATER RECIRCULATING PIPING (H.W.R.)
---	EXISTING HOT WATER PIPING
---	EXISTING HOT WATER RETURN PIPING
---	GAS PIPING (G.)
---	SHUT-OFF VALVE
---	GLOBE VALVE
---	CHECK VALVE
---	GAS SHUT-OFF VALVE
---	CLEANOUT (C.O.)
---	DECK PLATE CLEANOUT (D.P.C.O.)
---	UNION
---	SHOCK ARRESTOR
---	HANDICAPPED FACILITY
---	NEW CONNECTION TO EXISTING FACILITY
---	SQUARE FEET
---	PLUMBING STACK No. 1
---	DETAIL No. 1, DRAWING P-1

SYMBOL	DESCRIPTION
AFF	ABOVE FINISHED FLOOR
AFG	ABOVE FINISHED GRADE
BFP	BACK FLOW PREVENTER
BWV	BACK WATER VALVE
CLG	CEILING
CO	CLEAN OUT
CW	COLD WATER
DN	DOWN
DPCO	DECK PLATE CLEAN OUT
FAI	FRESH AIR INLET
FD	FLOOR DRAIN
FS	FLOOR SINK
FU	FIXTURE UNIT
HB	HOSE BIBB (18" A.F.F.)
HW	HOT WATER
HWR	HOT WATER RECIRCULATING
RD	ROOF DRAIN
RPZ	REDUCED PRESSURE ZONE
SA	SHOCK ARRESTOR
SK	SINK
U/G	UNDERGROUND
VTR	VENT THROUGH ROOF
WCO	WALL CLEANOUT
WH	WALL HYDRANT

FIXTURE	DESIGNATION	WASTE	VENT	H.W 110'	H.W 140'	C.W
WATER CLOSET	WC-1/WC-2	4"	2"	--	--	1 1/4"
URINAL	UR.	2"	1 1/2"	--	--	1"
LAVATORY	LAV.	1 1/2"	1 1/2"	1/2"	--	1/2"
COUNTER SINK	C.S.	2"	2"	1/2"	--	1/2"
SINK	S.K.	2"	1 1/2"	1/2"	--	1/2"
UTILITY SINK	U.S.	2"	1 1/2"	3/4"	--	3/4"


NOTE: EACH HOT & COLD WATER SUPPLY TO EACH FIXTURE SHALL BE INDIVIDUALLY VALVED.
 Φ = PROVIDE WITH SHOCK ARRESTORS

NOTE:
 REFER TO ACCESSIBLE STANDARDS ON ARCHITECTURAL DRAWINGS FOR LOCATION OF ALL CONTROLS.

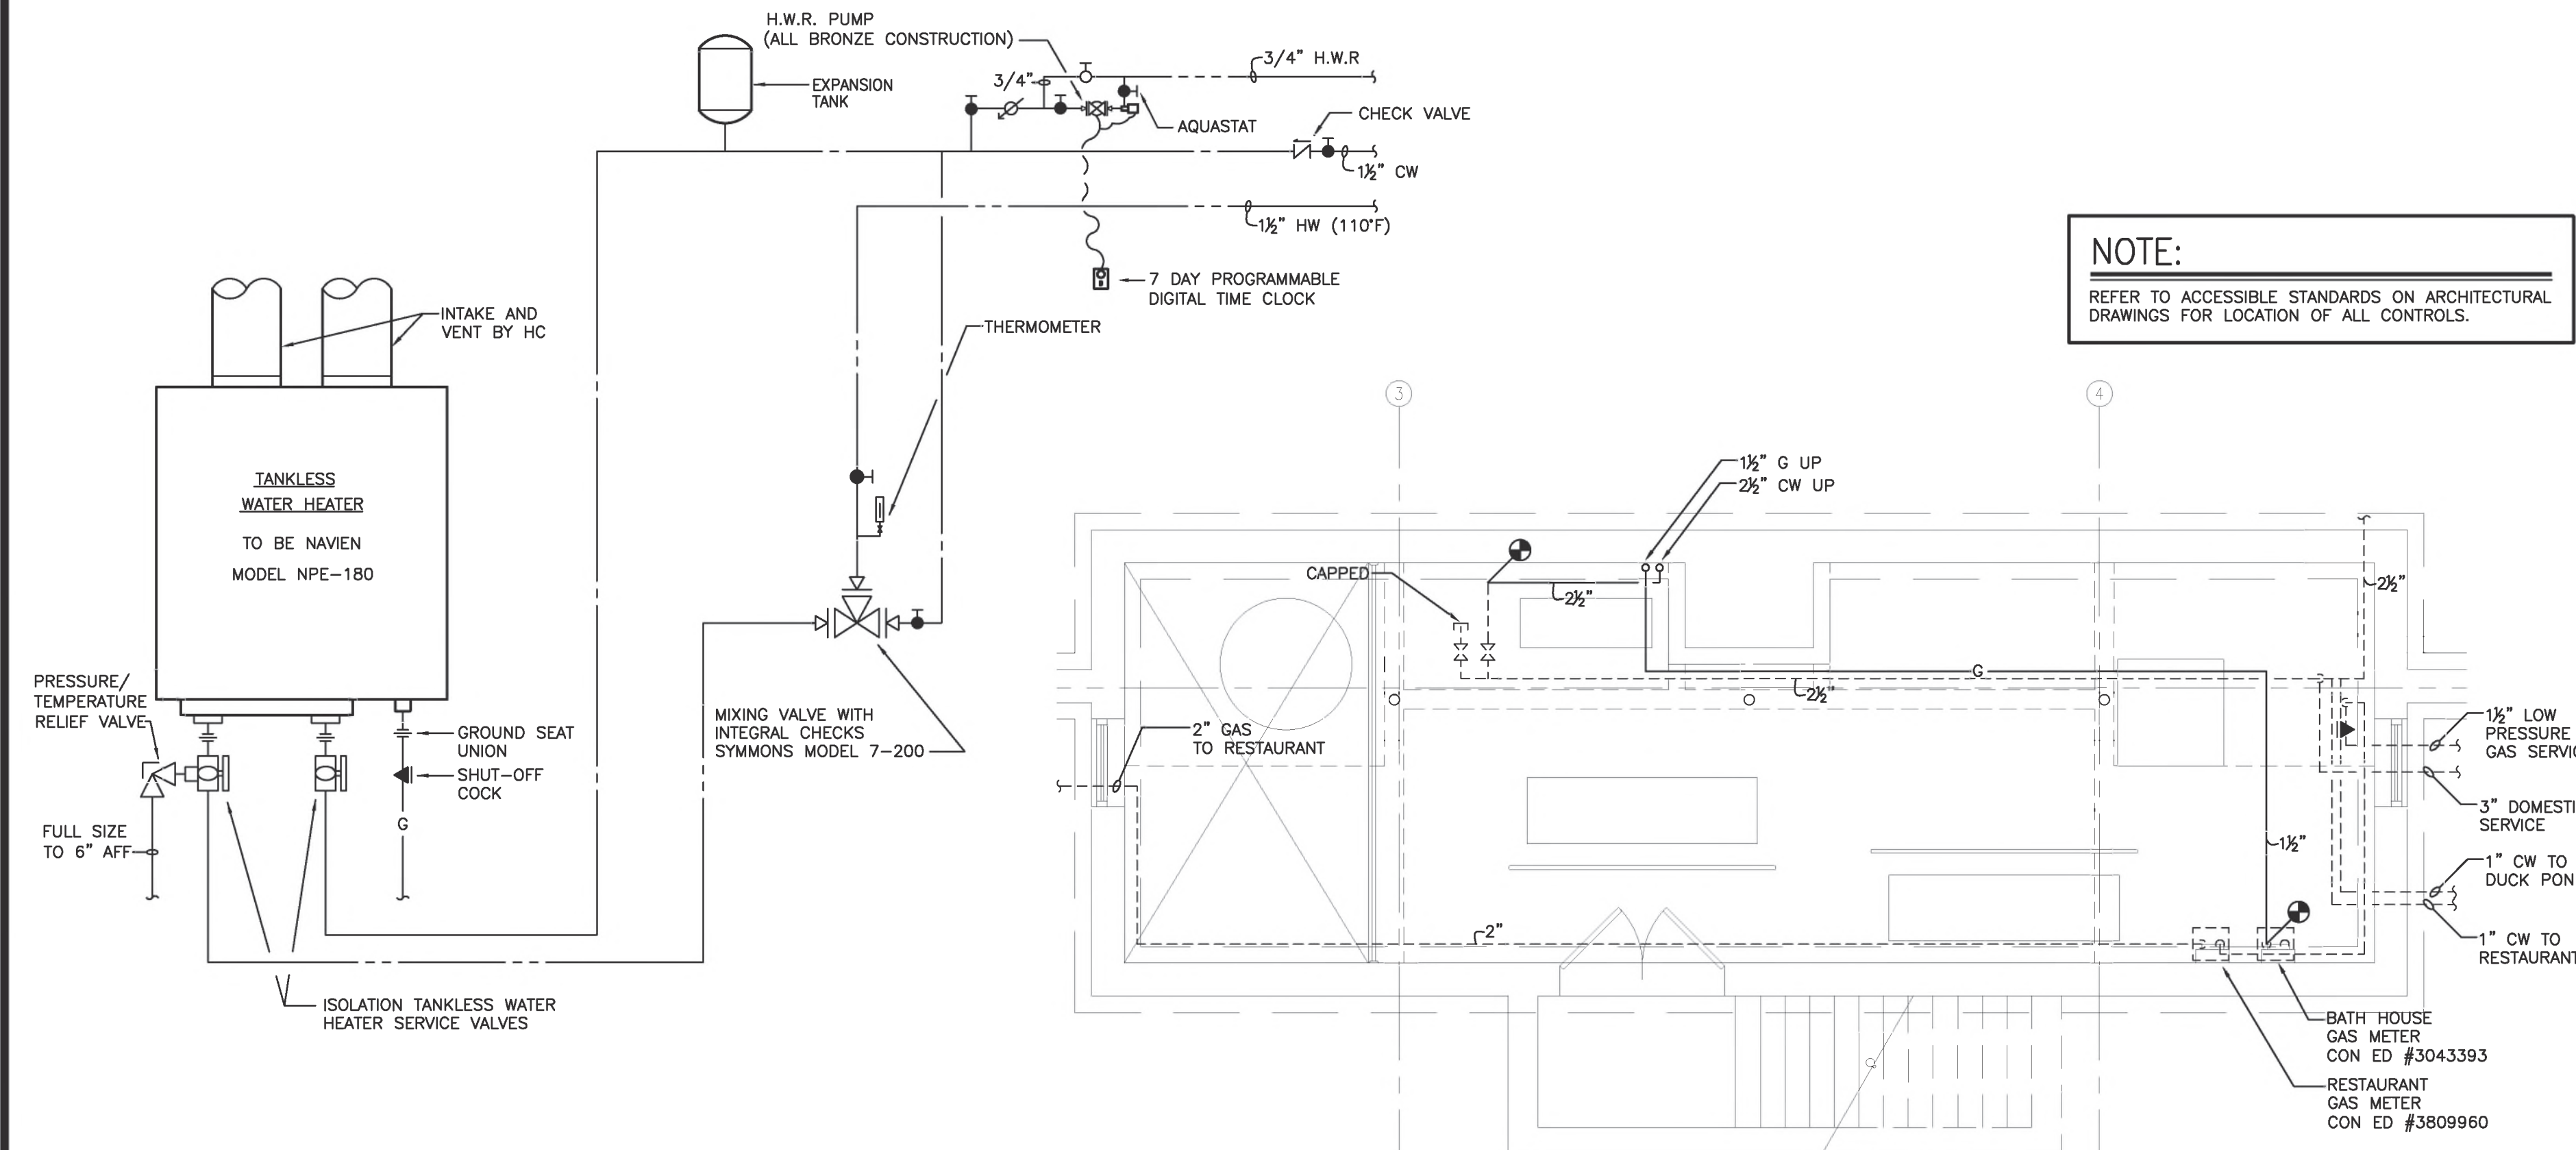

3 TANKLESS WATER HEATER PIPING
 P-100 NOT TO SCALE

2 CELLAR PLAN - PLUMBING
 P-100 SCALE: 1/4" = 1'-0"

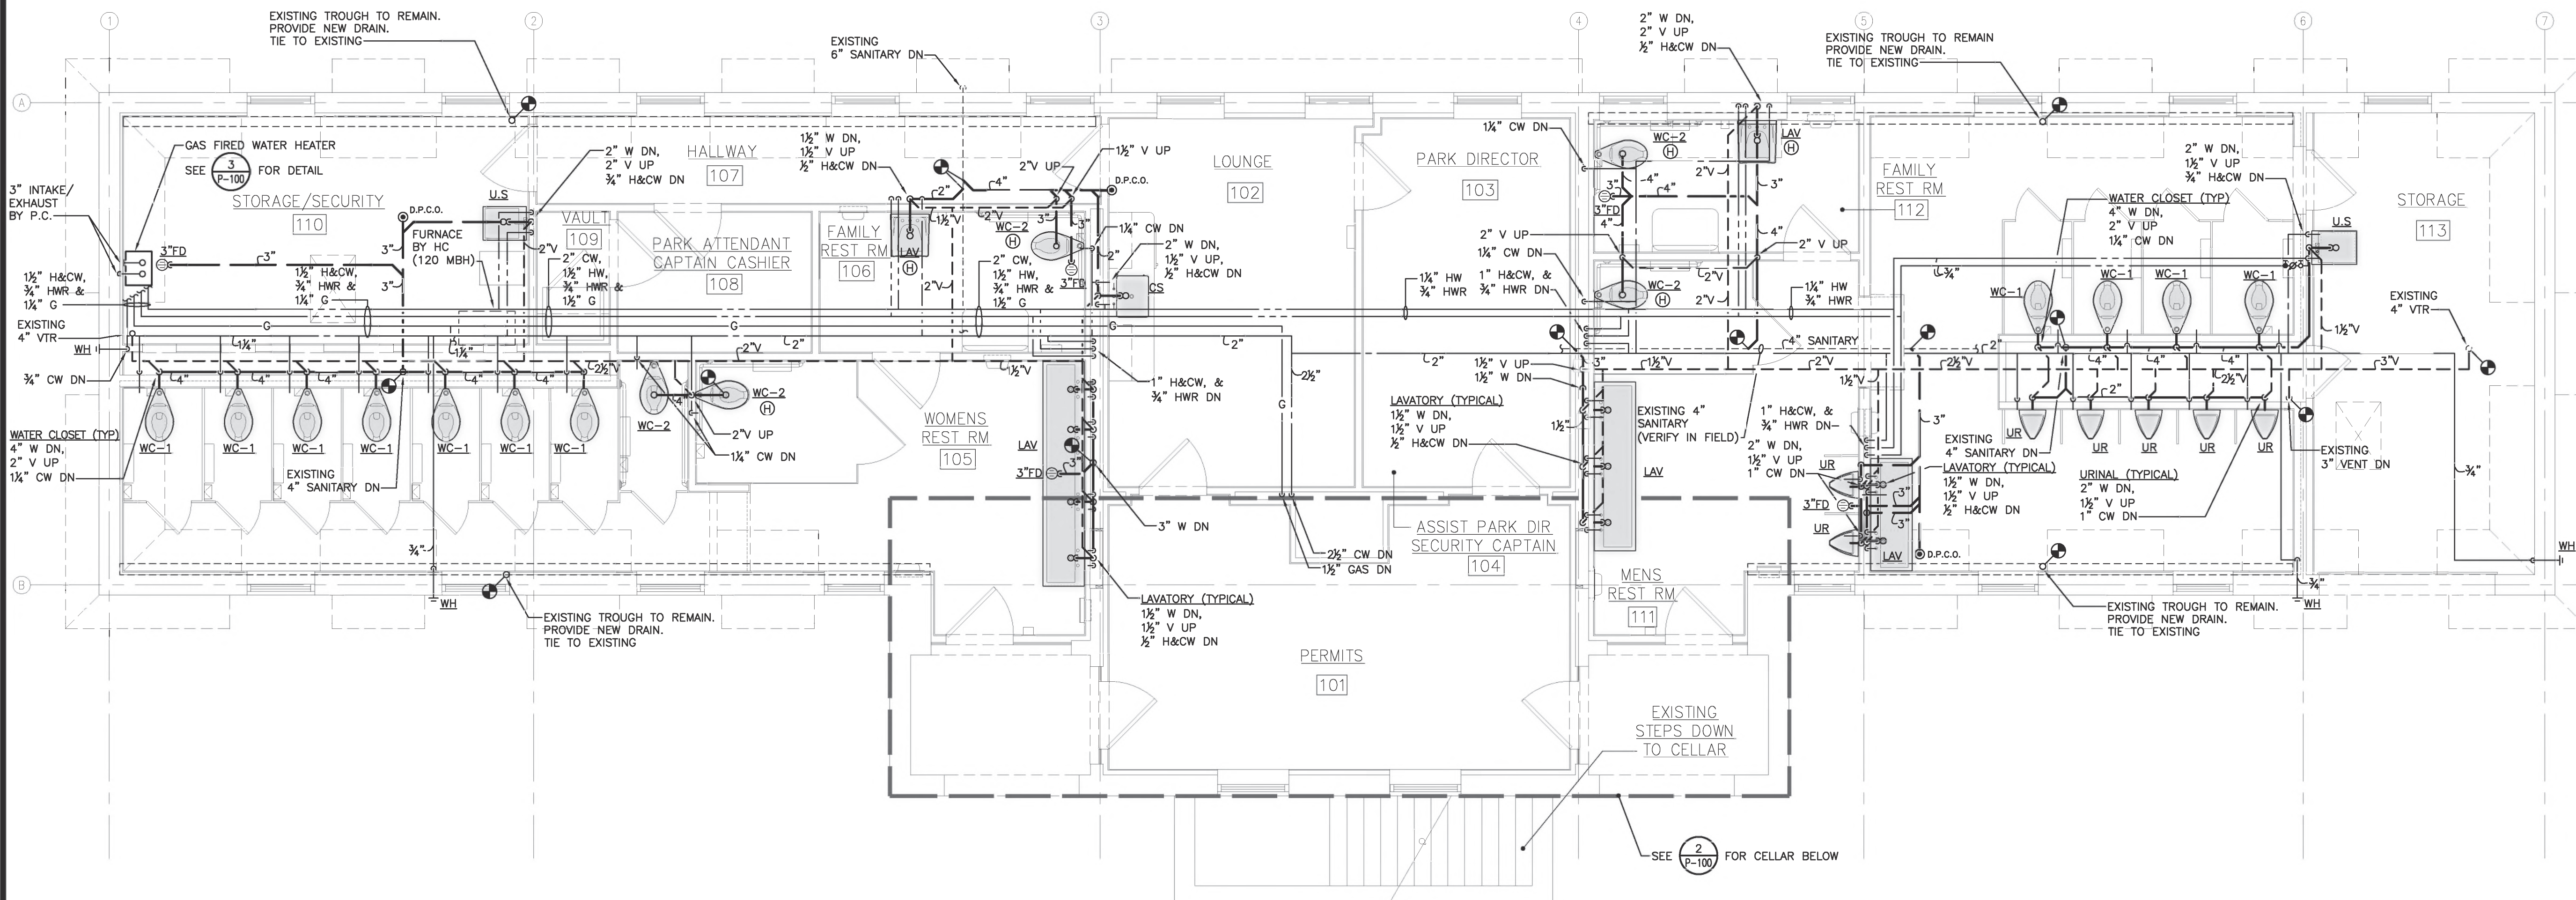


1 PROPOSED FLOOR PLAN - PLUMBING
 P-100 SCALE: 1/4" = 1'-0"




545.5 WESTCHESTER AVENUE
RYE BROOK, NY 10573
914-937-5596

RYE TOWN PARK BATH HOUSE
RYE, NEW YORK, 10580

DATE	ISSUE TO	PR	TO
01.18.22	ISSUANCE FOR CDBG		--
08.02.22	ISSUANCE FOR PRICING		--
06.26.25	ISSUE FOR PERMIT		--
07.07.25	ISSUE FOR BIDS		--

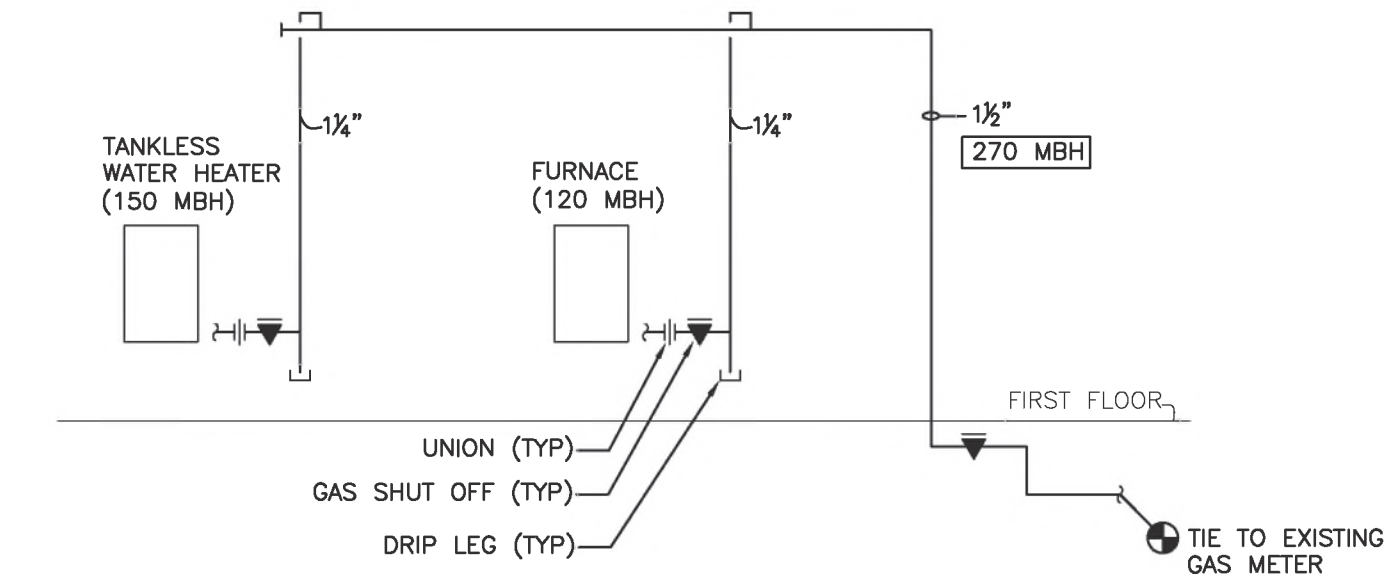


3 GAS RISER DIAGRAM
P-101 NOT TO SCALE

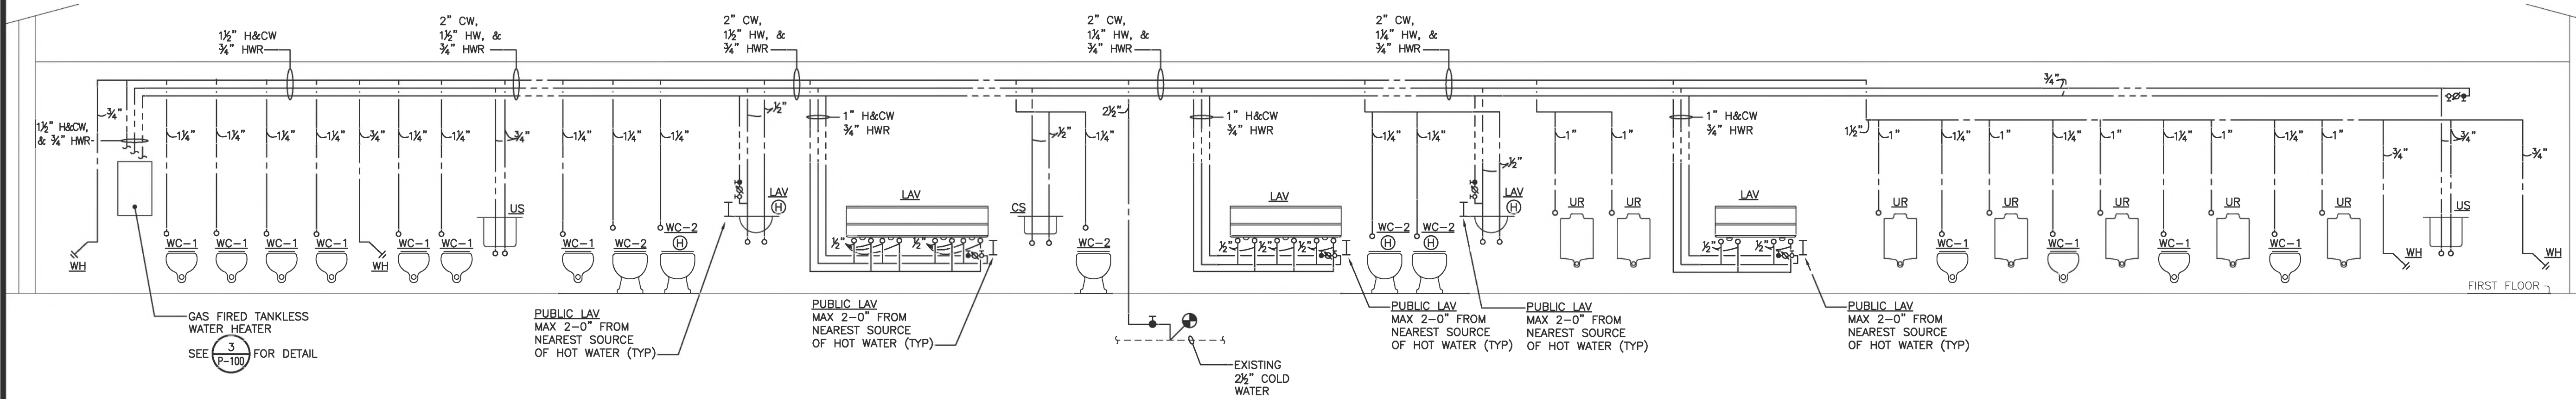

2 WATER RISER DIAGRAM
P-101 NOT TO SCALE

NOTE:
EACH HOT & COLD WATER SUPPLY TO EACH FIXTURE
SHALL BE INDIVIDUALLY VALVED

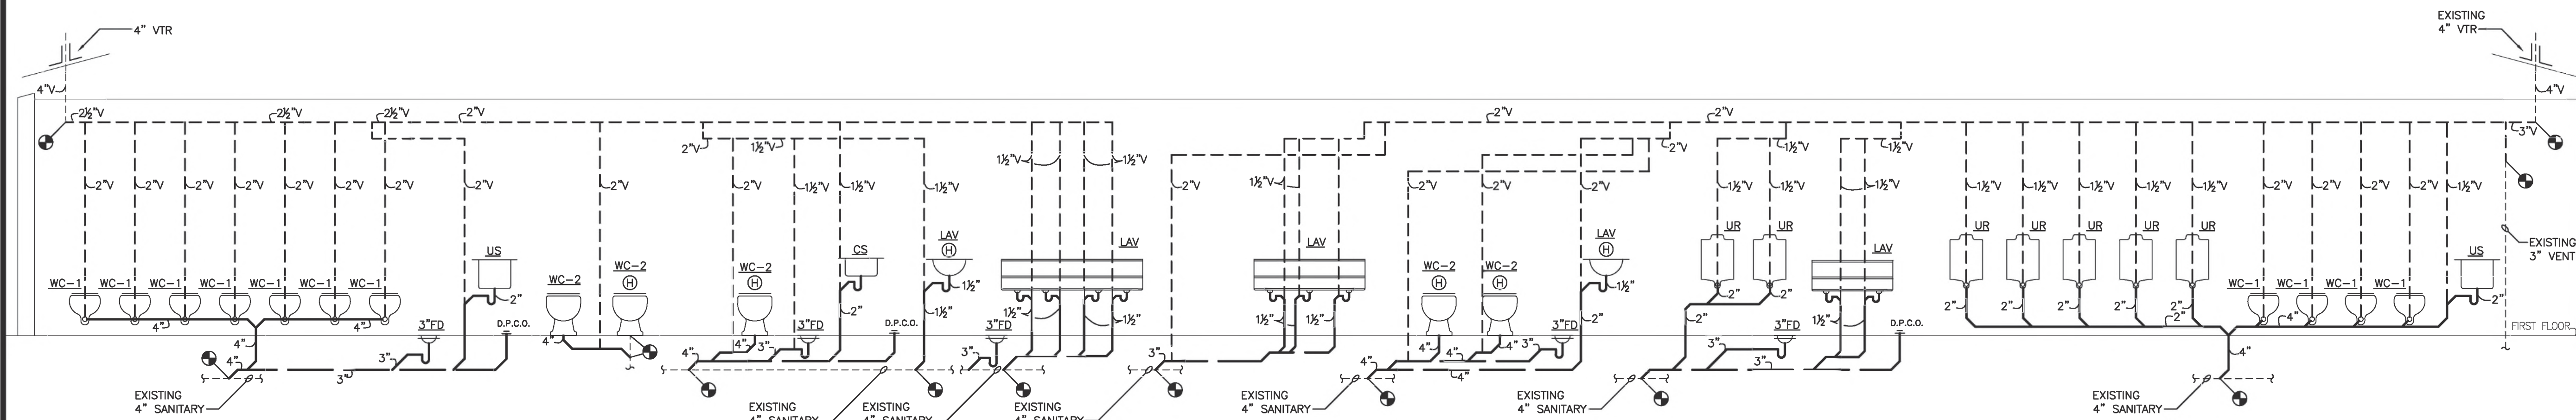

1 SANITARY RISER DIAGRAM
P-101 NOT TO SCALE

NO	DATE	REVISIONS	BY
1	01.18.22	ISSUANCE FOR CDBG	CBH

PLUMBING
GAS, WATER & SANITARY
RISER

PROJECT NO.:	2201
SCALE:	AS ANOTED
DRAWN BY:	
CHECKED BY:	
DATE:	12/13/21