


H-101 DRAWING...

- 1 OPEN ENDED DUCT, CUT AT 45 DEGREE ANGLE.
- 2 RETURN GRILLE TO BE CENTERED ON DOOR FRAME, MOUNT AS HIGH AS POSSIBLE WHILE KEEPING ASSOCIATED DUCTWORK IN FIRST FLOOR CEILING SPACE.
- 3 PROVIDE PRICE RETURN AIR SILENCER (RAS) AT RETURN GRILLE. SIZE OF RAS TO MATCH RETURN GRILLE SIZE.

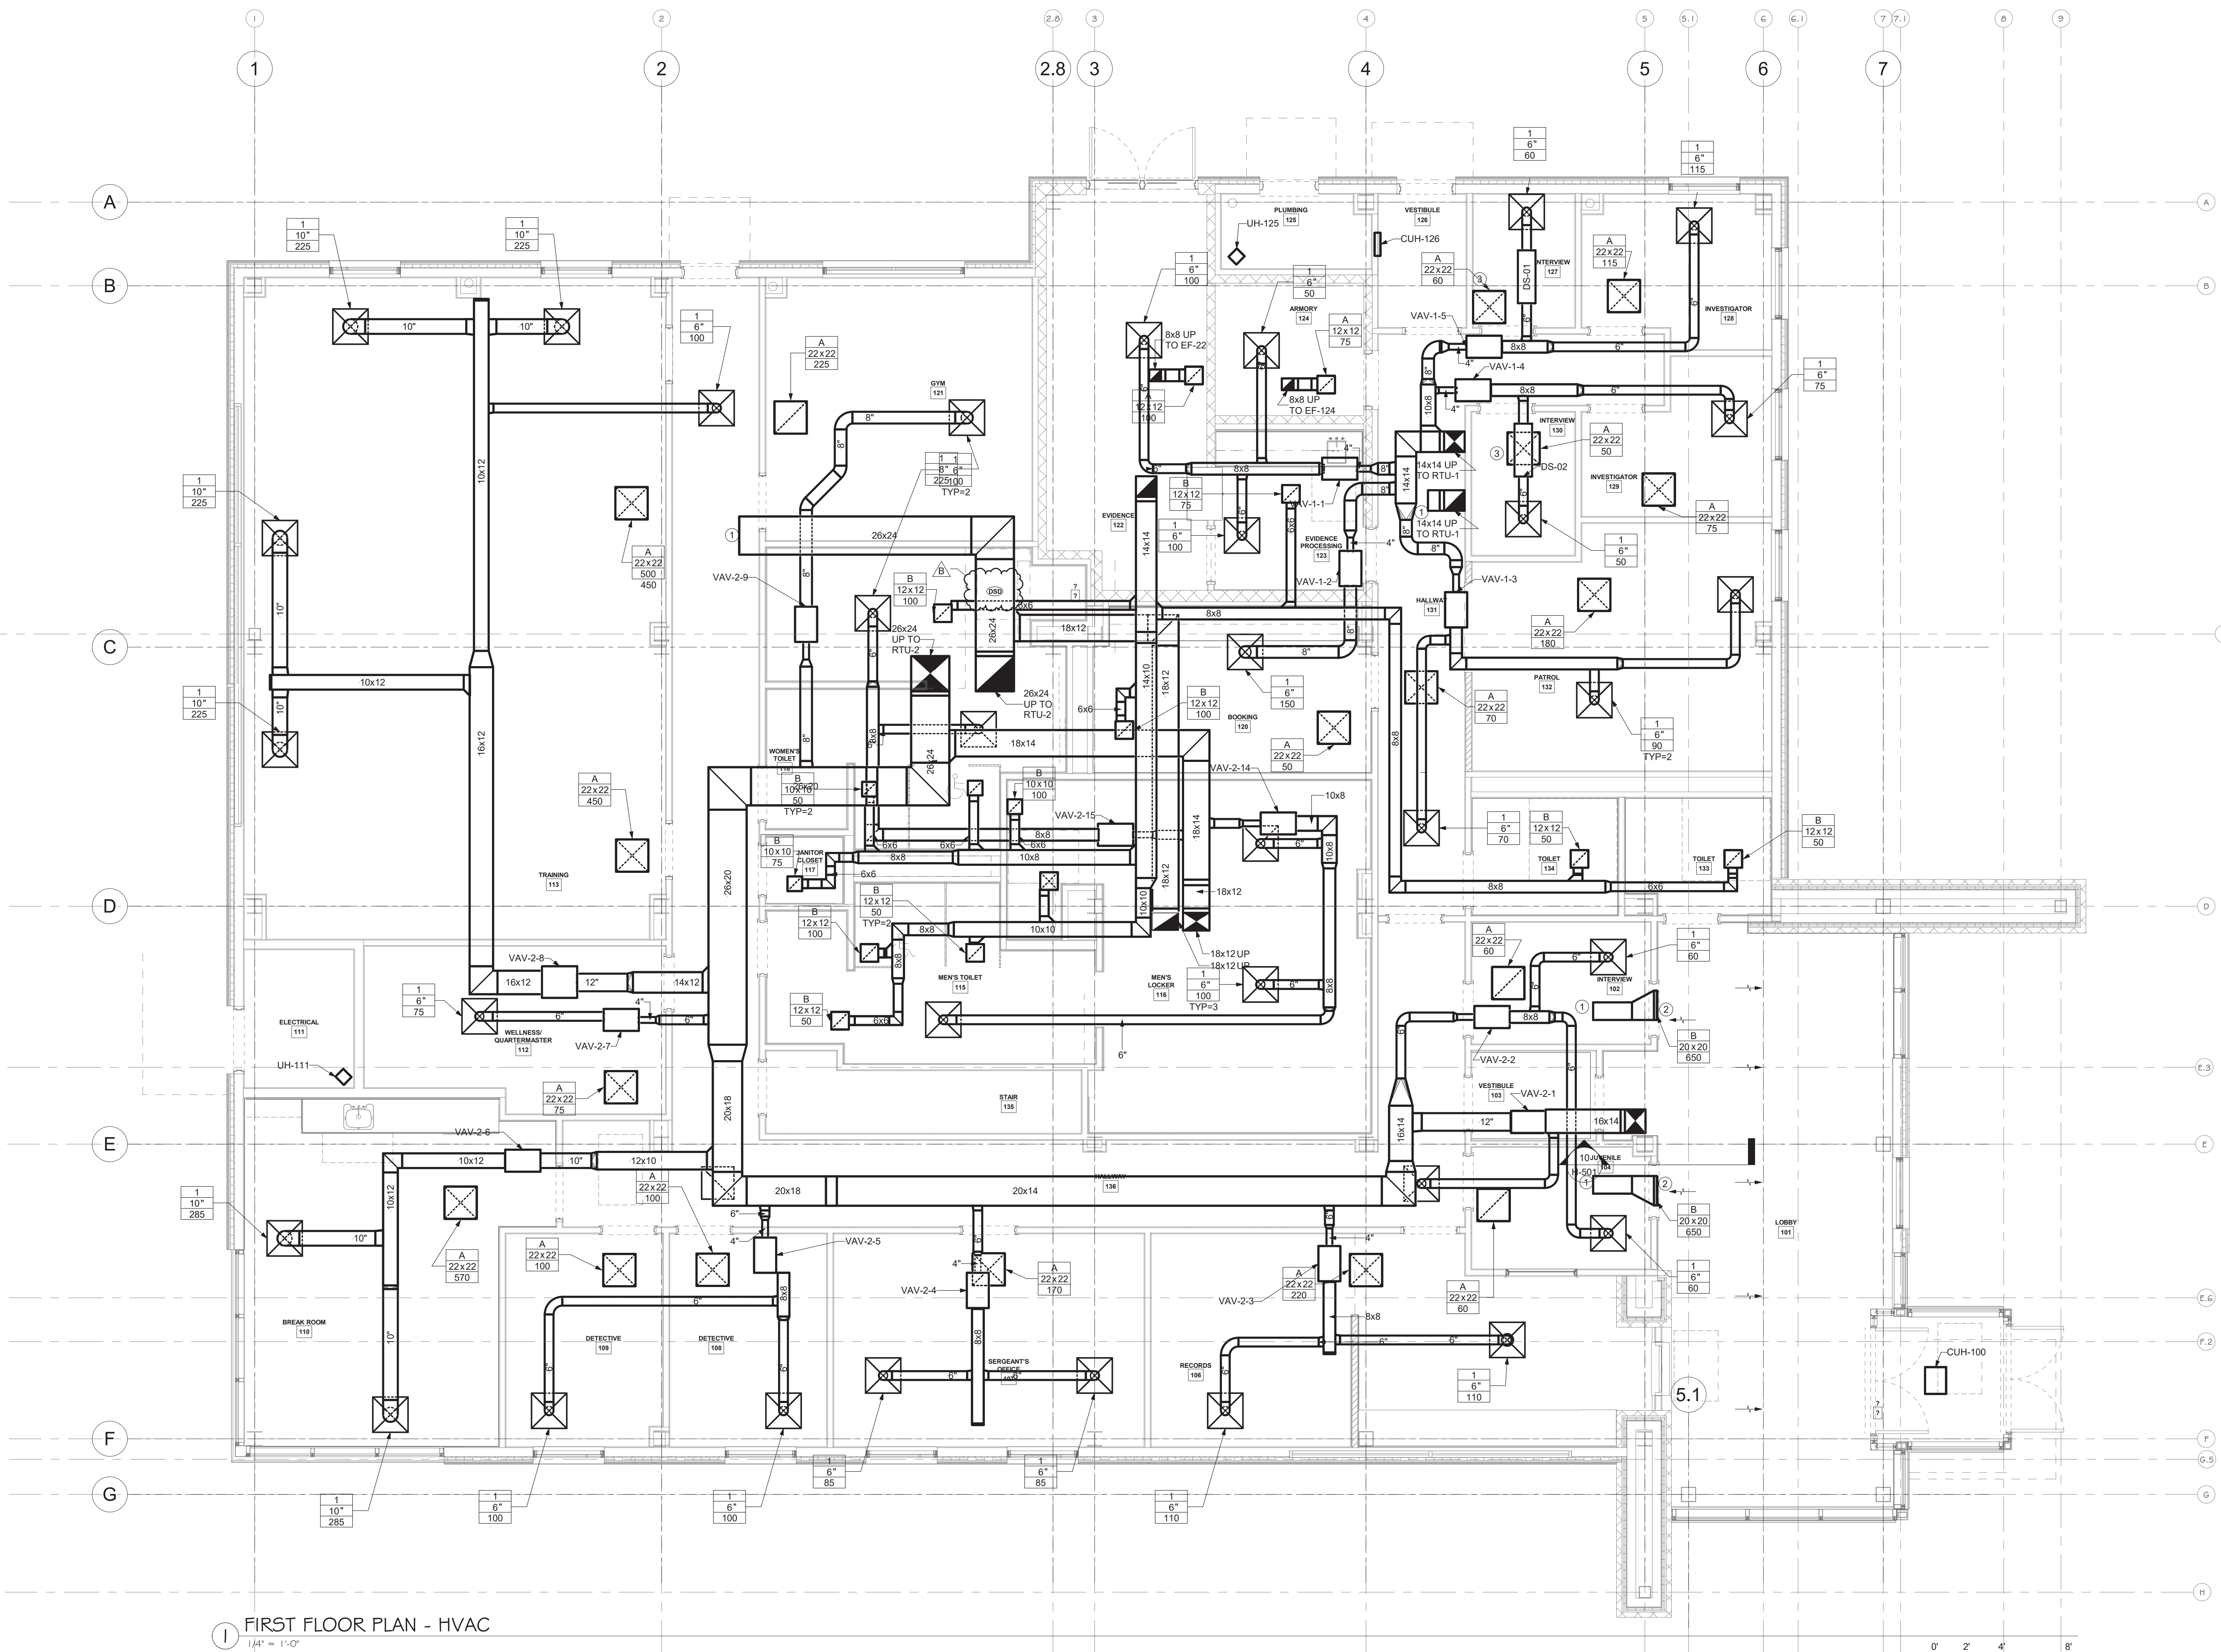

1 FIRST FLOOR PLAN - HVAC
1/4" = 1'-0"

ME ENGINEERING

Mechanical/Electrical Engineering Consultants

Capital District | Rochester | Buffalo | Syracuse

433 STATE STREET, 4TH FLOOR
SCHENECTADY, NY 12305

518.533.2171
www.meengineering.com

REVISIONS:

NUM.	DATE	DESCRIPTION
B	04/25/25	ADDENDUM 3

100% BID DOCUMENTS

KEY PLAN

ARCHITECTS

25 WALLKILL AVE • MONTGOMERY • NY 12549
O. 845.294.2724 | F. 888.305.6442
WWW.ADGARCHITECT.COM
CONTACT@ADGARCHITECT.COM

ARCHITECTURE • PLANNING • INTERIORS

Project: TOWN OF MONTGOMERY POLICE STATION
110 BRACKEN ROAD, MONTGOMERY,
NEW YORK 12549

Drawing: FIRST FLOOR PLAN - HVAC



Project: 23138 Date: 2/24/25

Drawn: JDH Scale: AS NOTED

Drawing Number:

H-101