

- RCP KEY NOTES:
- 1. SEE A-608 FOR LIGHTING AND CONTROL SCHEDULES.
 - 2. SEE A-108 FOR LIGHTING LAYOUT IN UTILITIES ROOMS.

ARCHITECT

di Domenico + Partners LLP

Architecture
Landscape Architecture
Planning
3743 Crescent Street, 3rd Floor
Long Island City, New York 11101
Tel 212-337-0400
Fax 212-337-3567

CIVIL PLANNING ENGINEER

JMC

JMC Planning Engineering Landscape
Architecture & Land Surveying, PLLC
120 Bedford Road
Armonk, New York 10504
Tel 914-273-5225
Fax 914-273-2102

MEP ENGINEER

Burns

BURNS ENGINEERING, PC.
1261 Broadway, Suite 708
New York, New York 10001
Tel 212-962-3503

STRUCTURAL ENGINEER

GEI

GEI50
1385 Broadway, 20th FL
New York, New York 10018
Tel 212-687-8282



MANHATTAN BEER DISTRIBUTORS
20 DUNNIGAN DRIVE
SUFFERN, NEW YORK


REV	DESCRIPTION	DATE
-	ISSUED FOR DOB SUBMISSION	9.10.21
-	ISSUED FOR BID	10.15.21
-	ISSUED FOR CONSTRUCTION	11.30.21
-	REVISED BID SET	01.20.22
-	REVISED FOR CONSTRUCTION	04.05.22
-	PER METAL PANEL REDESIGN	07.26.22
-	REVISED FOR CONSTRUCTION	08.15.22

DRAWN BY :	S. WOO
CHECKED BY :	D. TOBAR, R.A.
APPROVED BY :	A. BERGER, R.A.
DATE :	07.30.2021
SCALE :	AS NOTED

DRAWING TITLE :
PROPOSED RCP -
AS/RS WAREHOUSE
(SOUTH)

DWG NUMBER :

A-112

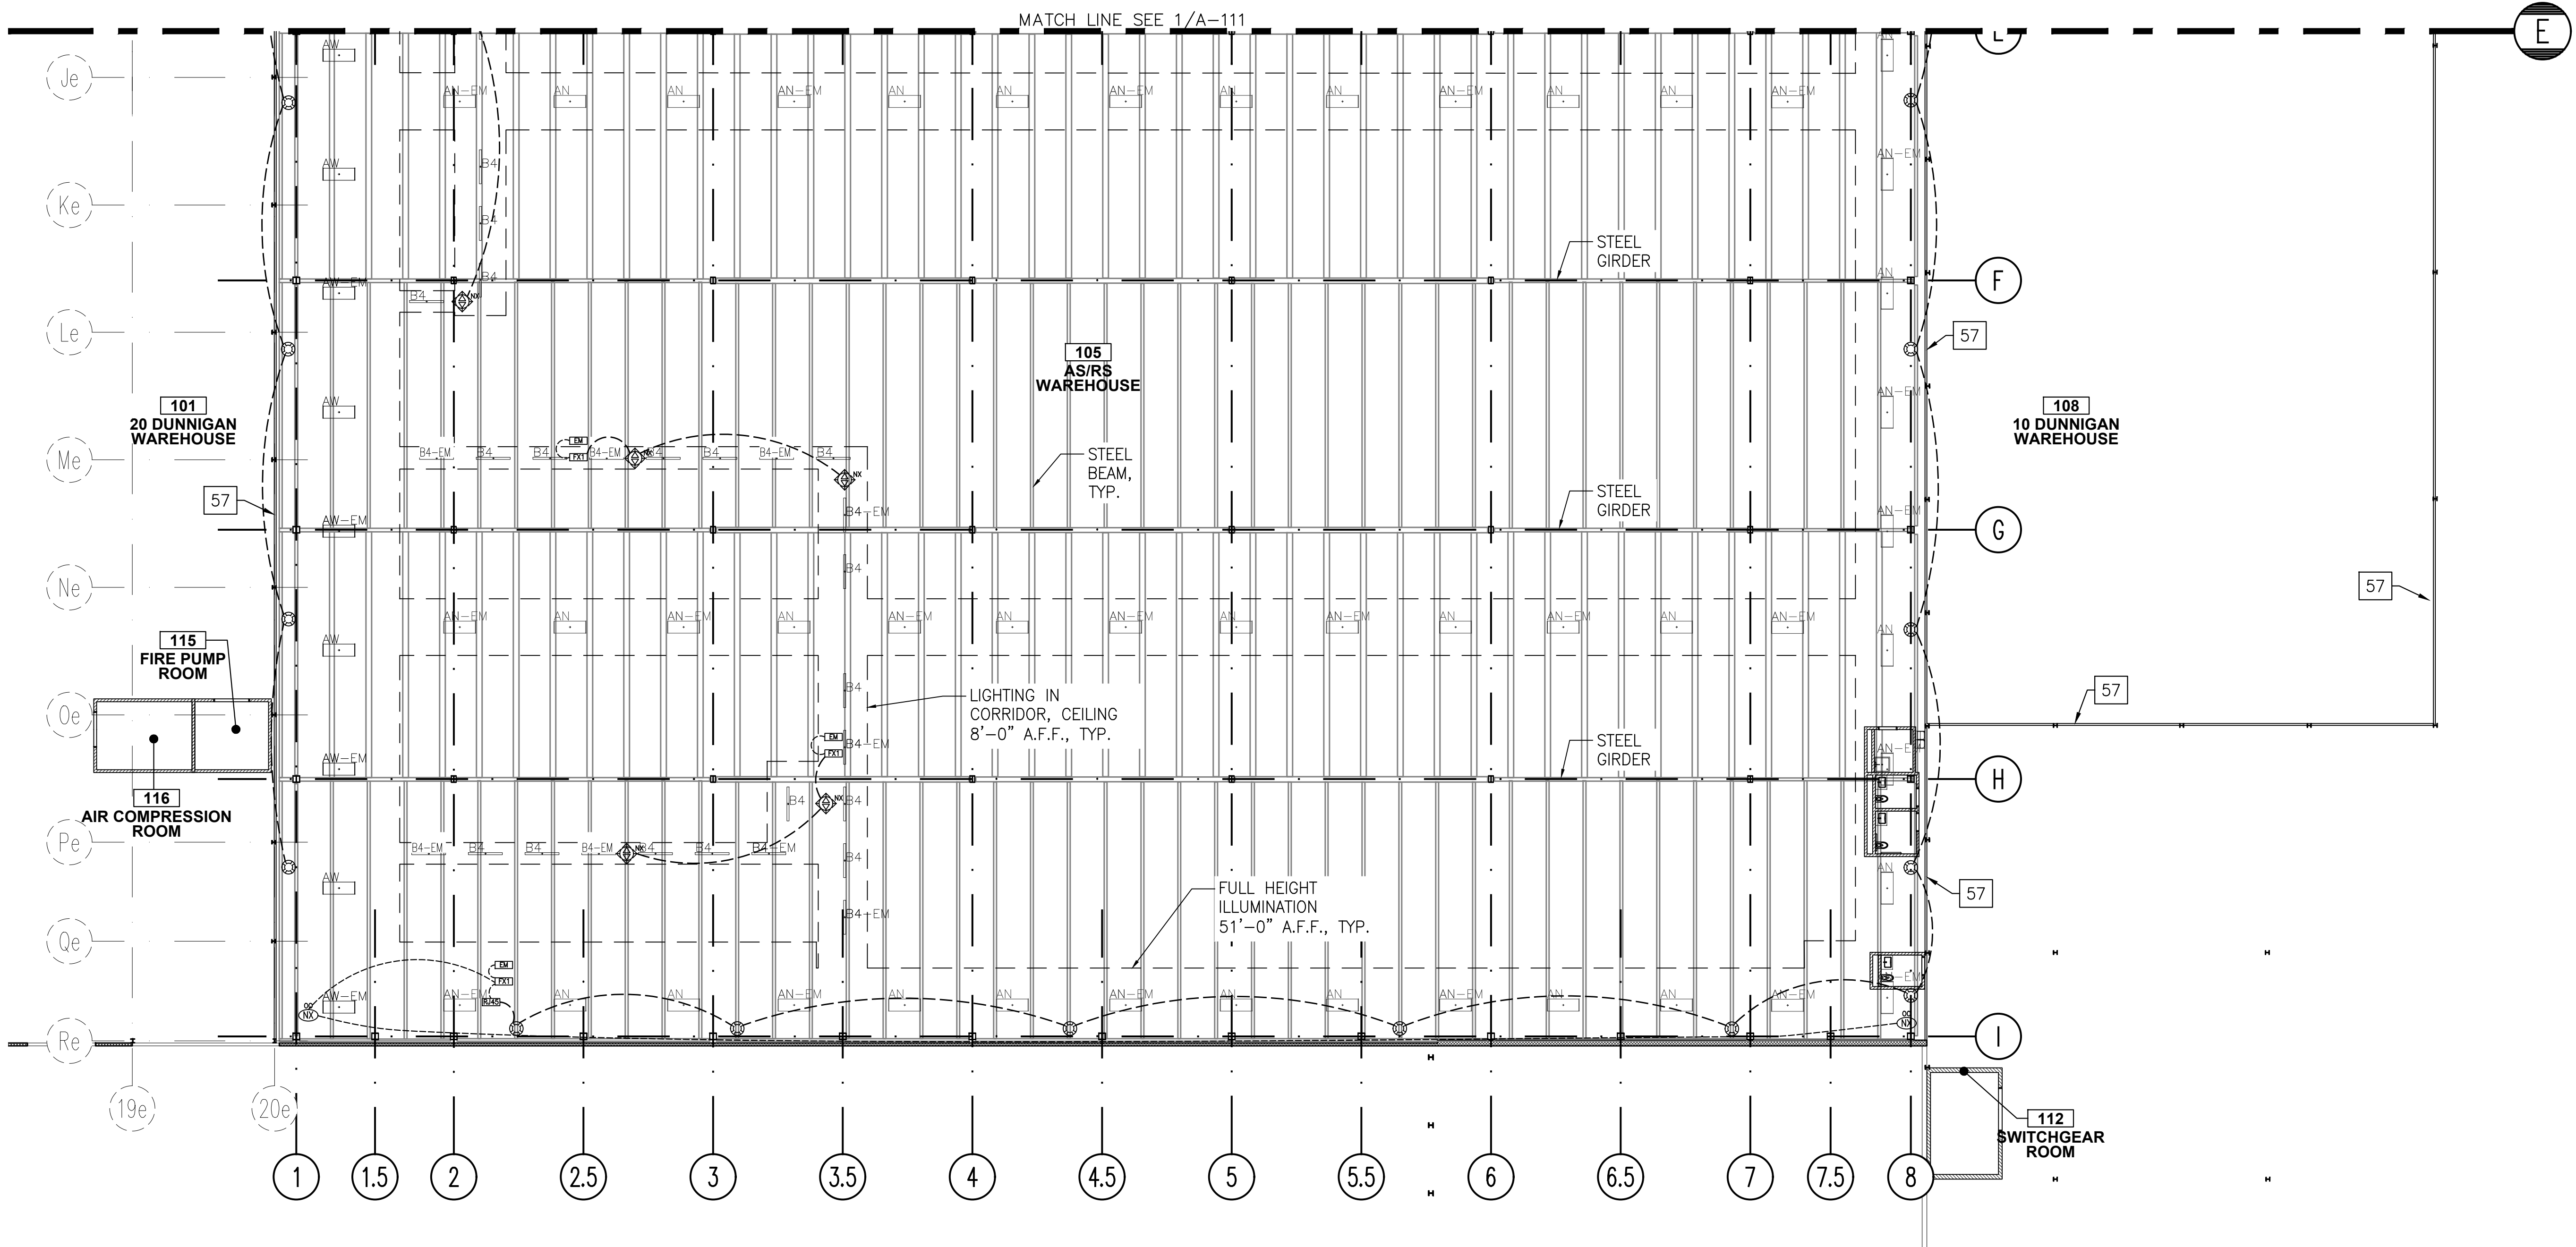

1 PROPOSED RCP - AS/RS WAREHOUSE (SOUTH)
A-112 A-112 SCALE: 1/16"=1'-0"