


B

MATCH LINE SEE DRAWING F-108

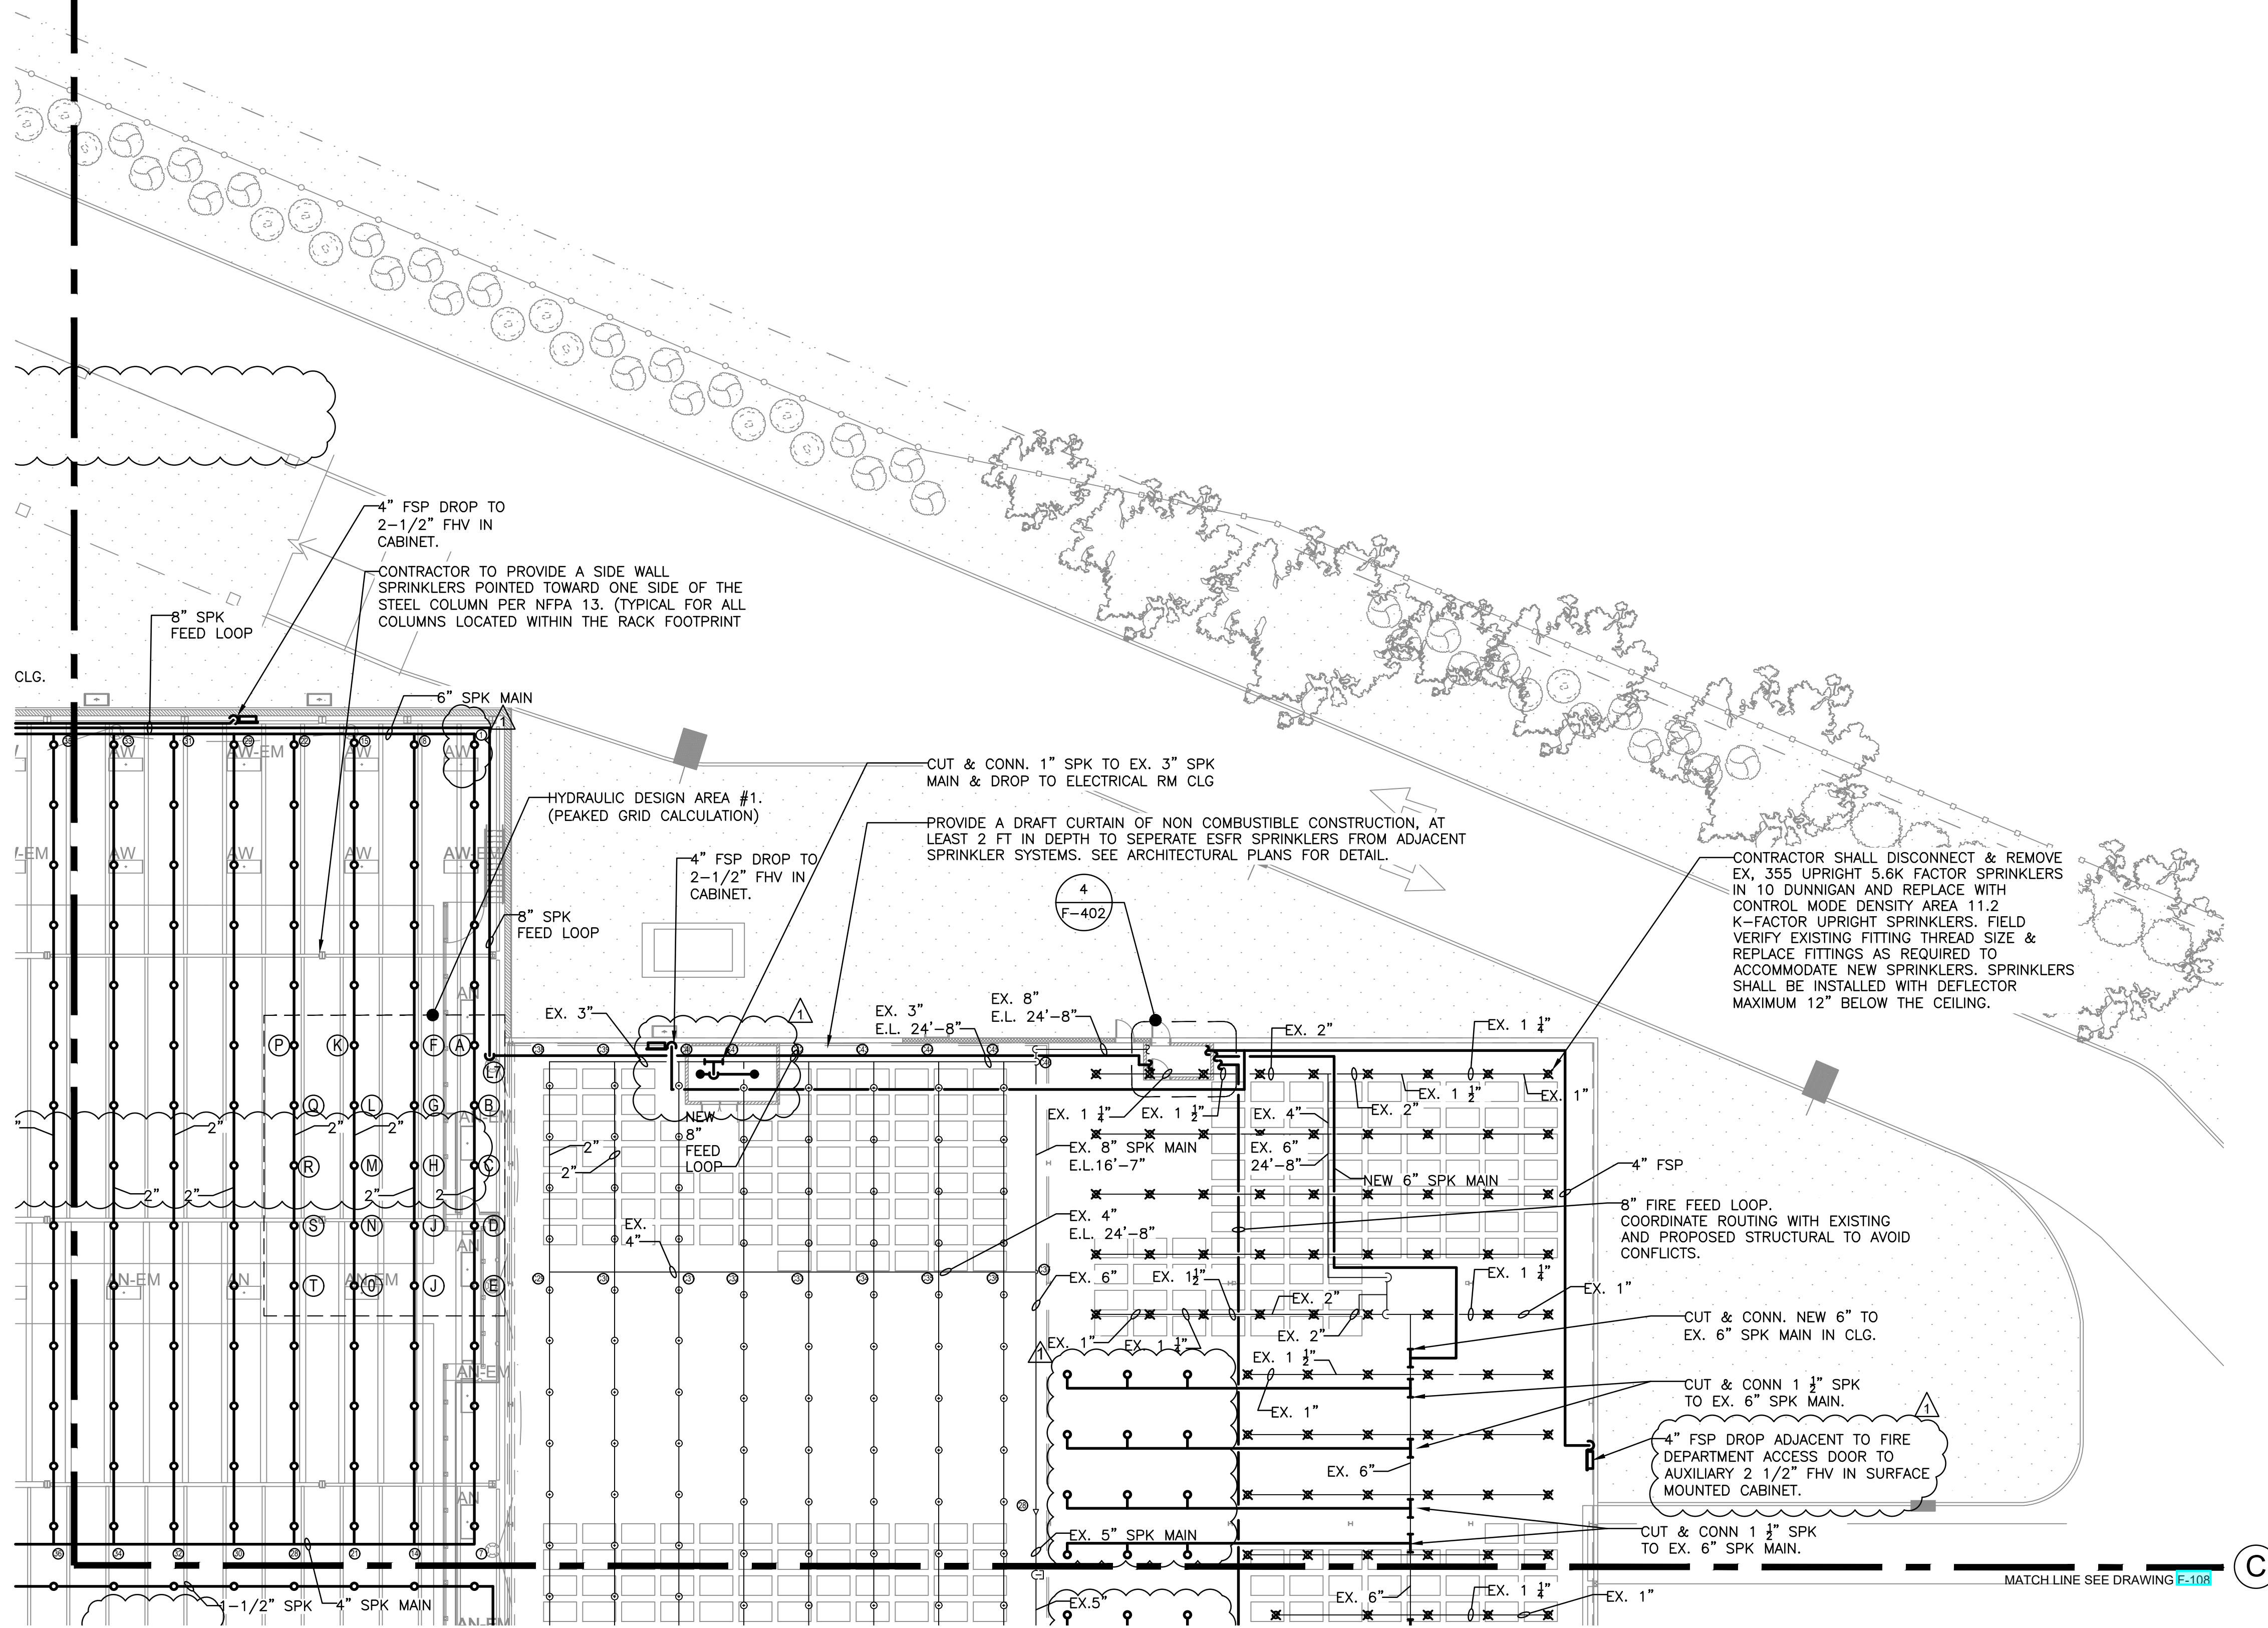

1
F-105

PARTIAL WAREHOUSE FLOOR PLAN

1/16" = 1'-0"

SPRINKLER NOTES

- 1) CONTRACTOR SHALL COORDINATE WITH THE BUILDING THE SHUT DOWN OF THE FIRE STANDPIPE/SPRINKLER RISERS.
- 2) CONTRACTOR SHALL COORDINATE ROUTING OF NEW SPRINKLER PIPING WITH THE PROPOSED STRUCTURE AND ALL TRADES TO AVOID CONFLICTS.
- 3) DESIGN DRAWINGS ARE SCHEMATIC. PIPING IS SHOWN APPROXIMATELY ONLY. EXACT LOCATION MUST BE DETERMINED BY THE SPRINKLER CONTRACTOR IN THE FIELD. CONTRACTOR SHALL VISIT THE SITE PRIOR TO BIDDING OR AWARD OF CONTACT TO INSPECT EXISTING FIELD CONDITIONS. THIS CONTRACT SHALL INCLUDE ALL LABOR AND MATERIALS NECESSARY FOR FIELD MODIFICATIONS DUE TO EXISTING CONDITIONS.
- 4) THE CONTRACTOR SHALL CONTACT THE ARCHITECT, ENGINEER OR OWNER PRIOR TO BIDDING FOR INTERPRETATIONS AND CLARIFICATIONS OF THE DESIGN AND INCLUDE IN HIS BID ALL COSTS TO MEET THE DESIGN INTENT. CLARIFICATIONS MADE BY THE ARCHITECT, ENGINEER OR OWNER AFTER BIDDING WILL BE FINAL AND SHALL BE IMPLEMENTED AT CONTRACTORS COST.
- 5) BIDDING CONTRACTORS SHALL HAVE A WORKING KNOWLEDGE OF LOCAL CODES AND ORDINANCES AND SHALL INCLUDE IN THEIR BIDS THE COSTS FOR ALL WORK INSTALLED IN STRICT ACCORDANCE WITH GOVERNING CODES. THE PLANS AND SPECIFICATIONS NOT WITHSTANDING, THE CONTRACTOR SHALL ALERT ARCHITECT, ENGINEER OR OWNER OF ANY APPARENT DISCREPANCIES BETWEEN GOVERNING CODES AND DESIGN INTENT.
- 6) PROVIDE SPRINKLER HEADS BELOW ALL EXPOSED OBSTRUCTIONS OVER 48" WIDE. THIS REQUIREMENT SHALL INCLUDE DUCT WORK RUNNING PARALLEL OF EACH OTHER PRODUCING A WIDTH OF 48" AND OVER. SPRINKLER HEAD INSTALLED WHERE MINIMUM HEAD CLEARANCE IS NOT MET SHALL BE EQUIPPED WITH WIRE GUARD COVERS.

ARCHITECT

di Domenico + Partners LLP



Architecture
Landscape Architecture
Planning
3743 Crescent Street, 3rd Floor
Long Island City, New York 11101
Tel 212-337-0400
Fax 212-337-3567

CIVIL PLANNING ENGINEER



JMC Planning Engineering Landscape
Architecture & Land Surveying, PLLC
120 Bedford Road
Armonk, New York 10504
Tel 914-273-5225
Fax 914-273-2102

MEP ENGINEER



BURNS ENGINEERING, PC.
1261 Broadway, Suite 708
New York, New York 10001
Tel 212-962-3503

STRUCTURAL ENGINEER



GEI50
1365 Broadway, 20th FL
New York, New York 10018
Tel 212-687-8282



MANHATTAN BEER DISTRIBUTORS
20 DUNNIGAN DRIVE
SUFFERN, NEW YORK

KEY PLAN

REV	DESCRIPTION	DATE
	ISSUED FOR DOB SUBMISSION	09/10/2021
	ISSUED FOR BID	10/15/2021
	ISSUED FOR PROGRESS	01/18/2022

DRAWN BY :	M.ESPINAL
CHECKED BY :	J.CLARK
APPROVED BY :	J.MIZRAHI
DATE :	04/16/21
SCALE :	1/16" = 1'-0"

DRAWING TITLE :

**FIRE PROTECTION L1 PLAN
QUADRANT 3**

DWG NUMBER :

F-105